


HOME PLANS FOR
FORD RESIDENCE
COLUMBIA COUNTY, FL

Plan Sheet Index:

Sheet No.	Description
1	title/index sheet
2	floor plan
3	front and left elevations
4	rear and right elevations
5	roof plan
6	plumbing plan
7	electrical plan

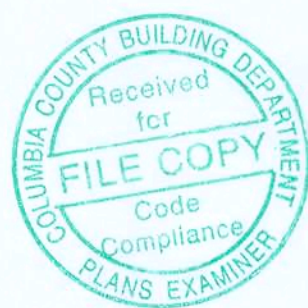

W



PLANS PREPARED BY:
CHRISTOPHER Q. DICKS
4035 SE CR 252, LAKE CITY, FL 32025

FORD RESIDENCE
COLUMBIA COUNTY, FLORIDA

SHEET
1
OF
7

SQUARE FOOTAGE	
HEATED AREA	2100 SF
PORCH	1260 SF
TOTAL	3360 SF


FLOOR PLAN

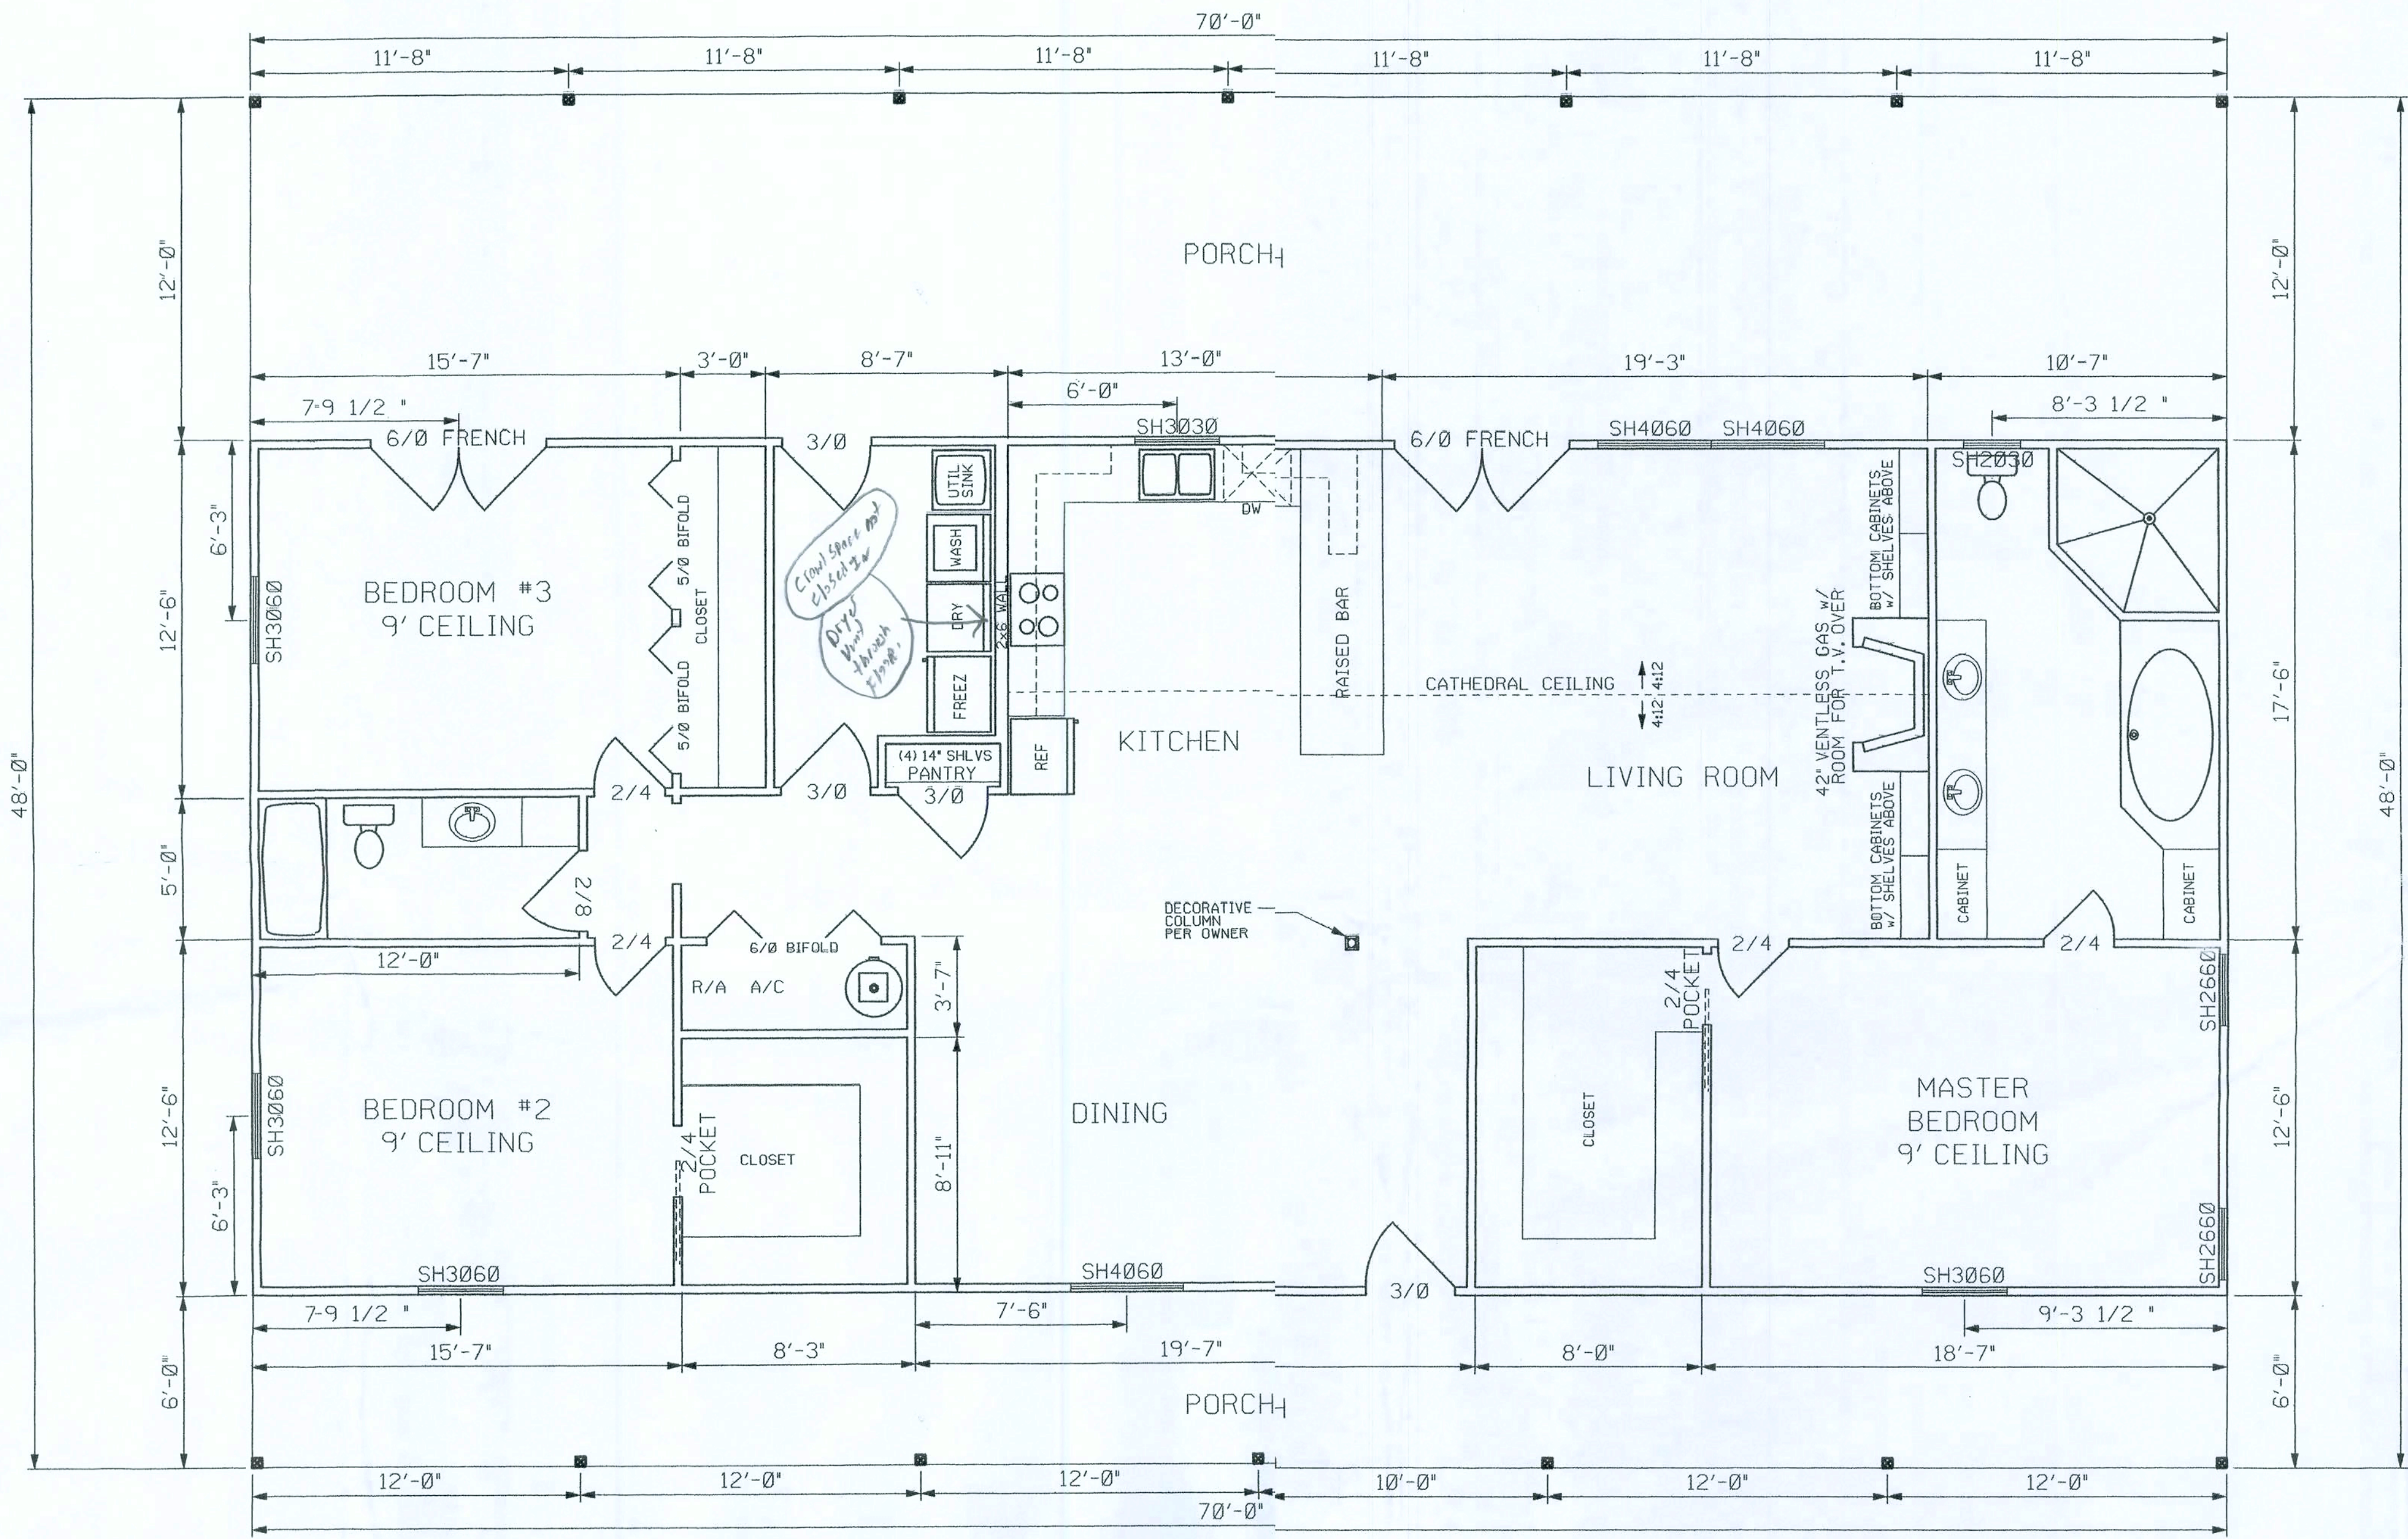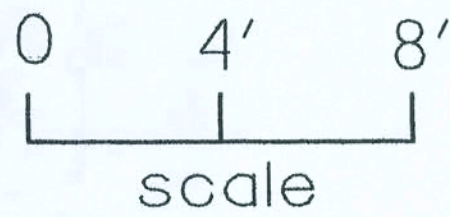


FORD RESIDENCE
COLUMBIA COUNTY, FLORIDA

SHEET
2
OF
7


PLANS PREPARED BY:
CHRISTOPHER Q. DICKS
4035 SE CR 252, LAKE CITY, FL 32025

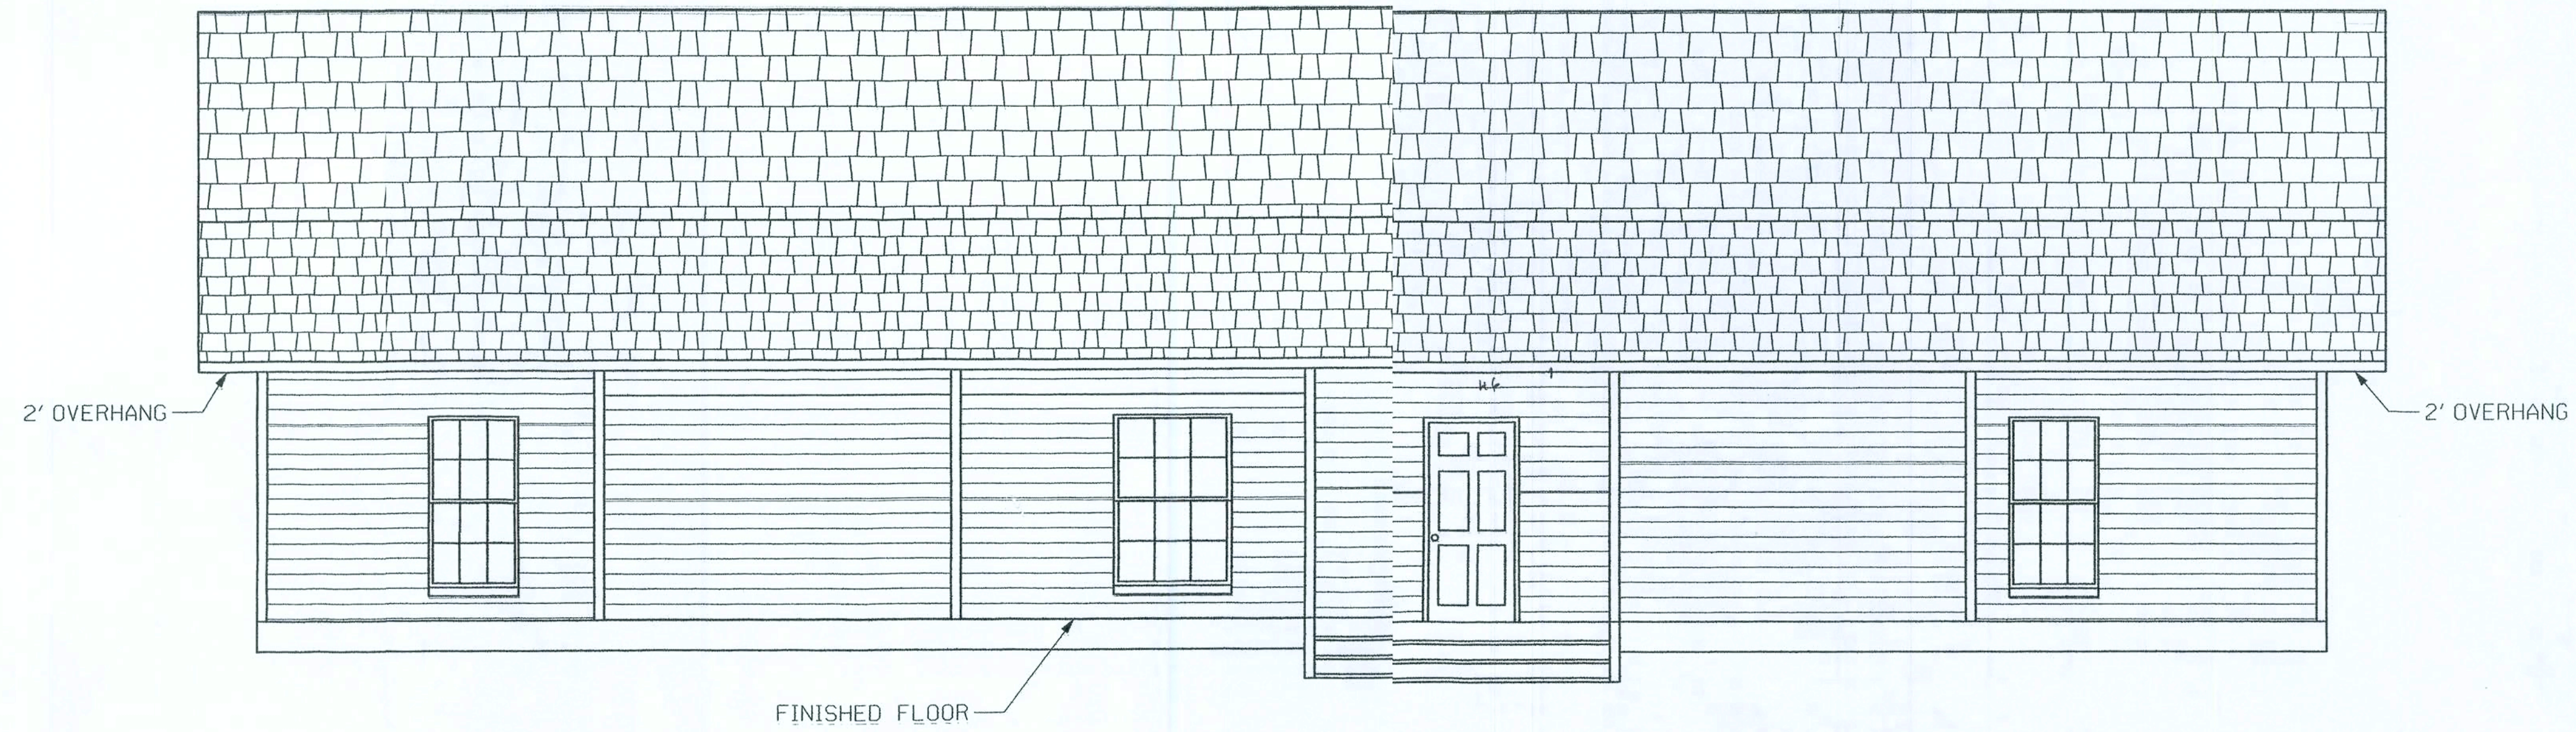

FRONT ELEVATION

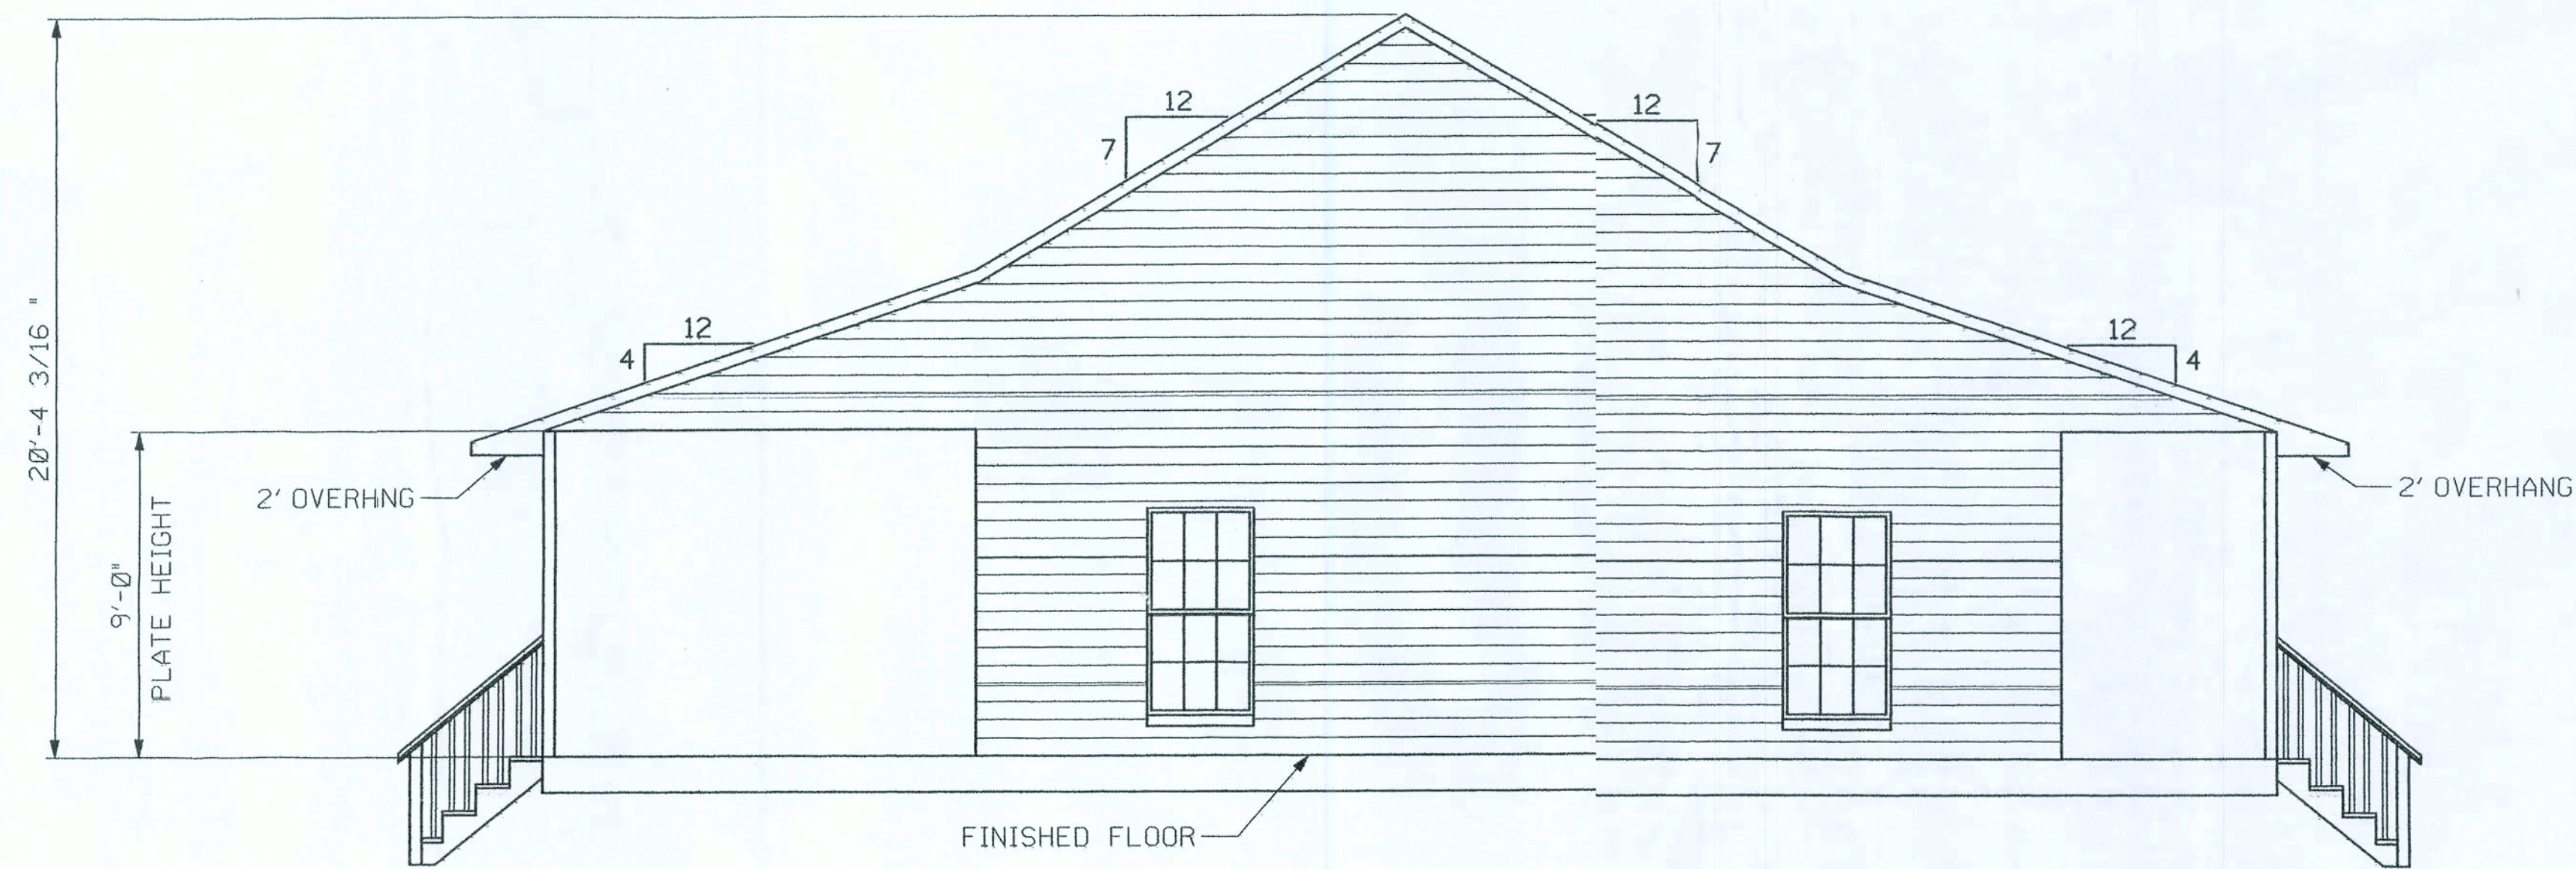


LEFT ELEVATION

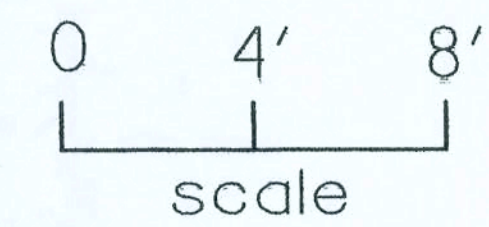


PLANS PREPARED BY:
CHRISTOPHER Q. DICKS
4035 SE CR 252, LAKE CITY, FL 32025

FORD RESIDENCE
COLUMBIA COUNTY, FLORIDA


SHEET
3
OF
7

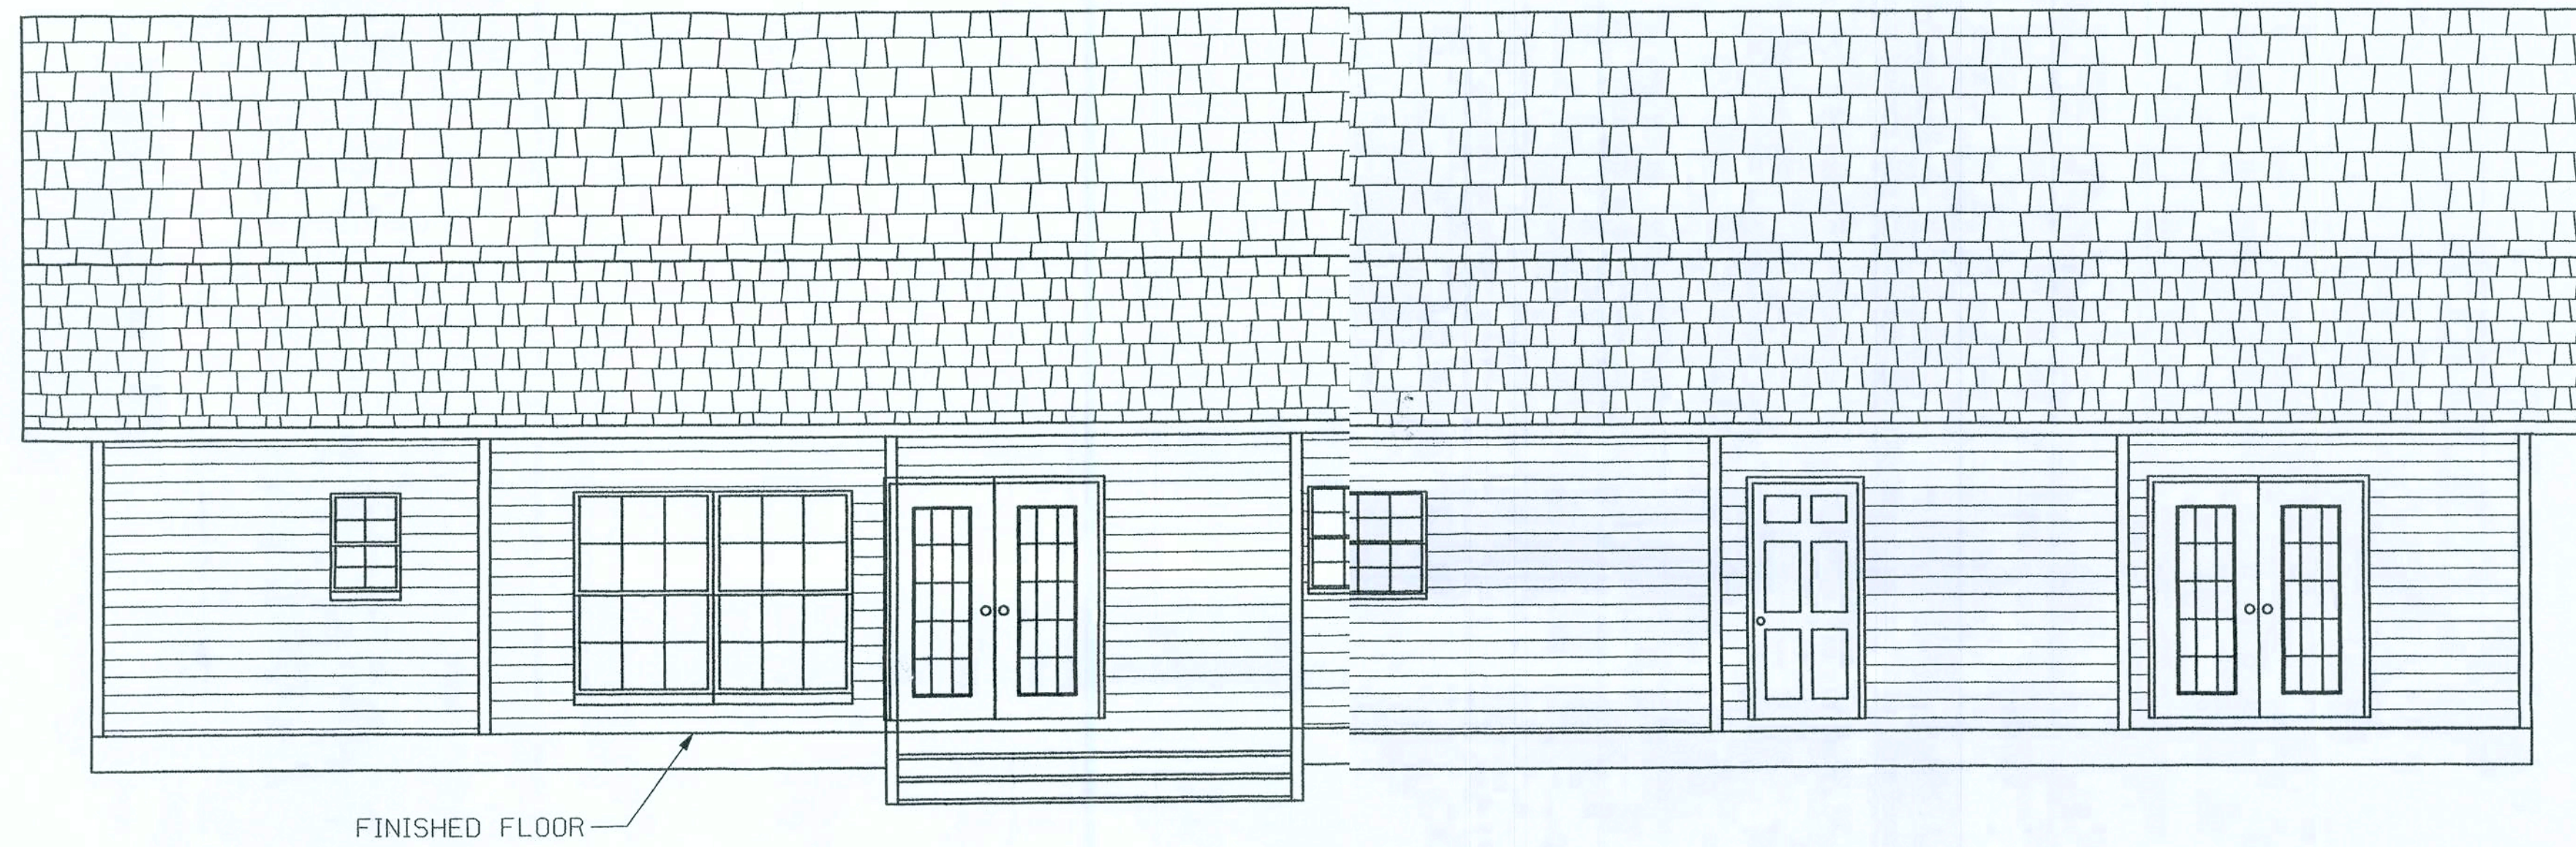

REAR ELEVATION

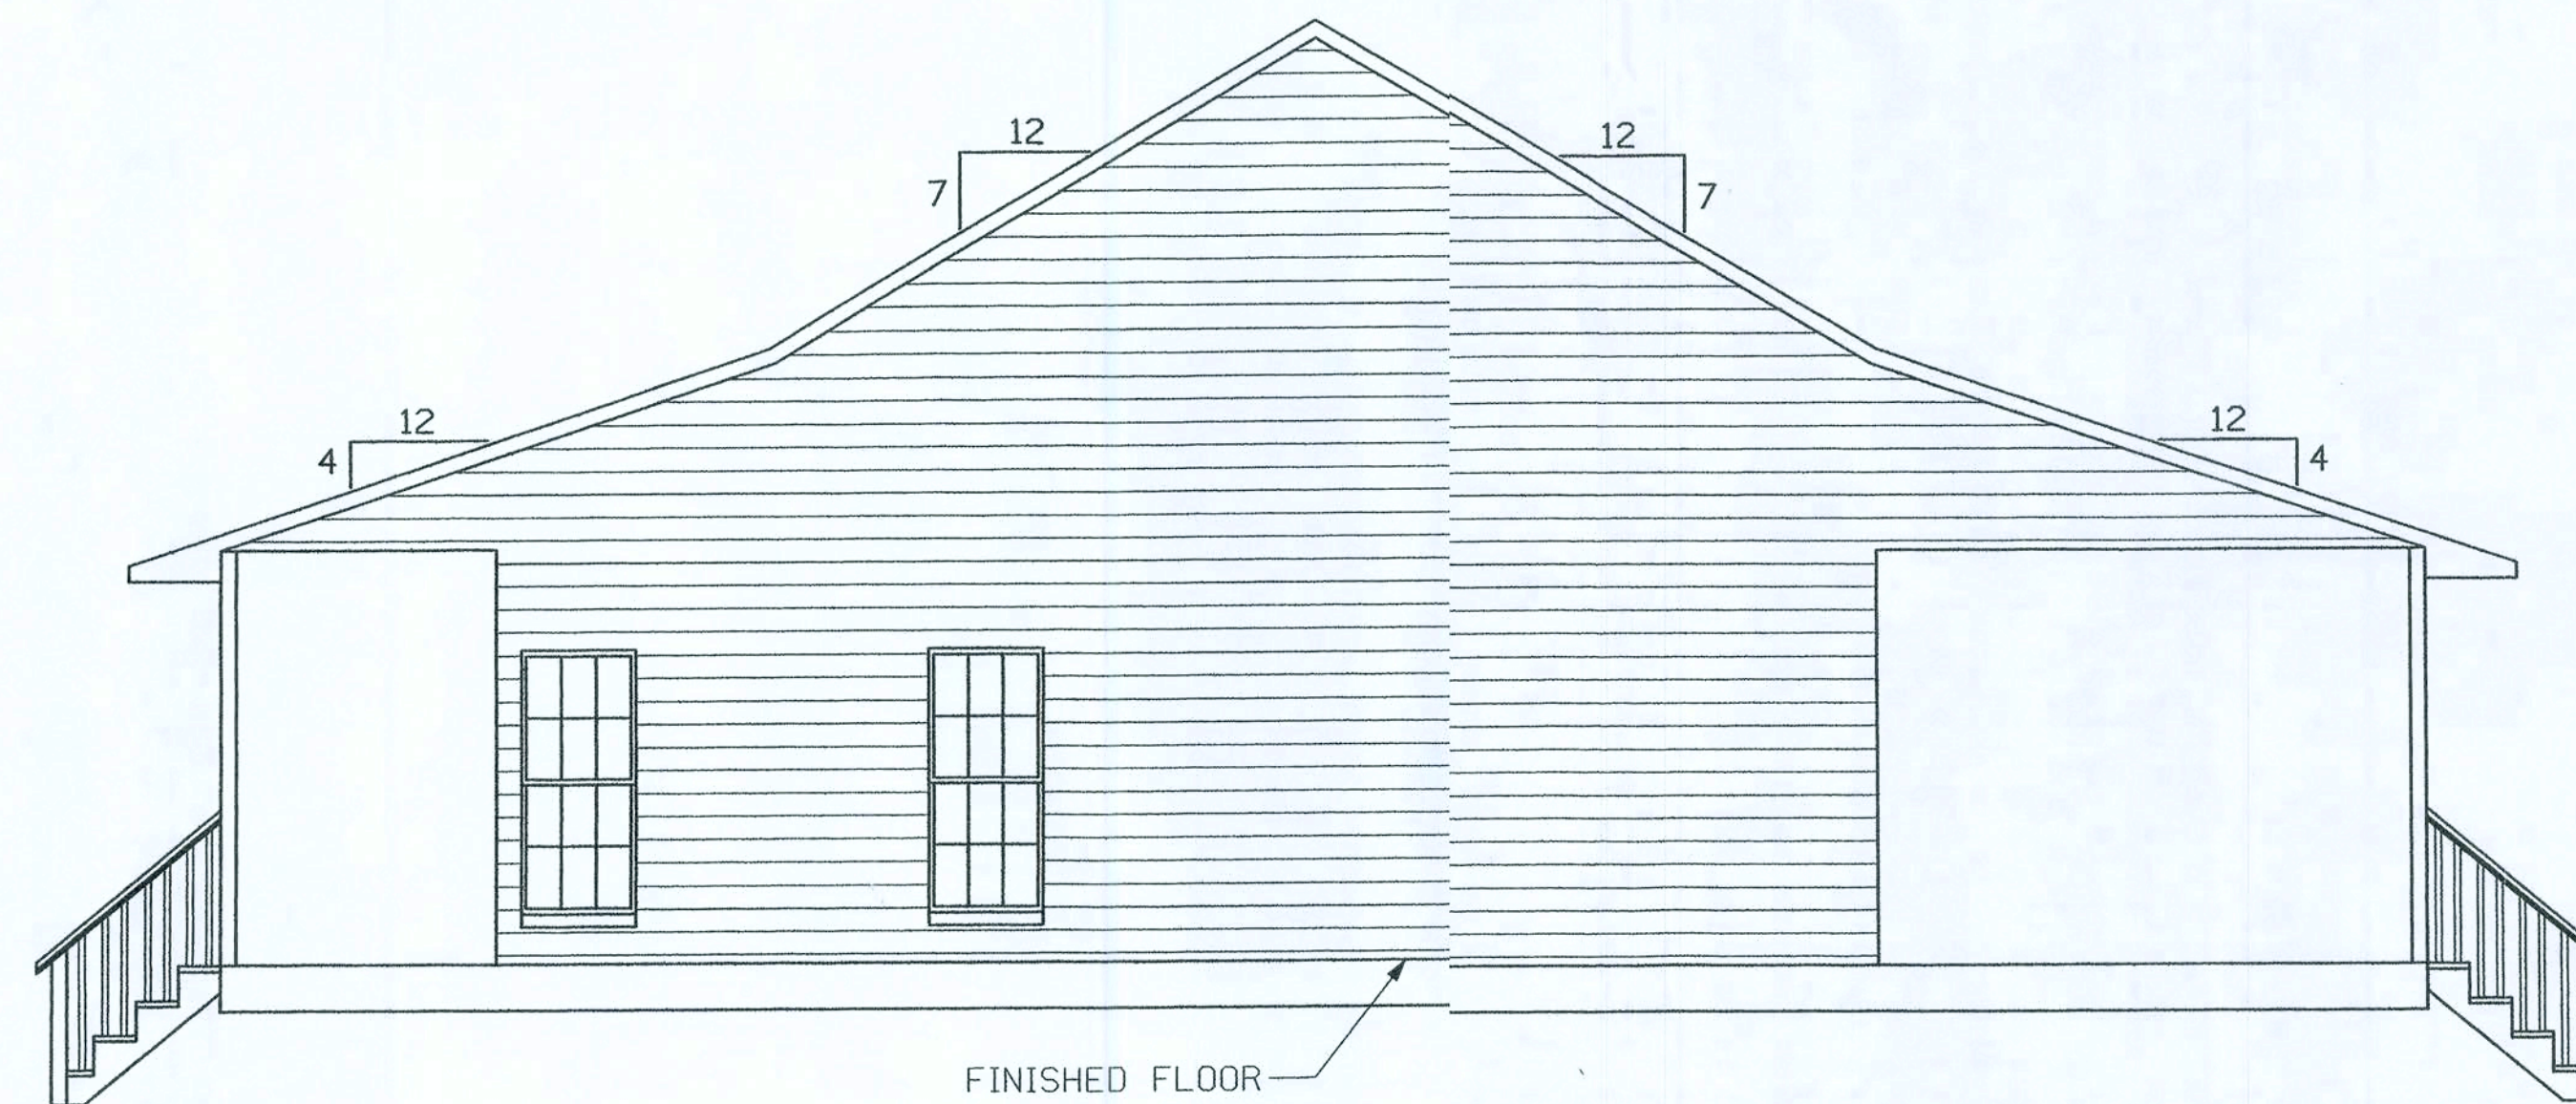

RIGHT ELEVATION

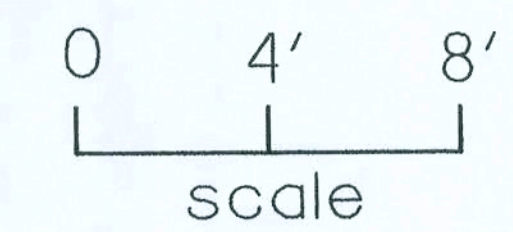


PLANS PREPARED BY:
CHRISTOPHER Q. DICKS
4035 SE CR 252, LAKE CITY, FL 32025

FORD RESIDENCE
COLUMBIA COUNTY, FLORIDA

SHEET
4
OF
7



ROOF PLAN

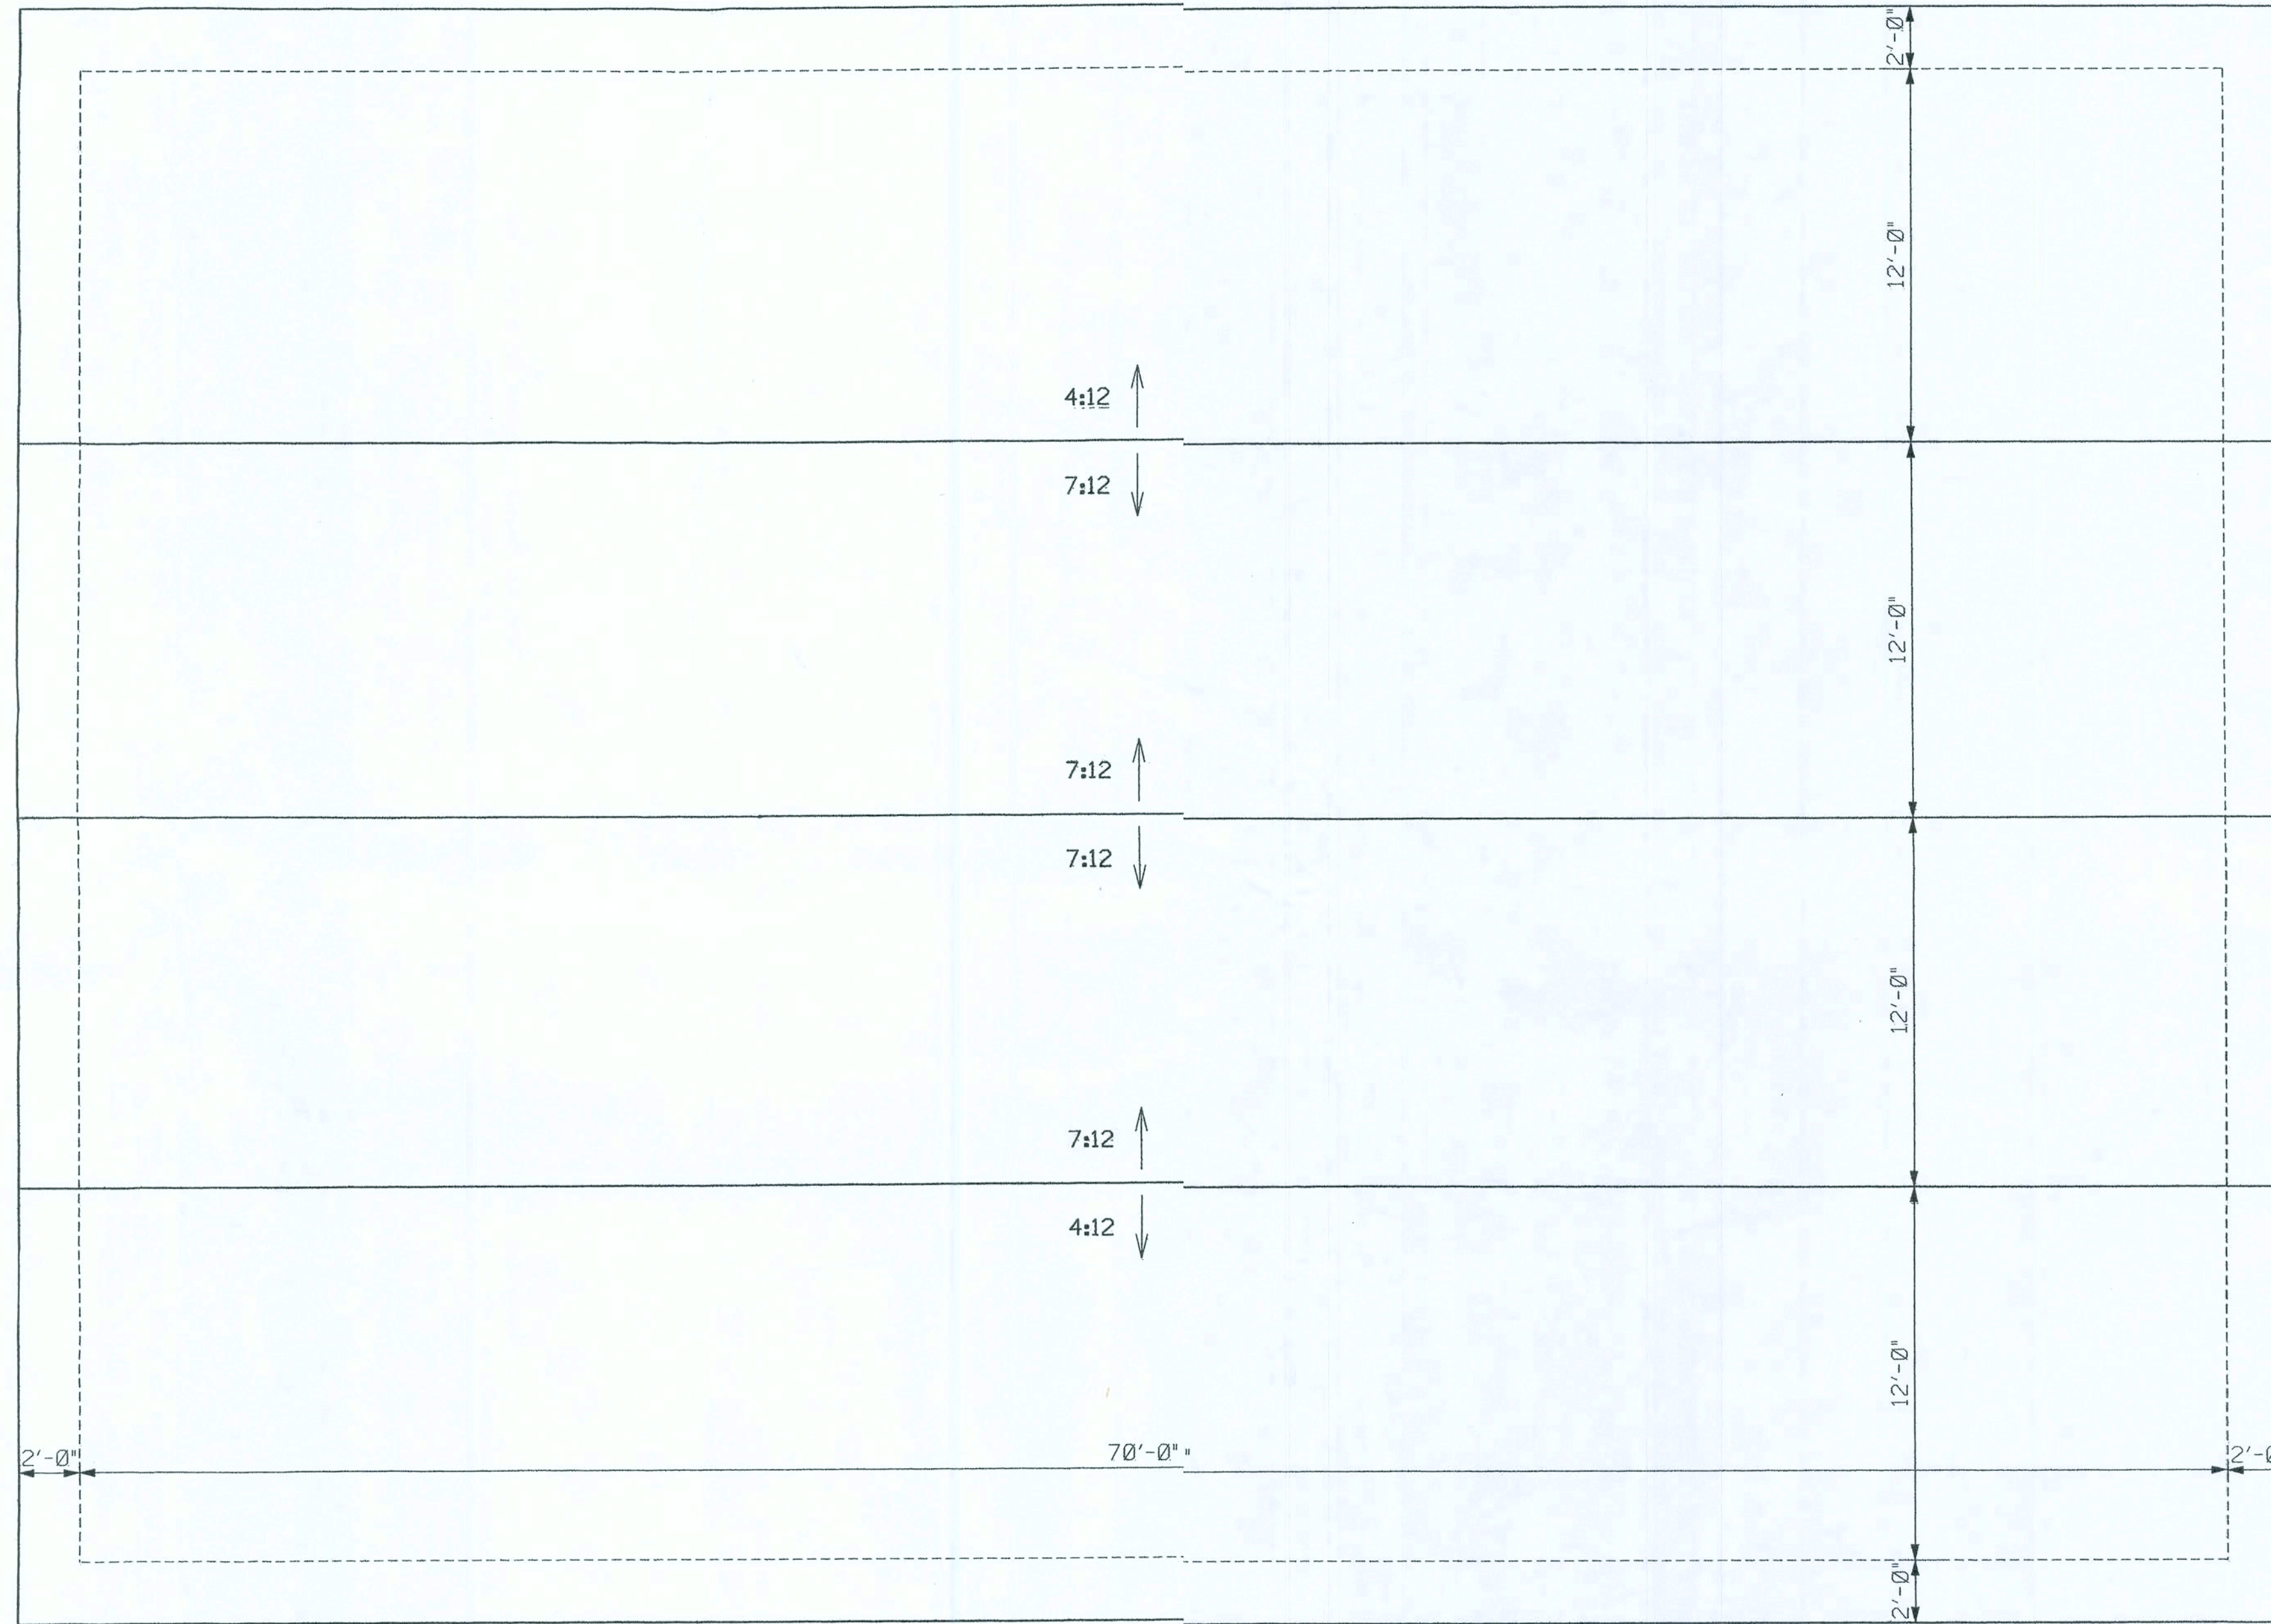

SHEET
5
OF
7

FORD RESIDENCE
COLUMBIA COUNTY, FLORIDA

PLANS PREPARED BY:
CHRISTOPHER Q. DICKS
4035 SE CR 252, LAKE CITY, FL 32025

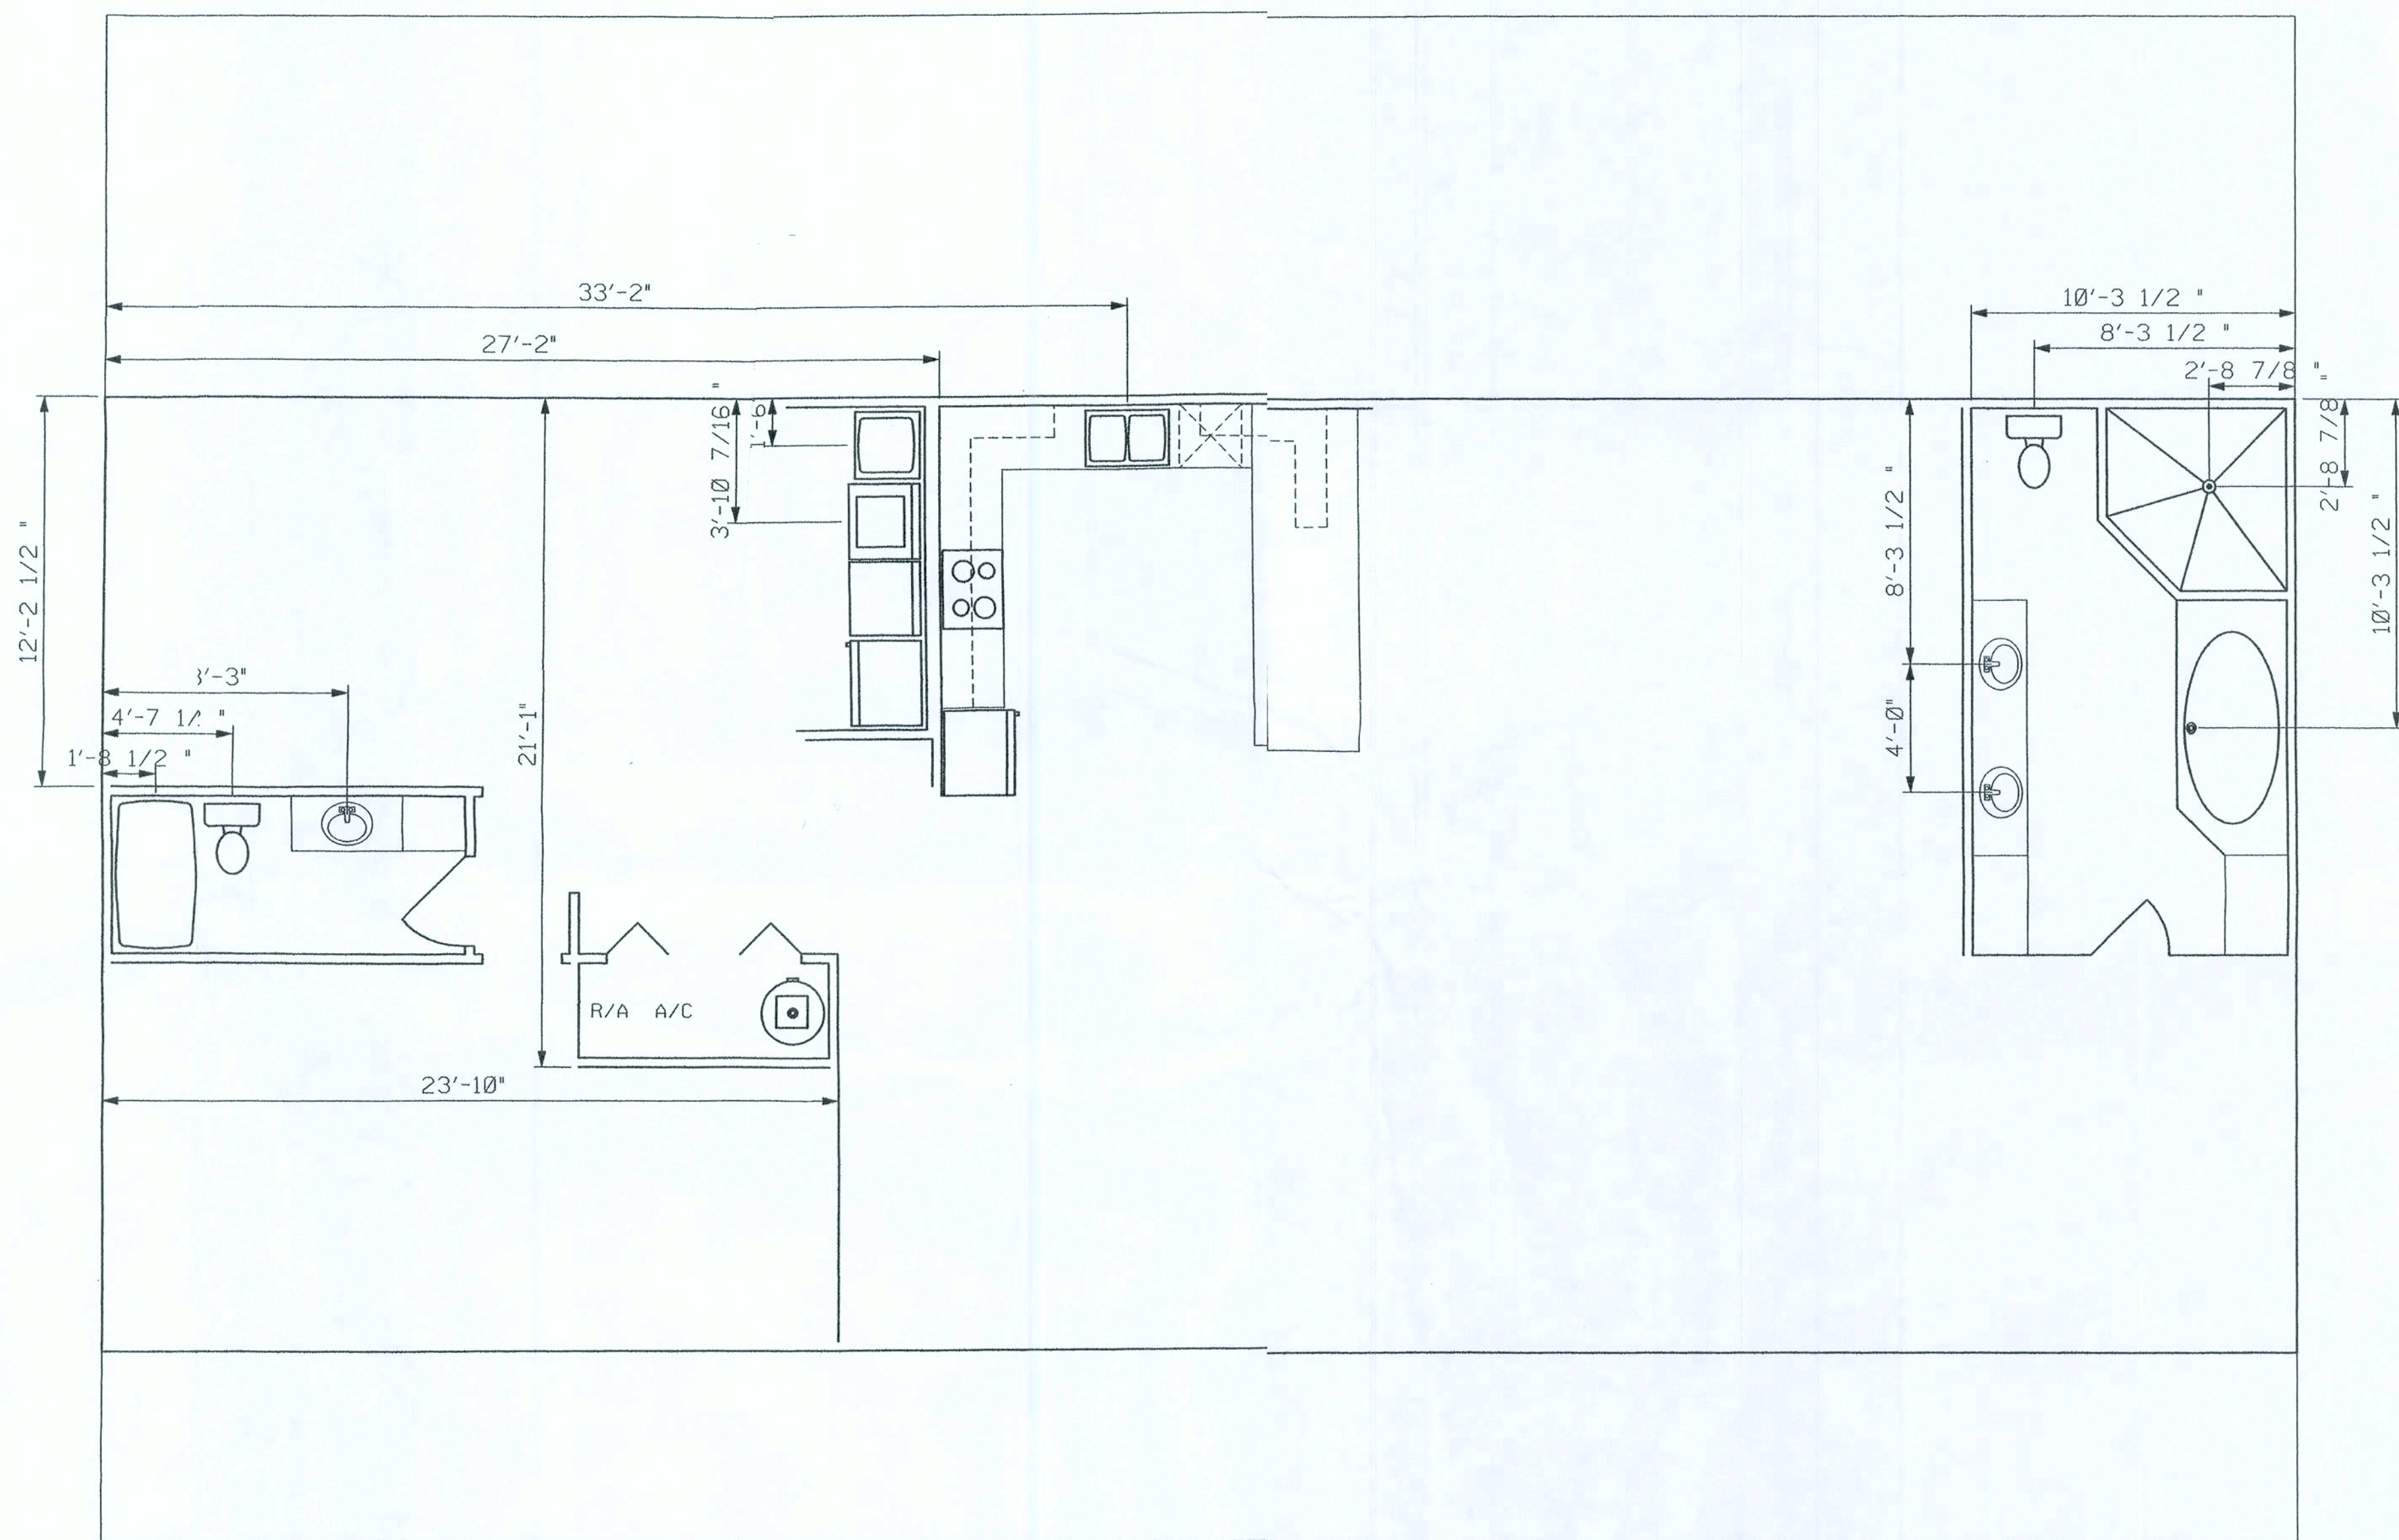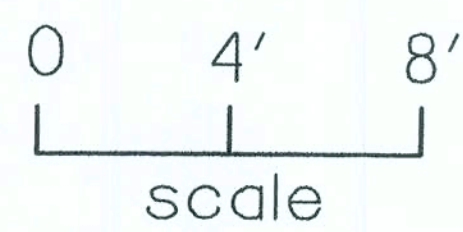





PLUMBING PLAN


SHEET
6
OF
7

FORD RESIDENCE
COLUMBIA COUNTY, FLORIDA

PLANS PREPARED BY:
CHRISTOPHER Q. DICKS
4035 SE CR 252, LAKE CITY, FL 32025

   ELECTRICAL LEGEND

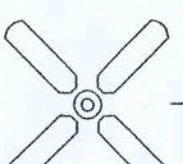
-  - CEILING FAN w LIGHTS
-  - LIGHT FIXTURE
-  - RECESSED CAN LIGHT
-  - SINGLE POLE SWITCH
-  - THREE-WAY SWITCH
-  - FLOOR RECEPT.
-  - RECEPT.
-  - GFI RECEPT OR PART OF A GFI CIRCUIT.
-  - SECURITY LIGHT
-  - EXHAUST FAN
-  - 220 V.
-  - SMOKE DETECTOR (AC/DC and interconnected)
-  - SMOKE/CARBON MONOXIDE DETECTOR COMBINATION (AC/DC and interconnected)
-  - TELEPHONE AND RG6 COAX
-  - FLUORESCENT LIGHT FIXTURE

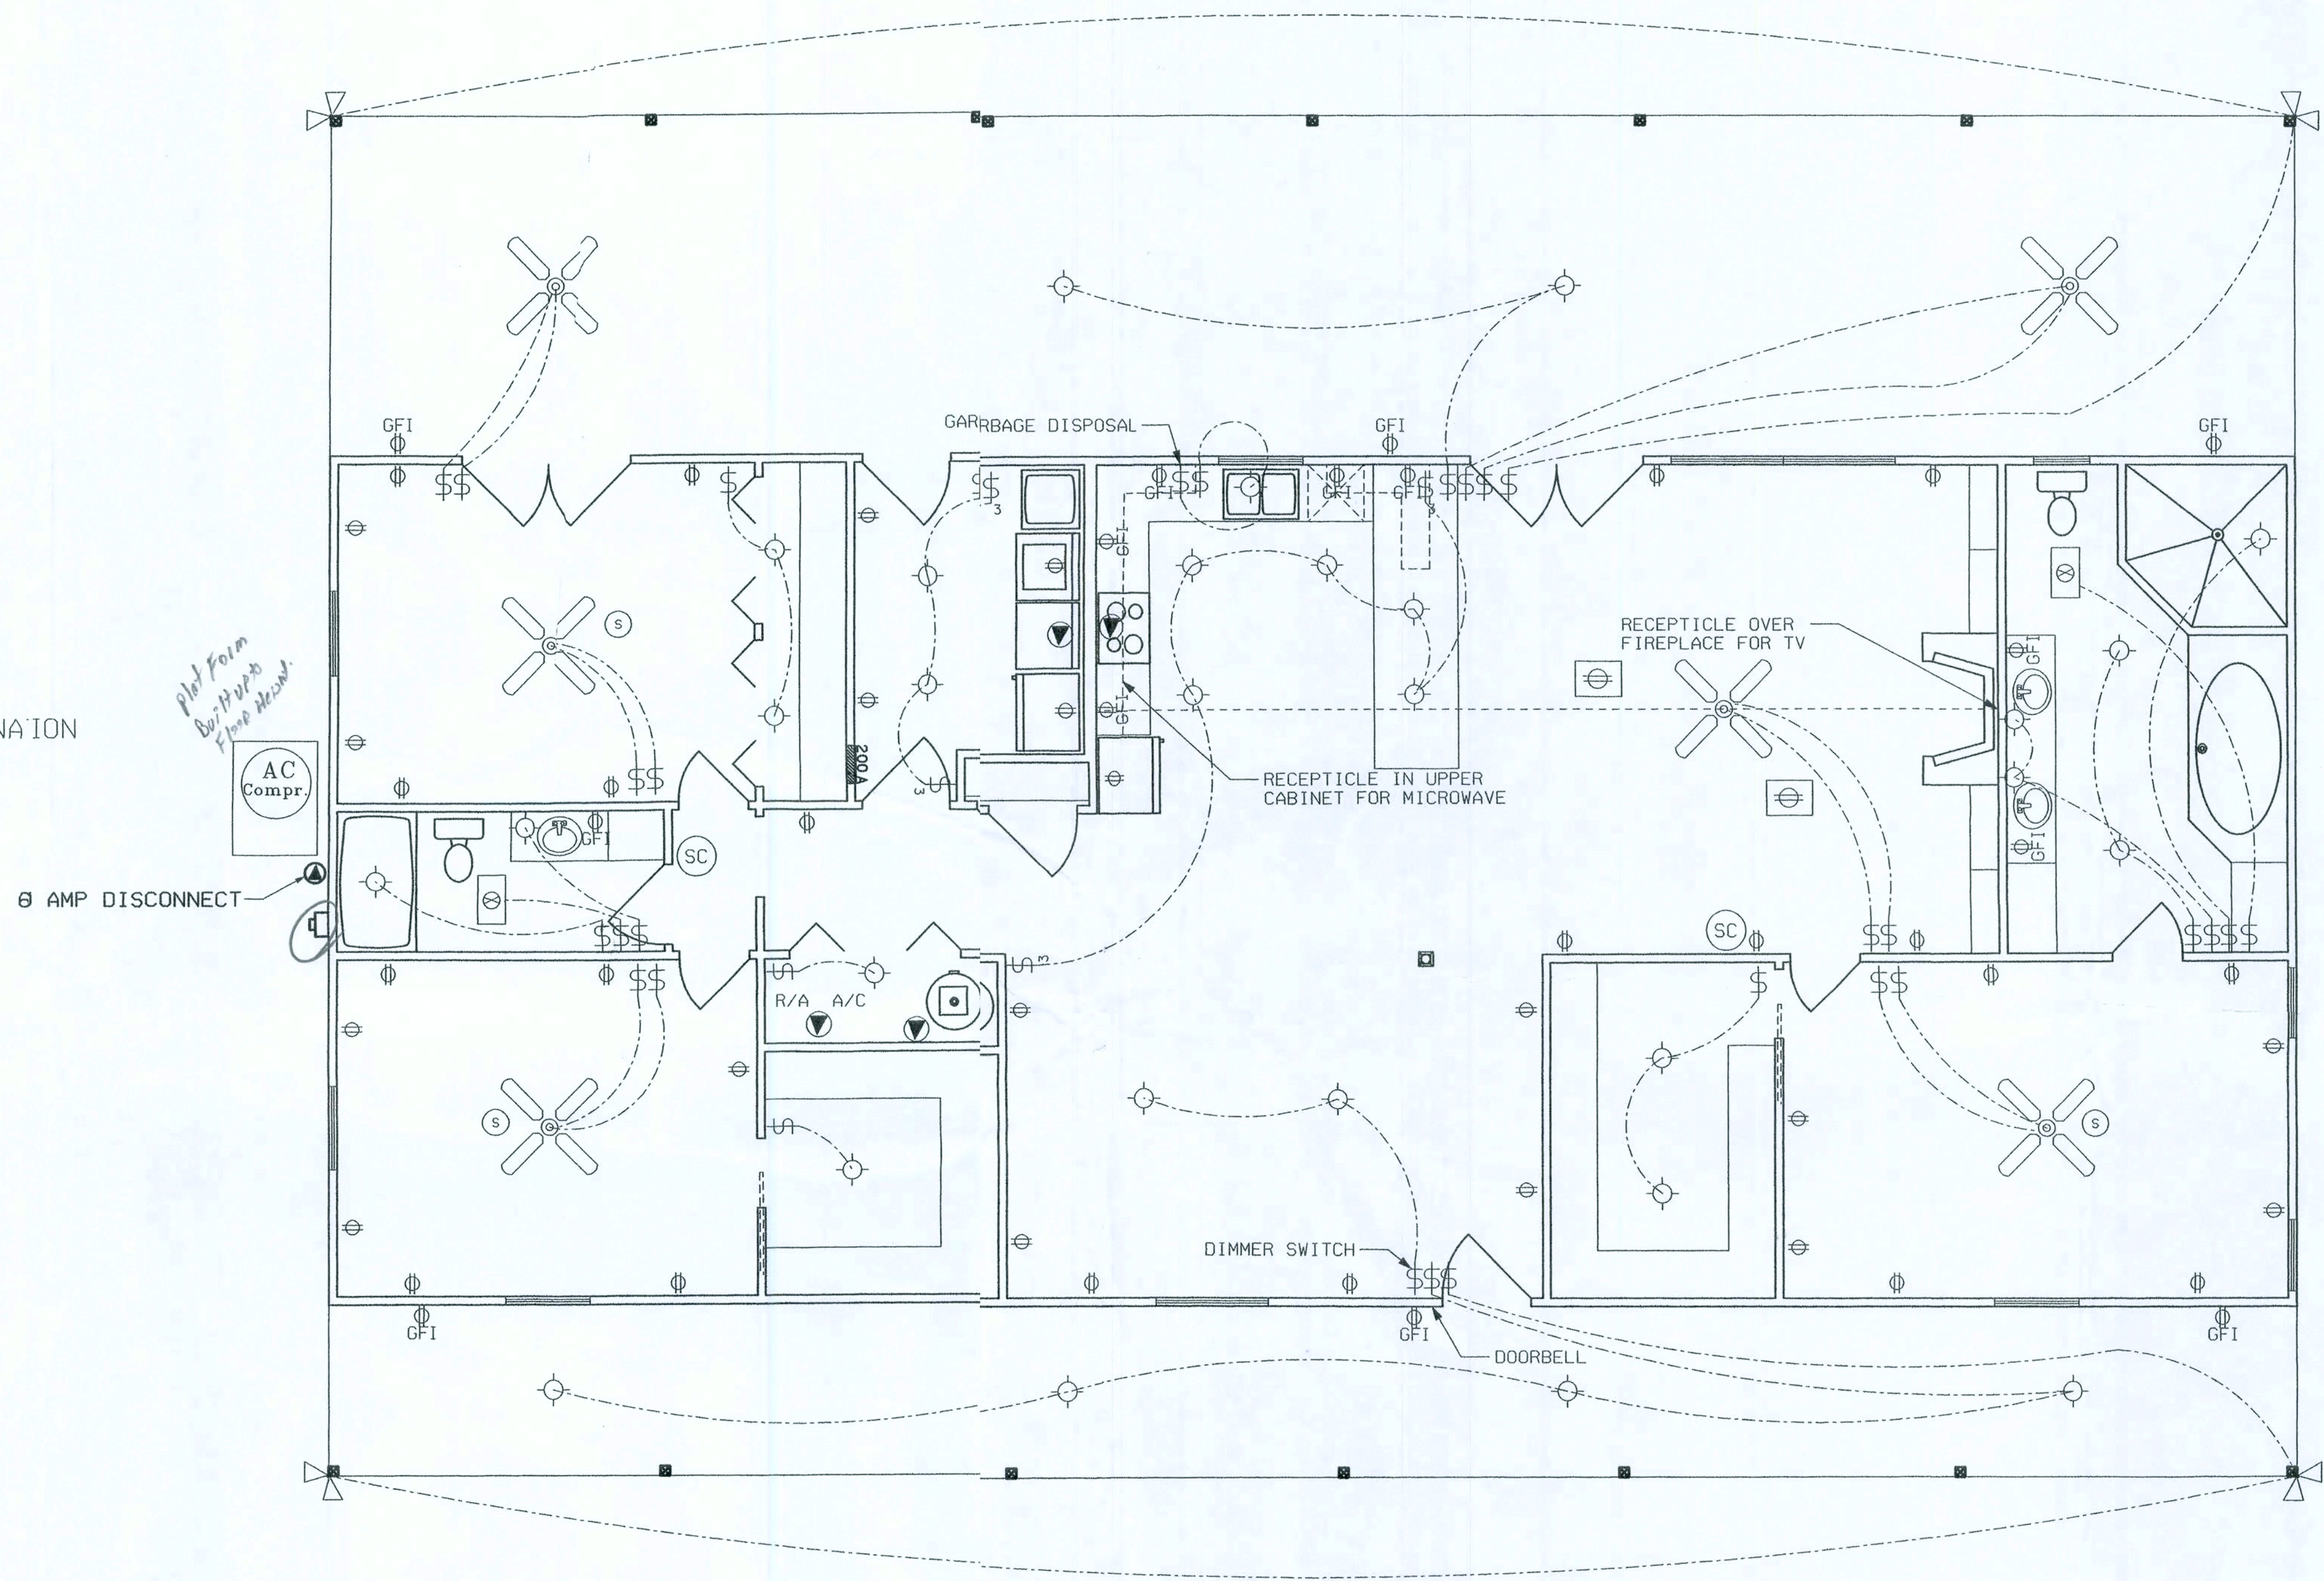

NOTES:

1. ALL ELECTRICAL COMPONENTS, EQUIPMENT AND SYSTEMS SHALL COMPLY WITH THE PROVISIONS OF NFPA 70, NATIONAL ELECTRICAL CODE (LATEST EDITION) AND THE FLORIDA BUILDING CODE (LATEST EDITION).
2. ALL EXTERIOR RECEPTACLES SHALL BE WEATEHPROOF.
3. ALL BEDROOM RECEPTS SHALL BE PART OF AN AFCI CIRCUIT. EACH BEDROOM SHALL BE ON AN INDIVIDUAL AFC CIRCUIT.
4. ALL RECEPTACLES SHALL BE CHILDPROOF.

ELECTRICAL PLAN

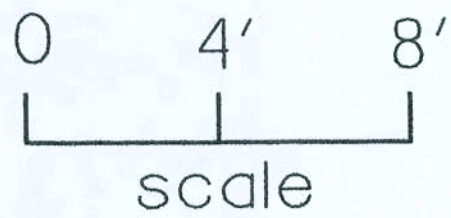

S.W. TOWER DRIVE
(AKA. Powell Road) (County Maintained Road)

