



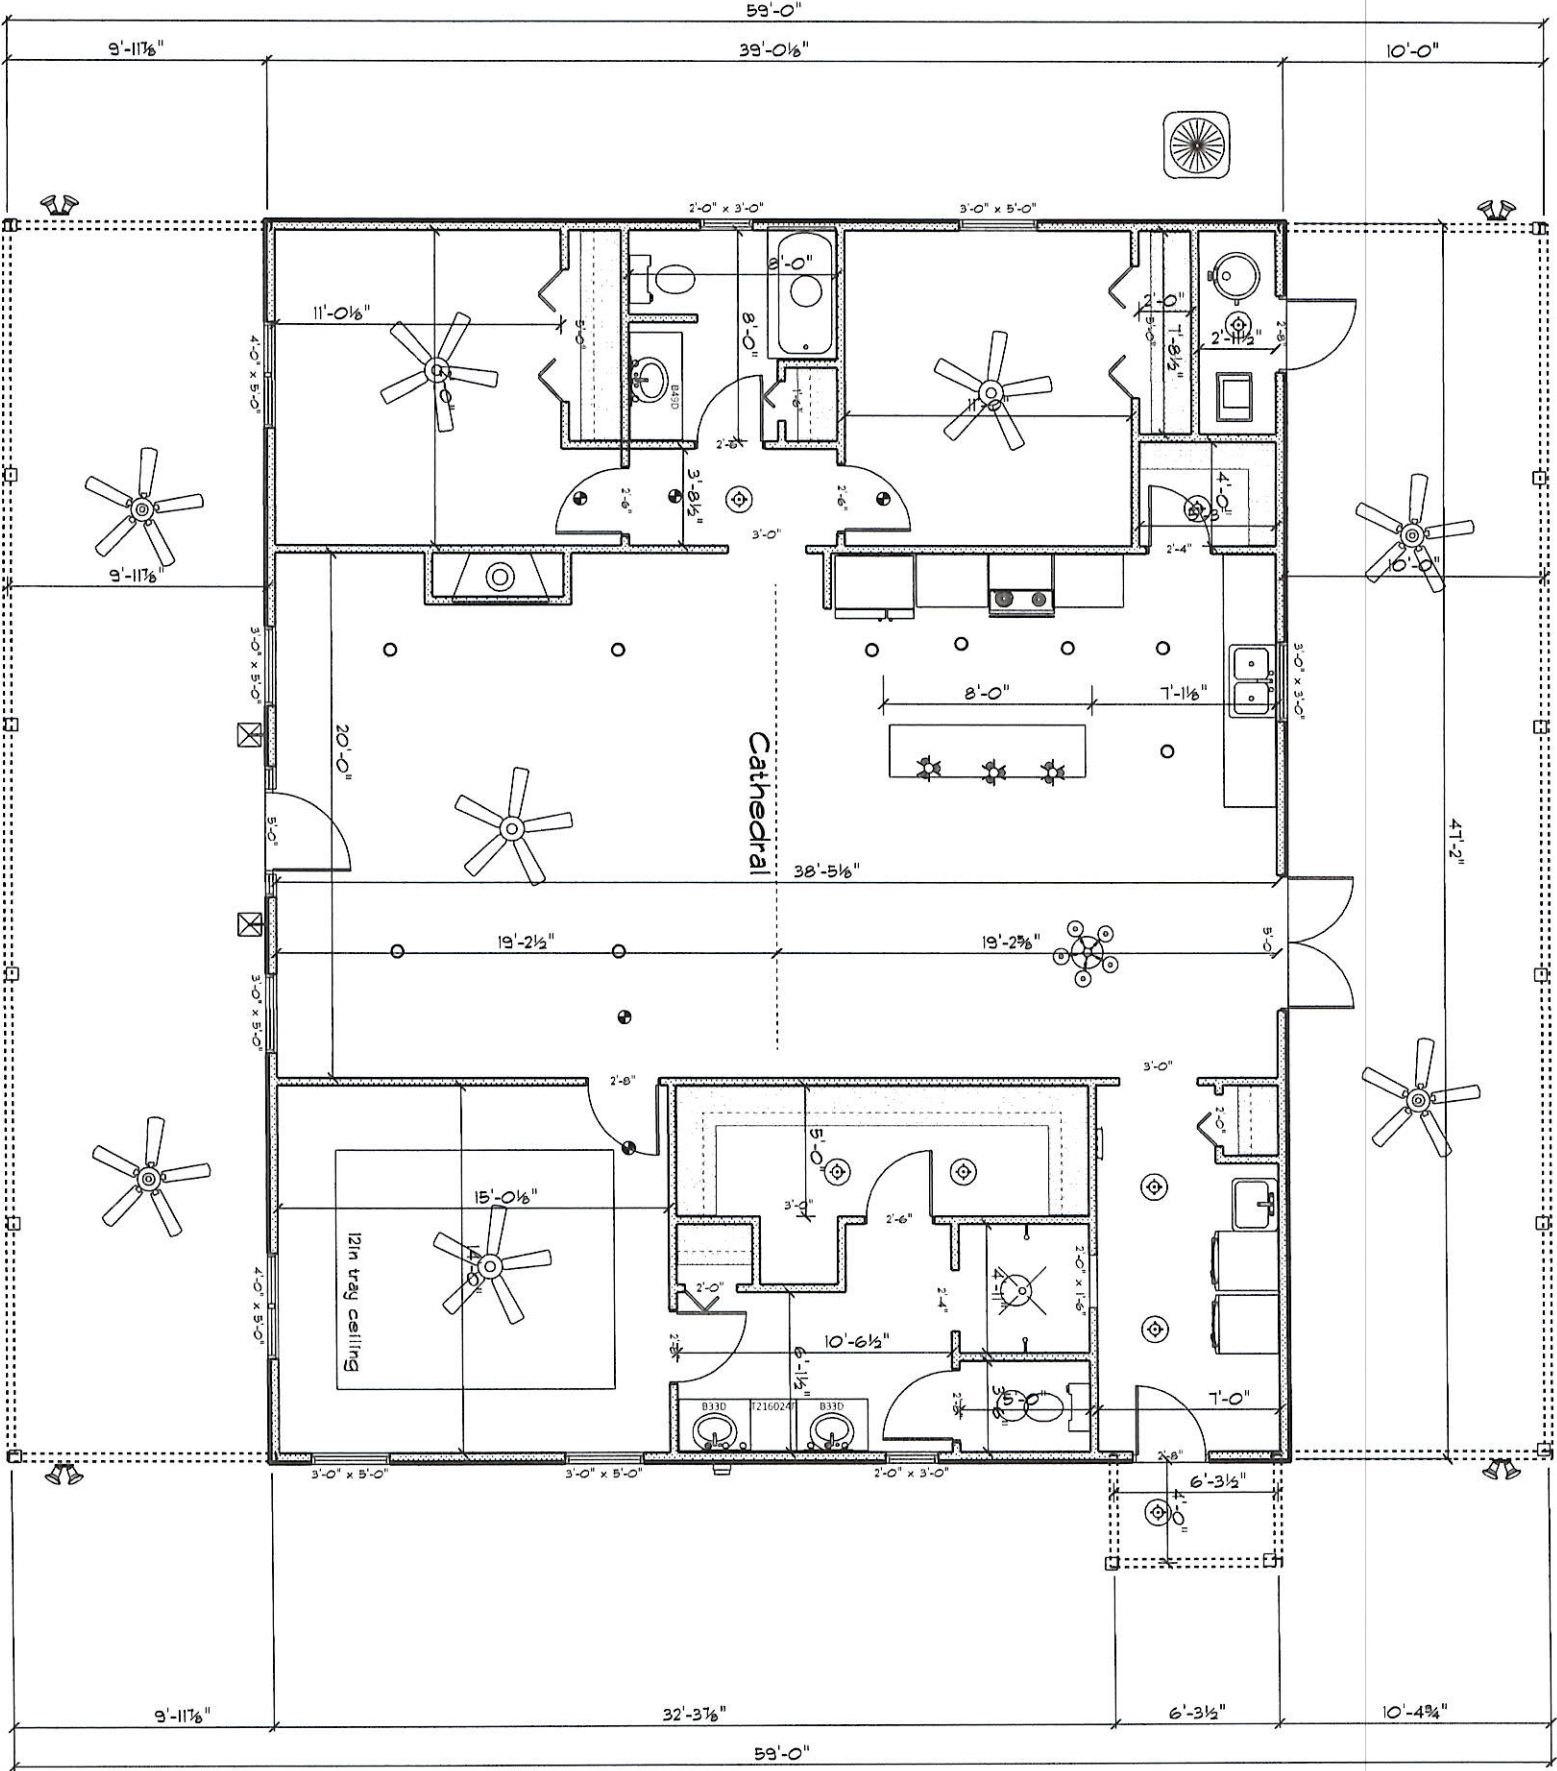


ELECTRICAL LEGEND		
ELECTRICAL	COUNT	SYMBOL
ceiling fan 5 bladed 01	4	
ceiling fan 5 bladed 02	4	
can light 6inch	9	
ceiling light 12	1	
ceiling light 22	3	
ceiling light 39	8	
ceiling light vent round	3	
exterior craftsman light fixture	4	
spotlight double with motion detector	4	
electrical panel	1	
smoke detector	5	
vanity bar light 02	3	

AREA SCHEDULE		
NAME	AREA	
Gross Floor Area	1551.6 sq ft	
Area 2	970.6 sq ft	

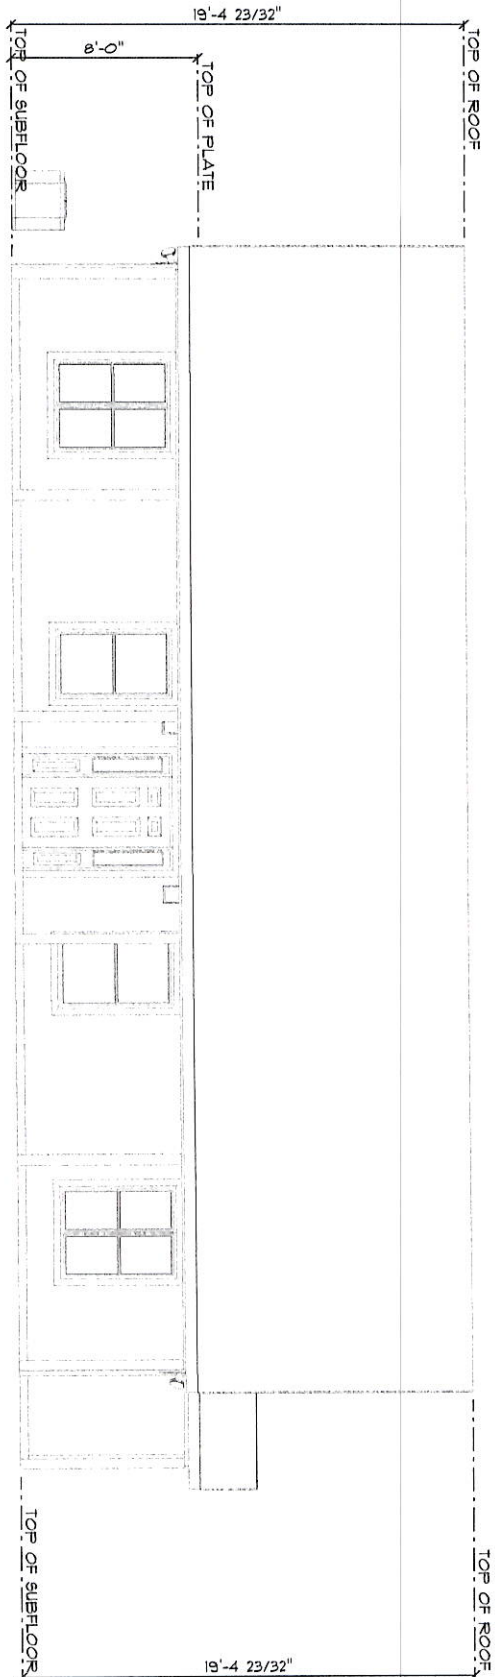


FRONT ELEVATION

SCALE: 1/8" = 1'-0"

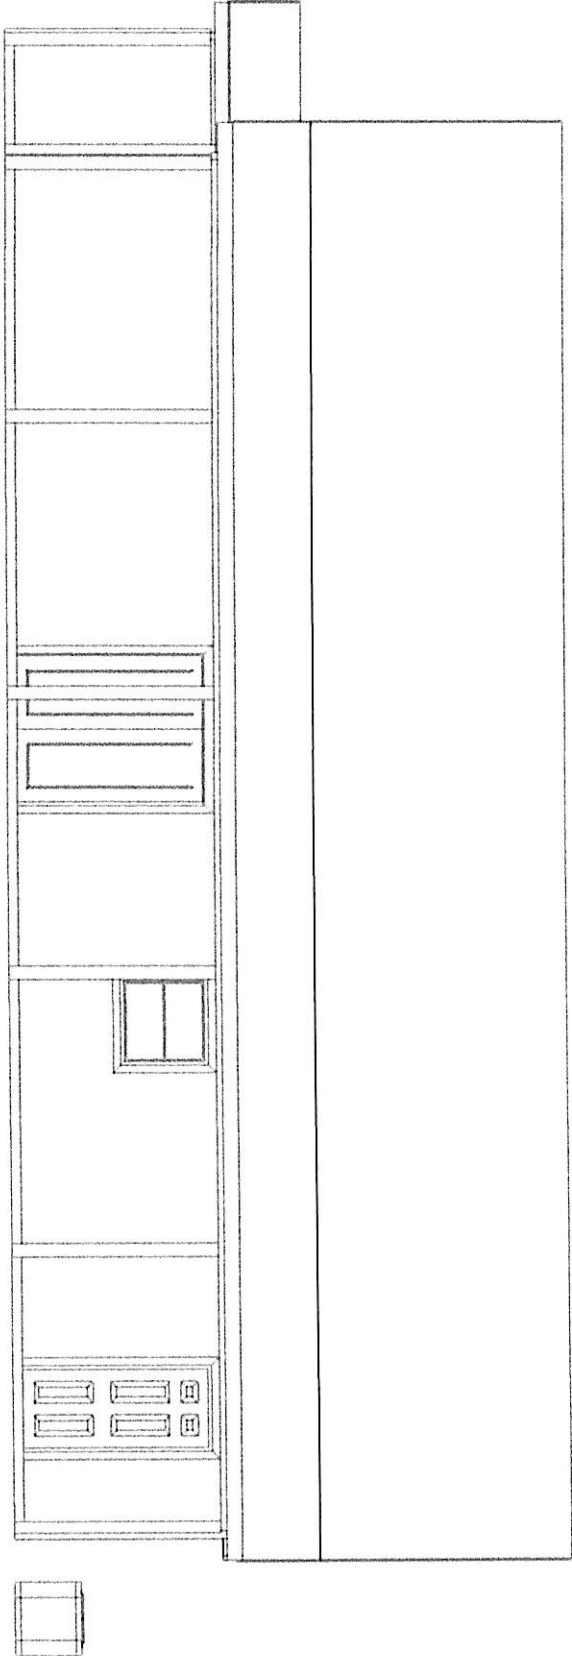


REAR ELEVATION

SCALE: 0.1563" = 1'-0"

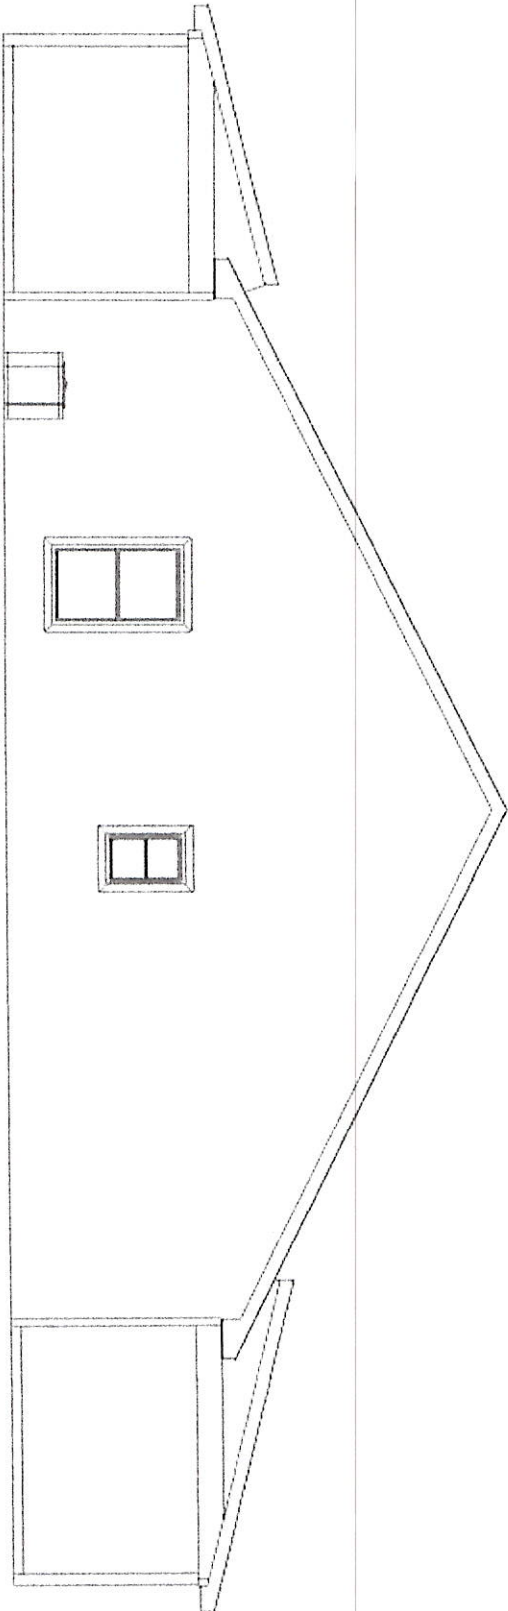

LEFT ELEVATION

SCALE: 0.1406" = 1'-0"

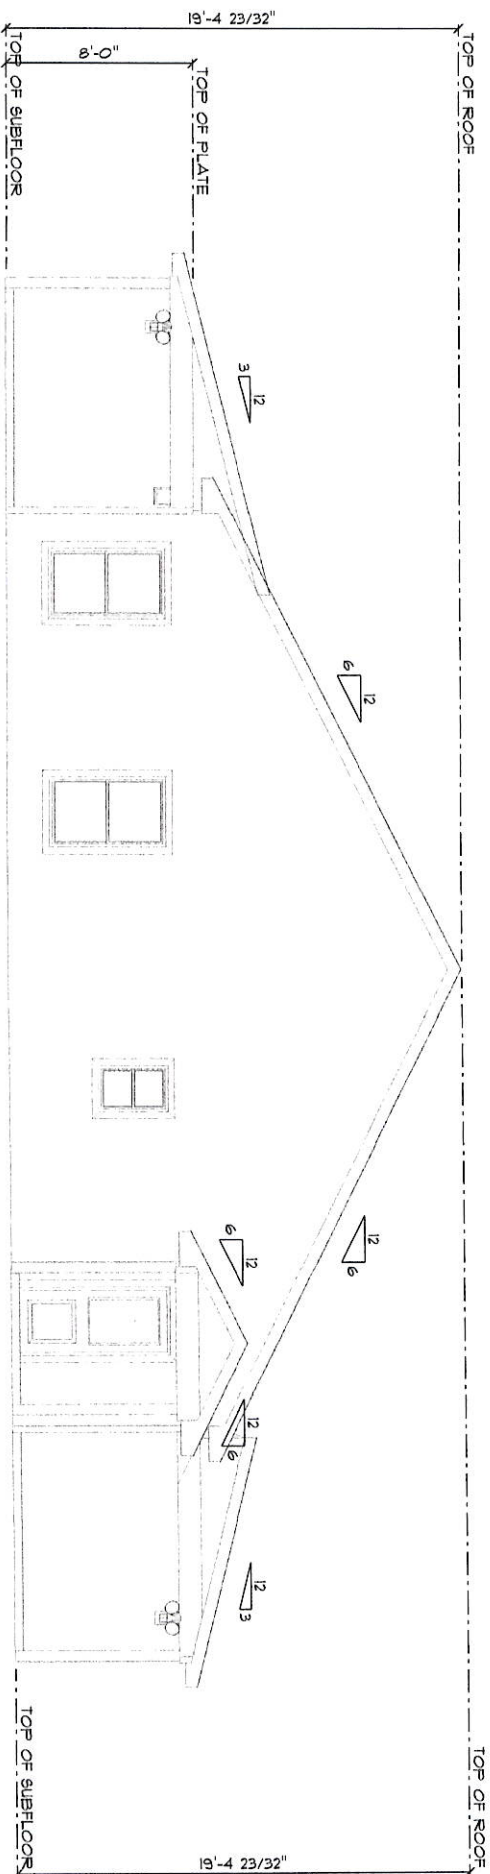

RIGHT ELEVATION

SCALE: 1/8" = 1'-0"