


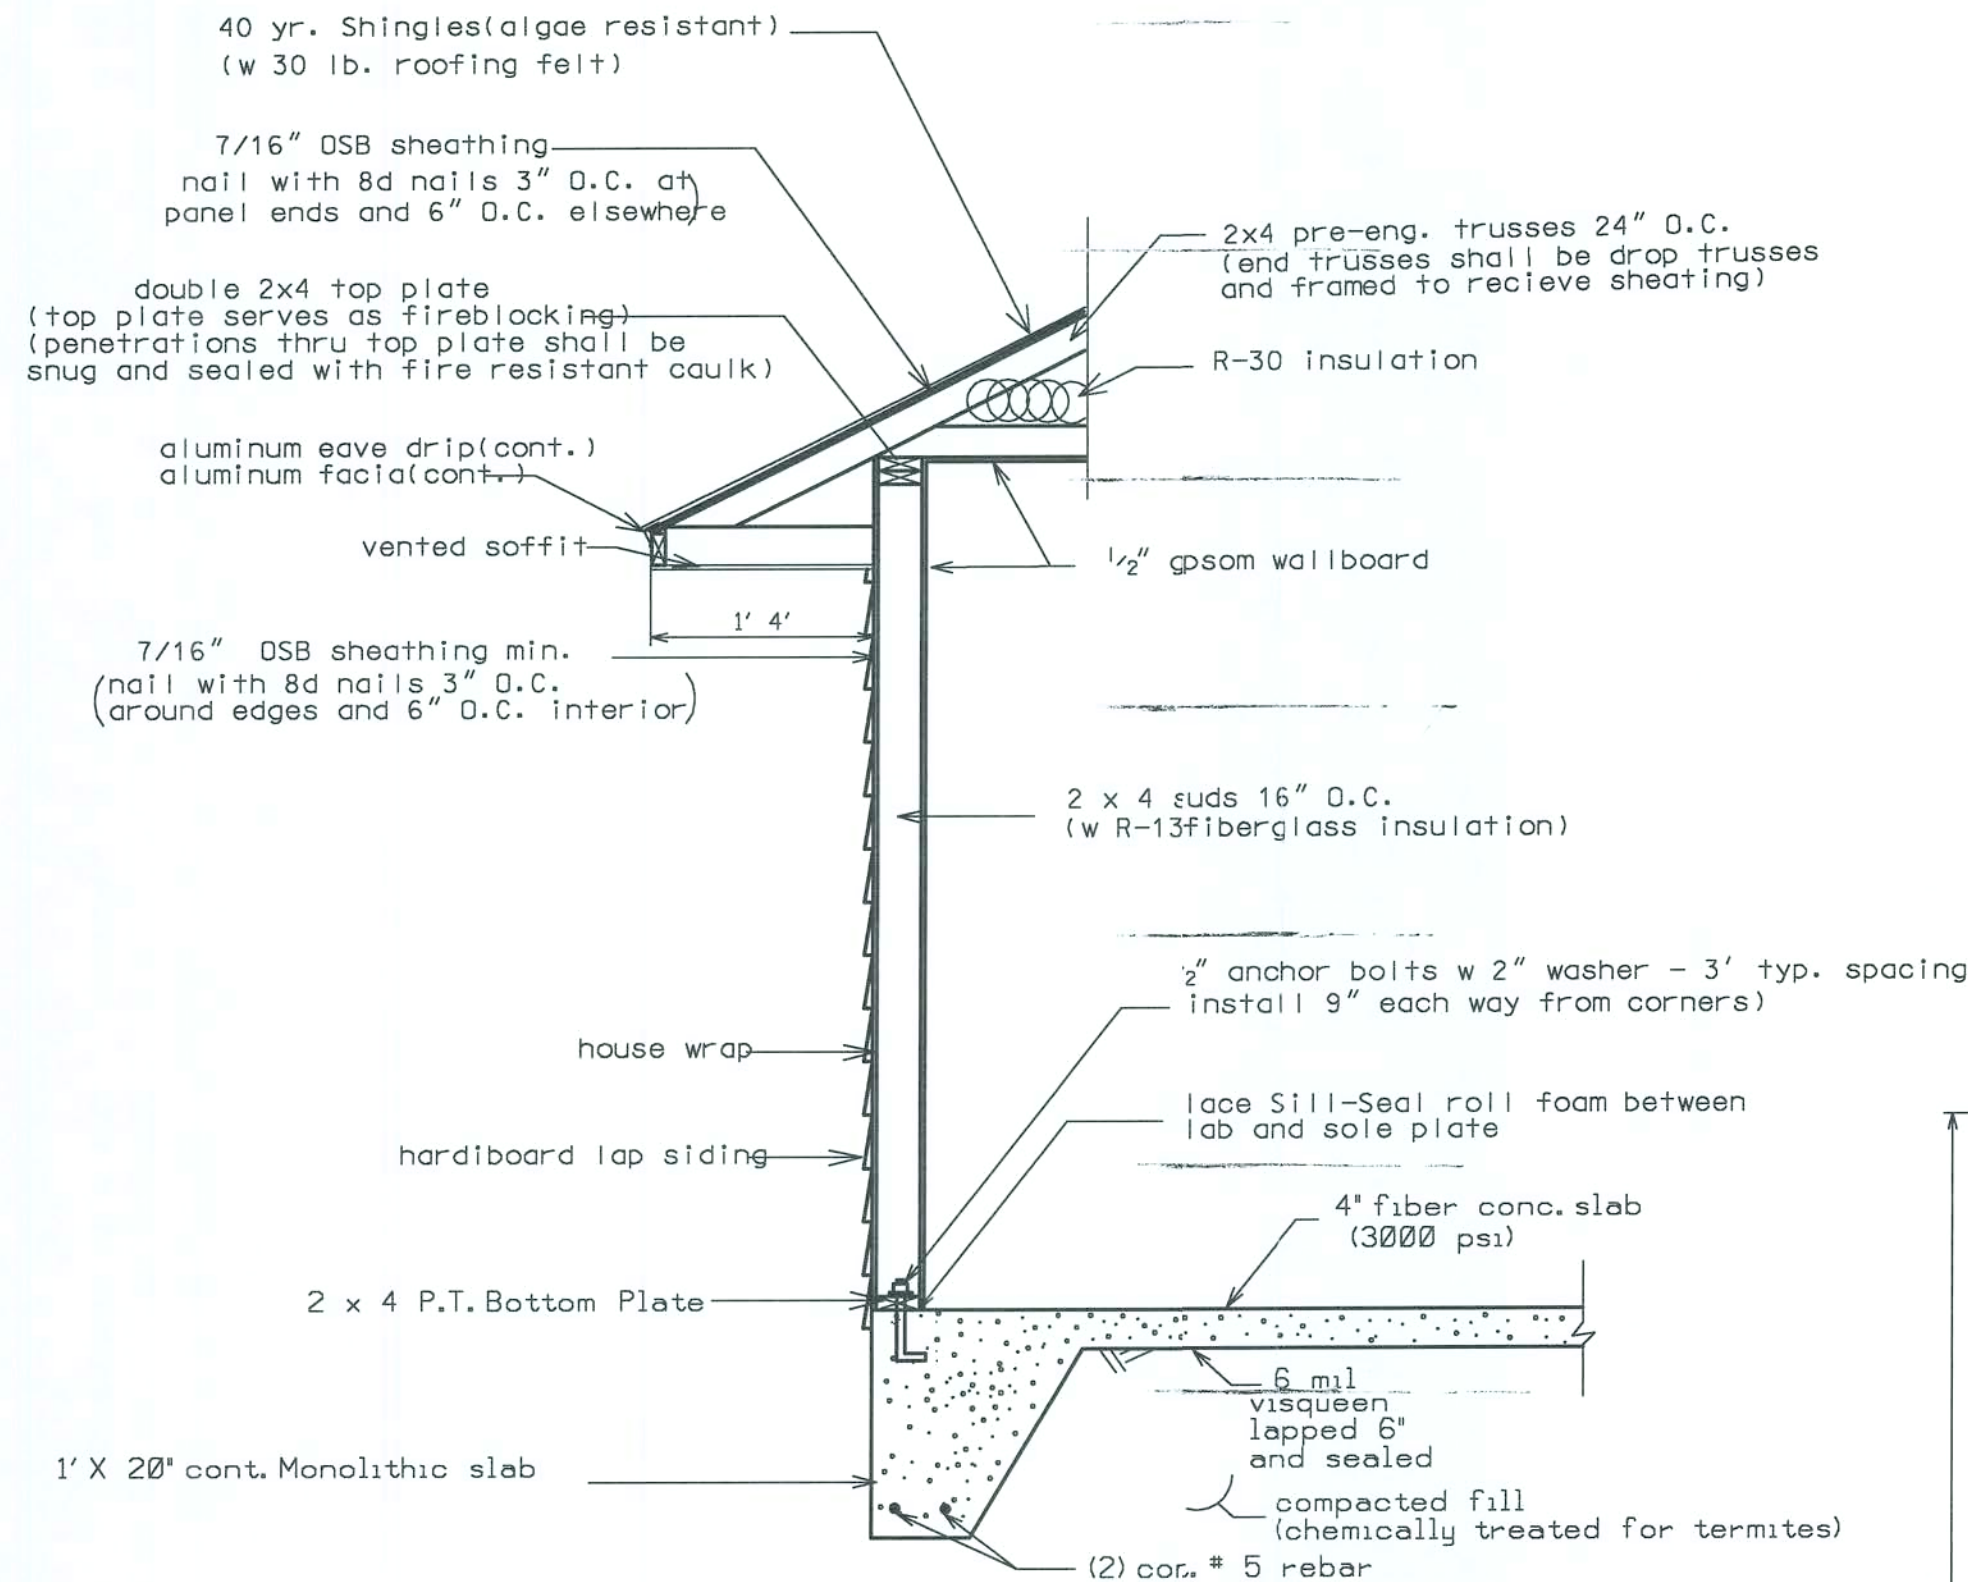


FOOTER DESIGN 1000 PSF WALL DETAIL (TYP.) (N.T.S.)

HEADER SIZES/MATERIAL SHALL BE AS FOLLOWS:
WINDOW AND DOOR OPENINGS (2 - #2 SYP 2X12's with 1/2\"/>

NO NEW PLUMBING FOR THE ADDITION
EXISTING SEPTIC WILL BE UPGRADED.

EXISTING LIVING AREA	1718 SF
EXISTING GARAGE	486 SF
EXISTING PORCH AREA	98 SF
ADDITION AREA	250 SF
TOTAL NEW AREA	2546 SF

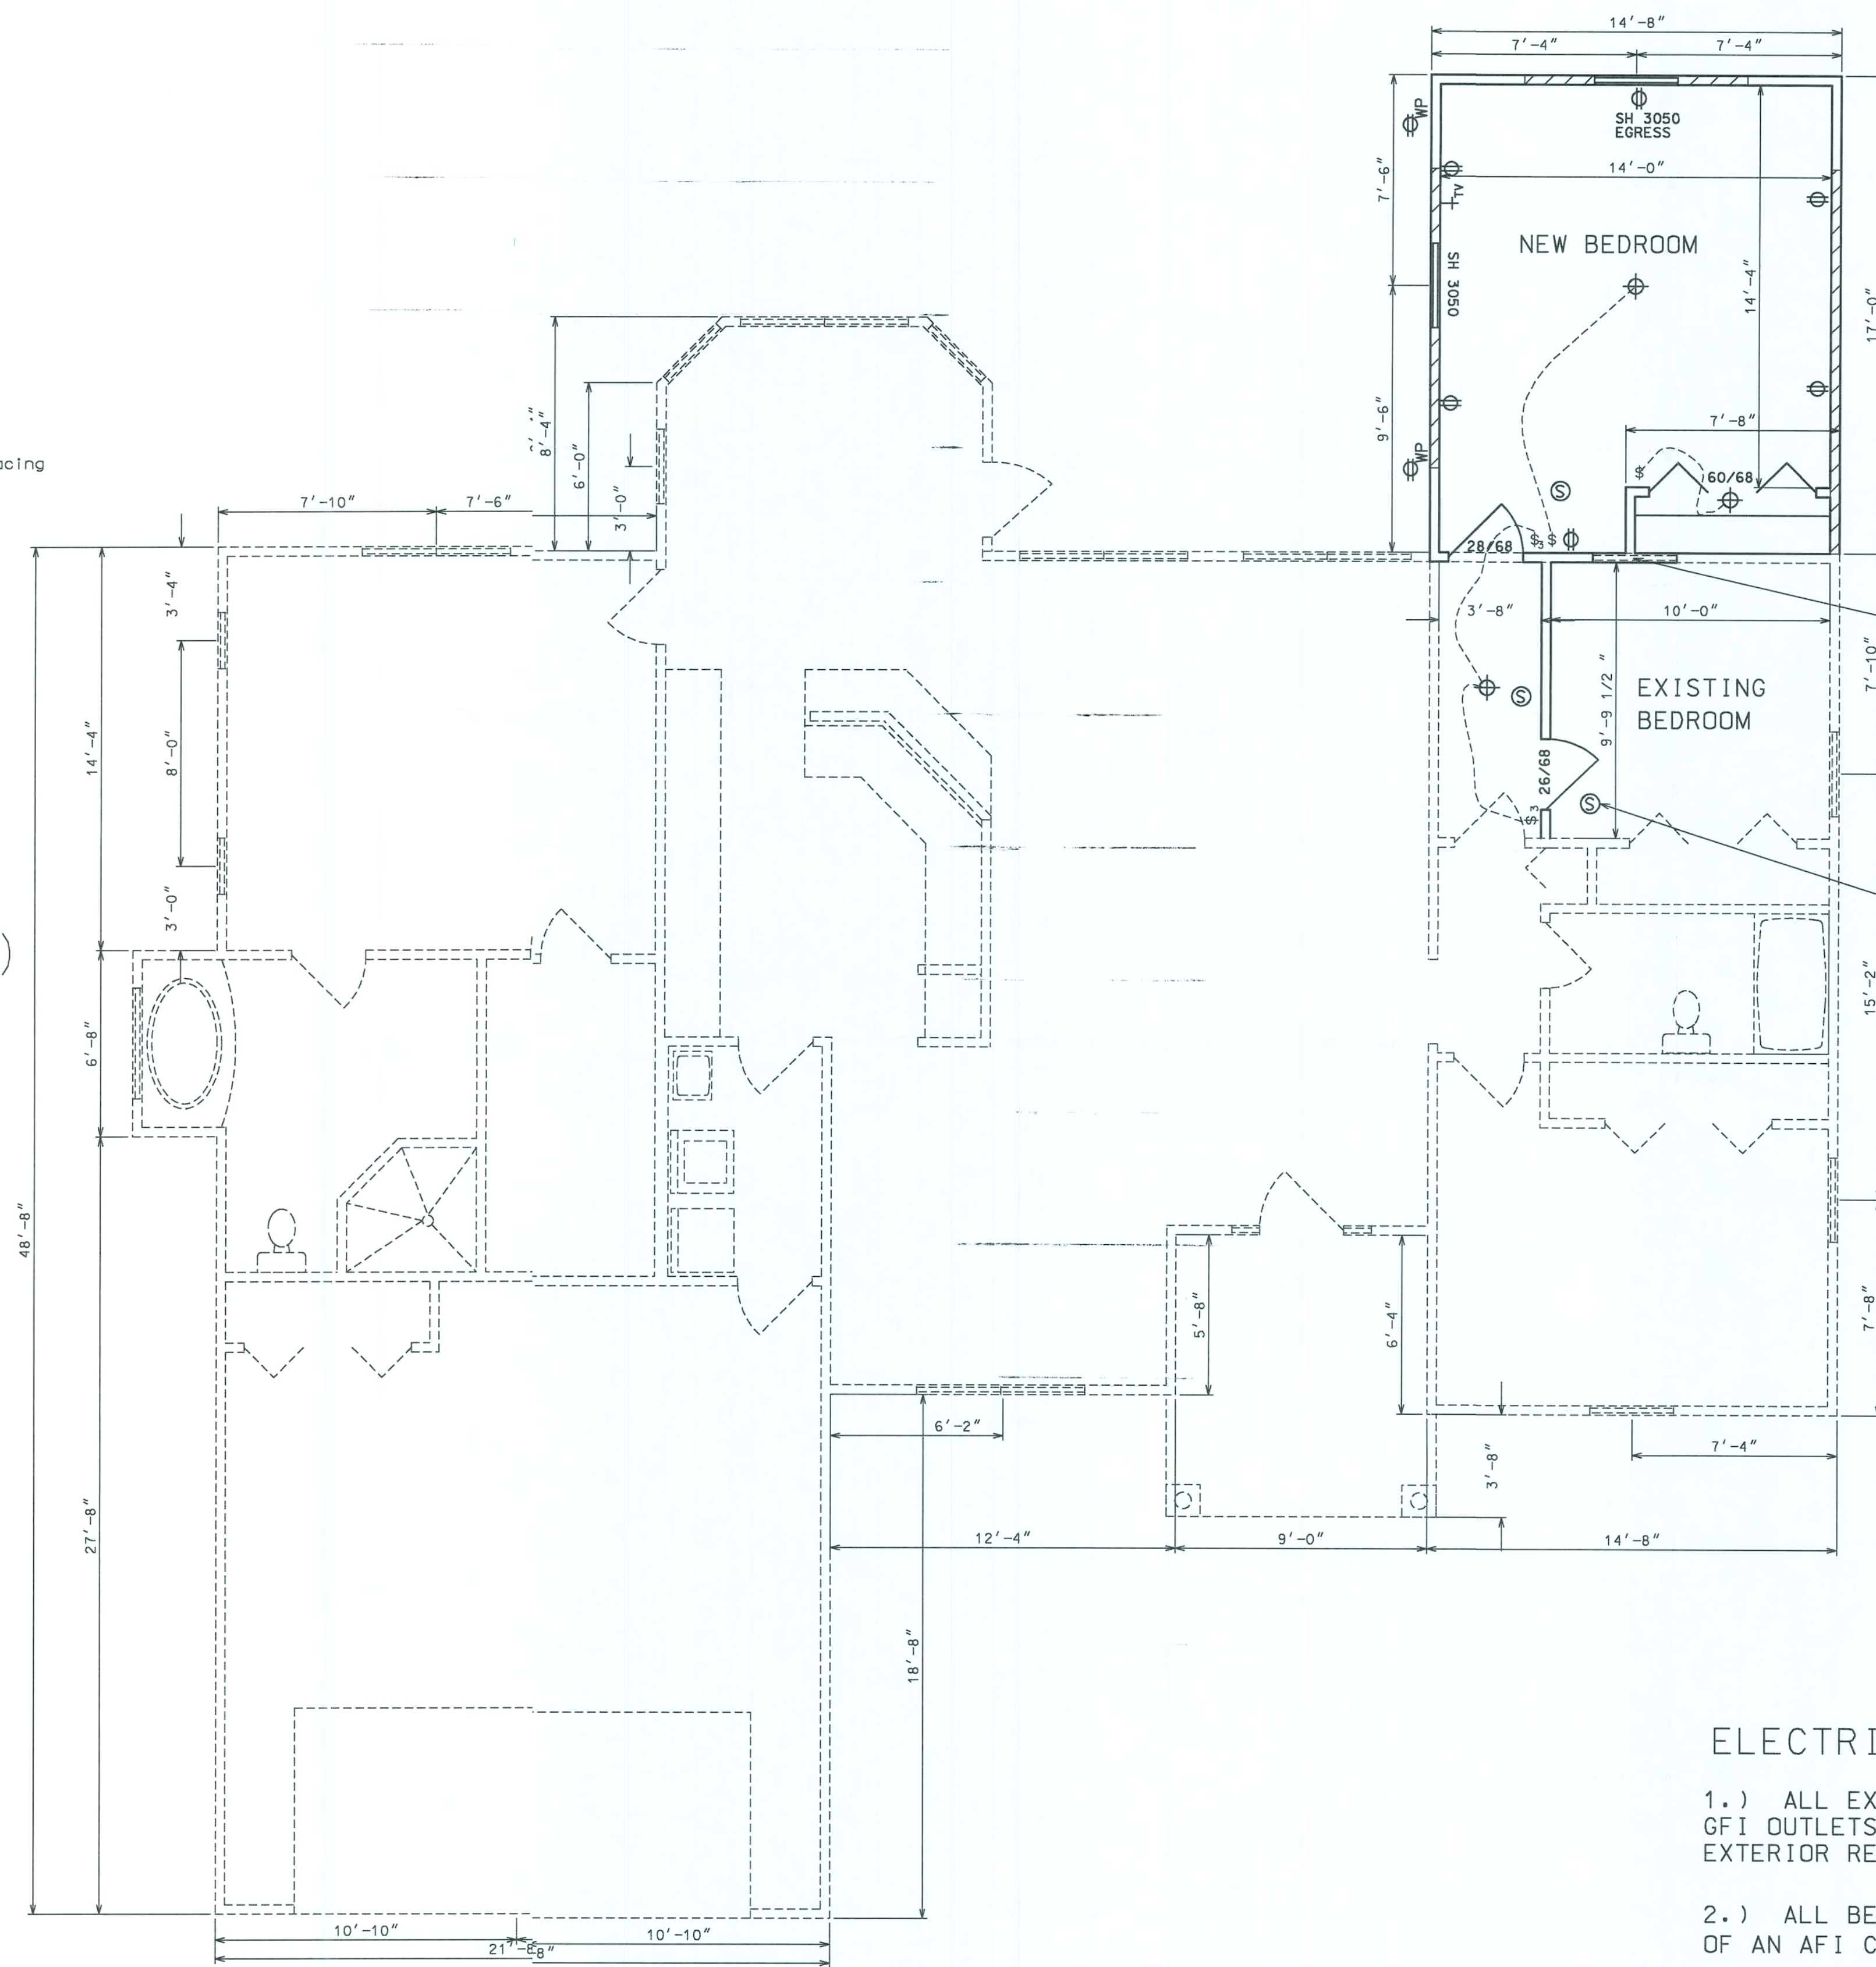

ELECTRICAL LEGEND

- ⊕ - LIGHT FIXTURE
- \$ - SINGLE POLE SWITCH
- \$3 - THREE-WAY ROCKER SWITCH
- ⊕ - RECEPT.
- Ⓢ - SMOKE DETECTOR (AC/DC and interconnected)
- Ⓣ - TELEPHONE

ELECTRICAL NOTES:

- 1.) ALL EXTERIOR RECEPTACLES SHALL EITHER BE GFI OUTLETS OR PART OF A GFI CIRCUIT. ALL EXTERIOR RECEPTACLES SHALL BE WEATHERPROOF.
- 2.) ALL BEDROOM RECEPTACLES SHALL BE PART OF AN AFI CIRCUIT.

SHEARWALL LOCATIONS

NOTE: ALL DASHED LINE ARE EXISTING CONDITIONS



HAYGOOD HOMES INC.

12592 So. U.S. HWY 441
LAKE CITY FL. 32025
OFFICE (386) 752-3496
MOBILE (386) 303-1981
CR-C1326715


KEN AND KINDA GARTIN
192 SW BLUE CT.
FORT WHITE FLORIDA

FLOORPLAN

PLAN No.	SCALE	DATE	SHEET NO.
P 0701	1/4" = 1'	01/27/07	3

NO CHANGE TO FRONT

FRONT ELEVATION

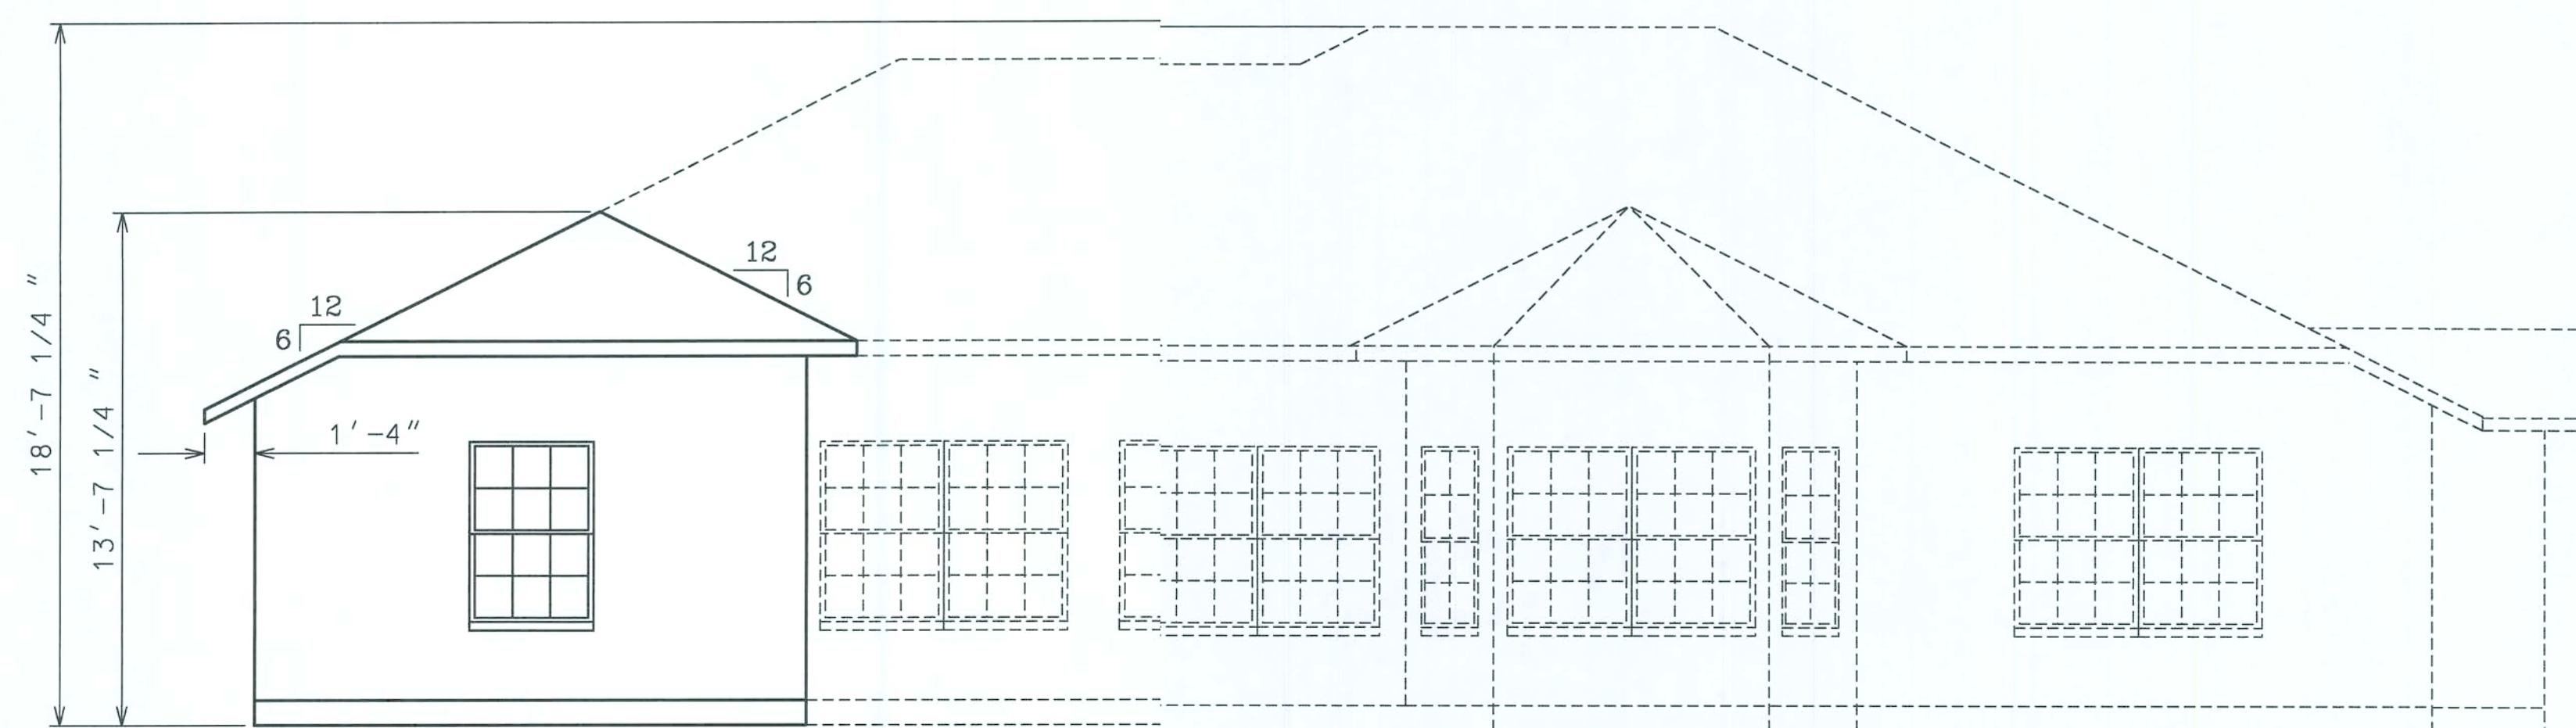

REAR ELEVATION

NOTE: ALL DASHED LINE ARE EXISTING CONDITIONS

THESE DRAWINGS, AS INSTRUMENTS OF SERVICE, ARE THE SOLE PROPERTY OF HAYGOOD HOMES, INC. AND ARE NOT TO BE USED, COPIED OR REPRODUCED IN WHOLE OR IN PART FOR USE ON OR INCORPORATED WITHIN ANY OTHER JOB WITHOUT SPECIFIC AND INDIVIDUAL AUTHORIZATION BY HAYGOOD HOMES, INC.




HAYGOOD HOMES INC.

12592 So. U.S. HWY 441
LAKE CITY FL 32025
OFFICE (386) 752-3496
MOBILE (386) 303-1981
CR-C1326715

KEN AND KINDA GARTIN
1932 SW BLUE CT.
FORT WHITE FLORIDA


ELEVATION

PLAN No.	SCALE	DATE	SHEET NO.
P 0701	1/4" = 1'	01/27/07	1

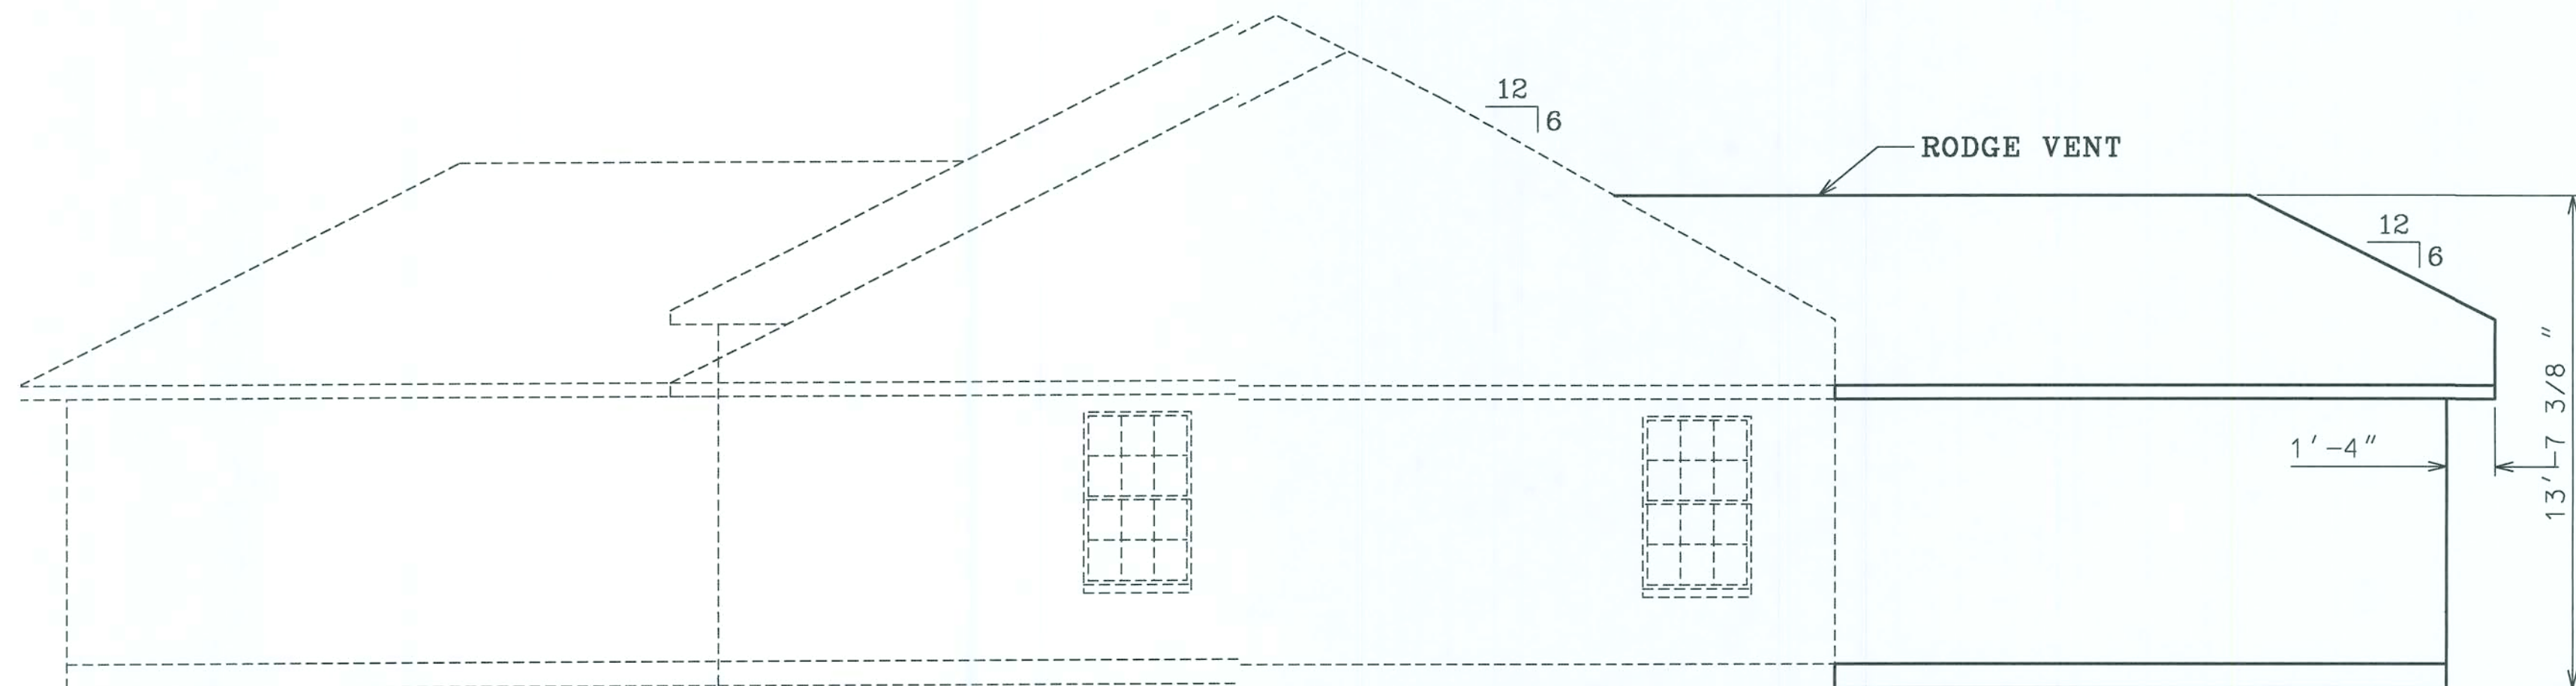

RIGHT ELEVATION

NOTE: ALL DASHED LINE ARE EXISTING CONDITIONS

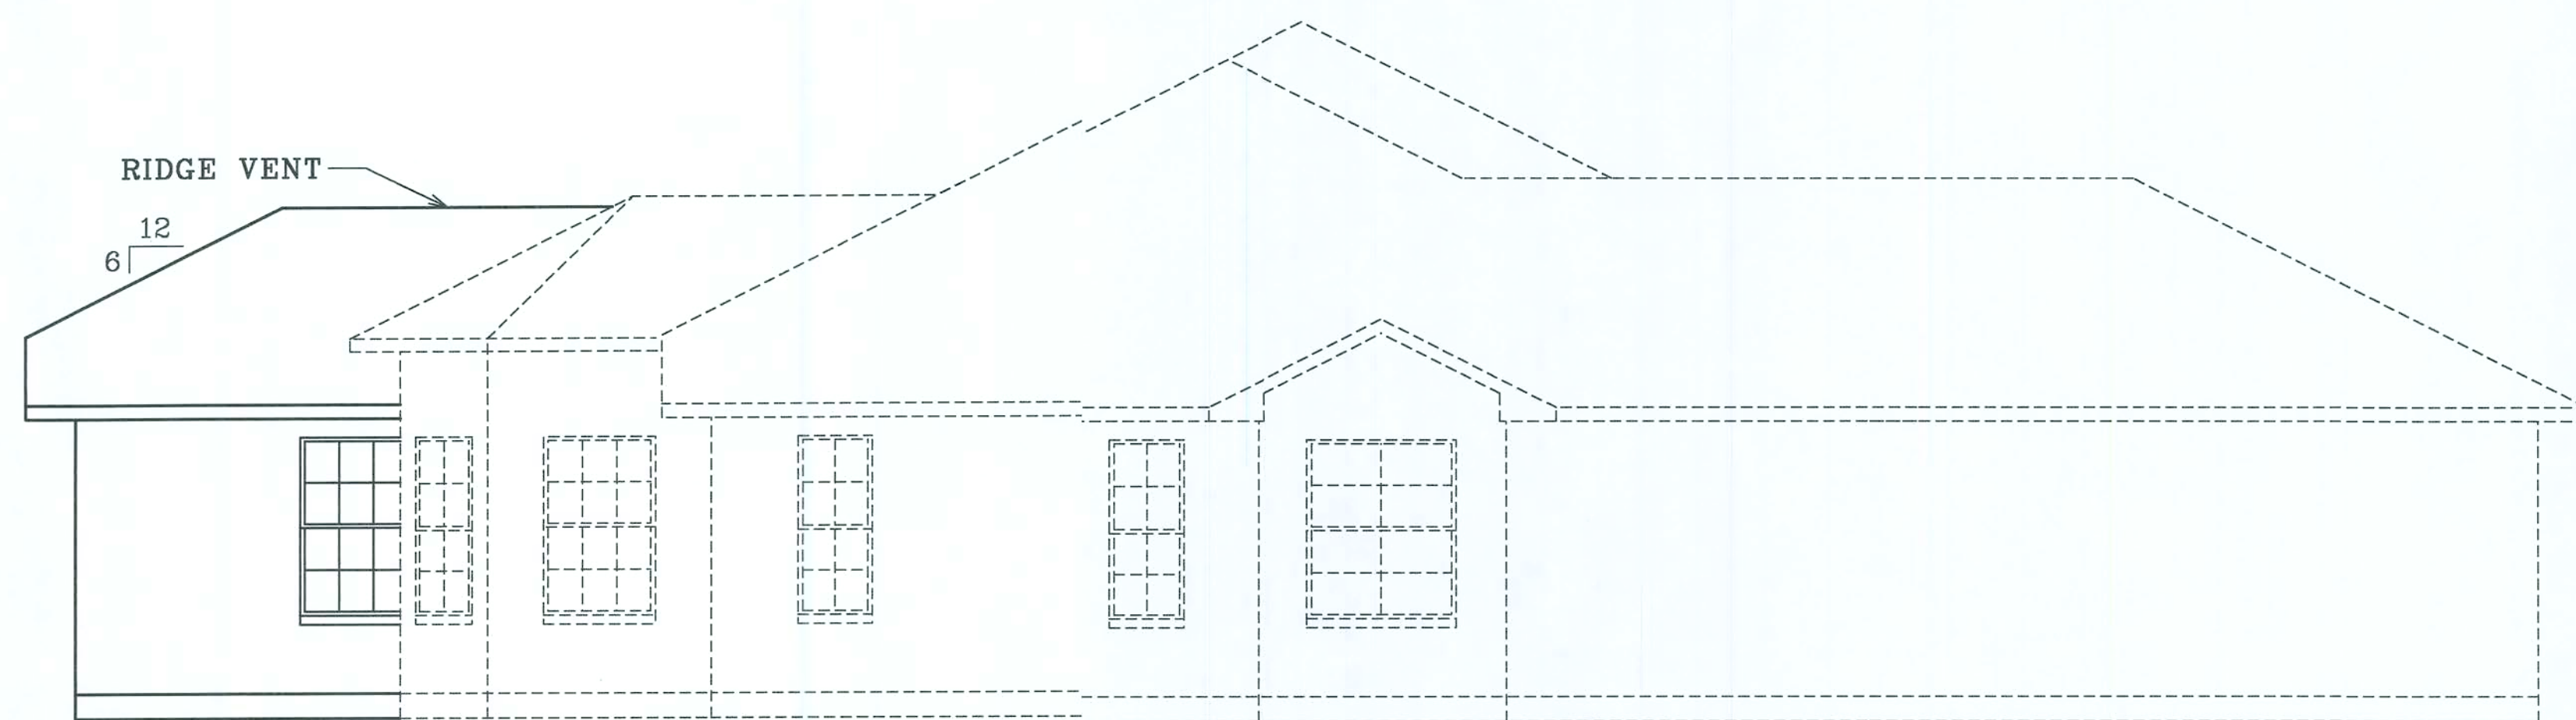

LEFT ELEVATION

NOTE: ALL DASHED LINE ARE EXISTING CONDITIONS

THESE DRAWINGS, AS INSTRUMENTS OF SERVICE, ARE THE SOLE PROPERTY OF HAYGOOD HOMES, INC.. AND ARE NOT TO BE USED, COPIED OR REPRODUCED IN WHOLE OR IN PART FOR USE ON OR INCORPORATED WITHIN ANY OTHER JOB WITHOUT SPECIFIC AND INDIVIDUAL AUTHORIZATION BY HAYGOOD HOMES, INC..



HAYGOOD HOMES INC.


12592 So. U.S. HWY 441
LAKE CITY FL. 32025
OFFICE (386) 752-3496
MOBILE (386) 303-1981
CR-C1326715

KEEN AND KINDA GARTIN
192 SW BLUE CT.
FORT WHITE FLORIDA

ELEVATION

PLAN No.	SCALE	DATE	SHEET NO.
P 0701	1/4" = 1'	01/27/07	2

THESE DRAWINGS, AS INSTRUMENTS OF SERVICE, ARE THE SOLE PROPERTY OF HAYGOOD HOMES, INC., AND ARE NOT TO BE USED, COPIED OR REPRODUCED IN WHOLE OR IN PART FOR USE ON OR INCORPORATED WITHIN ANY OTHER JOB WITHOUT SPECIFIC AND INDIVIDUAL AUTHORIZATION BY HAYGOOD HOMES, INC..

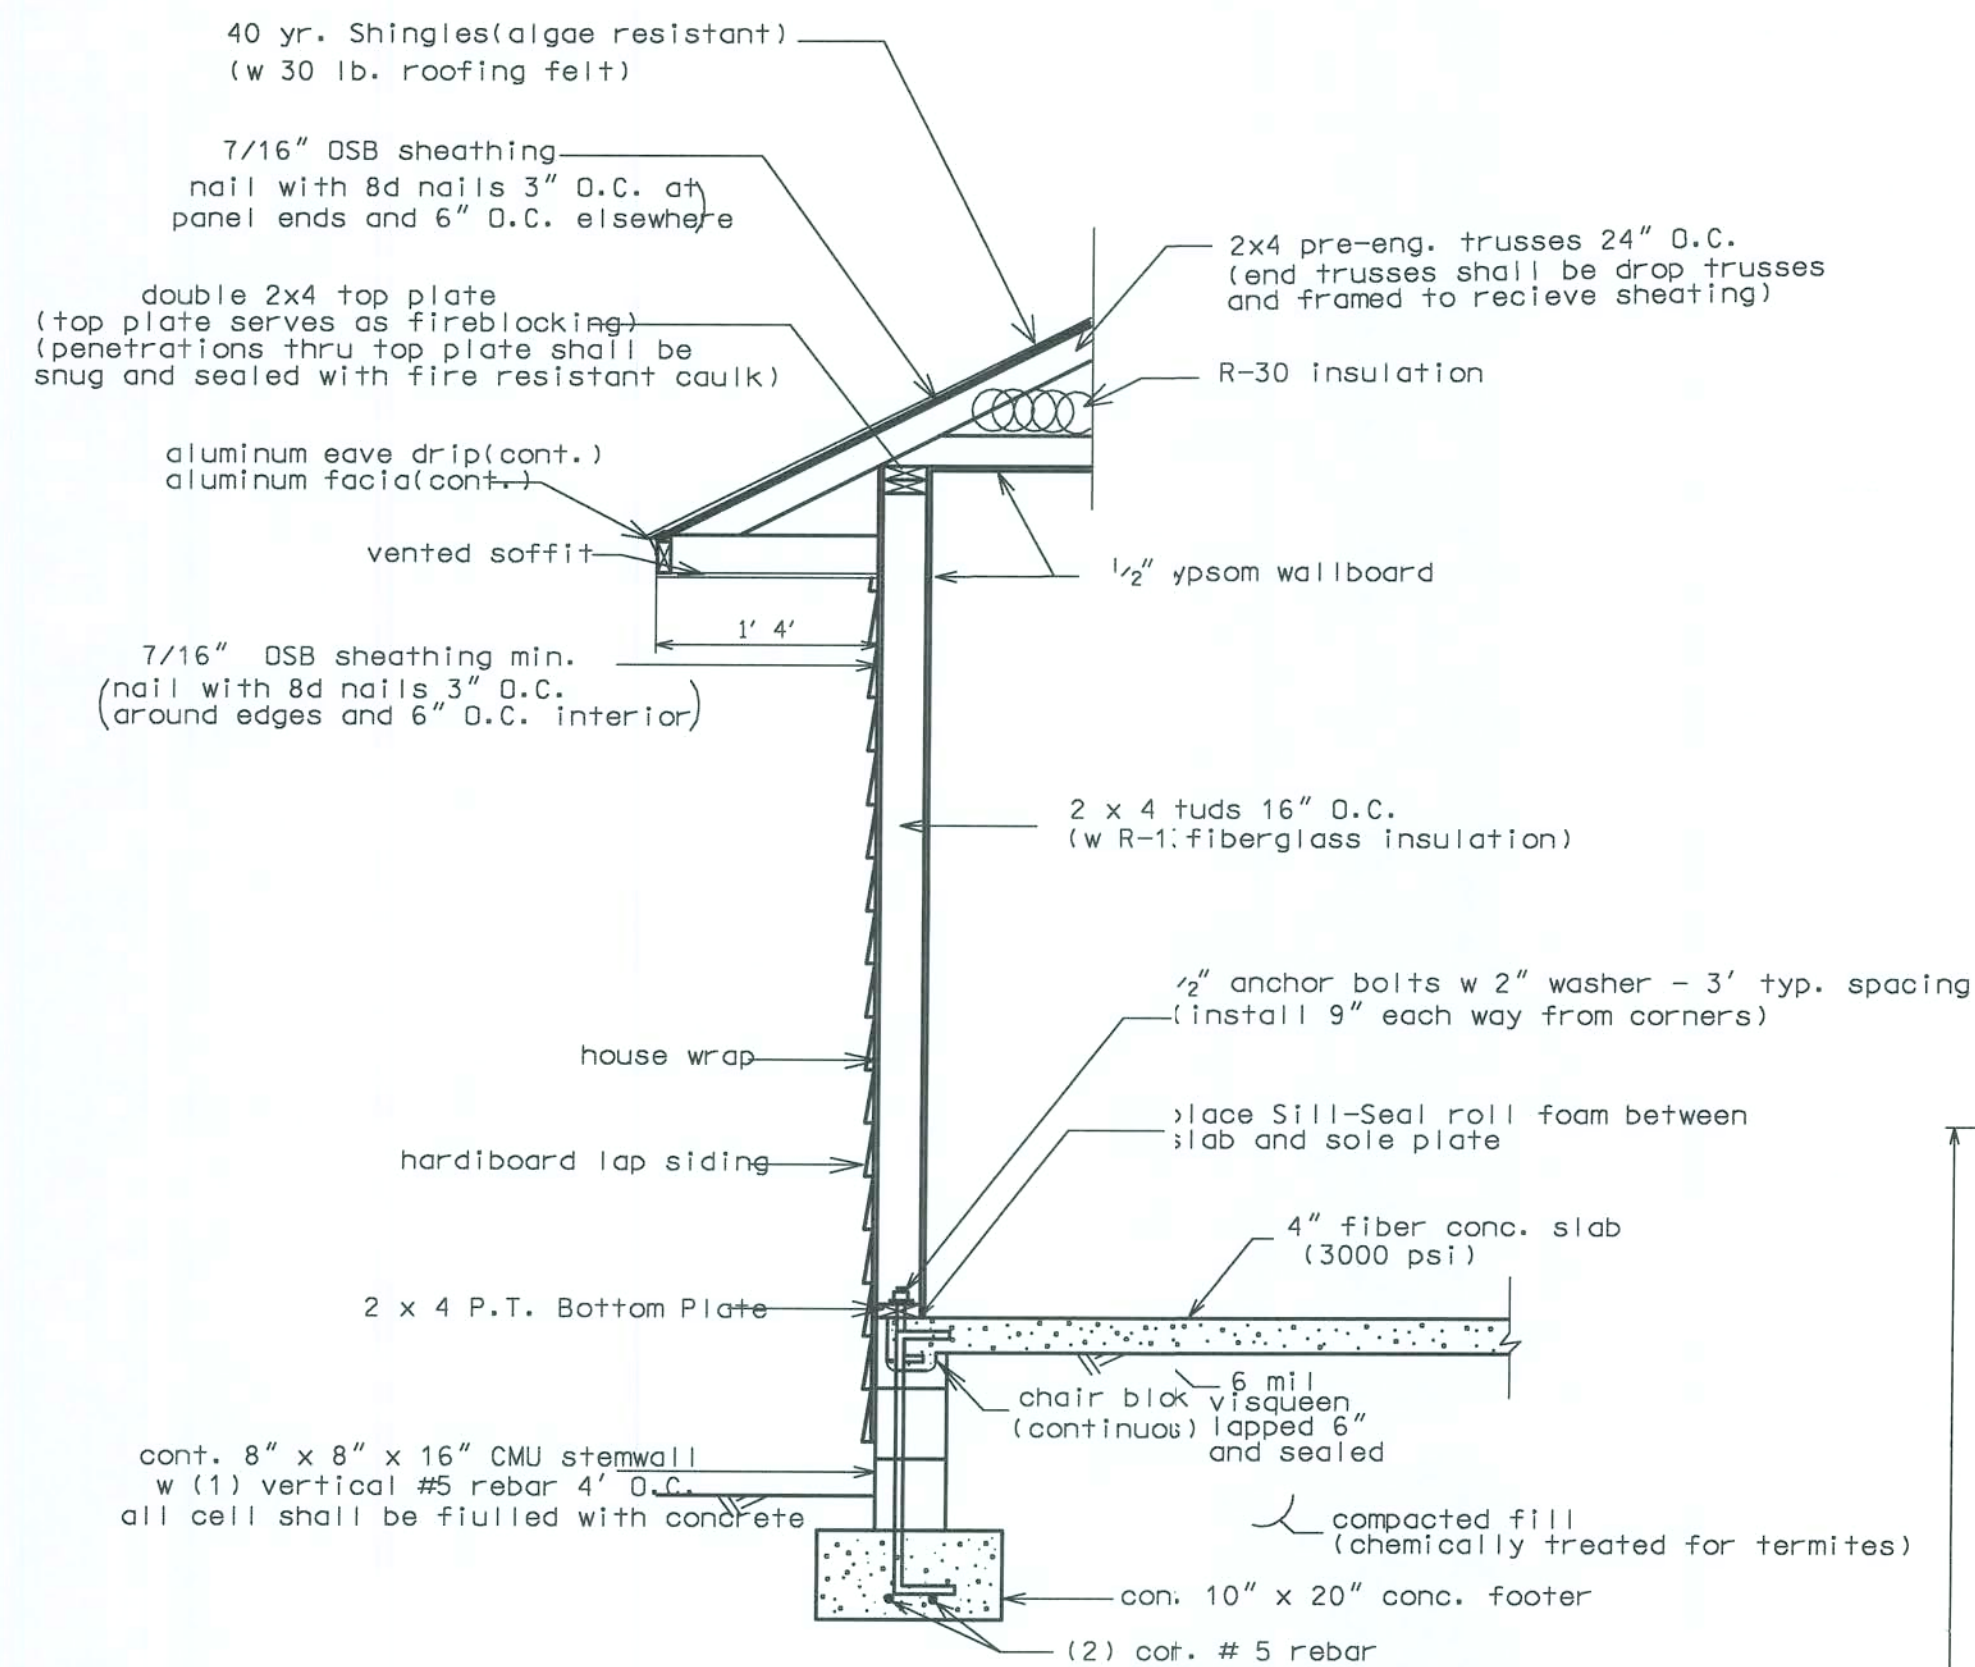


FOOTER DESIGN 1000 PSF WALL DETAIL (TYP.) (N.T.S.)

HEADER SIZES/MATERIAL SHALL BE AS FOLLOWS:

WINDOW AND DOOR OPENINGS (2 - #2 SYP 2X12's with 1/2" plywood between)
PORCH BEAMS (2 - #2 SYP 2X10's with 1/2" plywood between)

NO NEW PLUMBING FOR THE ADDITION
EXISTING SEPTIC WILL BE UPGRADED.

EXISTING LIVING AREA	1718 SF
EXISTING GARAGE	486 SF
EXISTING PORCH AREA	98 SF
ADDITION AREA	250 SF
TOTAL NEW AREA	2546 SF

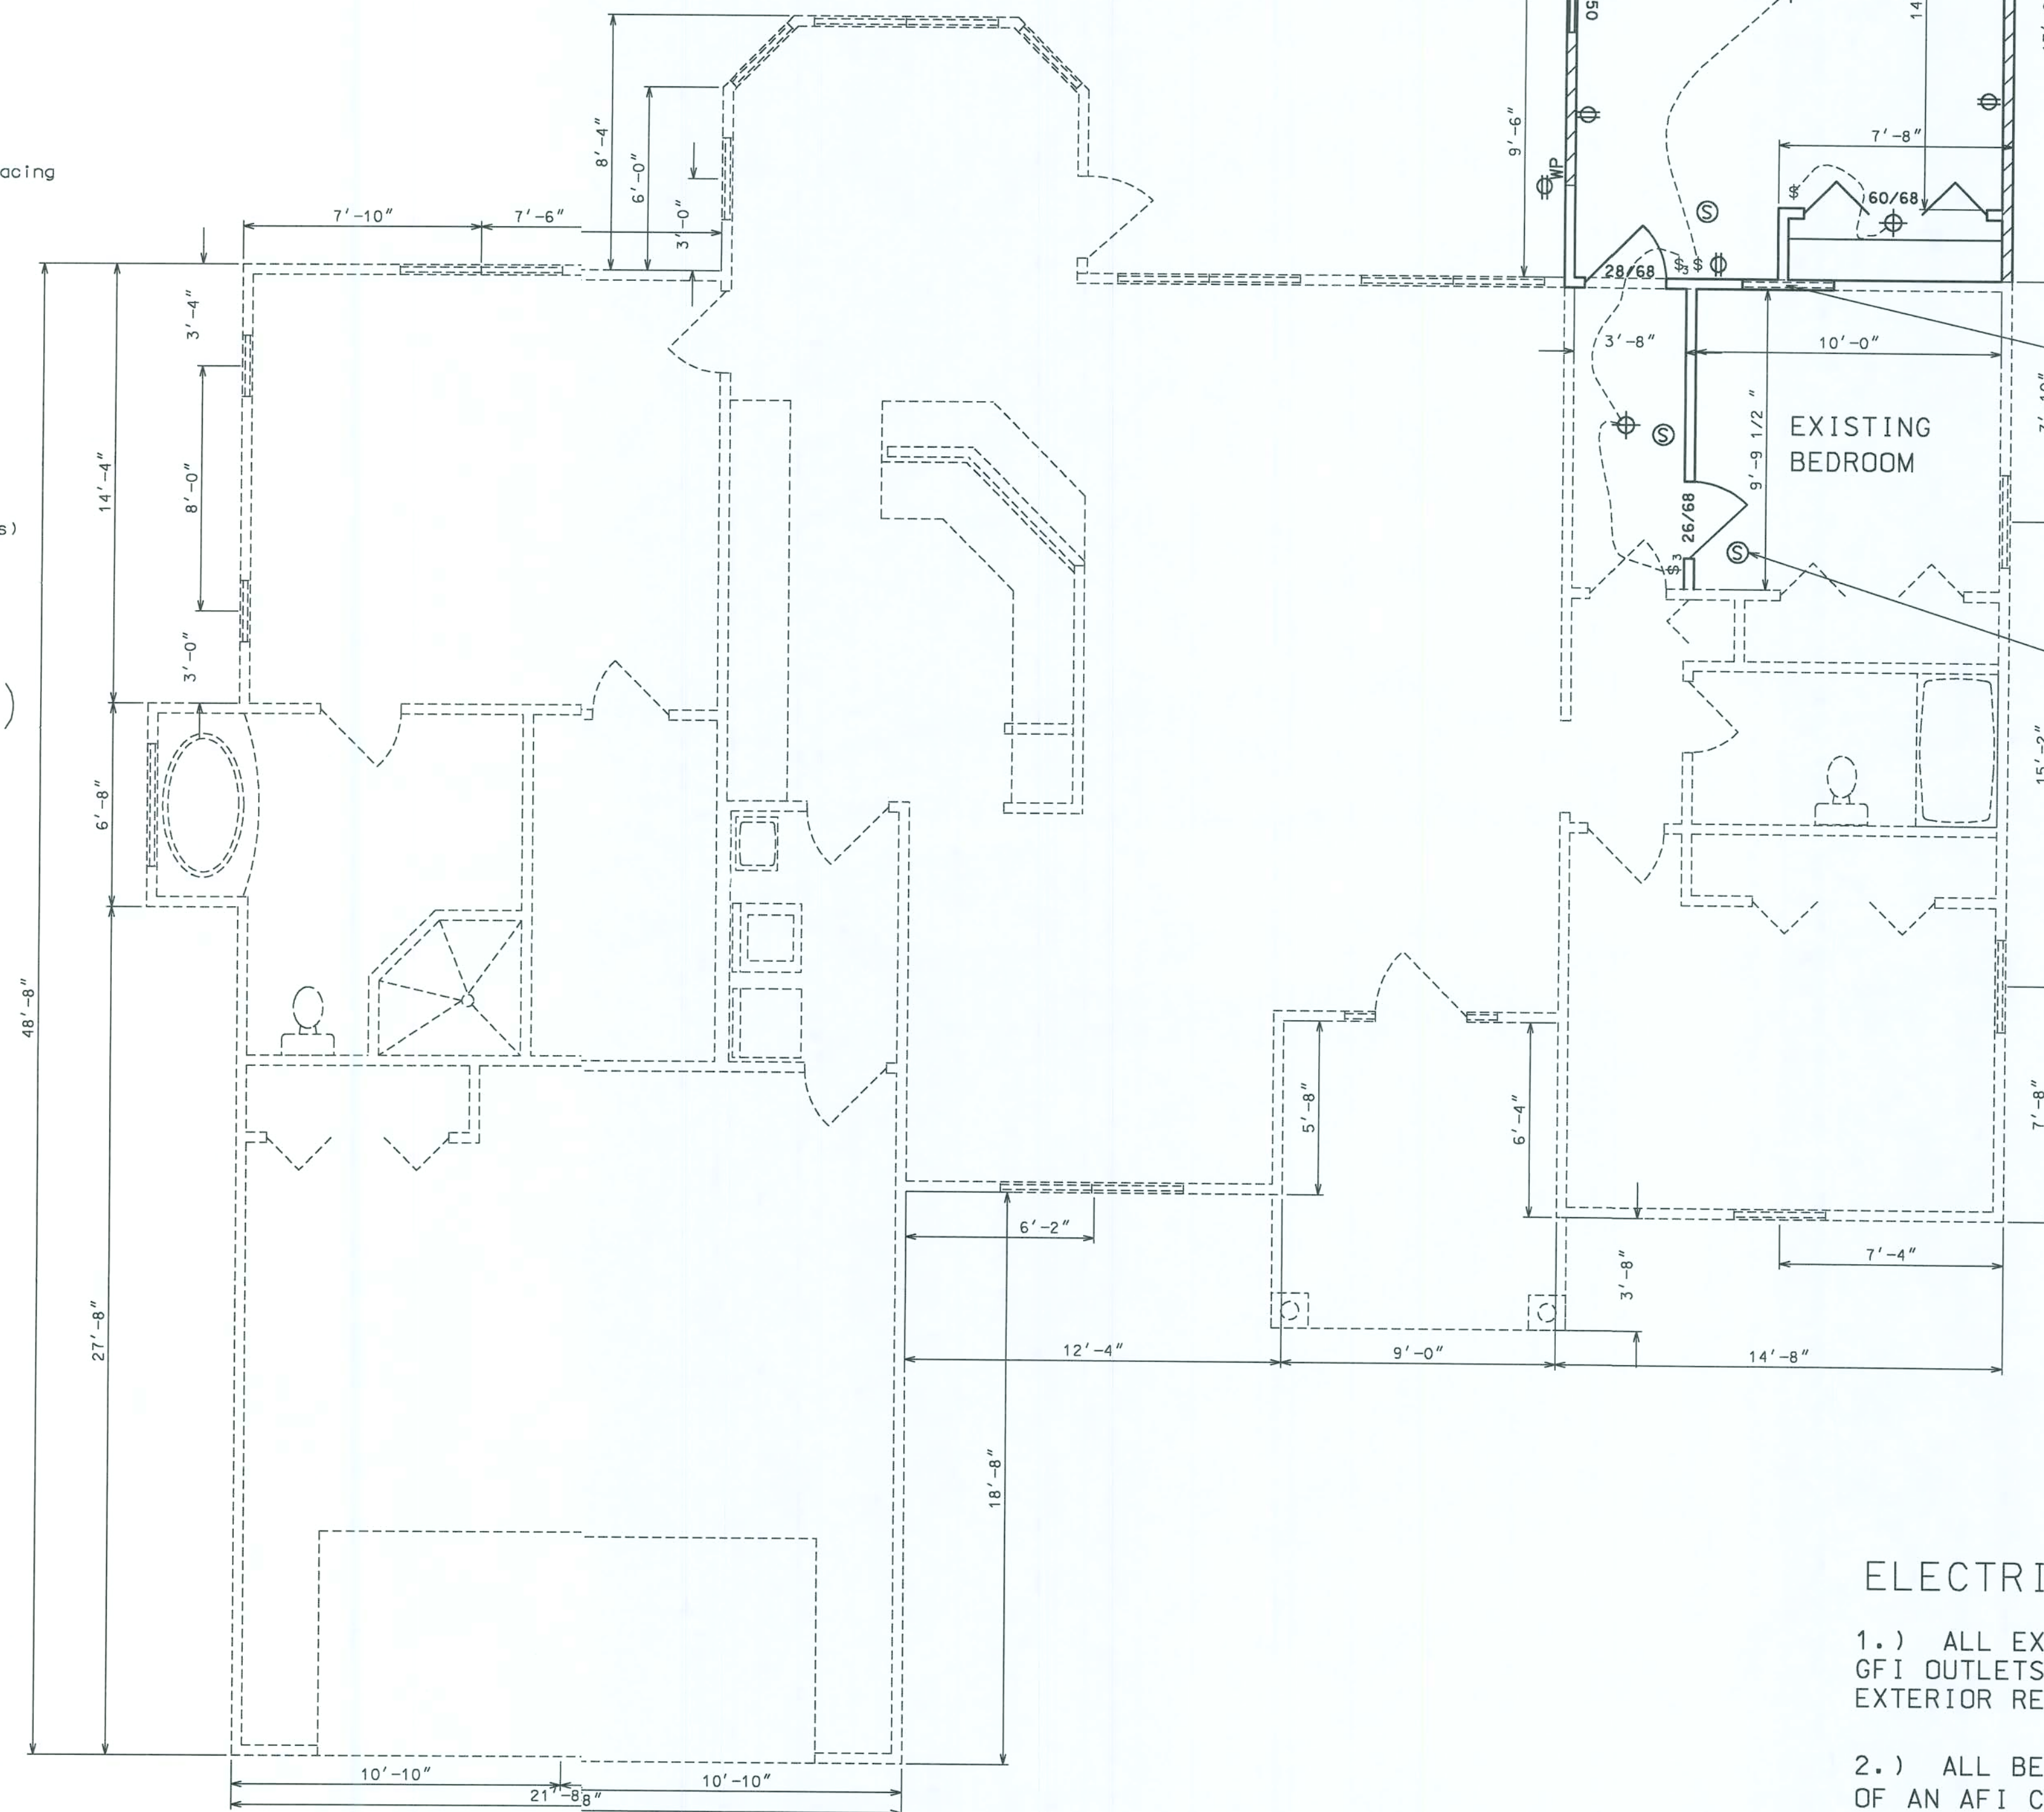

ELECTRICAL LEGEND

- ⊕ - LIGHT FIXTURE
- \$ - SINGLE POLE SWITCH
- \$₃ - THREE-WAY ROCKER SWITCH
- ⊕ - RECEPT.
- Ⓢ - SMOKE DETECTOR (AC/DC and interconnected)
- ☎ - TELEPHONE

ELECTRICAL NOTES:

- 1.) ALL EXTERIOR RECEPTACLES SHALL EITHER BE GFI OUTLETS OR PART OF A GFI CIRCUIT. ALL EXTERIOR RECEPTACLES SHALL BE WEATHERPROOF.
- 2.) ALL BEDROOM RECEPTACLES SHALL BE PART OF AN AFI CIRCUIT.

SHEARWALL LOCATIONS

NOTE: ALL DASHED LINE ARE EXISTING CONDITIONS



HAYGOOD HOMES INC.

12592 SO. U.S. HWY 441
LAKE CITY FL. 32025
OFFICE (386) 752-3496
MOBILE (386) 303-1981
CR-C1326715

KEN AND KINDA GARTIN
192 SW BLUE CT.
FORT WHITE FLORIDA

FLOORPLAN

PLAN No.	SCALE	DATE	SHEET NO.
P 0701	1/4" = 1'	01/27/07	3

... Projects\Gartlin\Floor1.dgn 2/18/2007 8:20:48 PM