


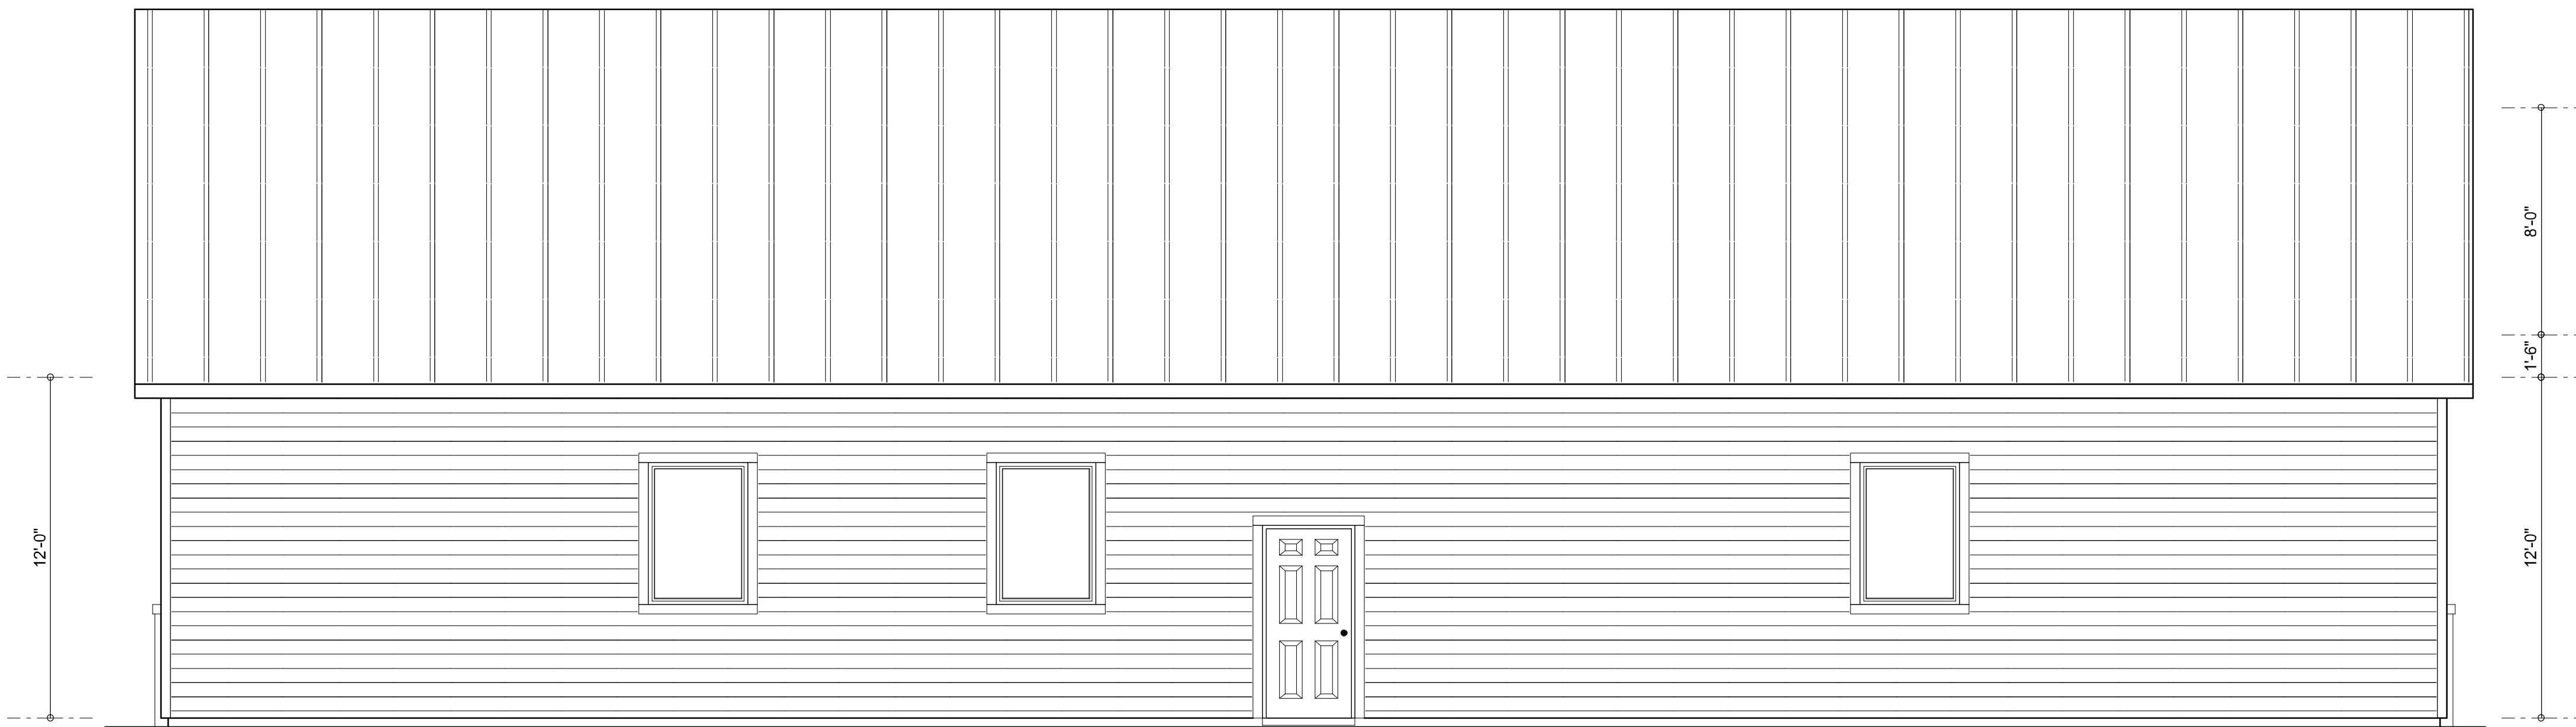

REAR ELEVATION
SCALE: 1/4" = 1'-0"



FRONT ELEVATION
SCALE: 1/4" = 1'-0"

NOTE: ALL DRAWINGS NOT TO BE SCALED, WRITTEN DIMENSIONS TAKE PRECEDENCE OVER SCALED DIMENSIONS

REVISIONS	
December 07, 2020	

SOFTPLAN
ARCHITECTURAL DESIGN SOFTWARE

Wm C Myers

NEW OFFICES FOR:
CAPITAL METAL SUPPLY
PROJECT ADDRESS: (COLUMBIA COUNTY)

AR0007005

NICHOLAS PAUL GEISLER ARCHITECT
N.C.A.R.B. Certified
1758 NW Brown Rd.
Lake City, FL 32055
(386) 365-4355


JOINT VENTURED WITH

© WM DESIGN & ASSOCIATES, INC.
428 SW COMMERCE DR., STE 130
LAKE CITY, FL 32025
(386) 758-8406
wm@willmayers.net



JOB NUMBER
20200901
DATE:
December 07, 2020

SHEET NUMBER
A.1

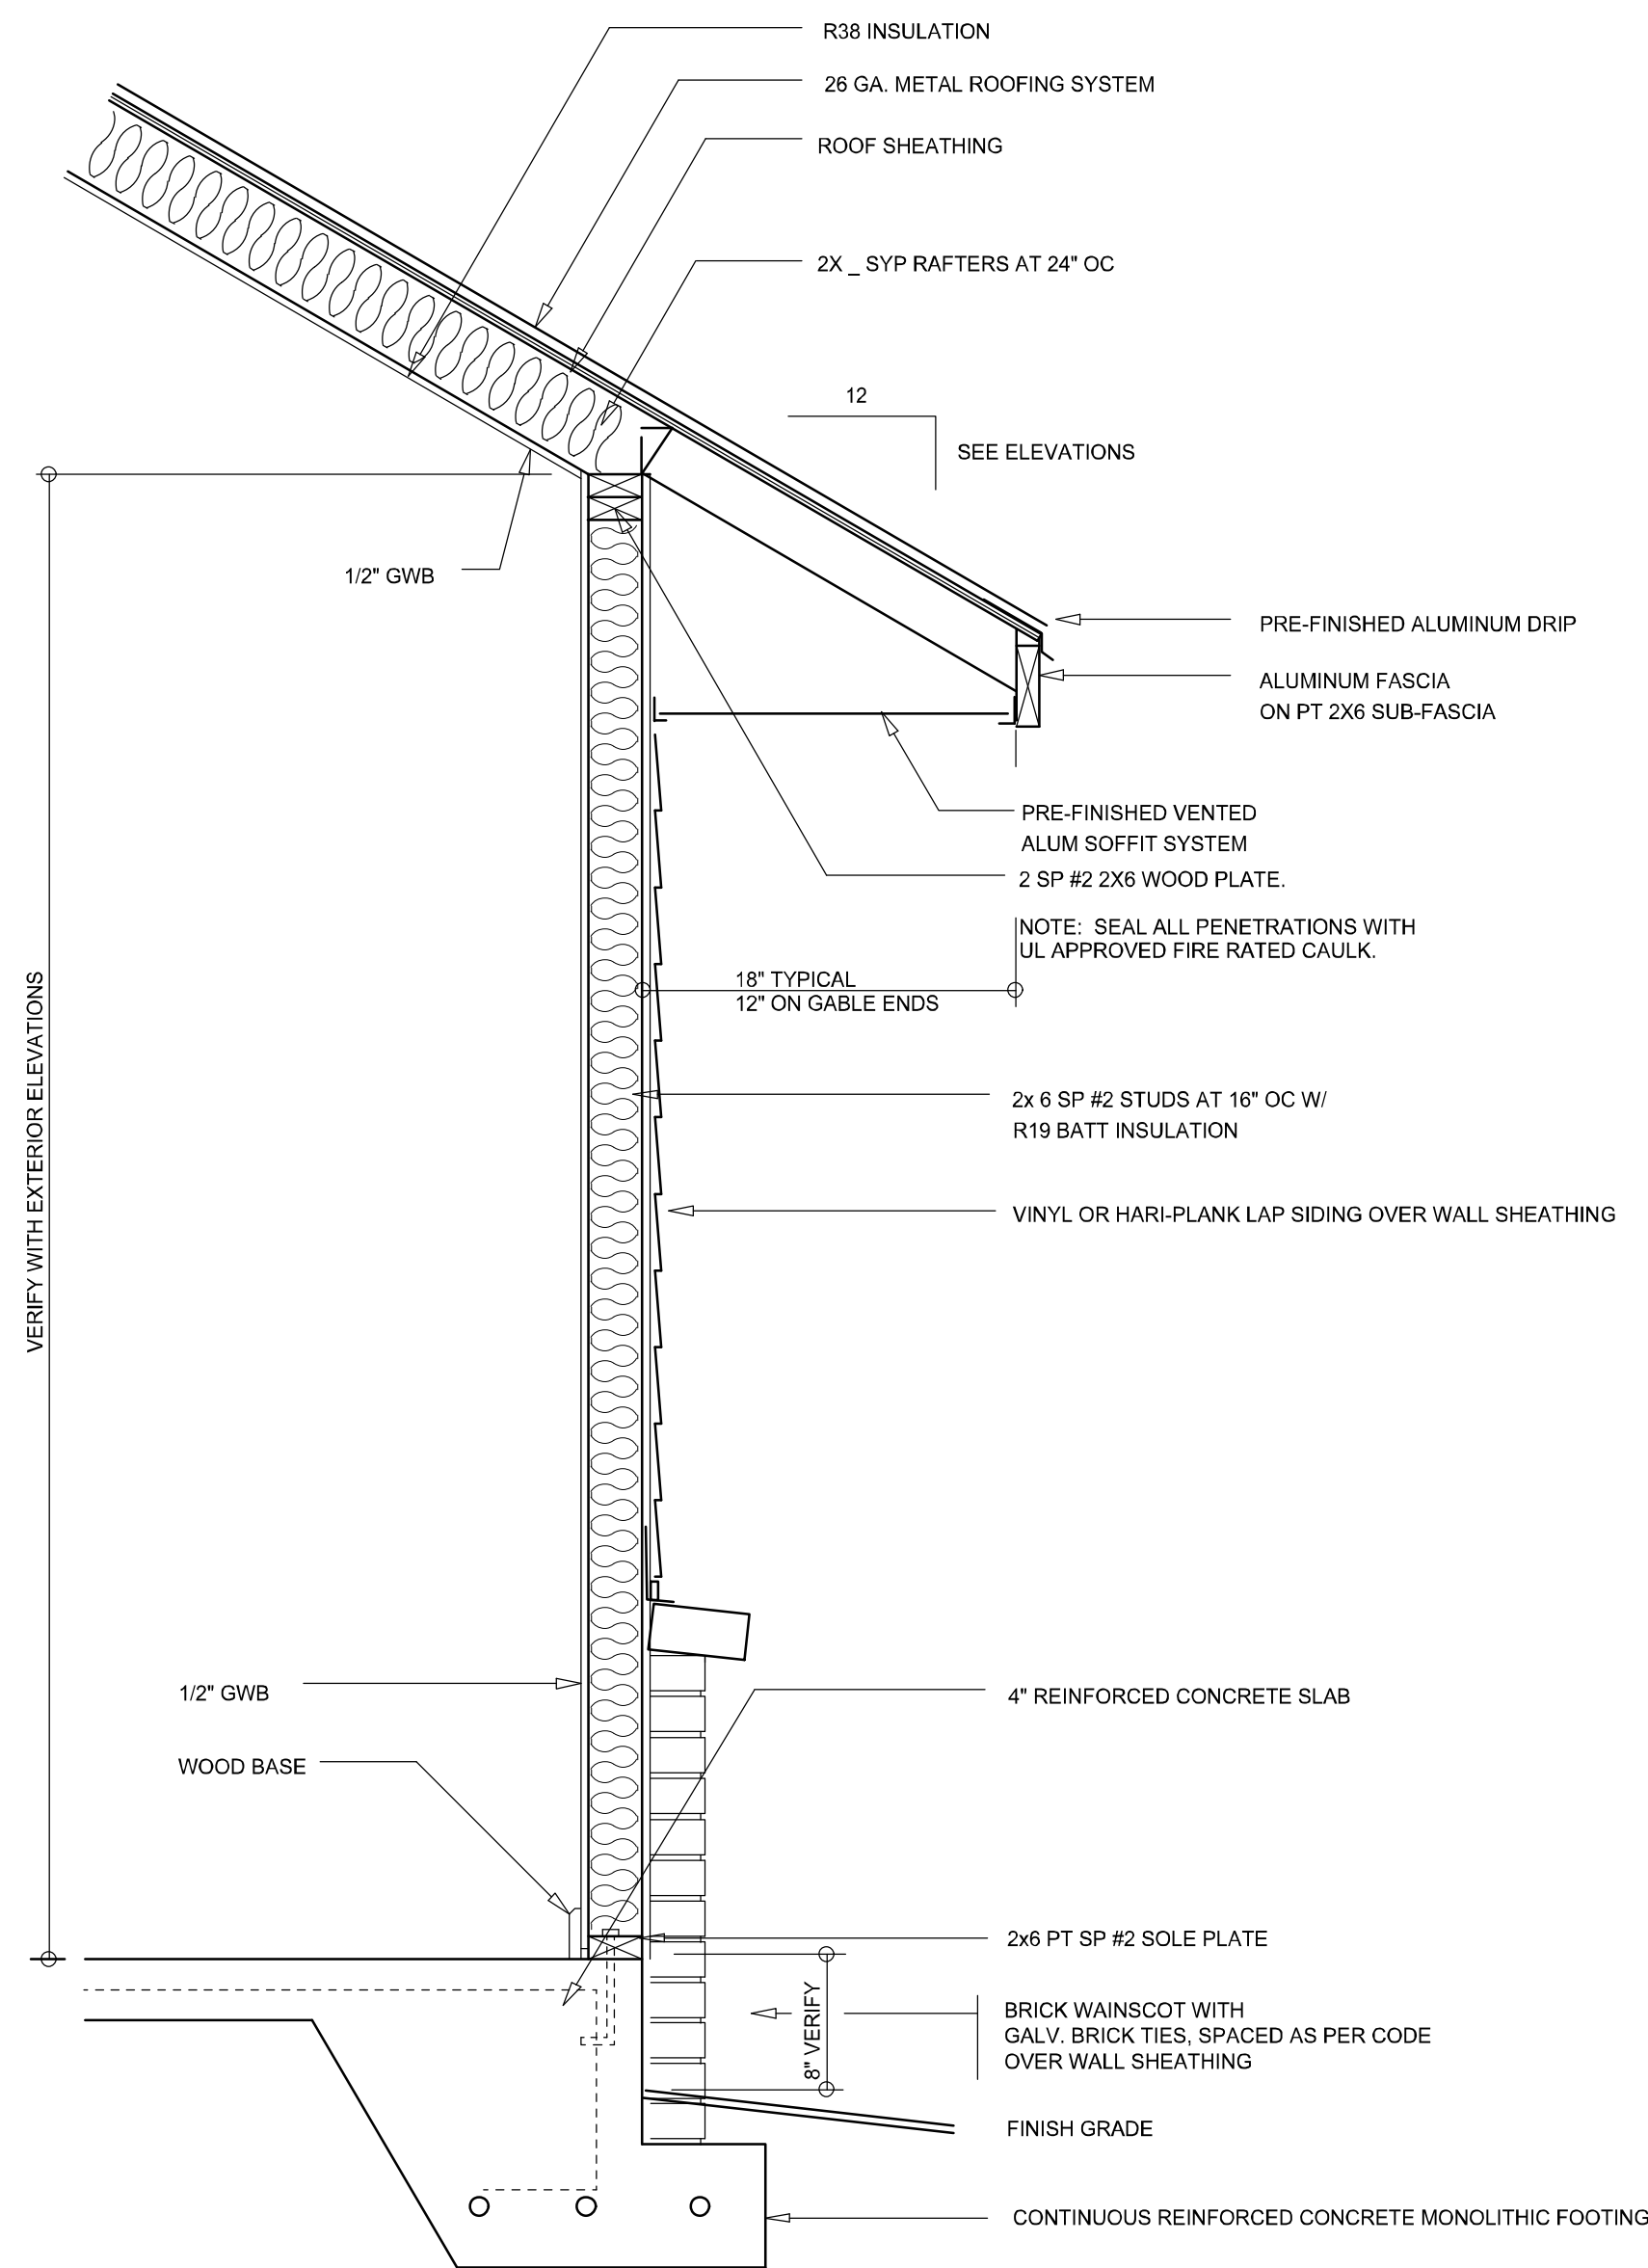

TYPICAL WALL SECTION

SCALE: 1" = 1'-0"



RIGHT ELEVATION

SCALE: 1/4" = 1'-0"



LEFT ELEVATION



SCALE: 1/4" = 1'-0"

NOTE: ALL DRAWINGS NOT TO BE SCALED, WRITTEN DIMENSIONS TAKE PRECEDENCE OVER SCALED DIMENSIONS

REVISIONS
December 07, 2020



NEW OFFICES FOR:
CAPITAL METAL SUPPLY
PROJECT ADDRESS: (COLUMBIA COUNTY)

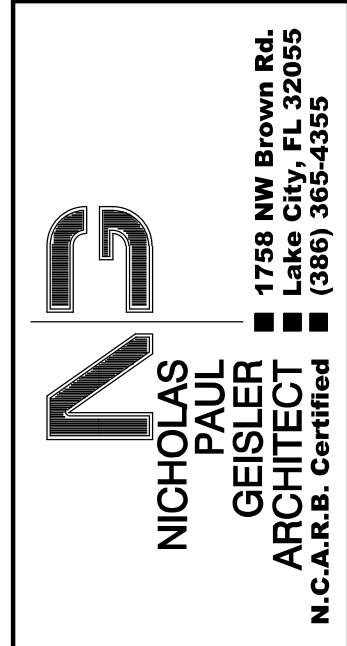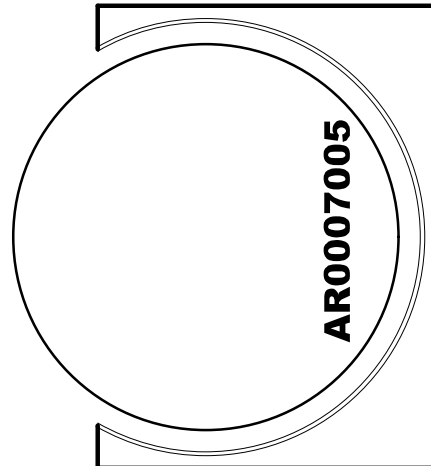

JOINT VENTURED WITH

© VM DESIGN & ASSOCIATES, INC.
426 SW COMMERCE DR., STE 130
LAKE CITY, FL 32025
(386) 758-8406
will@willmyers.net



JOB NUMBER
20200901
DATE:
December 07, 2020

SHEET NUMBER
A.2

REVISIONS
December 08, 2020



Will C. Fry

NEW OFFICES FOR:
CAPITAL METAL SUPPLY
PROJECT ADDRESS: (COLUMBIA COUNTY)

AR0007005



**GEISLER
ARCHITECT
N.C.A.R.B. Certified**

- 1758 NW Brown Rd.
- Lake City, FL 32055
- (386) 365-4355

JOINT VENTURED WITH




© WM DESIGN &
ASSOCIATES, INC.
26 SW COMMERCE DR., STE 130
LAKE CITY, FL 32025
(386) 758-8406
will@willmyers.net




JOB NUMBER
20200901
DATE:
December 08, 2020

SHEET NUMBER


A.3

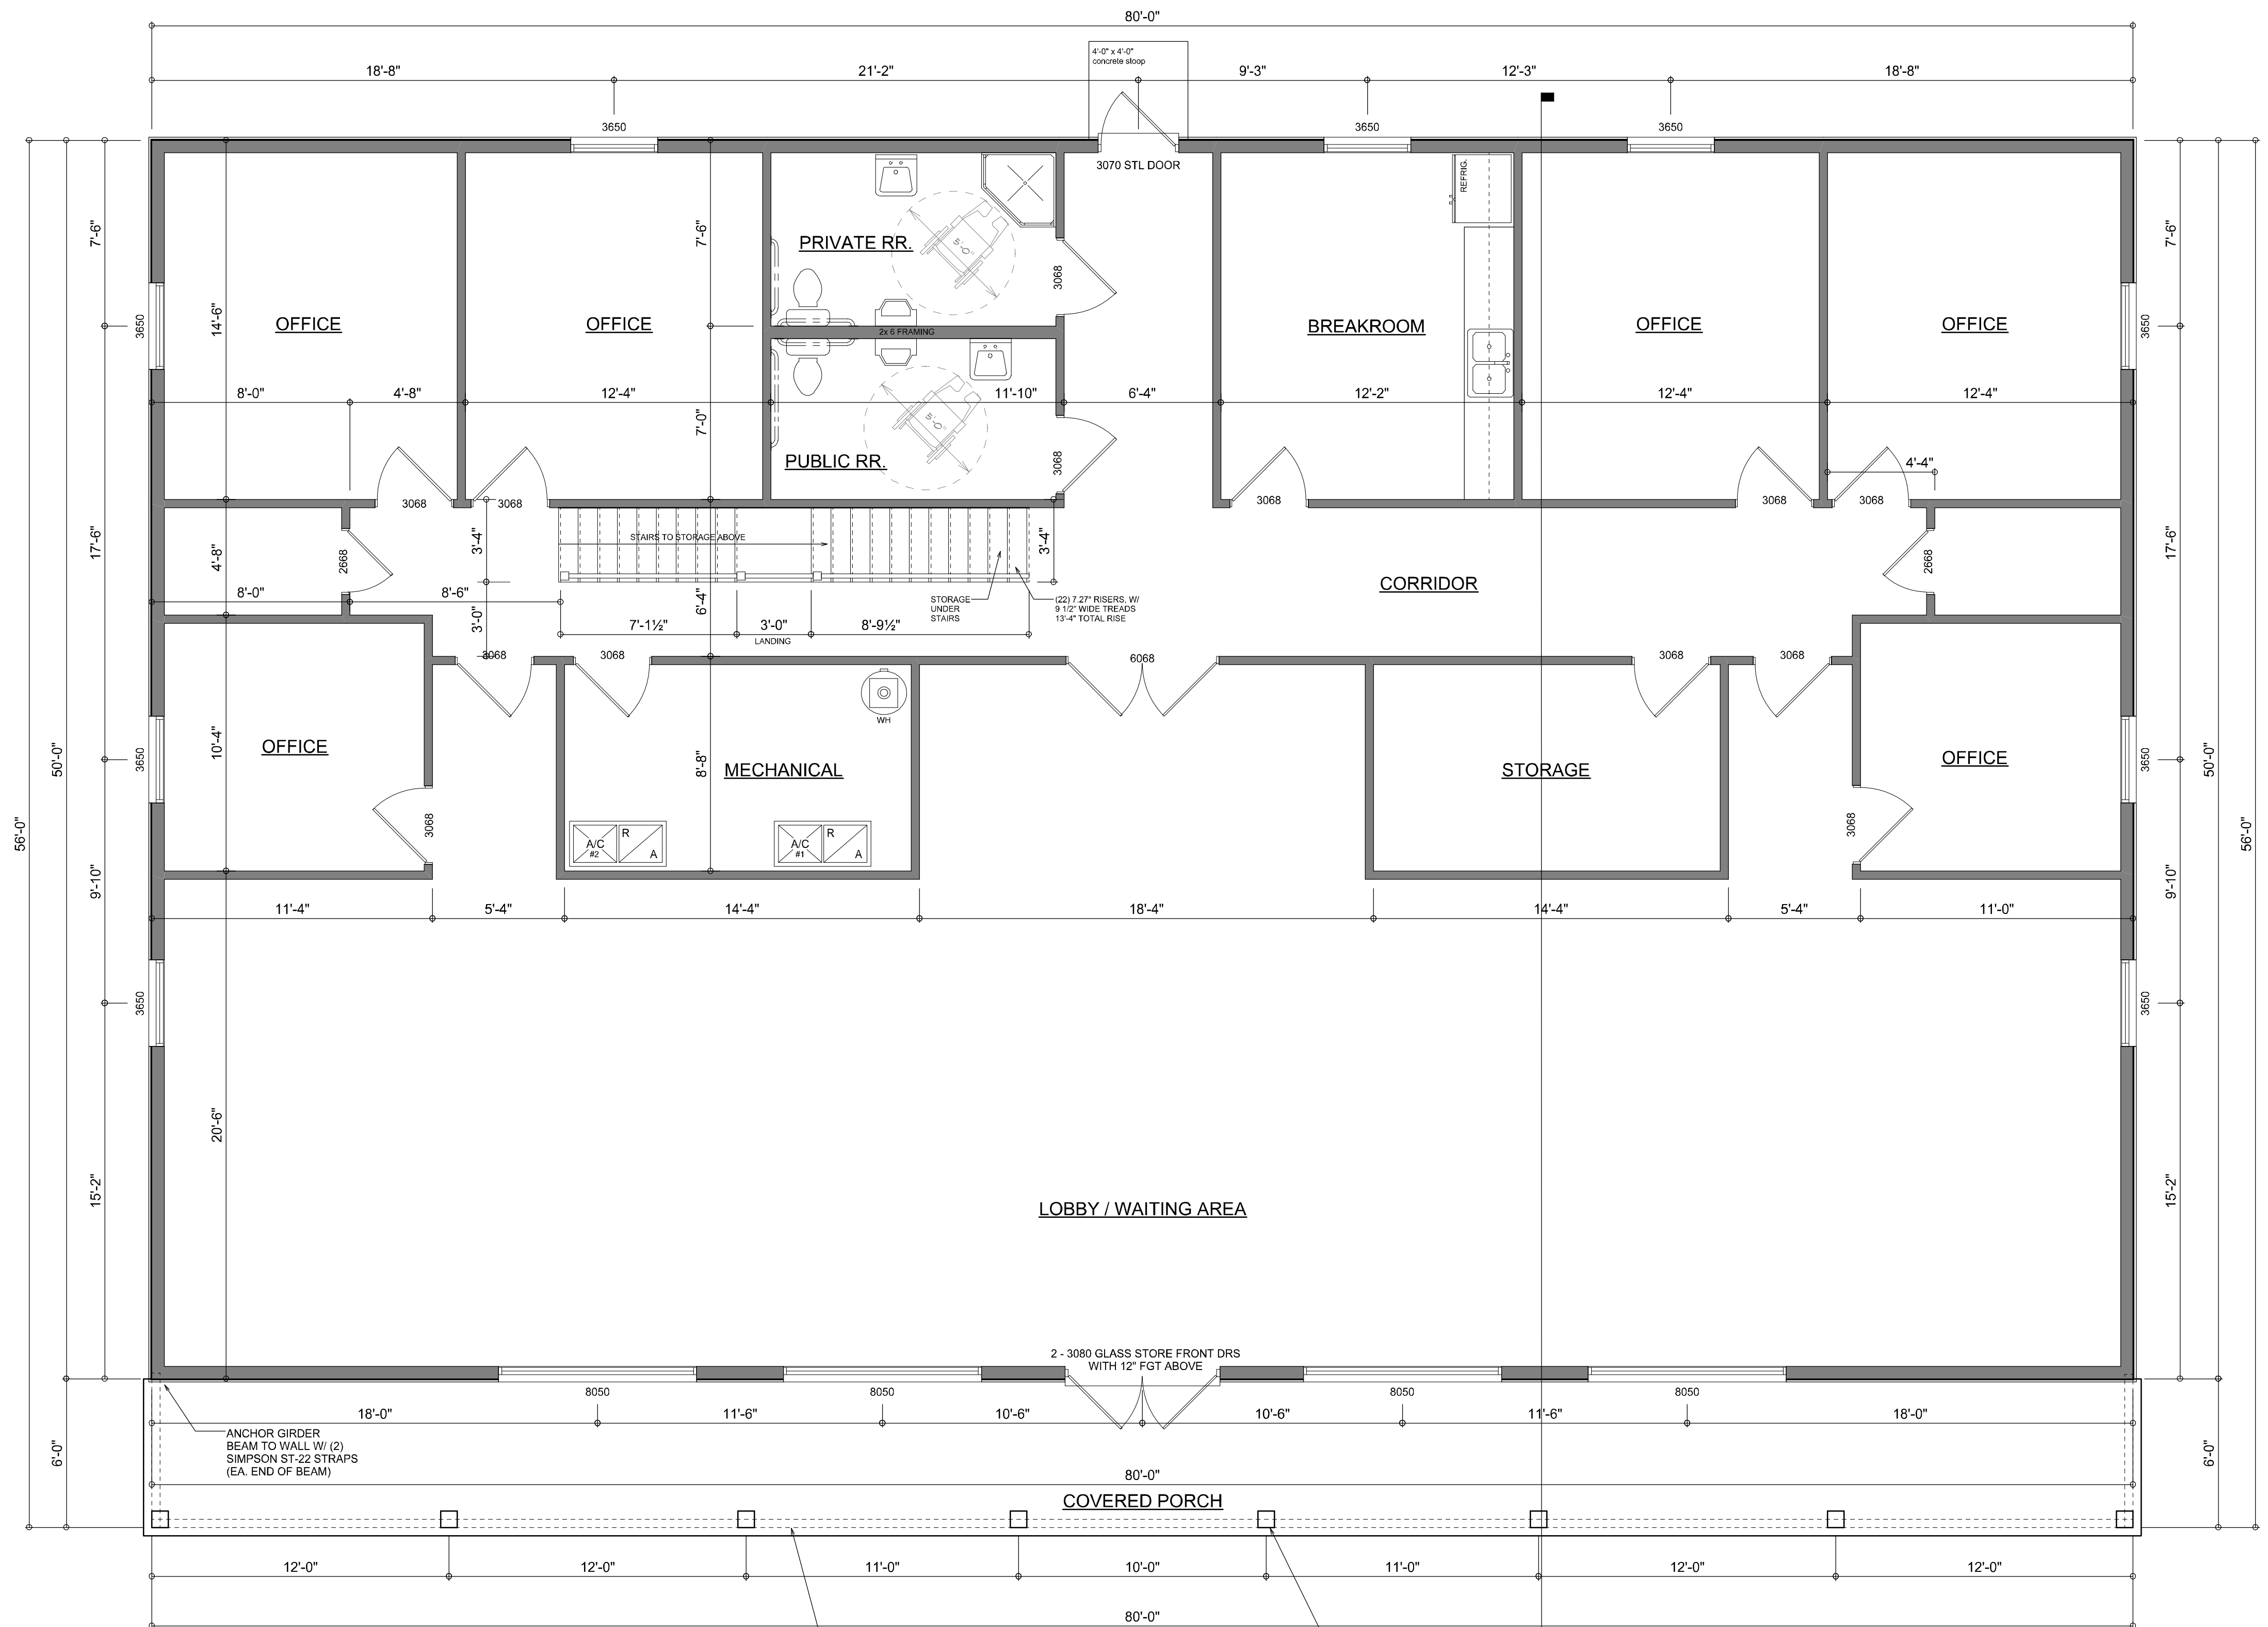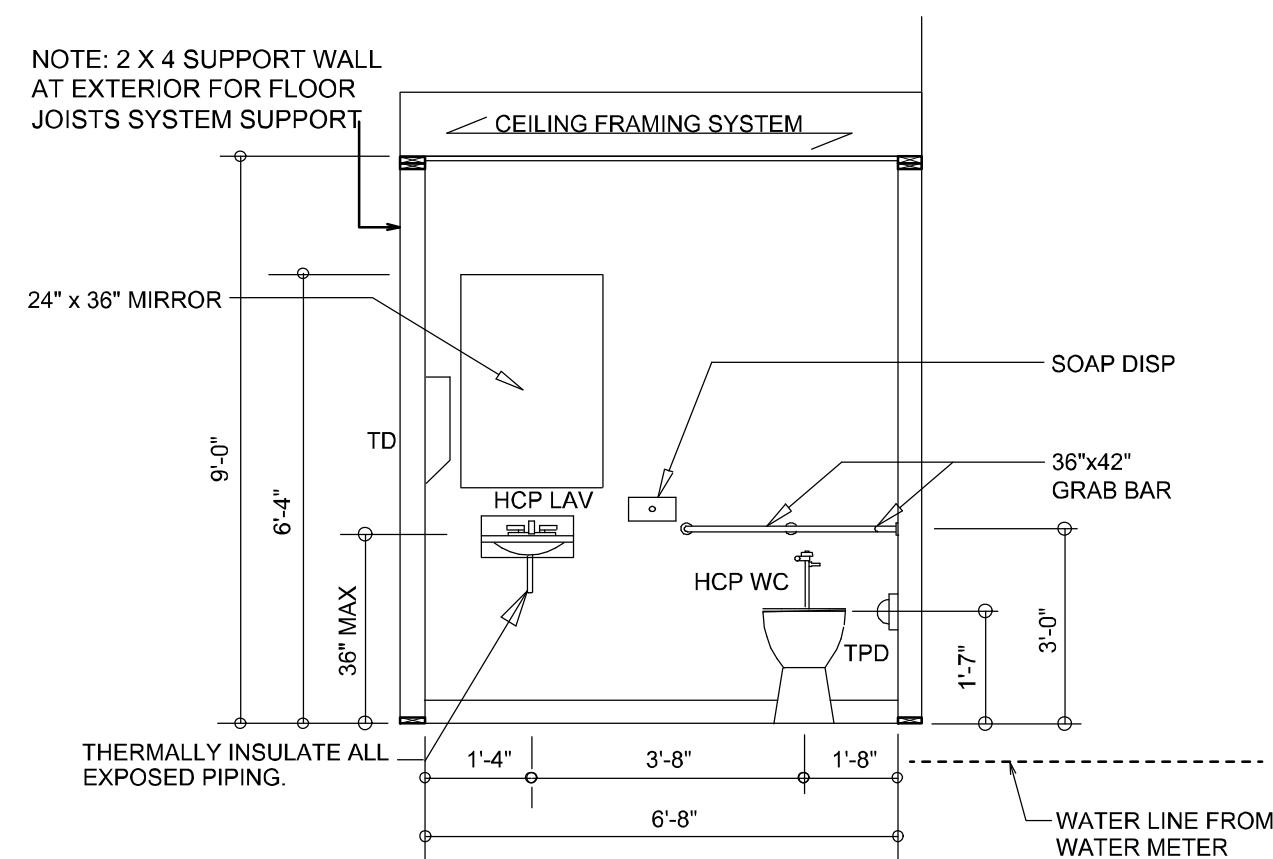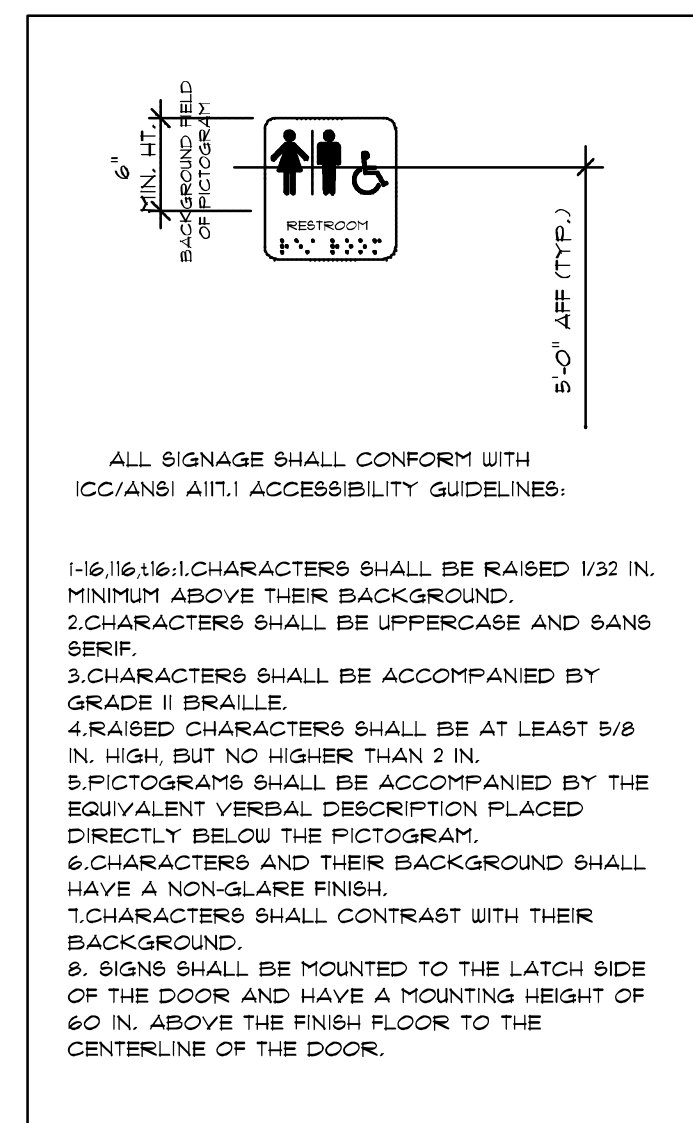

NOTE: ALL DRAWINGS NOT TO BE SCALED, WRITTEN DIMENSIONS TAKE PRECEDENCE OVER SCALED DIMENSIONS

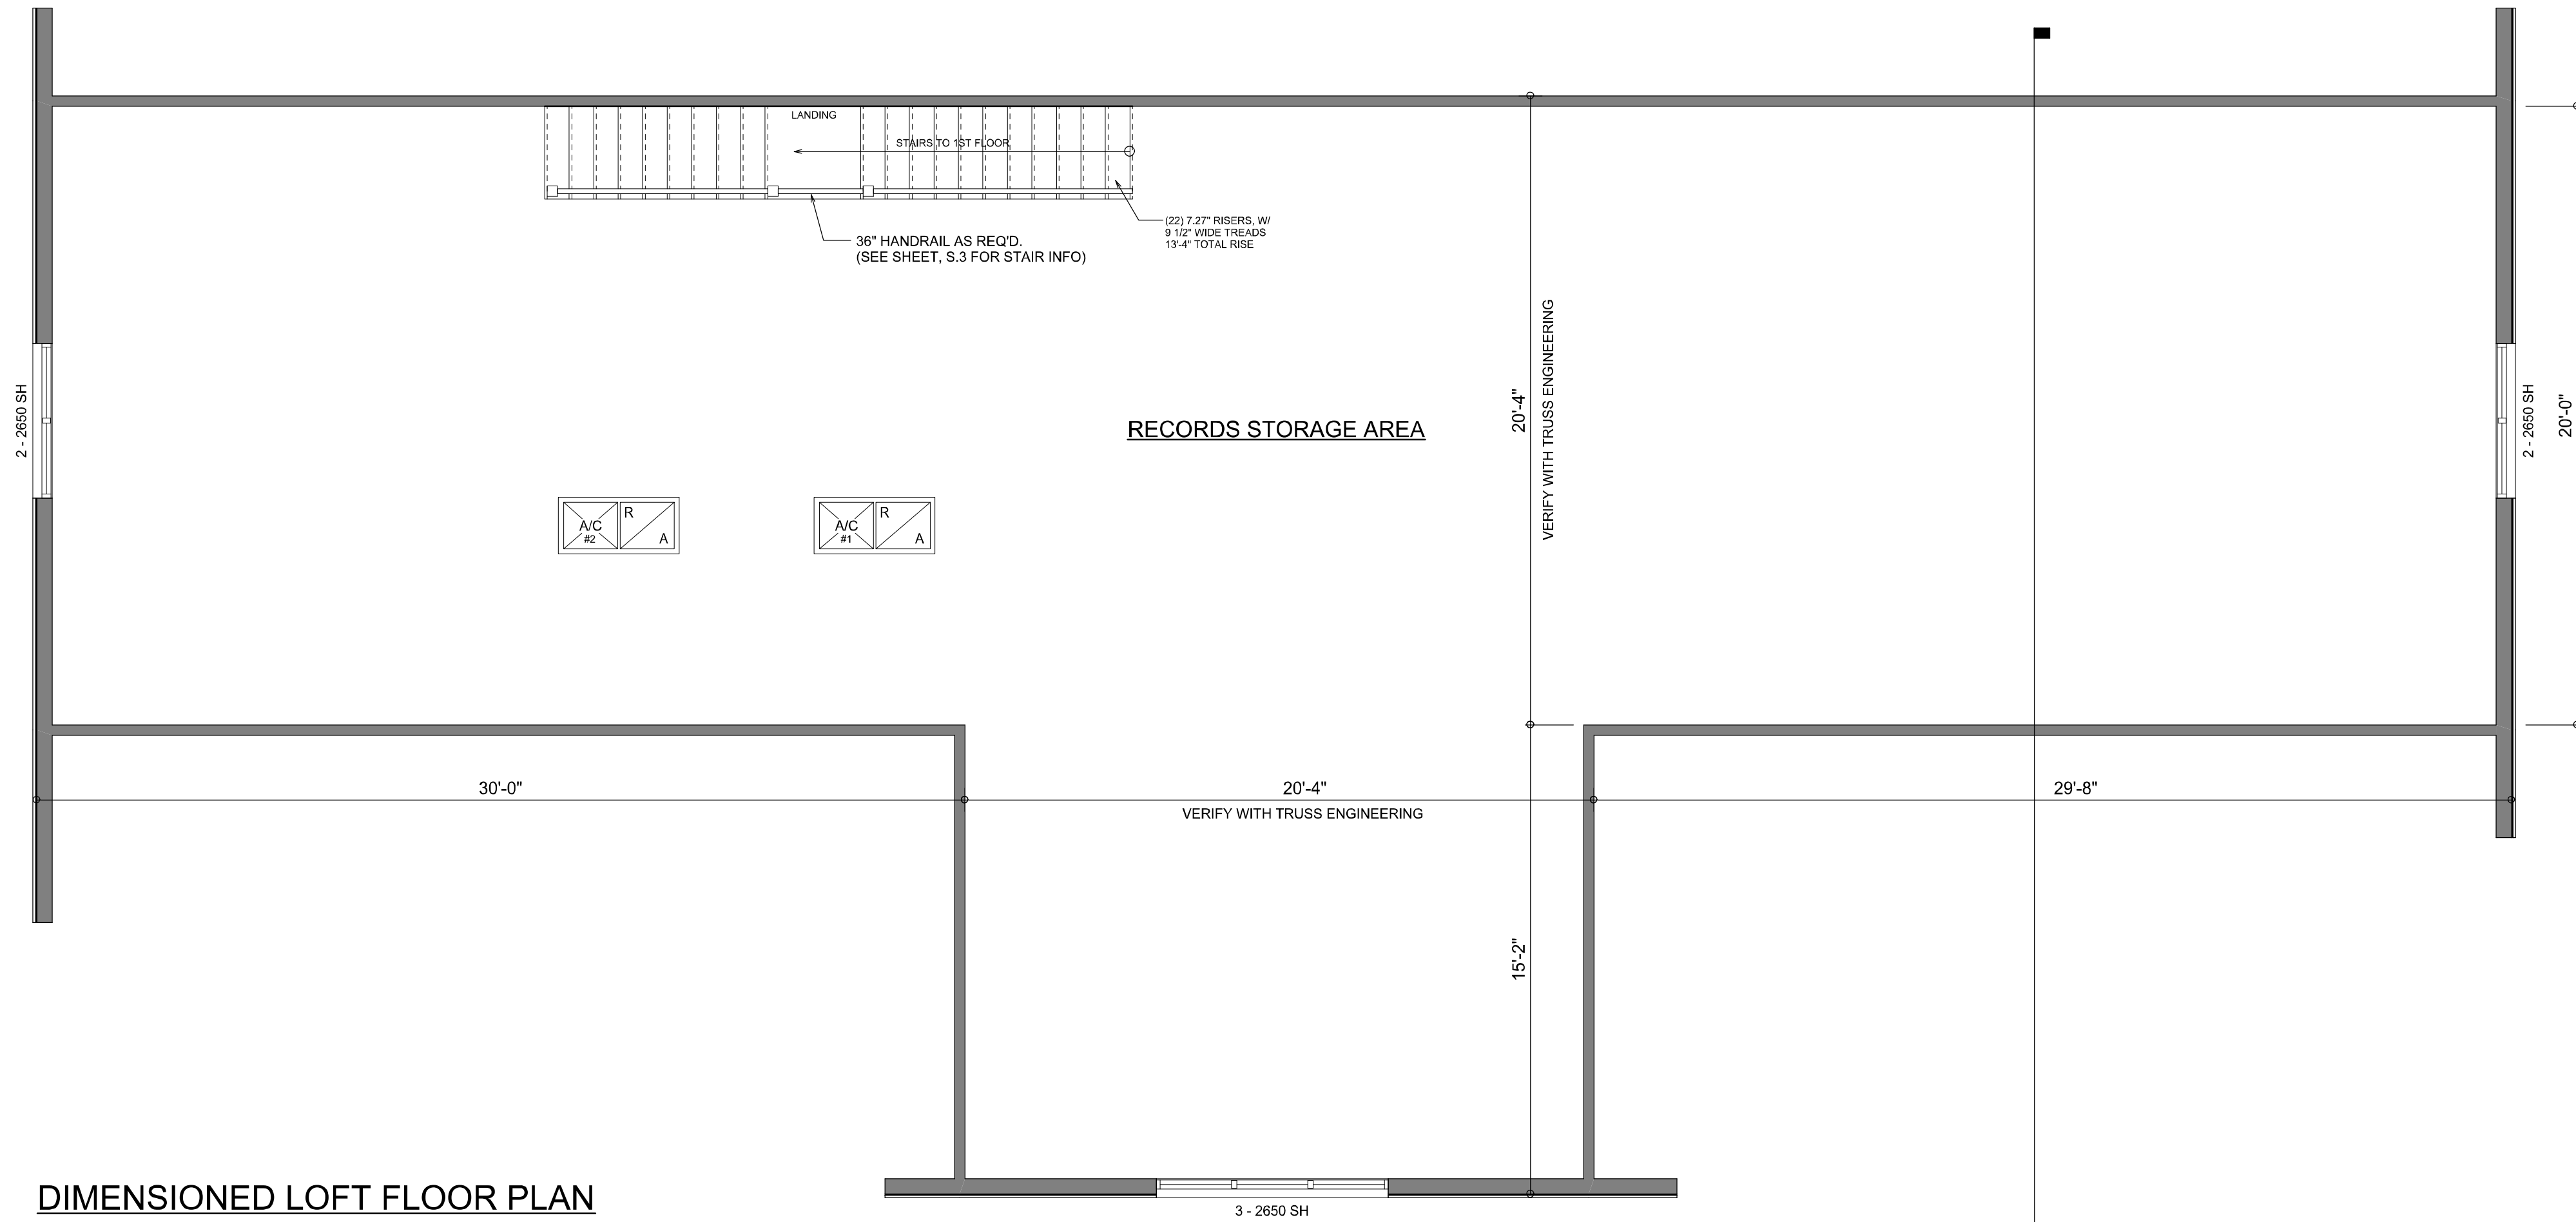

DIMENSIONED LOFT FLOOR PLAN
SCALE: 1/4" = 1'-0"

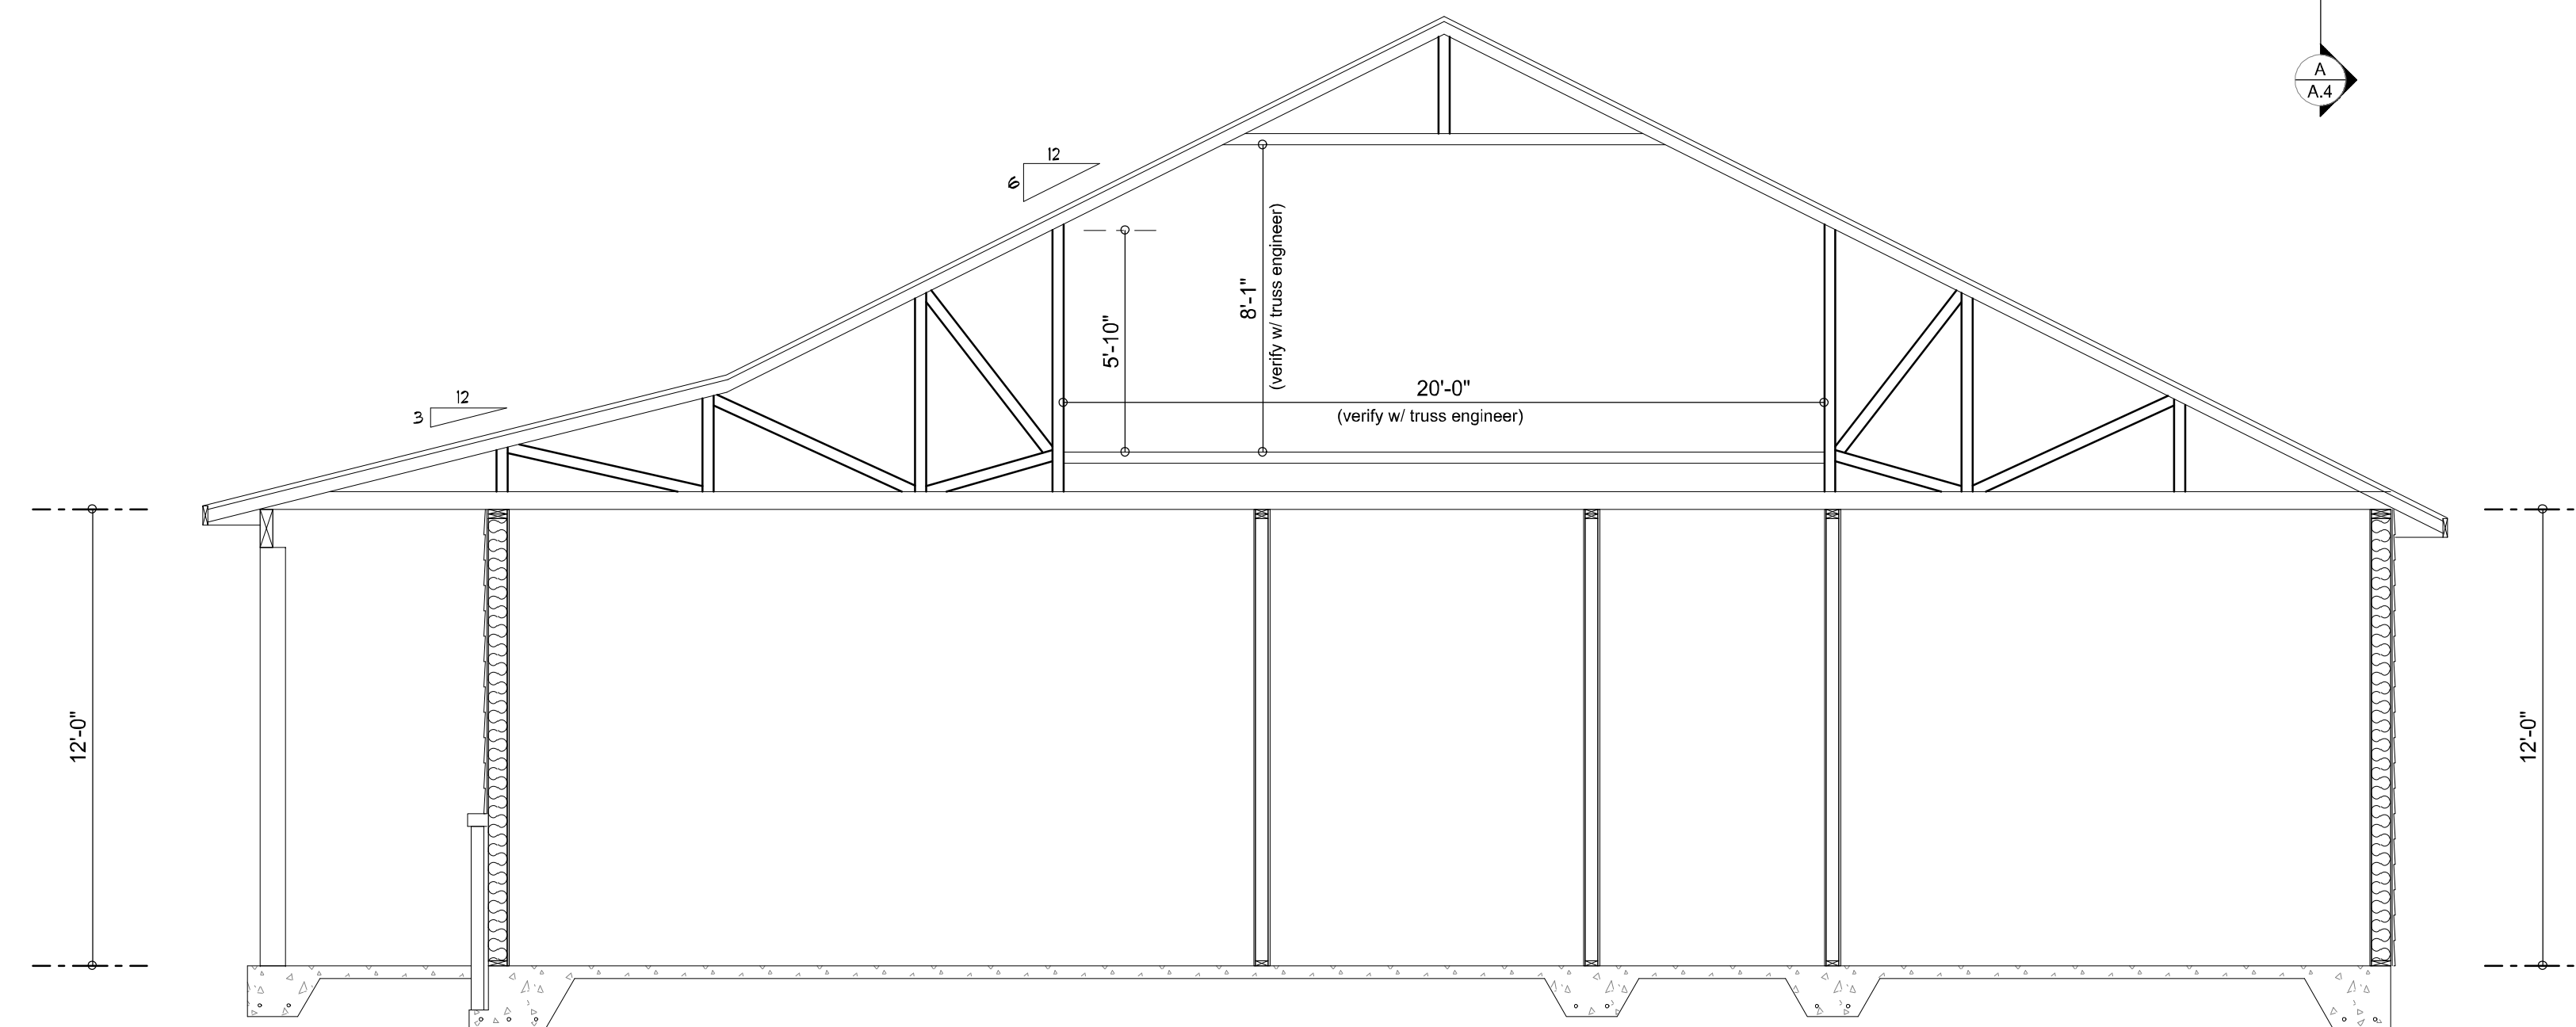

BUILDING SECTION 'A'
SCALE: 1/4" = 1'-0"

NOTE: ALL DRAWINGS NOT TO BE SCALED, WRITTEN DIMENSIONS TAKE PRECEDENCE OVER SCALED DIMENSIONS

REVISIONS	
December 08, 2020	

SOFTPLAN
ARCHITECTURAL DESIGN SOFTWARE

Wm C. Paul

NEW OFFICES FOR:
CAPITAL METAL SUPPLY

PROJECT ADDRESS: (COLUMBIA COUNTY)

AR0007005

NC

**NICHOLAS PAUL
GEISLER
ARCHITECT**
N.C.A.R.B. Certified

1758 NW Brown Rd.
Lake City, FL 32055
(386) 365-4355

JOINT VENTURED WITH

© **VM DESIGN &
ASSOCIATES, INC.**
426 SW COMMERCE DR., STE 130
LAKE CITY, FL 32025
(386) 758-8406
will@willmayers.net



JOB NUMBER
20200901

DATE:
December 08, 2020

SHEET NUMBER

A.4