
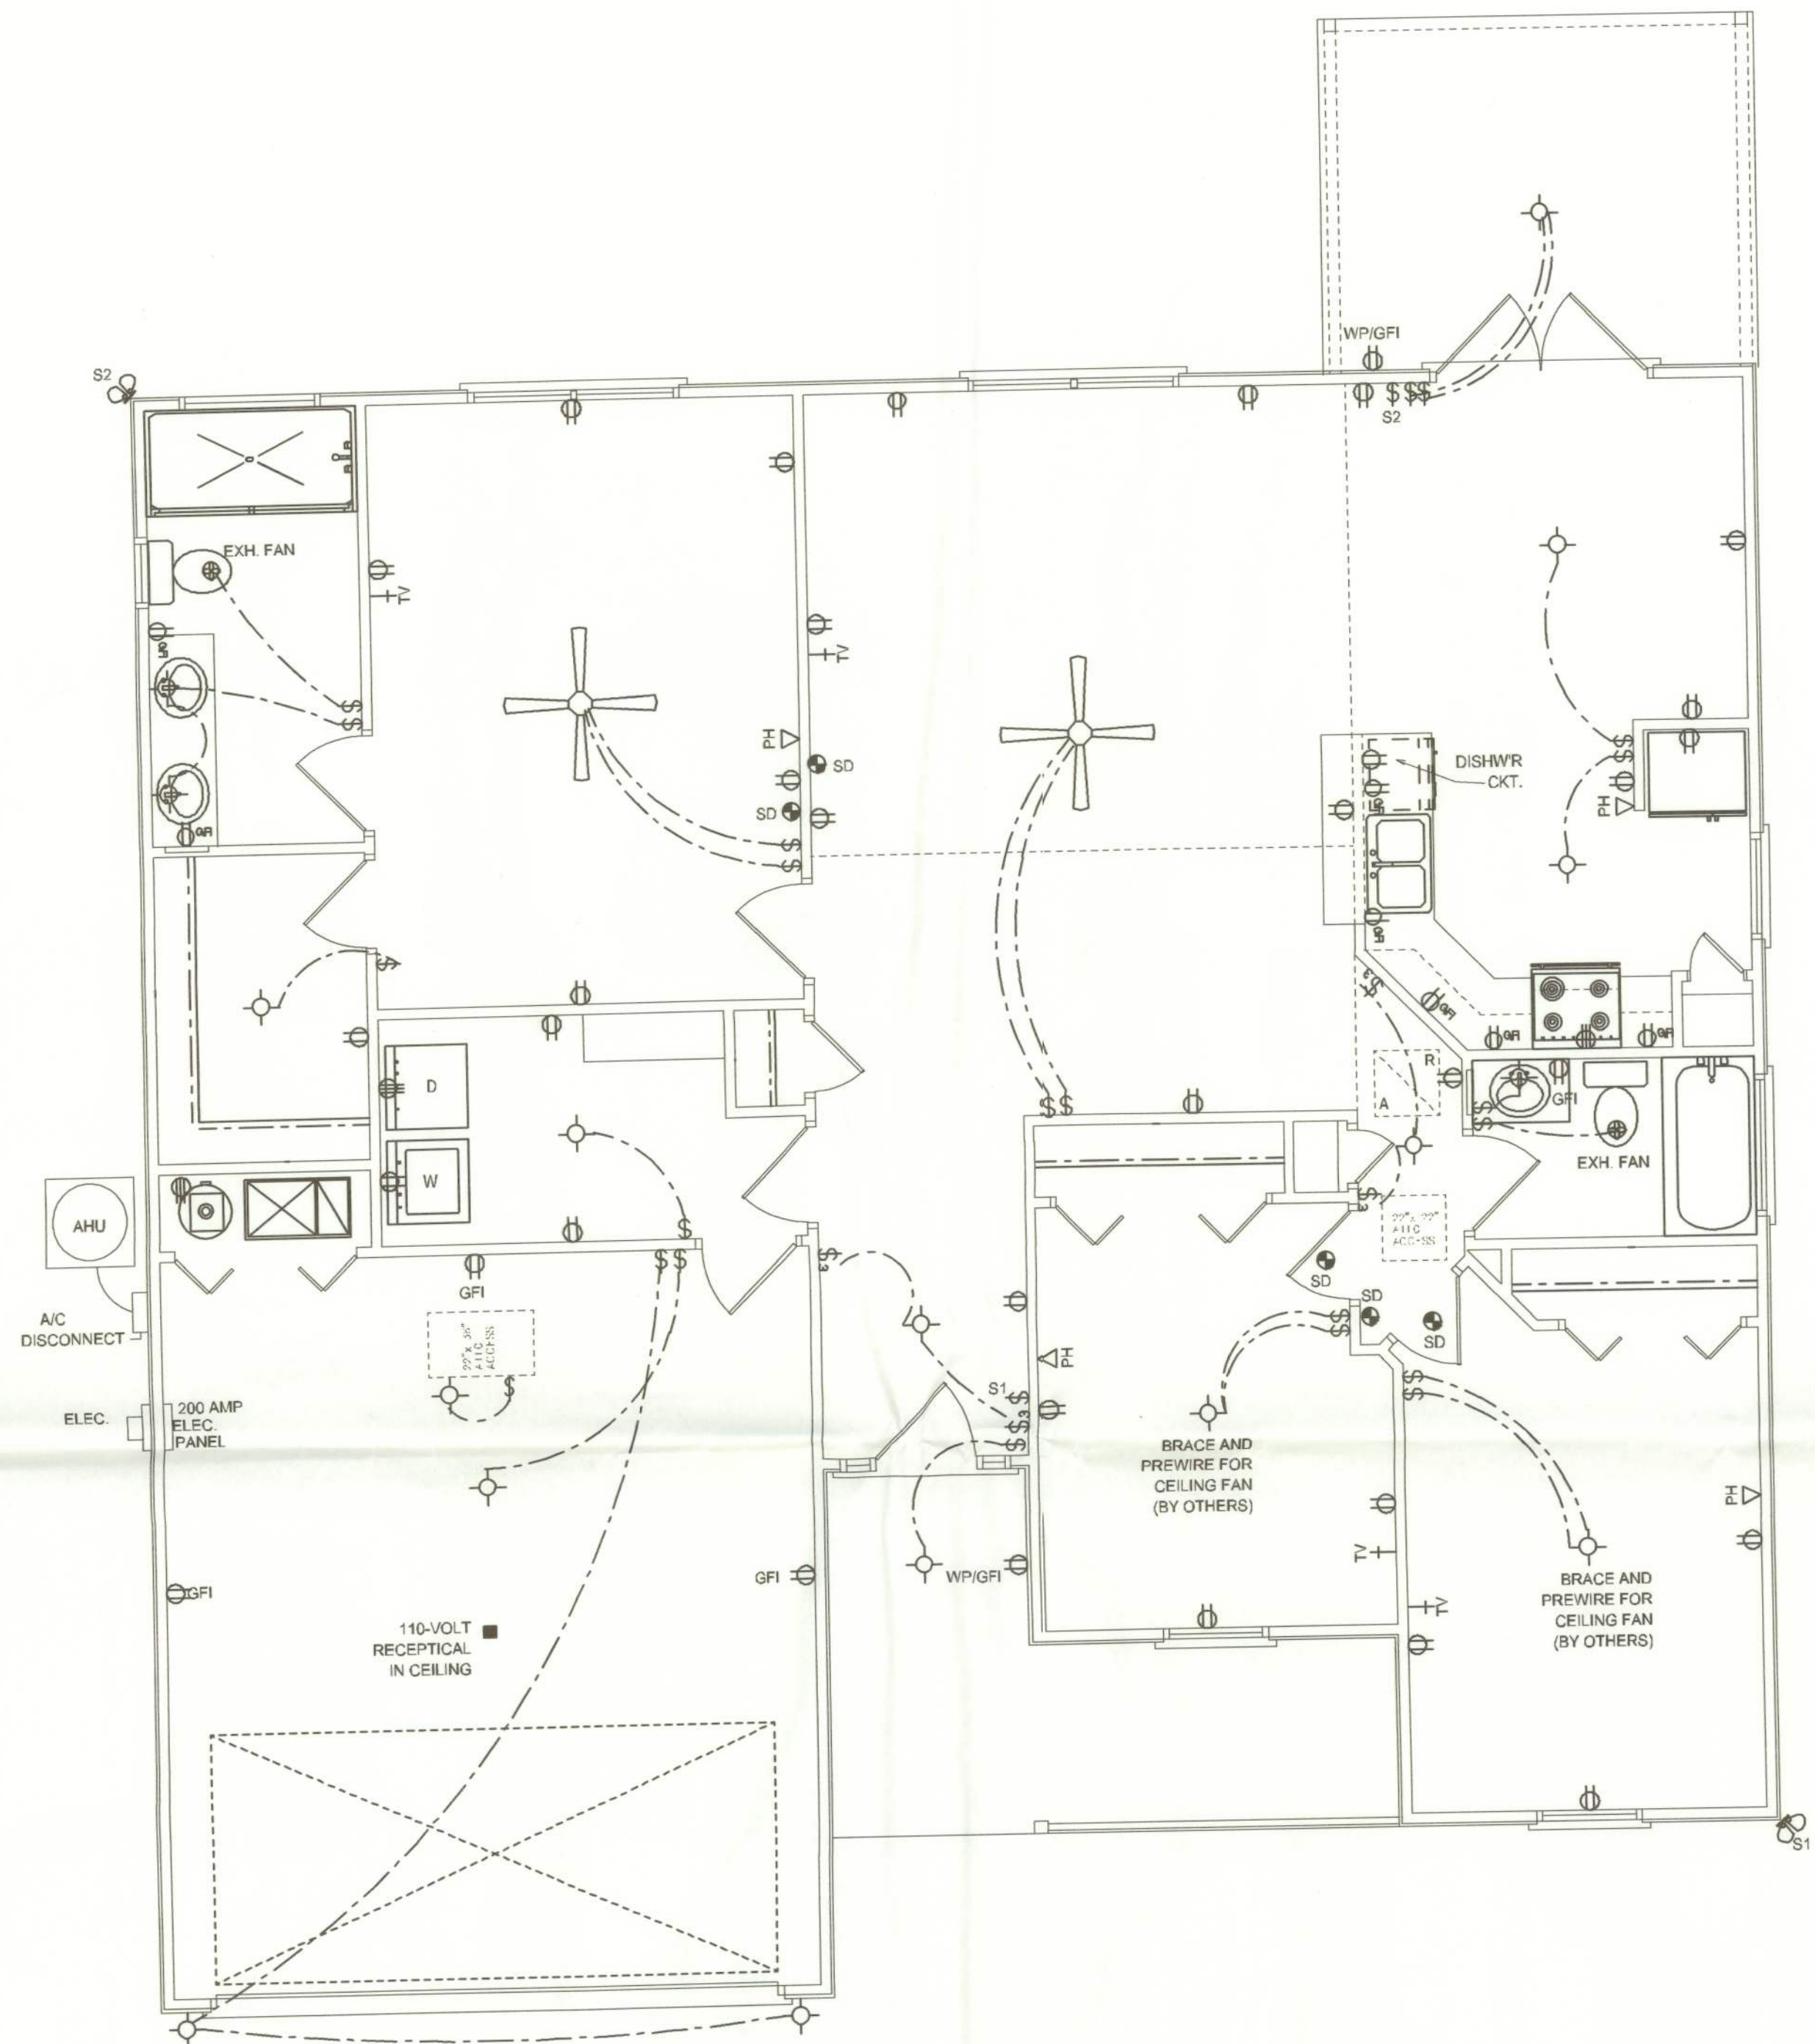


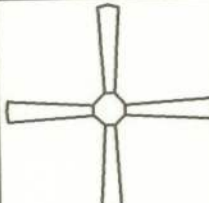


ELECTRICAL LEGEND	
	CEILING FAN (PRE-WIRE FOR LIGHT KIT)
	DOUBLE SECURITY LIGHT
	RECESSED CAN LIGHT
	BATH EXHAUST FAN
	LIGHT FIXTURE
	DUPLEX OUTLET
	220v OUTLET
	GFI DUPLEX OUTLET
	SMOKE DETECTOR (see note below)
	WALL SWITCH
	3 WAY WALL SWITCH
	WATER PROOF GFI OUTLET
	2 OR 4 TUB FLUORESCENT LIGHT

NOTE:
ALL BEDROOM RECEPTACLES SHALL BE AFCI
(ARC FAULT CIRCUIT INTERRUPT)

ALL SMOKE DETECTORS SHALL HAVE BATTERY BACKUP POWER
AND ALL WIRED TOGETHER SO IF ANY ONE UNIT IS ACTUATED THEY
ALL ACTIVATE.

ELECTRICAL NOTES

- E - 1 ALL WORK SHALL COMPLY WITH THE NATIONAL ELECTRIC CODE, LATEST EDITION, AND ALL OTHER APPLICABLE LOCAL CODES AND ORDINANCES
- E - 2 PREWIRE LOW VOLTAGE CONTROL WIRING FOR ELECTRIC GARAGE DOOR OPENERS
- E - 3 PROVIDE WIRING AS REQUIRED FOR AIR CONDITIONING, HEATING AND WATER HEATING EQUIPMENT

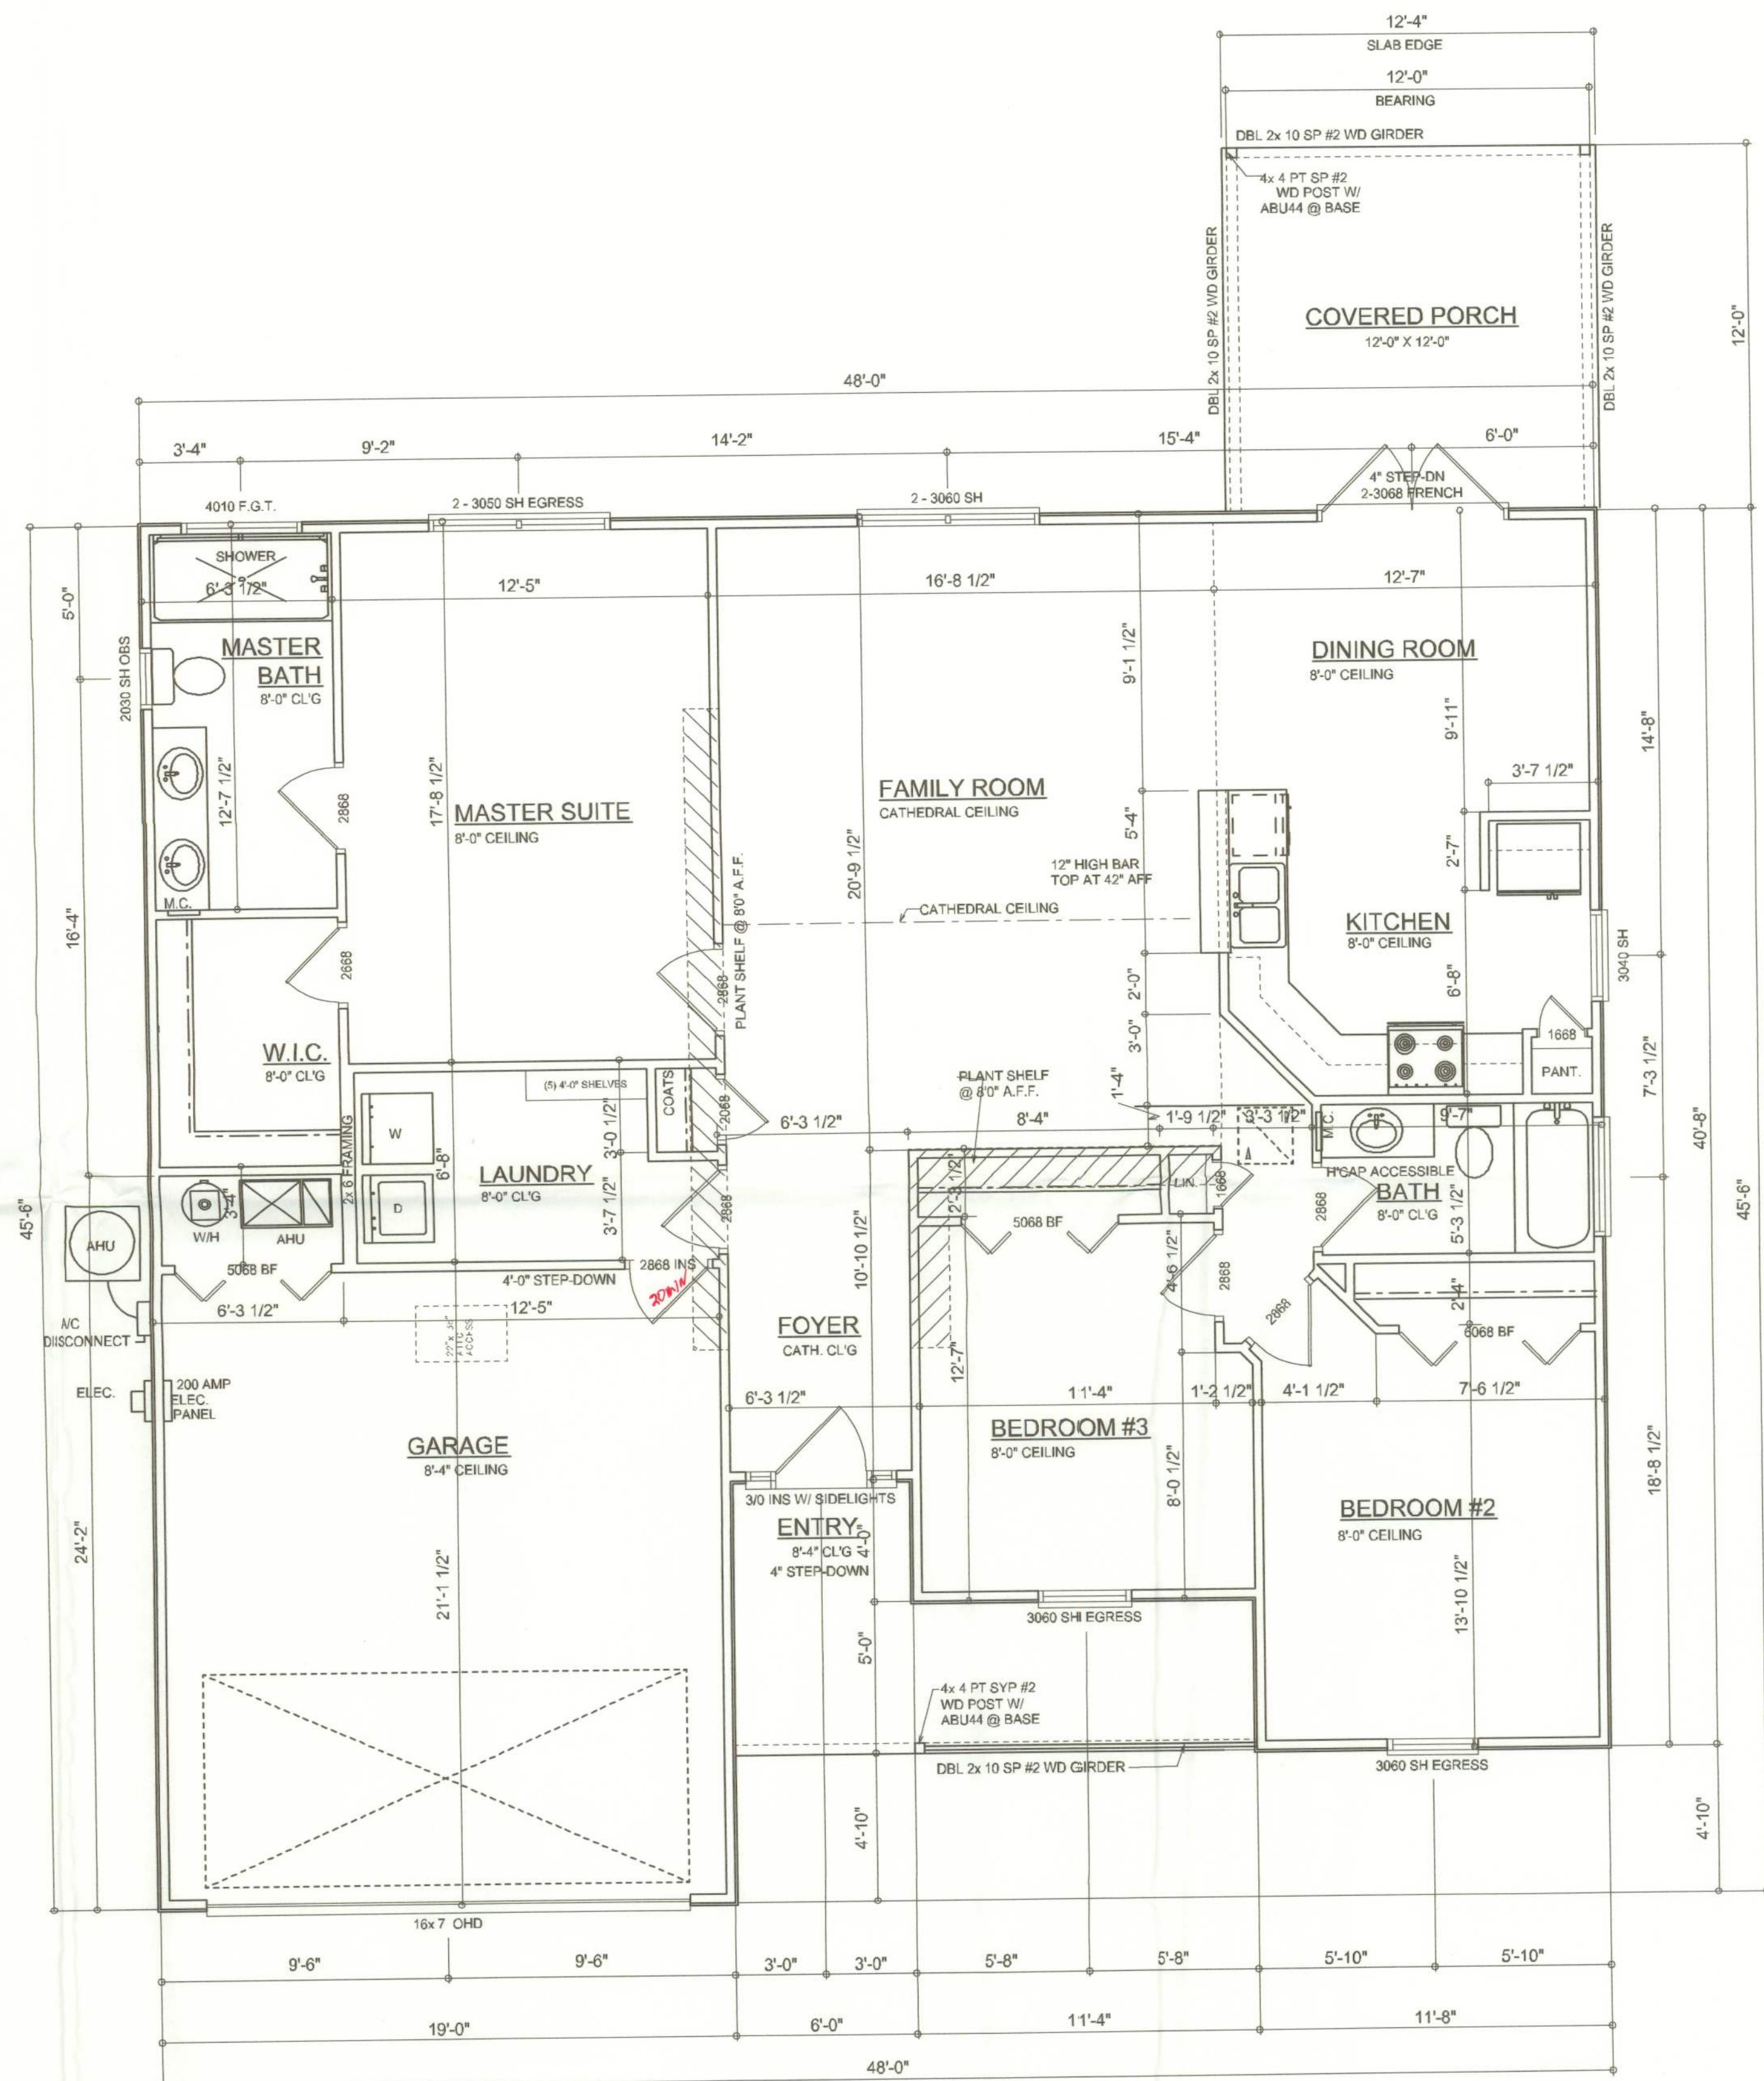

FLOOR PLAN
SCALE: 1/4" = 1'-0"

AREA SUMMARY

LIVING AREA	1514	S. F.
GARAGE AREA	415	S. F.
ENTRY PORCH AREA	116	S. F.
COVERED PORCH AREA	144	S. F.
TOTAL AREA	2189	S. F.

REVISIONS
September 07, 2005


SOFTPLAN
ARCHITECTURAL SOFTWARE

FLOOR PLAN
SCALE: 1/4" = 1'-0"

ELECTRICAL PLAN
SCALE: 1/4" = 1'-0"

A CUSTOM SPEC FOR:
AARON SIMQUE HOMES, INC.
PROJECT ADDRESS: LEGAL: 03-48-17-0787-000, SE CAROL GLEN, SUZANNE SD, LAKE CITY, FLORIDA 32025

©WILLIAM MYERS
DESIGN
P.O. BOX 1513
LAKE CITY, FL 32056
(386) 758-8406
will@willmyers.net

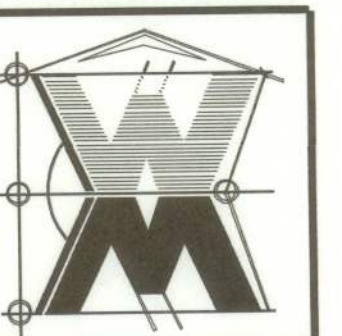

JOB NUMBER
050812

SHEET NUMBER
A.3
OF 3 SHEETS

Will Myers