


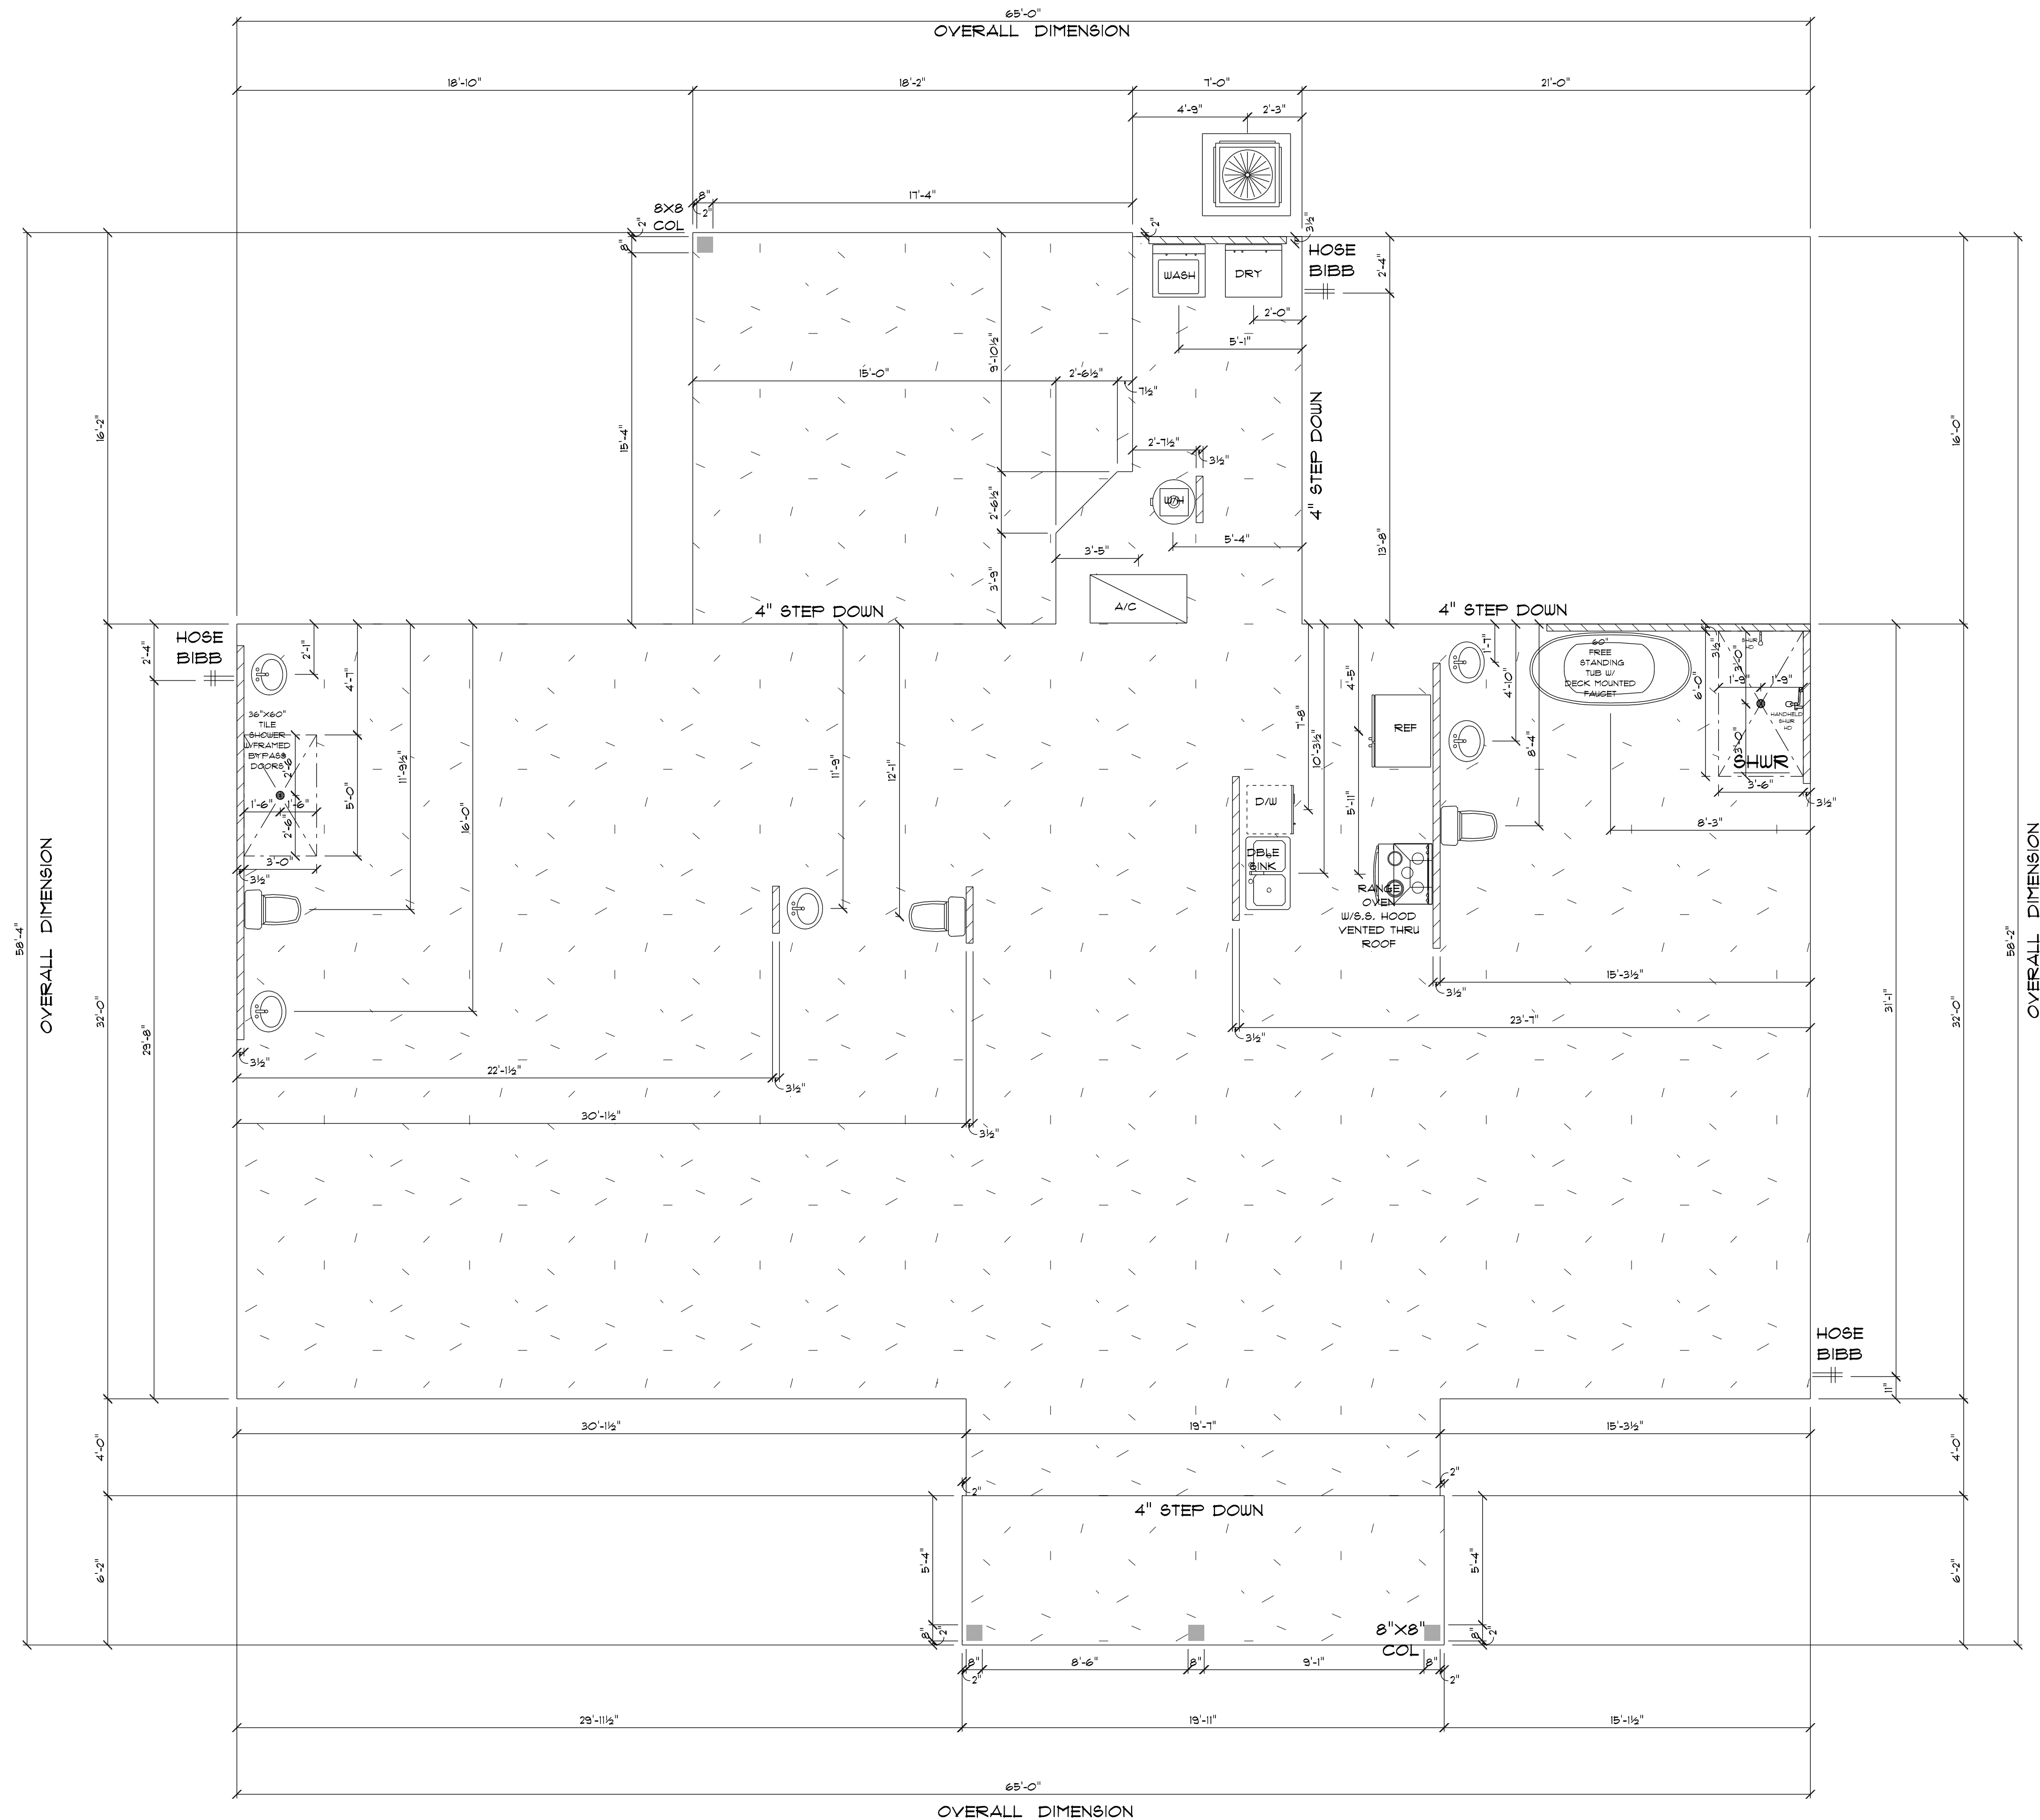

* PLUMBING & *

* CONCRETE PLAN *

SCALE : 1/4" = 1'-0"

IMPORTANT NOTE:

1. IT IS THE BUILDER'S RESPONSIBILITY TO VERIFY ALL GEOMETRY AND DIMENSIONS BEFORE ORDERING ANY MATERIALS OR BEGINNING CONSTRUCTION.
2. THESE PLANS ARE FOR LAYOUT AND DESIGN PURPOSES ONLY ALL STRUCTURAL NOTES AND DETAILS TO BE PROVIDED BY AN ENGINEER.

NEW RESIDENCE
FOR
TYRONE & THAYLA
MULLINE

Teena M. Ruffo
2925 SW 8R 41
Lake City Florida, 32025
Cell: (386) 861 - 1191
Email: teenaruffo@gmail.com

PRINTED DATE:
Monday, October 28, 2024

DRAWN BY: Teena and Kara

CHECKED BY:

BUILDING CONTRACTOR
ZECHER CONSTRUCTION


FINAL DATE:

JOB NUMBER:

DRAWING NUMBER

A-1

OF 5 SHEETS

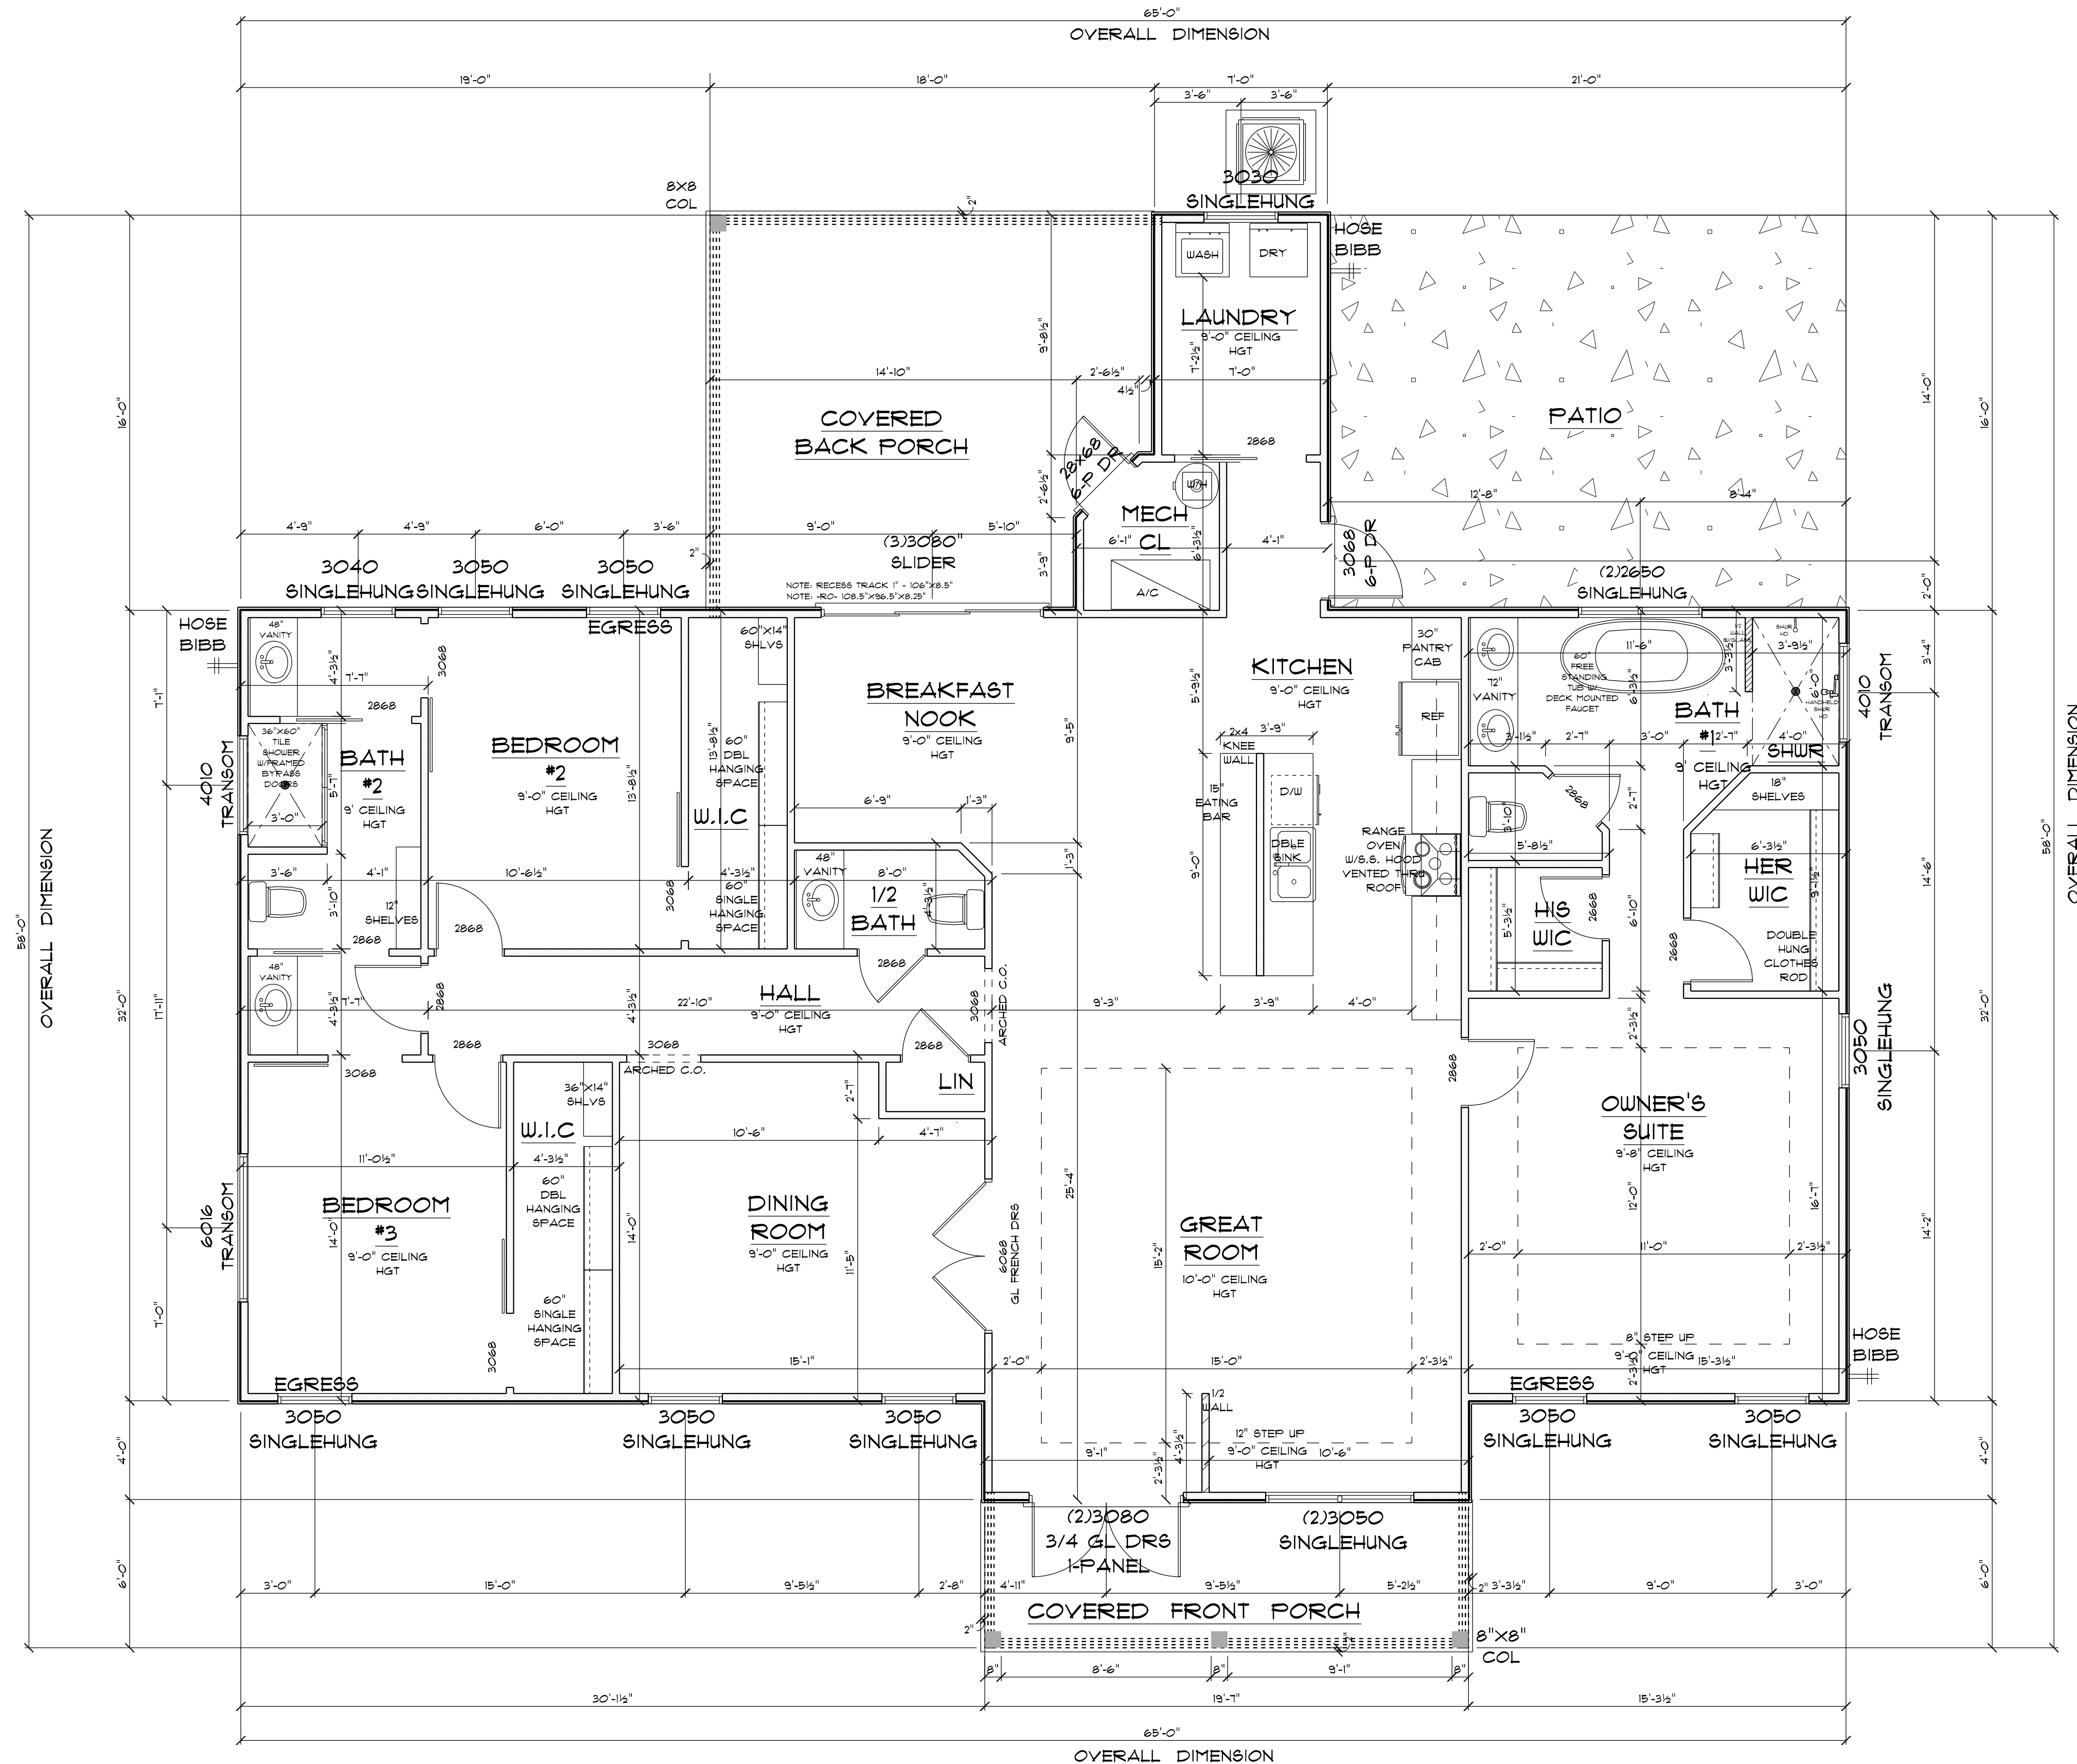

* FLOOR PLAN *

SCALE : 1/4" = 1'-0"

IMPORTANT NOTE:

- IT IS THE BUILDER'S RESPONSIBILITY TO VERIFY ALL GEOMETRY AND DIMENSIONS BEFORE ORDERING ANY MATERIALS OR BEGINNING CONSTRUCTION.
- THESE PLANS ARE FOR LAYOUT AND DESIGN PURPOSES ONLY ALL STRUCTURAL NOTES AND DETAILS TO BE PROVIDED BY AN ENGINEER.
- 2X4 EXTERIOR STUD WALLS 2X4 INTERIOR WALLS

MAIN A/C LIVING AREA	:	2287 S.F.
COVERED FRONT PORCH	:	123 S.F.
COVERED BACK PORCH	:	280 S.F.
TOTAL AREA UNDER ROOF	:	2,690 S.F.

NEW RESIDENCE
FOR
TYRONE & THAYLA
MULLINS

Teena M. Ruffo
2925 SW 8R 47
Lake City Florida, 32025
Cell: (386) 861-1191
Email: teenaruffo@gmail.com

PRINTED DATE:
Monday, October 28, 2024

DRAWN BY: Teena and Kara

CHECKED BY:

BUILDING CONTRACTOR
ZECHER CONSTRUCTION


FINAL DATE:

JOB NUMBER:

DRAWING NUMBER

A-2


OF 5 SHEETS

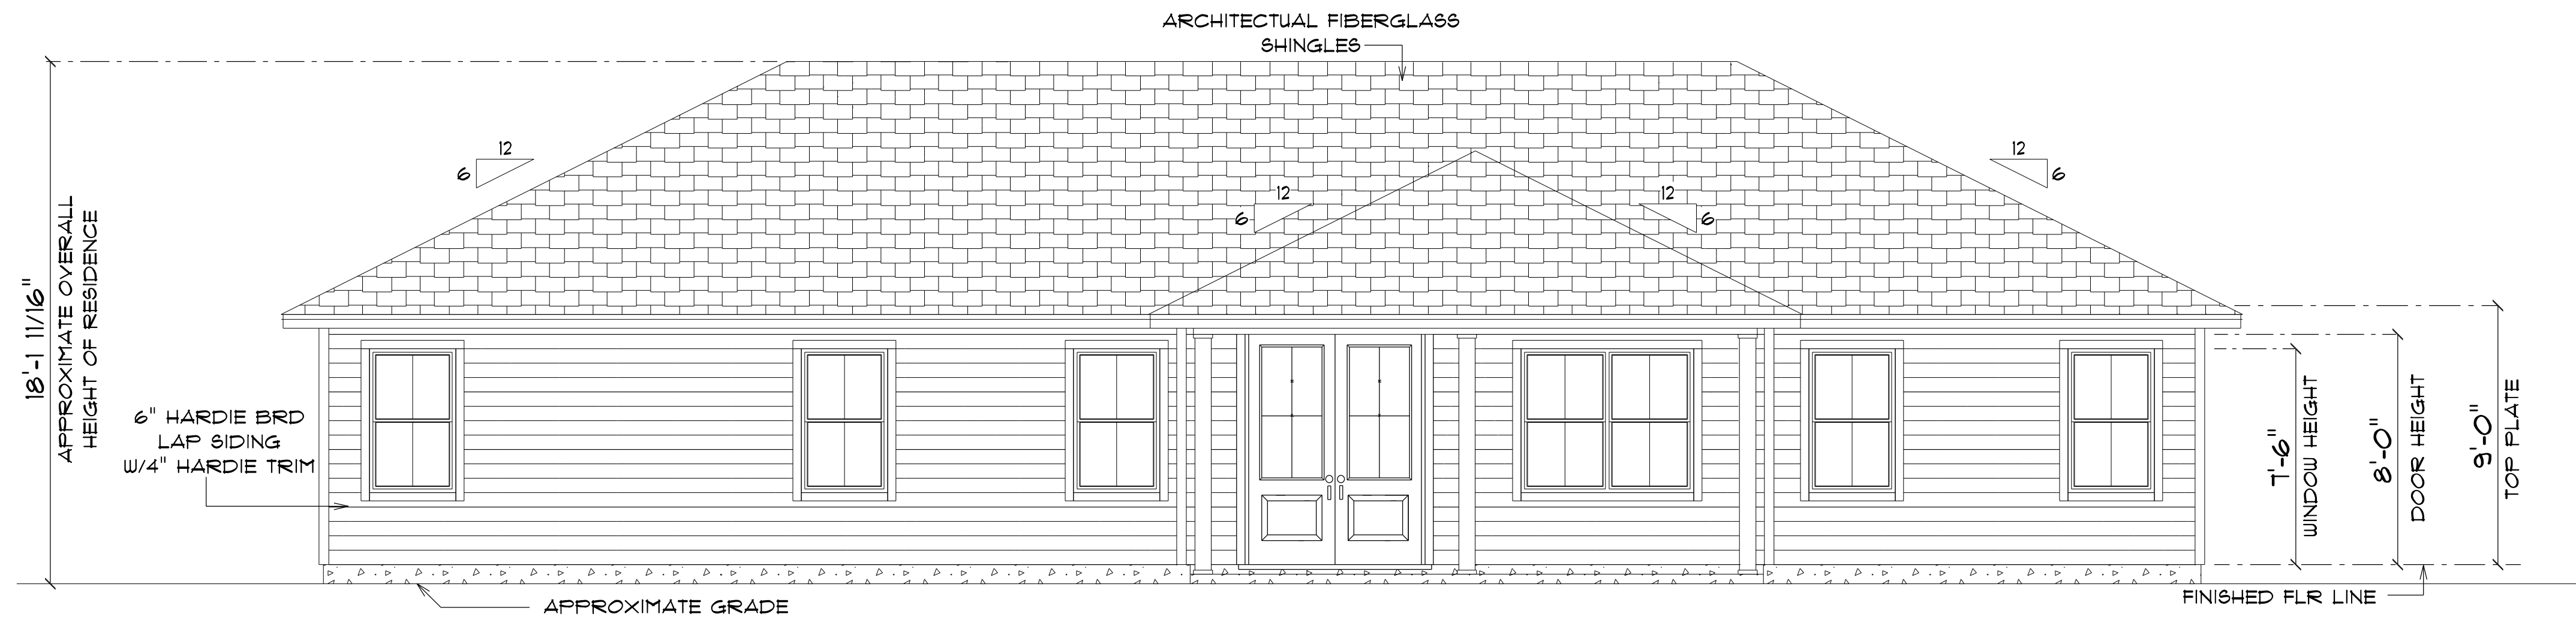

* FRONT ELEVATION *

SCALE : 1/4" = 1'-0"

NOTE: 18" OVERHANG ON EAVES

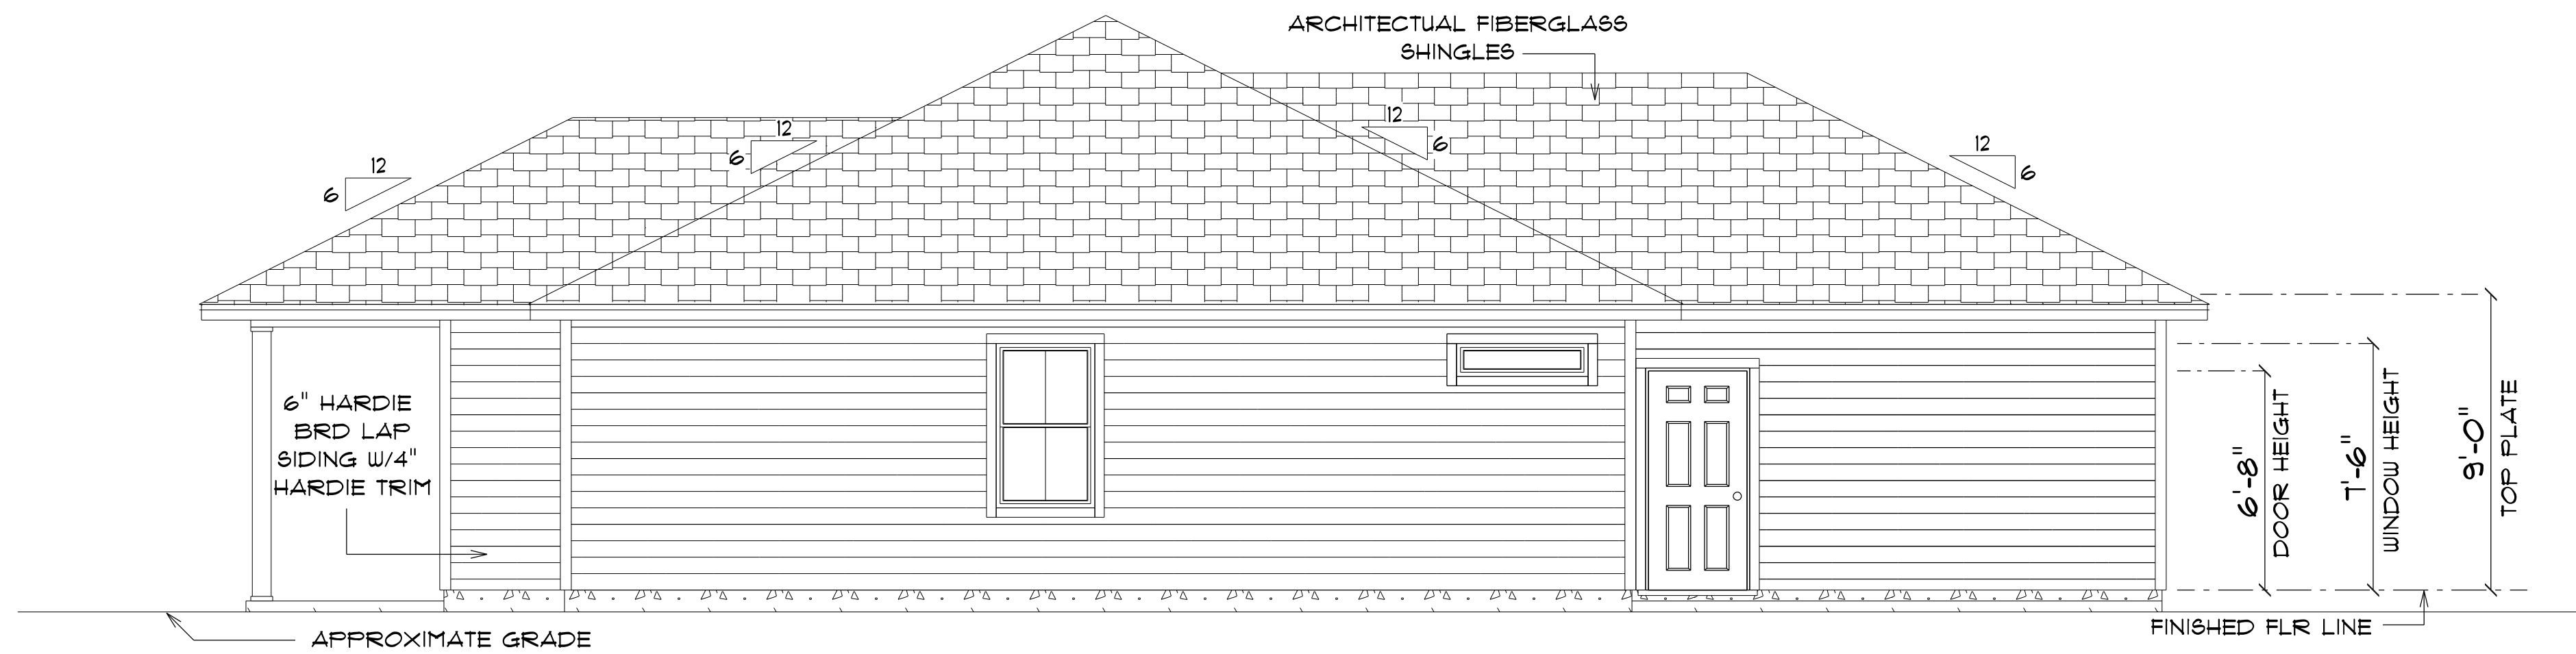

* RIGHT ELEVATION *

SCALE : 1/4" = 1'-0"

NOTE: 18" OVERHANG ON EAVES

NEW RESIDENCE
FOR
TYRONE & THAYLA
MULLINS

Teena M. Ruffo
2925 SW 8R 41
Lake City Florida, 32025
Cell: (386) 861 - 1191
Email: teenaruffo@gmail.com

PRINTED DATE:
Monday, October 28, 2024

DRAWN BY: Teena and Kara

BUILDING CONTRACTOR
ZECHER CONSTRUCTION


FINAL DATE:

JOB NUMBER:

DRAWING NUMBER

A-3

OF 5 SHEETS

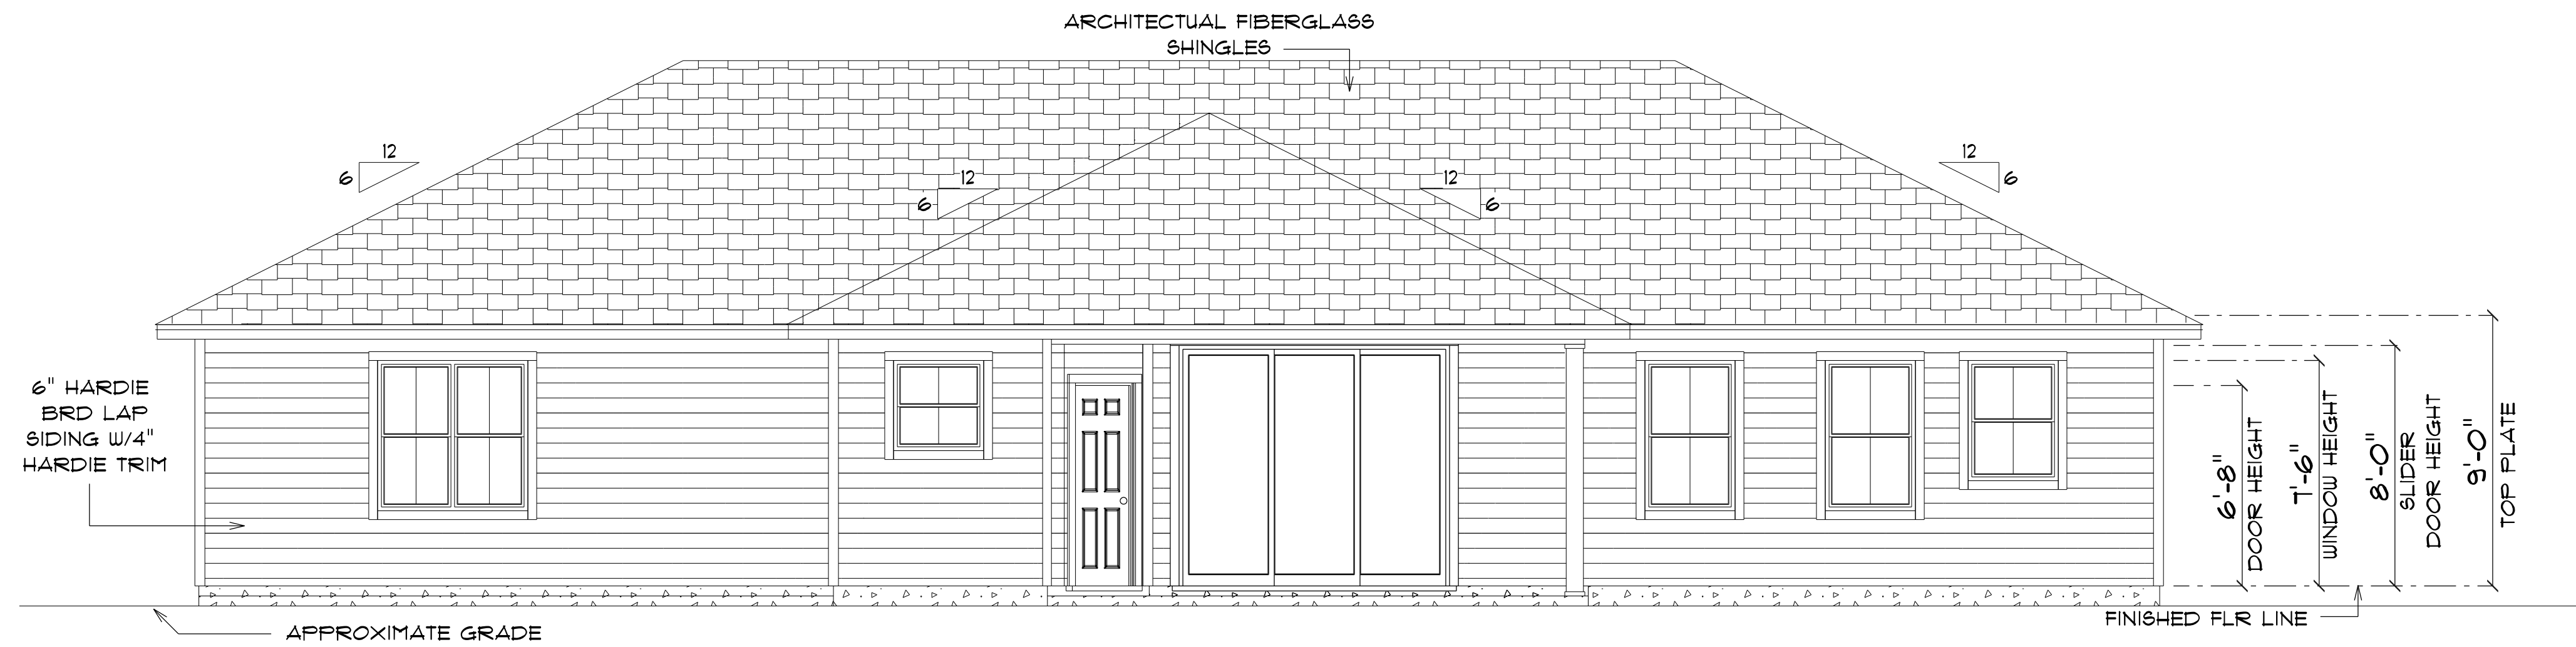

* REAR ELEVATION *

SCALE : 1/4" = 1'-0"

NOTE: 18" OVERHANG ON EAVES



* LEFT ELEVATION *

SCALE : 1/4" = 1'-0"

NOTE: 18" OVERHANG ON EAVES

NEW RESIDENCE
FOR
TYRONE & THAYLA
MULLINS

Teena M. Ruffo
2925 SW 8R 41
Lake City Florida, 32025
Cell: (386) 861 - 1191
Email: teenaruffo@gmail.com

PRINTED DATE:
Monday, October 28, 2024

DRAWN BY: Teena and Kara

CHECKED BY:

BUILDING CONTRACTOR
ZECHER CONSTRUCTION


FINAL DATE:

JOB NUMBER:

DRAWING NUMBER

A-4

OF 5 SHEETS

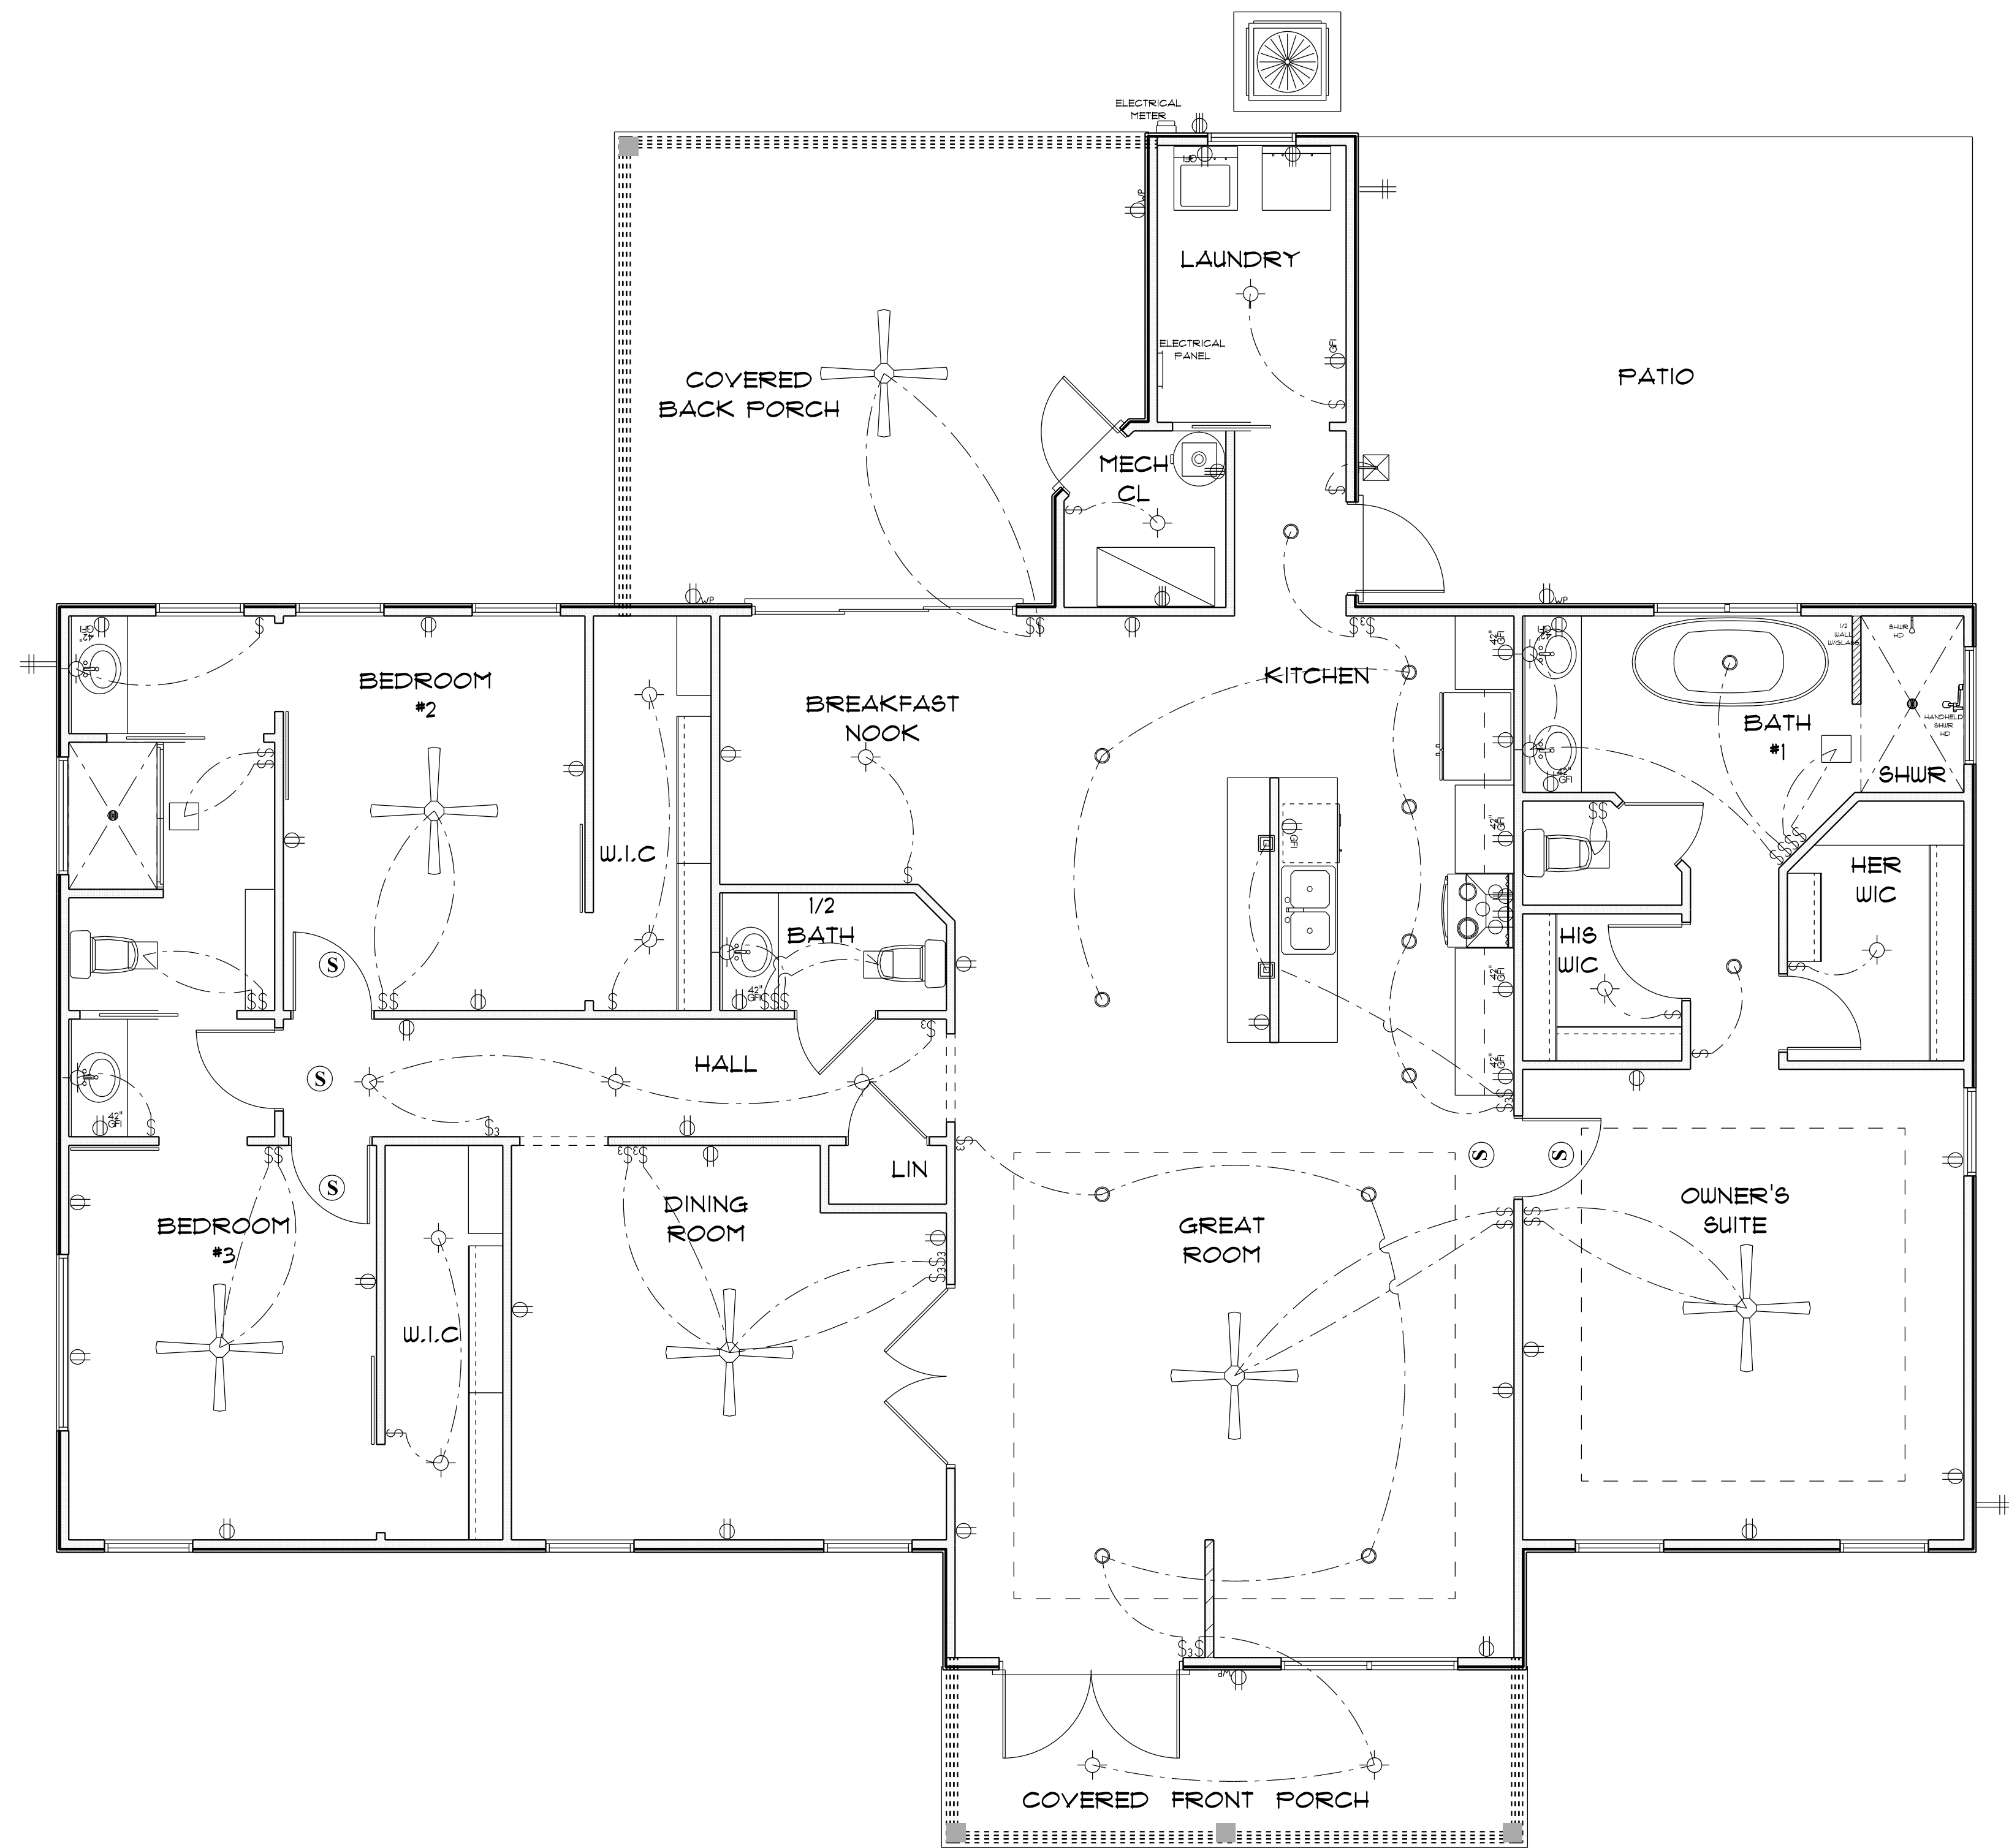

ELECTRICAL LEGEND		
ELECTRICAL	COUNT	SYMBOL
arts and craft exterior light	1	
ceiling fan	6	
ceiling light vent square	5	
electrical panel	1	
light	19	
outlet	28	
outlet 220v	5	
outlet gfi	12	
outlet wp	4	
pendant large	2	
pot light	13	
Smoke Detector	5	
switch	37	
switch 3 way	10	

ELECTRICAL PLAN NOTES

- E-1 WIRE ALL APPLIANCES, HVAC UNITS AND OTHER EQUIPMENT PER MANUFACTURER'S SPECIFICATIONS.
- E-2 CONSULT THE OWNER FOR THE NUMBER OF SEPERATE TELEPHONE LINES TO BE INSTALLED.
- E-3 ALL INSTALLATIONS SHALL BE PER NATIONAL ELECTRIC CODE.
- E-4 ALL SMOKE DETECTORS SHALL BE 120V W/BATTERY BACKUP OF THE PHOTOELECTRIC TYPE, AND SHALL BE INTERLOCKED TOGETHER. INSTALL INSIDE AND NEAR ALL BEDROOMS.
- E-5 TELEPHONE, TELEVISION AND OTHER LOW VOLTAGE DEVICES OR OUTLETS SHALL BE AS PER THE OWNER'S DIRECTION AND IN ACCORDANCE WITH APPLICABLE SECTIONS OF NATIONAL ELCT. CODE LATEST EDITION.
- E-6 ELECTRICAL CONTRACTOR SHALL BE RESPONSIBLE FOR THE DESIGN AND SIZING OF ELECTRICAL SERVICE AND CIRCUITS.
- E-7 ENTRY OF SERVICE UNDERGROUND OR OVERHEAD) IS TO BE DETERMINED BY THE POWER COMPANY.
- E-8 ALL BEDROOM RECEPTALS ARE TO BE AFCI (ARC FAULT CIRCUIT INTERRUPT)

* ELECTRICAL PLAN *

NEW RESIDENCE
FOR
TYRONE & THAYLA
MULLINS

Tesna M. Ruffo
2925 SW 8R 41
Lake City Florida, 32025
Cell: (386) 861 - 1191
Email: tesnaruffo@gmail.com

PRINTED DATE:
Monday, October 28, 2024

DRAWN BY: Tesna and Kara CHECKED BY:

BUILDING CONTRACTOR
ZECHER CONSTRUCTION

FINAL DATE:

JOB NUMBER:

DRAWING NUMBER

A-5
OF 5 SHEETS