


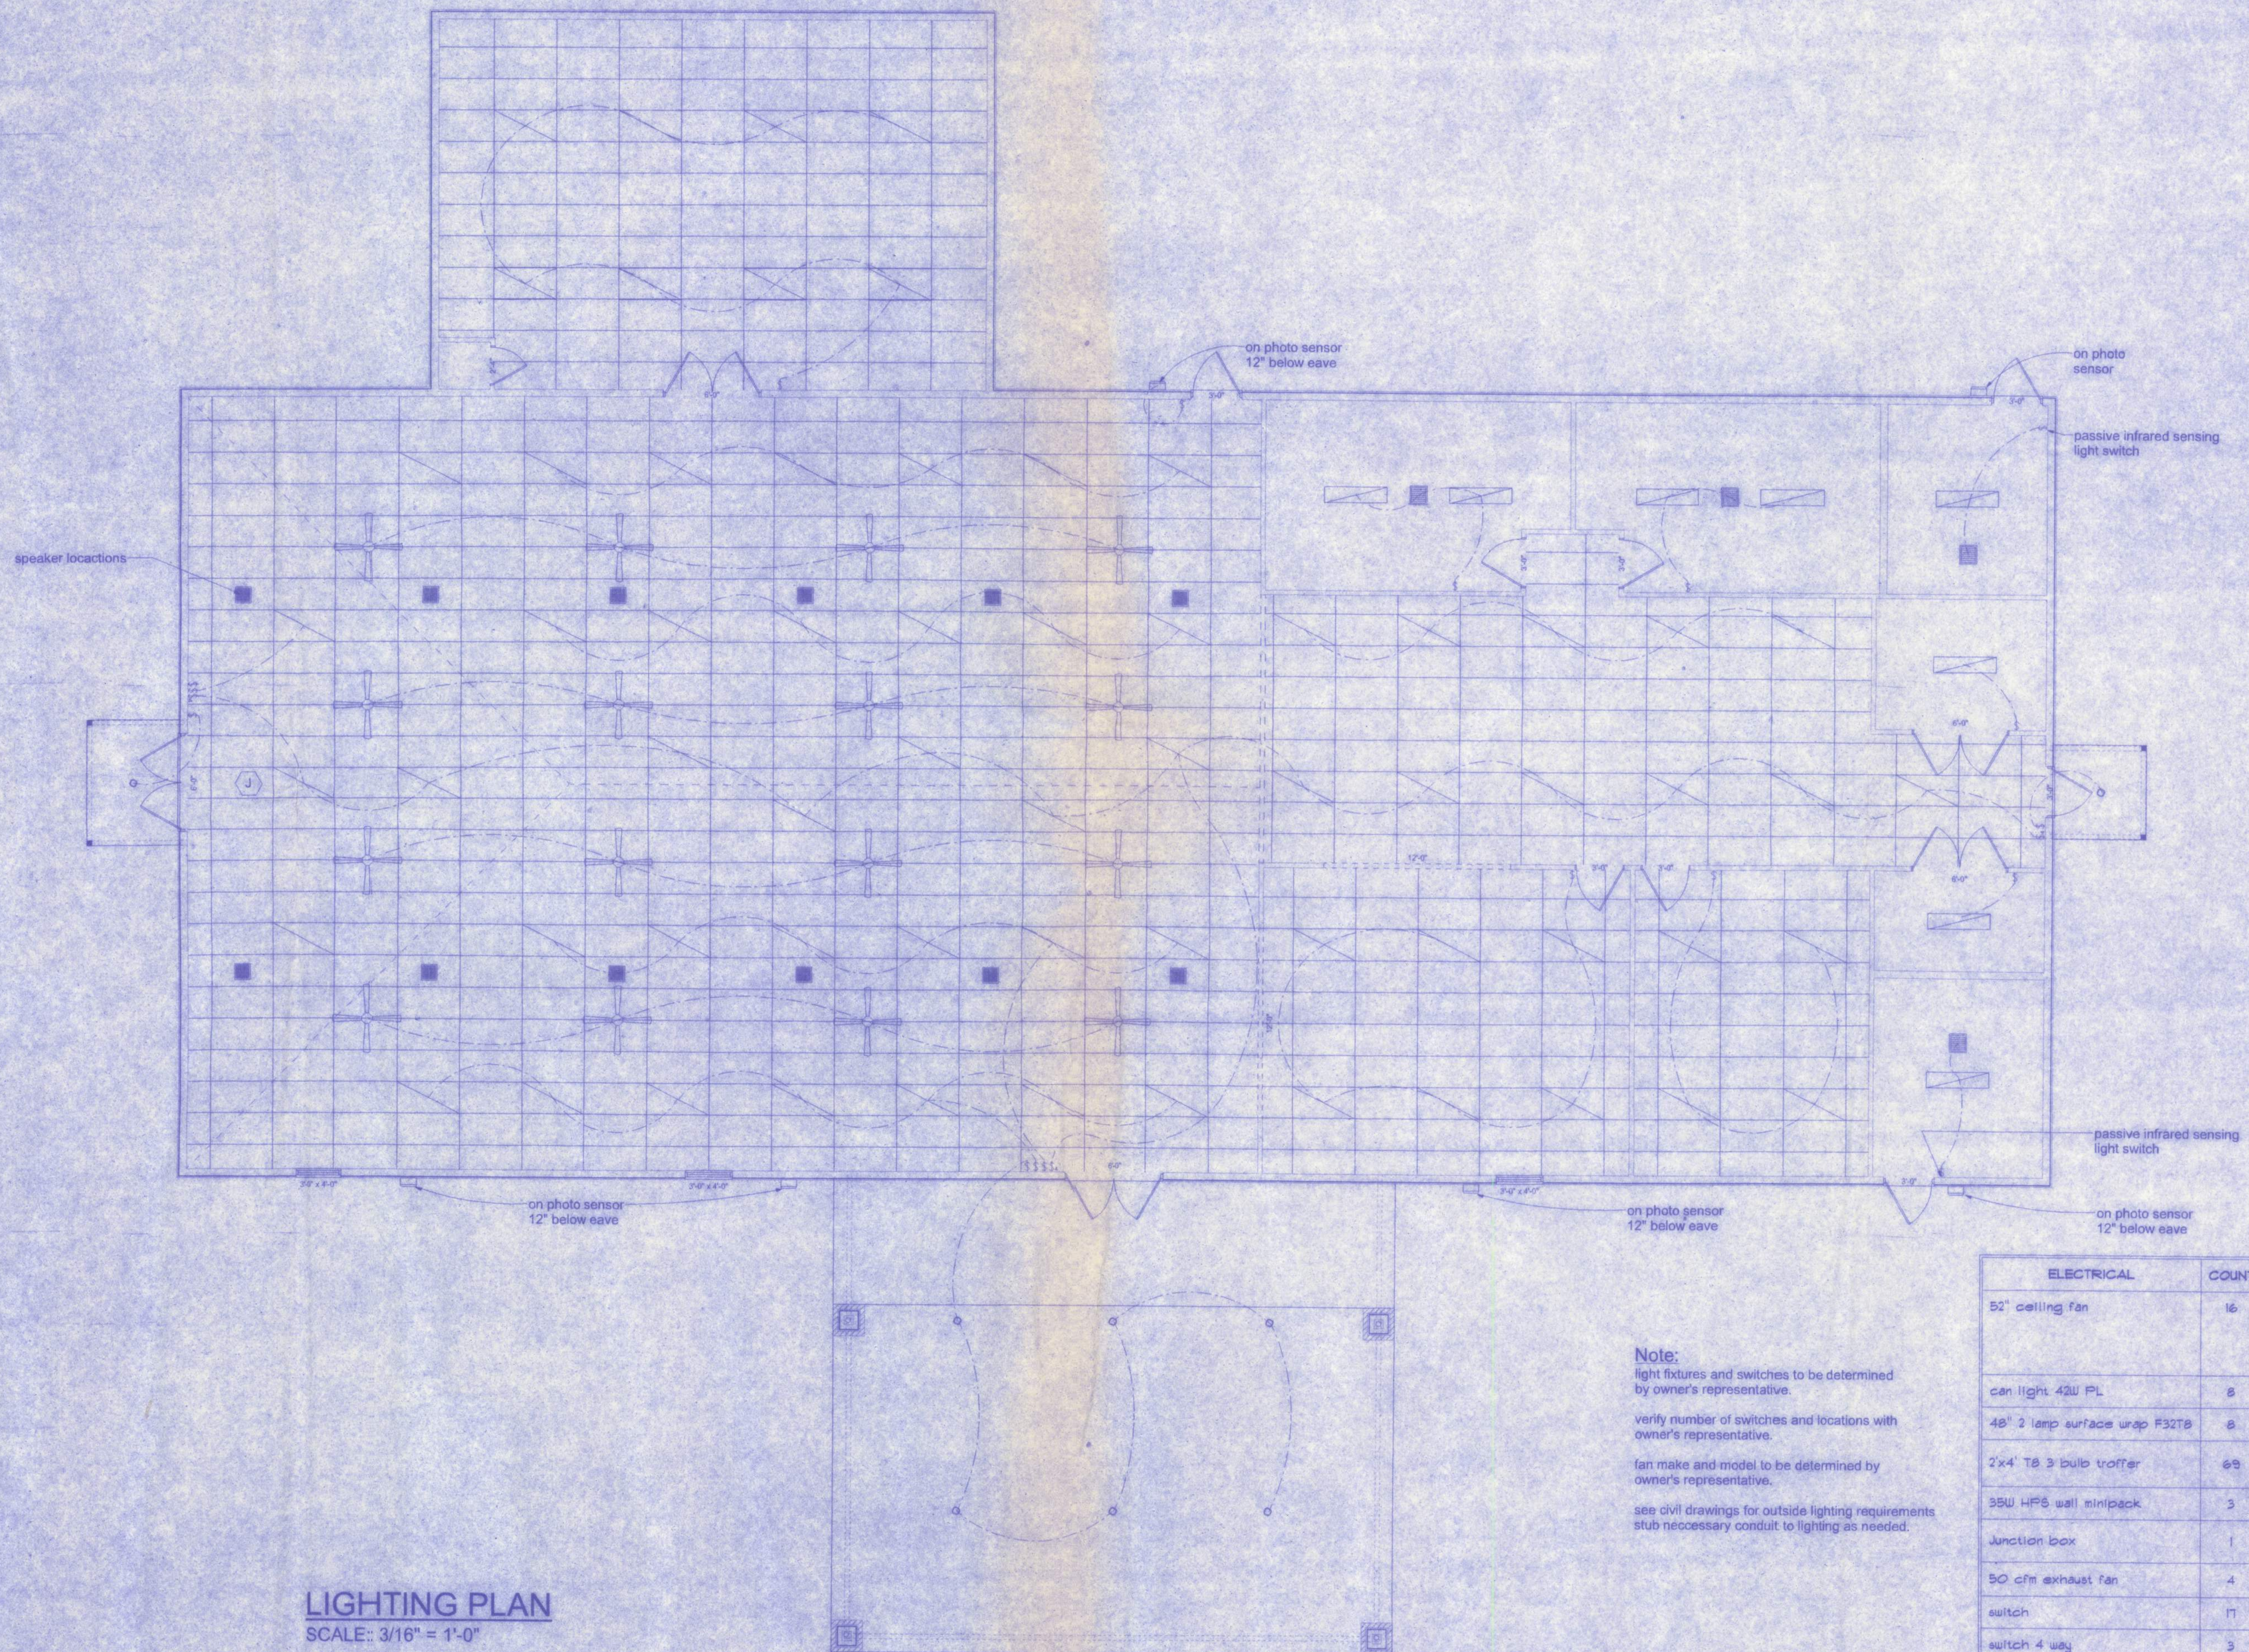


LIGHTING PLAN
SCALE: 3/16" = 1'-0"

Note:
light fixtures and switches to be determined by owner's representative.


verify number of switches and locations with owner's representative.

fan make and model to be determined by owner's representative.

see civil drawings for outside lighting requirements
stub necessary conduit to lighting as needed.

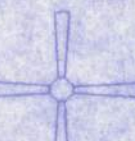ELECTRICAL	COUNT	SYMBOL
52" ceiling fan	16	
can light 42W PL	8	
48" 2 lamp surface wrap F32T8	8	
2'x4' T8 3 bulb troffer	69	
35W HPS wall minipack	3	
Junction box	1	
50 cfm exhaust fan	4	
switch	17	
switch 4 way	3	

128 SW NASSAU STREET
LAKE CITY, FL 32025
(386)758-4209

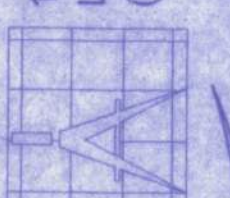

Freeman
Design Group Inc.

DATE
11/6/10

DRAWN BY
W.H.F.

APPROVED
W.H.F.

REVISIONS

SHEET E-2

OF 5

PROJECT NO.
09.C037

WEST SIDE COMMUNITY CENTER

W.H.F.
11/6/10
P.E. # 88801

CERTIFICATE OF AUTHORIZATION # 00088701