


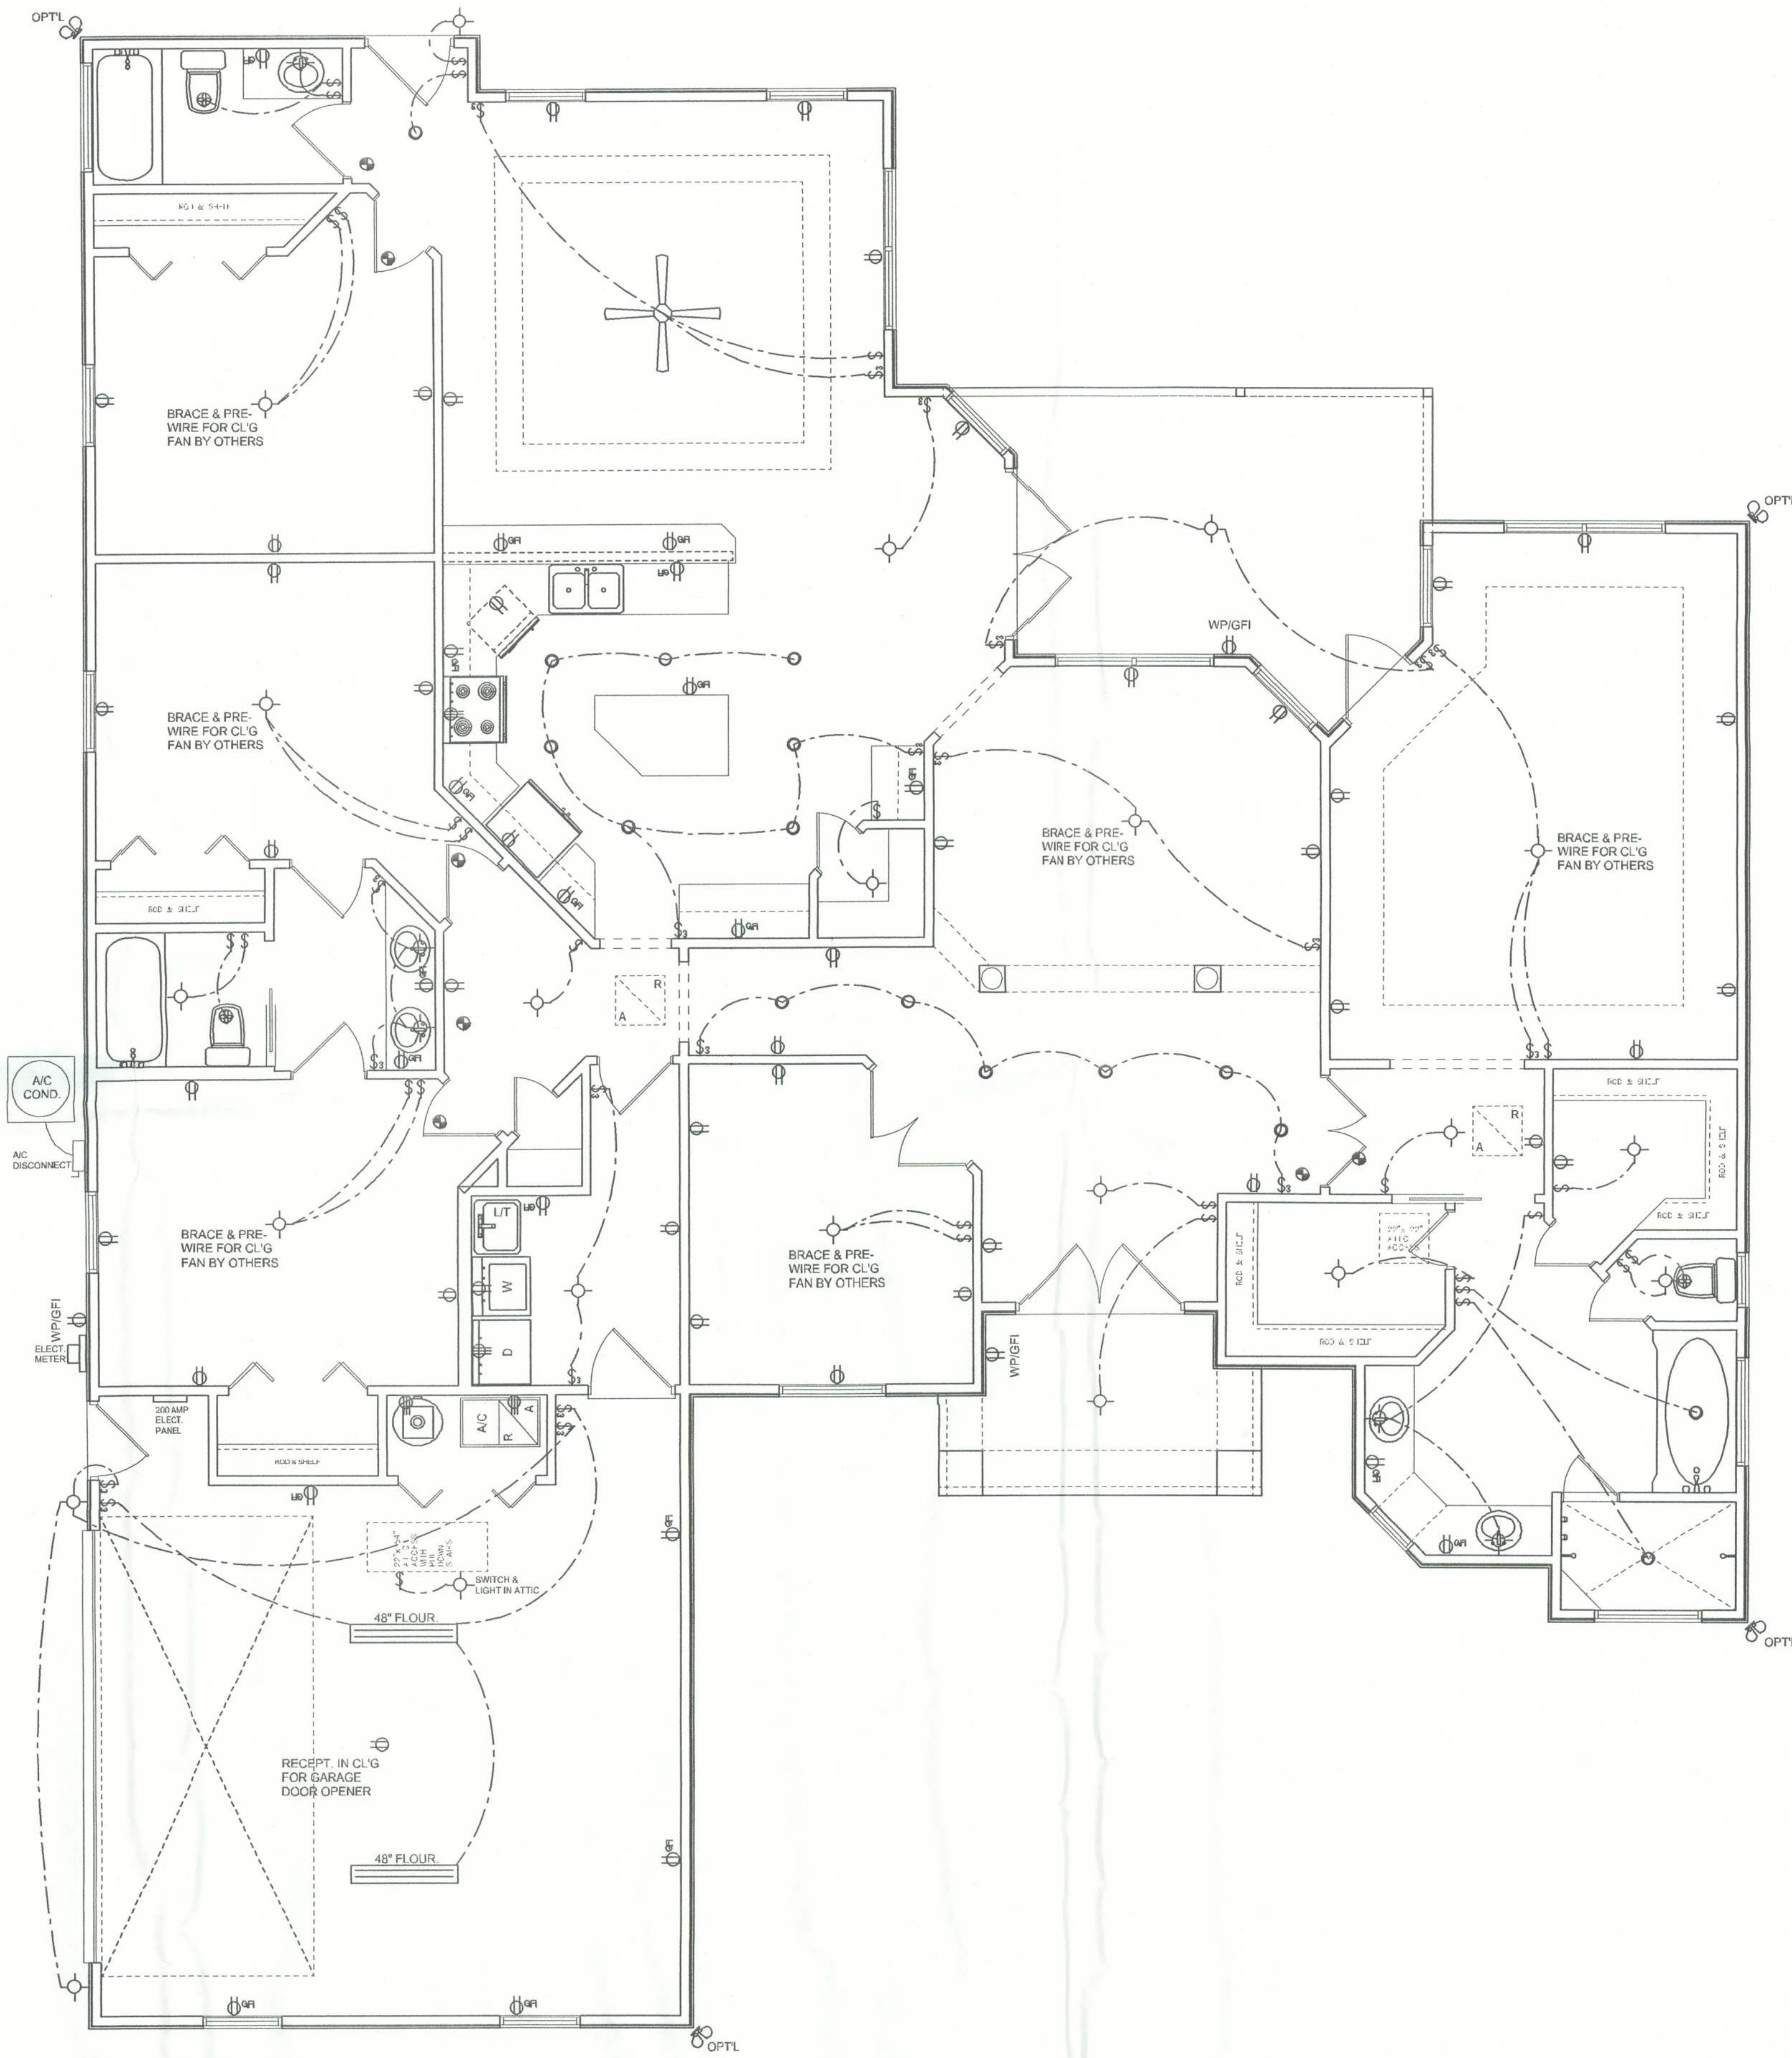

**ELECTRICAL PLAN**  
SCALE: 1/8" = 1'-0"

| ELECTRICAL LEGEND |                                         |
|-------------------|-----------------------------------------|
|                   | CEILING FAN<br>(PRE-WIRE FOR LIGHT KIT) |
|                   | DOUBLE SECURITY LIGHT                   |
|                   | RECESSED CAN LIGHT                      |
|                   | BATH EXHAUST FAN                        |
|                   | LIGHT FIXTURE                           |
|                   | DUPLEX OUTLET                           |
|                   | 220v OUTLET                             |
|                   | GFI DUPLEX OUTLET                       |
|                   | SMOKE DETECTOR (see note below)         |
|                   | WALL SWITCH                             |
|                   | 3 WAY WALL SWITCH                       |
|                   | WATER PROOF GFI OUTLET                  |
|                   | 2 OR 4 TUB FLUORESCENT FIXTURE          |

NOTE:  
ALL BEDROOM RECEPTACLES SHALL BE AFCI  
(ARC FAULT CIRCUIT INTERRUPT)  
ALL SMOKE DETECTORS SHALL HAVE BATTERY BACKUP POWER  
AND ALL WIRED TOGETHER SO IF ANY ONE UNIT IS ACTUATED THEY  
ALL ACTIVATE.


REVISIONS  
August 15, 2005

**SOFTPLAN**  
ARCHITECTURAL DESIGN SOFTWARE

**ELECTRICAL PLAN**  
SCALE: 1/8" = 1'-0"

A CUSTOM RESIDENCE FOR: TIM & TINA MORRIS  
**ERKINGER HOME BUILDERS, INC**  
PROJECT ADDRESS: LOT 6, HERITAGE HILLS, COLUMBIA COUNTY, FLORIDA

©WILLIAM MYERS  
**DESIGN**  
P.O. BOX 1513  
LAKE CITY, FL 32096  
(386) 758-6406  
will@willmyers.net

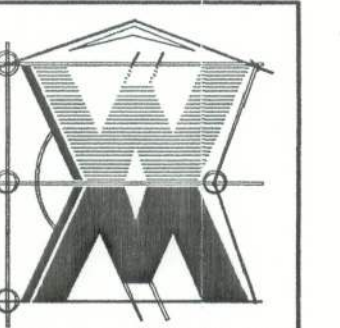

JOB NUMBER  
050407

SHEET NUMBER  
**A.4**  
OF 4 SHEETS

*William C. Myers*