
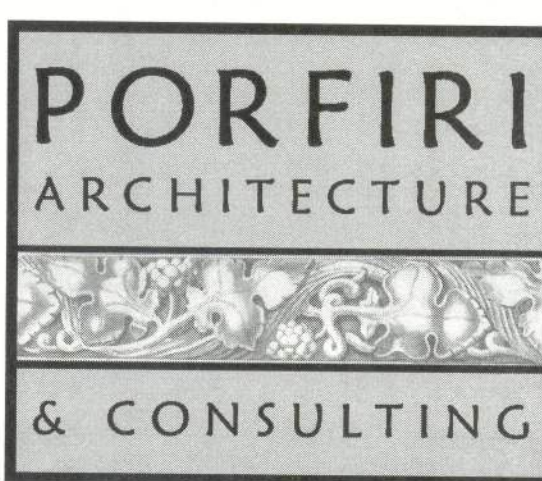


| PLUMBING FIXTURE CONNECTION SCHEDULE |                       |        |       |      |                    |
|--------------------------------------|-----------------------|--------|-------|------|--------------------|
| NO.                                  | DESCRIPTION           | DRAIN  | WATER |      | MANUFACTURER MODEL |
|                                      |                       |        | COLD  | HOT  |                    |
| WC 1                                 | WATER CLOSET TANK, HC | 3"     | 1/2"  | ---  | SELECTED BY OWNER  |
| WC 2                                 | WATER CLOSET TANK, HC | 3"     | 1/2"  | ---  |                    |
| WC 3                                 | WATER CLOSET TANK, HC | 3"     | 1/2"  | ---  |                    |
| BA 1                                 | BATH TUB              | 2"     | 1/2"  | 1/2" |                    |
| BA 2                                 | BATH TUB              | 2"     | 1/2"  | 1/2" |                    |
| SHR #1                               | Master Bath shower    | 2"     | 1/2"  | 1/2" |                    |
| SHR #2                               | Bath #2 HC shower     | 2"     | 1/2"  | 1/2" |                    |
| SHR #3                               | Mud Room shower       | 2"     | 1/2"  | 1/2" |                    |
| SK 1                                 | SINK, double          | 1 1/2" | 1/2"  | 1/2" |                    |
| SK 2                                 | SINK, wall mounted    | 1 1/2" | 1/2"  | 1/2" |                    |
| LV 1                                 | LAVATORY, countertop  | 1 1/2" | 1/2"  | 1/2" |                    |
| LV 2                                 | LAVATORY, countertop  | 1 1/2" | 1/2"  | 1/2" |                    |

| TANKLESS WATER HEATER                                                                      |                |                 |                         |               |                         |               |
|--------------------------------------------------------------------------------------------|----------------|-----------------|-------------------------|---------------|-------------------------|---------------|
| UNIT MARK                                                                                  | MANUFACTURER   | MODEL           | MAX FLOW @ 105°F OUTPUT |               | MAX FLOW @ 113°F OUTPUT |               |
|                                                                                            |                |                 | 55°F INCOMING           | 11°F INCOMING | 55°F INCOMING           | 11°F INCOMING |
| TWH 1                                                                                      | STIEBEL ELTRON | Temptra 20 Plus | 2.91 GPM                | 4.84 GPM      | 2.42 GPM                | 3.63 GPM      |
| TWH 2                                                                                      | STIEBEL ELTRON | Temptra 20 Plus | 2.91 GPM                | 4.84 GPM      | 2.42 GPM                | 3.63 GPM      |
| TWH 3                                                                                      | STIEBEL ELTRON | Temptra 15 Plus | 2.18 GPM                | 3.63 GPM      | 1.82 GPM                | 2.72 GPM      |
| TWH 4                                                                                      | STIEBEL ELTRON | Temptra 12 Plus | 1.82 GPM                | 3.03 GPM      | 1.51 GPM                | 2.21 GPM      |
| TOTALS:                                                                                    |                |                 | 9.82 GPM                | 16.34 GPM     | 8.17 GPM                | 12.25 GPM     |
| MIN. FLOW RATE PER Table 5, HUD-FHA = ( 72 GPH ) = <u>120 GPM</u><br>( 3 Bedroom, 3 Bath ) |                |                 |                         |               |                         |               |

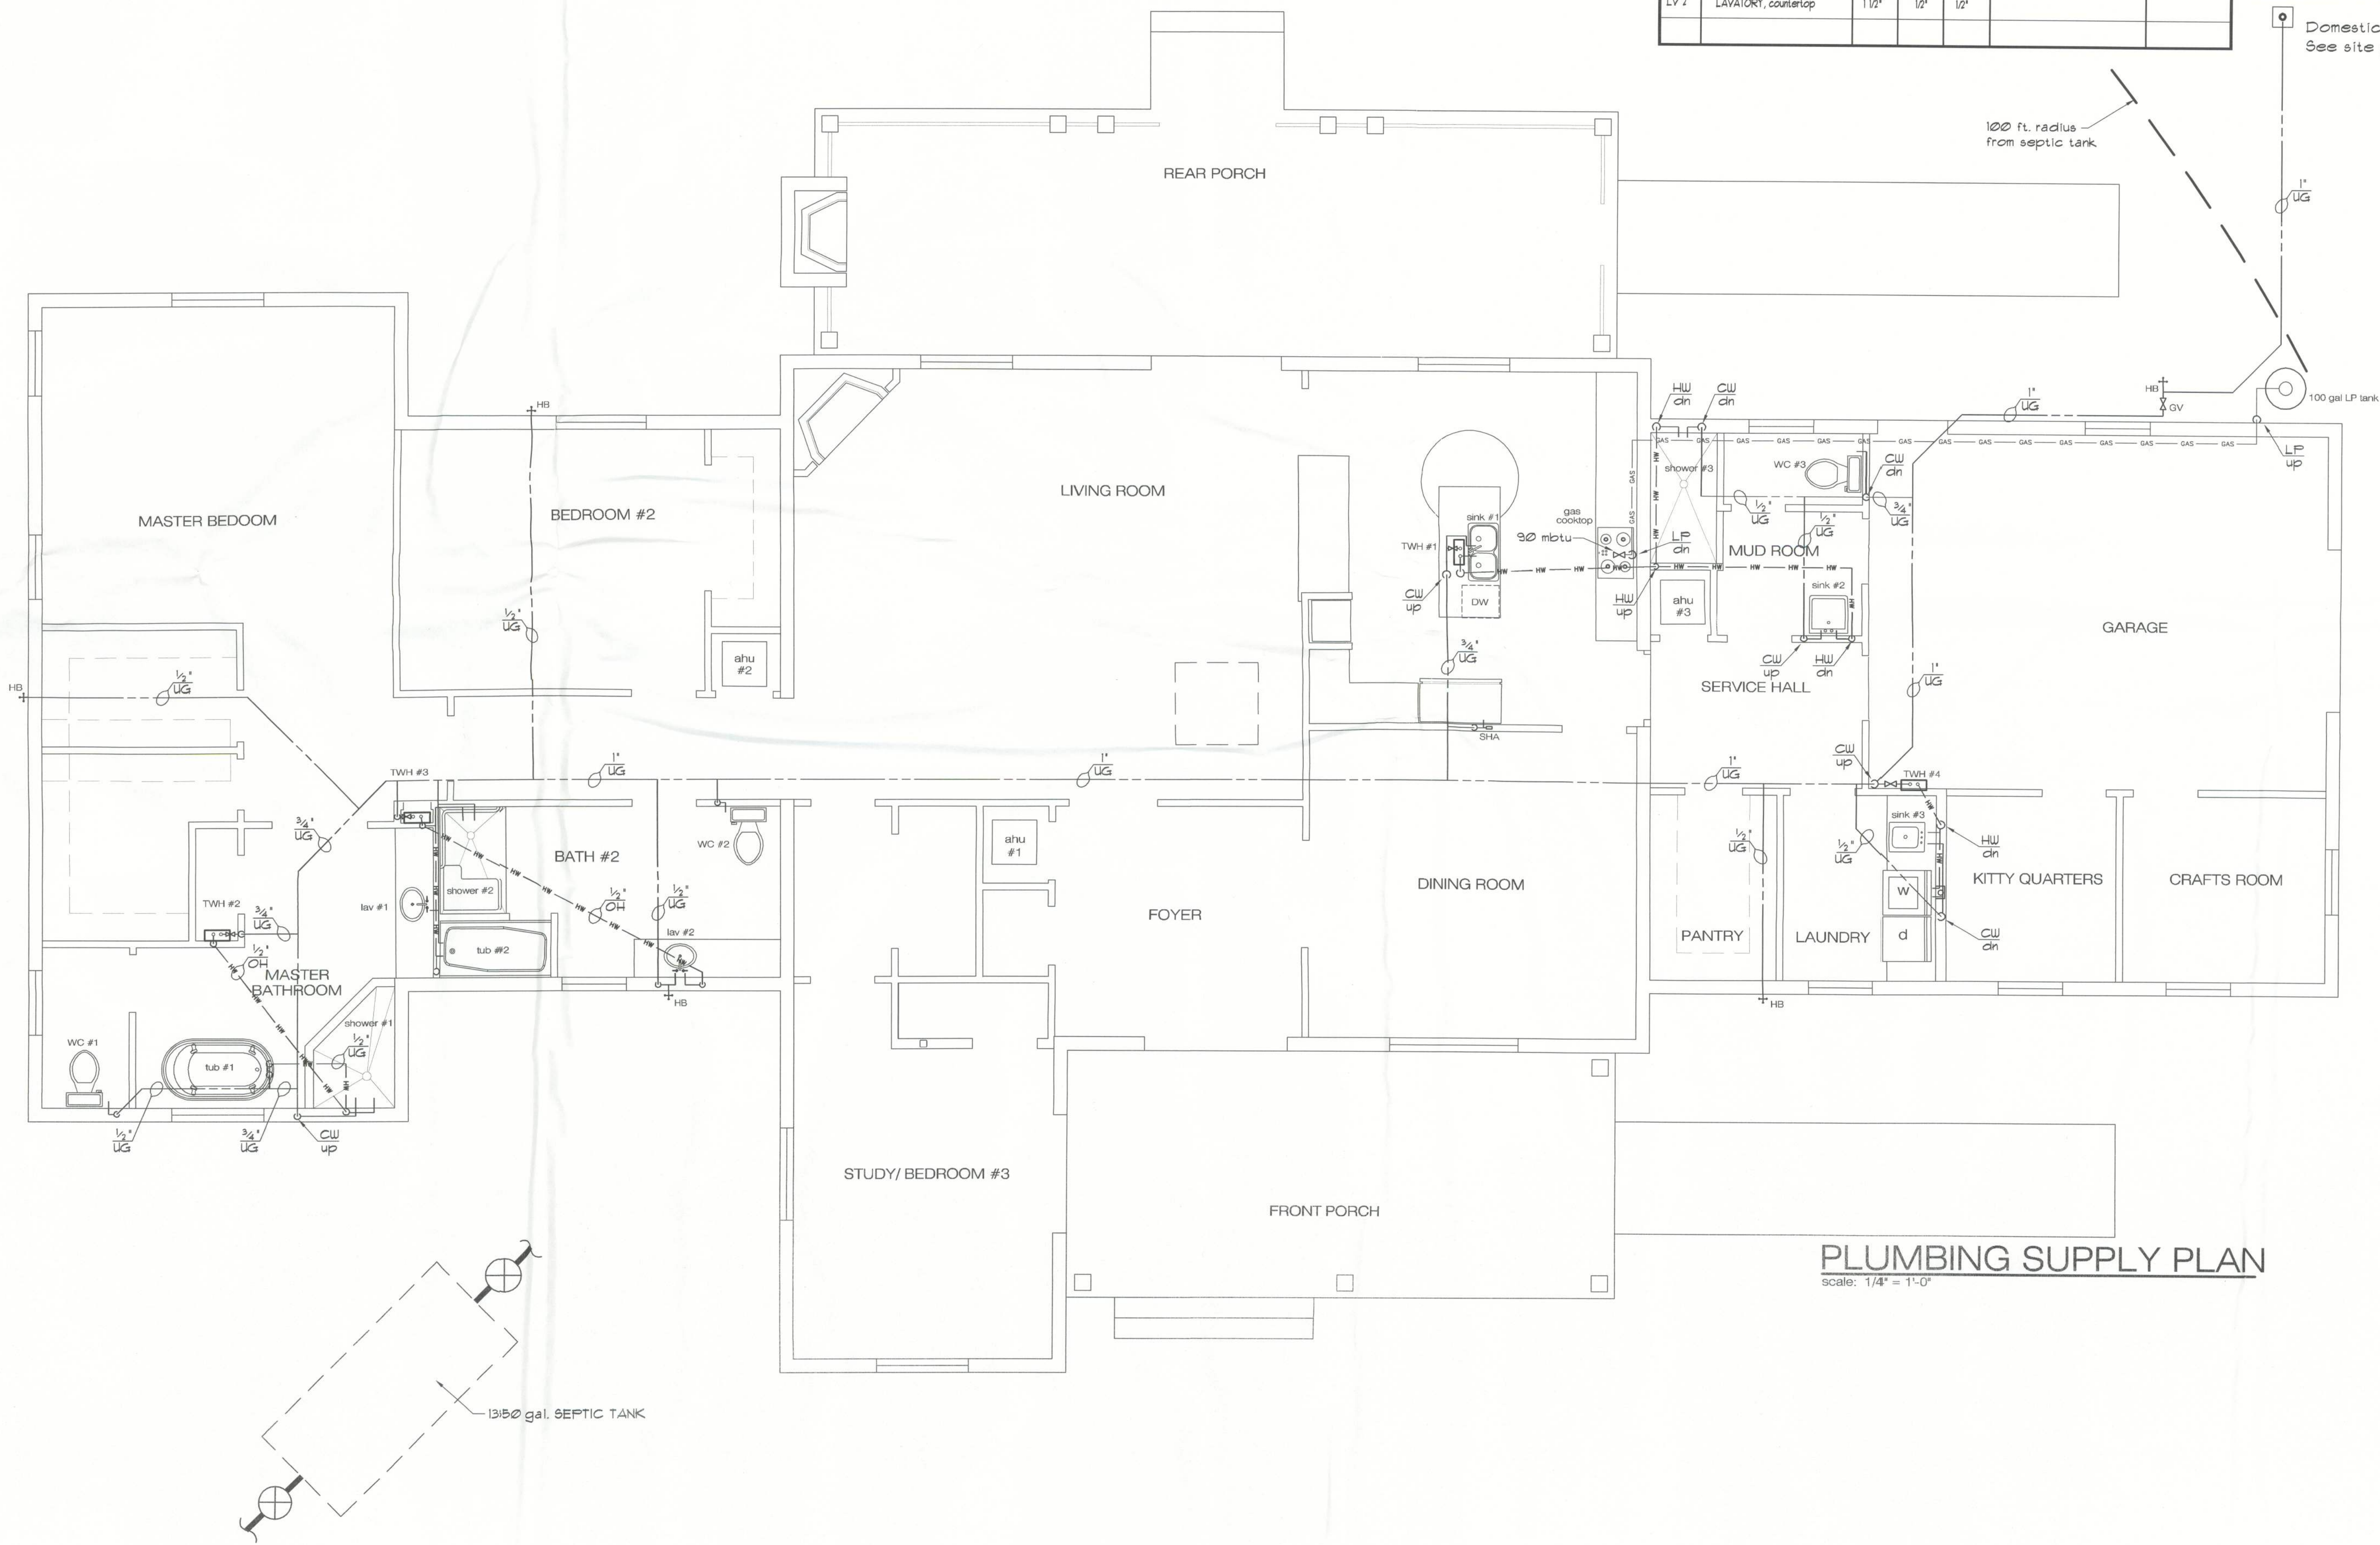

Florida Licenses: AR0008515 / AA26001883  
5794 Bird Road, # 225 Miami, Florida 33155  
Tel 305.665.5500 / Fax 305.665.5800

seal:

consultants:

Copyright notice:  
All graphic and written material appearing herein are instruments of the architect's service for use on this project, and are protected under the Architectural Works Copyright Protection Act of 1990. The material may not be duplicated, used, reprinted or disclosed without the prior written consent of John R. Porfiri, Architect.  
© 2010 John R. Porfiri, Porfiri Architecture & Consulting, LLC

New Residence for  
**Mr. & Mrs. Wade Schile**  
319 Singleton Terrace, Columbia County, Florida

Date: July 14, 2011

Project no.

Drawn: JRFP

Checked: JRFP

Revisions:

Sheet title:

PLUMBING SUPPLY PLAN

Sheet no.

P101