




SECTION VIEW

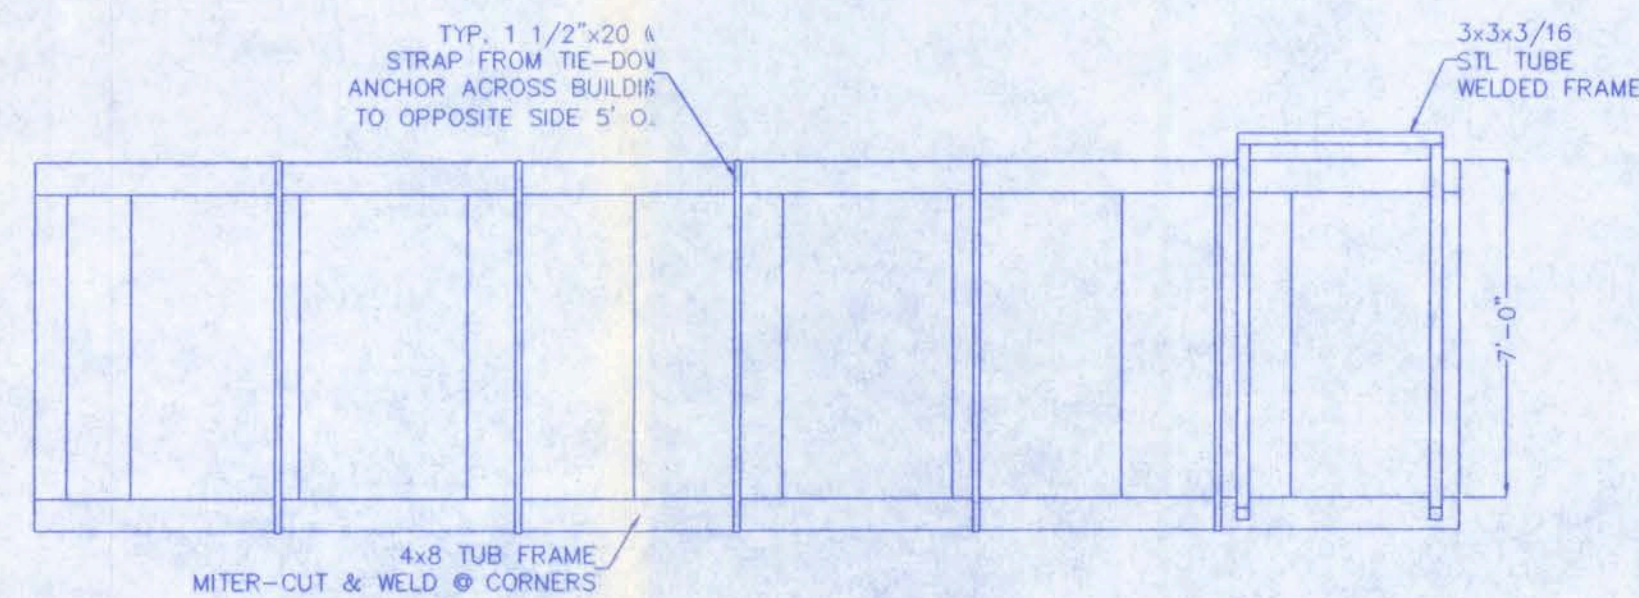


SIDE ELEV. VIEW

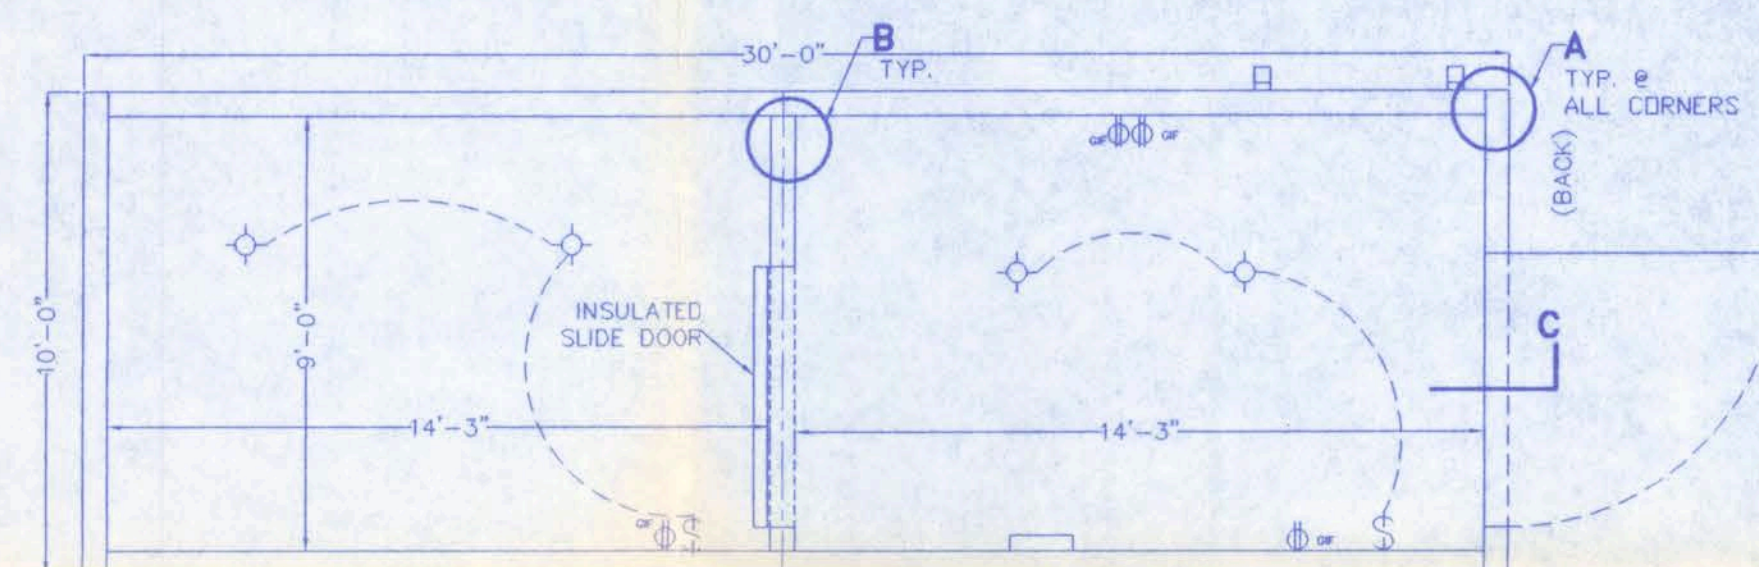


FLOOR PLAN

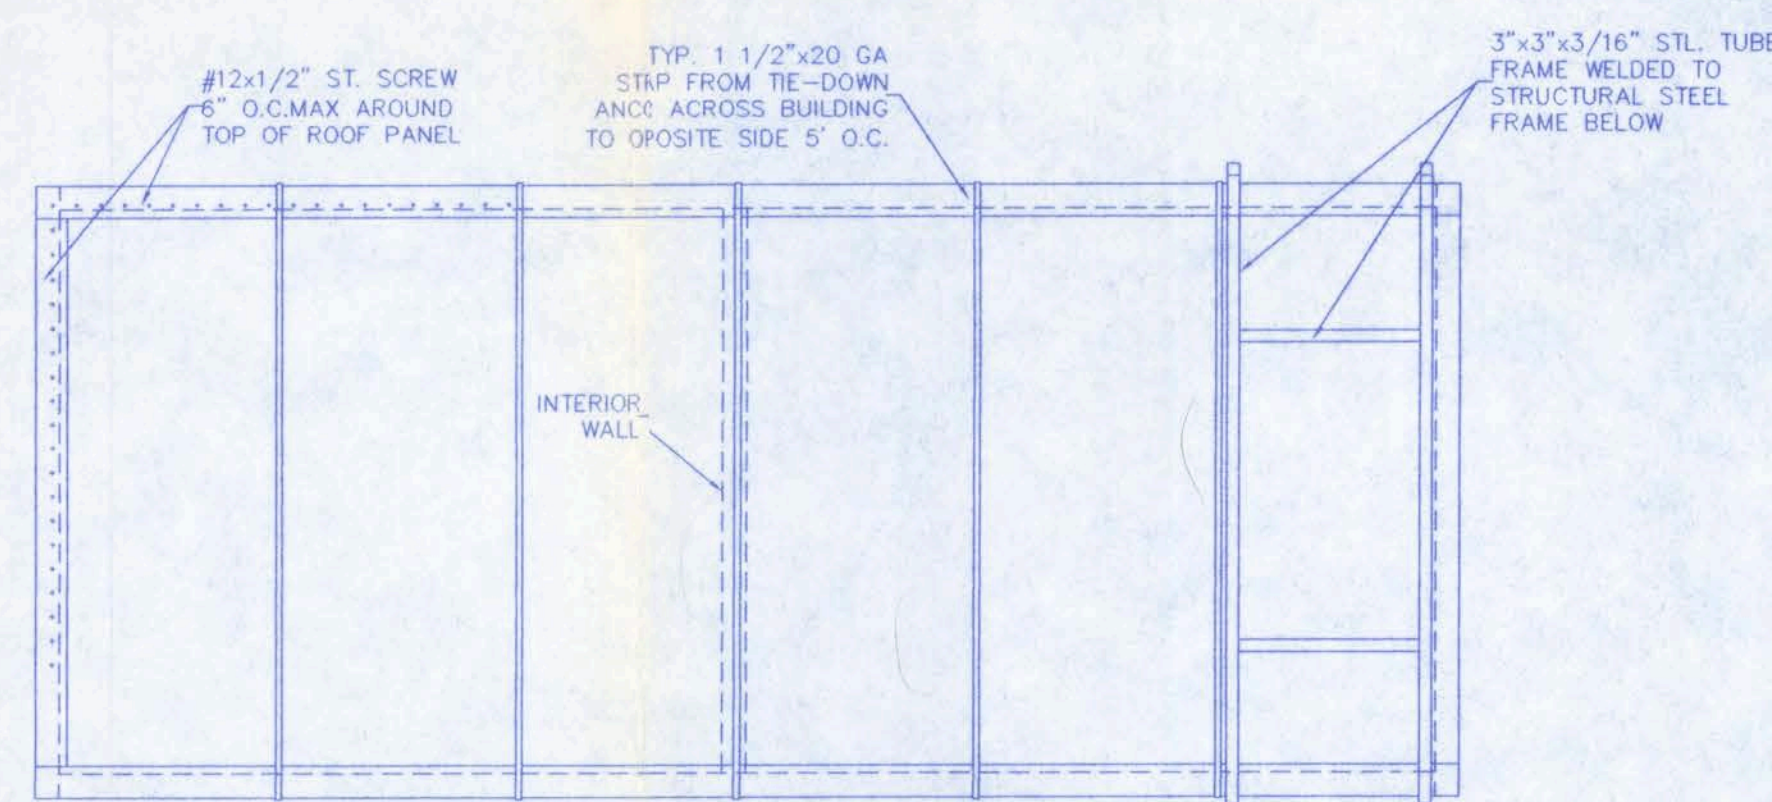


ROOF PLAN

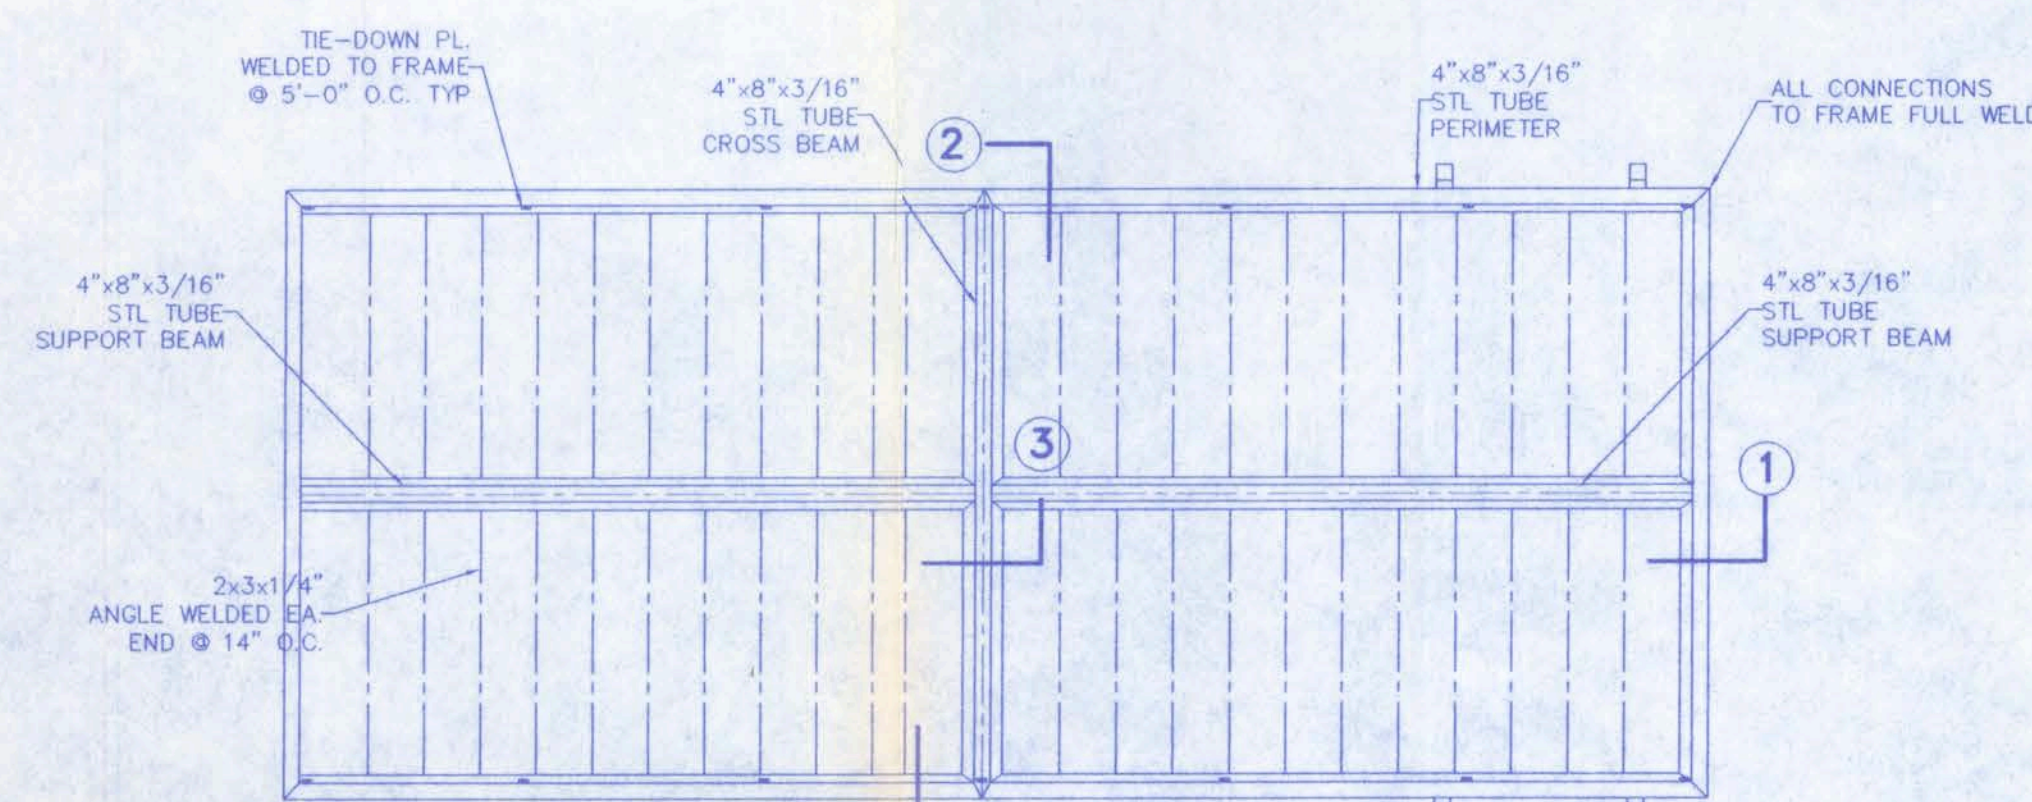


FRAME PLAN

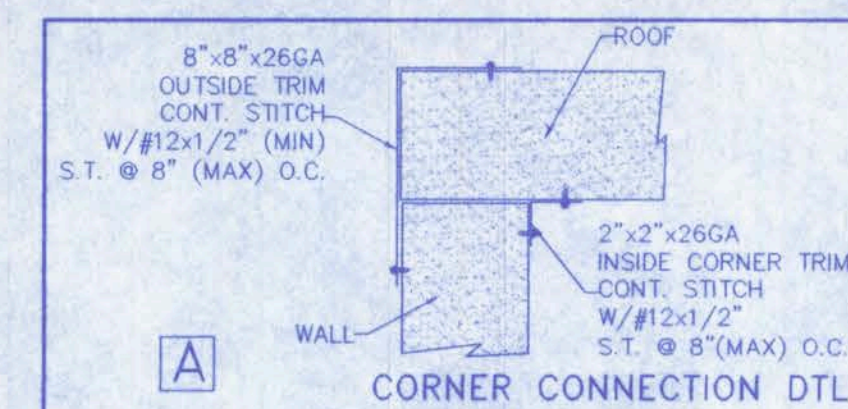


CORNER CONNECTION DTL

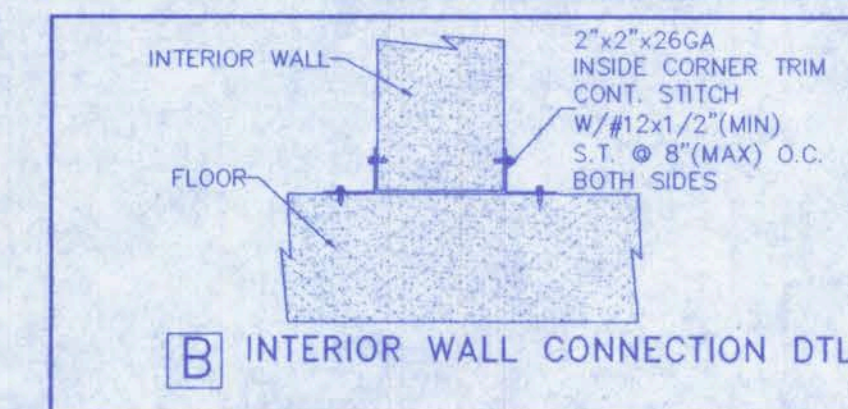


INTERIOR WALL CONNECTION DTL

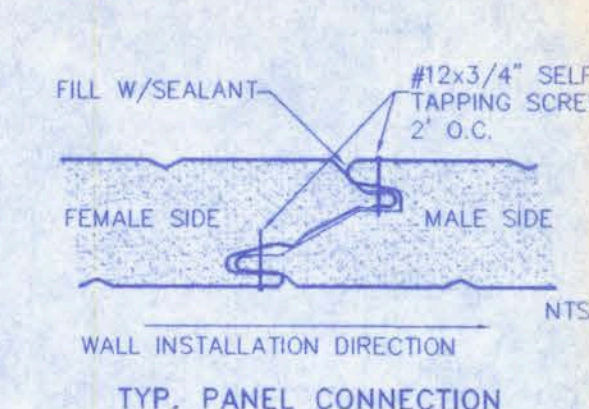


TYP. PANEL CONNECTION

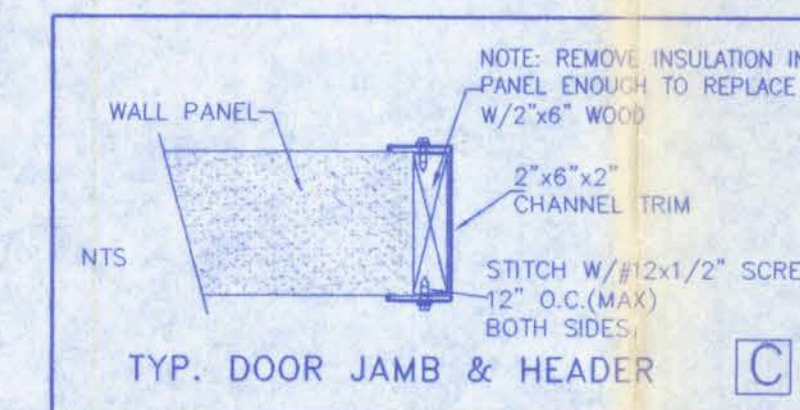


TYP. DOOR JAMB & HEADER

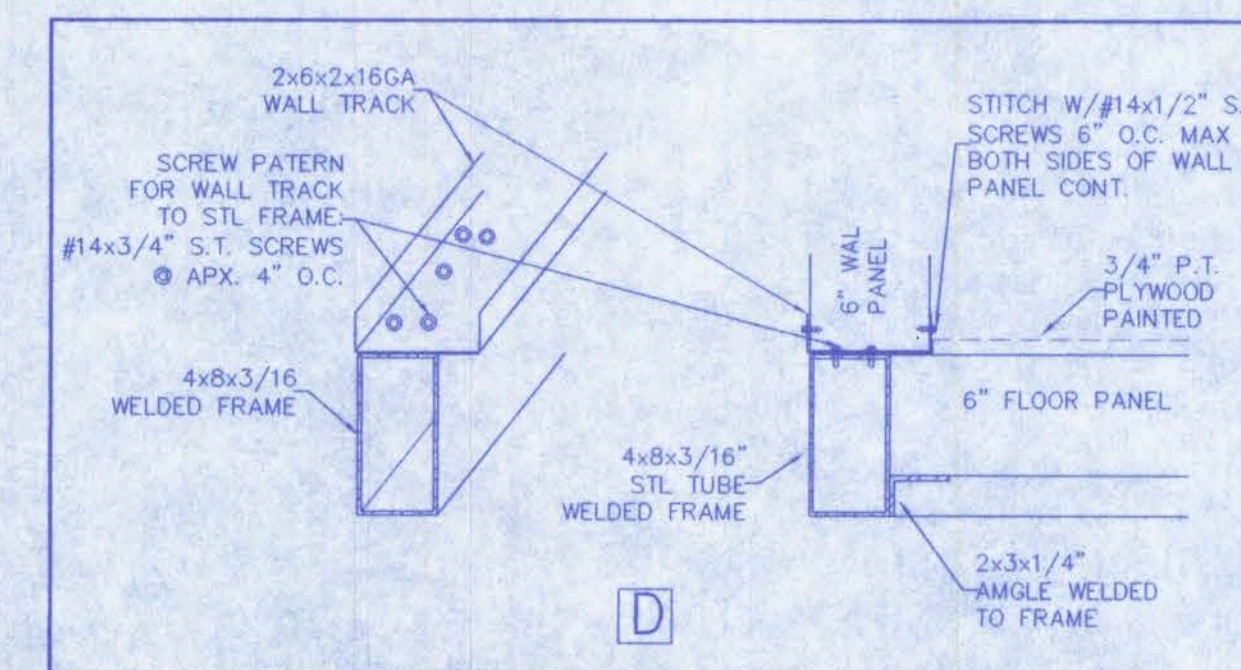


6" FLOOR PANEL

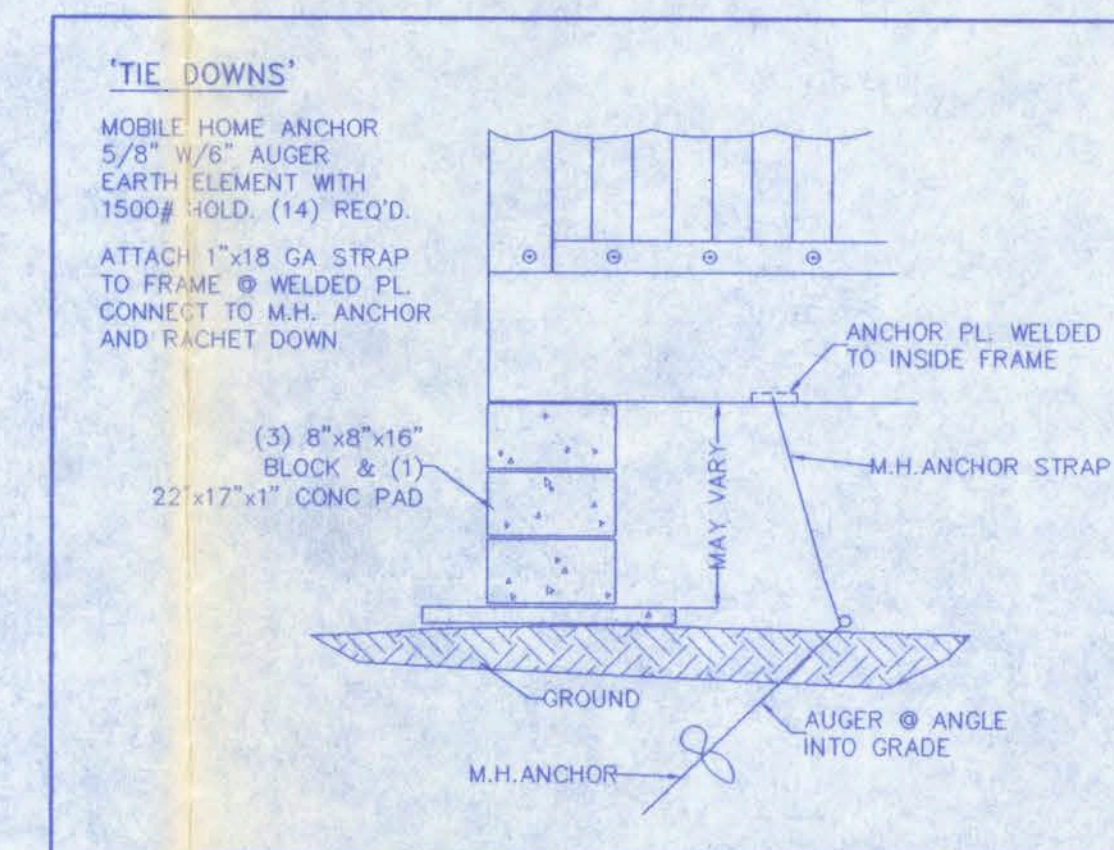


TIE DOWNS

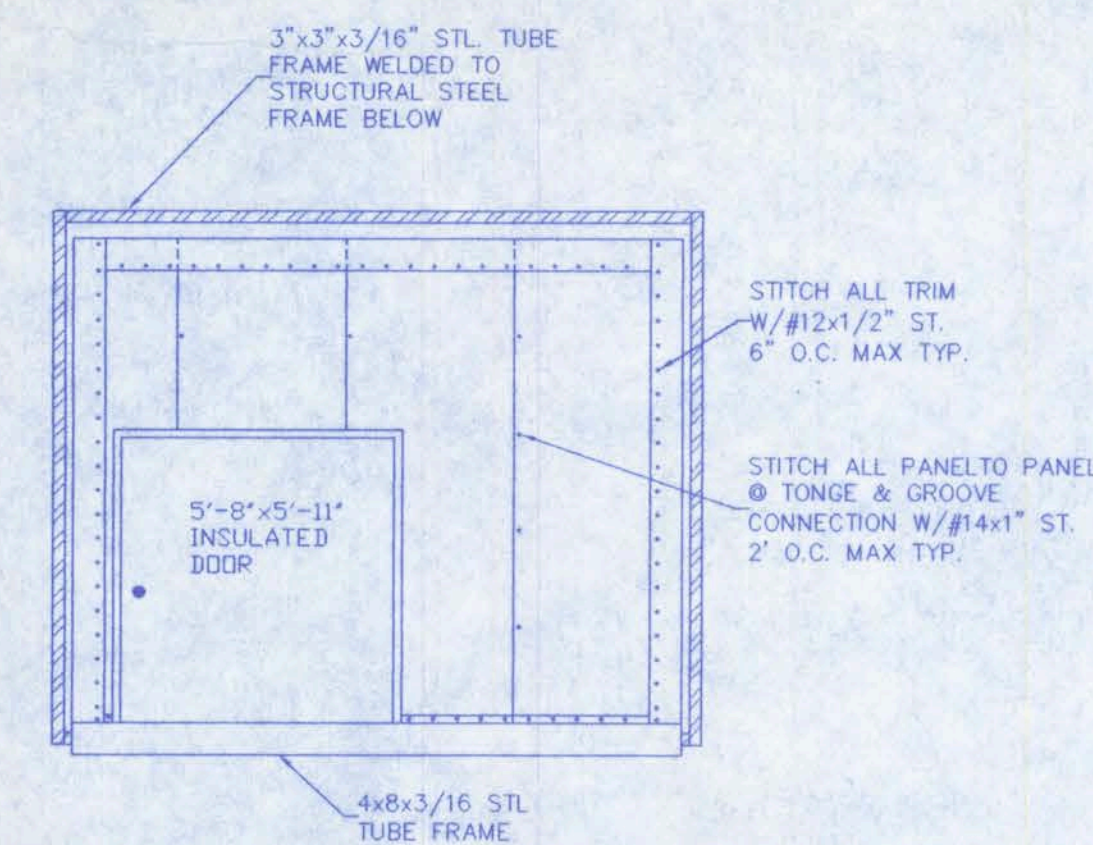


BACK ELEV. VIEW

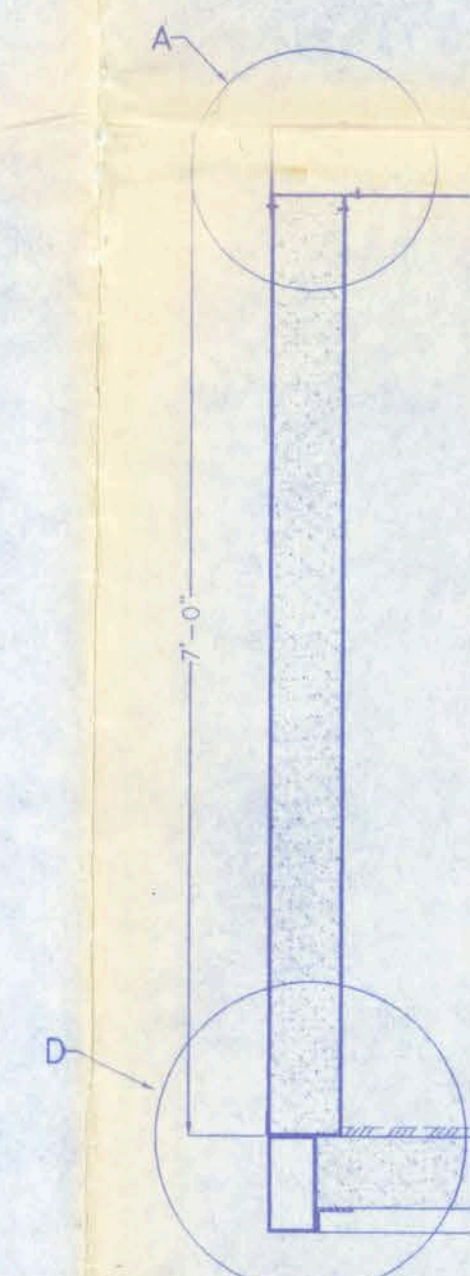


WALL SEC

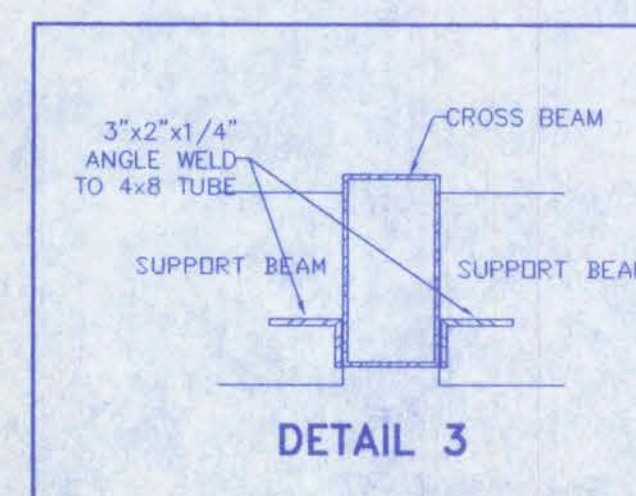

DETAIL 3

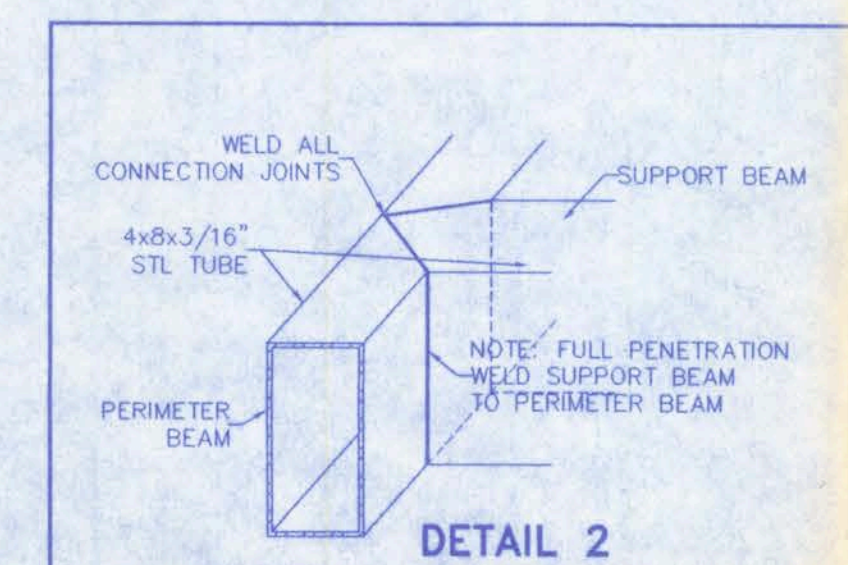

DETAIL 2

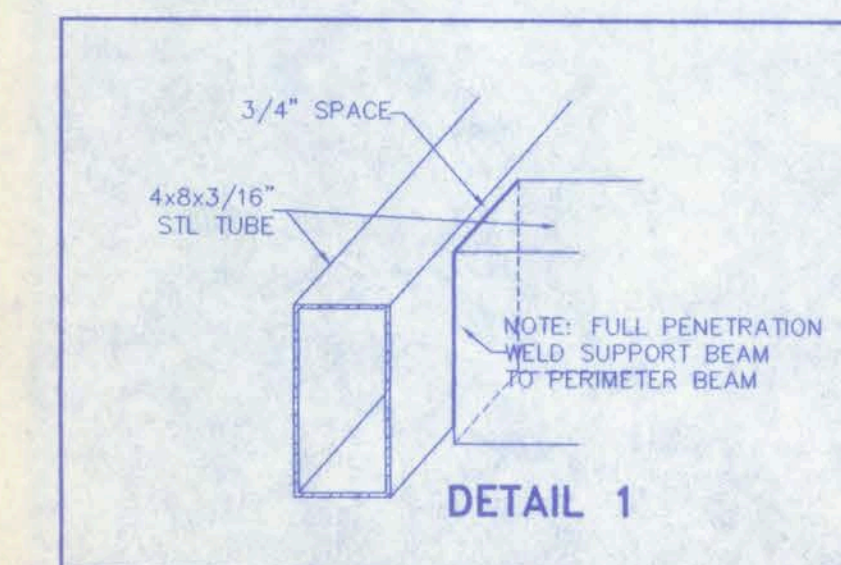

DETAIL 1

DATE: 07/05/05
SCALE: 1/4"=1'-0"

COMPUTER SERVICES BY
AUTO CAD TECHNICAL SERVICES
SHIRLEY CRISP
LEESBURG, FL 34748
FAX (352) 365-1785

ENGINEER: J.A.W. DAVIS, RPE
P.O. BOX 720 WEBSTER, FL 33597

FLOOR PLAN & DTLS
CARNIVAL ICE HOUSE
353 SW GREENRIDGE
LAKE CITY, FL 32025

See permit # Columbia County number 23465 for Stamped Version

1330 S.W. Main Blvd
32025

