



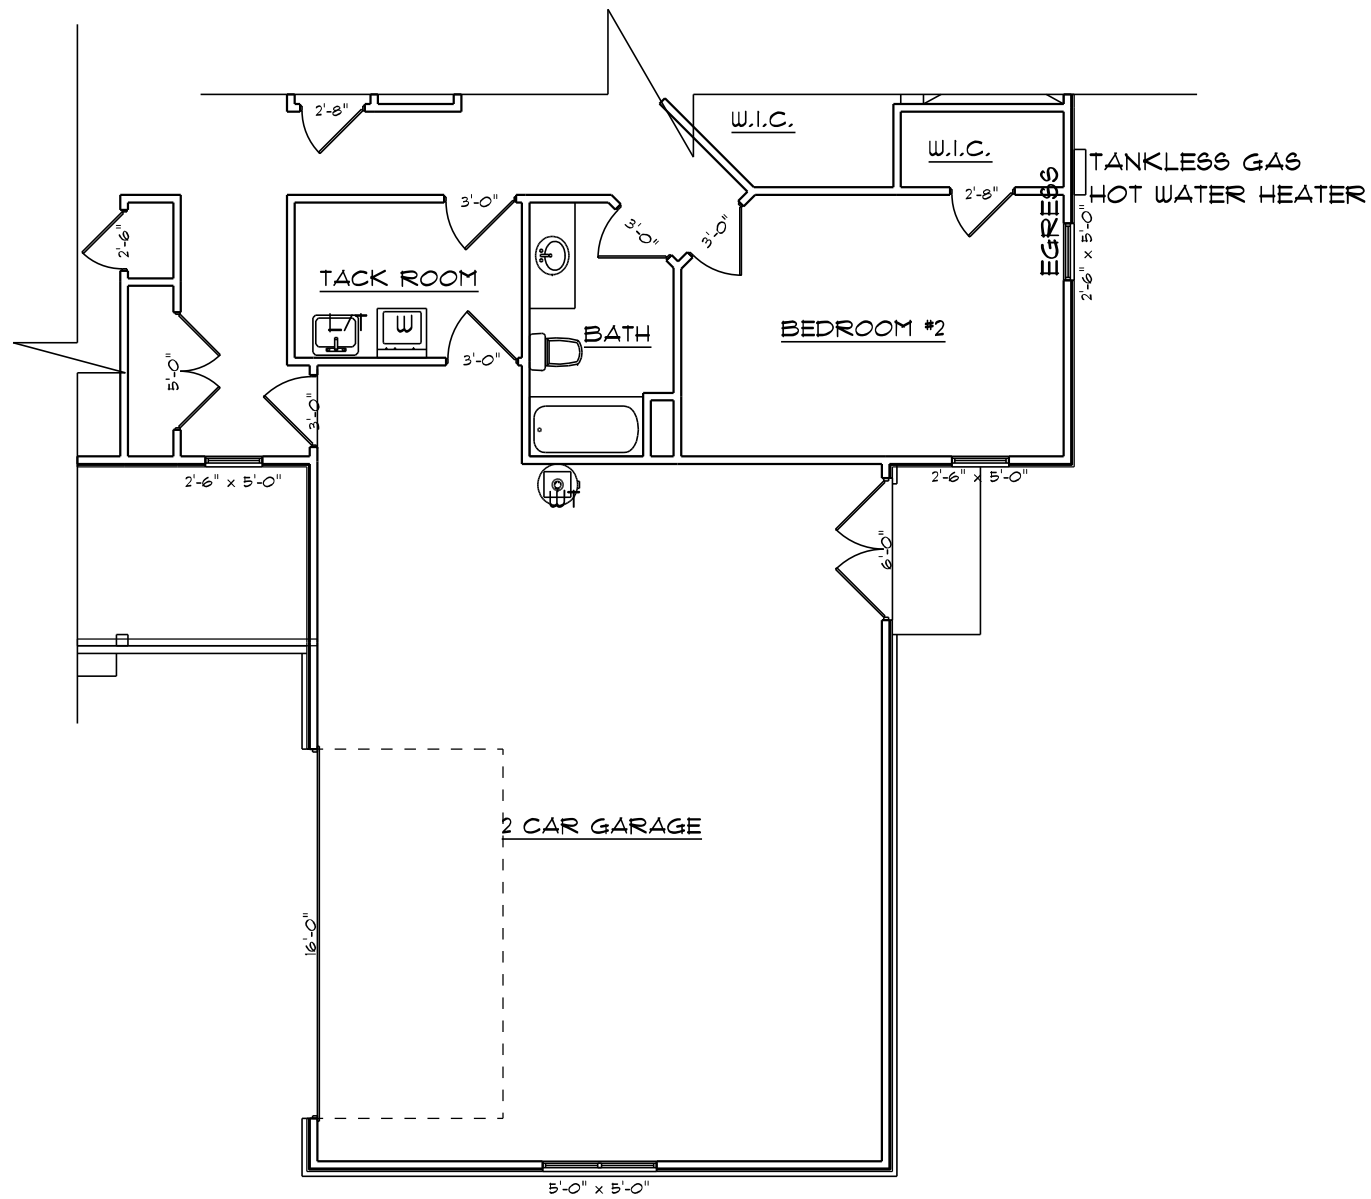

* EXISTING PARTIAL *

* FLOOR PLAN *

SCALE: 1/4" = 1'-0"

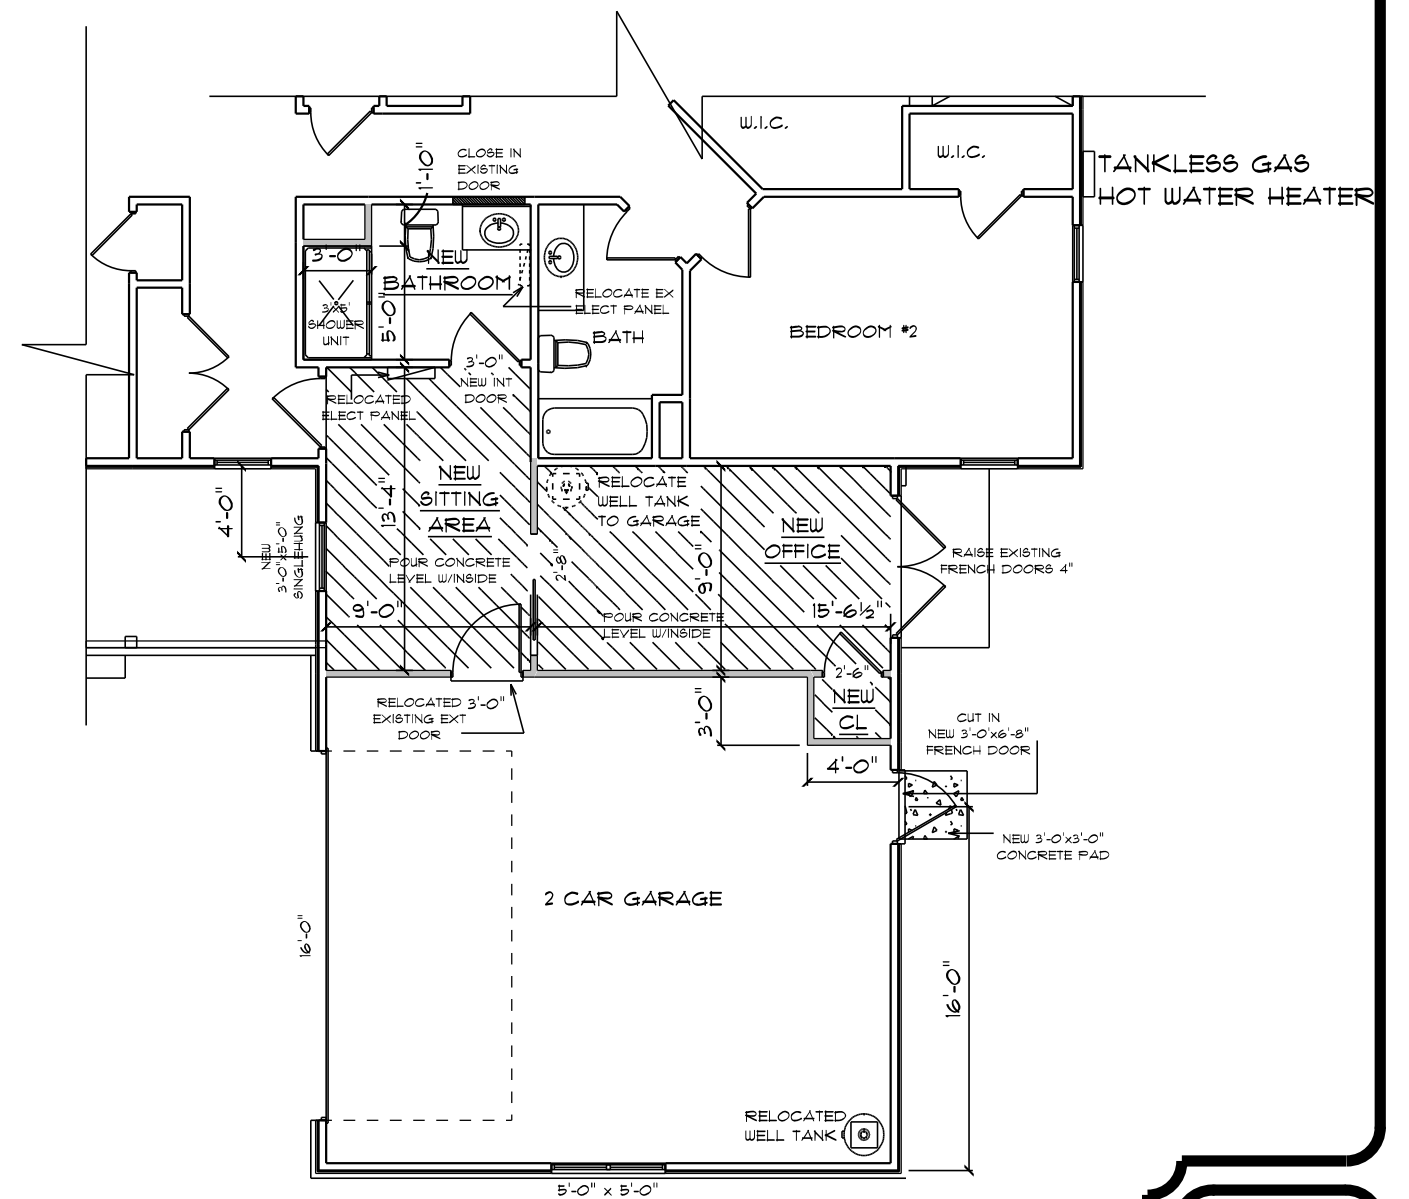

* PROPOSED PARTIAL *

* FLOOR PLAN *

SCALE: 1/4" = 1'-0"

GENERAL NOTES:
1. INSULATE WALLS & CEILING
2. DRYWALL/TRIM & PAINT
3. ALL TILE FLOORING

REMODEL
for
MIKE RADWAN

1134 SW CUSTOM MADE CR
LAKE CITY, FLORIDA

Teana M. Ruffo
2825 SW SR 41
Lake City Florida, 32025
Cell: (386) 861-1191
Email: teanaruffo@gmail.com

PRINTED DATE:
Monday, February 22, 2021

DRAWN BY: Teana M. Ruffo CHECKED BY:

BUILDING CONTRACTOR
BRYAN ZECHER

FINALS DATE:


JOB NUMBER:

DRAWING NUMBER

A-1

OF 2 SHEETS

ELECTRICAL LEGEND		
ELECTRICAL	COUNT	SYMBOL
ceiling fan globe 01	2	
exterior light 03	1	
vanity bar light	1	
outlet	6	
outlet gfi	2	
switch	7	
switch 3 way	2	
vent light combo	1	

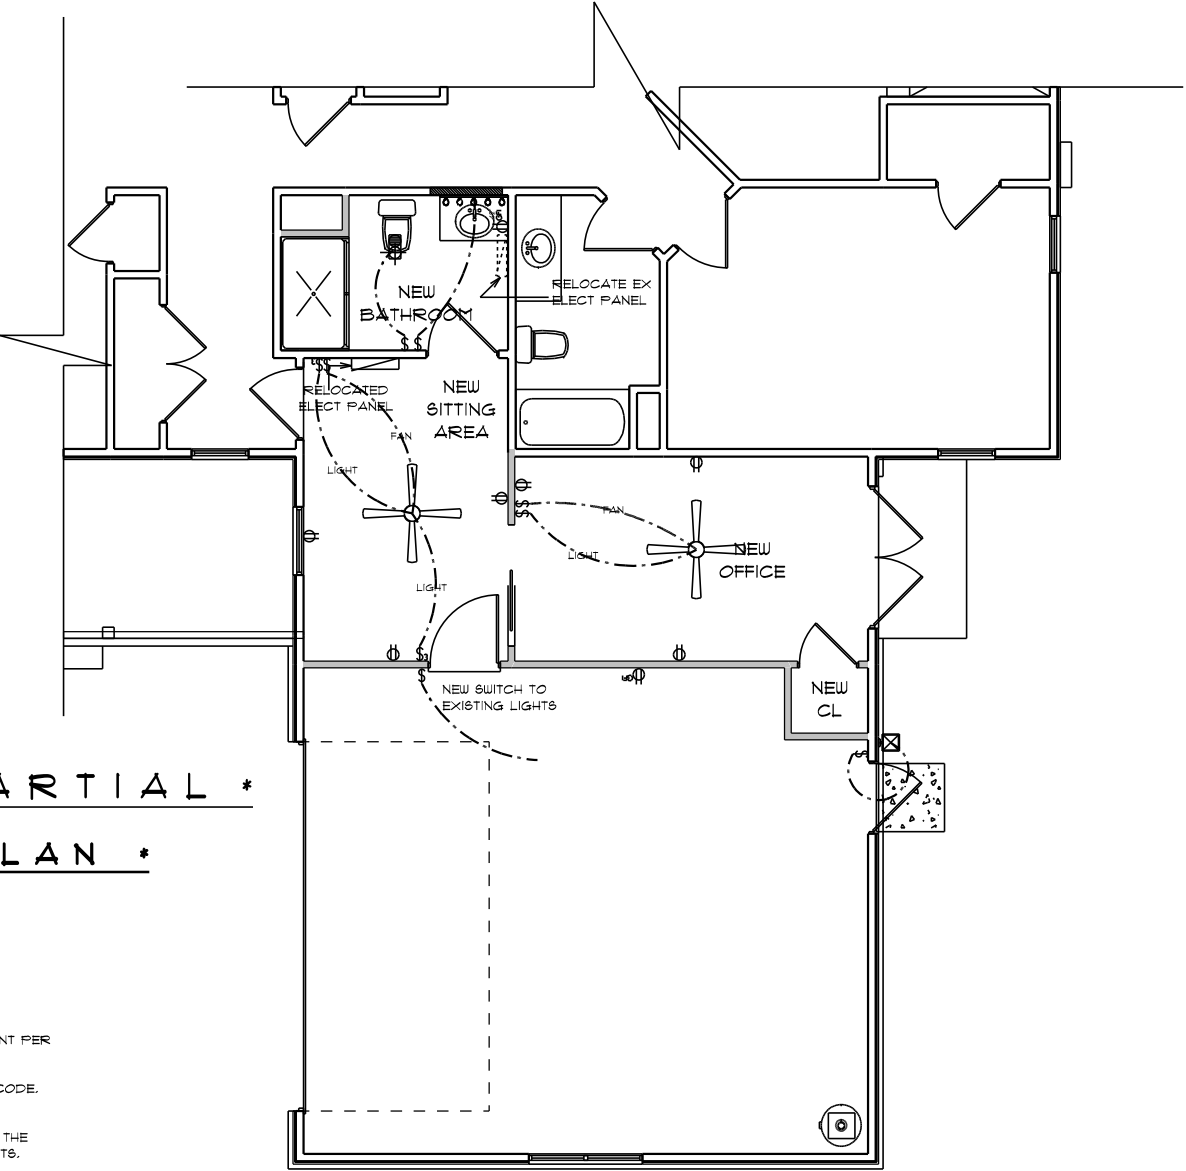

* PROPOSED PARTIAL *

* ELECTRICAL PLAN *

SCALE: 1/4" = 1'-0"

ELECTRICAL PLAN NOTES

- E-1 WIRE ALL APPLIANCES, HVAC UNITS AND OTHER EQUIPMENT PER MANUFACTURER'S SPECIFICATIONS.
- E-2 ALL INSTALLATIONS SHALL BE PER NATIONAL ELECTRIC CODE.
- E-3 ELECTRICAL CONTRACTOR SHALL BE RESPONSIBLE FOR THE DESIGN AND SIZING OF ELECTRICAL SERVICE AND CIRCUITS.

REMODEL
for
MIKE RADWAN

1134 SW CUSTOM MADE CR
LAKE CITY, FLORIDA

Teana M. Ruffo
2825 SW SR 41
Lake City Florida, 32025
Cell: (386) 861 - 1191
Email: teanaruffo@gmail.com

PRINTED DATE:
Monday, February 22, 2021

DRAWN BY: Teana M. Ruffo CHECKED BY:

BUILDING CONTRACTOR
BRYAN ZECHER

FINALS DATE:

JOB NUMBER:

DRAWING NUMBER

A-2
OF 2 SHEETS