


UNFINISHED
STORAGE
ELECTRICAL PLAN

POWER SUPPLY DISCONNECT
POWER SUPPLIED FROM EXISTING
BUILDING

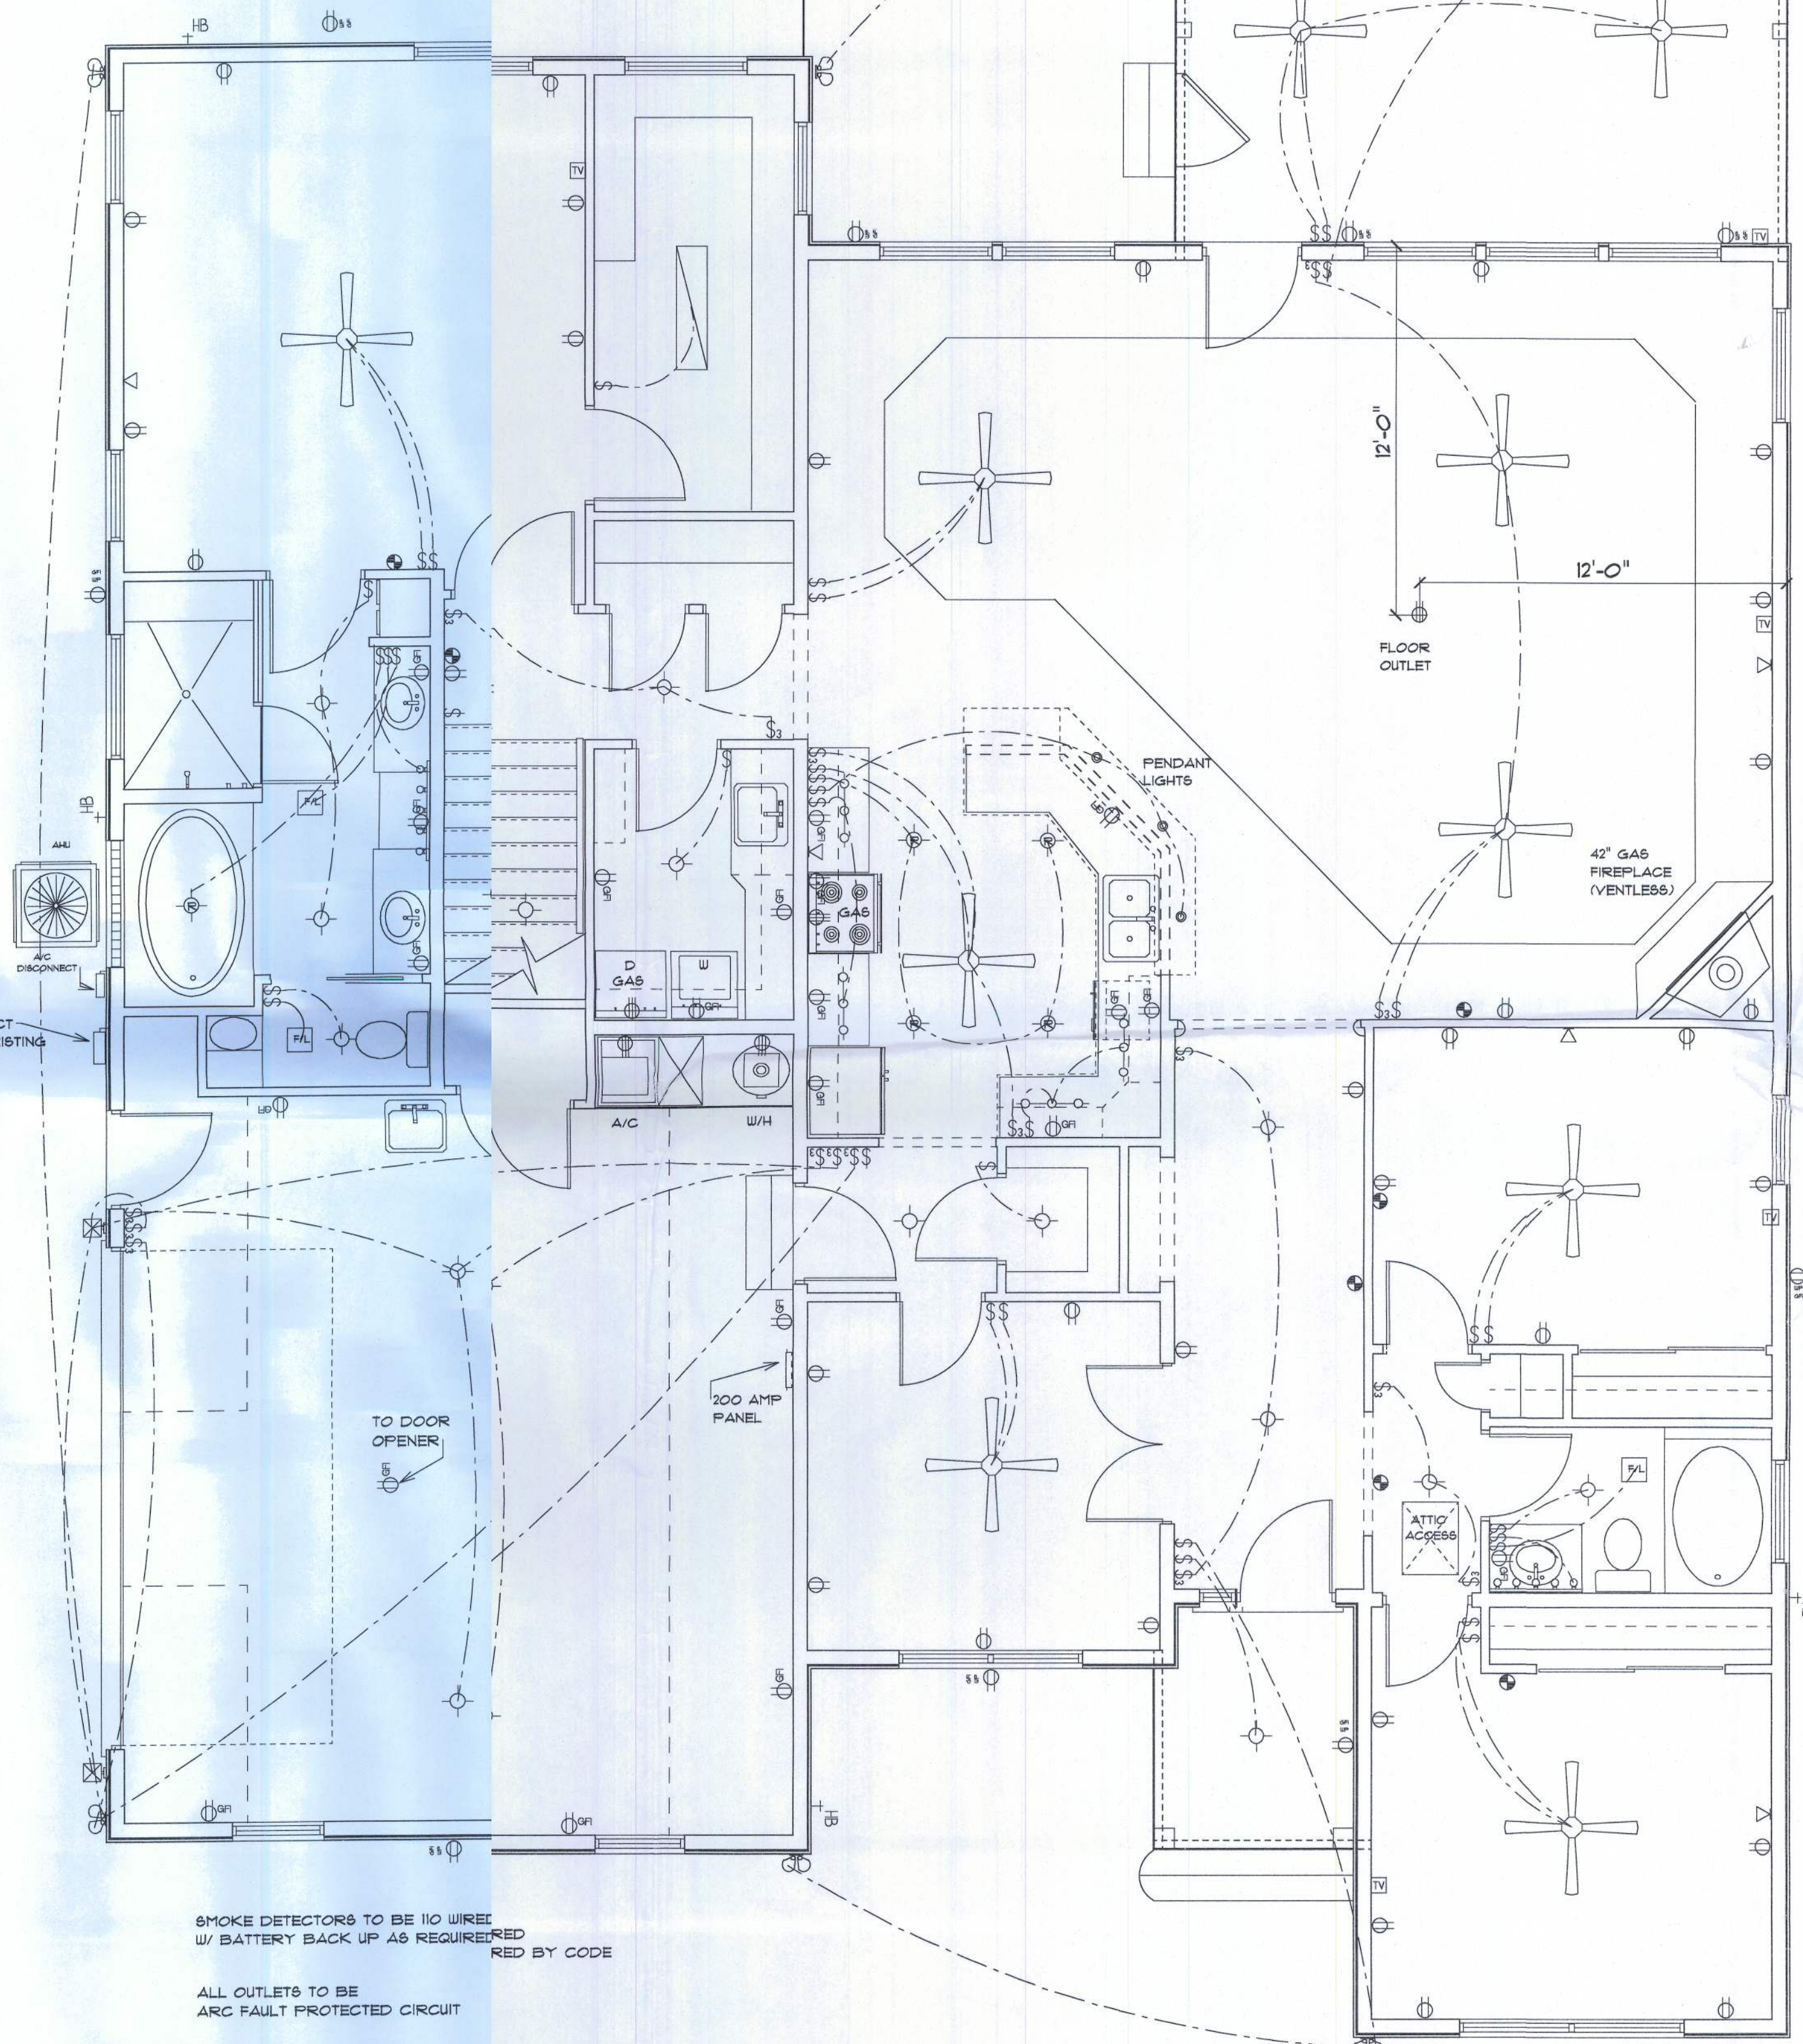

SMOKE DETECTORS TO BE 110 WIRE
W/ BATTERY BACK UP AS REQUIRED
RED BY CODE

ALL OUTLETS TO BE
ARC FAULT PROTECTED CIRCUIT

ALL EXTERIOR OUTLETS
TO BE WATERPROOF GFI

ALL RECEPTACLES
NEAR WATER TO
BE GFI

PHONE AND TV
OUTLETS PER
OWNERS

ELECTRICAL PLAN

ELECTRIC PLAN IS A SUGGESTED LOCATION
FOR SWITCHES PLUGS AND LIGHTS
IT IS THE OWNER AND OR THE
CONTRACTORS RESPONSIBILITY
TO FOLLOW ALL STATE AND LOCAL CODES.

ELECTRICAL	SYMBOL
ceiling fan	
exterior light 2	
double spotlight	
fluorescent fixture	
pendant light	
vanity bar light	
electrical panel	
A-C Disconnect	
power Disconnect	
under cabinet light	
Exhaust Fan-Light	
Heat Pump	
Recess Light	
WaterProof-GFI	
cable tv outlet	
light	
outlet	
outlet 220v	
outlet gfi	
smoke detector	
switch	
switch 3 way	
telephone	

SCALE 1/4" = 1'

DESIGN BY P.A.C.

O'NEIL
CONSTRUCTION

COLACINO
DRAFTING&DESIGN
PH. 352-472-3462

DATE 6/7/11

REVISED 6/13/11

REVISED 6/20/11

NELSON RESIDENCE

5