



FIRE VALVE CABINET

7

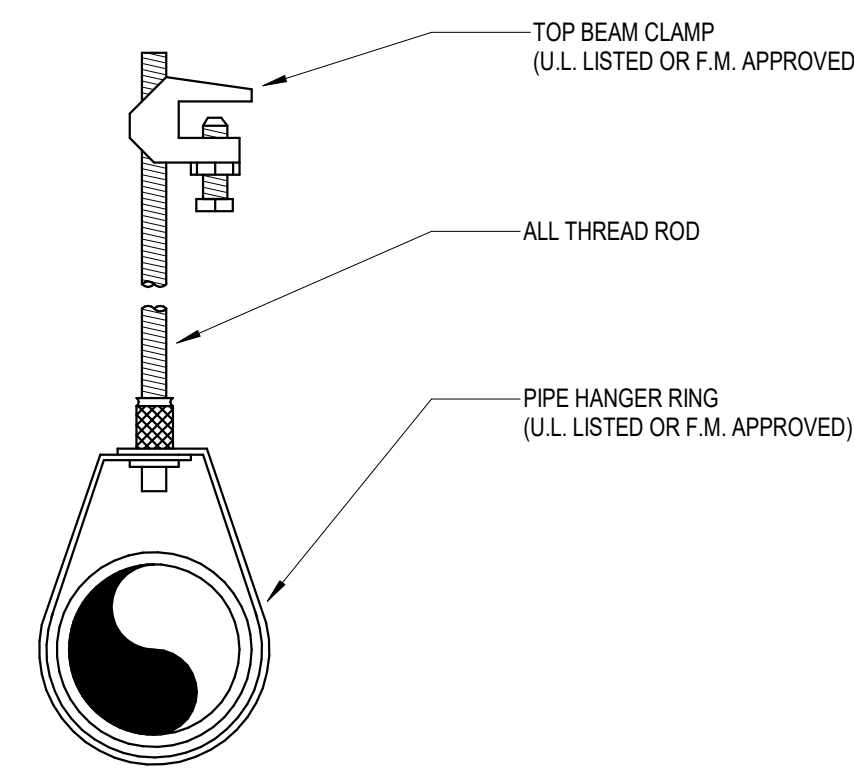


HANGER - STEEL
No Scale

4

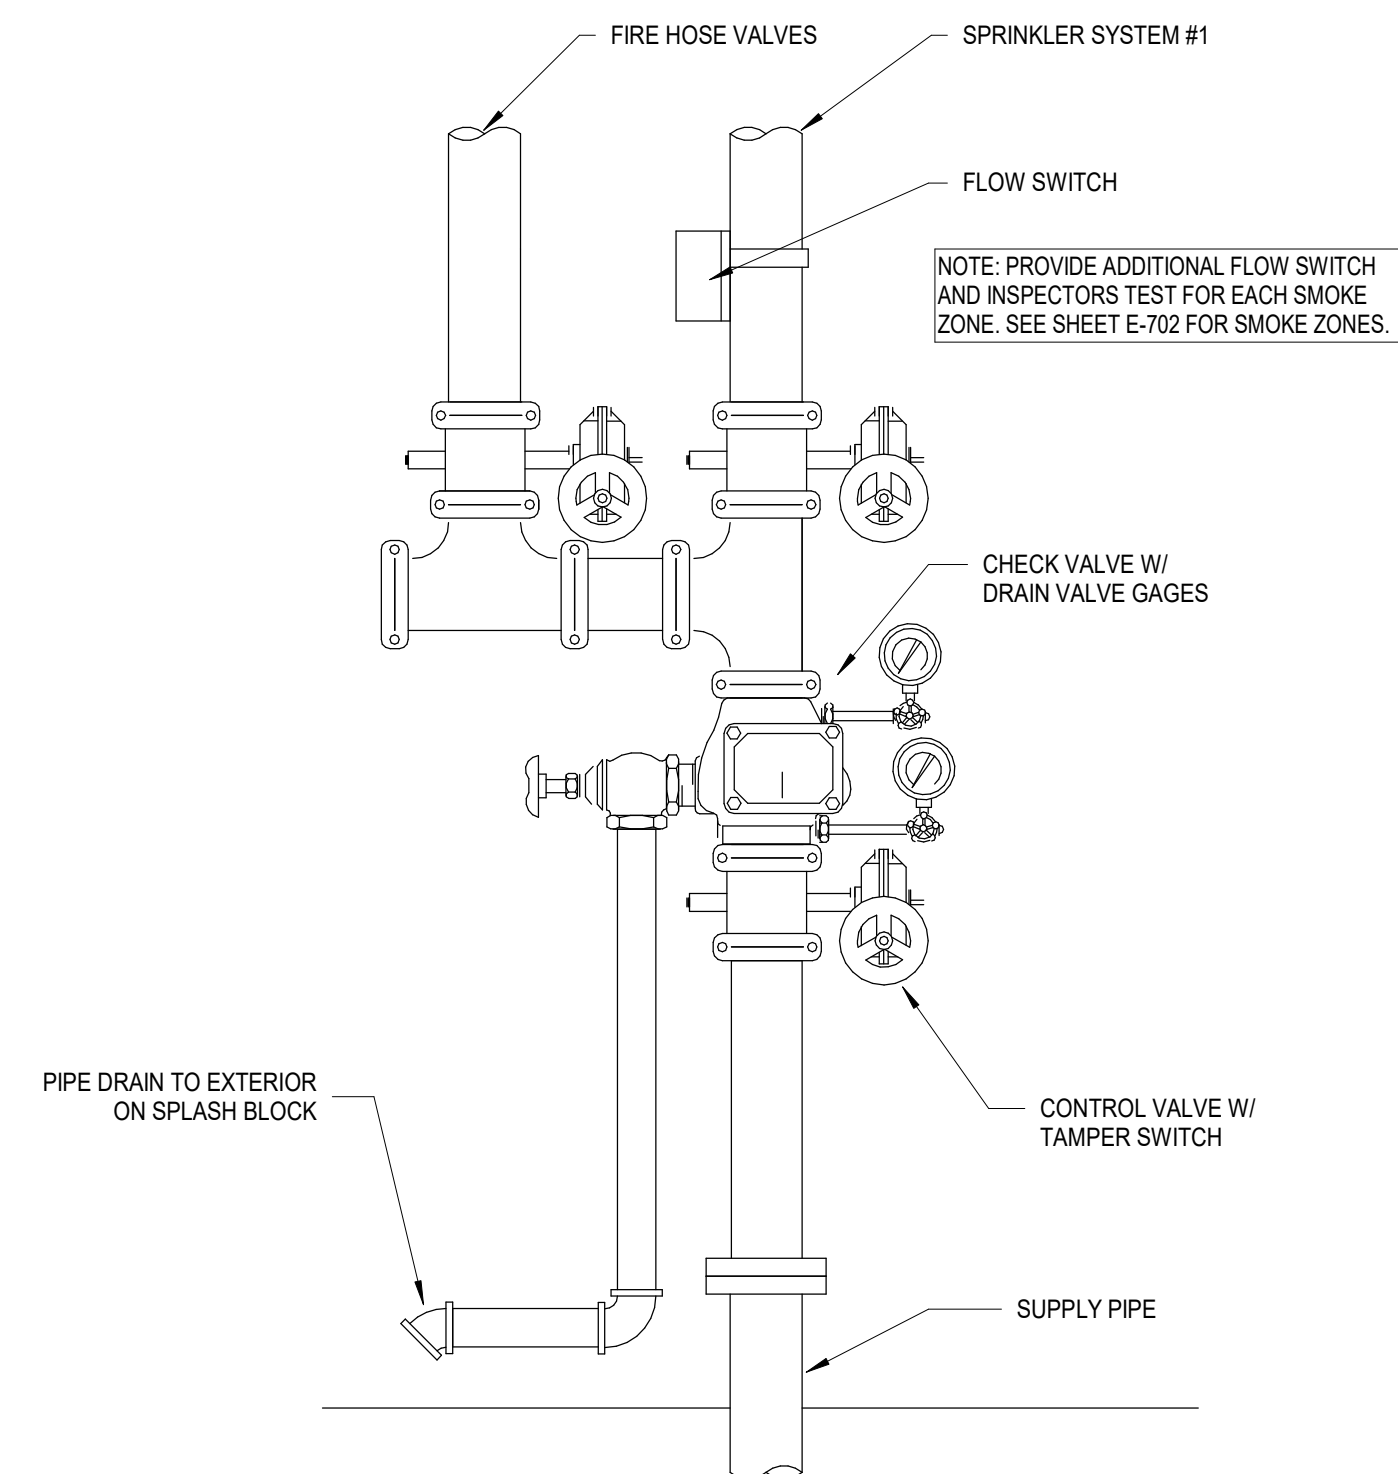

SPRINKLER RISER - WET PIPE SYSTEM


1

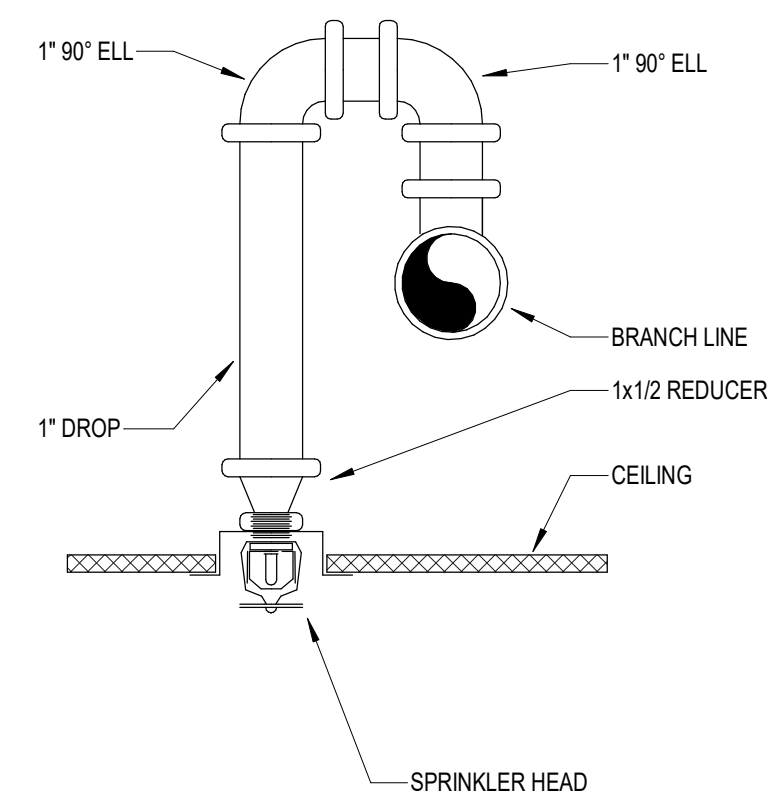

RETURN BEND


No Scale

5

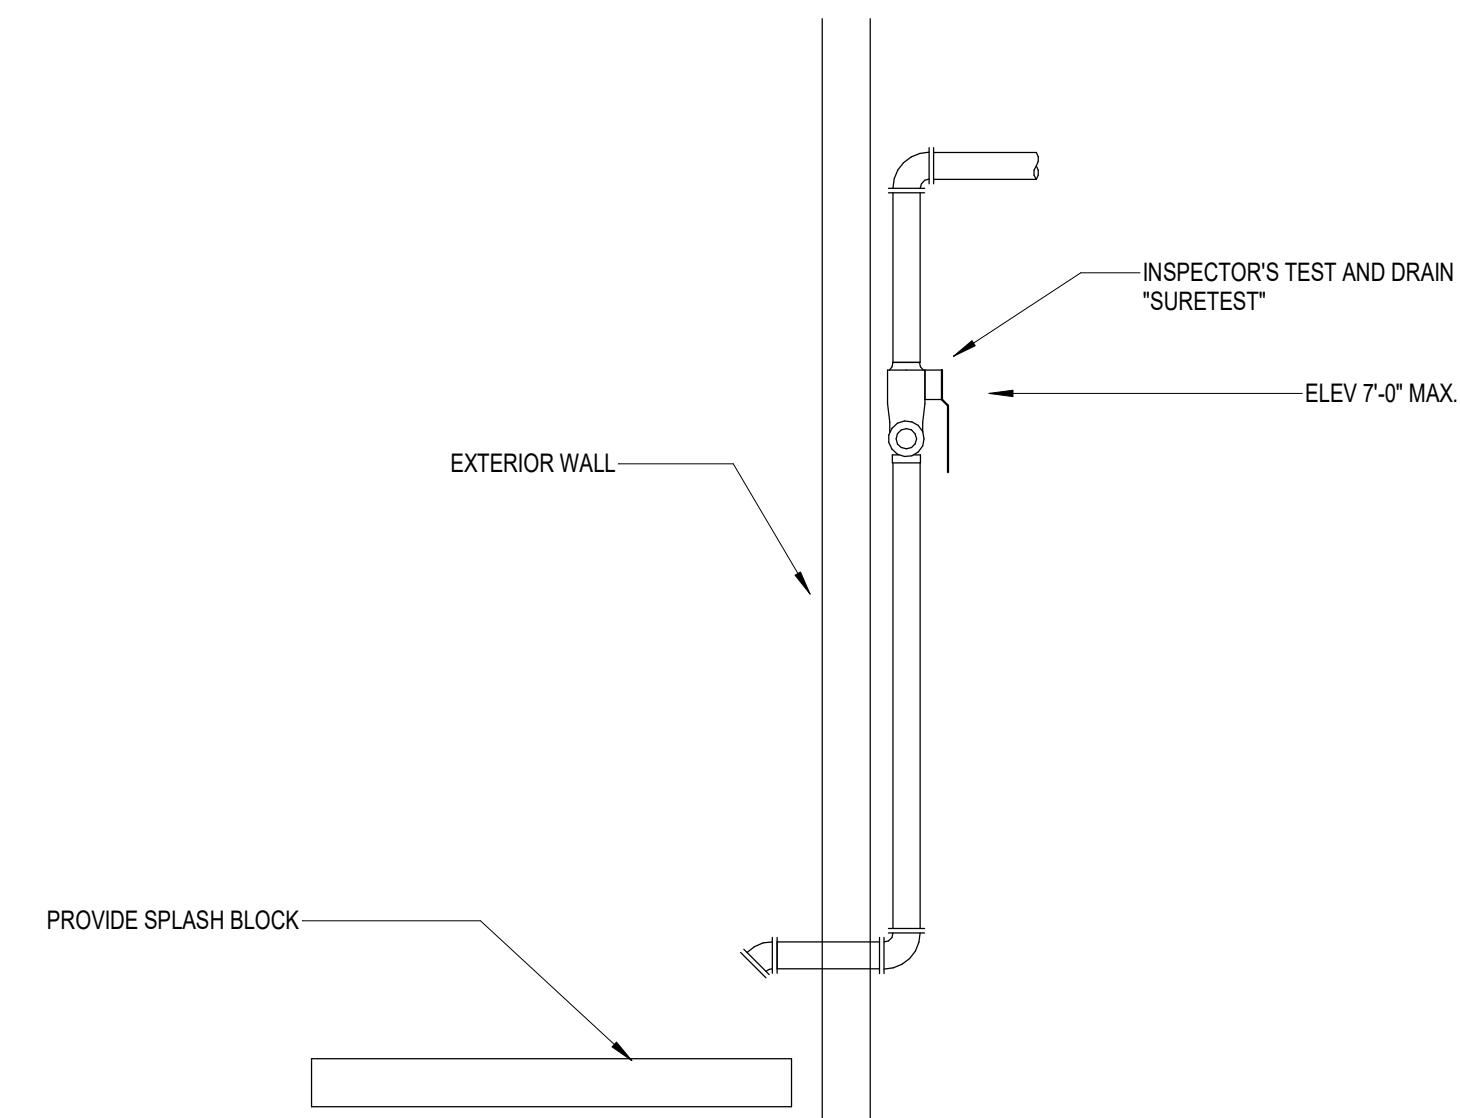


INSPECTOR'S TEST - WET PIPE SYSTEM

2

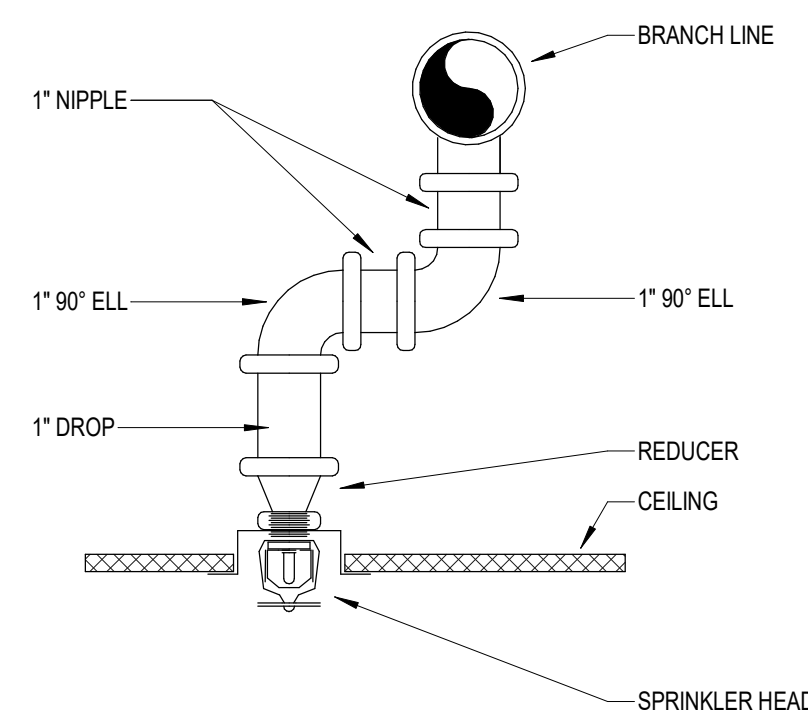


SWING JOINT

6

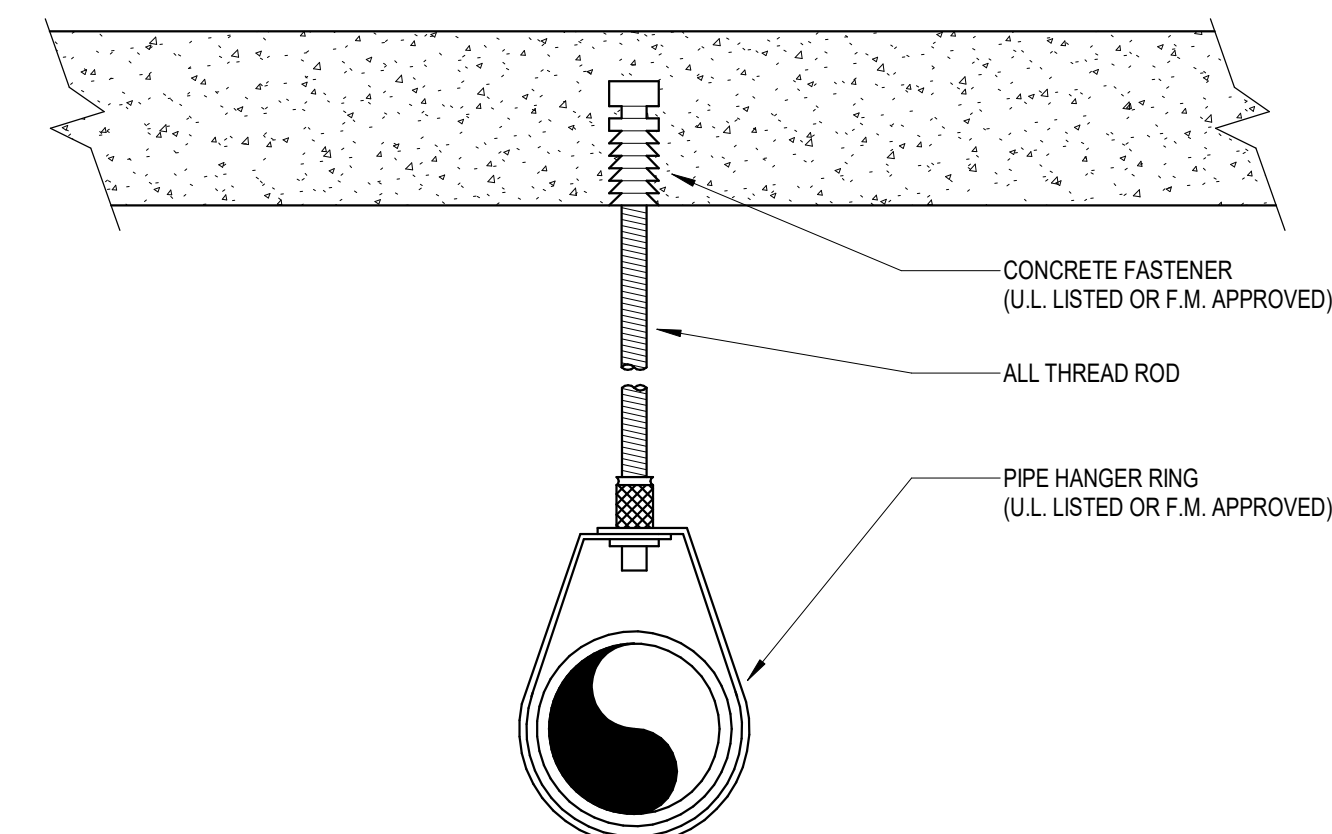

HANGER - CONCRETE

3


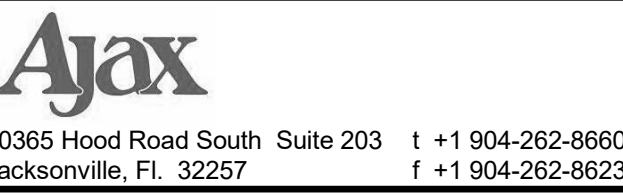


Professional Seals

Christopher J. Floegel, P.E.
State of Florida
Professional Engineer
License No. 84276

This item has been electronically signed and sealed by the individual named above, using a dated Digital Signature in the space below, per F.A.C. Rule 61G15-23.004. Printed copies of this document are not considered signed and sealed, and the signature must be verified on any electronic copies.

Christopher Floegel
Digitally signed by Christopher Floegel
DN: cn=Christopher Floegel,
ou=405418000000000A76F20000H,
o=FLC ENGINEERING SOLUTIONS, c=US
Date: 2020.07.23 09:22:05 -0400

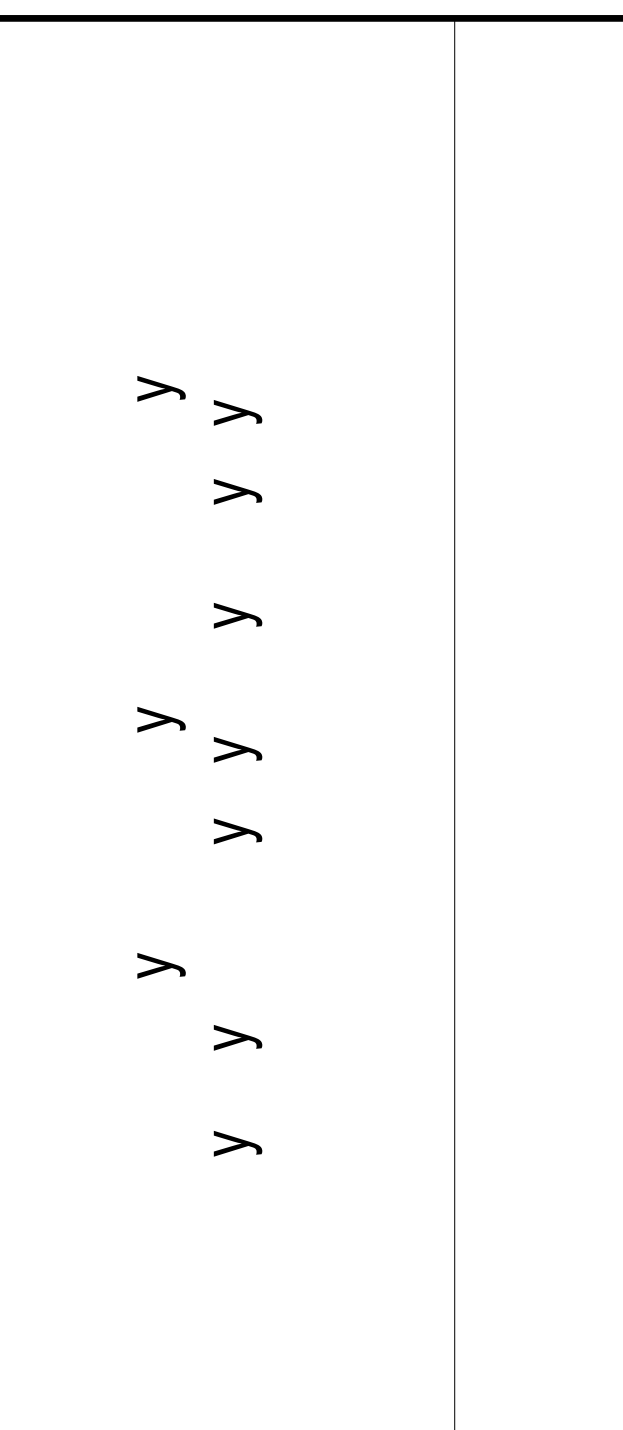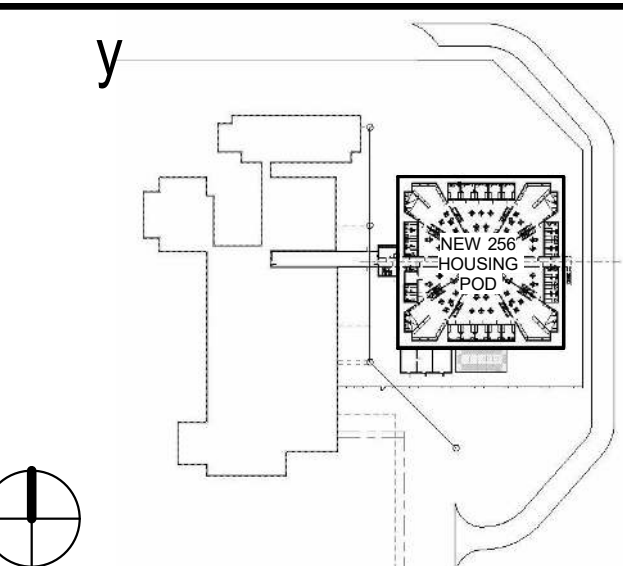

SCALE As indicated

[illegible]

REVISIONS

DRAWN BY	D PETERSON
APPROVED BY	F ROBERTSON
CHECKED BY	F GARDNER
DATE	JULY 24, 2020

TITLE

FIRE PROTECTION DETAILS

PROJECT NO.	50101397
-------------	----------

FP-701

SHEET NO.

DESTROY AFTER USE