



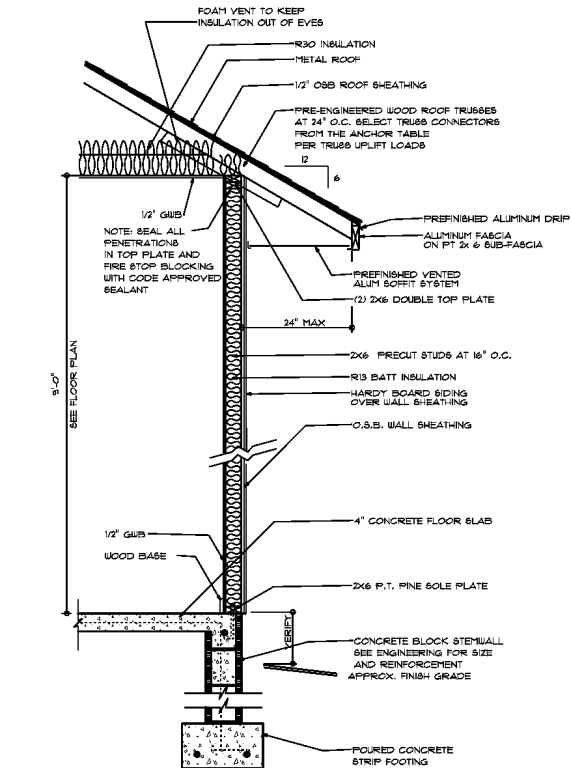

TYPICAL DESIGN WALL SECTION
NON - STRUCTURAL DATA

N.T.S.

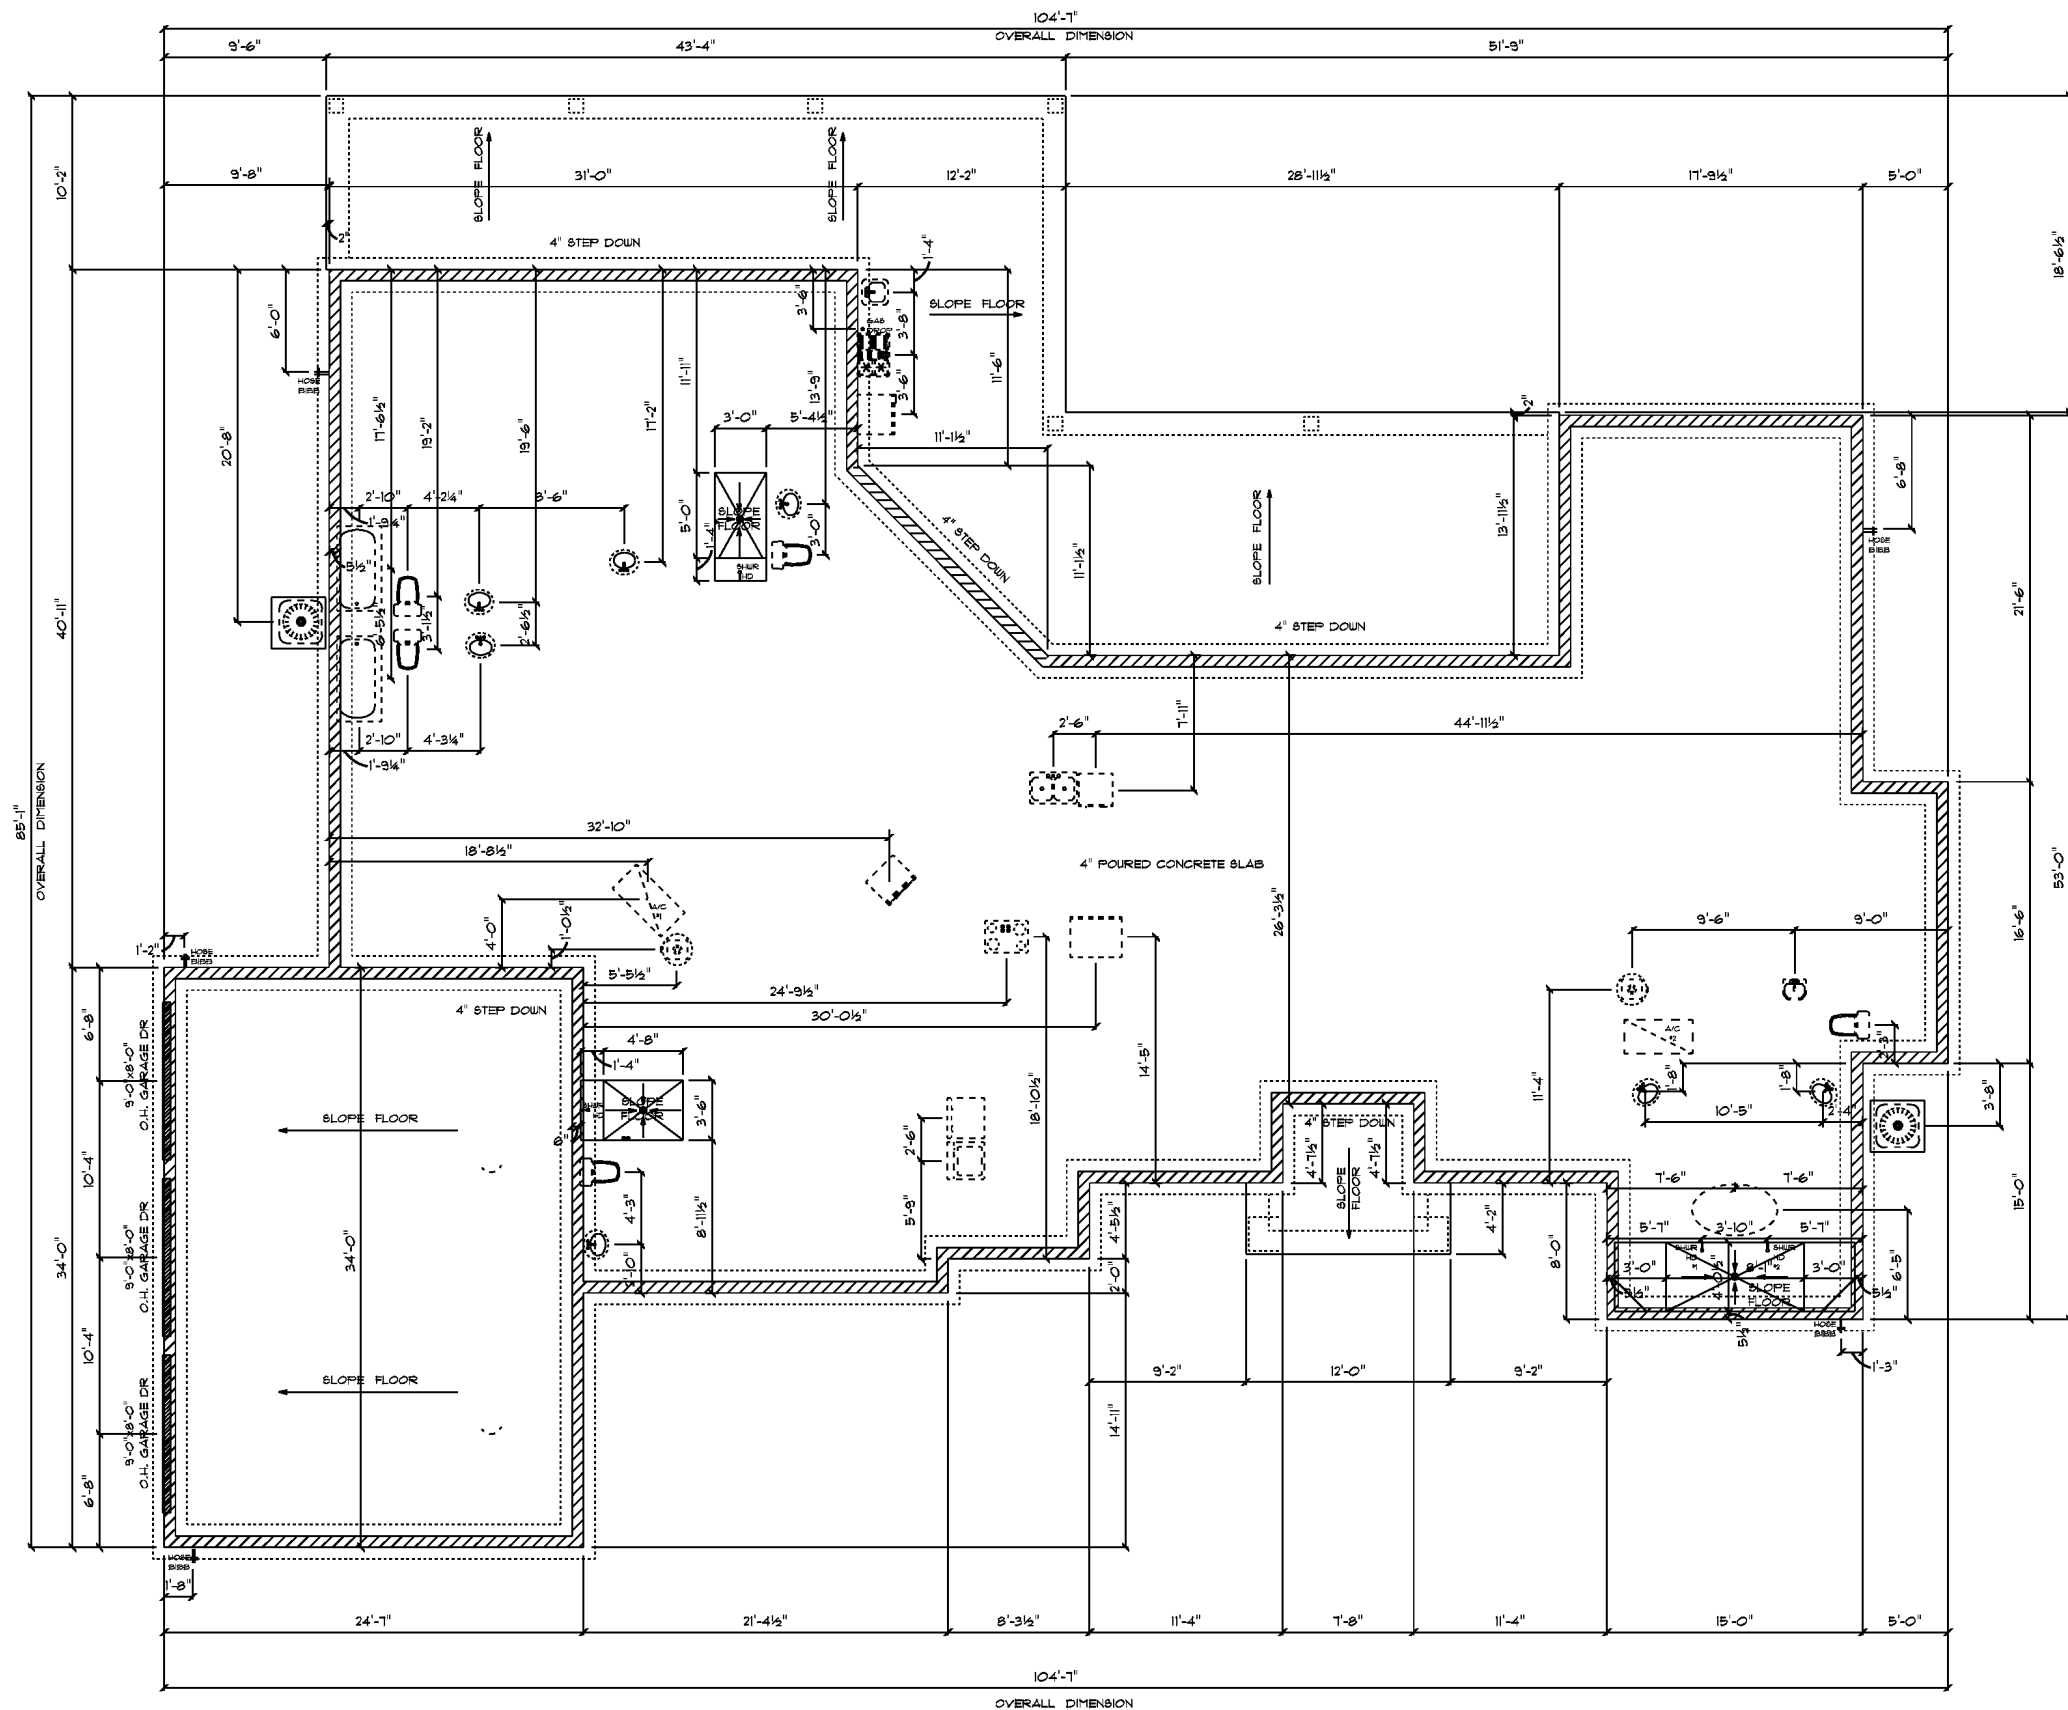

- IMPORTANT NOTES:
1. IT IS THE BUILDERS RESPONSIBILITY TO VERIFY ALL GEOMETRY AND DIMENSIONS BEFORE ORDERING ANY MATERIALS OR BEGINNING CONSTRUCTION.
 2. THESE PLANS ARE FOR LAYOUT AND DESIGN PURPOSES ONLY ALL STRUCTURAL NOTES AND DETAILS TO BE PROVIDED BY AN ENGINEER.
 3. ALL EXTERIOR WALLS ARE 2X6 FRAME.
 4. ALL INTERIOR DOORS 6'-8\".

• FOUNDATION PLAN •

SCALE : 3/16" = 1'-0"

RESIDENCE
for
REINARD WILSON

LAKE CITY
FLORIDA

Teresa M. Ruffo
2825 SW 8R 47
Lake City Florida, 32025
Cell: (386) 861-1191
Email: tsernuffo@gmail.com

PRINTED DATE:
Wednesday, May 27, 2020

DRAWN BY: T.M. Ruffo

CHECKED BY:

BUILDING CONTRACTOR


FINALS DATE:

JOB NUMBER:

DRAWING NUMBER

A-2

OF 6 SHEETS

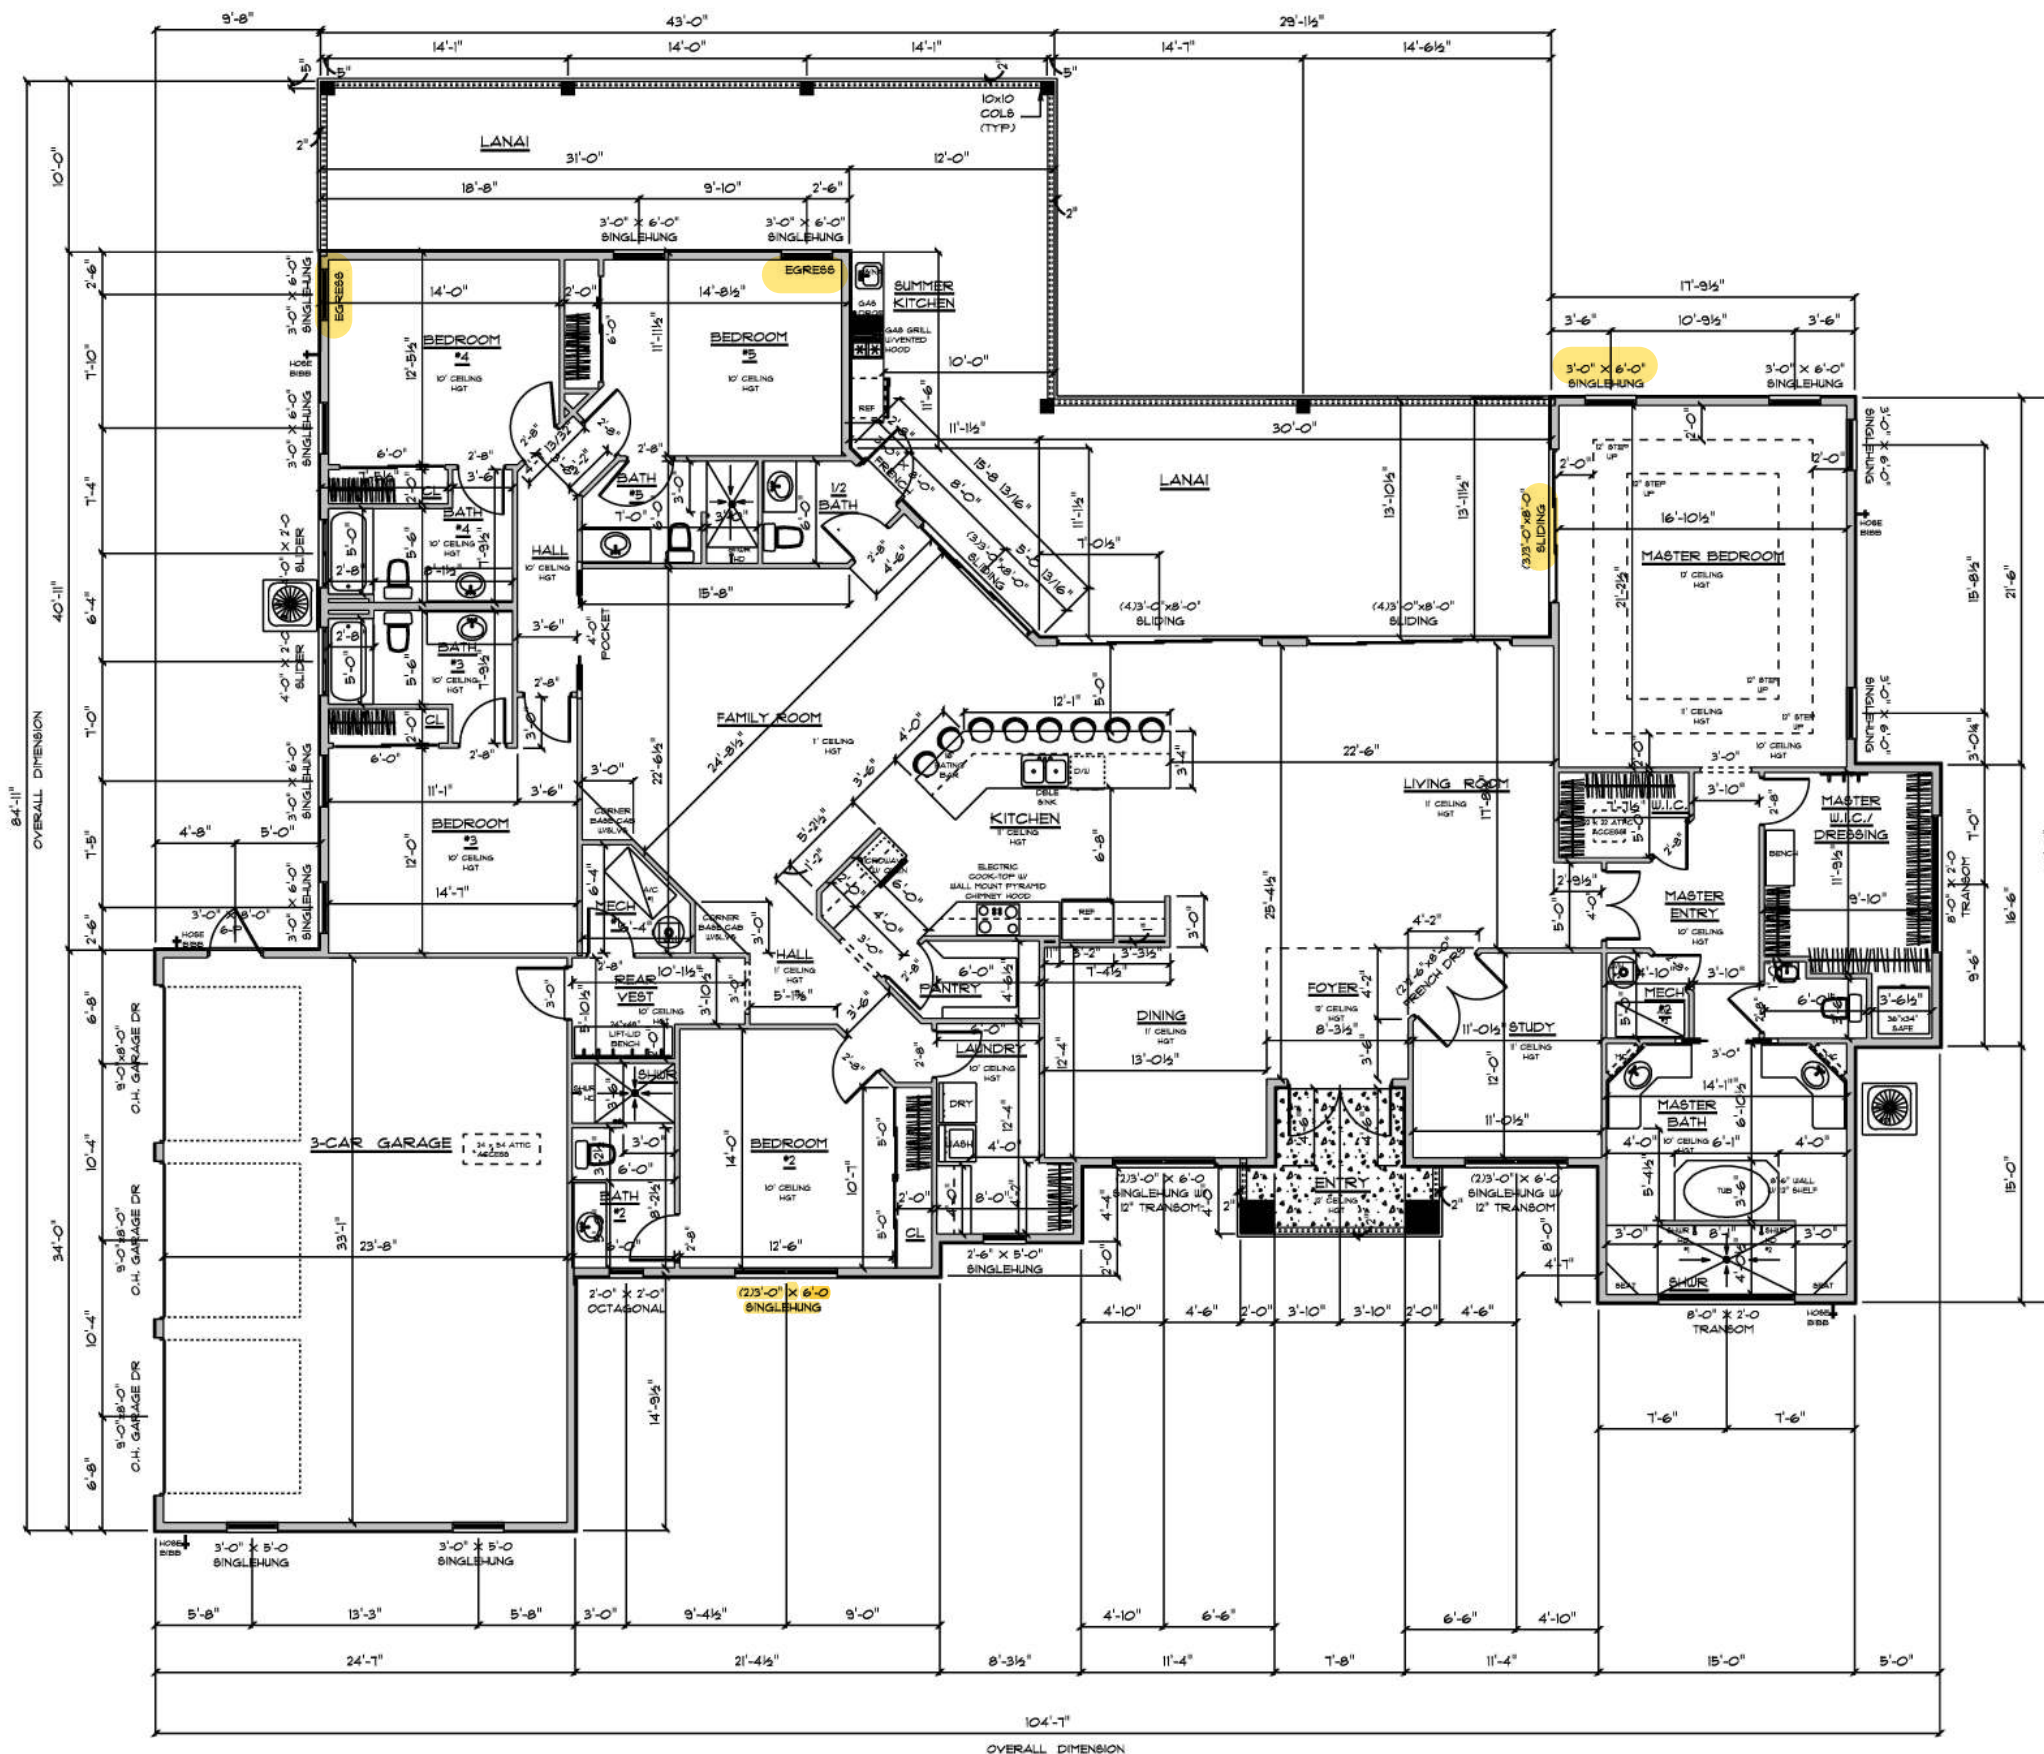

IMPORTANT NOTES:
 1. IT IS THE BUILDER'S RESPONSIBILITY TO VERIFY ALL GEOMETRY AND DIMENSIONS BEFORE ORDERING ANY MATERIALS OR BEGINNING CONSTRUCTION.
 2. THESE PLANS ARE FOR LAYOUT AND DESIGN PURPOSES ONLY. ALL STRUCTURAL NOTES AND DETAILS TO BE PROVIDED BY AN ENGINEER.
 3. ALL EXTERIOR WALLS ARE 2X6 FRAME.
 4. ALL INTERIOR DOORS 6'-0\"/>

*** FLOOR PLAN ***
 SCALE : 3/16" = 1'-0"

A/C LIVING AREA	=	3952 S.F.
ENTRY	=	82 S.F.
LANAI	=	1048 S.F.
3 CAR GARAGE	=	826 S.F.
TOTAL AREA UNDER ROOF	=	5908 S.F.

RESIDENCE
for
REINARD WILSON

LAKE CITY
FLORIDA

Teena M. Ruffo
 2925 SW 6R 41
 Lake City Florida, 32025
 Cell: (386) 861-1181
 Email: teenaruffo@gmail.com

PRINTED DATE:
 Wednesday, May 27, 2020

DRAWN BY: Teena M. Ruffo
 CHECKED BY:
 BUILDING CONTRACTOR:


FINALS DATE:

JOB NUMBER:

DRAWING NUMBER

A-3


OF 6 SHEETS

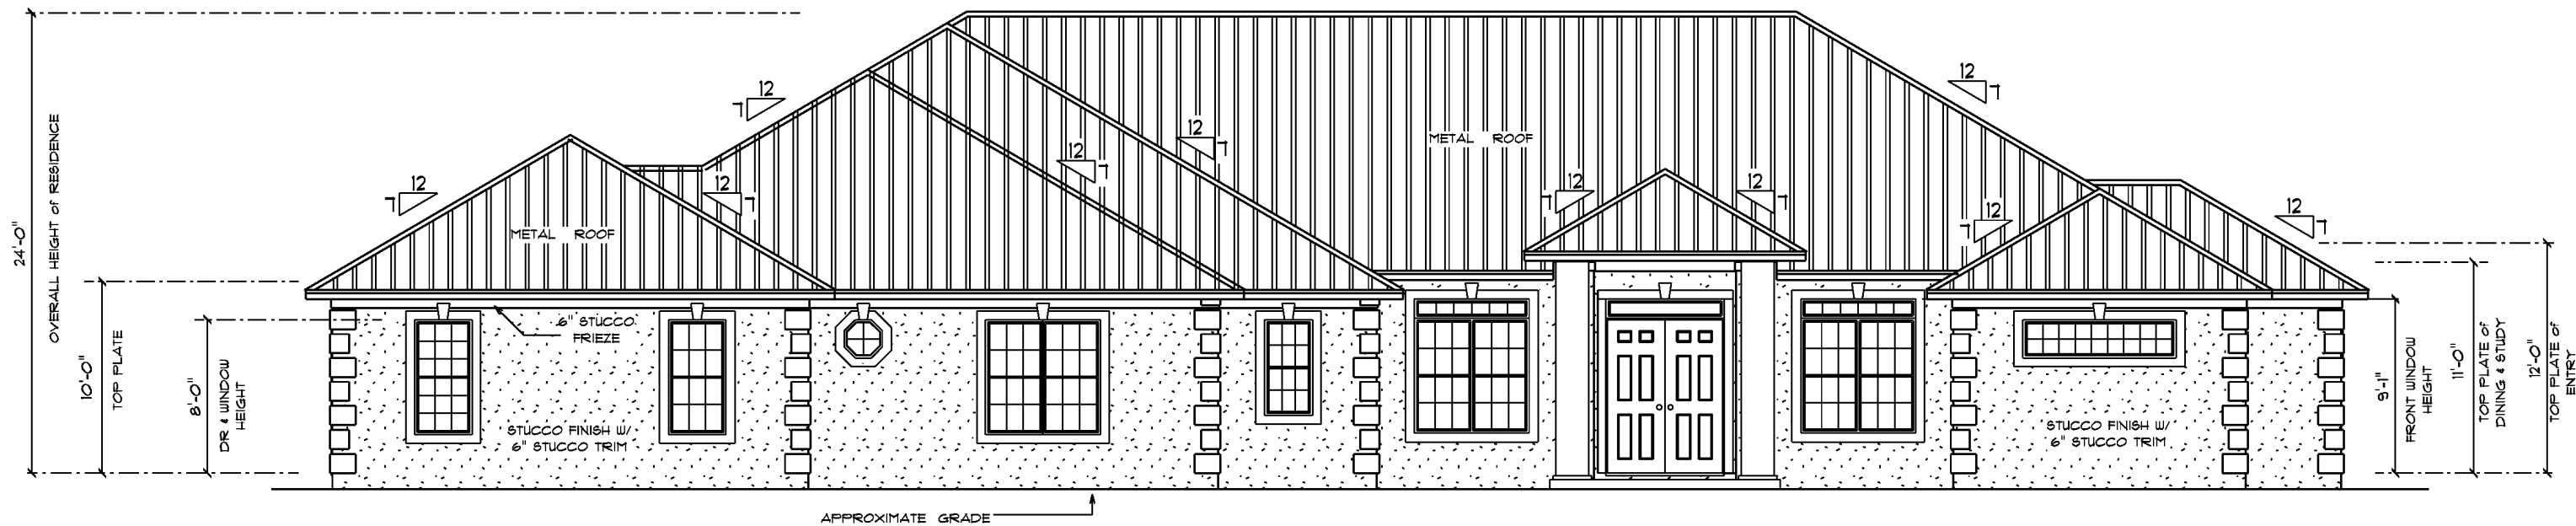

* FRONT ELEVATION *

SCALE : 1/4" = 1'-0"

NOTE :
18" OVERHANG ON ALL EAVES

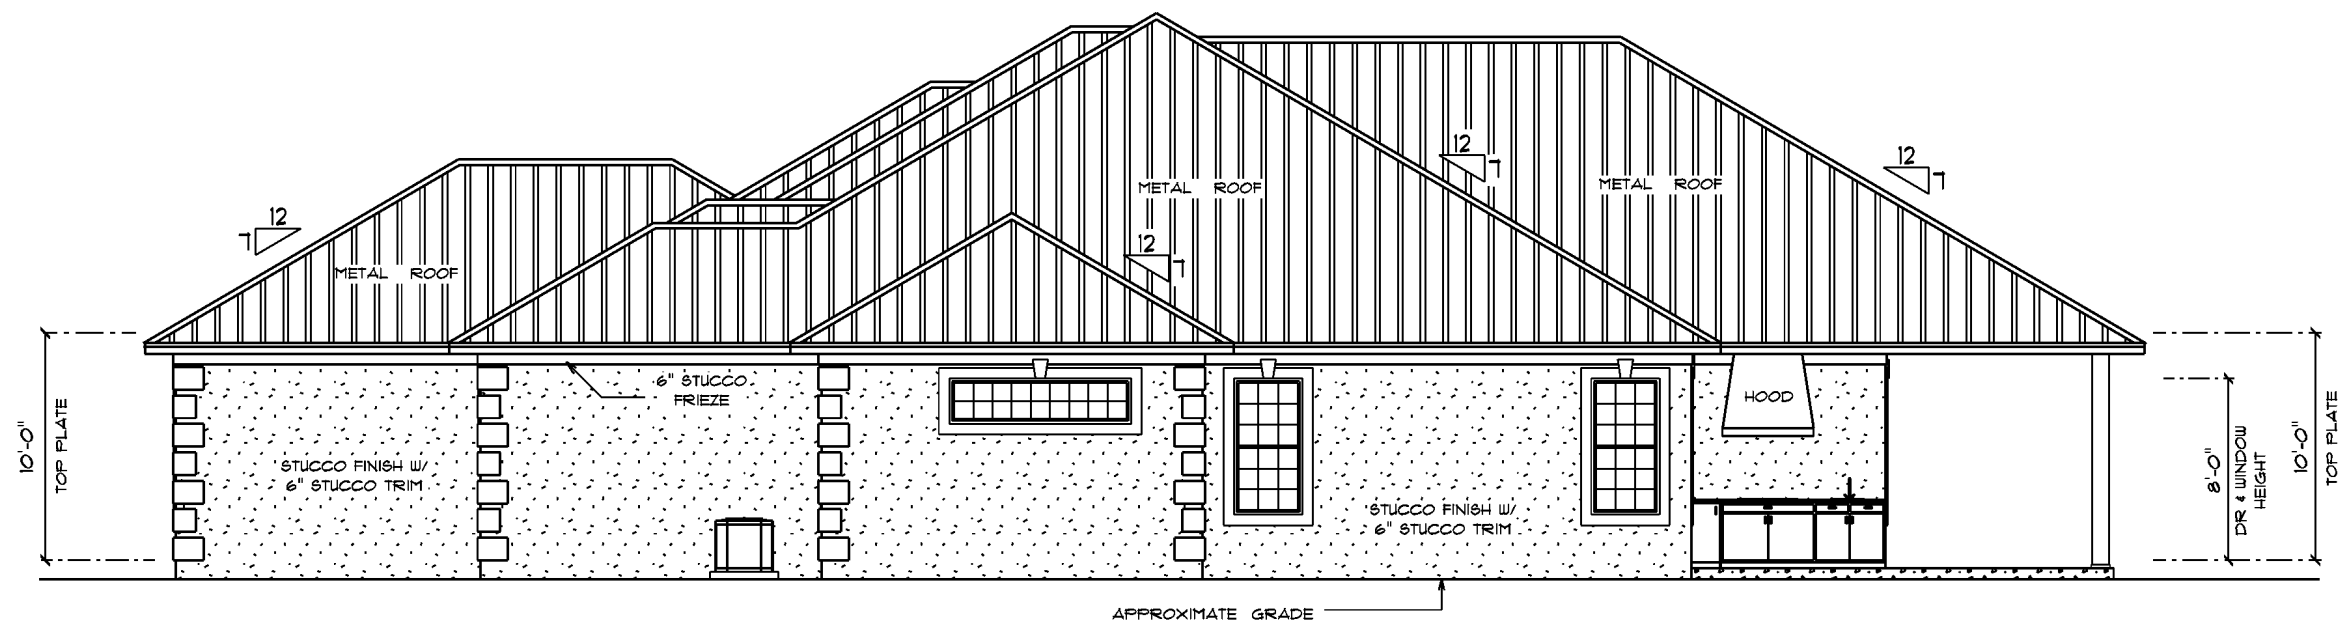

* RIGHT SIDE ELEVATION *

SCALE : 1/4" = 1'-0"

RESIDENCE
for
REINARD WILSON

LAKE CITY
FLORIDA

Teresa M. Ruffo
2825 SW 8R 41
Lake City, Florida, 32025
Cell: (386) 861-1191
Email: teresaruffo@gmail.com

PRINTED DATE:
Wednesday, May 27, 2020

DRAWN BY: Teresa M. Ruffo CHECKED BY:

BUILDING CONTRACTOR


FINALS DATE:

JOB NUMBER:

DRAWING NUMBER


A-4

OF 6 SHEETS

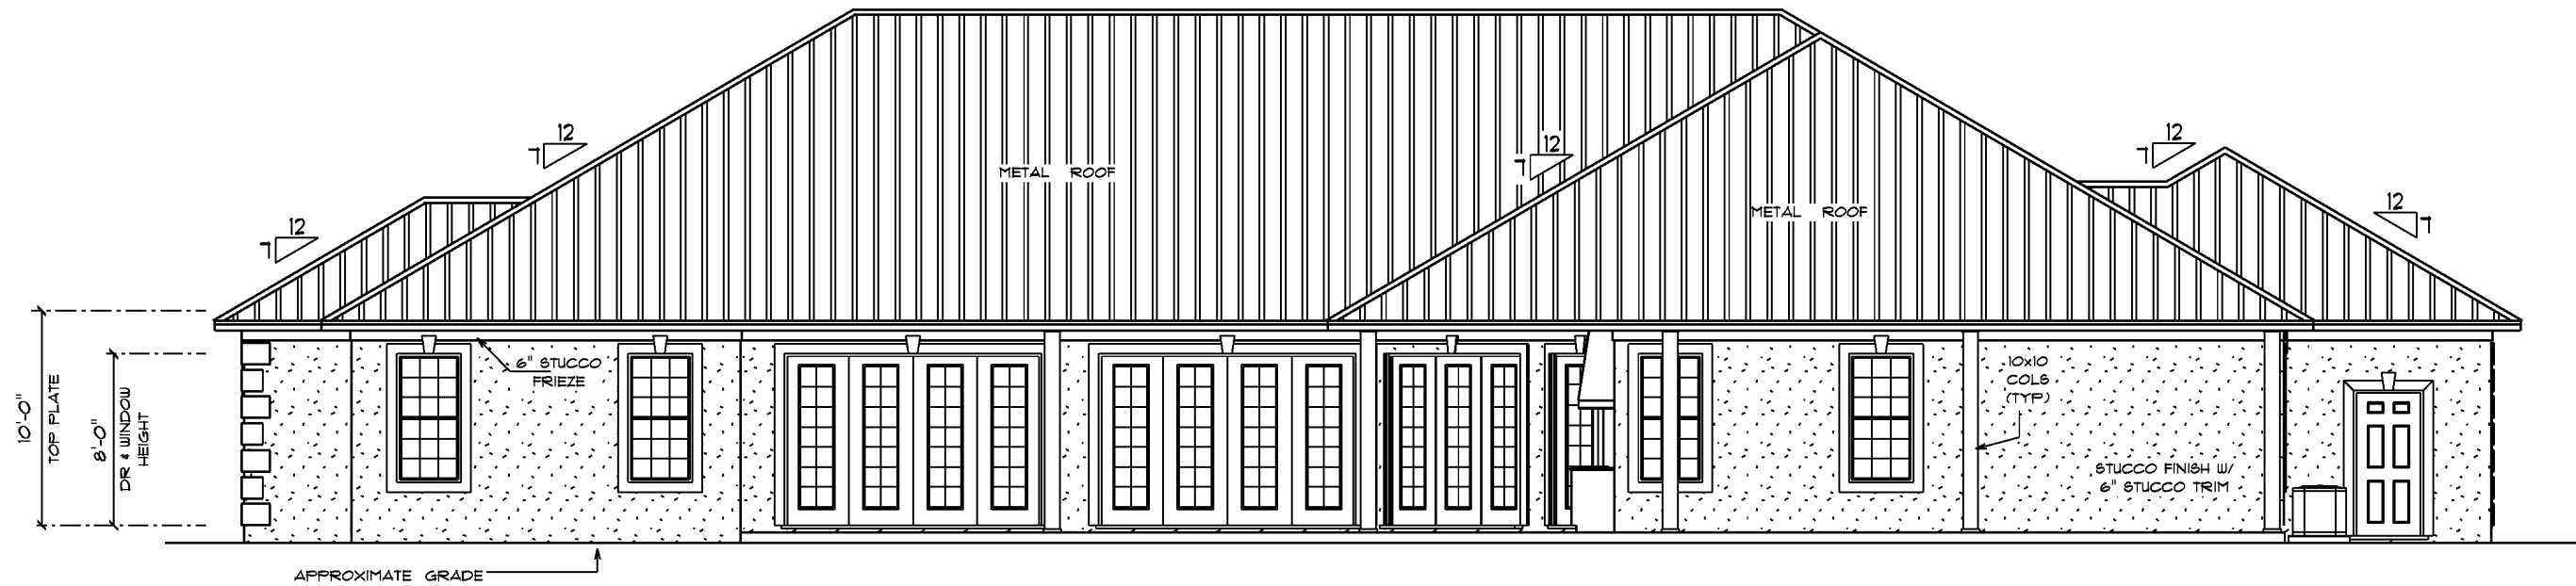

• REAR ELEVATION •

SCALE : 1/4" = 1'-0"

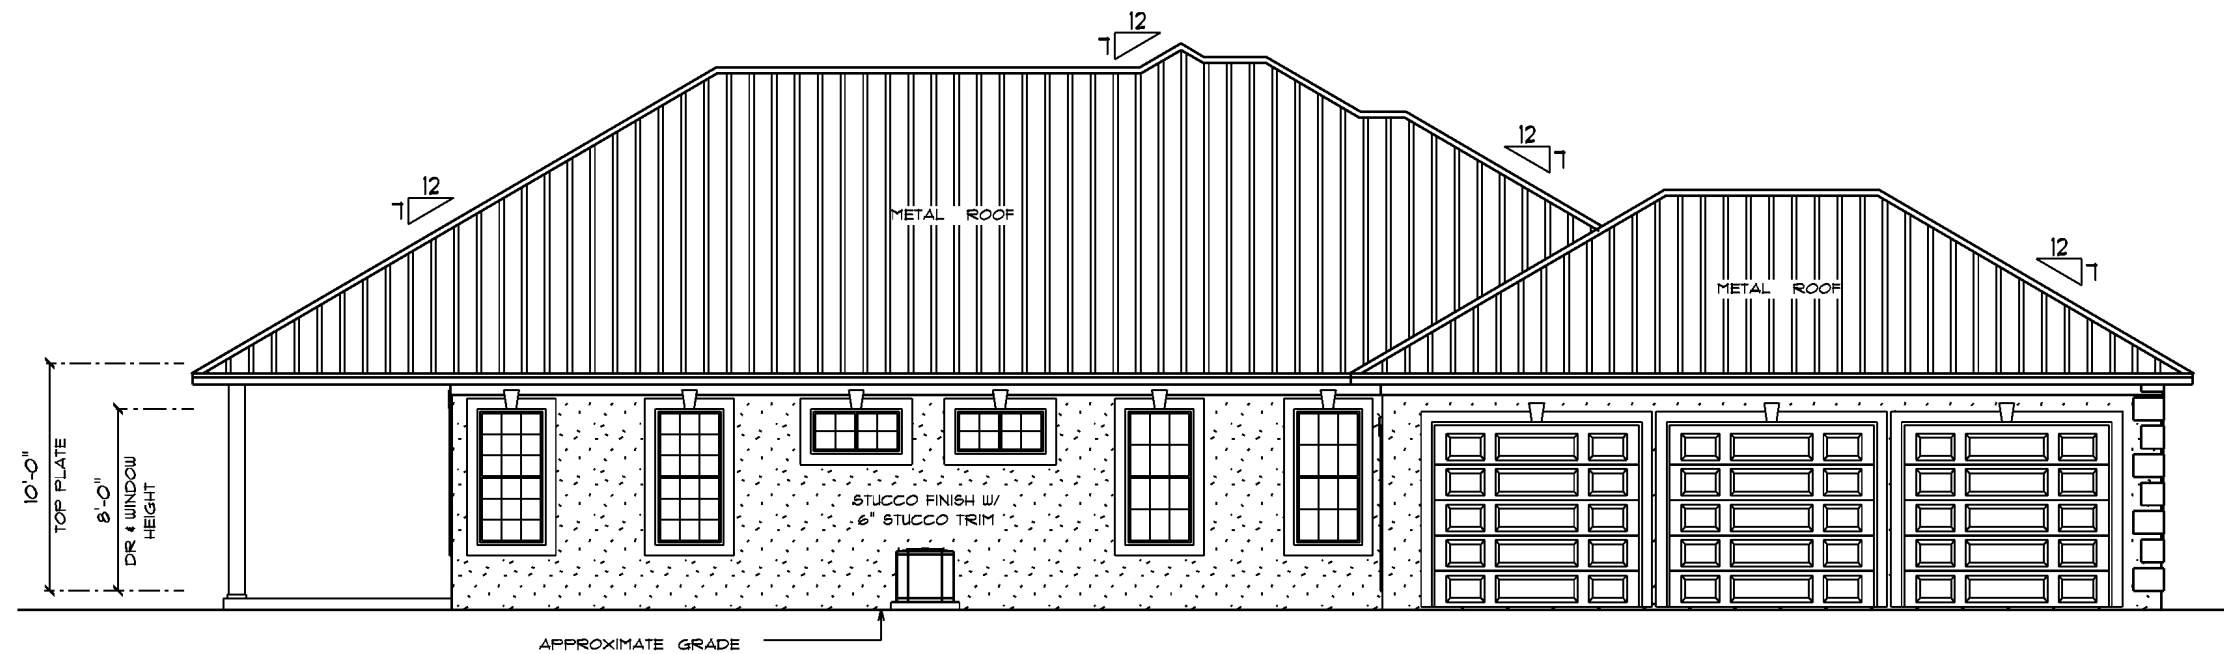

• RIGHT SIDE ELEVATION •

SCALE : 1/4" = 1'-0"

RESIDENCE
for
REINARD WILSON

LAKE CITY
FLORIDA

Teena M. Ruffo
2925 SW 8R 41
Lake City, Florida, 32025
Cell: (386) 861-1191
Email: teenaruffo@gmail.com

PRINTED DATE:
Wednesday, May 27, 2020

DRAWN BY: Teena M. Ruffo

CHECKED BY:

BUILDING CONTRACTOR

FINALS DATE:

JOB NUMBER:


DRAWING NUMBER

A-5

OF 6 SHEETS

ELECTRICAL LEGEND		
ELECTRICAL	COUNT	SYMBOL
ceiling fan globe O1	17	+
pendant large	5	•
pot light	64	•
exterior craftsman light fixture	4	•
exterior light O3	1	•
spotlight double	12	•
Smoke Detector	9	⊙
electrical meter	1	•
electrical panel	1	•
floor outlet single	2	•
automatic garage dr opener	3	•
dimmer switch	5	•
dimmer switch 3-way	2	•
garage dr opener	3	•
light	8	•
outlet	57	•
outlet 220v	9	•
outlet gfi	23	•
outlet up	7	•
switch	46	•
switch 3 way	16	•
switch 4 way	3	•
vent light combo	6	•
fluorescent light 1 x 4	4	•
vanity bar light O2	8	•

- ELECTRICAL PLAN NOTES**
- E-1 WIRE ALL APPLIANCES, HVAC UNITS AND OTHER EQUIPMENT PER MANUFACTURER'S SPECIFICATIONS.
 - E-2 ALL INSTALLATIONS SHALL BE PER NATIONAL ELECTRIC CODE.
 - E-3 ALL SMOKE /CARBON MONOXIDE DETECTORS SHALL BE 120V W/BATTERY BACKUP OF THE PHOTOELECTRIC TYPE, AND SHALL BE INTERLOCKED TOGETHER. INSTALL INSIDE AND NEAR ALL BEDROOMS AS PER CODE.
 - E-4 TELEPHONE, TELEVISION AND OTHER LOW VOLTAGE DEVICES OR OUTLETS SHALL BE AS PER THE OWNER'S DIRECTION AND IN ACCORDANCE WITH APPLICABLE SECTIONS OF NATIONAL ELCT. CODE LATEST EDITION.
 - E-5 ELECTRICAL CONTRACTOR SHALL BE RESPONSIBLE FOR THE DESIGN AND SIZING OF ELECTRICAL SERVICE AND CIRCUITS.
 - E-6 ENTRY OF SERVICE UNDERGROUND OR OVERHEAD) IS TO BE DETERMINED BY THE POWER COMPANY.
 - E-7 ALL BEDROOM RECEPTALS ARE TO BE AFCI (ARC FAULT CIRCUIT INTERRUPT).
 - E-8 75% OF ALL PERMANENT LIGHTS TO BE ENERGY EFFICIENT.

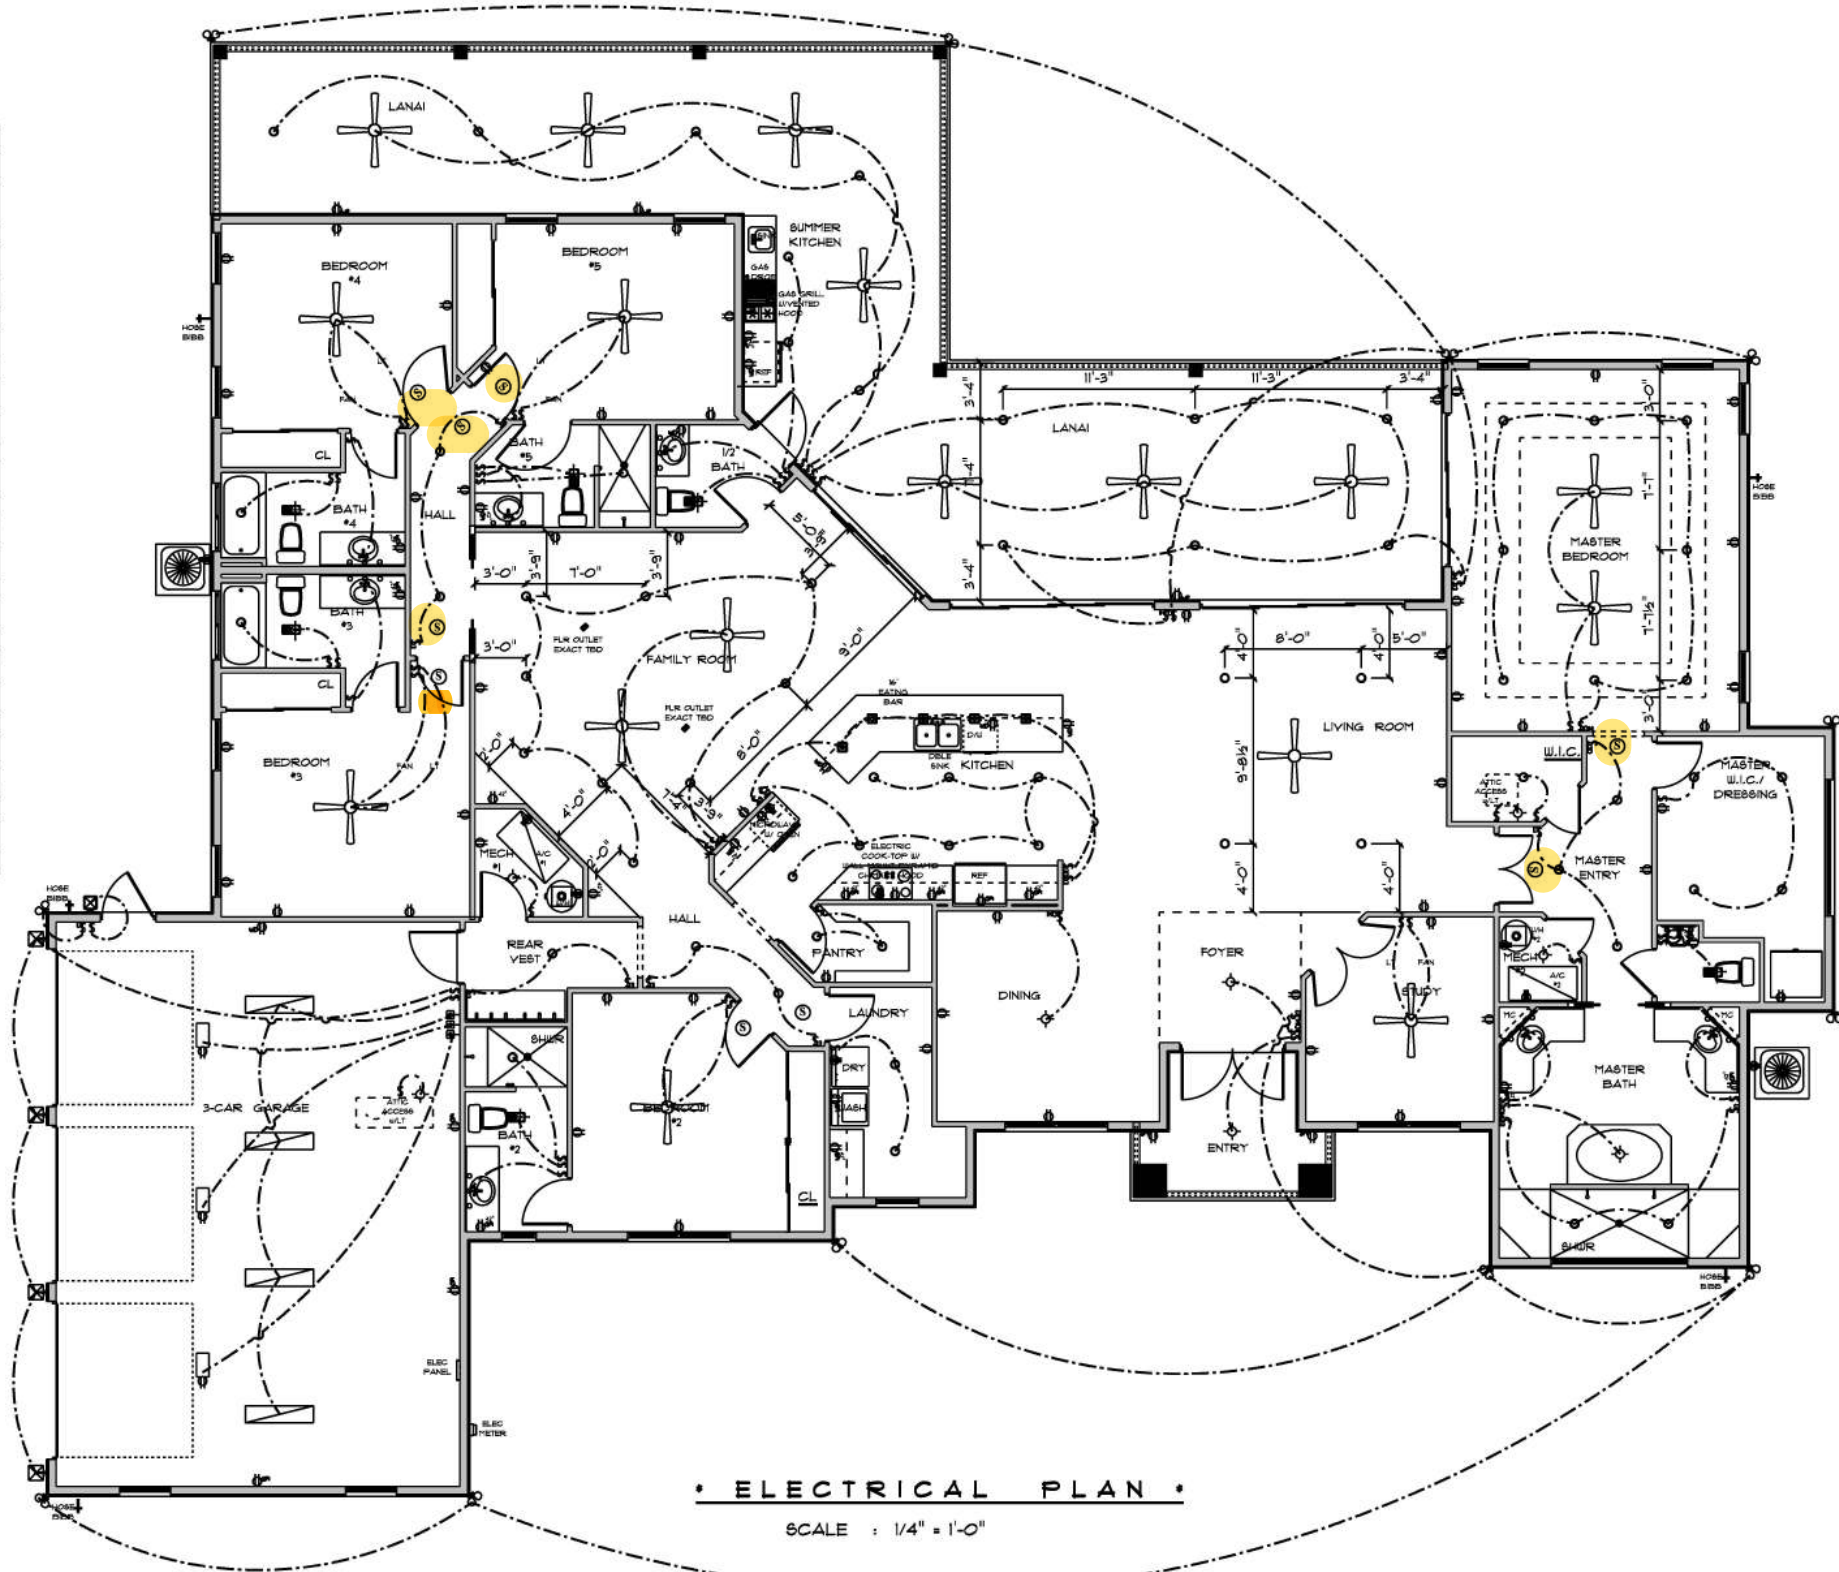

RESIDENCE
for
REINARD WILSON

LAKE CITY
FLORIDA

Teena M. Ruffo
2925 SW 68 41
Lake City Florida, 32025
Cell: (386) 861-1181
Email: teenaruffo@gmail.com

PRINTED DATE:
Wednesday, May 27, 2020

DRAWN BY: Teena M. Ruffo
CHECKED BY:
BUILDING CONTRACTOR

FINALS DATE:

JOB NUMBER:

DRAWING NUMBER

A-6

OF 6 SHEETS