



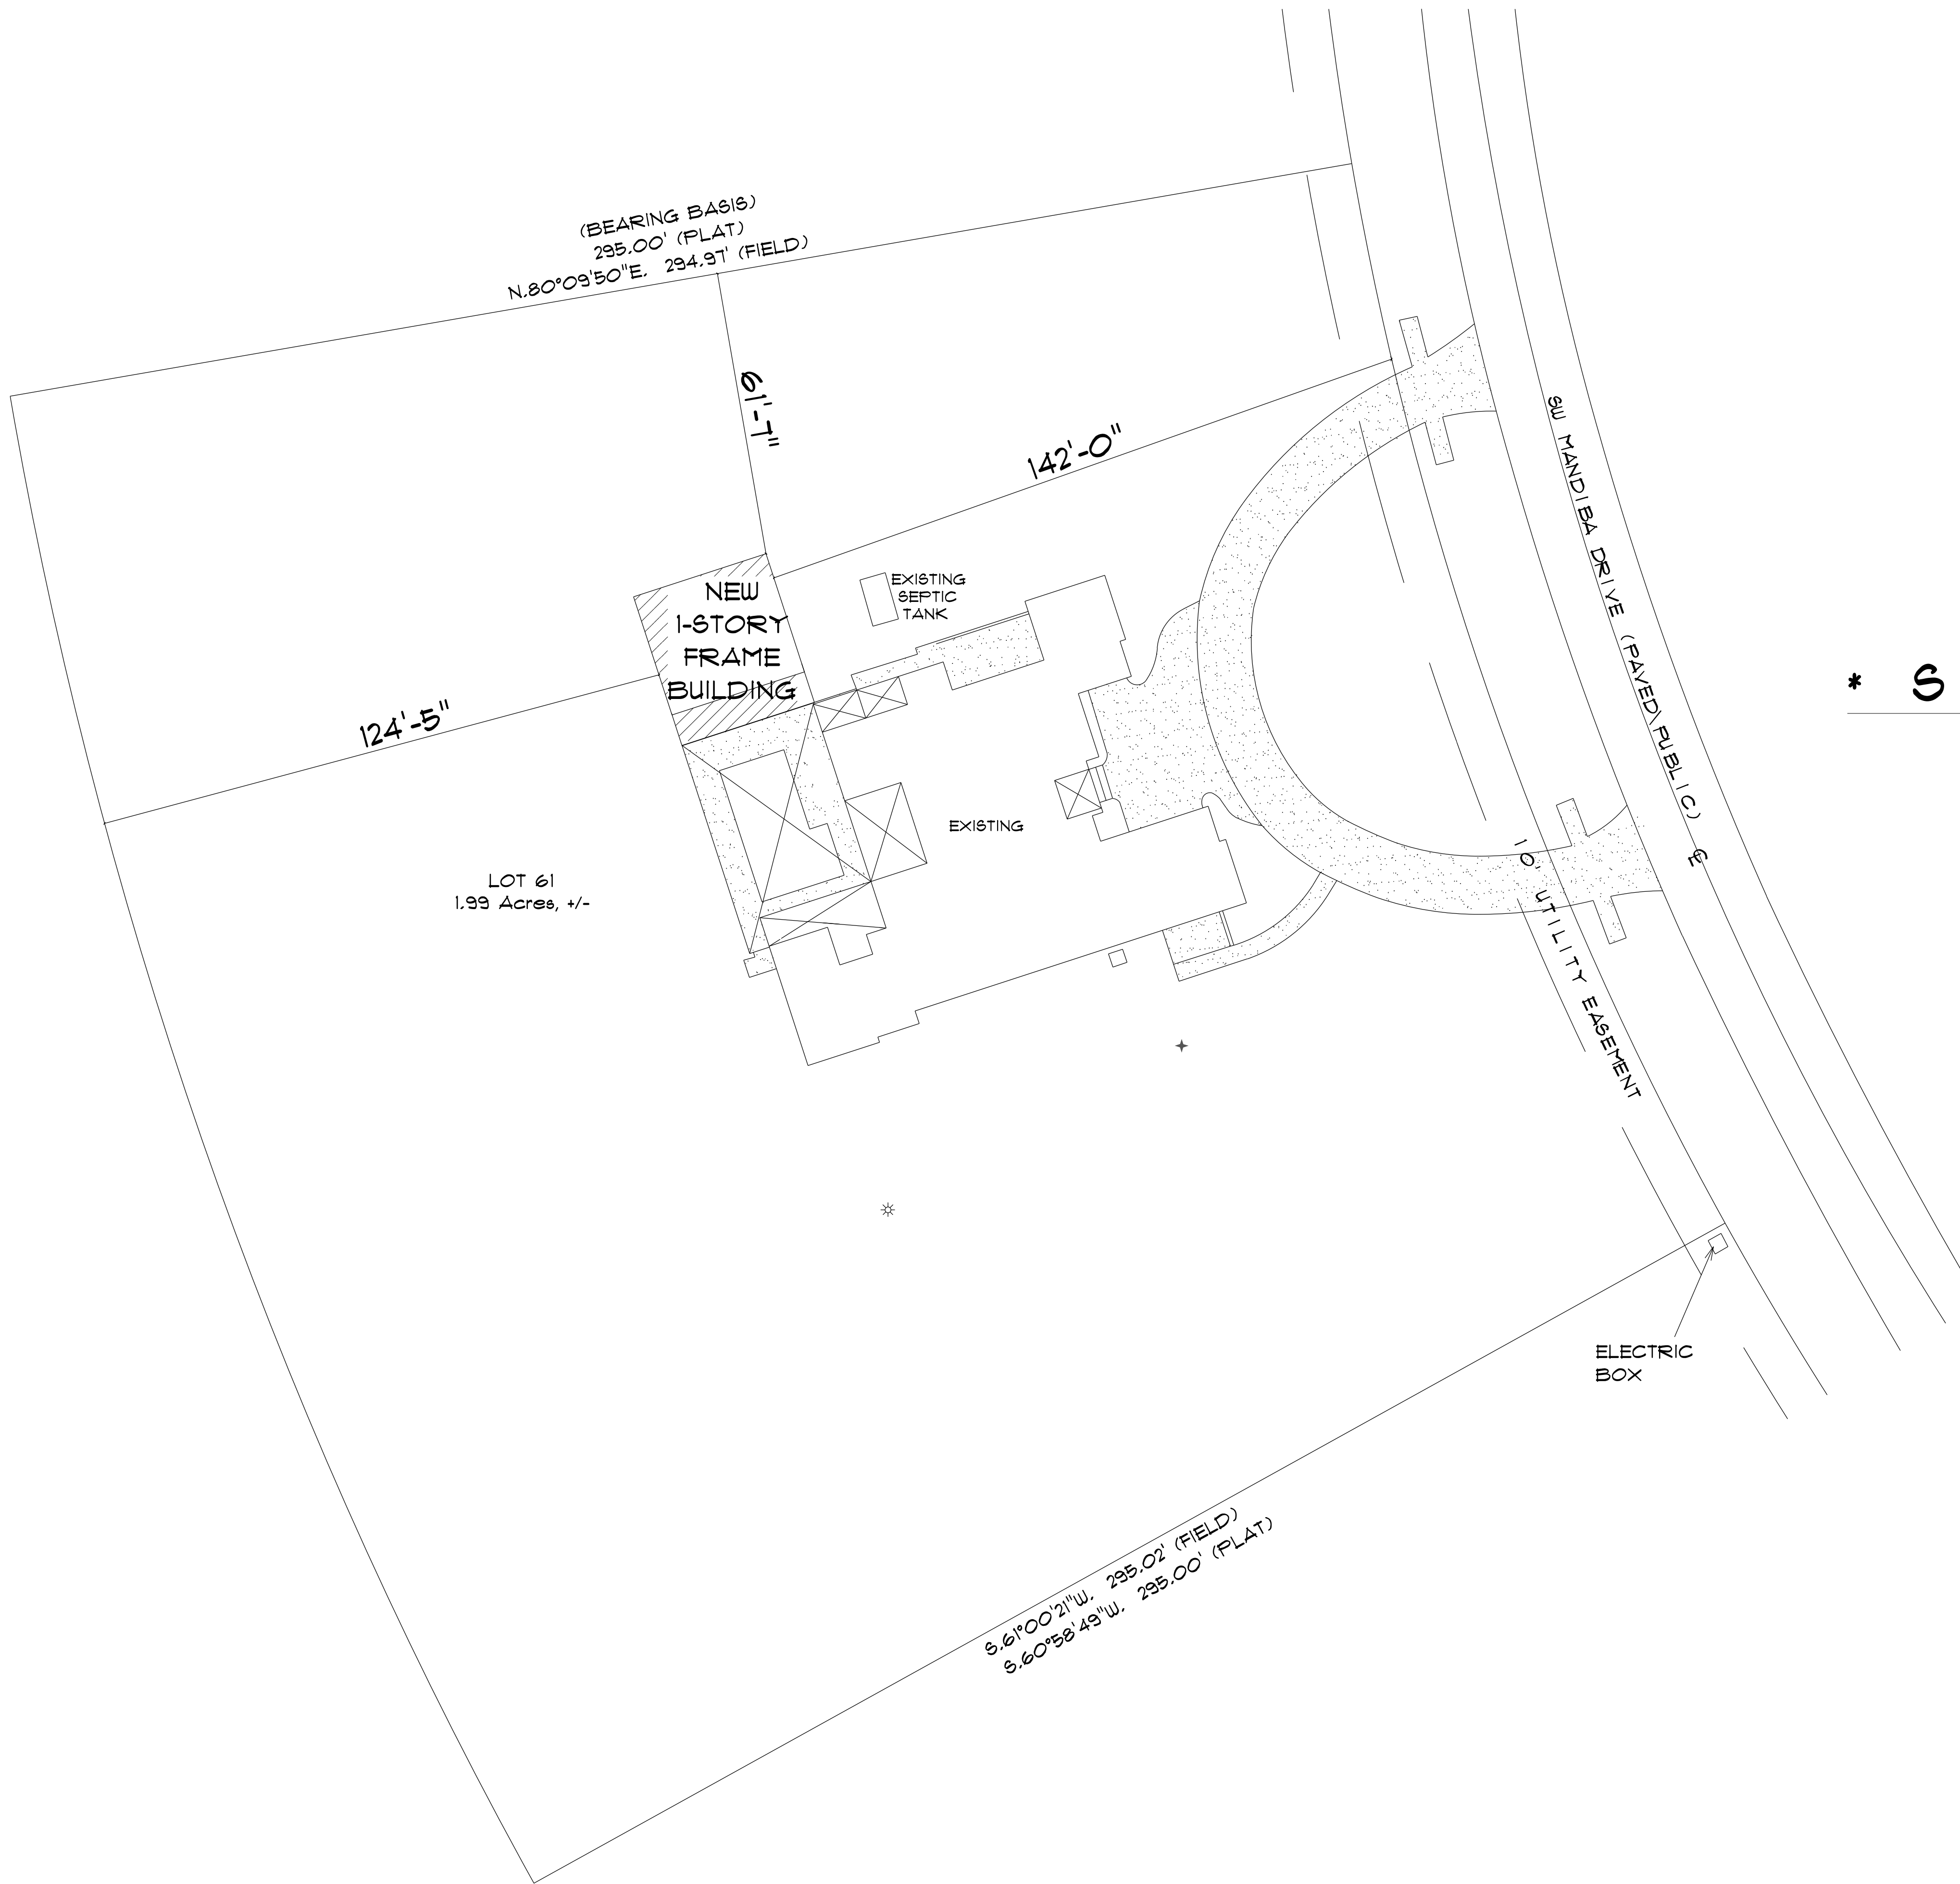

* SITE PLAN *

SCALE: 1" = 20'

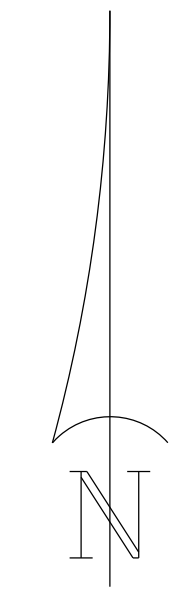

POOL HOUSE
FOR
DAN & RACHEL
SHELLEY

Teena M. Ruffo
2925 SW SR 47
Lake City Florida, 32025
Cell: (386) 861-1191
Email: teenaruffo@gmail.com

PRINTED DATE:
Friday, May 30, 2025

DRAWN BY: Teena and Kara CHECKED BY:


BUILDING CONTRACTOR
ZECHER CONSTRUCTION

FINAL DATE:

JOB NUMBER:

DRAWING NUMBER
A-1

OF 4 SHEETS

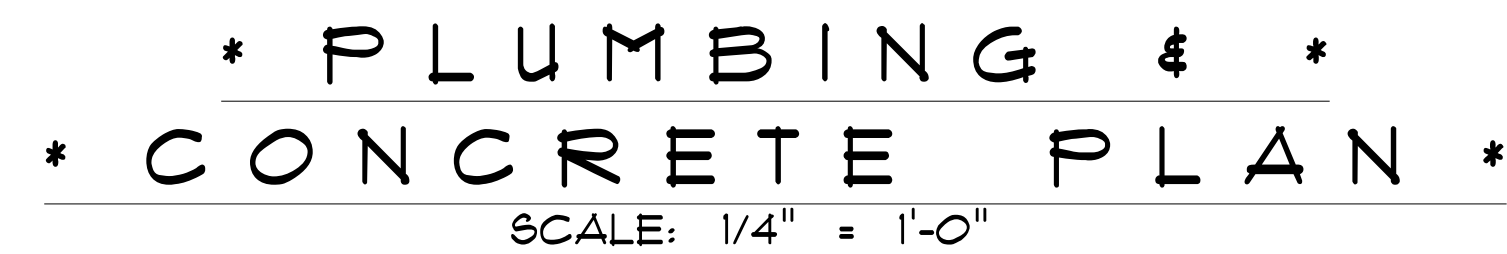


1. IT IS THE BUILDER'S RESPONSIBILITY TO VERIFY ALL GEOMETRY AND DIMENSIONS BEFORE ORDERING ANY MATERIALS OR BEGINNING CONSTRUCTION.
2. THESE PLANS ARE FOR LAYOUT AND DESIGN PURPOSES ONLY ALL STRUCTURAL NOTES AND DETAILS TO BE PROVIDED BY AN ENGINEER.



A/C LIVING AREA	=	798 S.F.
COVERED PORCH	=	209 S.F.
TOTAL AREA UNDER ROOF	=	1,007 S.F.

1. IT IS THE BUILDERS RESPONSIBILITY TO VERIFY ALL GEOMETRY AND DIMENSIONS BEFORE ORDERING ANY MATERIALS OR BEGINNING CONSTRUCTION.
2. THESE PLANS ARE FOR LAYOUT AND DESIGN PURPOSES ONLY ALL STRUCTURAL NOTES AND DETAILS TO BE PROVIDED BY AN ENGINEER.
3. 2X6 EXTERIOR STUD WALLS 2X4 INTERIOR WALLS


OF 4 SHEETS

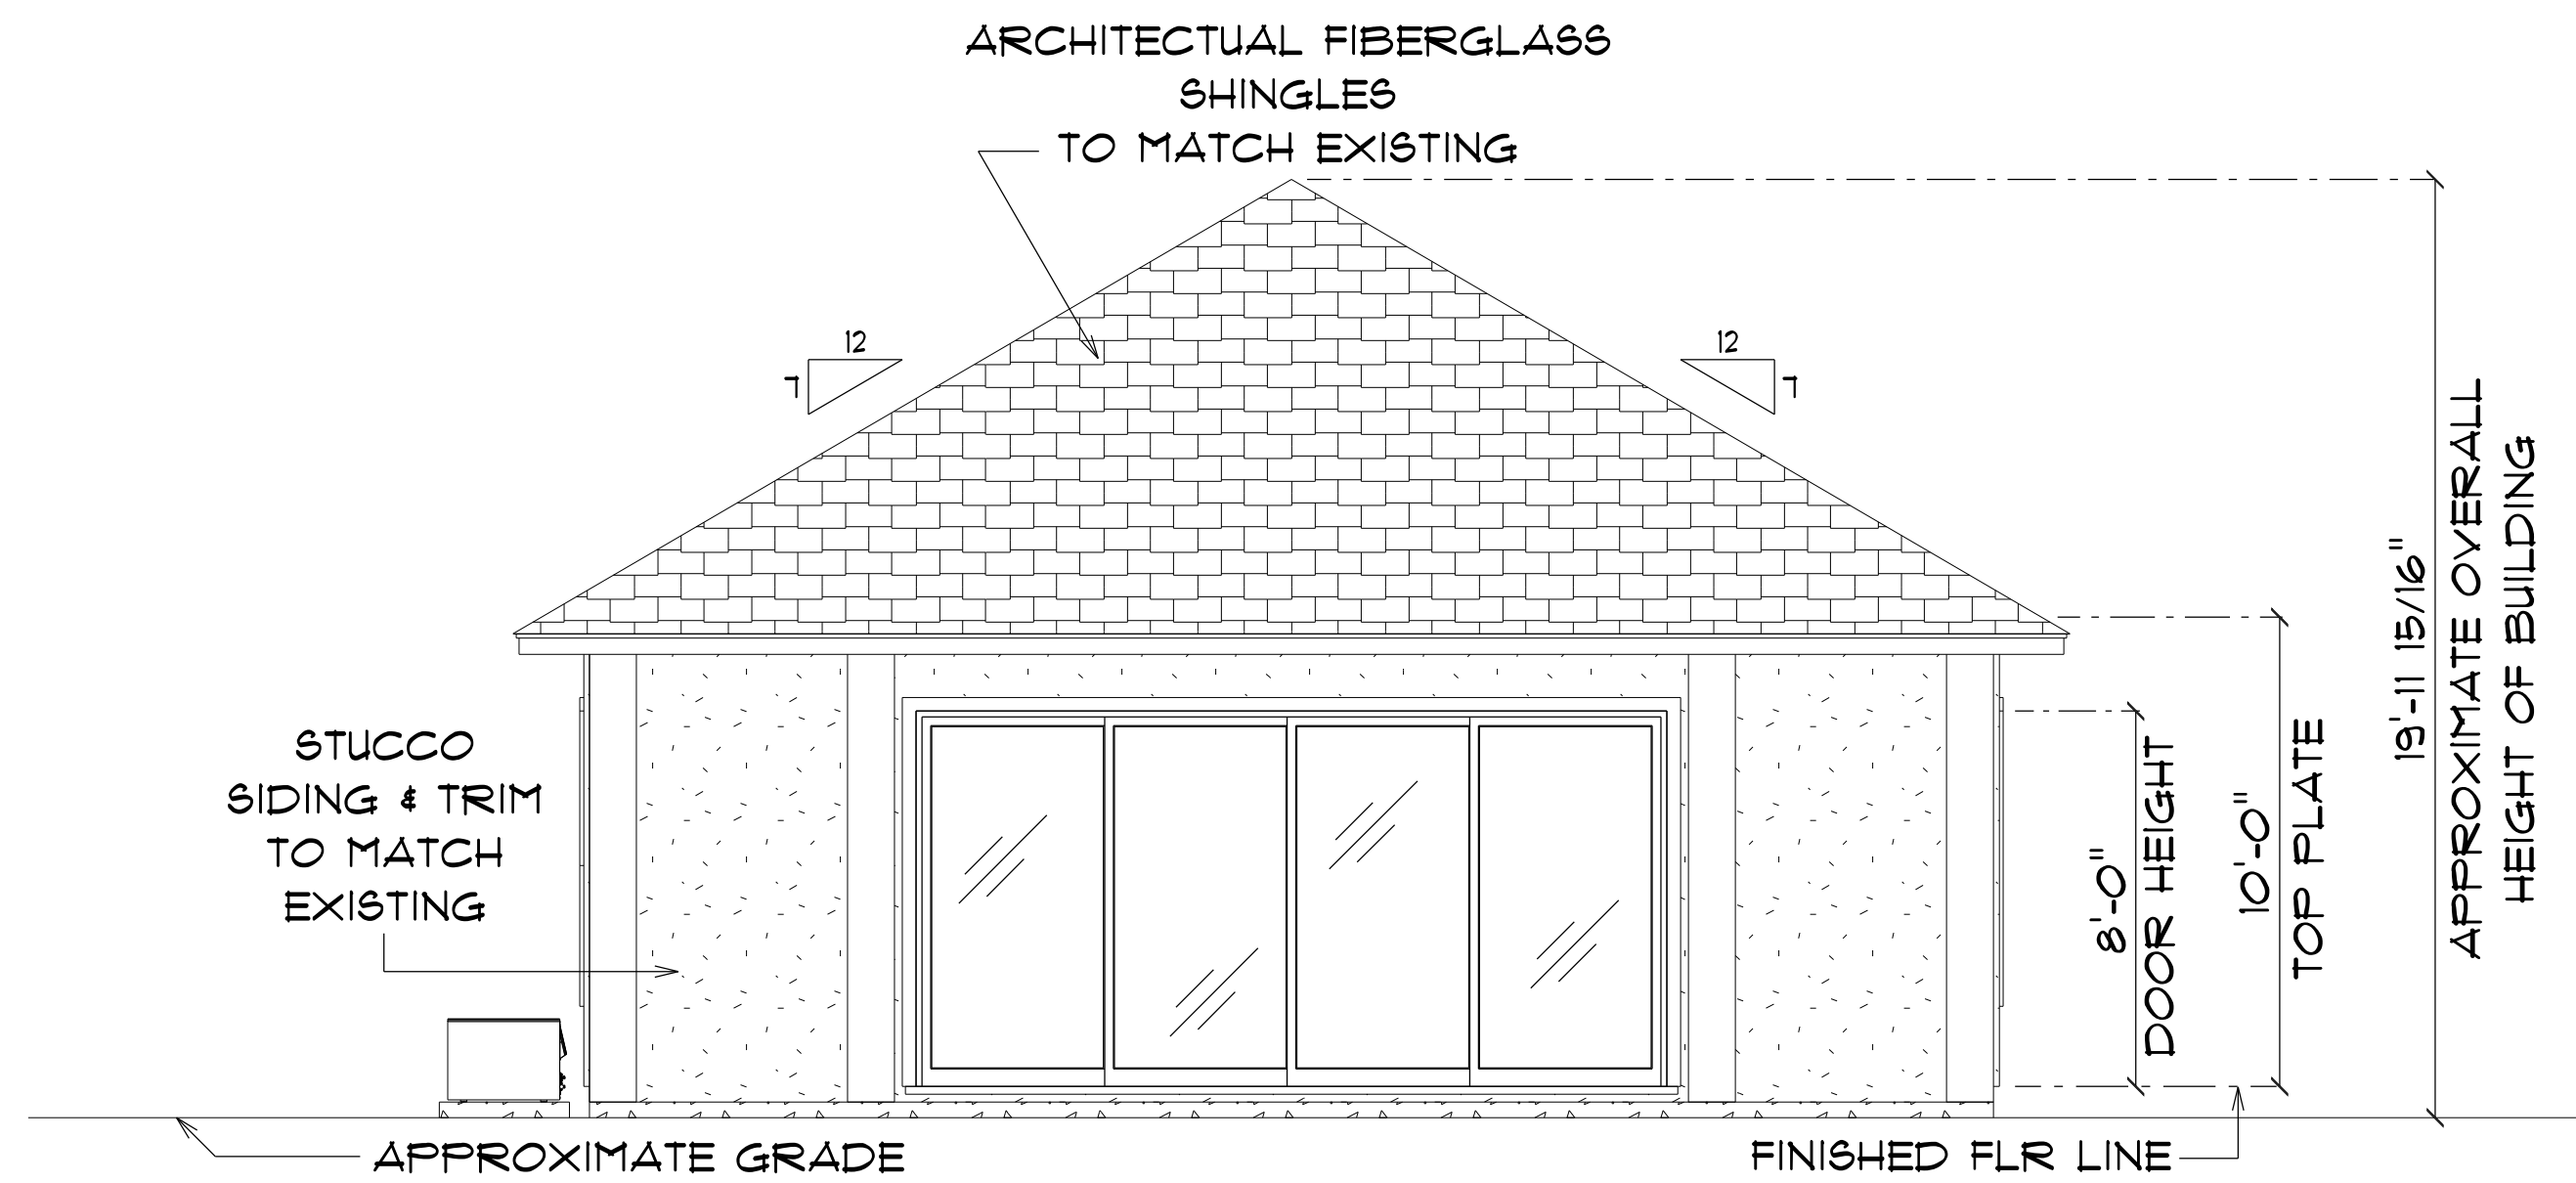

* FRONT ELEVATION *

SCALE : 1/4" = 1'-0"


NOTE: 18" OVERHANG ON EAVES

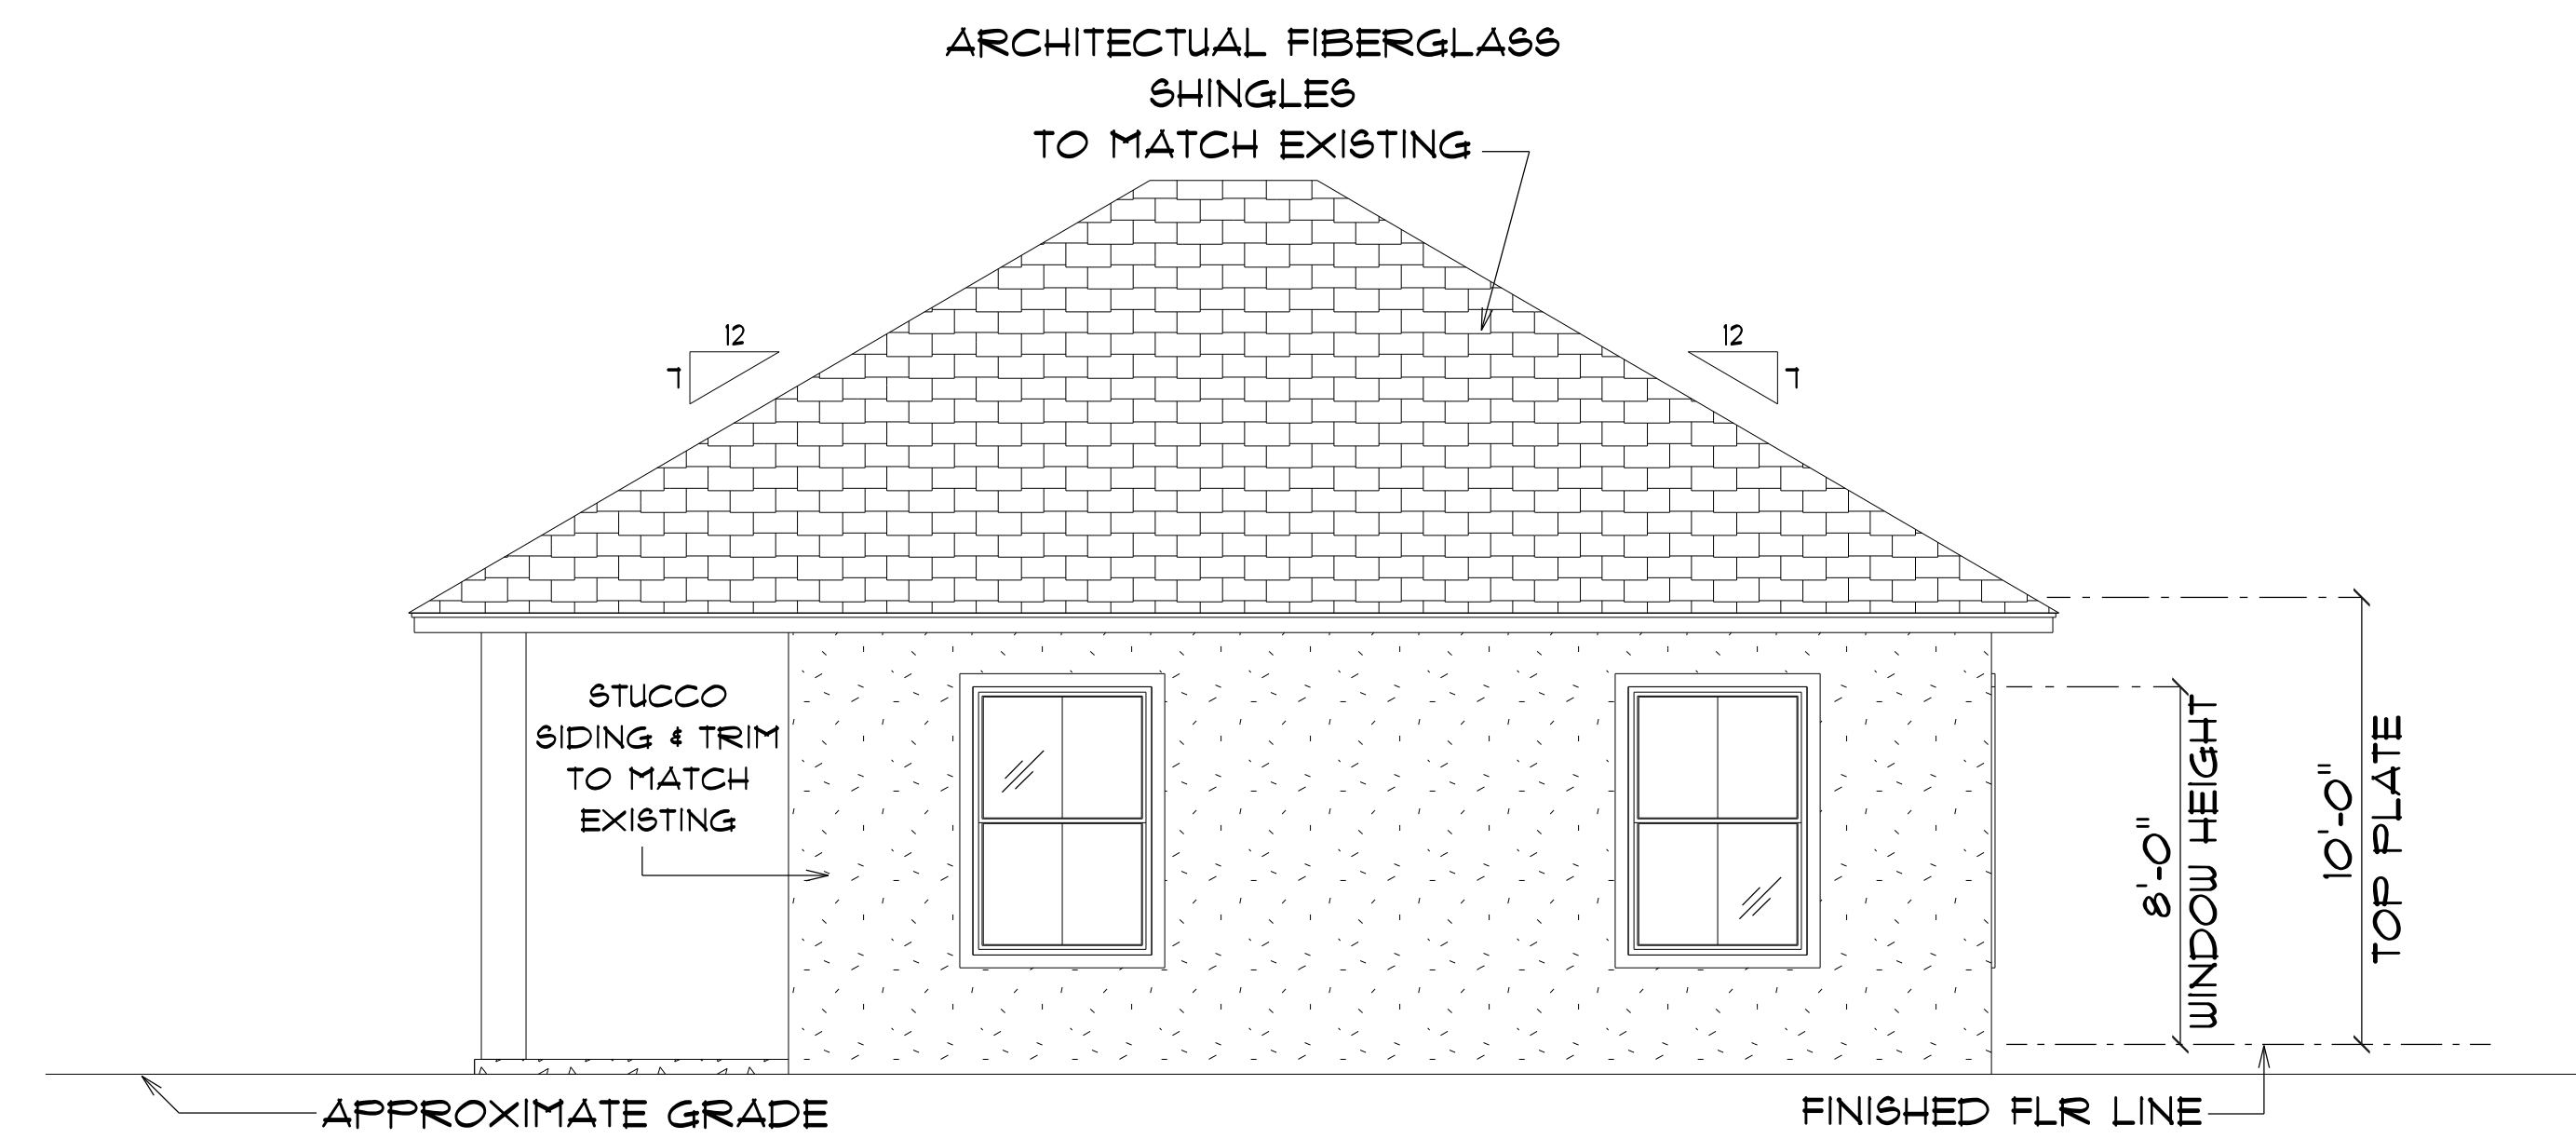

* RIGHT ELEVATION *

SCALE : 1/4" = 1'-0"


NOTE: 18" OVERHANG ON EAVES

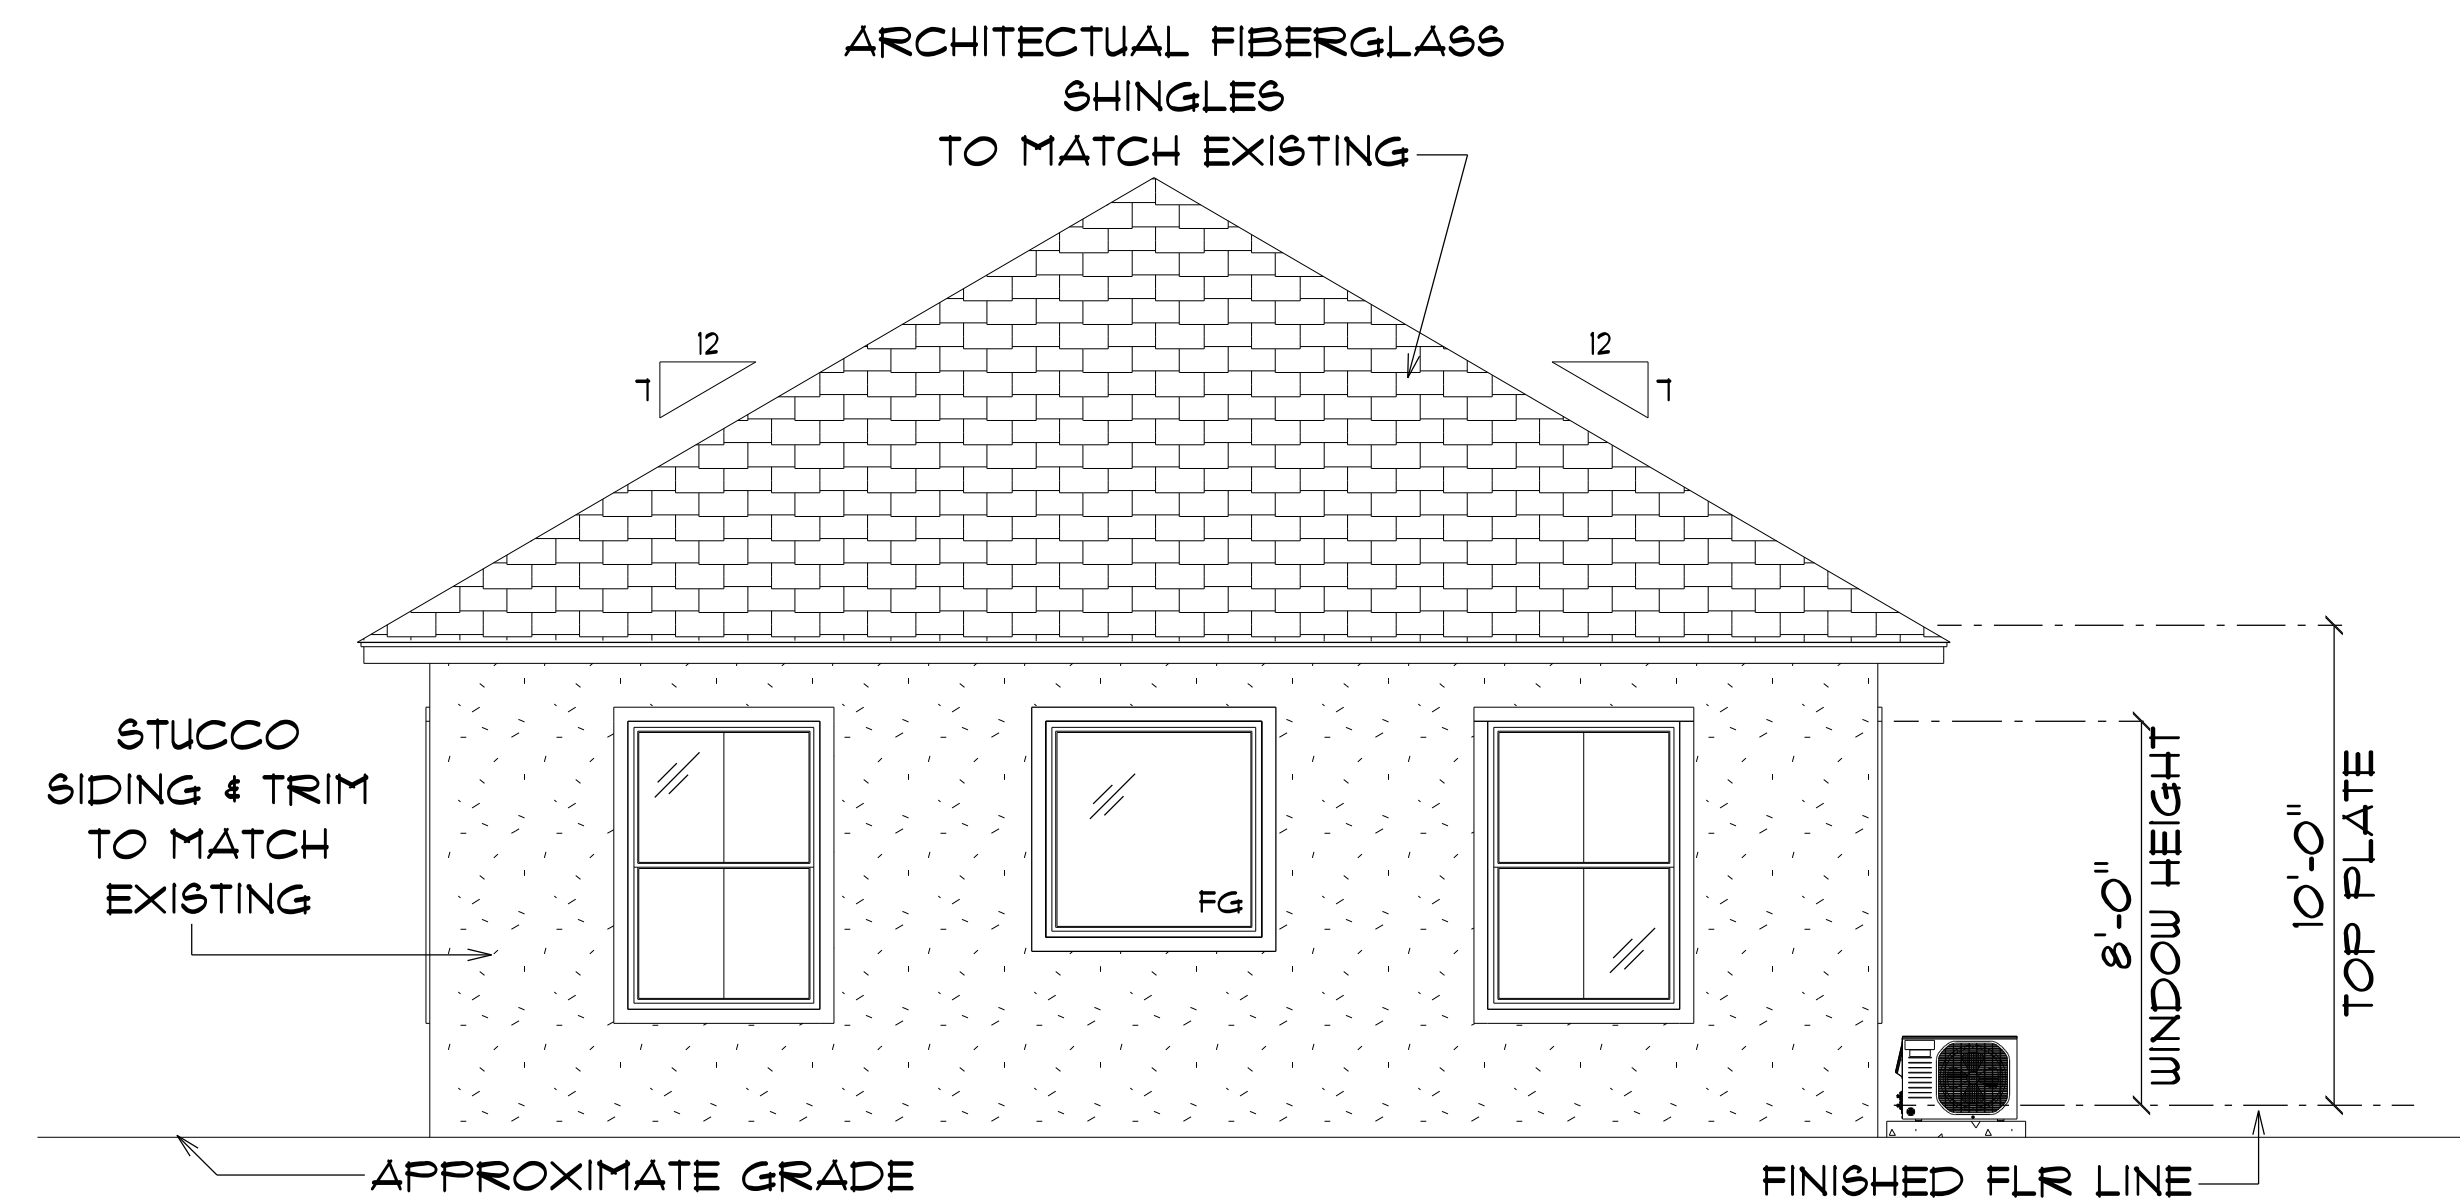

* REAR ELEVATION *

SCALE : 1/4" = 1'-0"

NOTE: 18" OVERHANG ON EAVES

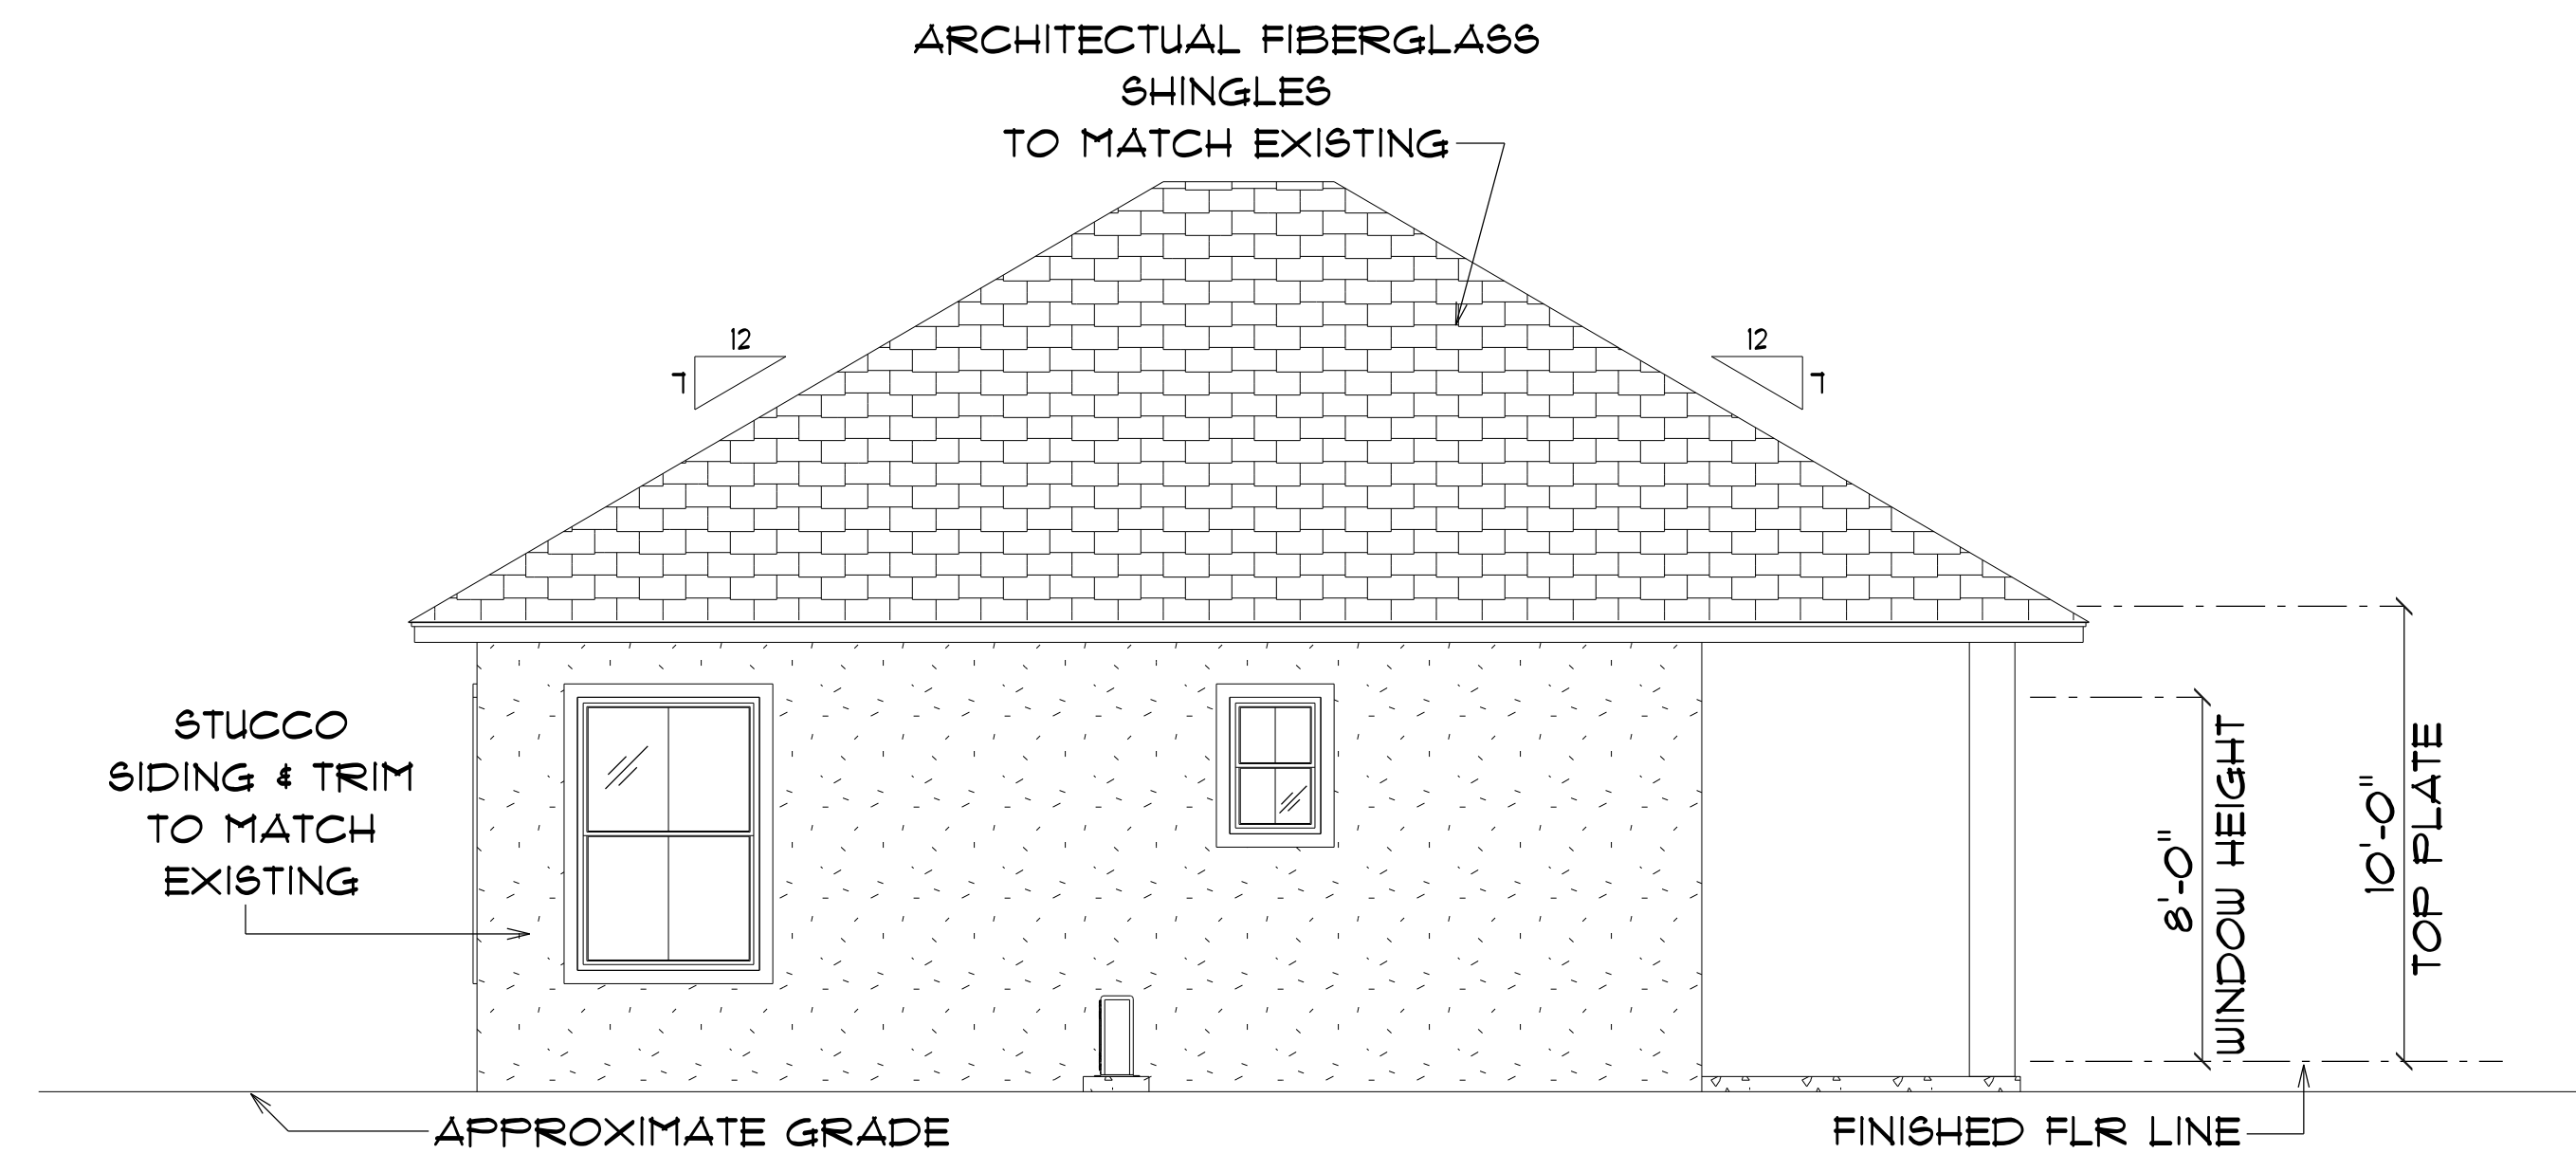

* LEFT ELEVATION *

SCALE : 1/4" = 1'-0"

NOTE: 18" OVERHANG ON EAVES

POOL HOUSE
FOR
DAN & RACHEL
SHELLEY

Teena M. Ruffo
2925 SW SR 47
Lake City Florida, 32025
Cell: (386) 867-1191
Email: teenaruffo@gmail.com

PRINTED DATE:
Friday, May 30, 2025

DRAWN BY: Teena and Kara

BUILDING CONTRACTOR
ZECHER CONSTRUCTION


FINAL DATE:

JOB NUMBER:

DRAWING NUMBER

A-3

OF 4 SHEETS

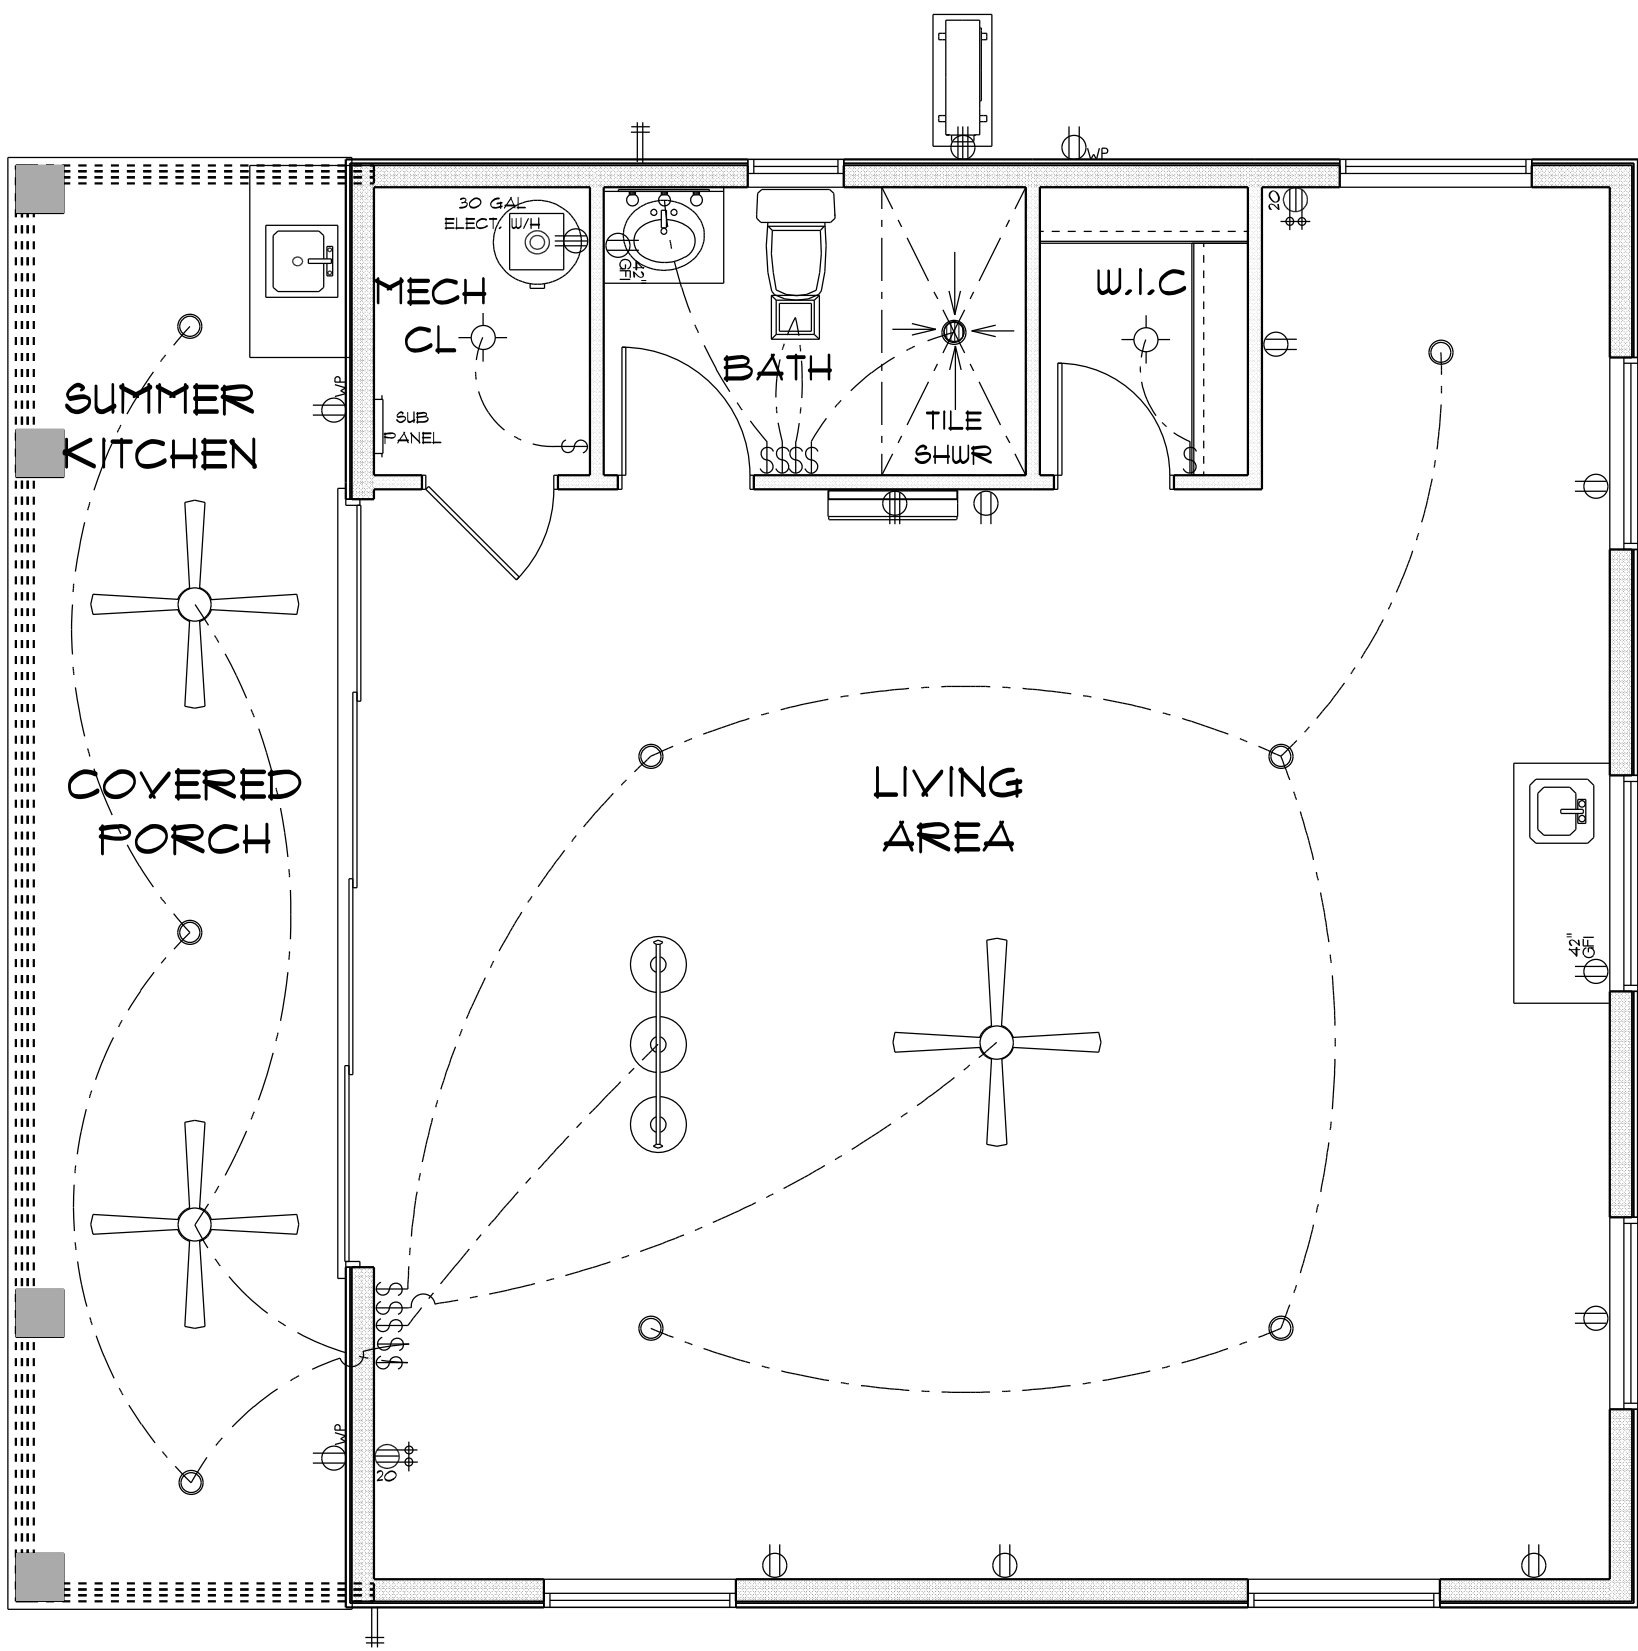

ELECTRICAL LEGEND		
ELECTRICAL	COUNT	SYMBOL
20 amp dedicated circuit/outlet	2	
billiard light	1	
ceiling fan globe OI	3	
combination fan and light-square	1	
electrical subpanel	1	
light	2	
outlet	7	
outlet 220v	3	
outlet gfi	2	
outlet up	3	
pot light	9	
switch	11	
vanity bar light O2	1	

- ELECTRICAL PLAN NOTES
- E-1 WIRE ALL APPLIANCES, HVAC UNITS AND OTHER EQUIPMENT PER MANUFACTURERS SPECIFICATIONS.
- E-2 ALL INSTALLATIONS SHALL BE PER NATIONAL ELECTRIC CODE.
- E-3 ALL SMOKE /CARBON MONOXIDE DETECTORS SHALL BE 120V W/BATTERY BACKUP OF THE PHOTOELECTRIC TYPE AND SHALL BE INTERLOCKED TOGETHER. INSTALL INSIDE AND NEAR ALL BEDROOMS AS PER CODE.
- E-4 TELEPHONE, TELEVISION AND OTHER LOW VOLTAGE DEVICES OR OUTLETS SHALL BE AS PER THE OWNERS DIRECTION AND IN ACCORDANCE WITH APPLICABLE SECTIONS OF NATIONAL ELCT. CODE LATEST EDITION.
- E-5 ELECTRICAL CONTRACTOR SHALL BE RESPONSIBLE FOR THE DESIGN AND SIZING OF ELECTRICAL SERVICE AND CIRCUITS.
- E-6 ENTRY OF SERVICE UNDERGROUND OR OVERHEAD) IS TO BE DETERMINED BY THE POWER COMPANY.
- ALL BEDROOM RECEPTICALS ARE TO BE AFCI (ARC FAULT CIRCUIT INTERRUPT)
- 75% OF ALL PERMANENT LIGHTS TO BE ENERGY EFFICIENT.

* ELECTRICAL PLAN *

SCALE: 1/4" = 1'-0"

POOL HOUSE
FOR
DAN & RACHEL
SHELLEY

Teena M. Ruffo
2925 SW 8R 47
Lake City Florida, 32025
Cell: (386) 867 - 1191
Email: teenaruffo@gmail.com

PRINTED DATE:
Friday, May 30, 2025

DRAWN BY: Teena and Kara

CHECKED BY:

BUILDING CONTRACTOR
ZECHER CONSTRUCTION

FINAL DATE:

JOB NUMBER:

DRAWING NUMBER

A-4

OF 4 SHEETS