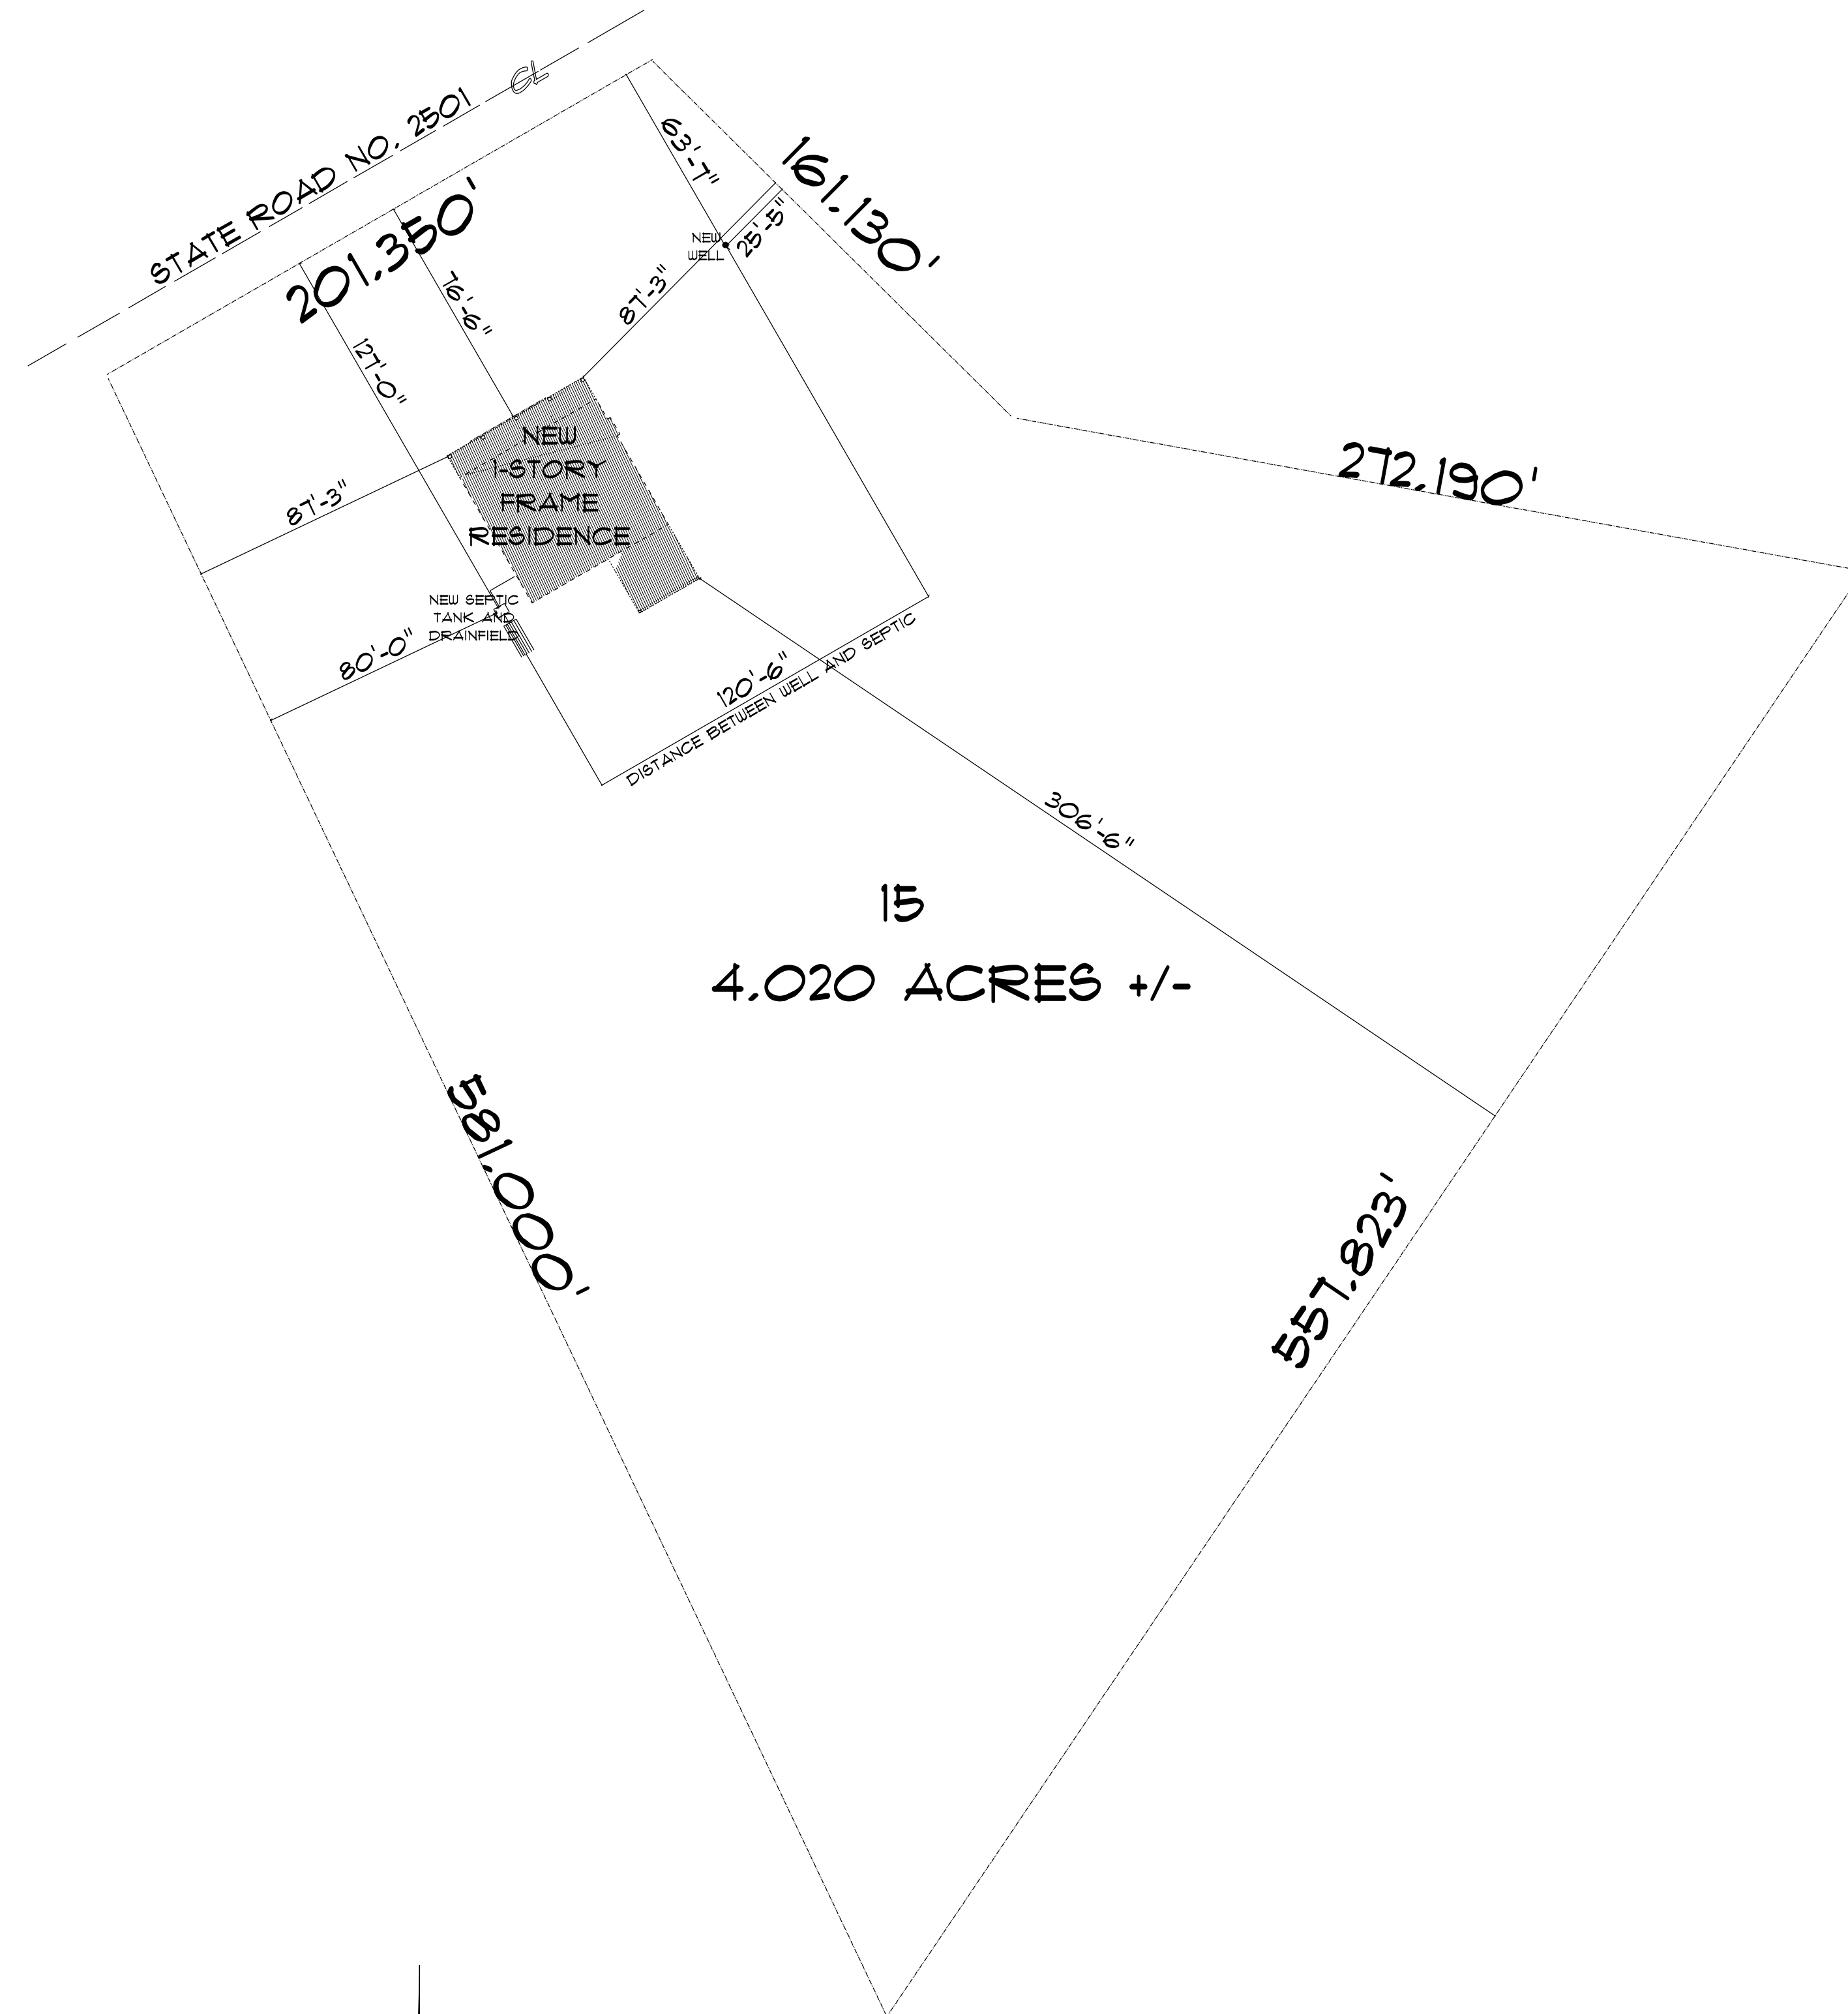


* SITE PLAN *

SCALE: 1" = 40'-0"

RESIDENCE
DONNY & MISSY
DUPREE

LAKE CITY, FLORIDA

Teena M. Ruffo
2925 SW SR 47
Lake City Florida, 32025
Cell: (386) 867-1191
Email: teenaruffo@gmail.com

PRINTED DATE:
Sunday, December 19, 2021

DRAWN BY: Teena M. Ruffo CHECKED BY:

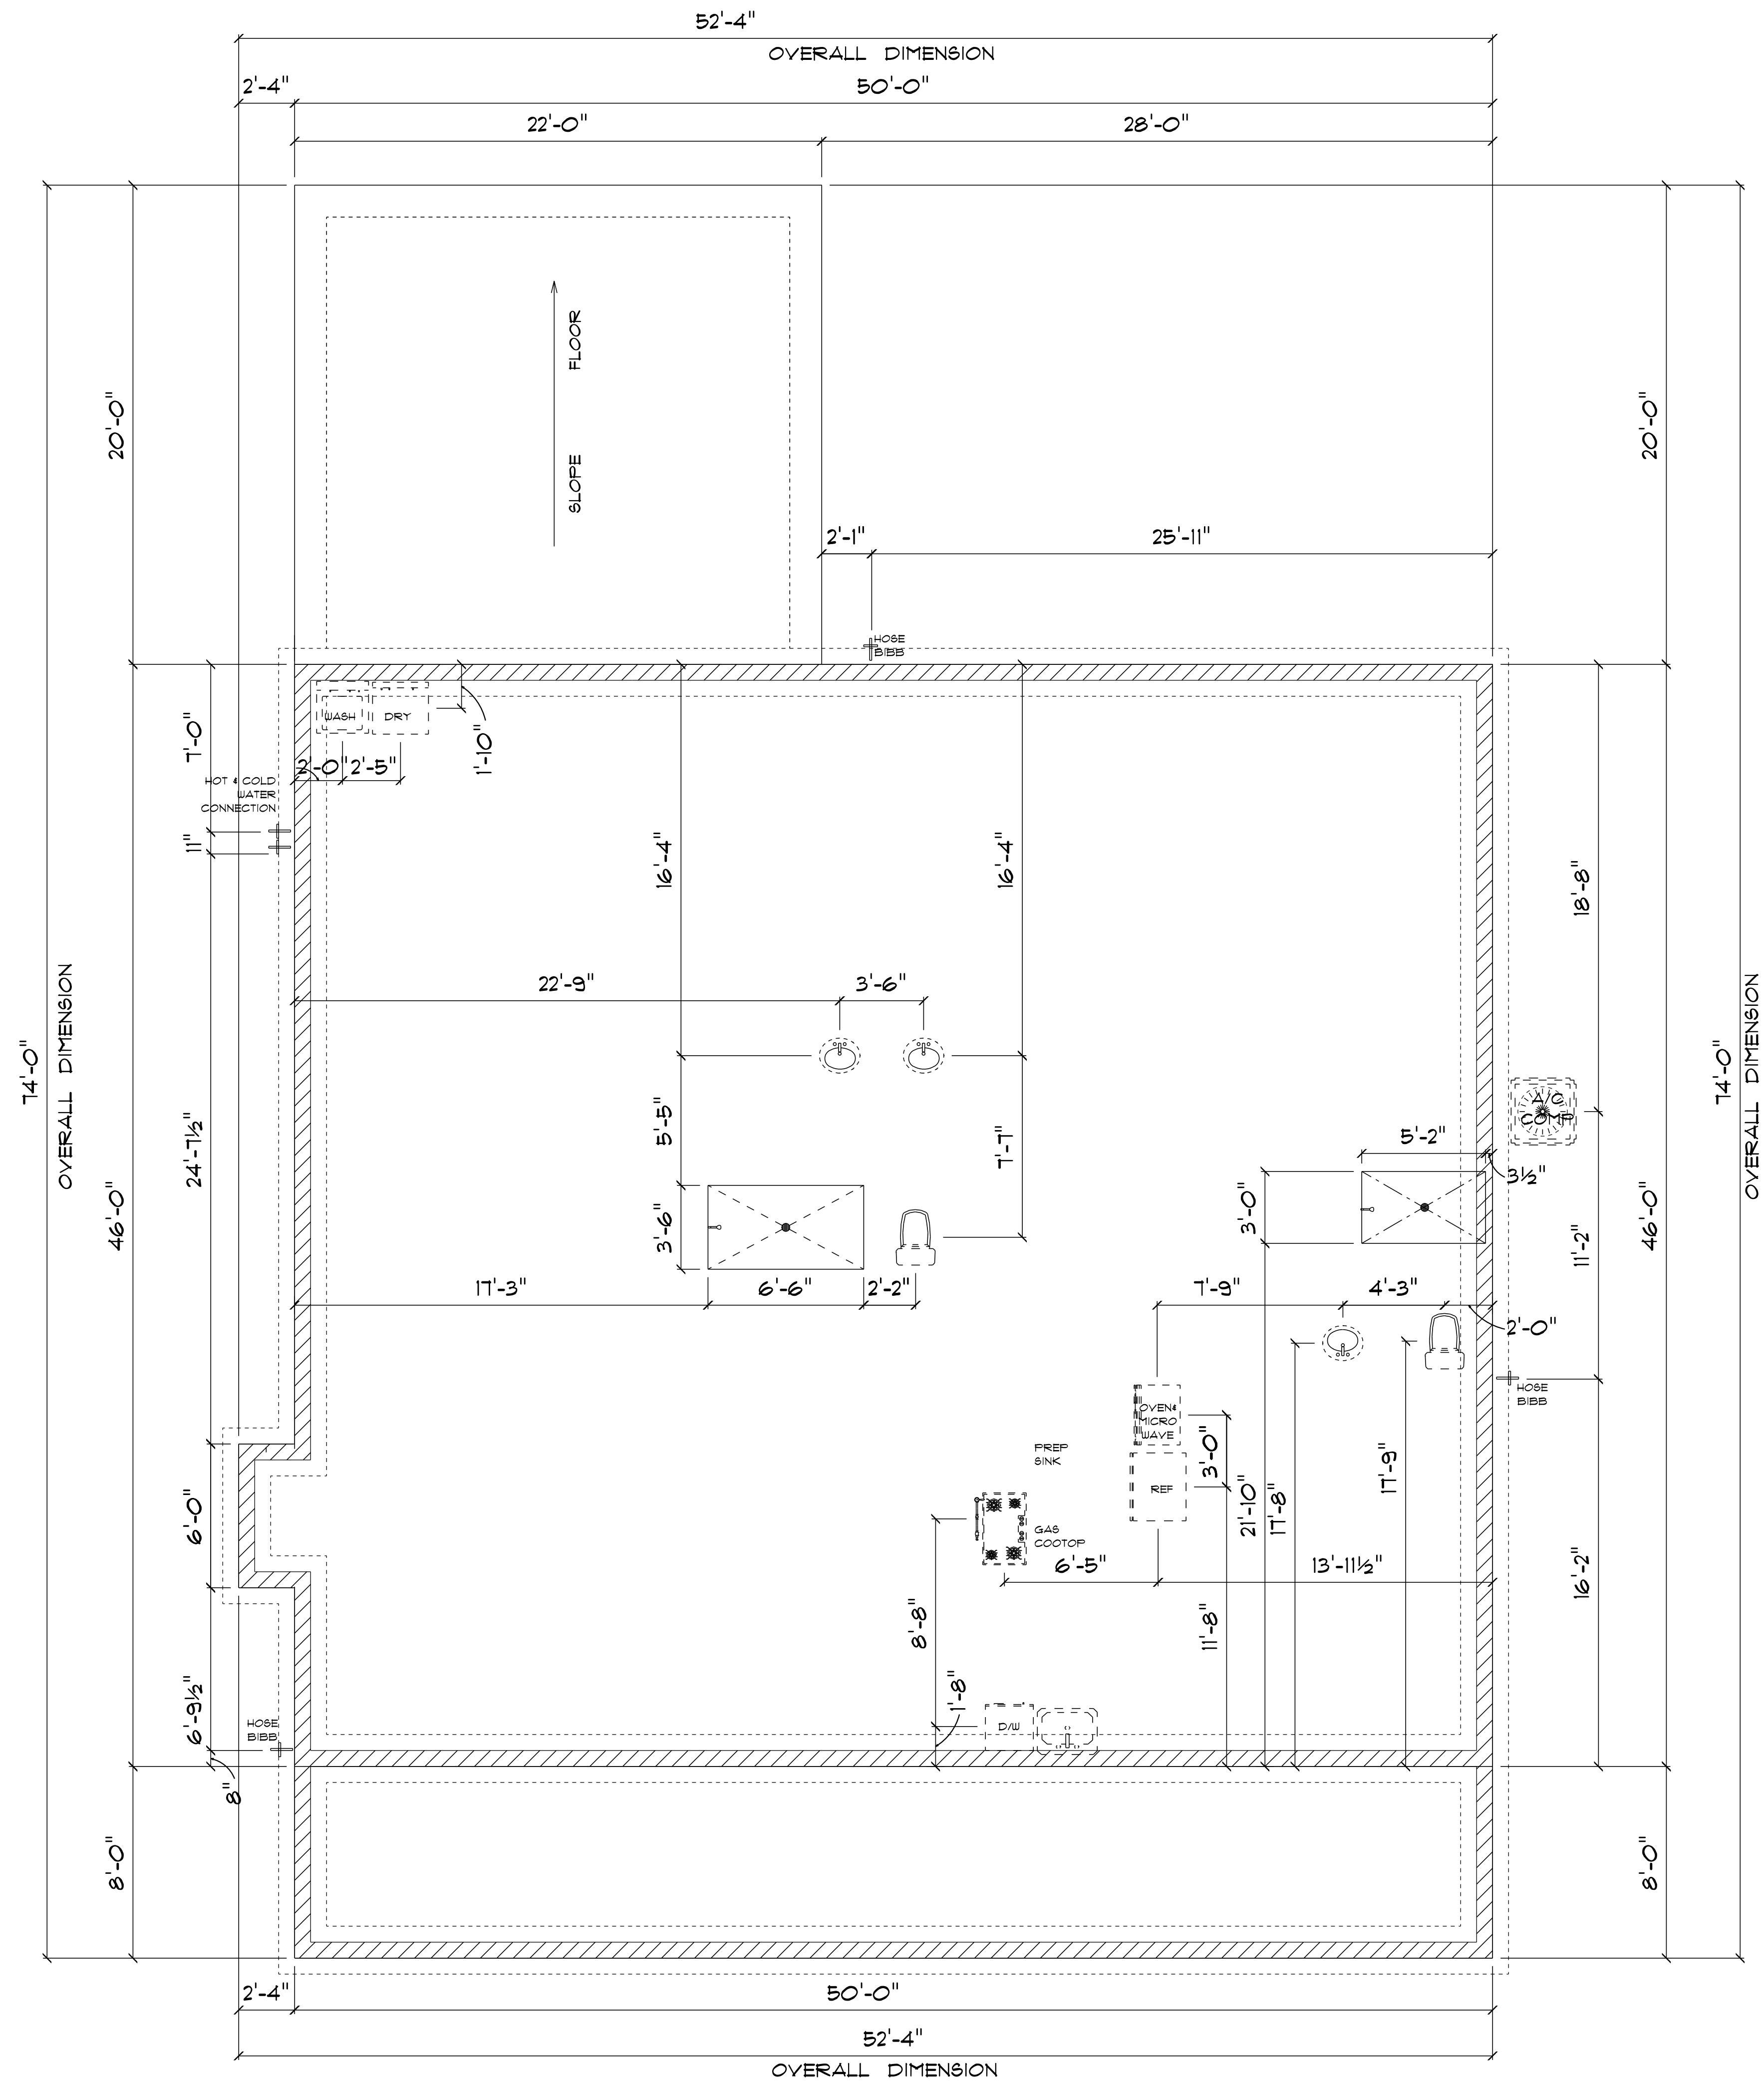
BUILDING CONTRACTOR
DUPREE CONSTRUCTION

FINAL \$ DATE:

JOB NUMBER:

DRAWING NUMBER
A-1

OF 6 SHEETS



PLUMBING/
* FOUNDATION PLAN *

SCALE : 1/4" = 1'-0"

- IMPORTANT NOTES:
1. IT IS THE BUILDERS RESPONSIBILITY TO VERIFY ALL GEOMETRY AND DIMENSIONS BEFORE ORDERING ANY MATERIALS OR BEGINNING CONSTRUCTION.
 2. THESE PLANS ARE FOR LAYOUT AND DESIGN PURPOSES ONLY ALL STRUCTURAL NOTES AND DETAILS TO BE PROVIDED BY AN ENGINEER.

RESIDENCE
DONNY & MISSY
DUPREE

LAKE CITY, FLORIDA

Teena M. Ruffo
2925 SW 8R 41
Lake City Florida, 32025
Cell: (386) 861 - 1191
Email: teenaruffo@gmail.com

PRINTED DATE:
Sunday, December 19, 2021

DRAWN BY: Teena M. Ruffo
CHECKED BY:

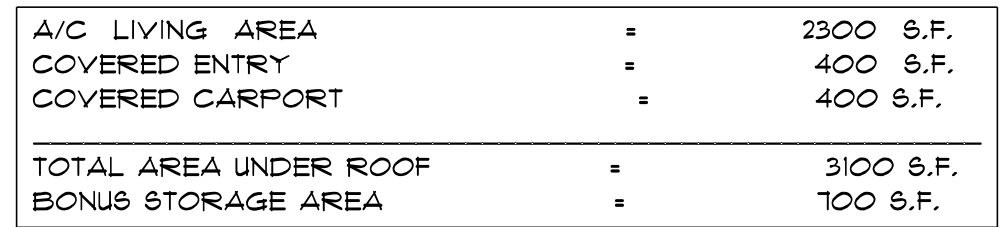
BUILDING CONTRACTOR
DUPREE CONSTRUCTION

FINAL DATE:

JOB NUMBER:

DRAWING NUMBER
A-2

OF 6 SHEETS



IMPORTANT NOTES:

1. IT IS THE BUILDERS RESPONSIBILITY TO VERIFY ALL GEOMETRY AND DIMENSIONS BEFORE ORDERING ANY MATERIALS OR BEGINNING CONSTRUCTION.
2. THESE PLANS ARE FOR LAYOUT AND DESIGN PURPOSES ONLY ALL STRUCTURAL NOTES AND DETAILS TO BE PROVIDED BY AN ENGINEER.

* M A I N *

* F L O O R P L A N *

SCALE : 1/4" = 1'-0"

RESIDENCE
DONNY & MISSY
DUPREE

LAKE CITY, FLORIDA,

Tesna M. Ruffo
2925 SW 5R 47
Lake City Florida, 32025
Cell: (386) 867 - 1191
Email: tesnaruffo@gmail.com

PRINTED DATE:
Sunday, December 19, 2021

DRAWN BY:	CHECKED BY:
-----------	-------------

BUILDING CONTRACTOR


DUPREE CONSTRUCTION

--	--

DRAWING NUMBER


A-3

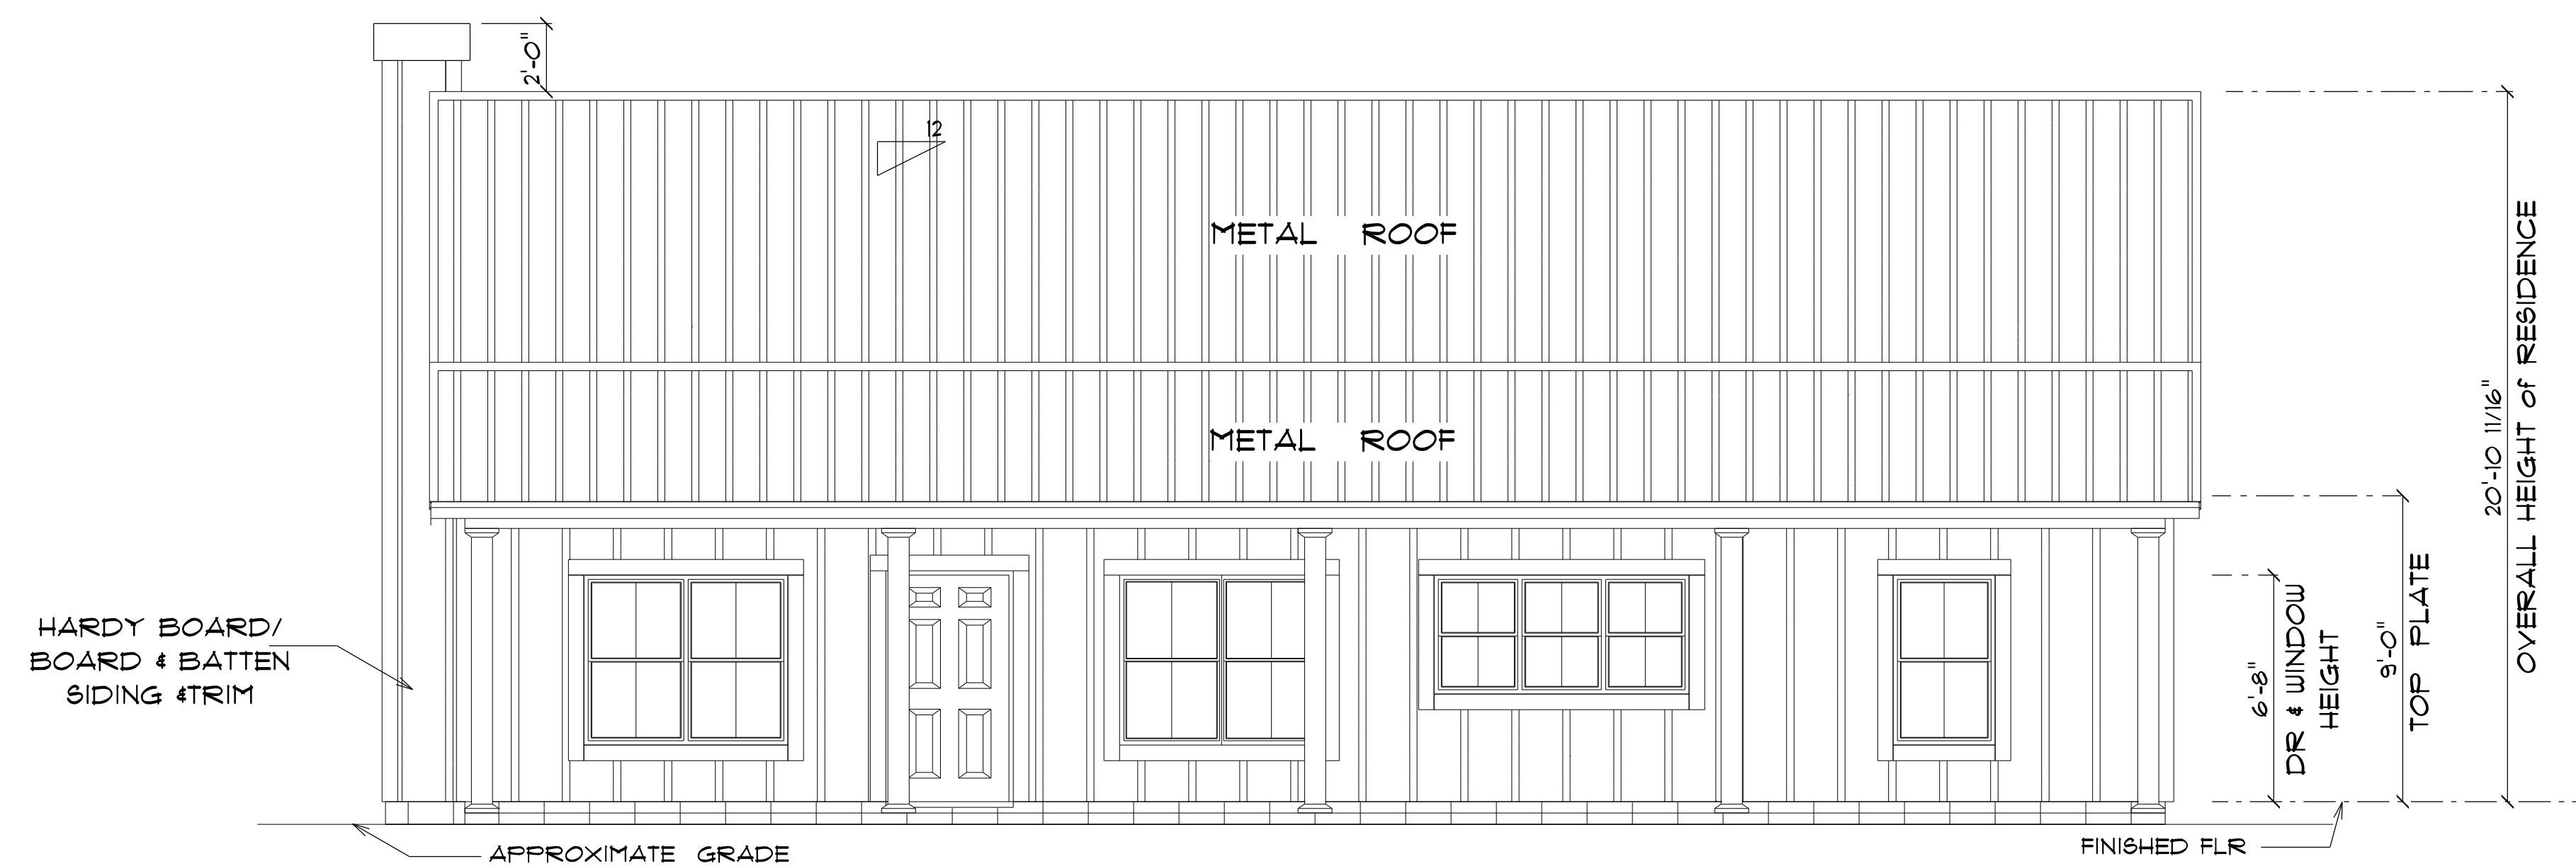OF 6 SHEETS



* FRONT ELEVATION *

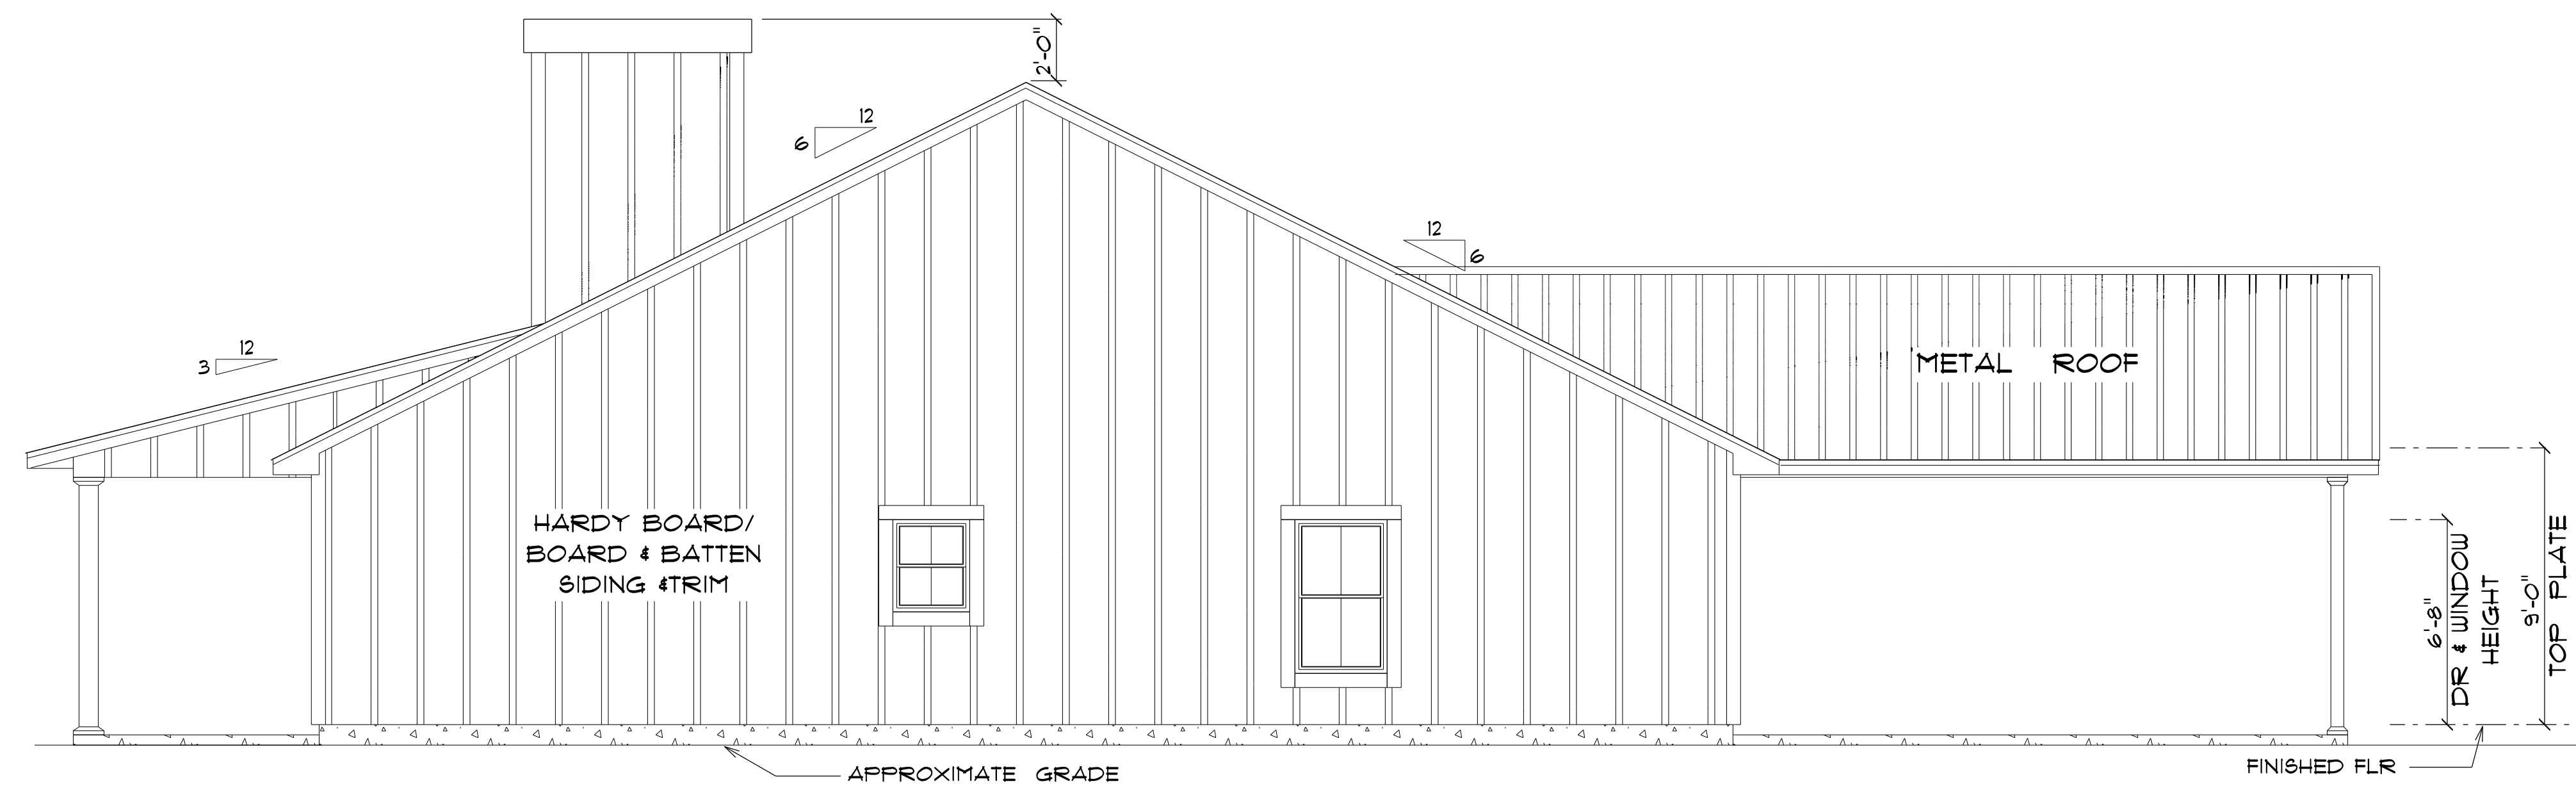SCALE : 1/4" = 1'-0"



* RIGHT ELEVATION *

SCALE : 1/4" = 1'-0"

RESIDENCE
DONNY & MISSY
DUPREE

LAKE CITY, FLORIDA

Teena M. Ruffo
2925 SW SR 47
Lake City Florida, 32025
Cell: (386) 867-1191
Email: teenaruffo@gmail.com

PRINTED DATE:
Sunday, December 19, 2021

DRAWN BY: Teena M. Ruffo CHECKED BY:

BUILDING CONTRACTOR
DUPREE CONSTRUCTION

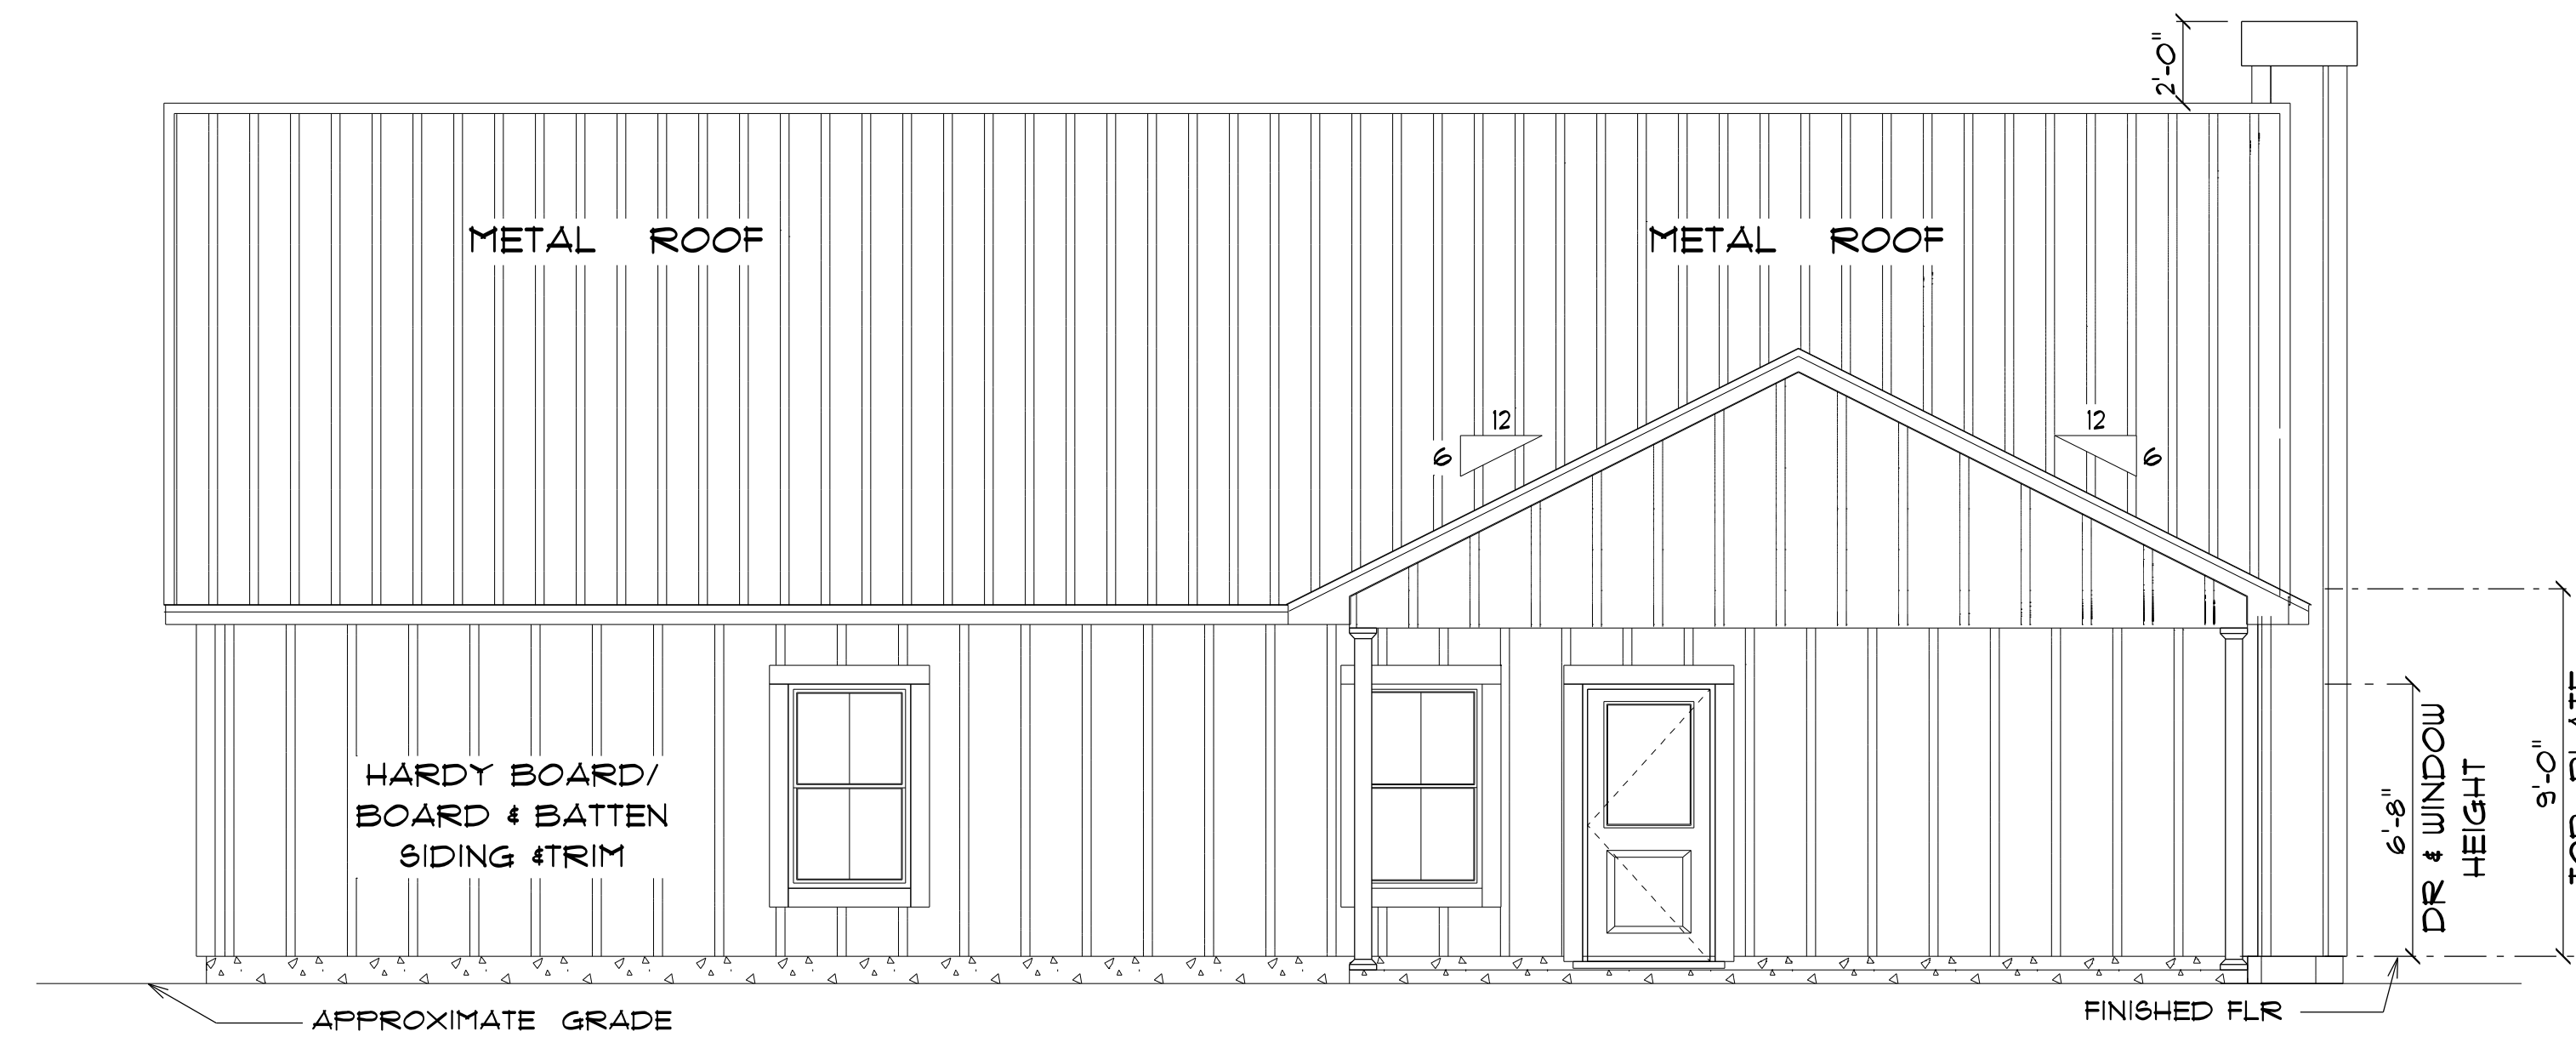
FINAL DATE:

JOB NUMBER:

DRAWING NUMBER


A-4

OF 6 SHEETS



* REAR ELEVATION *

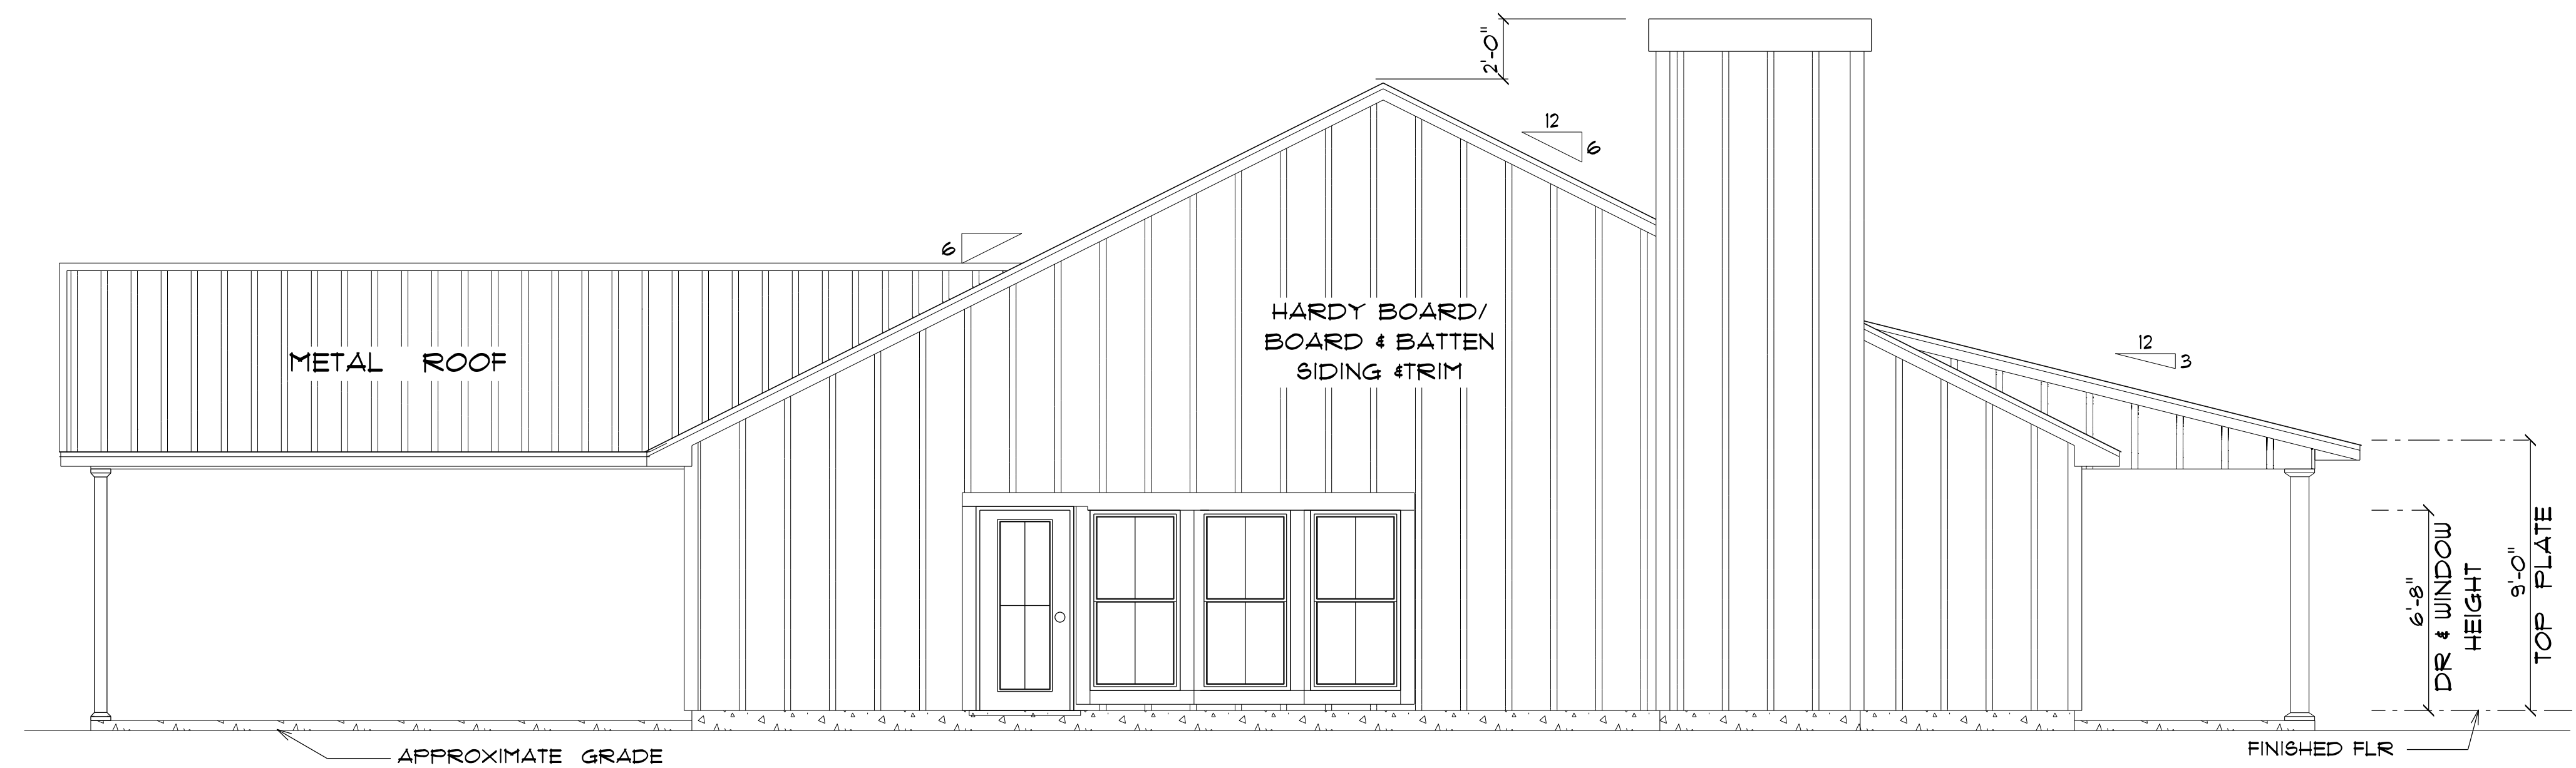SCALE : 1/4" = 1'-0"



* LEFT ELEVATION *

SCALE : 1/4" = 1'-0"

RESIDENCE
DONNY & MISSY
DUPREE

LAKE CITY, FLORIDA

Teena M. Ruffo
2925 SW 8R 41
Lake City Florida, 32025
Cell: (386) 861-1191
Email: teenaruffo@gmail.com

PRINTED DATE:
Sunday, December 19, 2021

DRAWN BY: Teena M. Ruffo CHECKED BY:

BUILDING CONTRACTOR
DUPREE CONSTRUCTION

 
 
 
 
 
 
 
 
 
 
 
FINAL DATE:

JOB NUMBER:

DRAWING NUMBER

A-5

OF 6 SHEETS

ELECTRICAL LEGEND		
ELECTRICAL	COUNT	SYMBOL
ceiling fan globe 01	11	
traditional 08	1	
pendant large	3	
pot light	10	
spotlight double	4	
Smoke Detector	4	
electrical panel	1	
dimmer switch	1	
dimmer switch 3-way	4	
light	6	
outlet	39	
outlet 220v	4	
outlet gfi	15	
outlet wp	6	
switch	24	
switch 3 way	12	
vent light combo	2	
vanity bar light 01	3	

ELECTRICAL PLAN NOTES

E-1 WIRE ALL APPLIANCES, HVAC UNITS AND OTHER EQUIPMENT PER MANUFACTURER'S SPECIFICATIONS.

E-2 ALL INSTALLATIONS SHALL BE PER NATIONAL ELECTRIC CODE.

E-3 ALL SMOKE /CARBON MONOXIDE DETECTORS SHALL BE 120V W/BATTERY BACKUP OF THE PHOTOELECTRIC TYPE, AND SHALL BE INTERLOCKED TOGETHER. INSTALL INSIDE AND NEAR ALL BEDROOMS AS PER CODE.

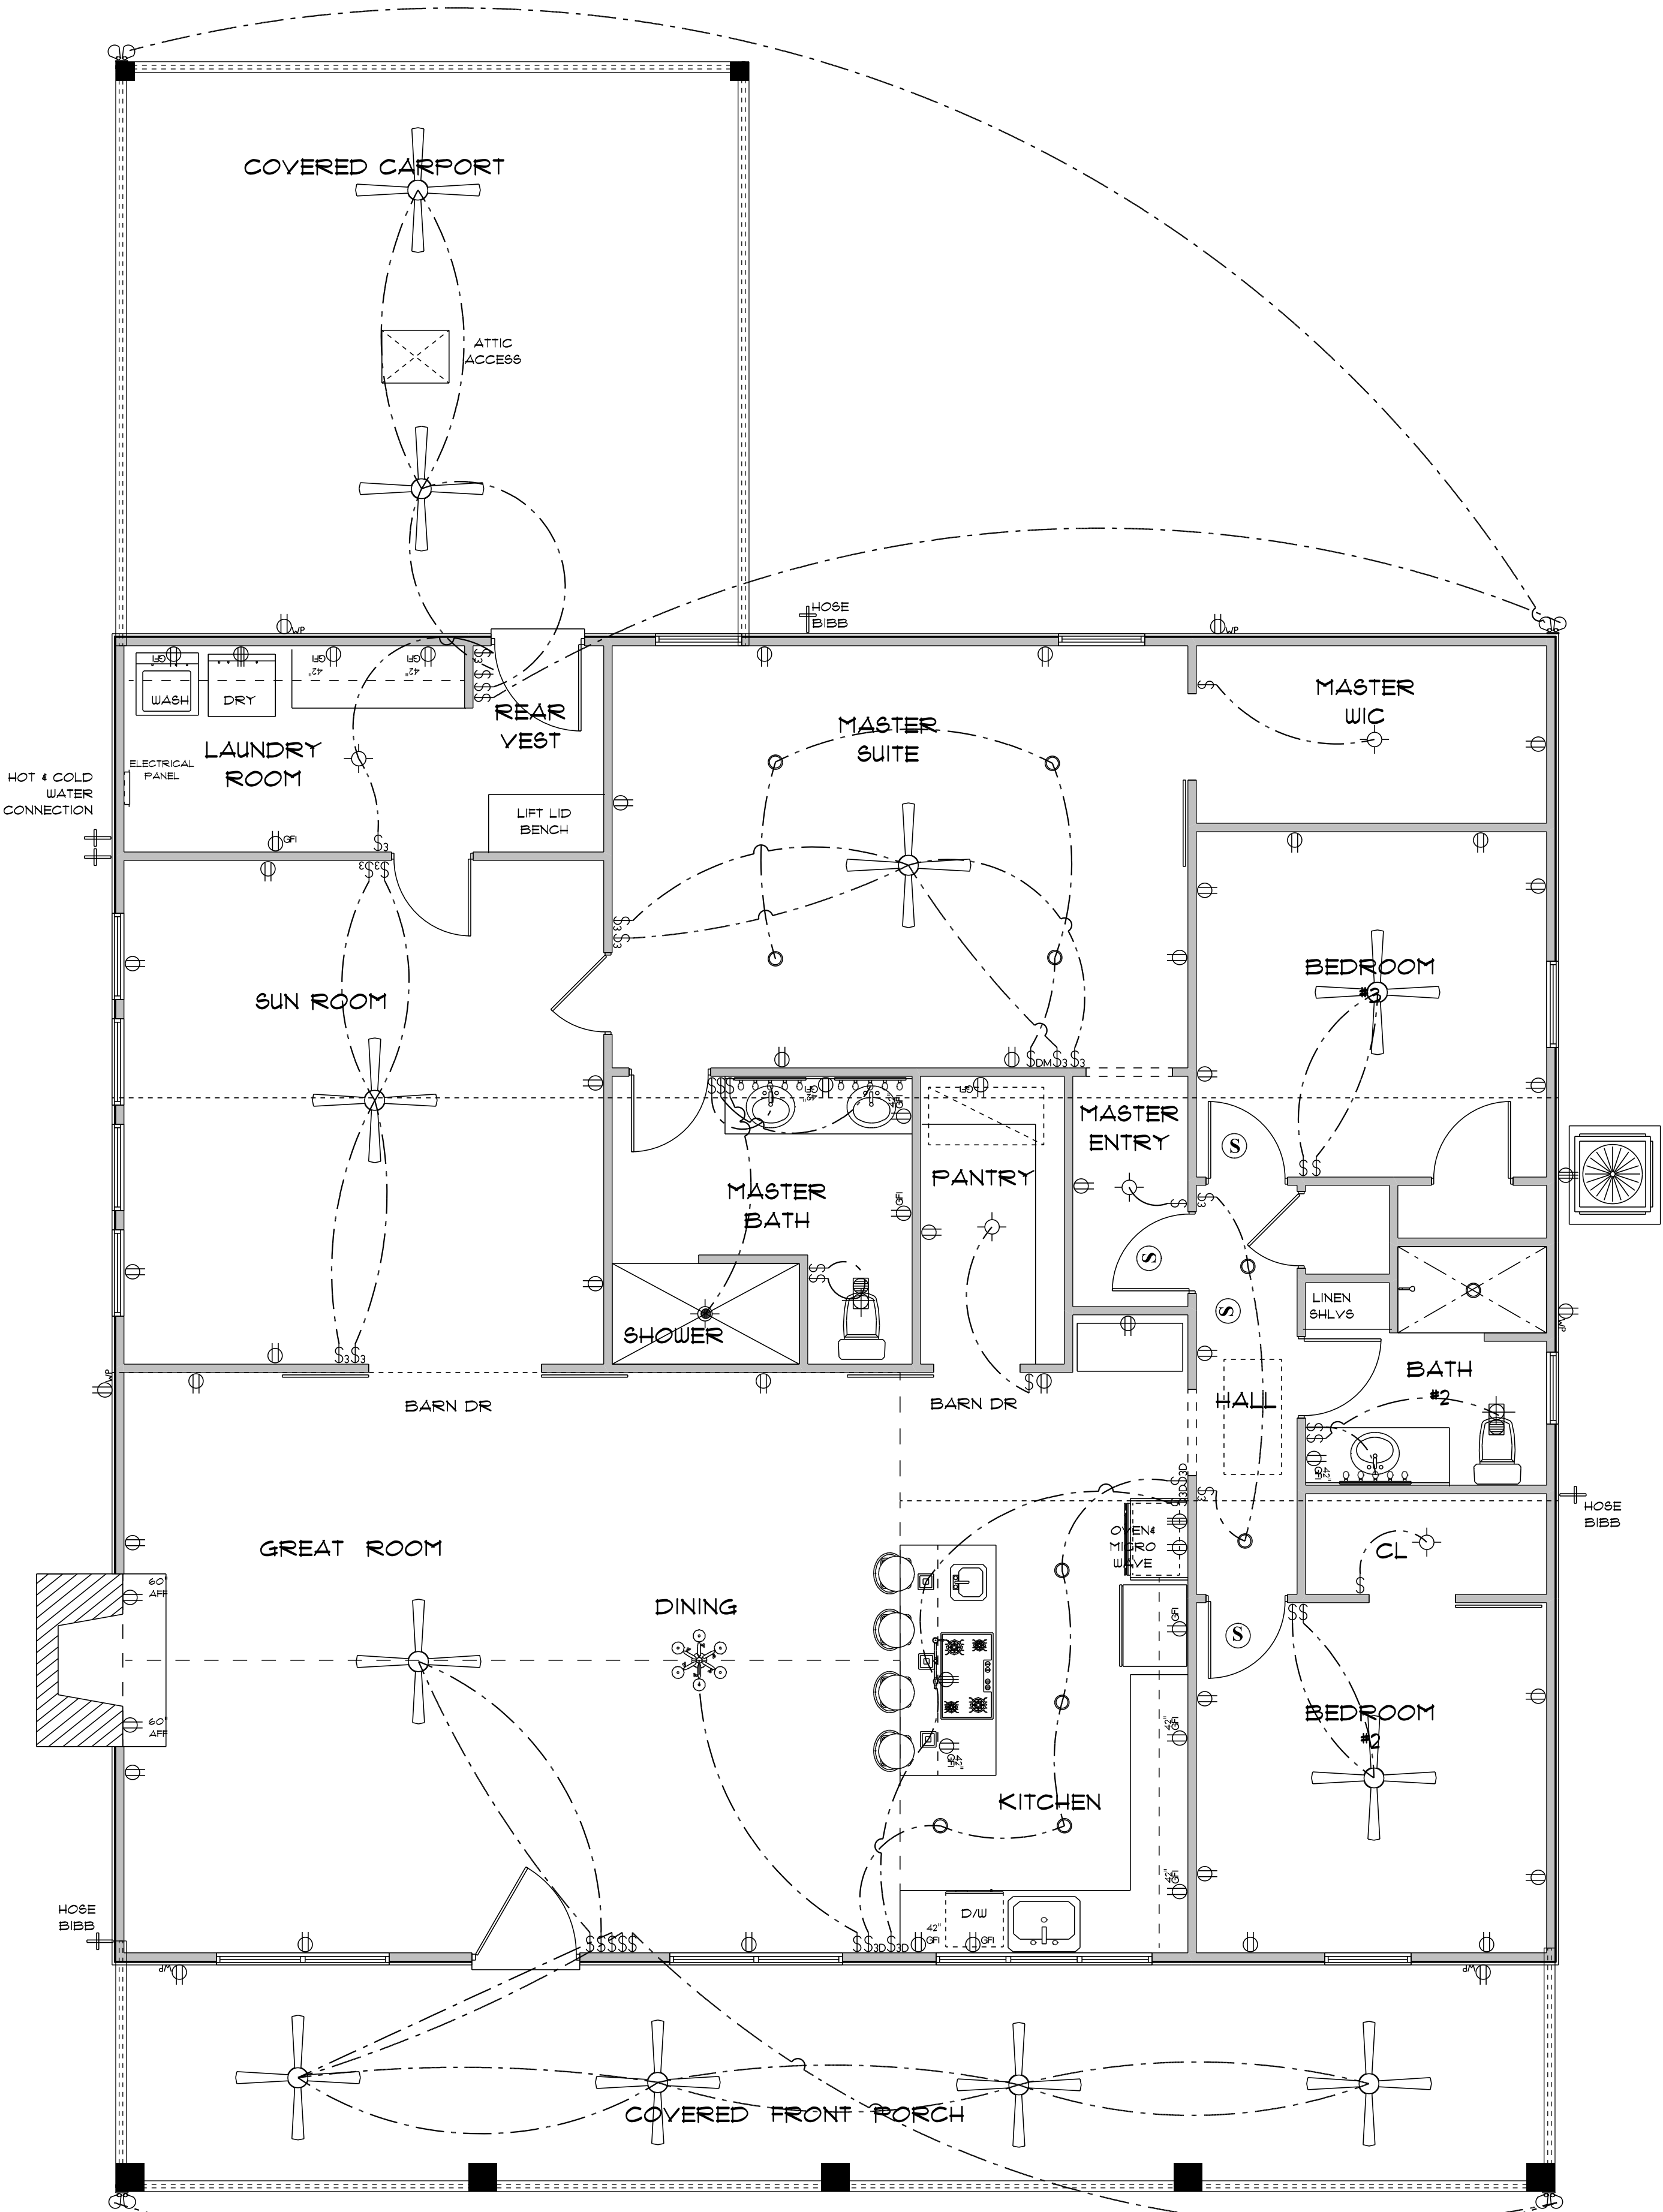
E-4 TELEPHONE, TELEVISION AND OTHER LOW VOLTAGE DEVICES OR OUTLETS SHALL BE AS PER THE OWNER'S DIRECTION AND IN ACCORDANCE WITH APPLICABLE SECTIONS OF NATIONAL ELCT. CODE LATEST EDITION.

E-5 ELECTRICAL CONTRACTOR SHALL BE RESPONSIBLE FOR THE DESIGN AND SIZING OF ELECTRICAL SERVICE AND CIRCUITS.

E-6 ENTRY OF SERVICE UNDERGROUND OR OVERHEAD) IS TO BE DETERMINED BY THE POWER COMPANY.

ALL BEDROOM RECEPTALS ARE TO BE AFCI (ARC FAULT CIRCUIT INTERRUPT)

75% OF ALL PERMANENT LIGHTS TO BE ENERGY EFFICIENT.



* ELECTRIC PLAN *
SCALE : 1/4" = 1'-0"

RESIDENCE
DONNY & MISSY
DUPREE

LAKE CITY, FLORIDA

Teena M. Ruffo
2925 SW 8R 41
Lake City Florida, 32025
Cell: (386) 861 - 1191
Email: teenaruffo@gmail.com

PRINTED DATE:
Sunday, December 19, 2021

DRAWN BY: Teena M. Ruffo

CHECKED BY:

BUILDING CONTRACTOR
DUPREE CONSTRUCTION

FINAL DATE:

JOB NUMBER:

DRAWING NUMBER

A-6

OF 6 SHEETS