


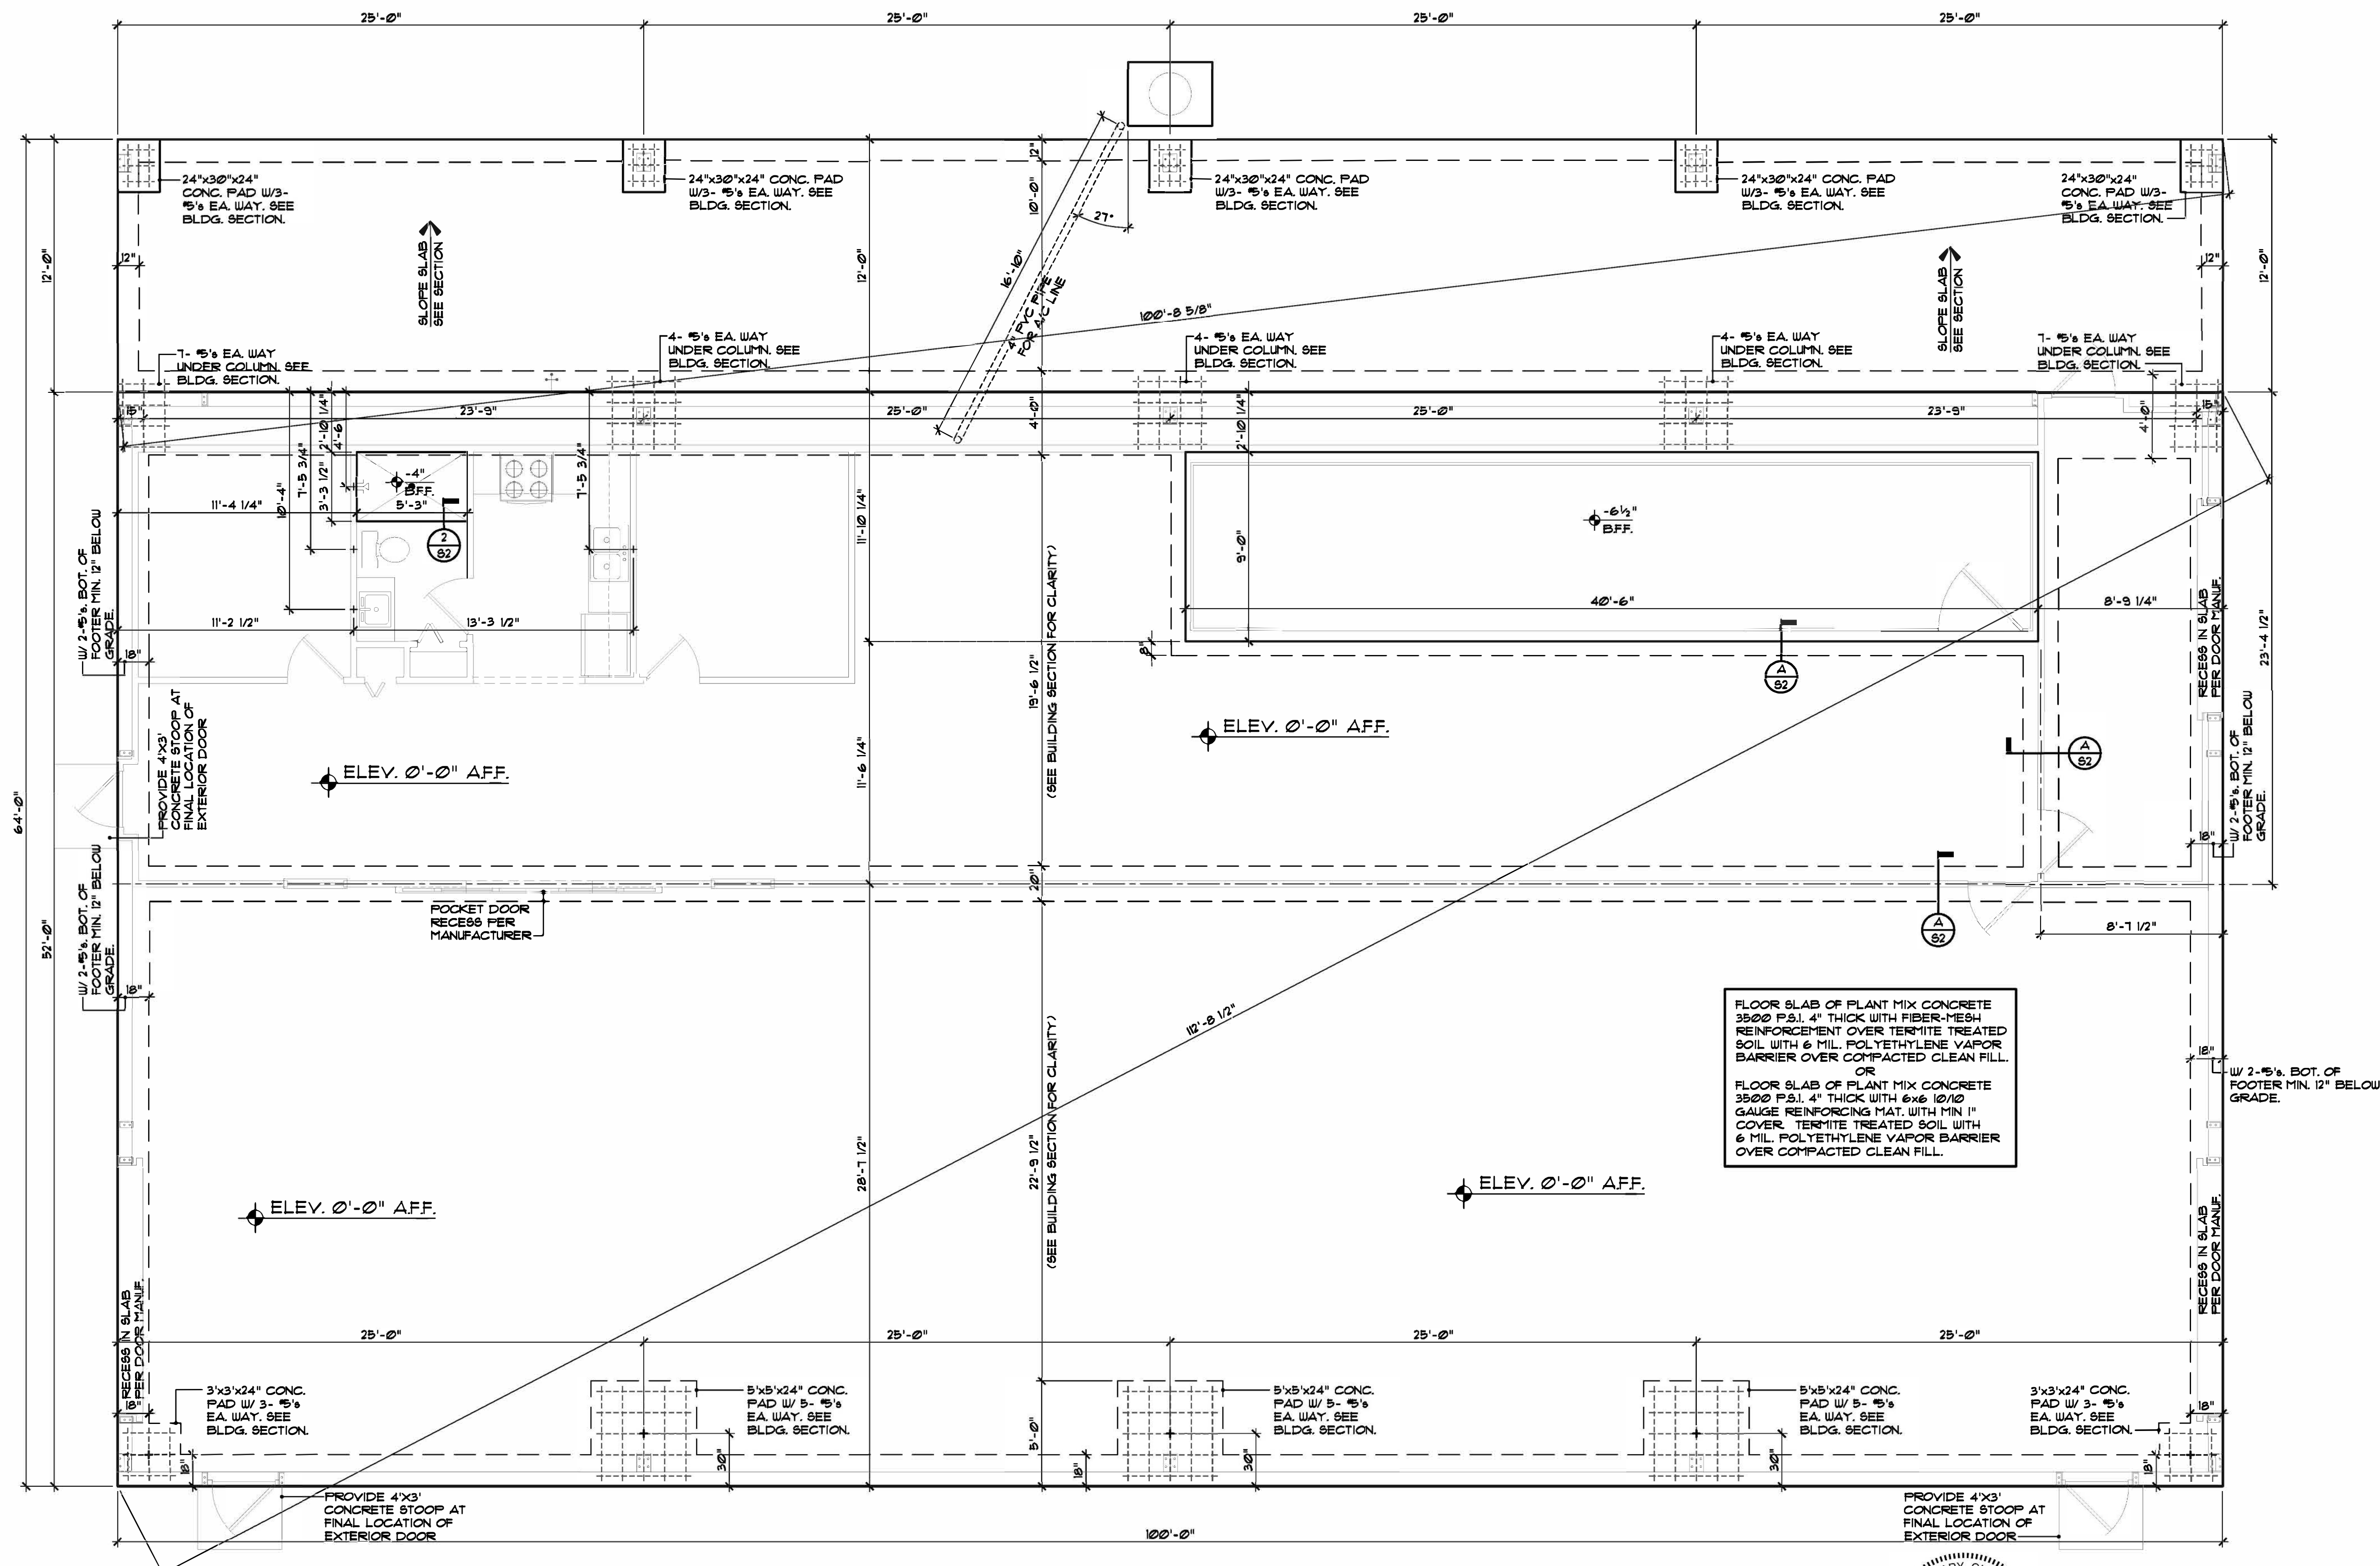

Foundation Plan
SCALE: 1/4" = 1'-0"
SEE BUILDING SECTION FOR PERIMETER FOOTERS

Digitally signed by Gary Gill
Date: 2025.05.05 14:42:24 -0400



THIS ITEM HAS BEEN DIGITALLY SIGNED AND SEALED BY GARY GILL ON THE DATE ADJACENT TO THE SEAL. PRINTED COPIES OF THIS DOCUMENT ARE NOT CONSIDERED SIGNED AND SEALED AND THE SIGNATURE MUST BE VERIFIED ON ANY ELECTRONIC COPIES.


revisions	by

DRAKE INTERIOR BUILDOUT


PARCEL: 02-66-16-03166-135 (150993)
FORT WHITE, FLORIDA

Seal
GILL ENGINEERING SERVICES, INC
AUTH # 30824
GARY GILL PE #51942
144 SW WATERFORD CT.
LAKE CITY, FL 32025
386-590-1242
job no
D1124
drawn by
DA
checked
date
04/05/25
scale
AS NOTED
drawing no.


S1

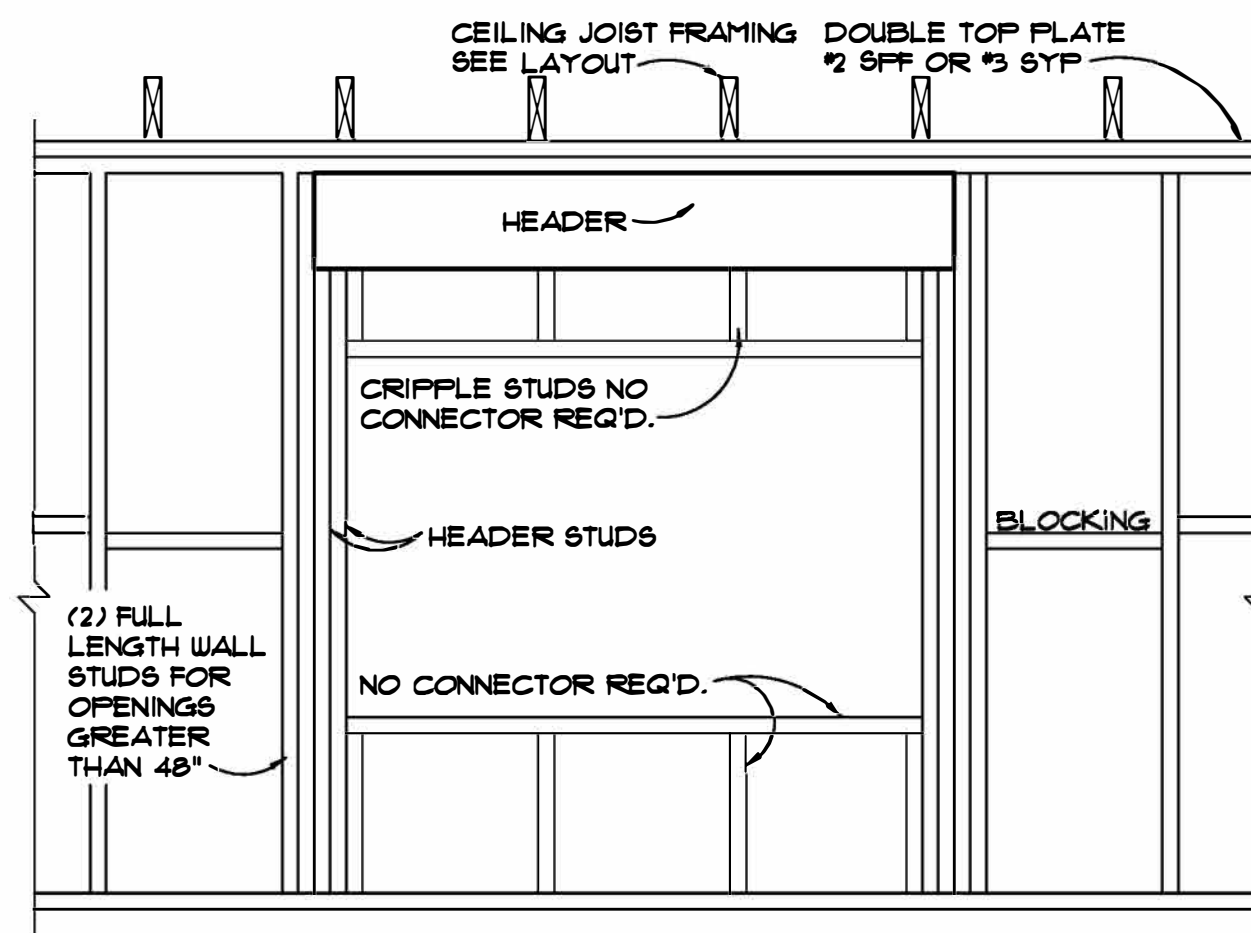

1 Bearing Opening Wood Frame
SCALE: N.T.S. NO "UPLIFT"

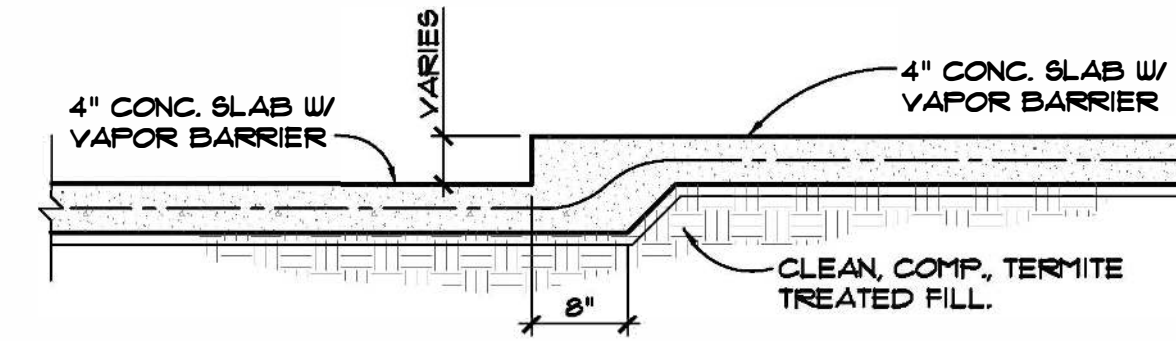

2 Step in Slab, Non Bearing
SCALE: 3/4" = 1'-0"

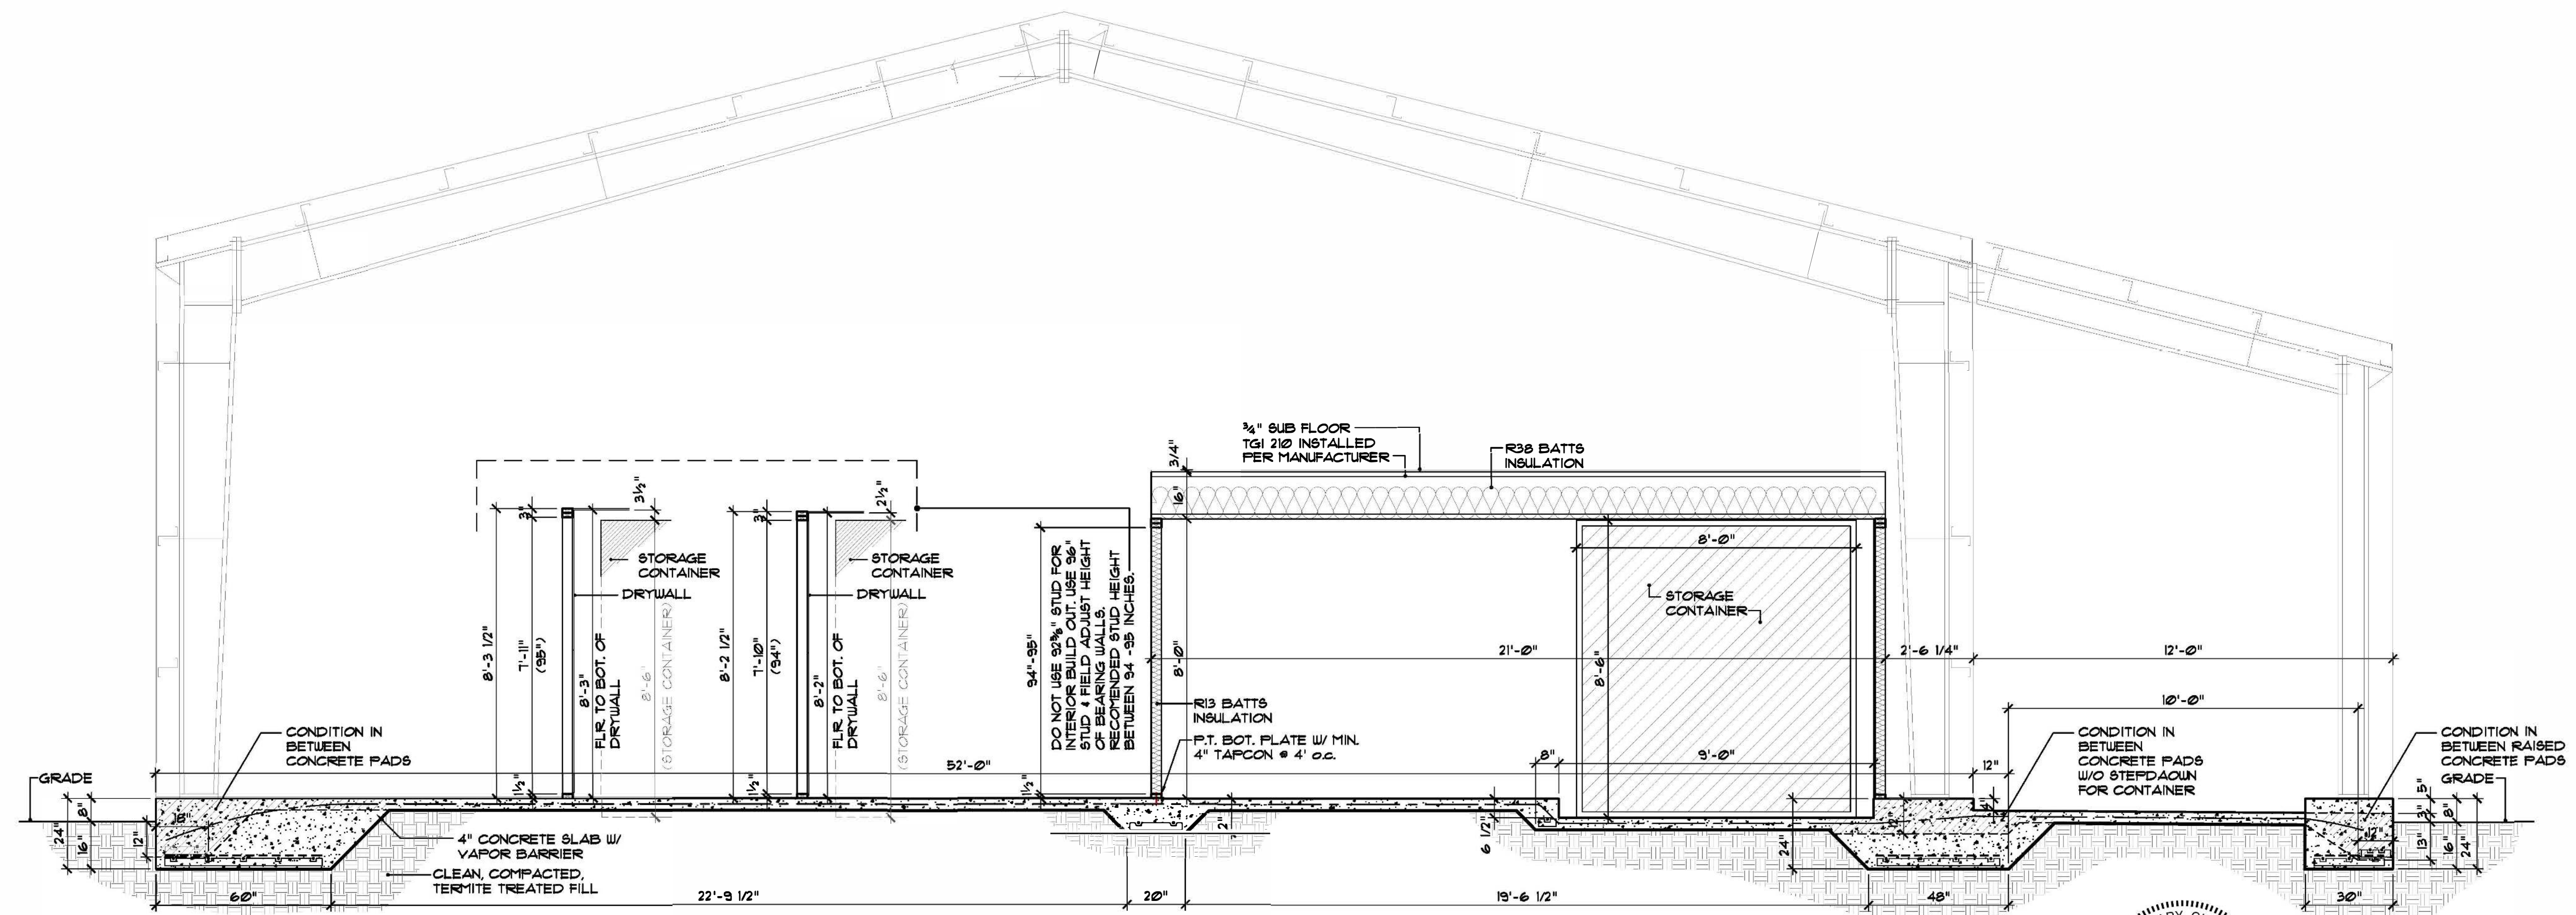

A Building Section
SCALE: 1/4" = 1'-0"

Digitally signed by Gary Gill
Date: 2025.05.05 14:42:03
-04'00'



THIS ITEM HAS BEEN DIGITALLY SIGNED AND SEALED BY GARY GILL ON THE DATE ADJACENT TO THE SEAL. PRINTED COPIES OF THIS DOCUMENT ARE NOT CONSIDERED SIGNED AND SEALED AND THE SIGNATURE MUST BE VERIFIED ON ANY ELECTRONIC COPIES.


revisions	by

DRAKE INTERIOR BUILDOUT
PARCEL: 02-66-16-03166-135 (15093)
FORT WHITE, FLORIDA

job no	D1124
drawn by	DA
checked	
date	04/05/25
scale	AS NOTED
drawing no.	


S2

THE OFFICIAL RECORD OF THIS SHEET IS THE ELECTRONIC FILE DIGITALLY SIGNED AND SEALED UNDER RULE 61G15-23.004, F.A.C. ENGINEERING SCOPE IS LIMITED TO WIND LOAD CALCULATIONS, STRUCTURAL ELEMENTS, AND COMPONENTS.

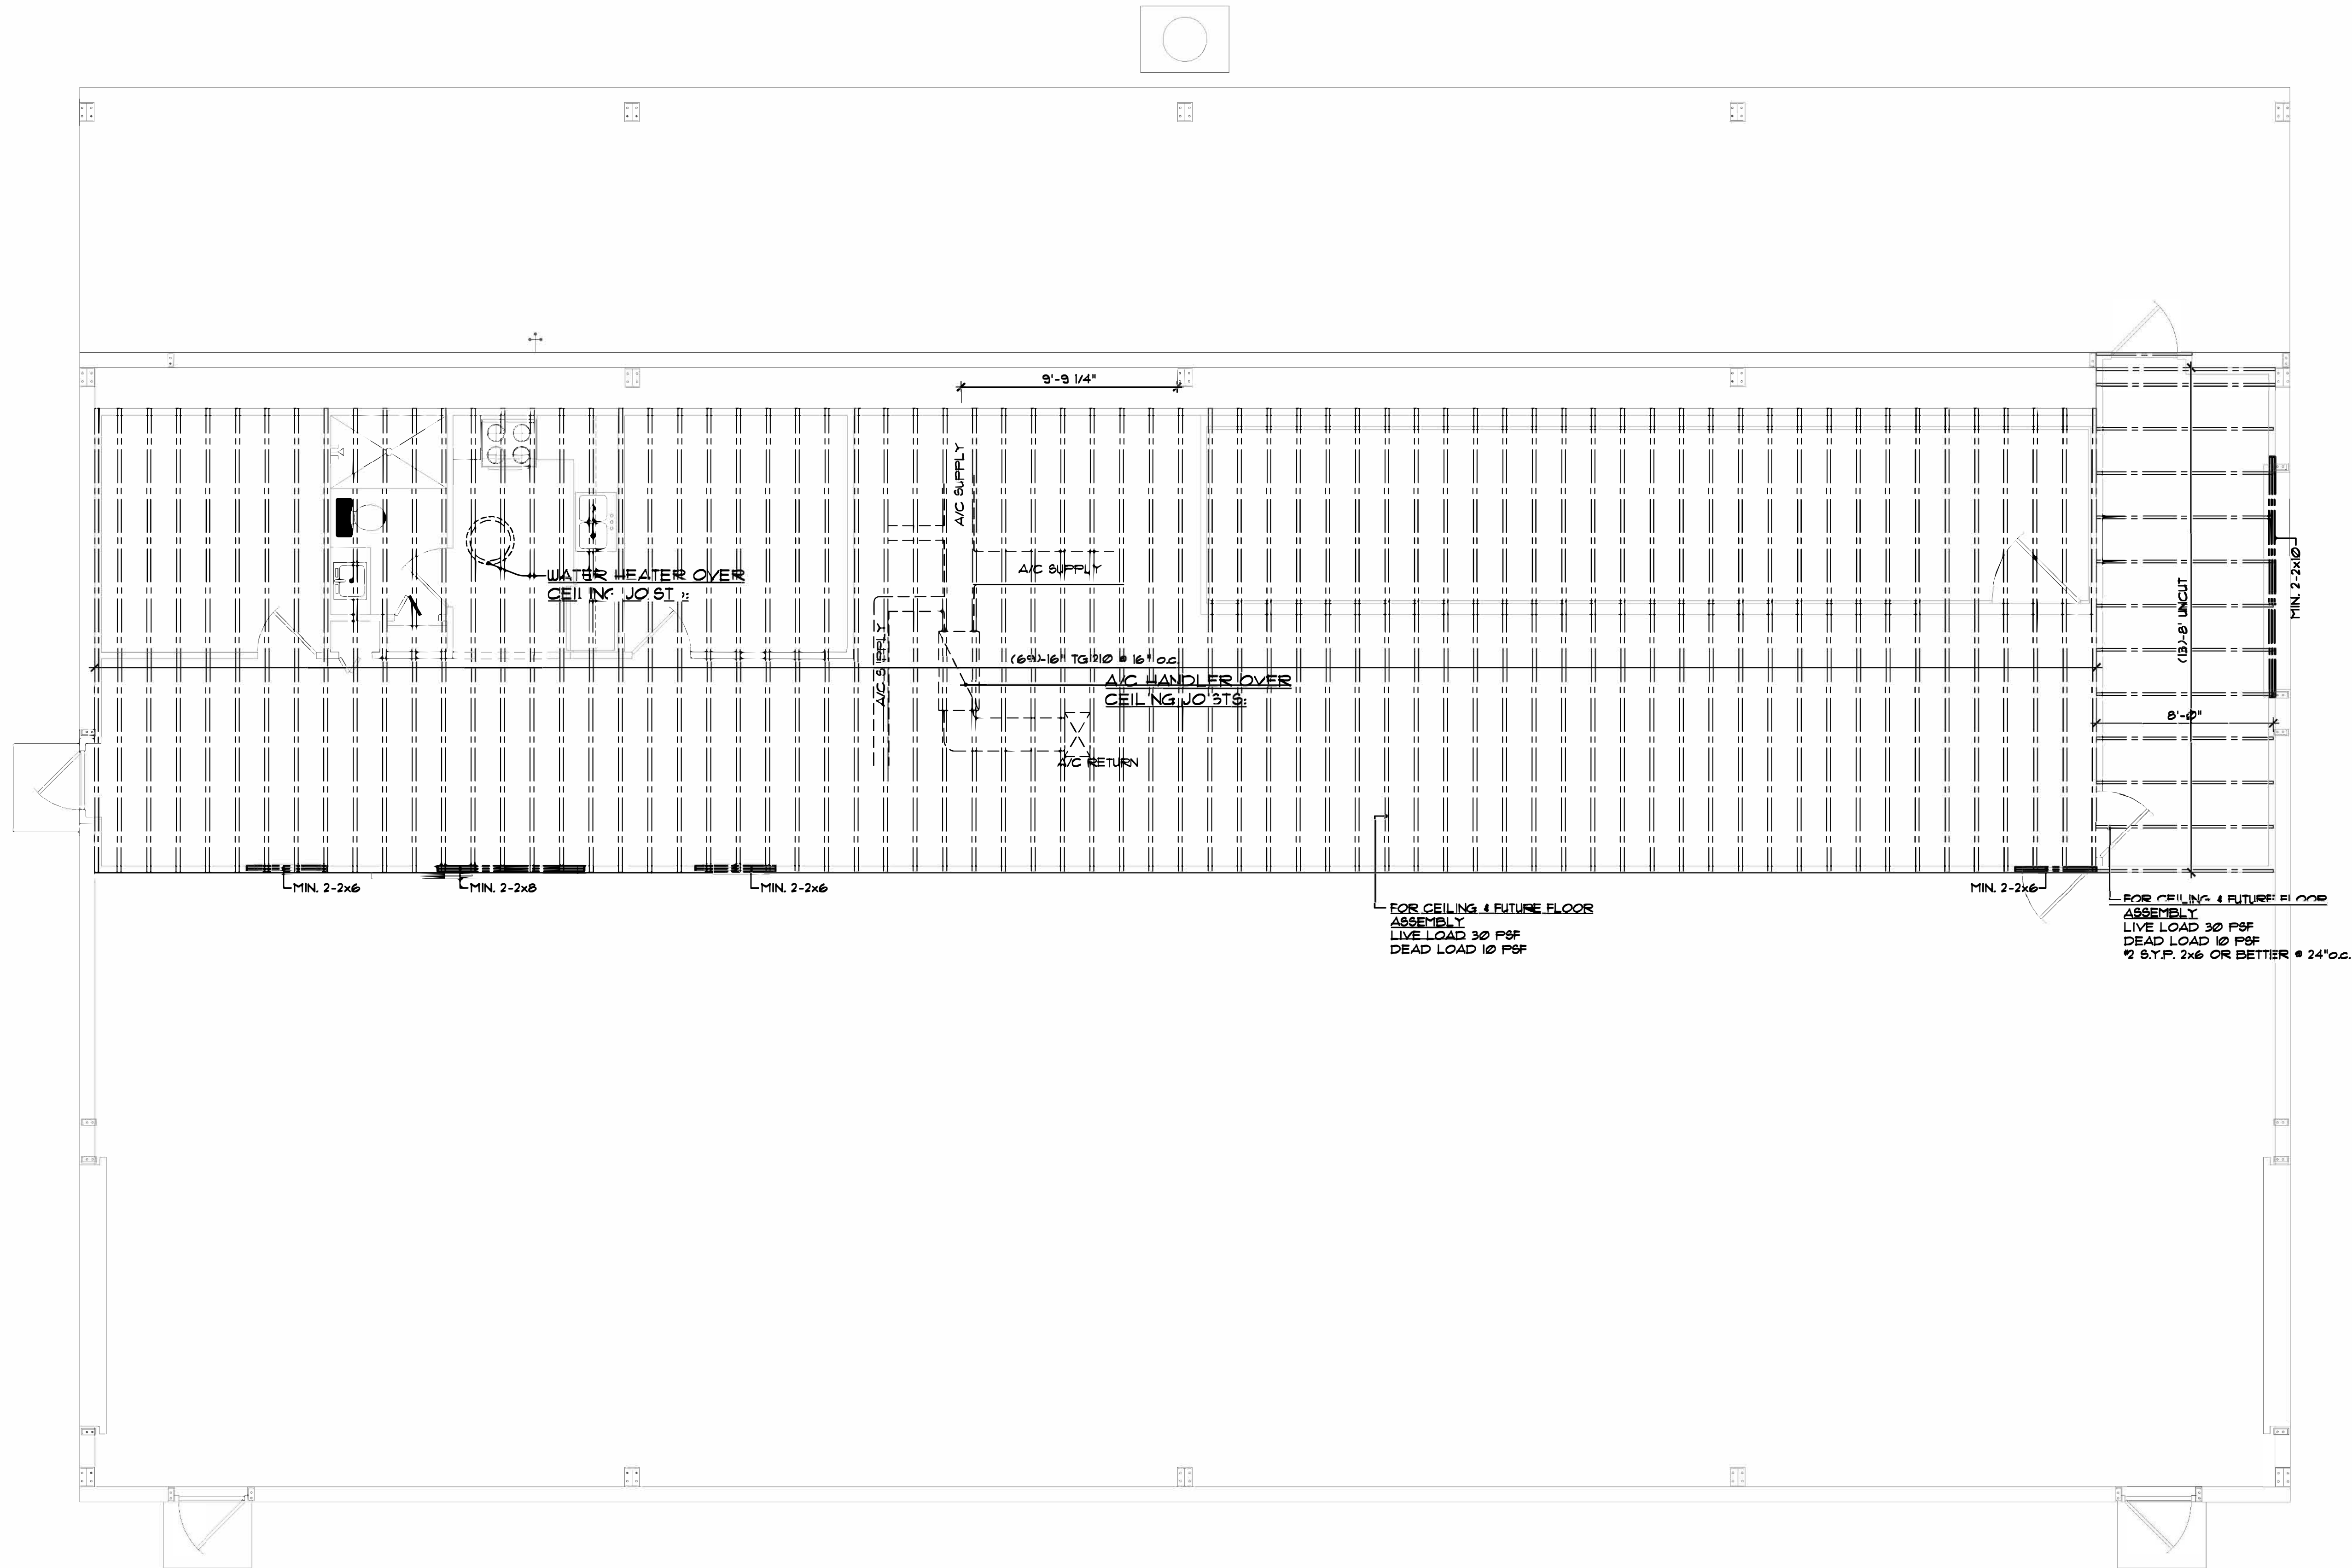

A Ceiling Framing Plan
SCALE: 1/4" = 1'-0"

Digitally signed by Gary Gill
Date: 2025.05.05 14:42:20
-04'00'

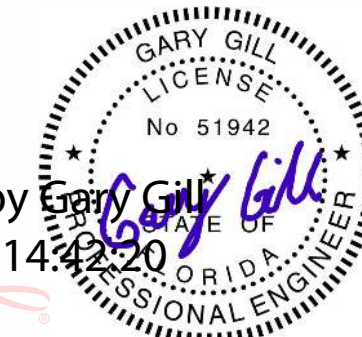

THIS ITEM HAS BEEN DIGITALLY SIGNED AND SEALED BY GARY GILL ON THE DATE ADJACENT TO THE SEAL. PRINTED COPIES OF THIS DOCUMENT ARE NOT CONSIDERED SIGNED AND SEALED AND THE SIGNATURE MUST BE VERIFIED ON ANY ELECTRONIC COPIES.

revisions	by

DRAKE INTERIOR BUILDOUT

PARCEL: 02-46-16-03166-135 (150993)
PORTLAND, FLORIDA

Seal
GILL ENGINEERING
SERVICES, INC
AUTH # 30824
GARY GILL PE #51942
144 SW WATERFORD CT.
LAKE CITY, FL 32025
386-590-1242

job no
D1124
drawn by
DA
checked
date
04/05/25
scale
AS NOTED
drawing no.

S3