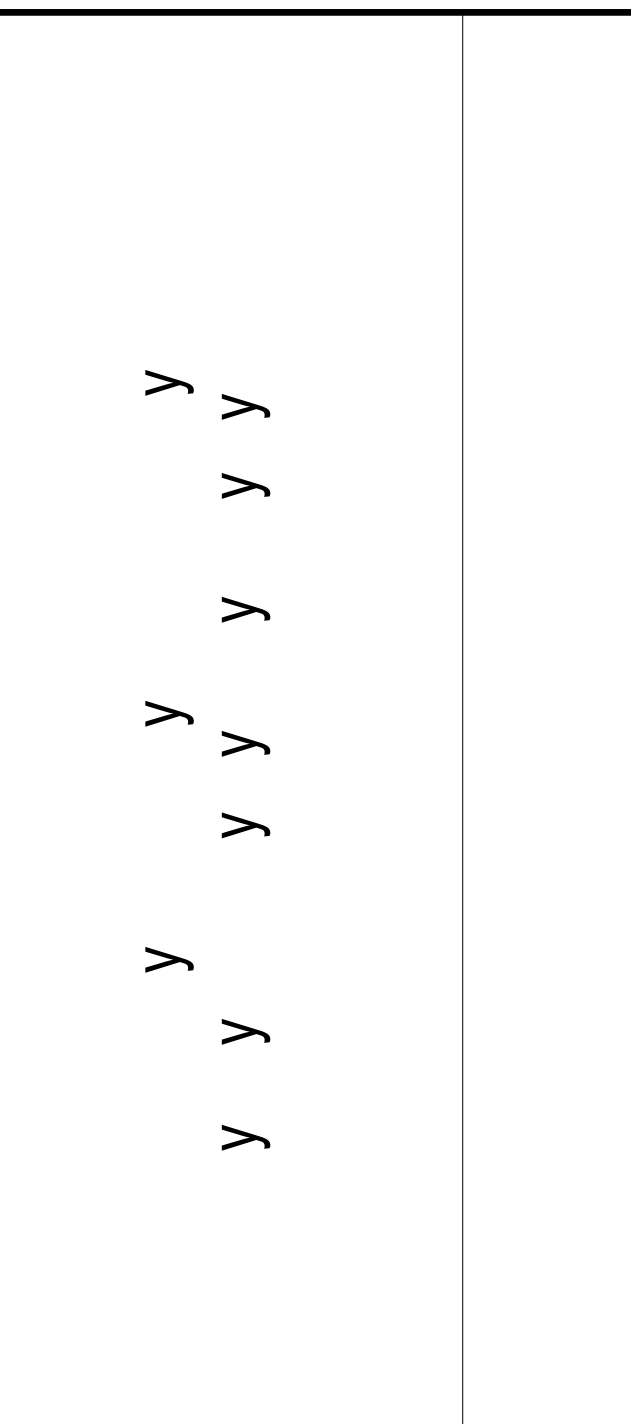


This item has been electronically signed and sealed by the individual named above, using a dated Digital Signature in the space below, per F.A.C. Rule 1G15-23.004. Printed copies of this document are not considered signed and sealed, and the signature must be verified on any electronic copies.

Christopher Floegel  
Digitally signed by Christopher Floegel  
DN: cn=Christopher Floegel,  
o=ALC, ou=ALC, email=chris.floegel@alc.com,  
c=US  
Date: 2023.07.23 09:20:11 -0400

[illegible]

DRAWN BY	D PETERSON
APPROVED BY	F ROBERTSON
CHECKED BY	F GARDNER
DATE	JULY 24, 2020

UPPER TIER  
PLUMBING PLAN -  
AREA C

# P-121C

SHEET NO. \_\_\_\_\_

DESTROY AFTER USE

1 UPPER TIER PLUMBING PLAN - AREA C  
Scale: 1/8" = 1'-0"