


REVISIONS

SOFTPLAN
ARCHITECTURAL DESIGN SOFTWARE

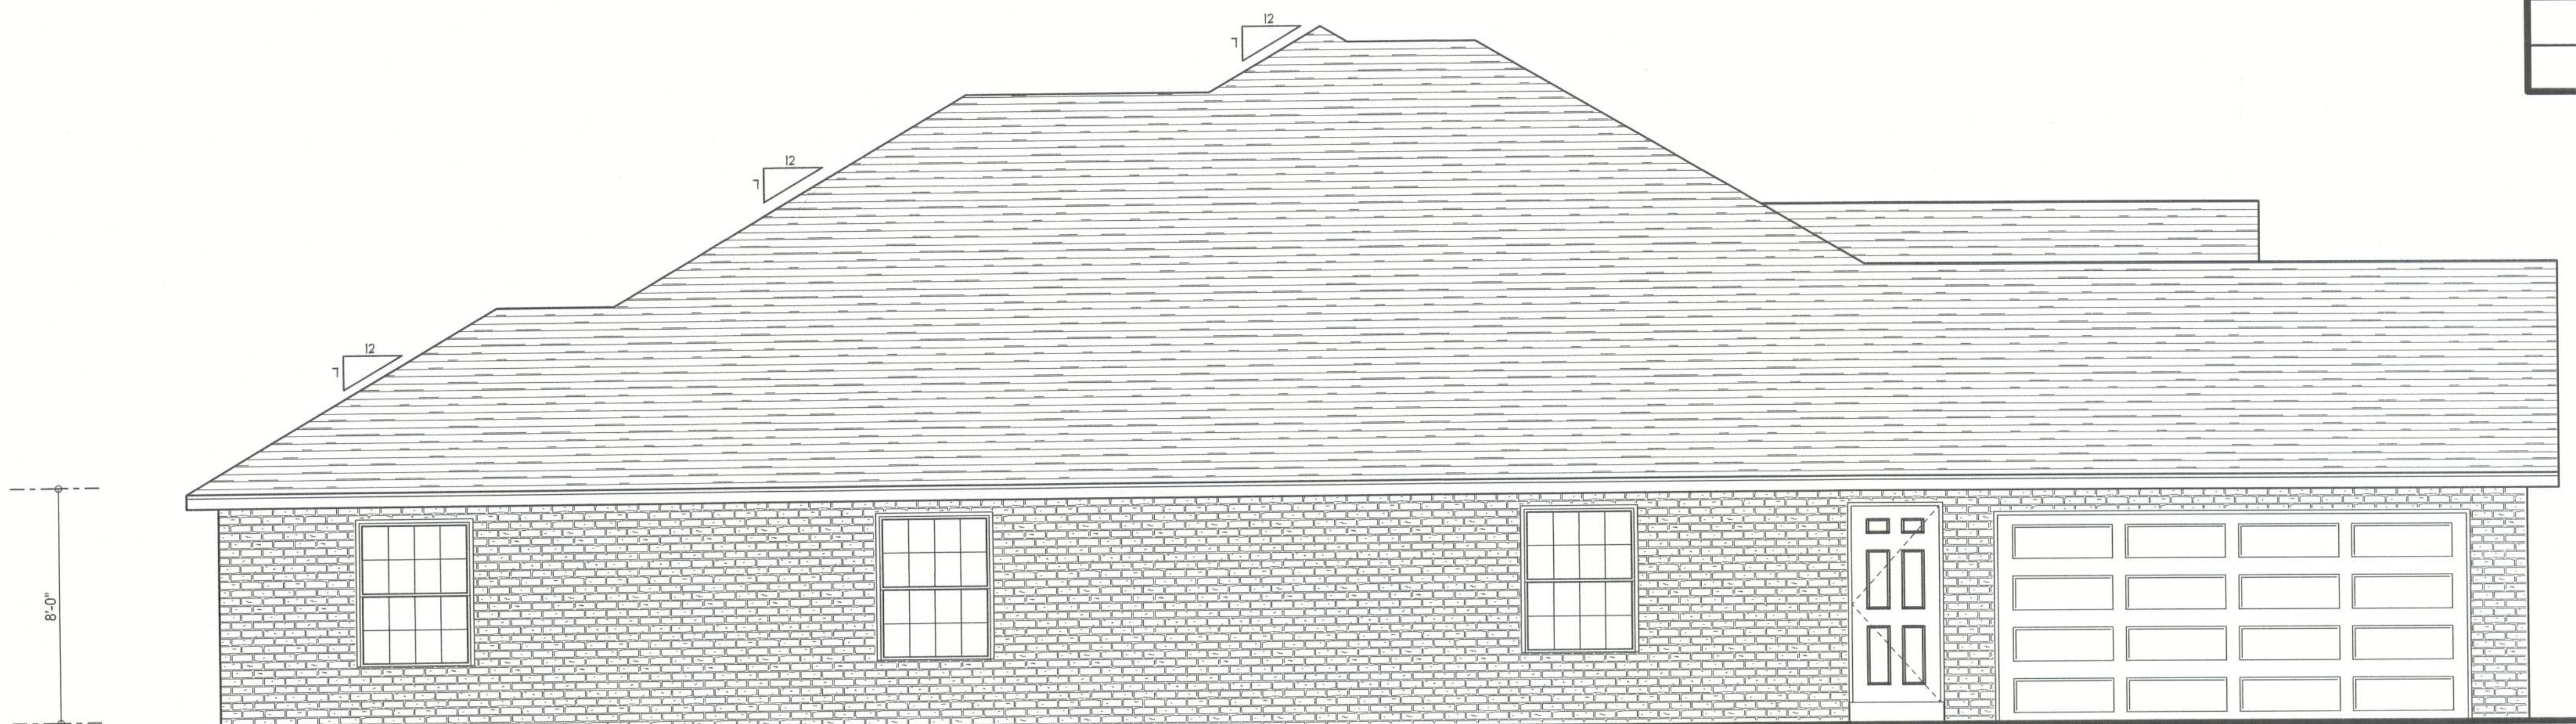

LEFT ELEVATION
SCALE: 1/4" = 1'-0"



RIGHT ELEVATION
SCALE: 1/4" = 1'-0"



FRONT ELEVATION
SCALE: 1/4" = 1'-0"



REAR ELEVATION
SCALE: 1/4" = 1'-0"

REQUIRED VENTILATION SCHEDULE:
AS PER FLORIDA BUILDING CODE 2309.7

RIDGE VENT
MIN. 50% TOTAL VENT AREA
LOCATED IN THE UPPER PORTION OF ATTIC (MIN. 3' ABOVE EAVE)
3472 S.F. / 300 x 50% = 6 S.F. RIDGE VENT AREA REQUIRED
54 FEET OF RIDGE VENT REQUIRED

SOFFIT VENT
3472 S.F. / 300 x 50% = 6 S.F. SOFFIT VENT AREA REQUIRED
200 FEET OF SOFFIT VENT REQUIRED

BUILDER MUST VERIFY THE FOLLOWING MINIMUM NET FREE VENT AREAS:

1. RIDGE VENTS = 16 IN2/FT (11 FT2/FT)
2. OFF-RIDGE VENTS = .70 FT2 PER 4' UNIT
3. SOFFIT VENTS = 4.3 IN2/FT (.03 FT2/FT)

WINDLOAD ENGINEER: Mark Disosway,
PE No. 53915, PCB 868, Lake City, FL
32056, 386-754-5419

DIMENSIONS:
Stated dimensions supercede scaled
dimensions. Refer all questions to
Mark Disosway, P.E. for resolution.
Do not proceed without clarification.

COPYRIGHTS AND PROPERTY RIGHTS:
Mark Disosway, P.E. hereby expressly reserves
its common law copyrights and property right in
these instruments of service. This document is
not to be reproduced, altered or copied in any
form or manner without first the express written
permission and consent of Mark Disosway.

CERTIFICATION: I hereby certify that I have
examined this plan, and that the applicable
portions of the plan, relating to wind engineering
comply with section 1606, Florida building code
2001, to the best of my knowledge.

LIMITATION: This design is valid for one
building, at specified location.

MARK DISOSWAY
P.E. 53915

Mark Disosway
27 SEP 05
SEAL

ERKINGER
BUILDERS

Phillip & Cathy
Wooley Residence

ADDRESS:
099-02-000, Columbia County, FL

Mark Disosway P.E.
P.O. Box 868
Lake City, Florida 32056
Phone: (386) 754 - 5419
Fax: (386) 269 - 4871

PRINTED DATE:
September 27, 2005

DRAWN BY: David Disosway
CHECKED BY:

FINALS DATE:
20 / Sep / 05

JOB NUMBER:
508031

DRAWING NUMBER

A-1

OF 6 SHEETS