


PROFESSIONAL
BUILDING DESIGN

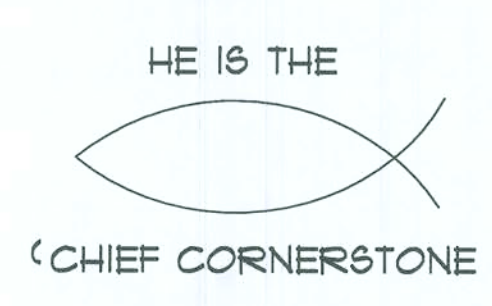


JANUARY S. JERNIGAN
119 SW JOHN STREET
LIVE OAK, FL 32064
PHONE: 386-208-1340
E-MAIL: skydesigns@alltel.net



A RESIDENCE FOR:
BILL & MARY ROGERS

SHEET INDEX:

FLOOR PLAN	1
FOUNDATION PLAN	2
ELECTRICAL PLAN	3
ELEVATIONS	4
DETAILS: PROVIDED BY OTHERS	

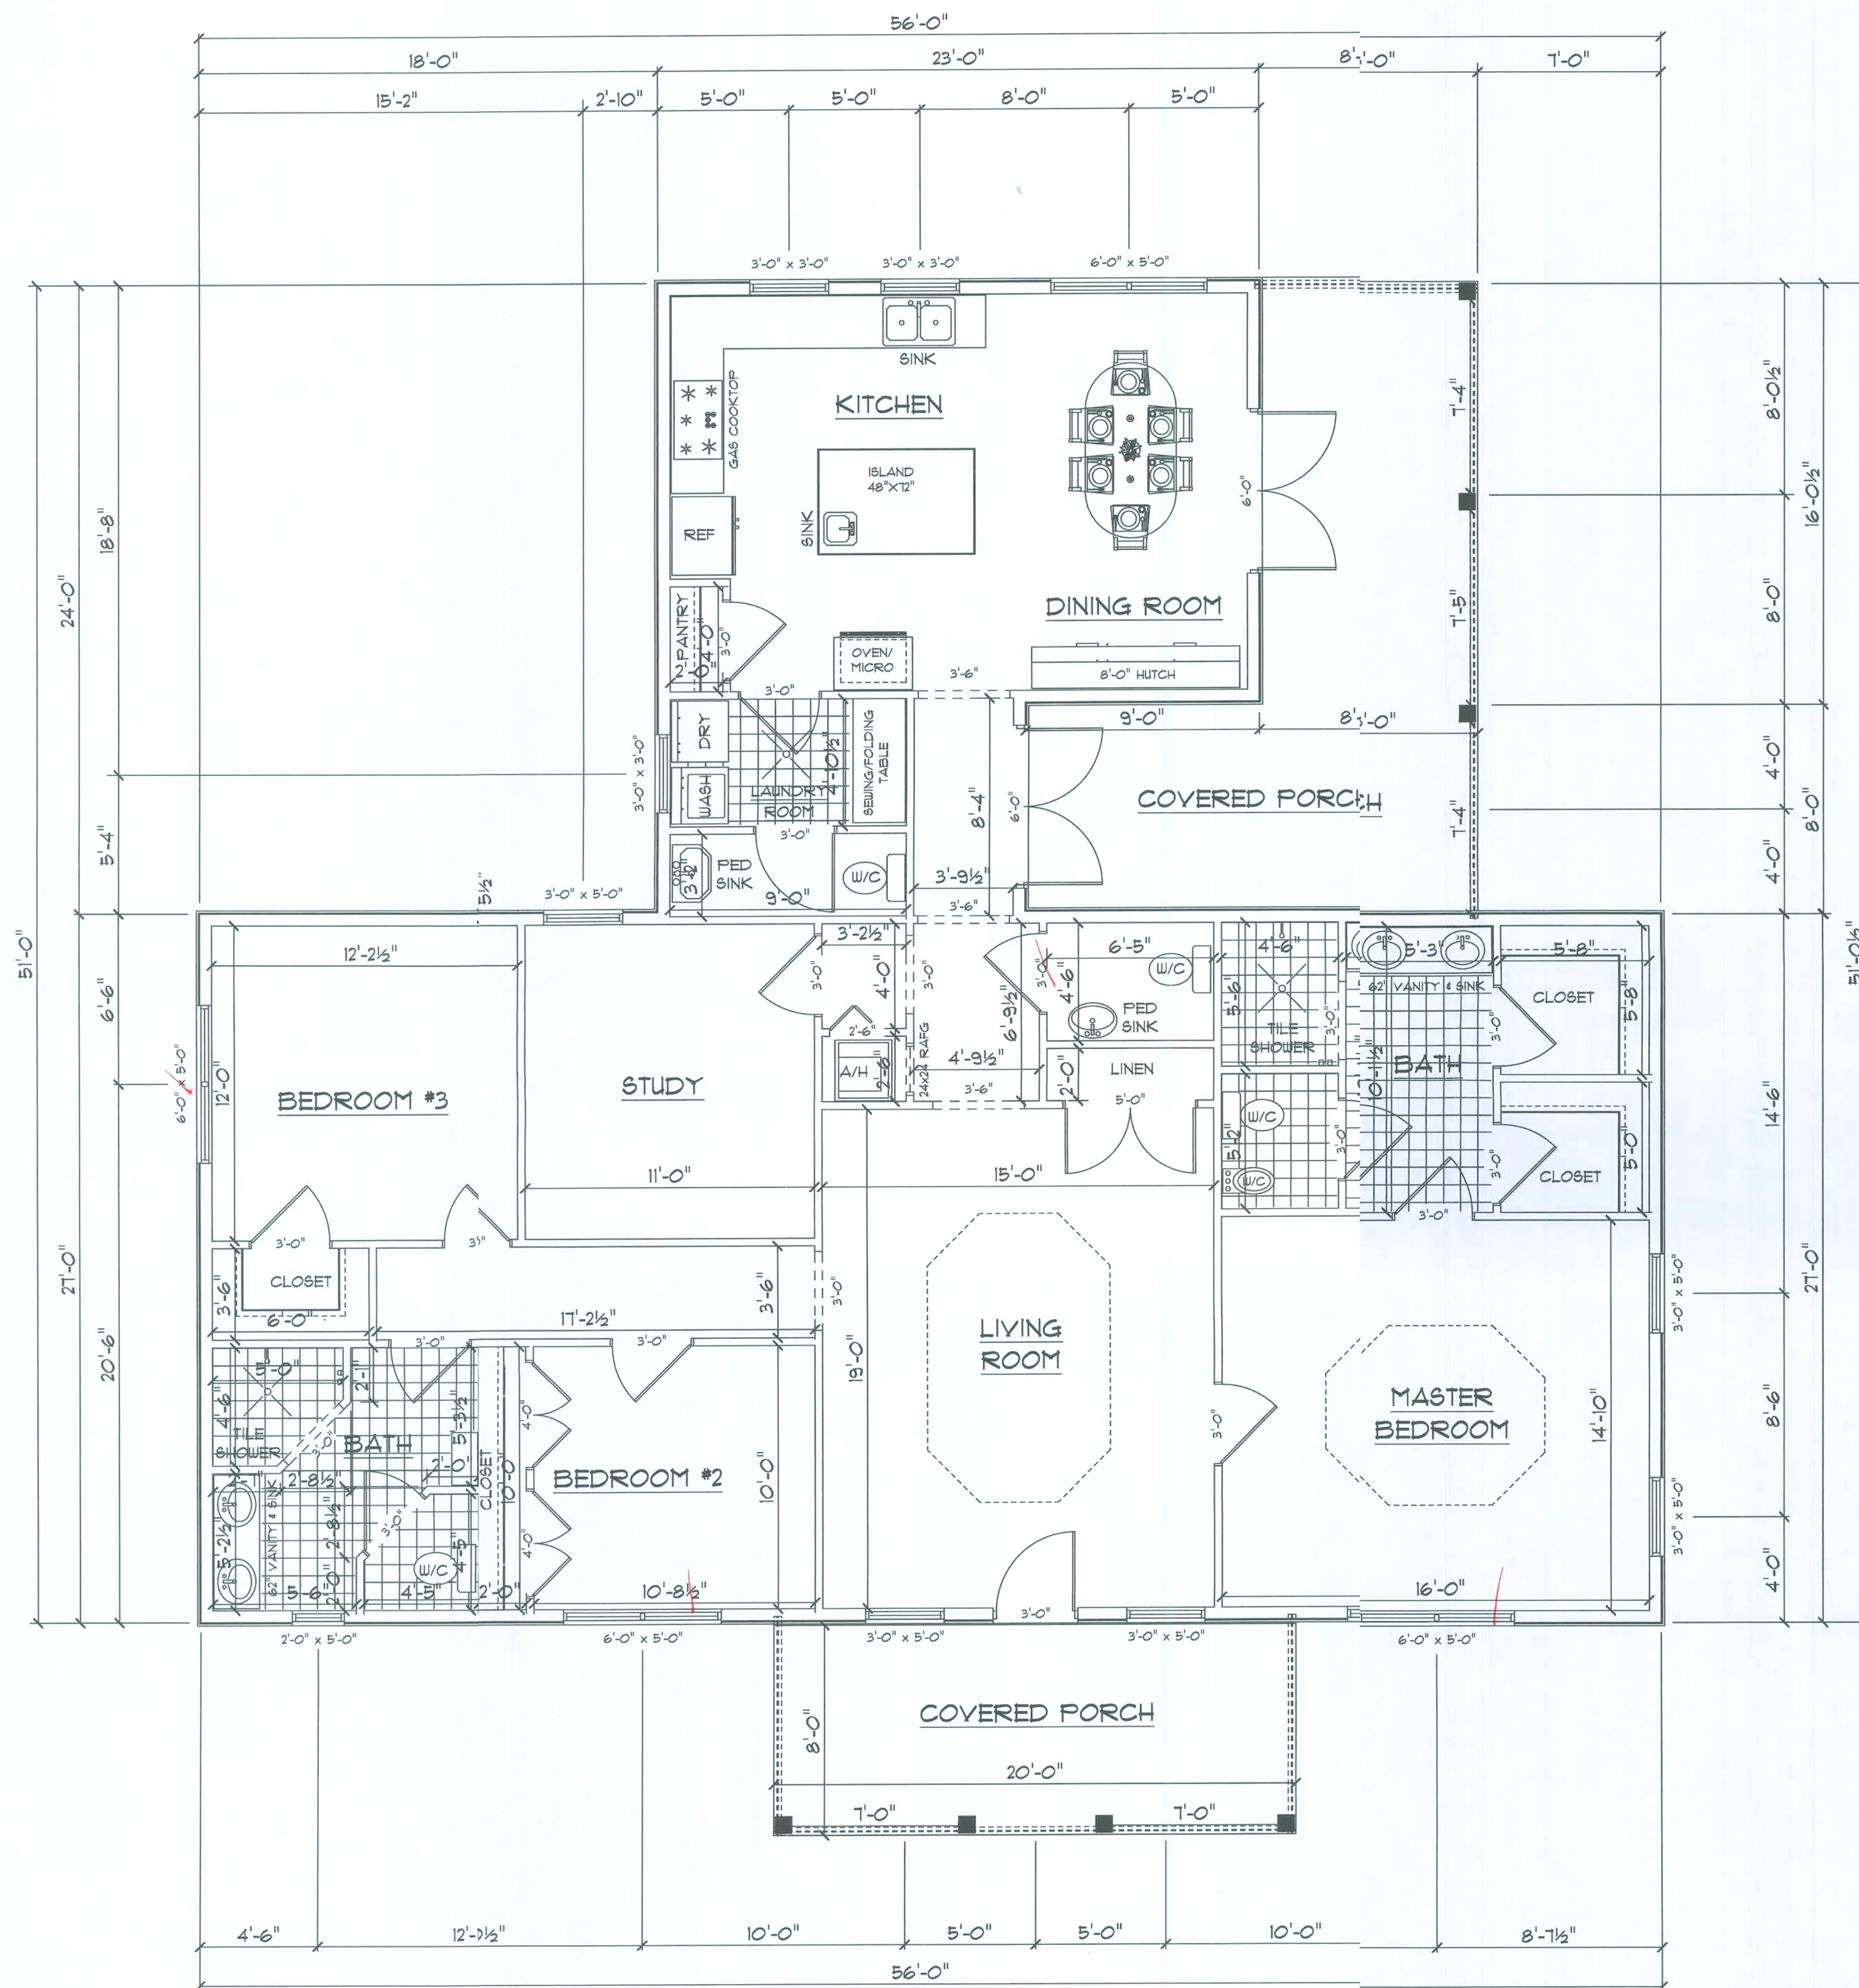

AREA TABULATION

HEATED AREA:	1,992 SF
PORCH AREA:	428 SF
TOTAL PROJECT AREA:	2,420 SF

OPENING SCHEDULE

PRODUCT CODE	SIZE	COUNT
30X80 BIFOLD COLONIAL 1	2'-6"	1
36X80 COLONIAL A 1	3'-0"	15
48X80 COLONIAL A 2	4'-0"	2
60X80 COLONIAL A 2	5'-0"	1
36X80 DUTCH ENTRY	3'-0"	1
12X80 GLASS 2	6'-0"	2
24X60 SINGLE HUNG 1	2'-0" x 5'-0"	1
36X36 SINGLE HUNG 1	3'-0" x 3'-0"	3
12X60 SINGLE HUNG 2	6'-0" x 5'-0"	4
36X60 SINGLE HUNG 1	3'-0" x 5'-0"	5
24X24 RAFG	2'-0" x 2'-0"	1

HE IS THE
CHIEF
CORNERSTONE

January S. Jernigan
115 5th John Street
Live Oak, FL 32064
Phone: 386-209-1340
E-Mail: skydes@earthlink.net


A RESIDENCE FOR:
BILL & MARY ROGERS

PROFESSIONAL
BUILDING DESIGN

FLOOR LAYOUT
Date: 10/2007

Sheet Number:
1

Drawn By: JSJ
Scale: 1/4" = 1'

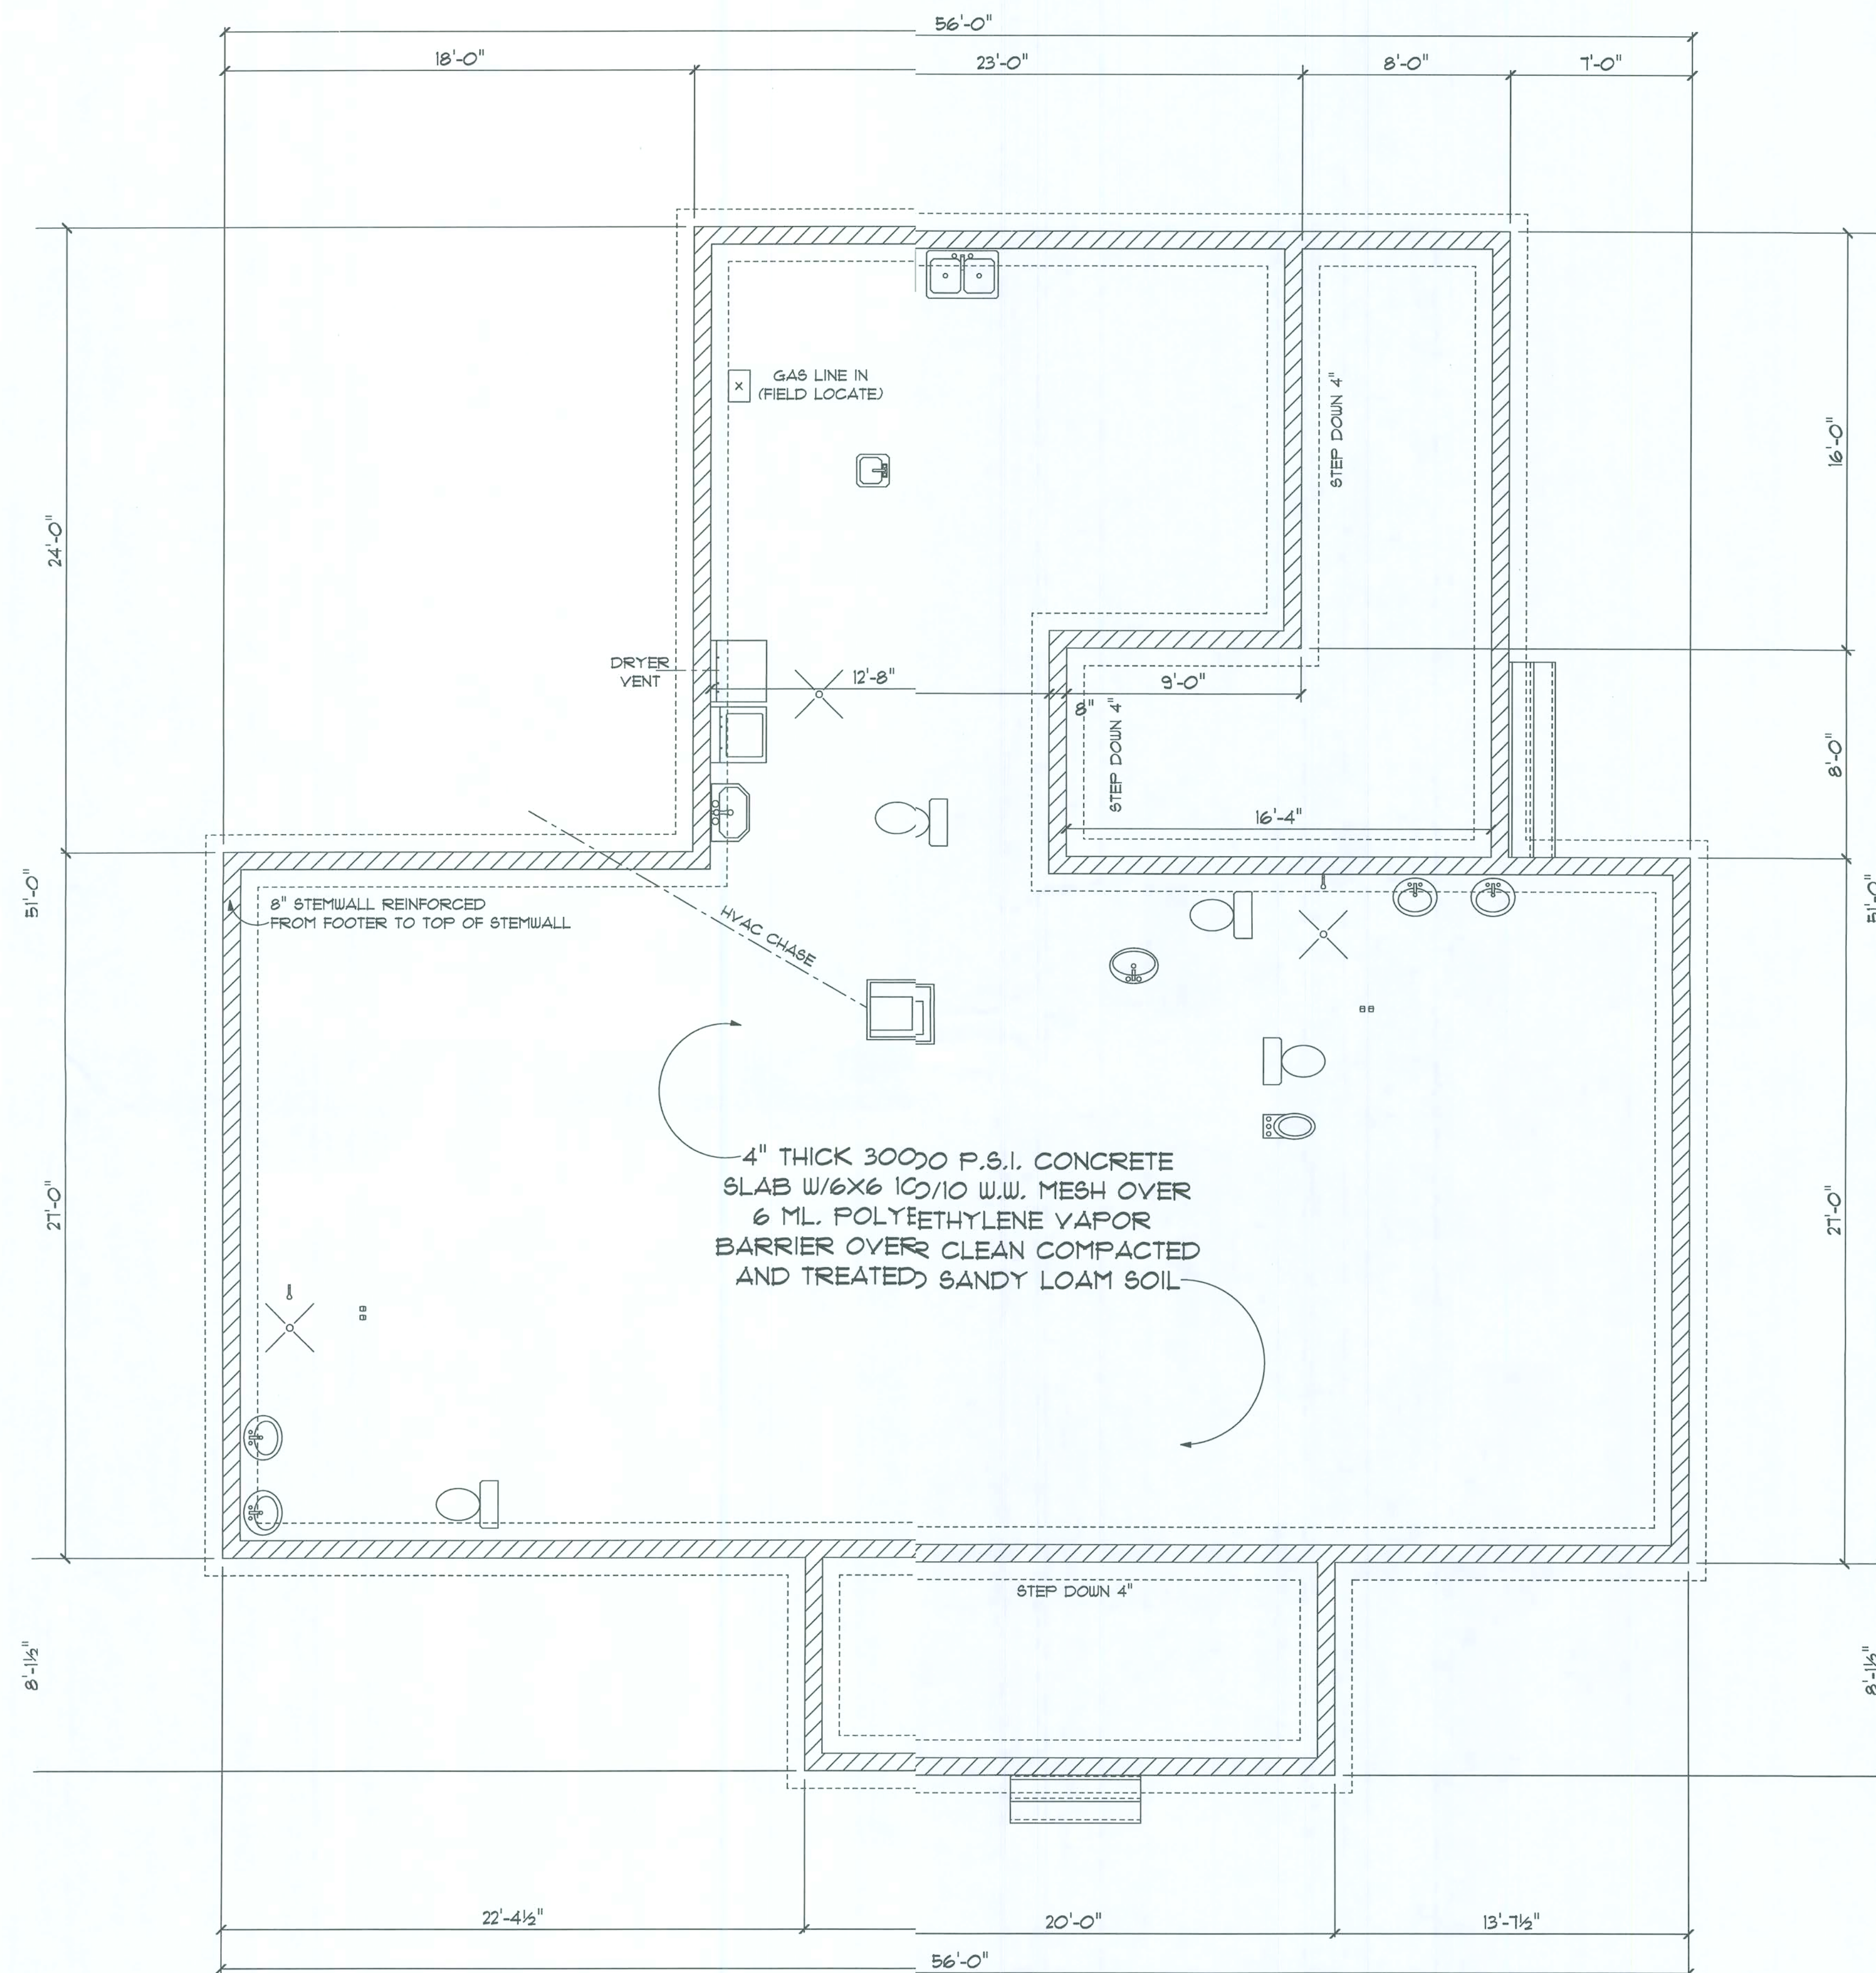

HE IS THE
CHIEF
CORNERSTONE

January S. Jernigan
119 SW John Street
Live Oak, FL 32064
Phone: 386.326.1270
E-Mail: skydesigns@att.net


A RESIDENCE FOR:
BILL & MARY ROGERS

PROFESSIONAL
BUILDING DESIGN

FOUNDATION
Date: 10/2007

Sheet Number:
2

Drawn By: JSJ
Scale: 1/4" = 1'

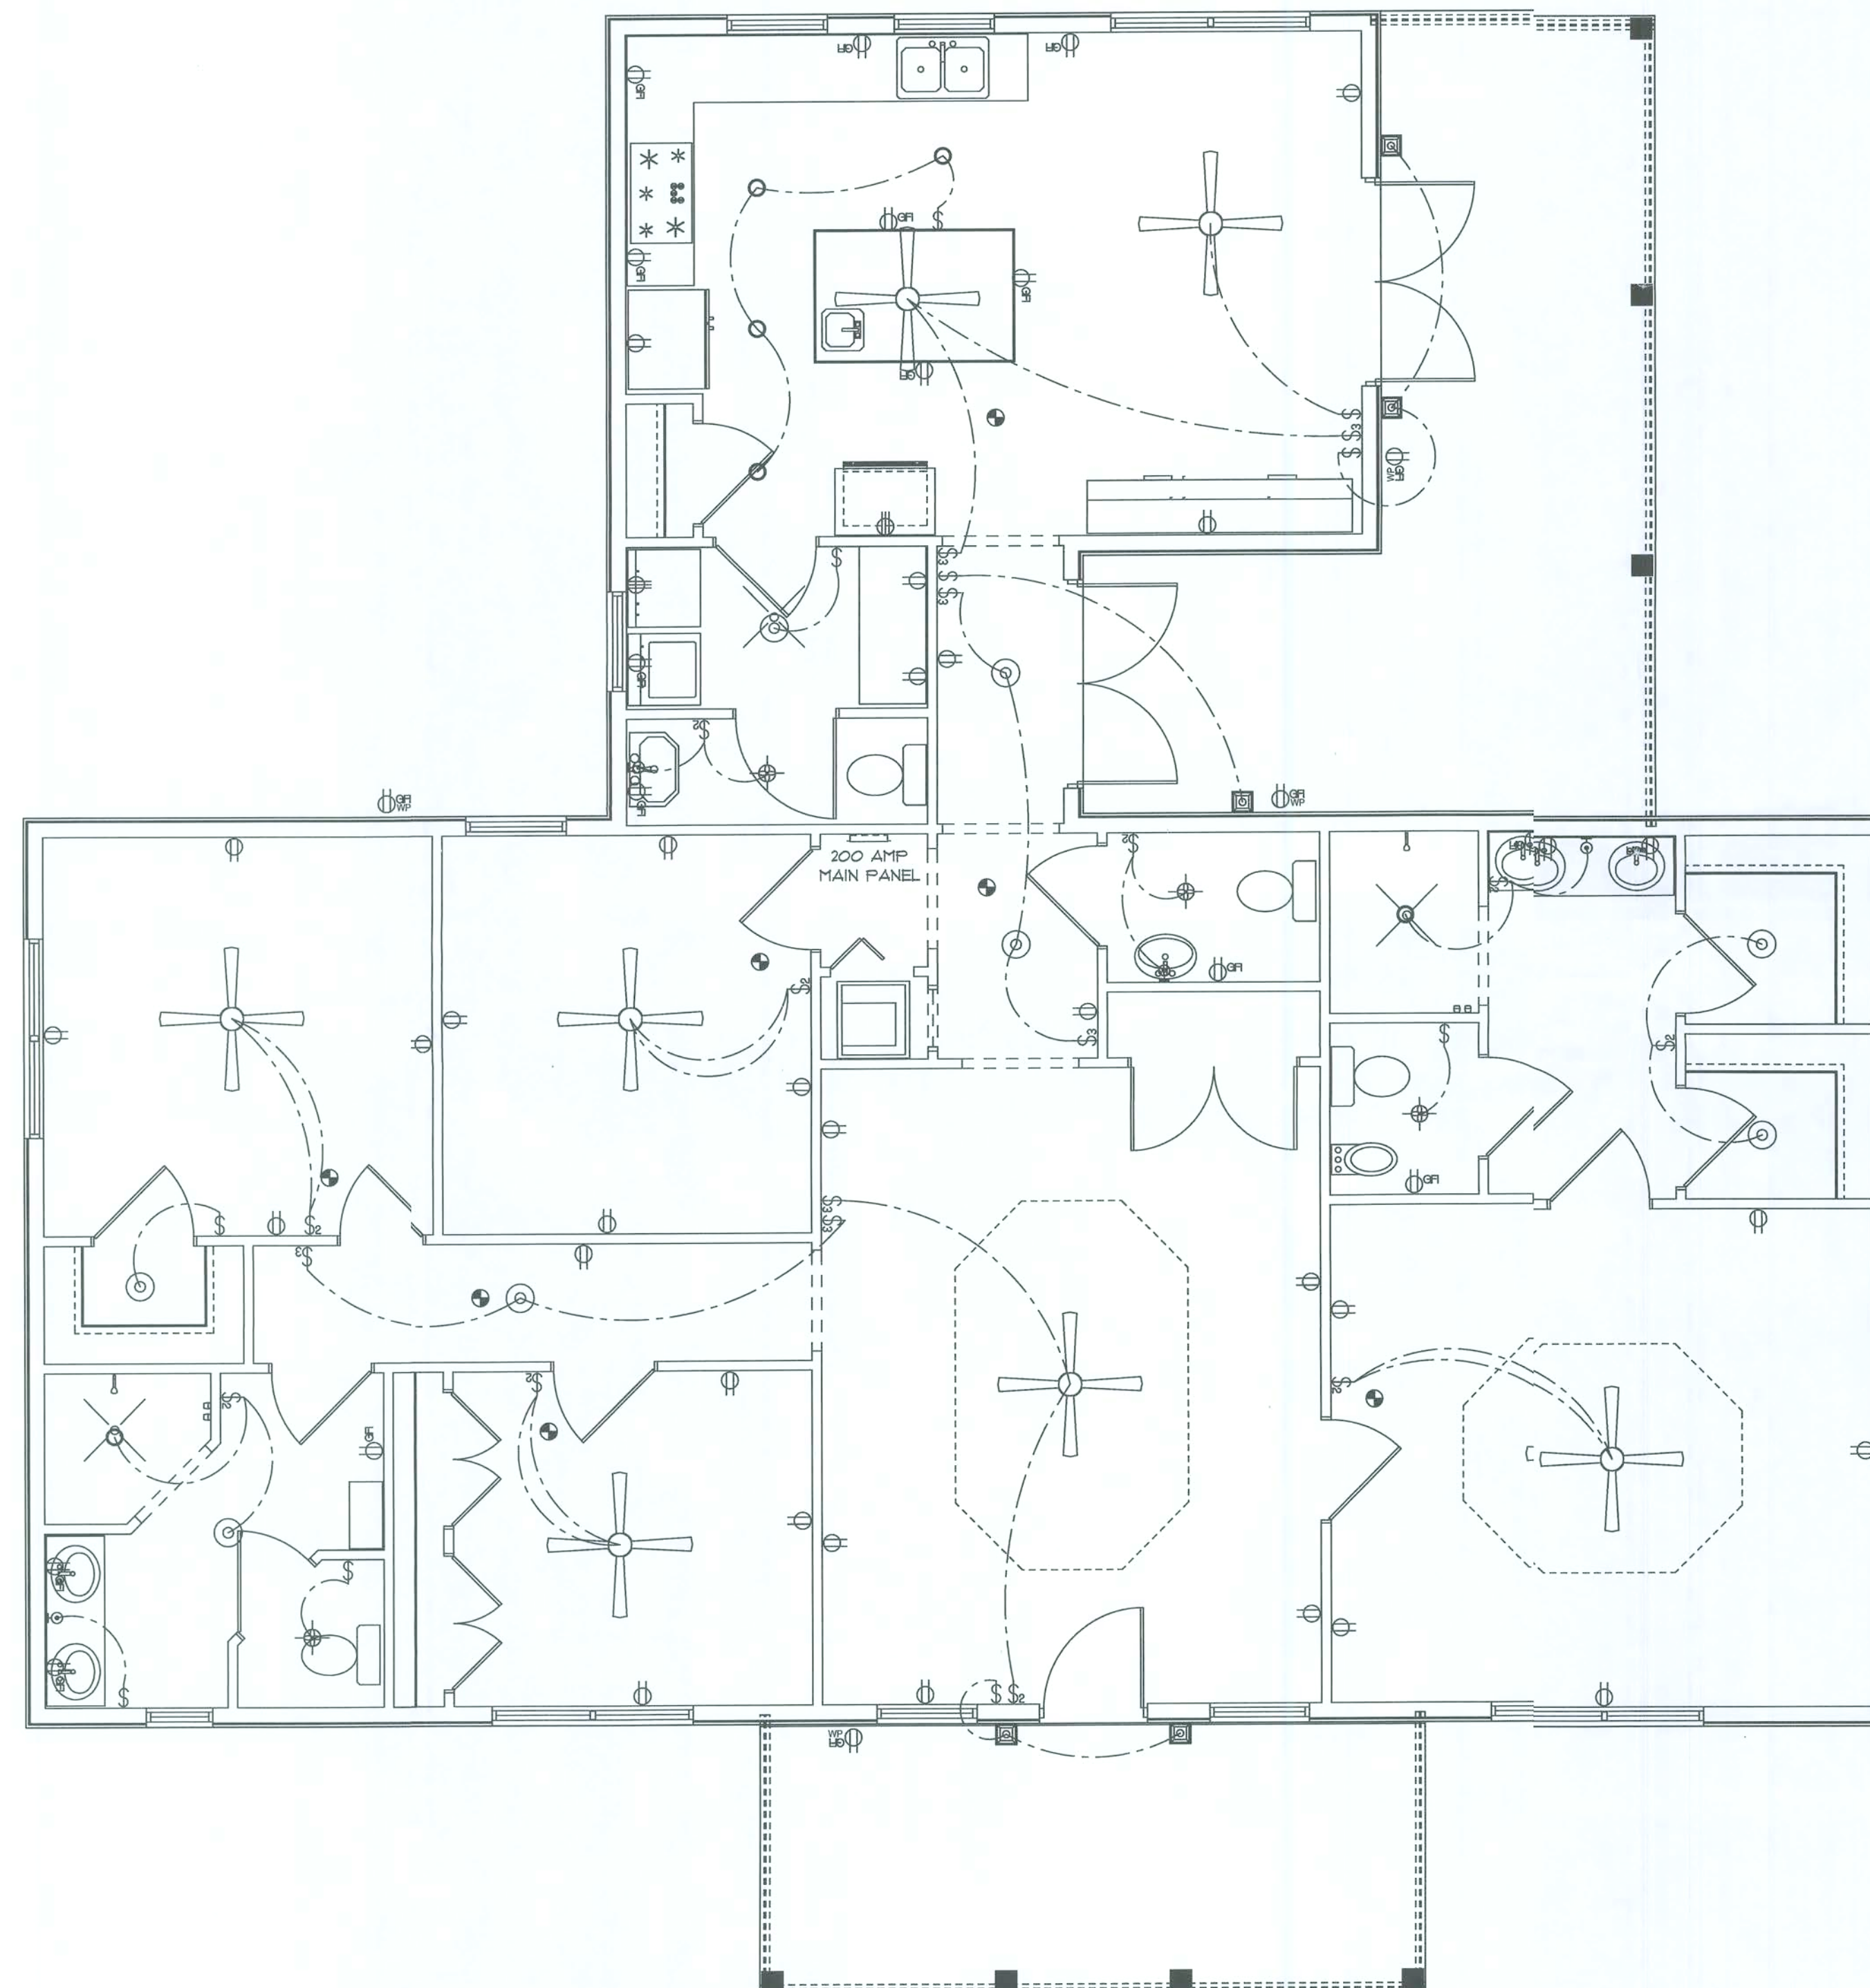

ELECTRICAL LEGEND

ELECTRICAL	COUNT	SYMBOL
ceiling fan globe 1	5	
ceiling globe light	8	
electrical panel	1	
fan light combo	6	
pot light	6	
wall mount 2	5	
wall sconce	4	
outlet wp	4	
outlet	29	
outlet 220v	2	
outlet gfi	16	
smoke detector	7	
switch	10	
switch 3 way	7	
switch double	10	

NOTE:

1. OUTLETS LOCATED IN KITCHEN, BATH, MEDIA CENTER & BEHIND REFRIGERATOR SHALL BE A MINIMUM OF 4'-0" A.F.F.
2. ALL OTHER OUTLETS SHALL BE A MINIMUM OF 12" A.F.F. UNLESS OTHERWISE SPECIFIED.
3. PLACE SWITCH PLATES A MINIMUM OF 2 1/2" FROM DOOR TRIM
4. ALL PHONE/MULTIMEDIA OUTLETS SHALL BE PLACED PER OWNER
5. SMOKE ALARMS SHALL BE BATTERY OPERATED AND HARD-WIRED INTO THE ELECTRICAL SYSTEM (ONE CIRCUIT CONNECTION TO PANEL) OR TO BE PLUG-IN ALARM
6. TOILET ROOMS AND BATHROOMS REQUIRE OUTDOOR VENTILATION AREA-50 CFM (INTERMITTENT) OR 20 CFM (CONTINUOUS)
7. ALL BRANCH-CIRCUITS THAT SUPPLY 125 VOLT, SINGLE PHASE, 15 20AMP OUTLETS LOCATED IN DWELLING-UNIT BEDROOMS MUST BE PROTECTED BY AN ARC-FAULT CIRCUIT INTERRUPTER TO PROVIDE PROTECTION OF THE ENTIRE BRANCH-CIRCUIT

HE IS THE
CHIEF
CORNERSTONE

January 5, Jernigan
119 SW John Street
Lima Oak, FL 32064
Phone: 386-208-1340
E-Mail: akjdesign@aol.net


A RESIDENCE FOR:
BILL & MARY ROGERS

PROFESSIONAL
BUILDING DESIGN


ELECTRICAL
Date: 10/2007

Sheet Number:
3

Drawn By: JSJ
Scale: 1/4" = 1'

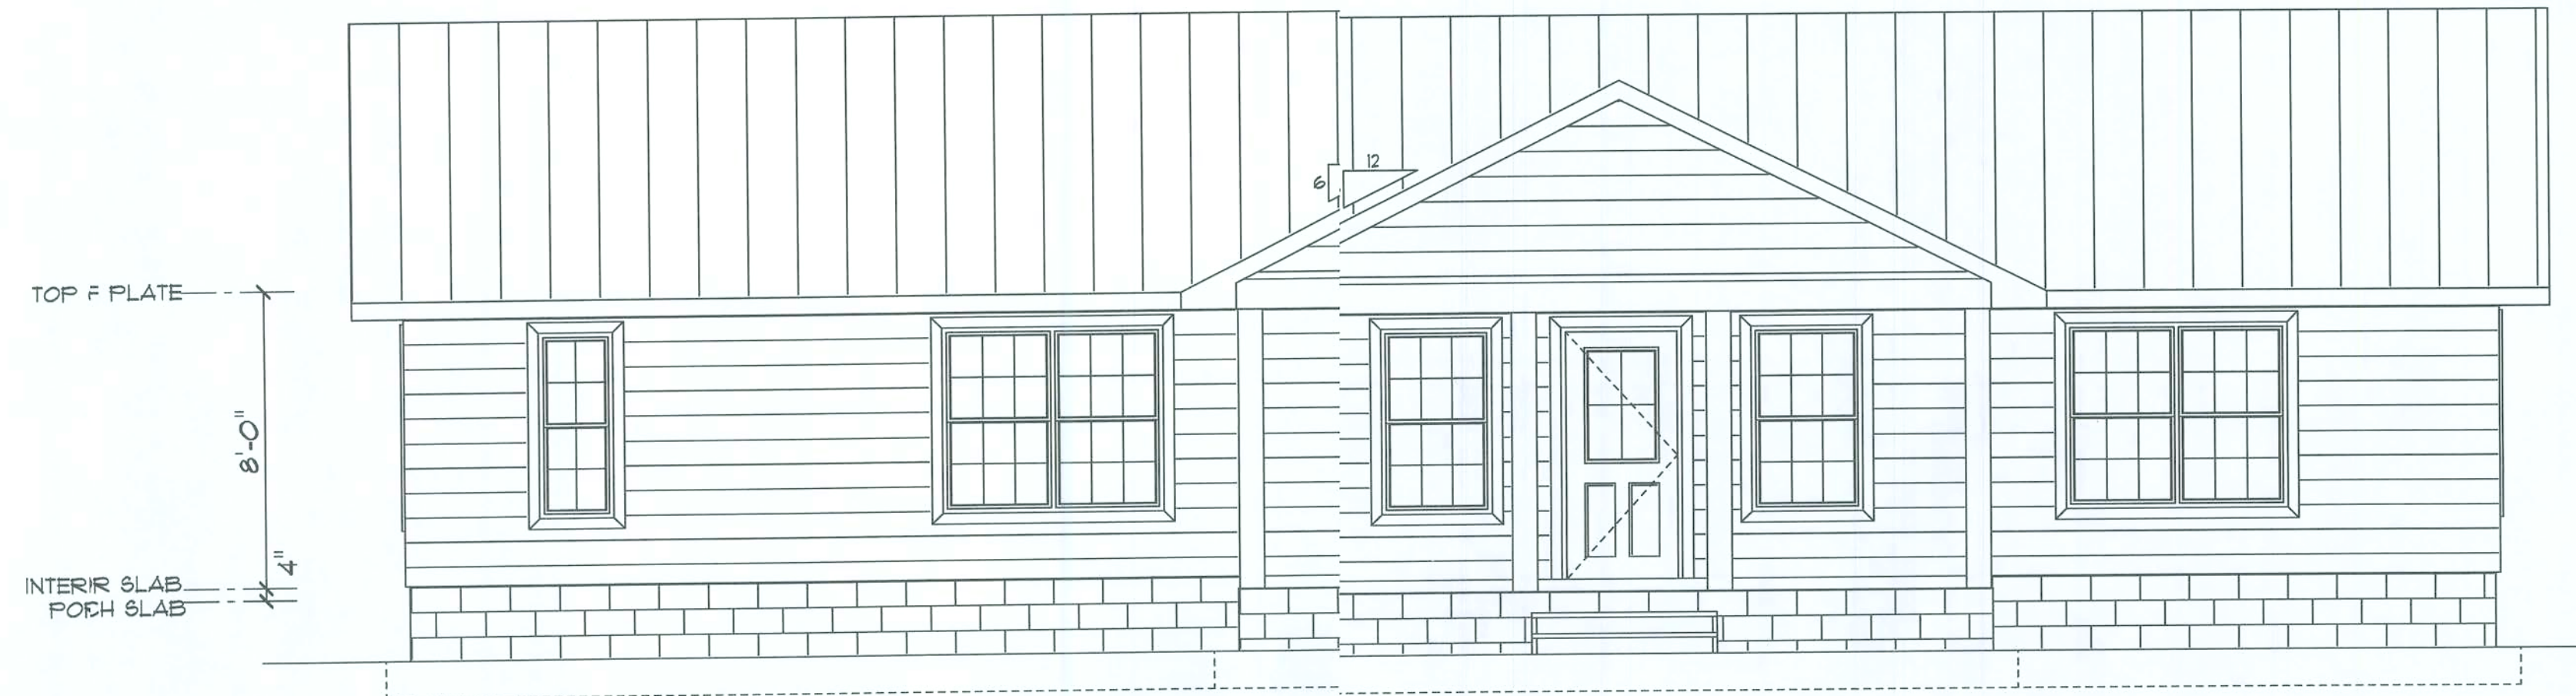


FRONT ELEVATION

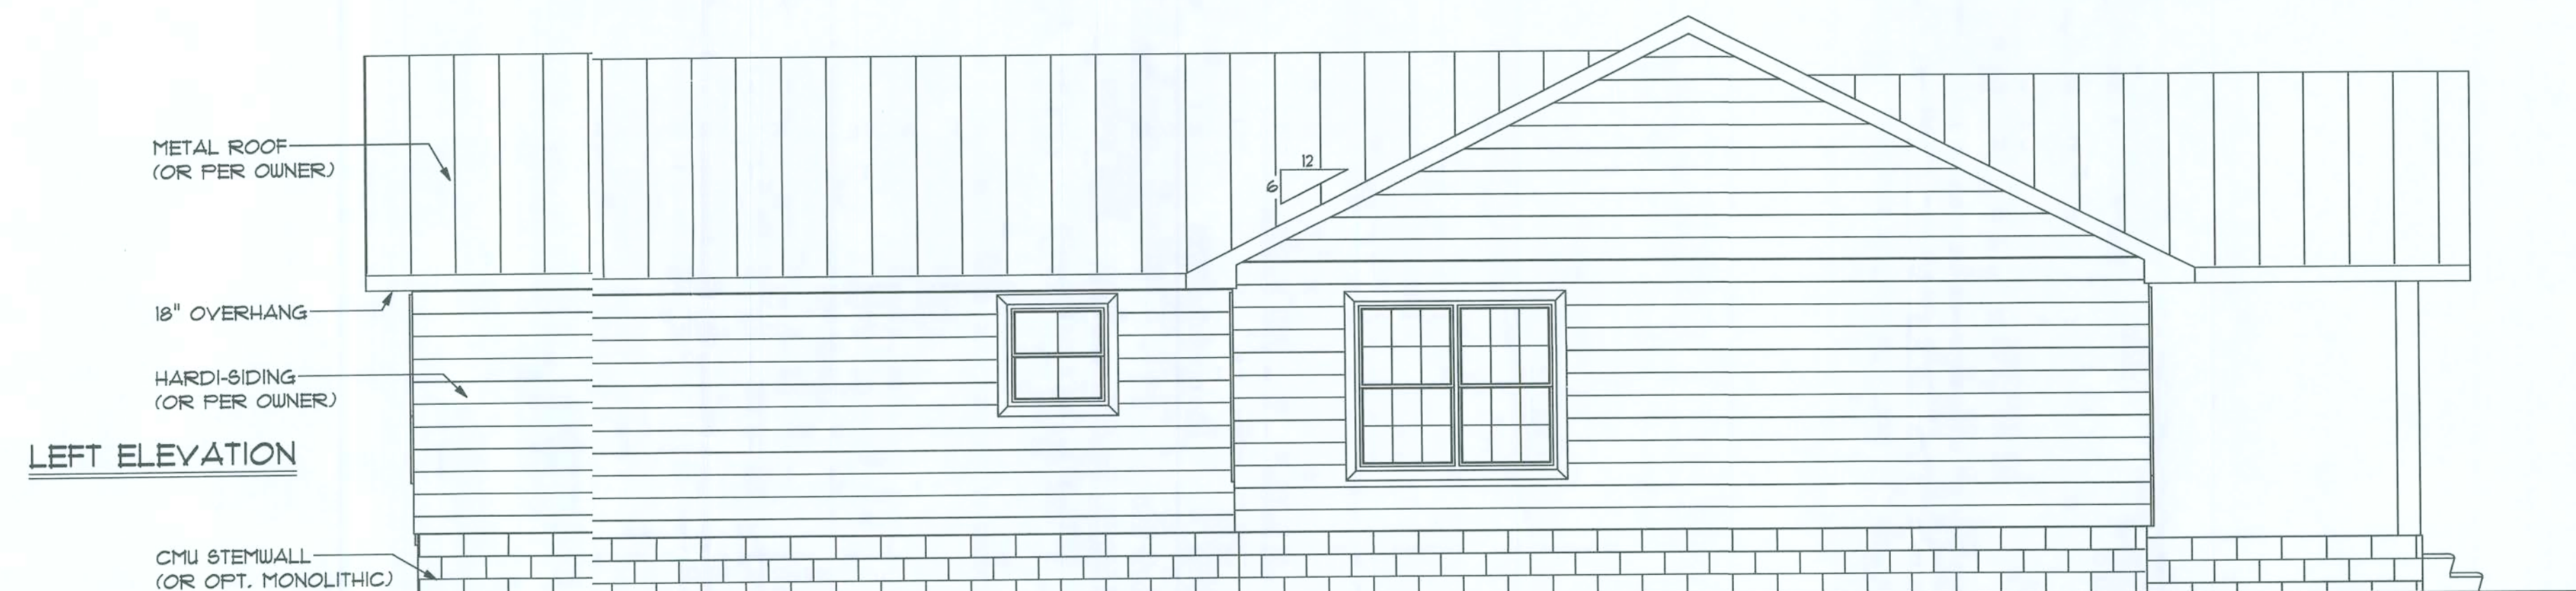


LEFT ELEVATION



RIGHT ELEVATION

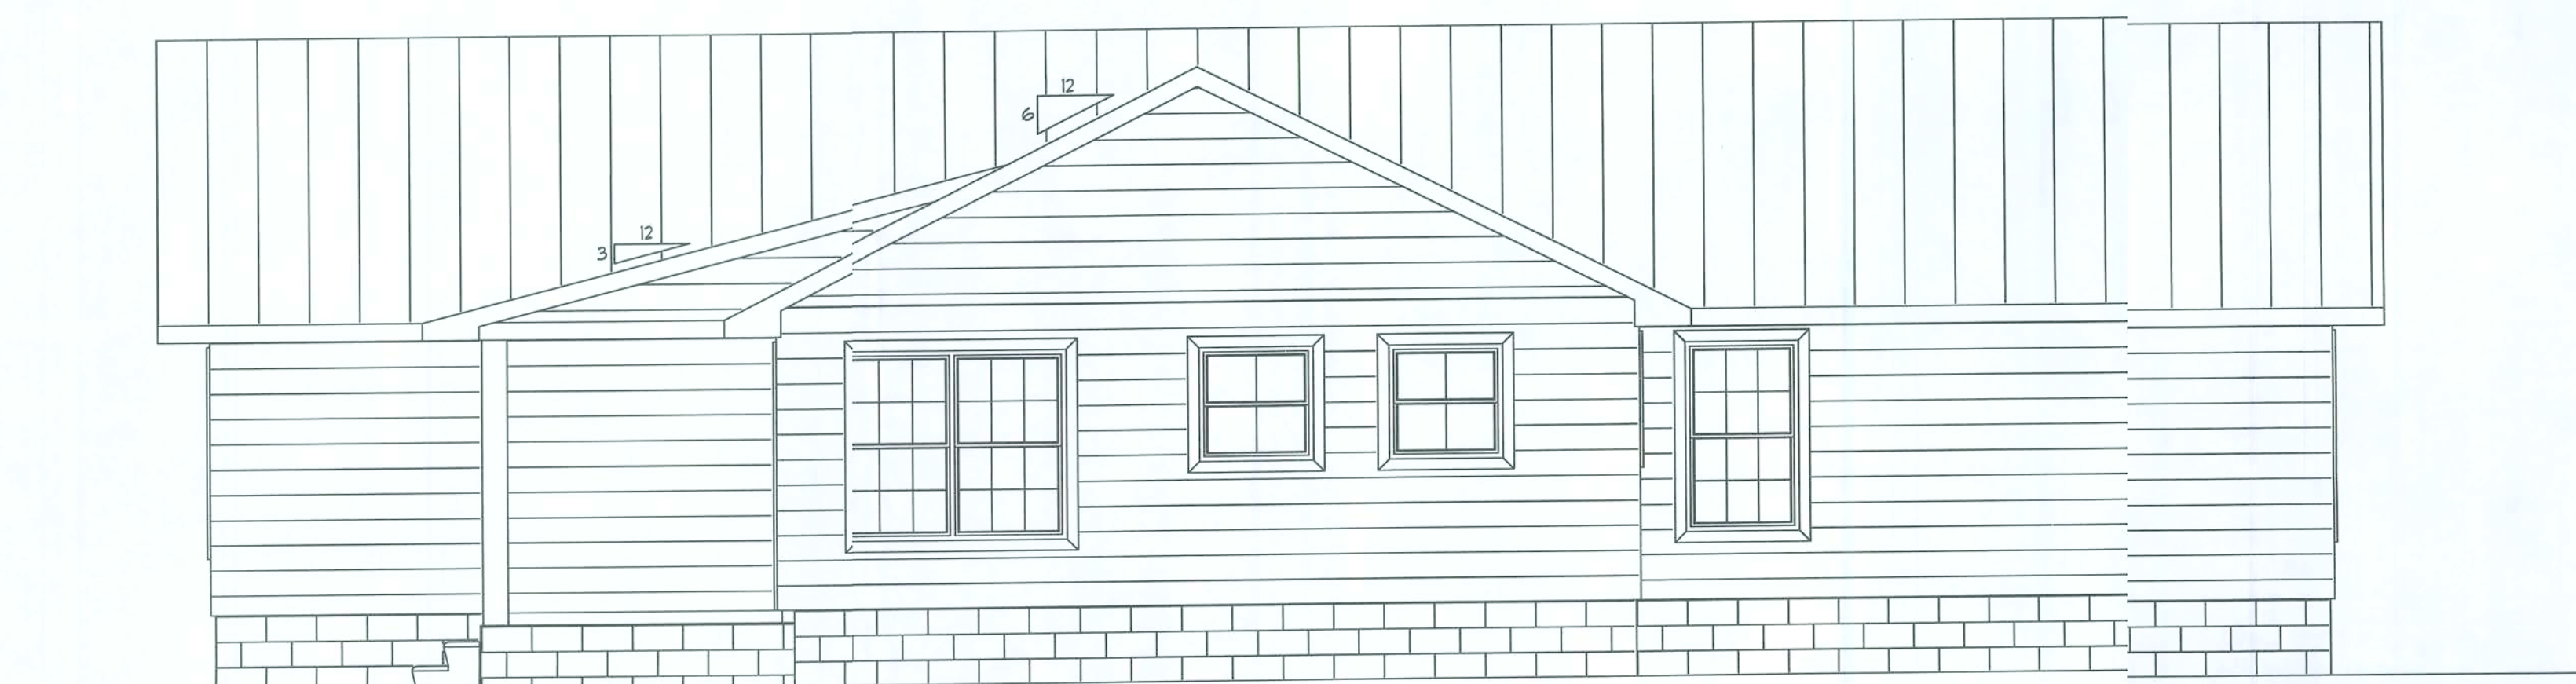

REAR ELEVATION

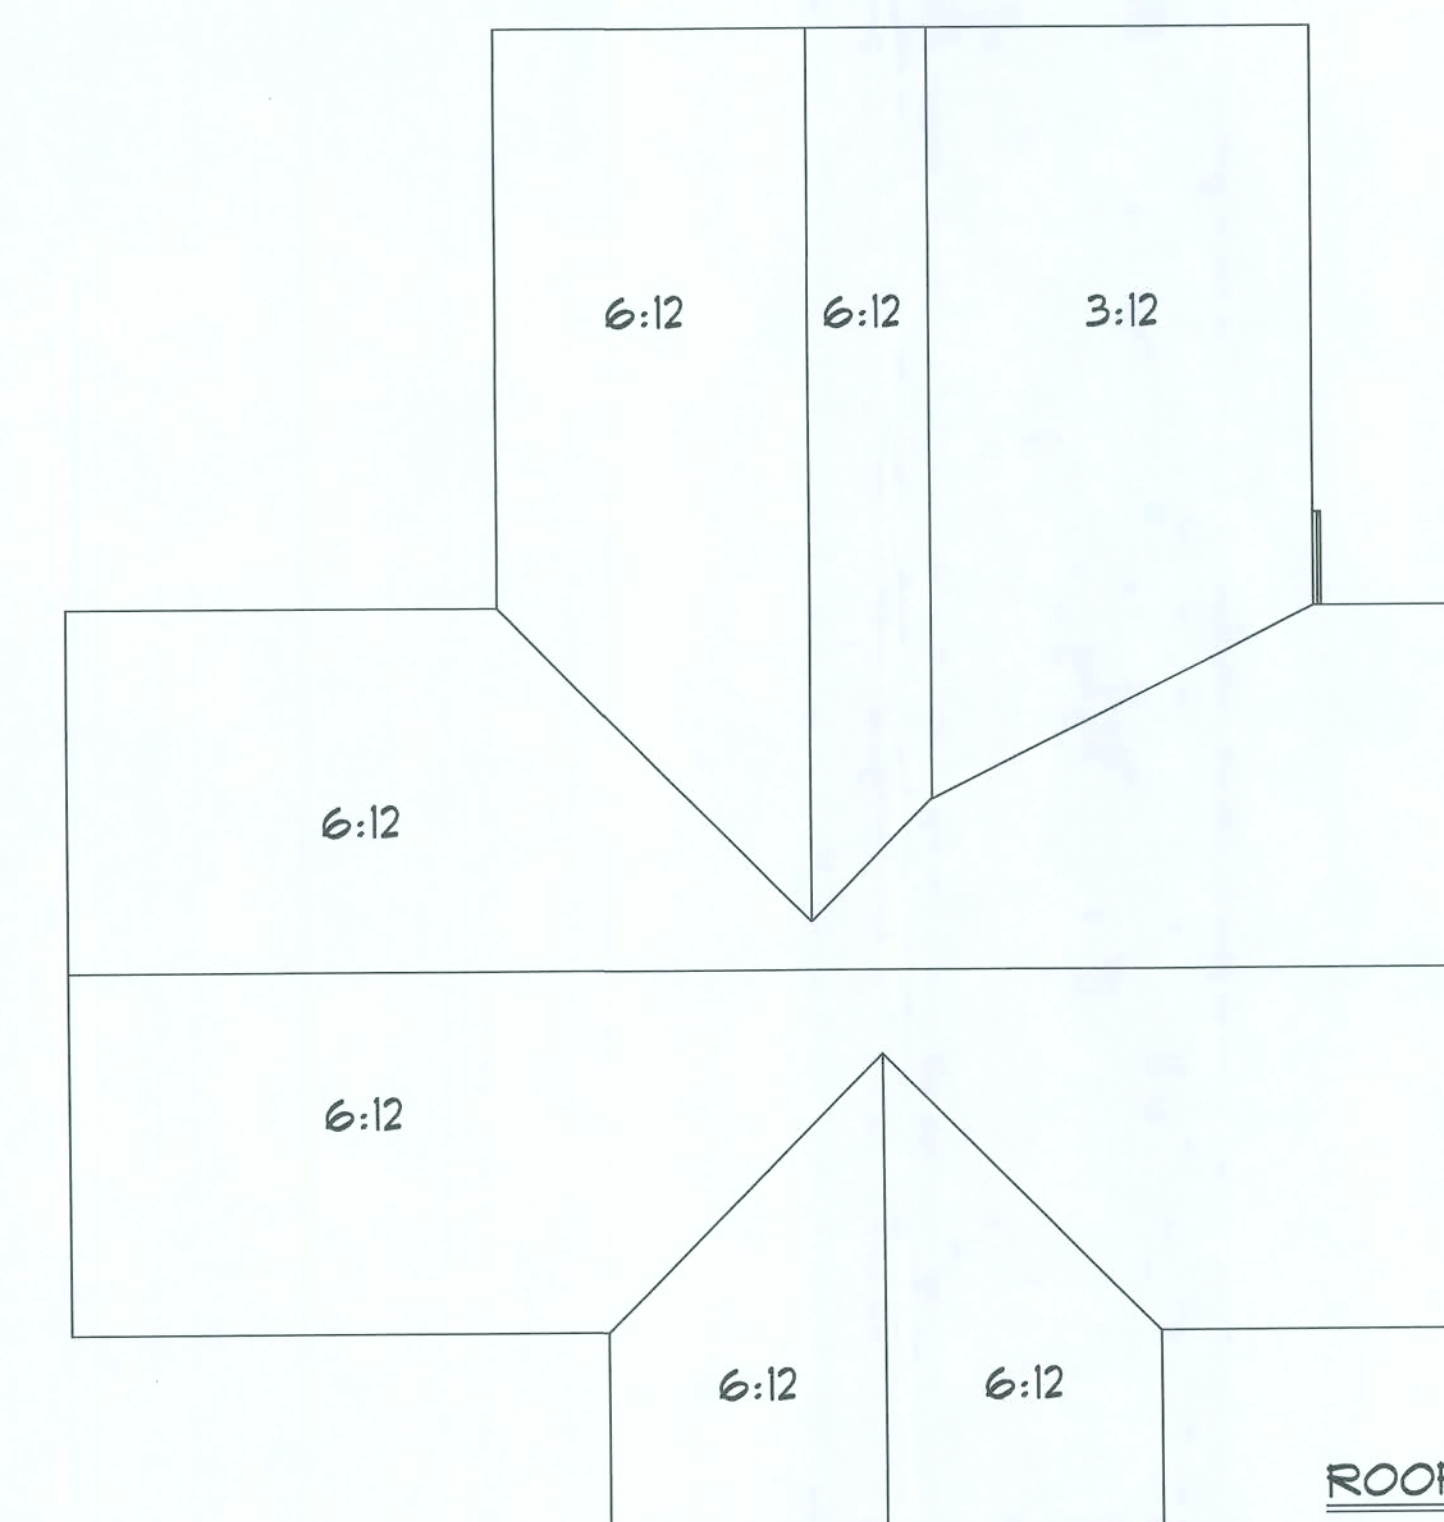

ROOF PLAN

HE IS THE
CHIEF
CORNERS'ONE

January 6, Jernigan
119 5th John Street
Live Oak, FL 32064
Phone: 386-208-1340
E-Mail: sdydesign@aol.net

A RESIDENCE FOR:
BILL & MARY ROGERS

PROFESSIONAL
BUILDING DESIGN

ELEVATIONS
Date: 10/2007

Sheet Number:
4

Drawn By: JSJ
Scale: 1/4" = 1'