



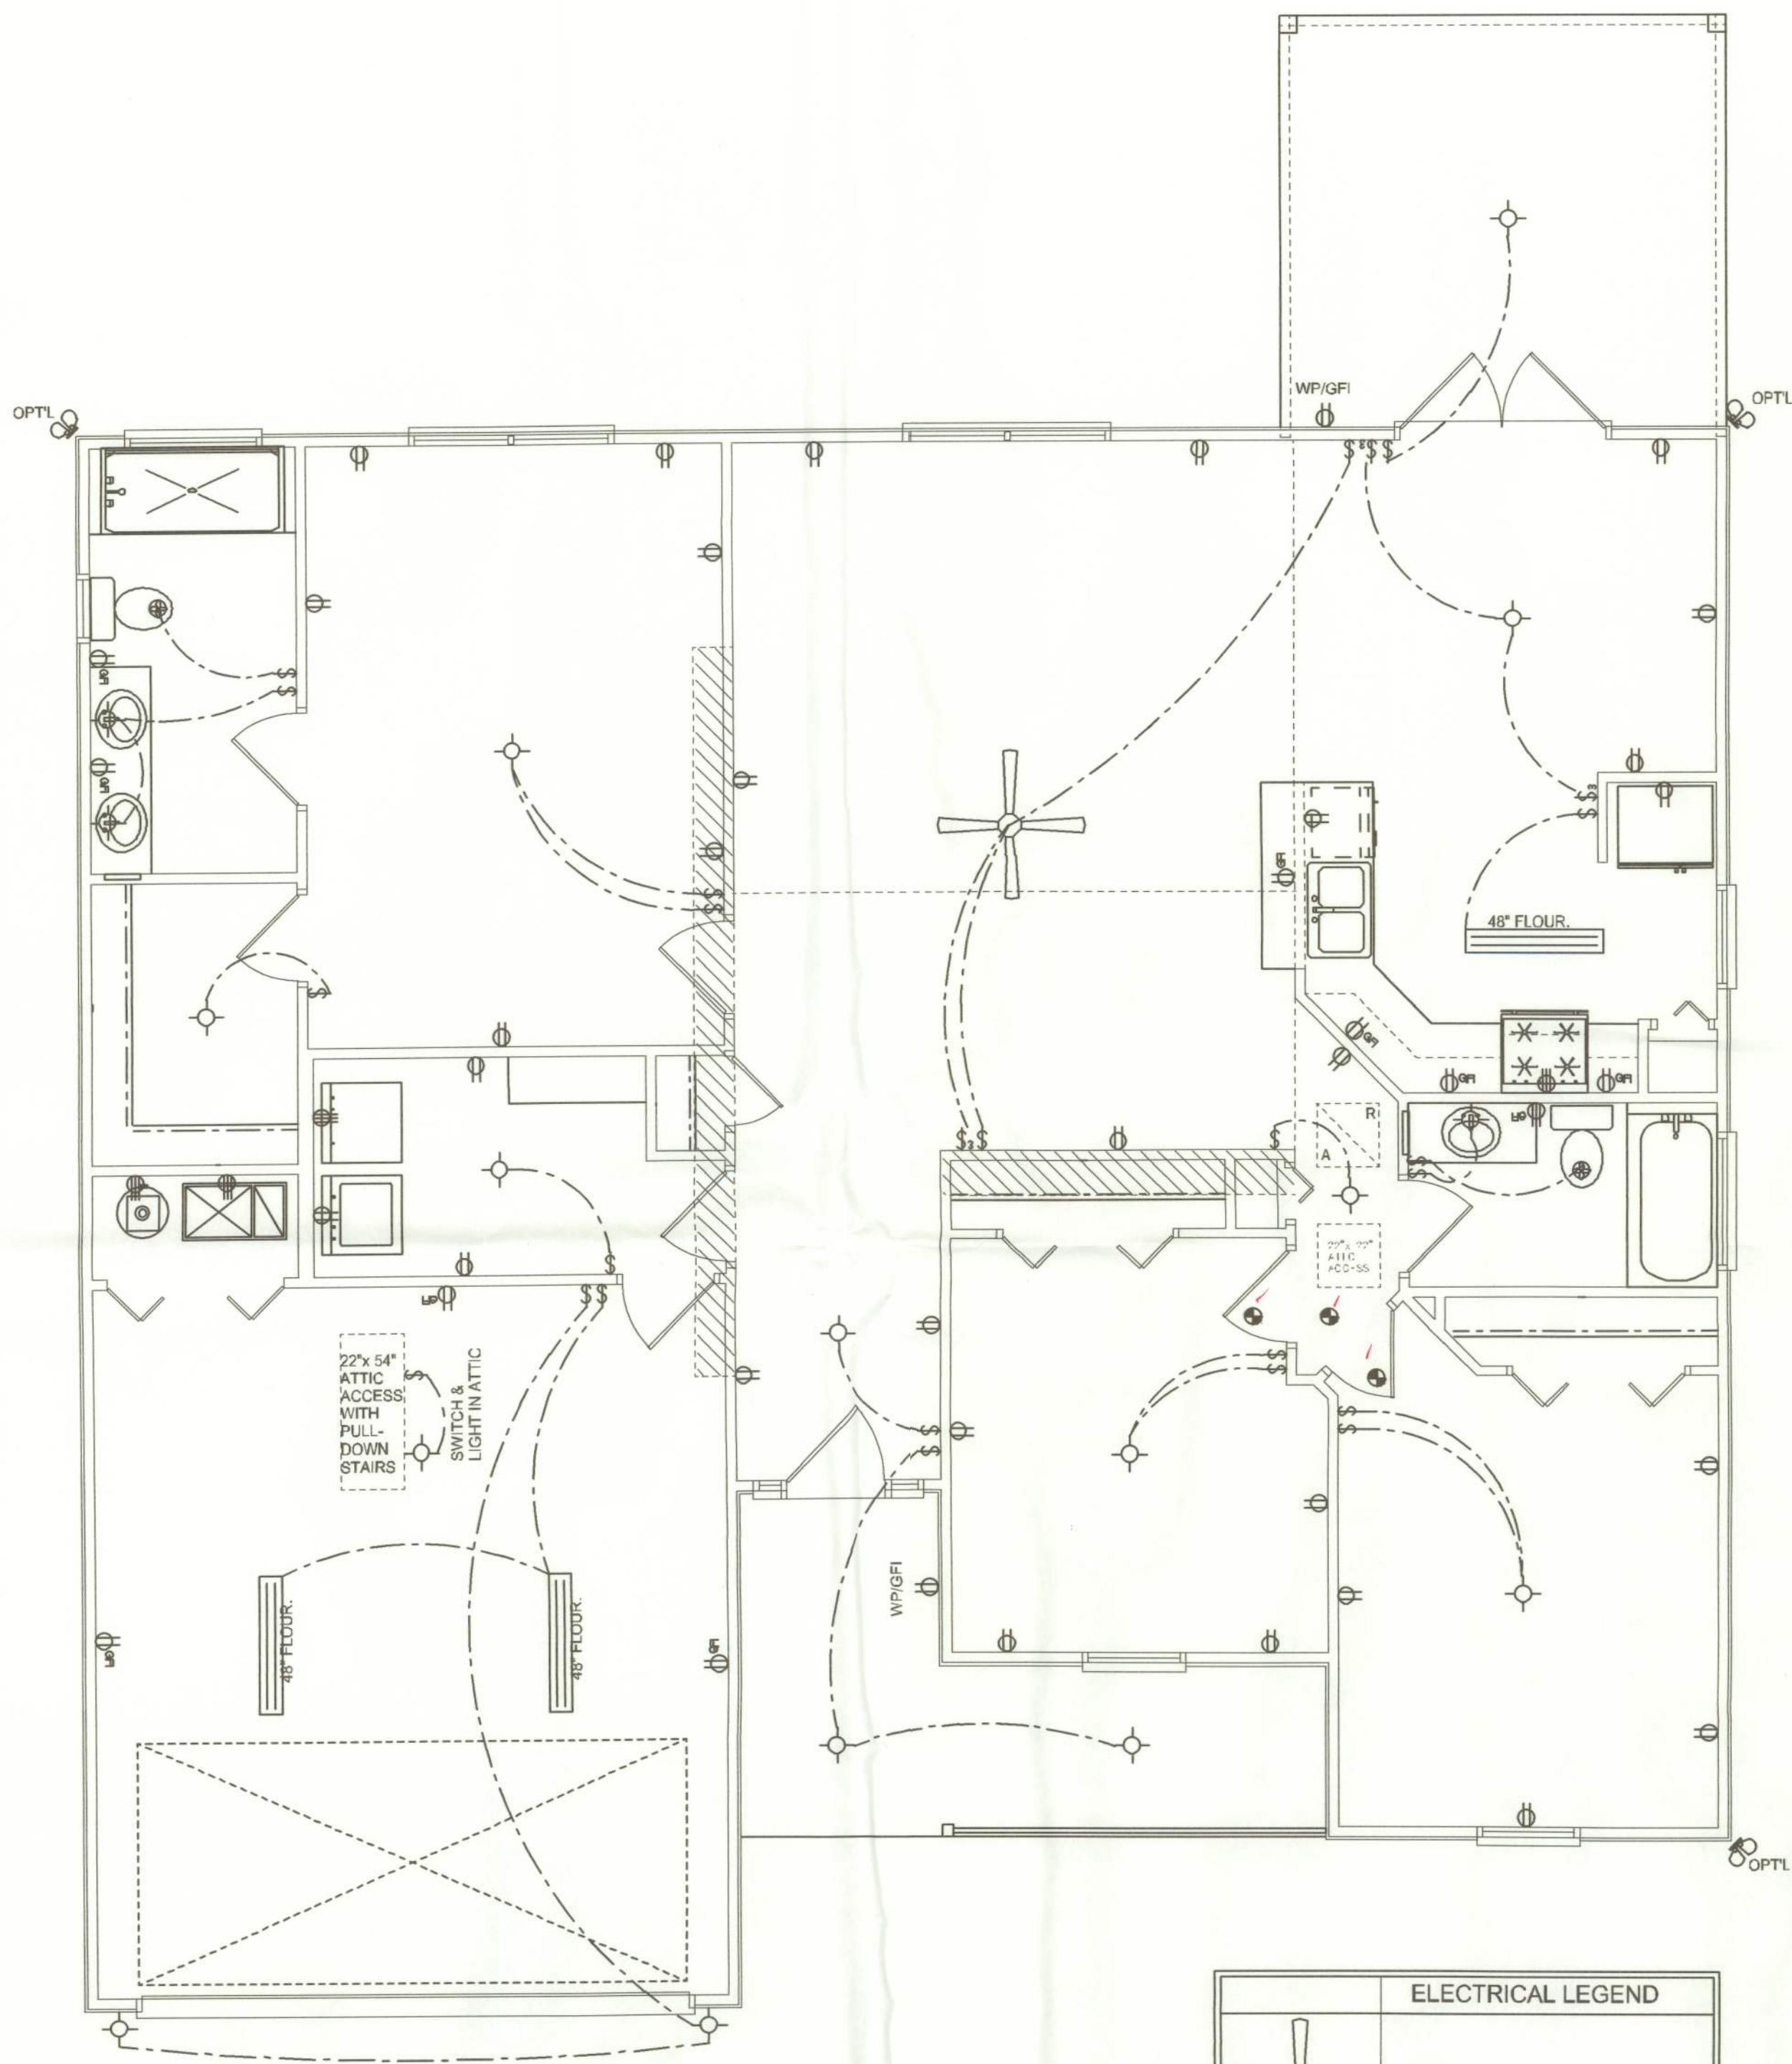

ELECTRICAL PLAN
SCALE: 1/4" = 1'-0"

ELECTRICAL LEGEND	
	CEILING FAN (PRE-WIRE FOR LIGHT KIT)
	DOUBLE SECURITY LIGHT
	RECESSED CAN LIGHT
	BATH EXHAUST FAN
	LIGHT FIXTURE
	DUPLEX OUTLET
	220v OUTLET
	GFI DUPLEX OUTLET
	SMOKE DETECTOR (see note below)
	WALL SWITCH
	3 WAY WALL SWITCH
	WATER PROOF GFI OUTLET
	2 OR 4 TUB FLUORESCENT FIXTURE

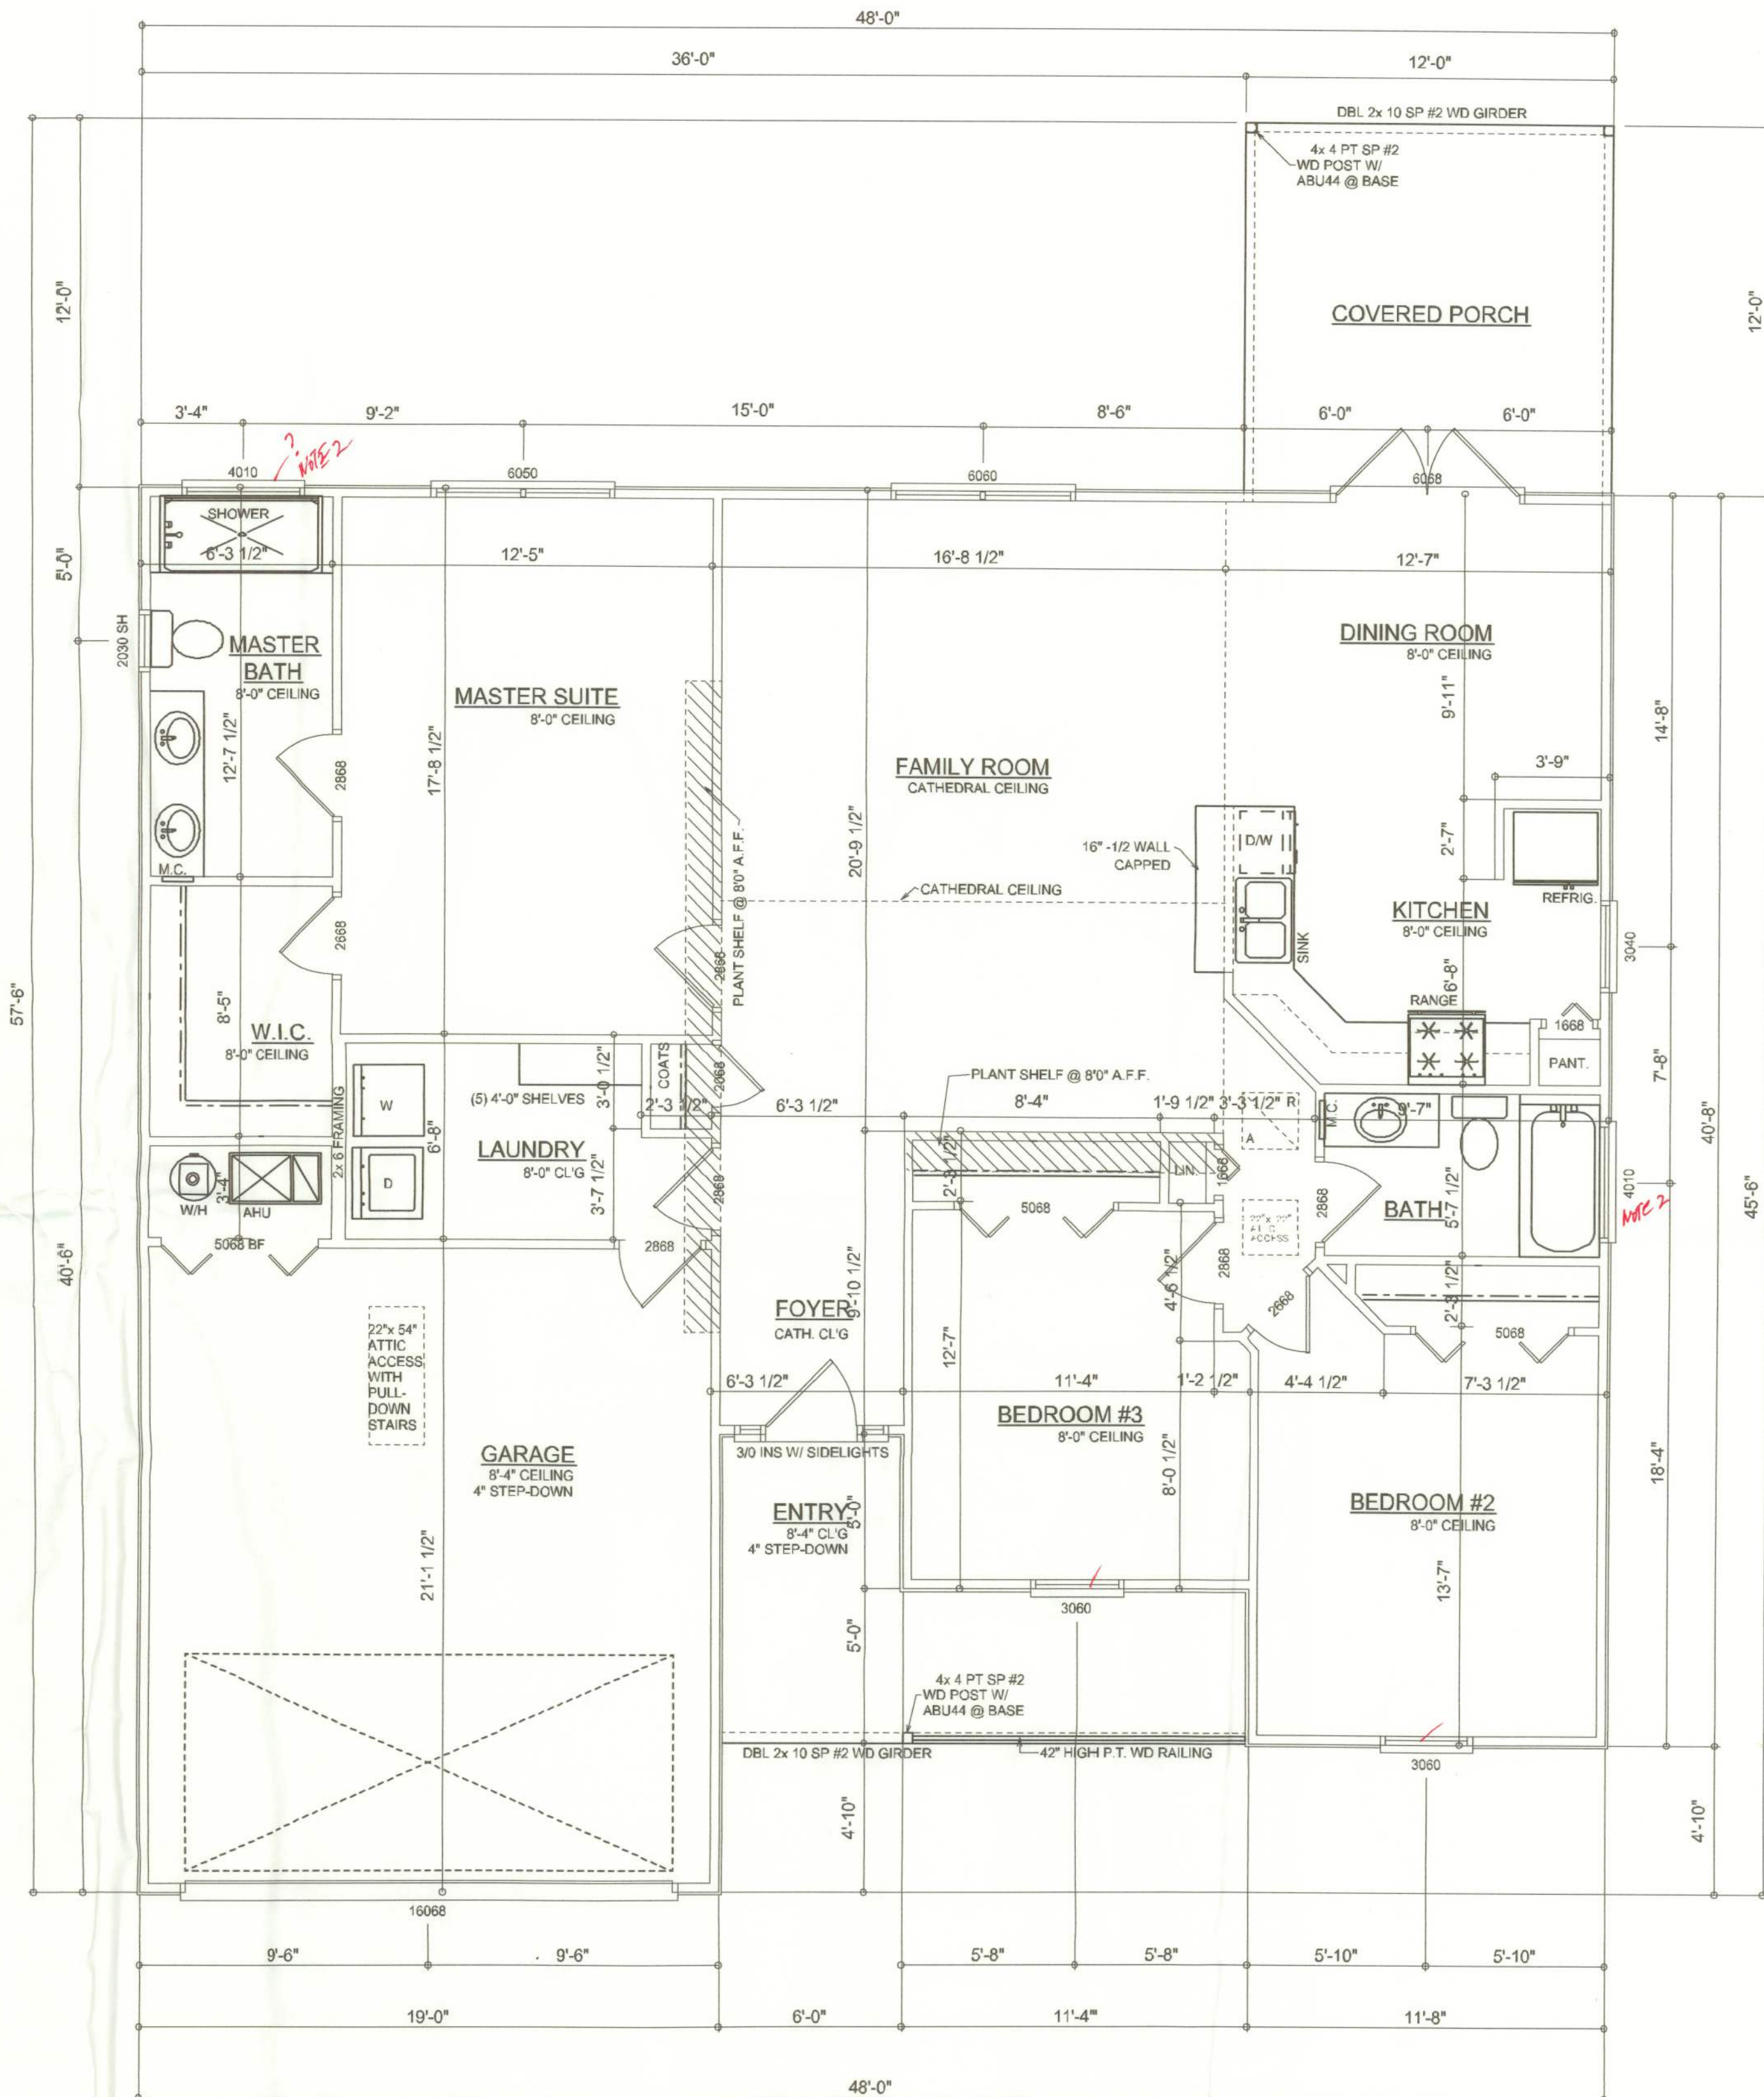

FLOOR PLAN
SCALE: 1/4" = 1'-0"

AREA SUMMARY

LIVING AREA	1514	S.F.
GARAGE AREA	415	S.F.
ENTRY PORCH AREA	116	S.F.
COVERED PORCH AREA	144	S.F.
TOTAL AREA	2189	S.F.

REVISIONS
September 07, 2005


SOFTPLAN
ARCHITECTURAL SOFTWARE

FLOOR PLAN
SCALE: 1/4" = 1'-0"

ELECTRICAL PLAN
SCALE: 1/4" = 1'-0"

A SPEC HOUSE FOR:
AARON SIMPLE HOMES, INC
PROJECT ADDRESS: LEGAL: 03-4S-17-07571-000, SE CAROL GLEN, SUZANNE SD LAKE CITY FLORIDA 32025

©WILLIAM MYERS
DESIGN
P.O. BOX 1513
LAKE CITY, FL 32066
(386) 758-8406
will@willmyers.net

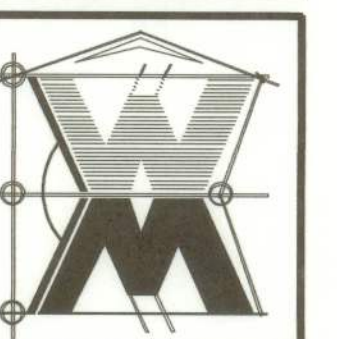

JOB NUMBER
050813

SHEET NUMBER

A.3
OF 3 SHEETS

W.M.C. Myers