

ELECTRICAL SYMBOL LEGEND

- ⌘ WALL SWITCH
- ⌘³ WALL SWITCH 3 WAY
- DIMMER — INDICATES DIMMER SWITCH
- ⌘ 110 V DUPLEX OUTLET
- ⌘ 110V DUPLEX GFCI OUTLET WATER PROOF
- ⌘ 110 V DUPLEX GFCI OUTLET
- ⌘⁴² 110 V DUPLEX RAISE TO HEIGHT INDICATED
- ⌘ 220 V SINGULAR OUTLET
- ⌘ 110 V FLOOR OUTLET
- SPECIAL DIRECT WIRE SERVICE
- COMBO SMOKE/CARBON MONOXIDE DETECTOR
- SMOKE DETECTOR
- CEILING MOUNT FIXTURE
- 6" LED RECESSED CAN
- WALL MOUNT FIXTURE
- EXHAUST FAN
- EXHAUST FAN W/ LIGHT
- CEILING FAN W/ LIGHT
- INDICATES GAS LINE


ELECTRICAL PLAN NOTES

NOTE: CONTRACTOR TO VERIFY ALL LIGHTING LOCATIONS WITH OWNER PRIOR BEGINNING INSTALLATION.

NOTE: CAN LOCATIONS MAY VARY DUE TO TRUSS BOTTOM CHORD LOCATIONS.

NOTE: HVAC CONTRACTOR TO INSTALL PROPERLY SIZED HVAC SYSTEM TO WORK IN CONJUNCTION W/ ICYENE INSULATING SYSTEM. (DEHUMIDIFIER TO BE INSTALLED AS PART OF THIS SYSTEM PER HVAC CONT.)

NOTE: THE DWELLING SHALL BE EQUIPPED WITH SMOKE ALARMS LOCATED AS REQUIRED FOR NEW DWELLINGS. THE SMOKE ALARMS SHALL BE INTERCONNECTED AND HARD WIRED.

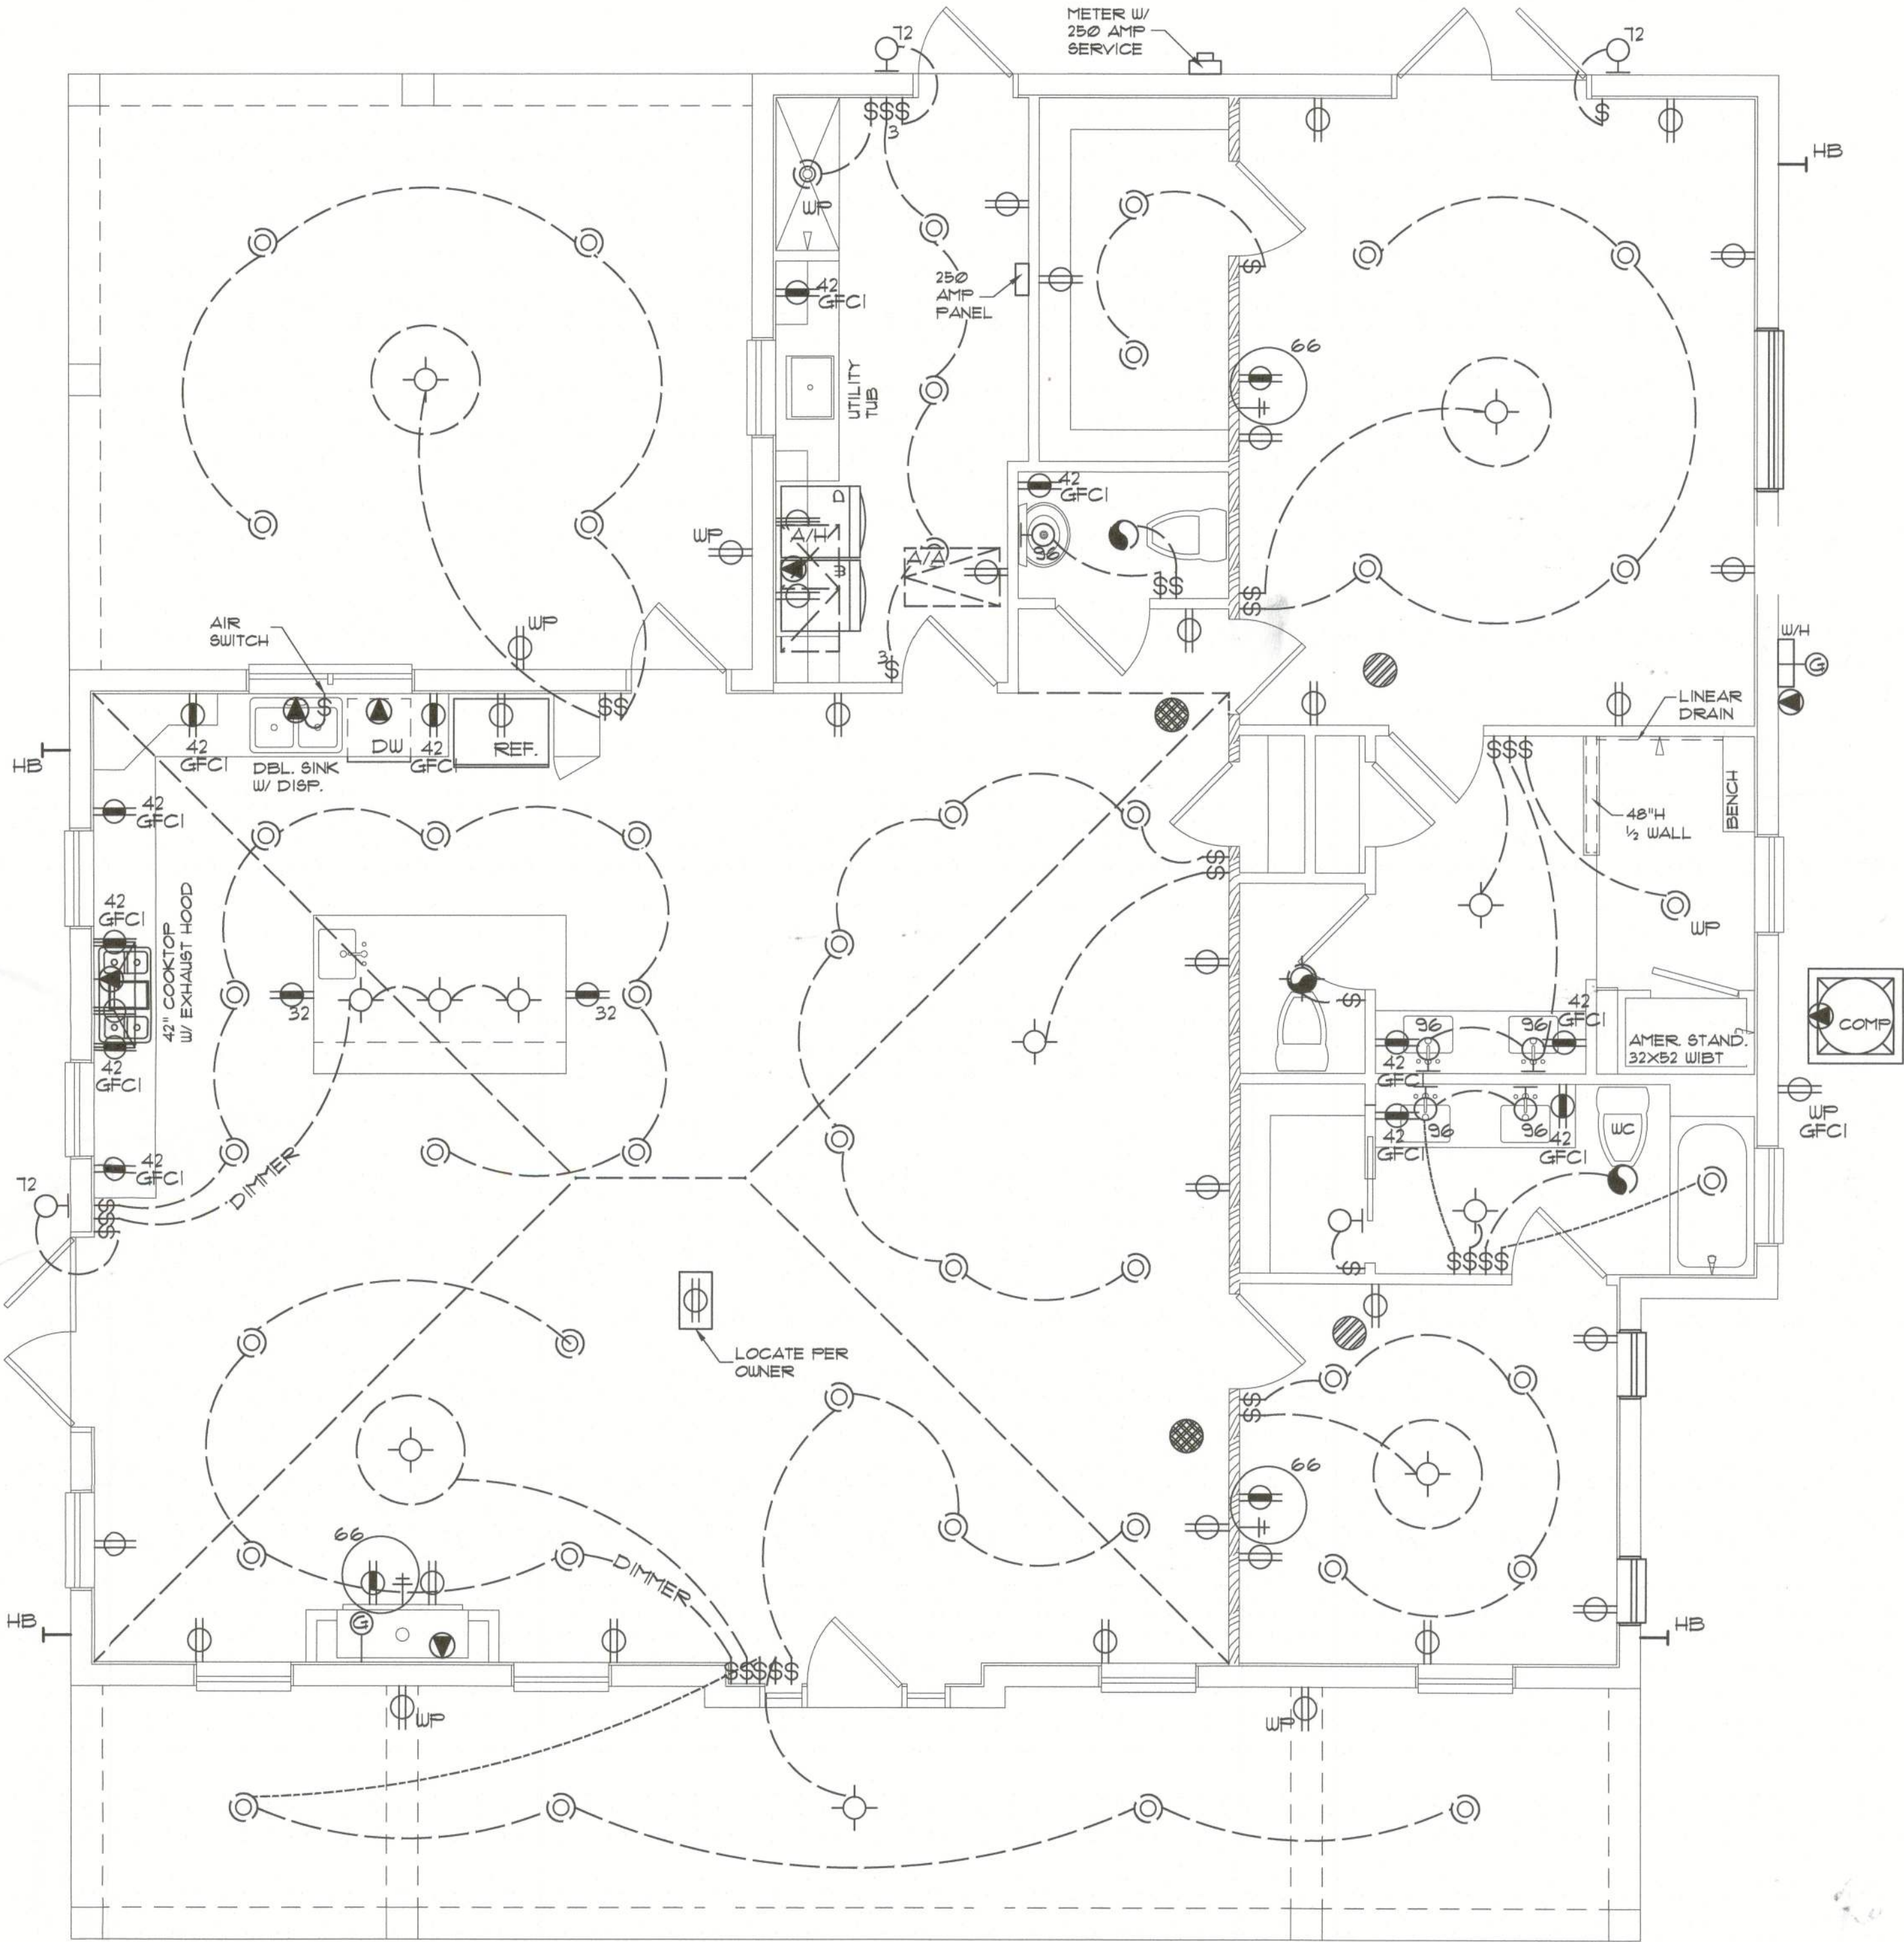

ELECTRICAL PLAN
SCALE - 1/4" = 1' - 0"

REVISIONS	BY

sdg ARCHITECTURE
AA2600339 727-796-5463
RODNEY L. COLLAMAN, AIA
4/11/23
793 San Christopher Drive • Suite A • Dunedin, FL 34698

CUSTOM HOME FOR:
ROBERT L & KATHRYN L MCDOW
1630 SW SALEM RD, LAKE CITY

DRAWN BY: XM
CHECK BY: TJG
JOB#
20-058
DATE
03/27/23
■ PROGRESS SET
□ PERMITTING SET
PAGE
0
OF 8