


FRONT ELEVATION
SCALE: 1/4" = 1'-0"



REAR ELEVATION
SCALE: 1/4" = 1'-0"



LEFT ELEVATION
SCALE: 1/4" = 1'-0"

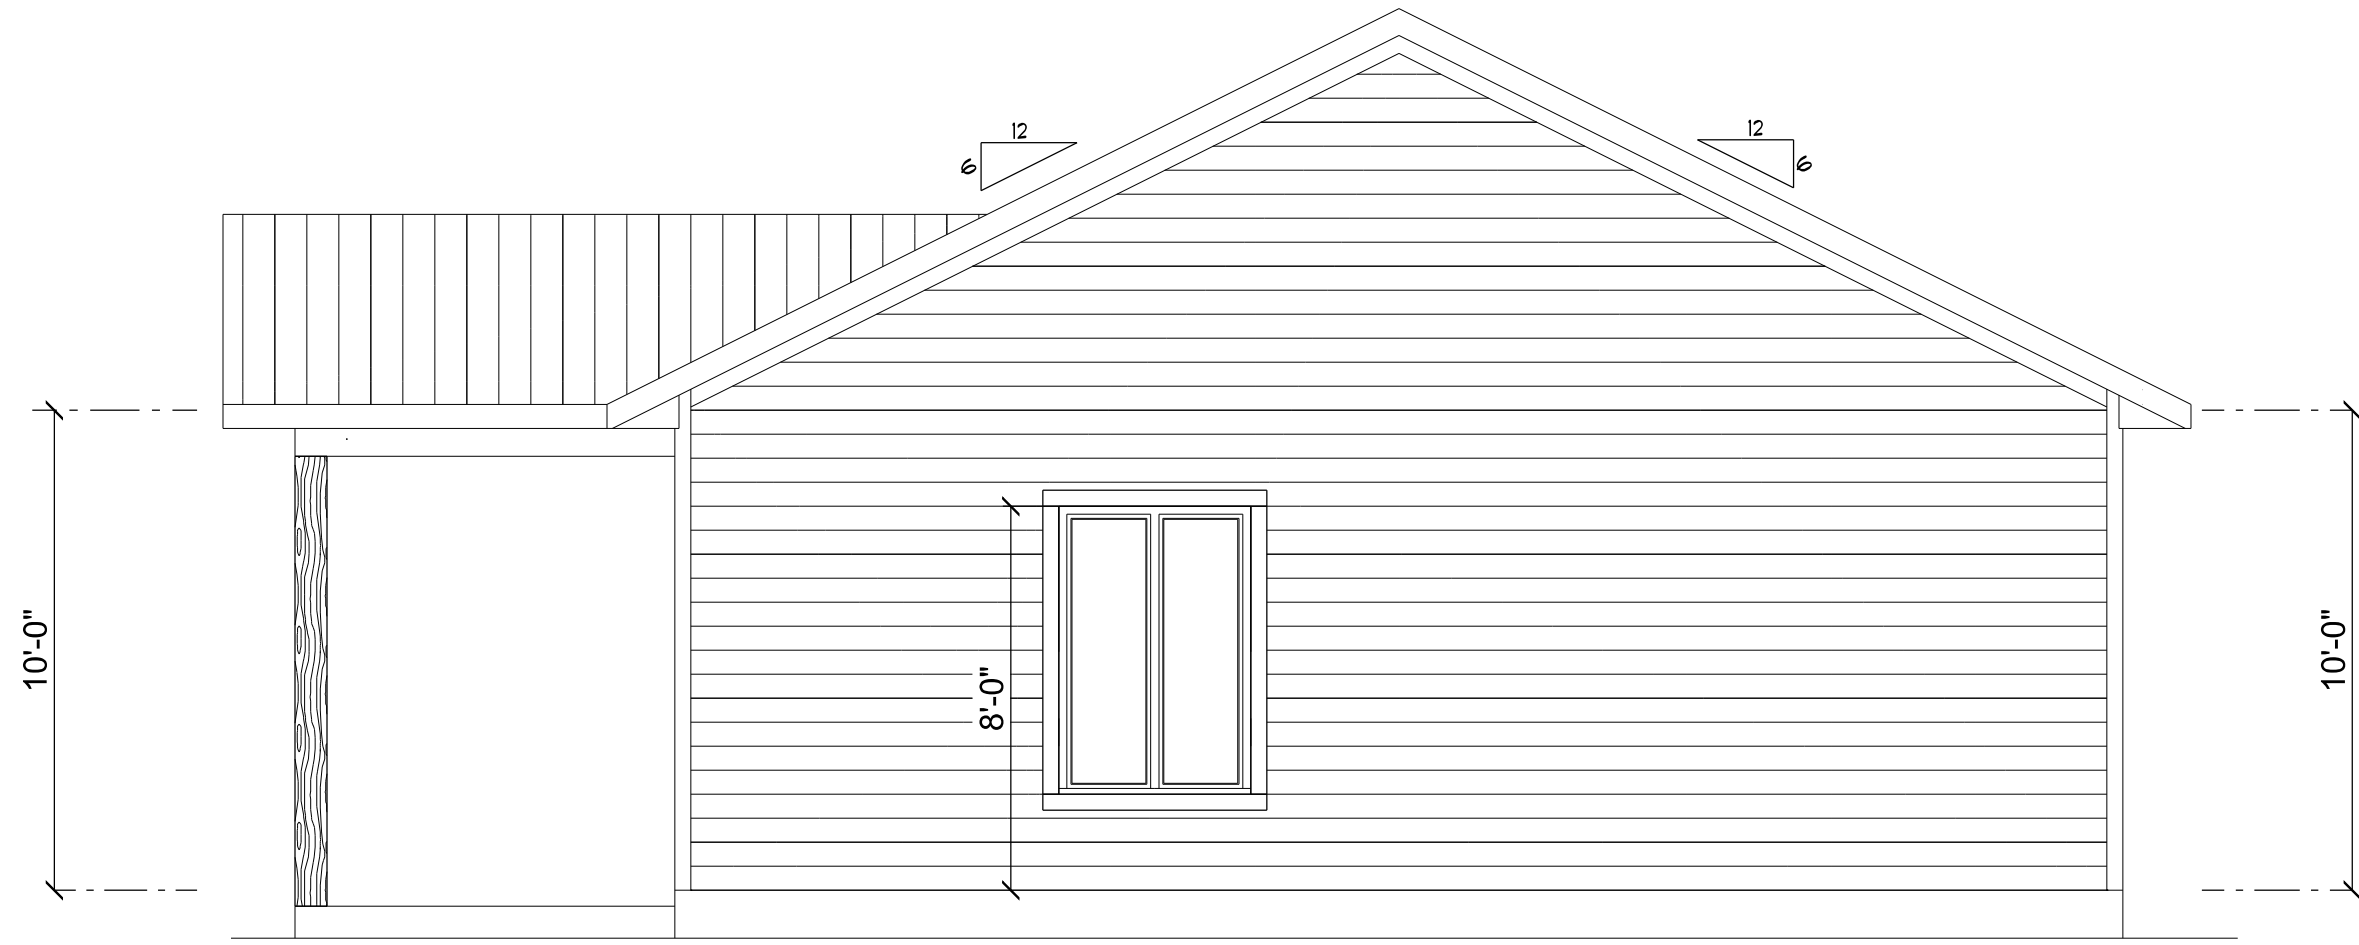

RIGHT ELEVATION
SCALE: 1/4" = 1'-0"

REVISIONS SCHEDULE	
PROPOSAL	Jan. 8th, 2024
REVISIONS	Jan. 23rd, 2024
REVISIONS	June 18th, 2024

CUSTOM HOME FOR:

DEEN RESIDENCE

COLUMBIA COUNTY, FL

RIDGEPOINT


DESIGN

566 SW ARLINGTON BLVD. STE 101, LAKE CITY, FL 32025
P: 386-288-1188
E: RIDGEPOINTDESIGN@GMAIL.COM


SHEET NUMBER

A.1

OF 6 SHEETS

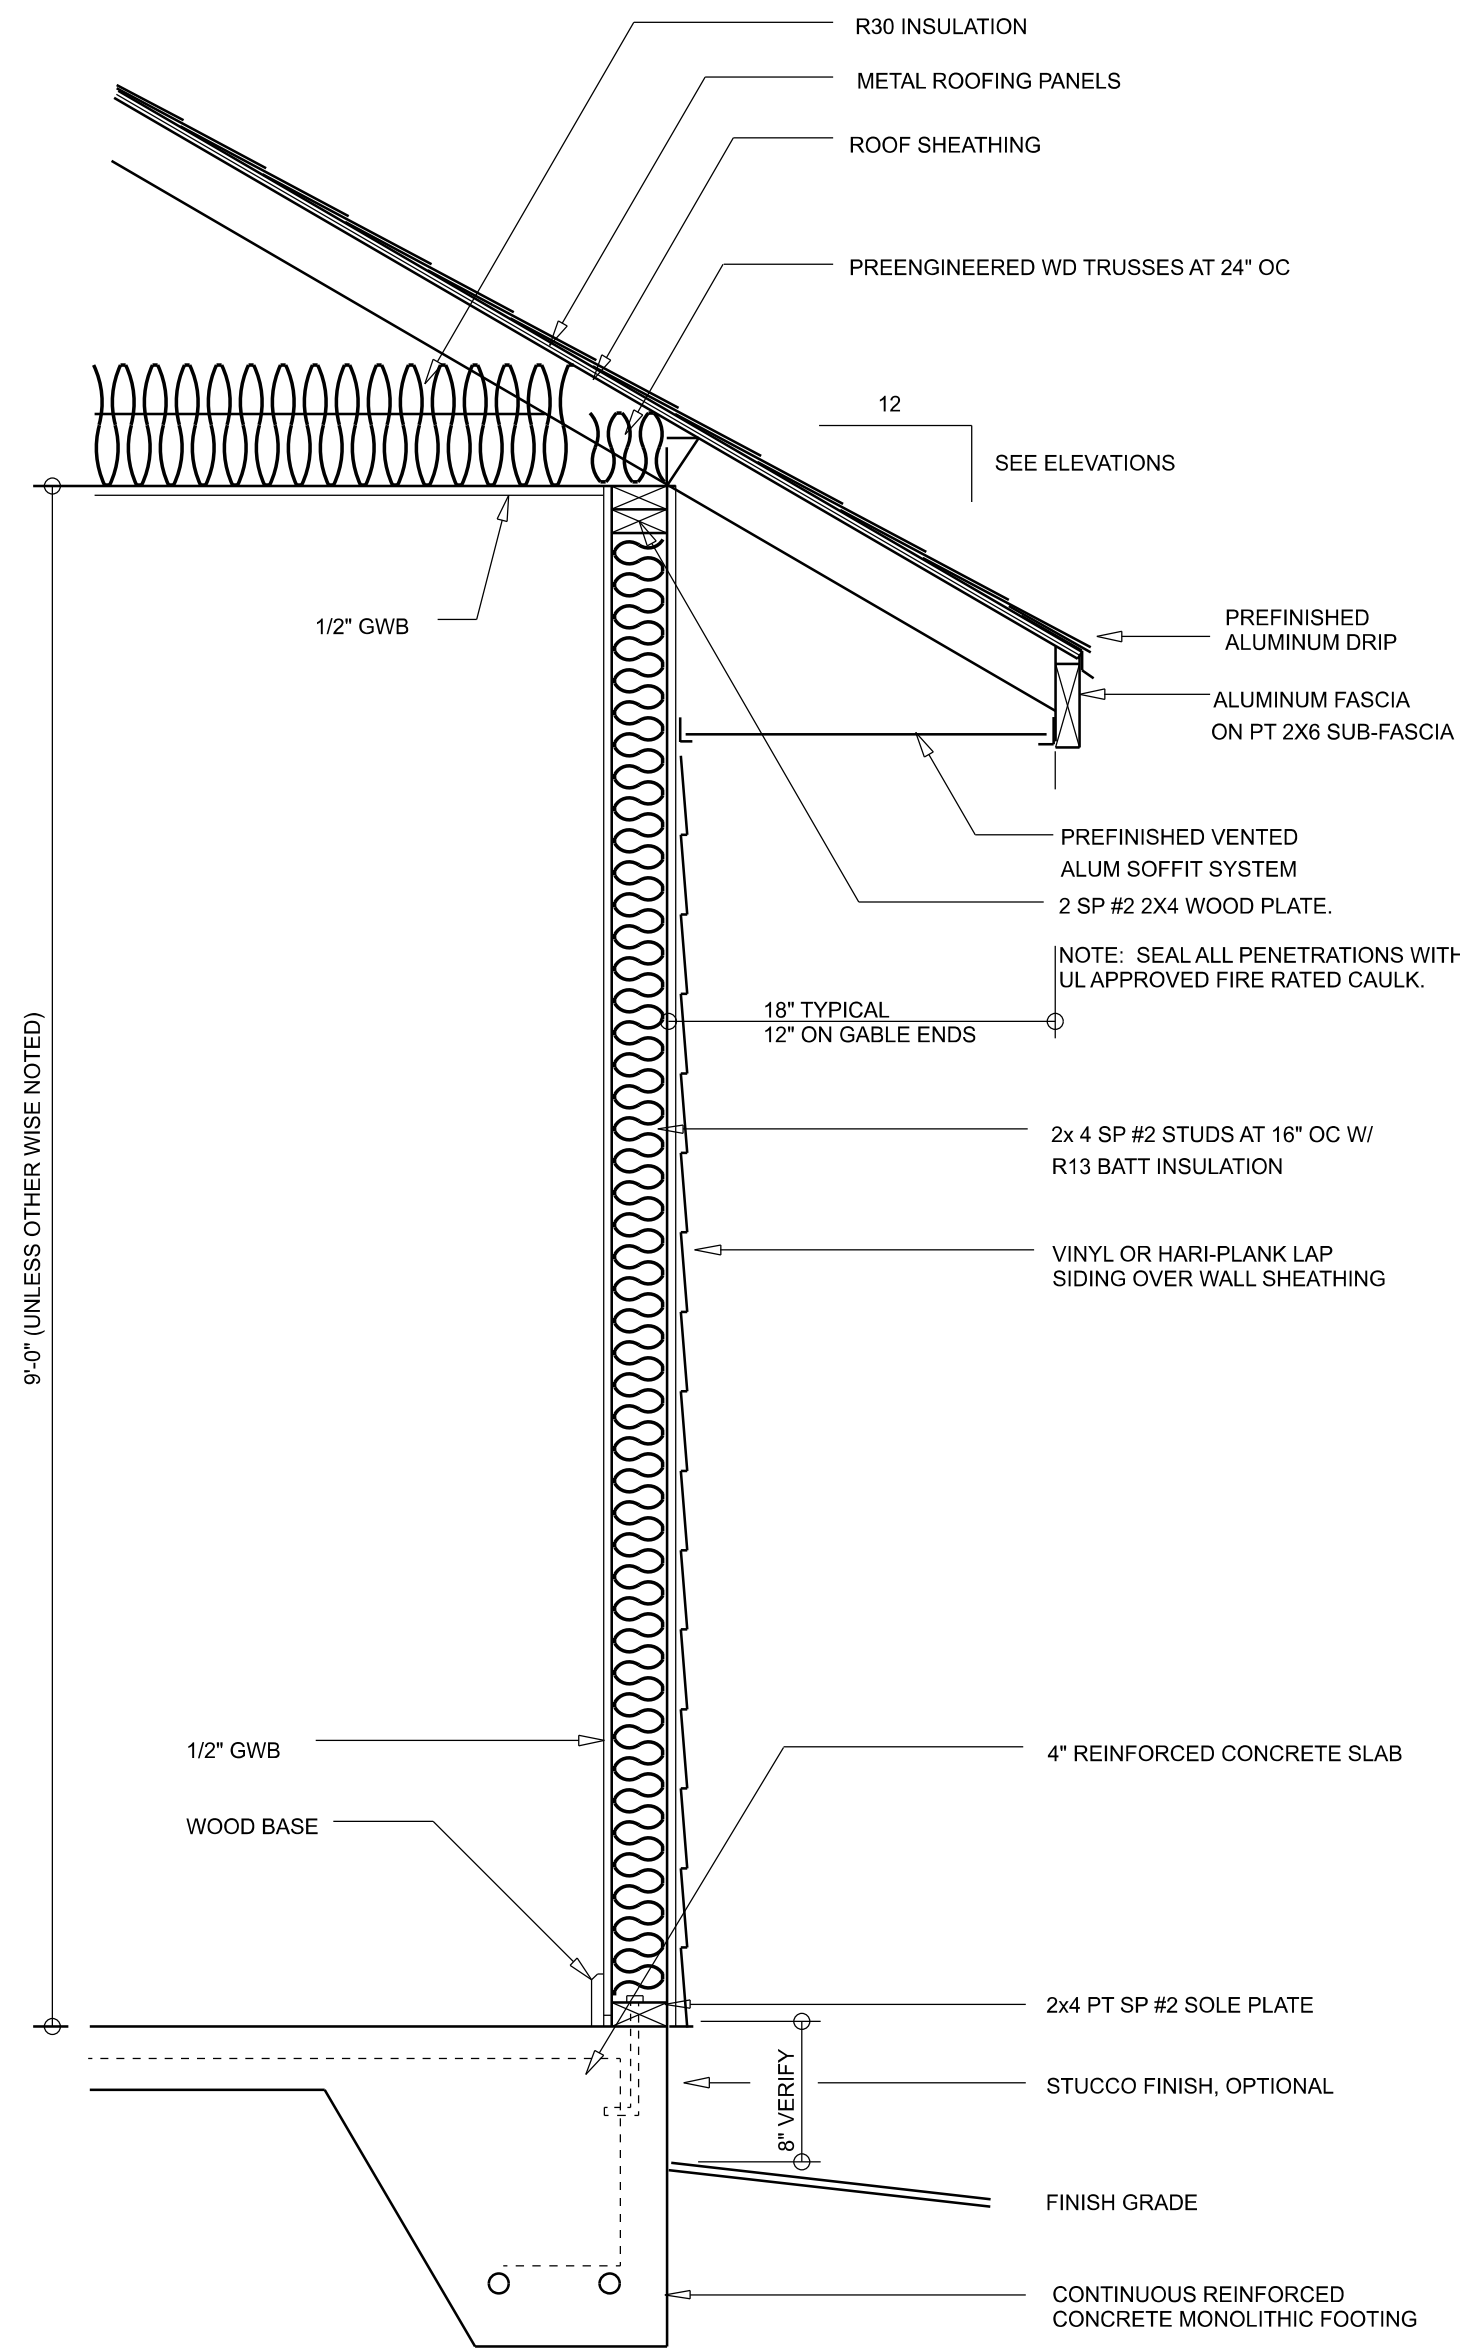

TYPICAL WALL SECTION
SCALE: 1" = 1'-0"

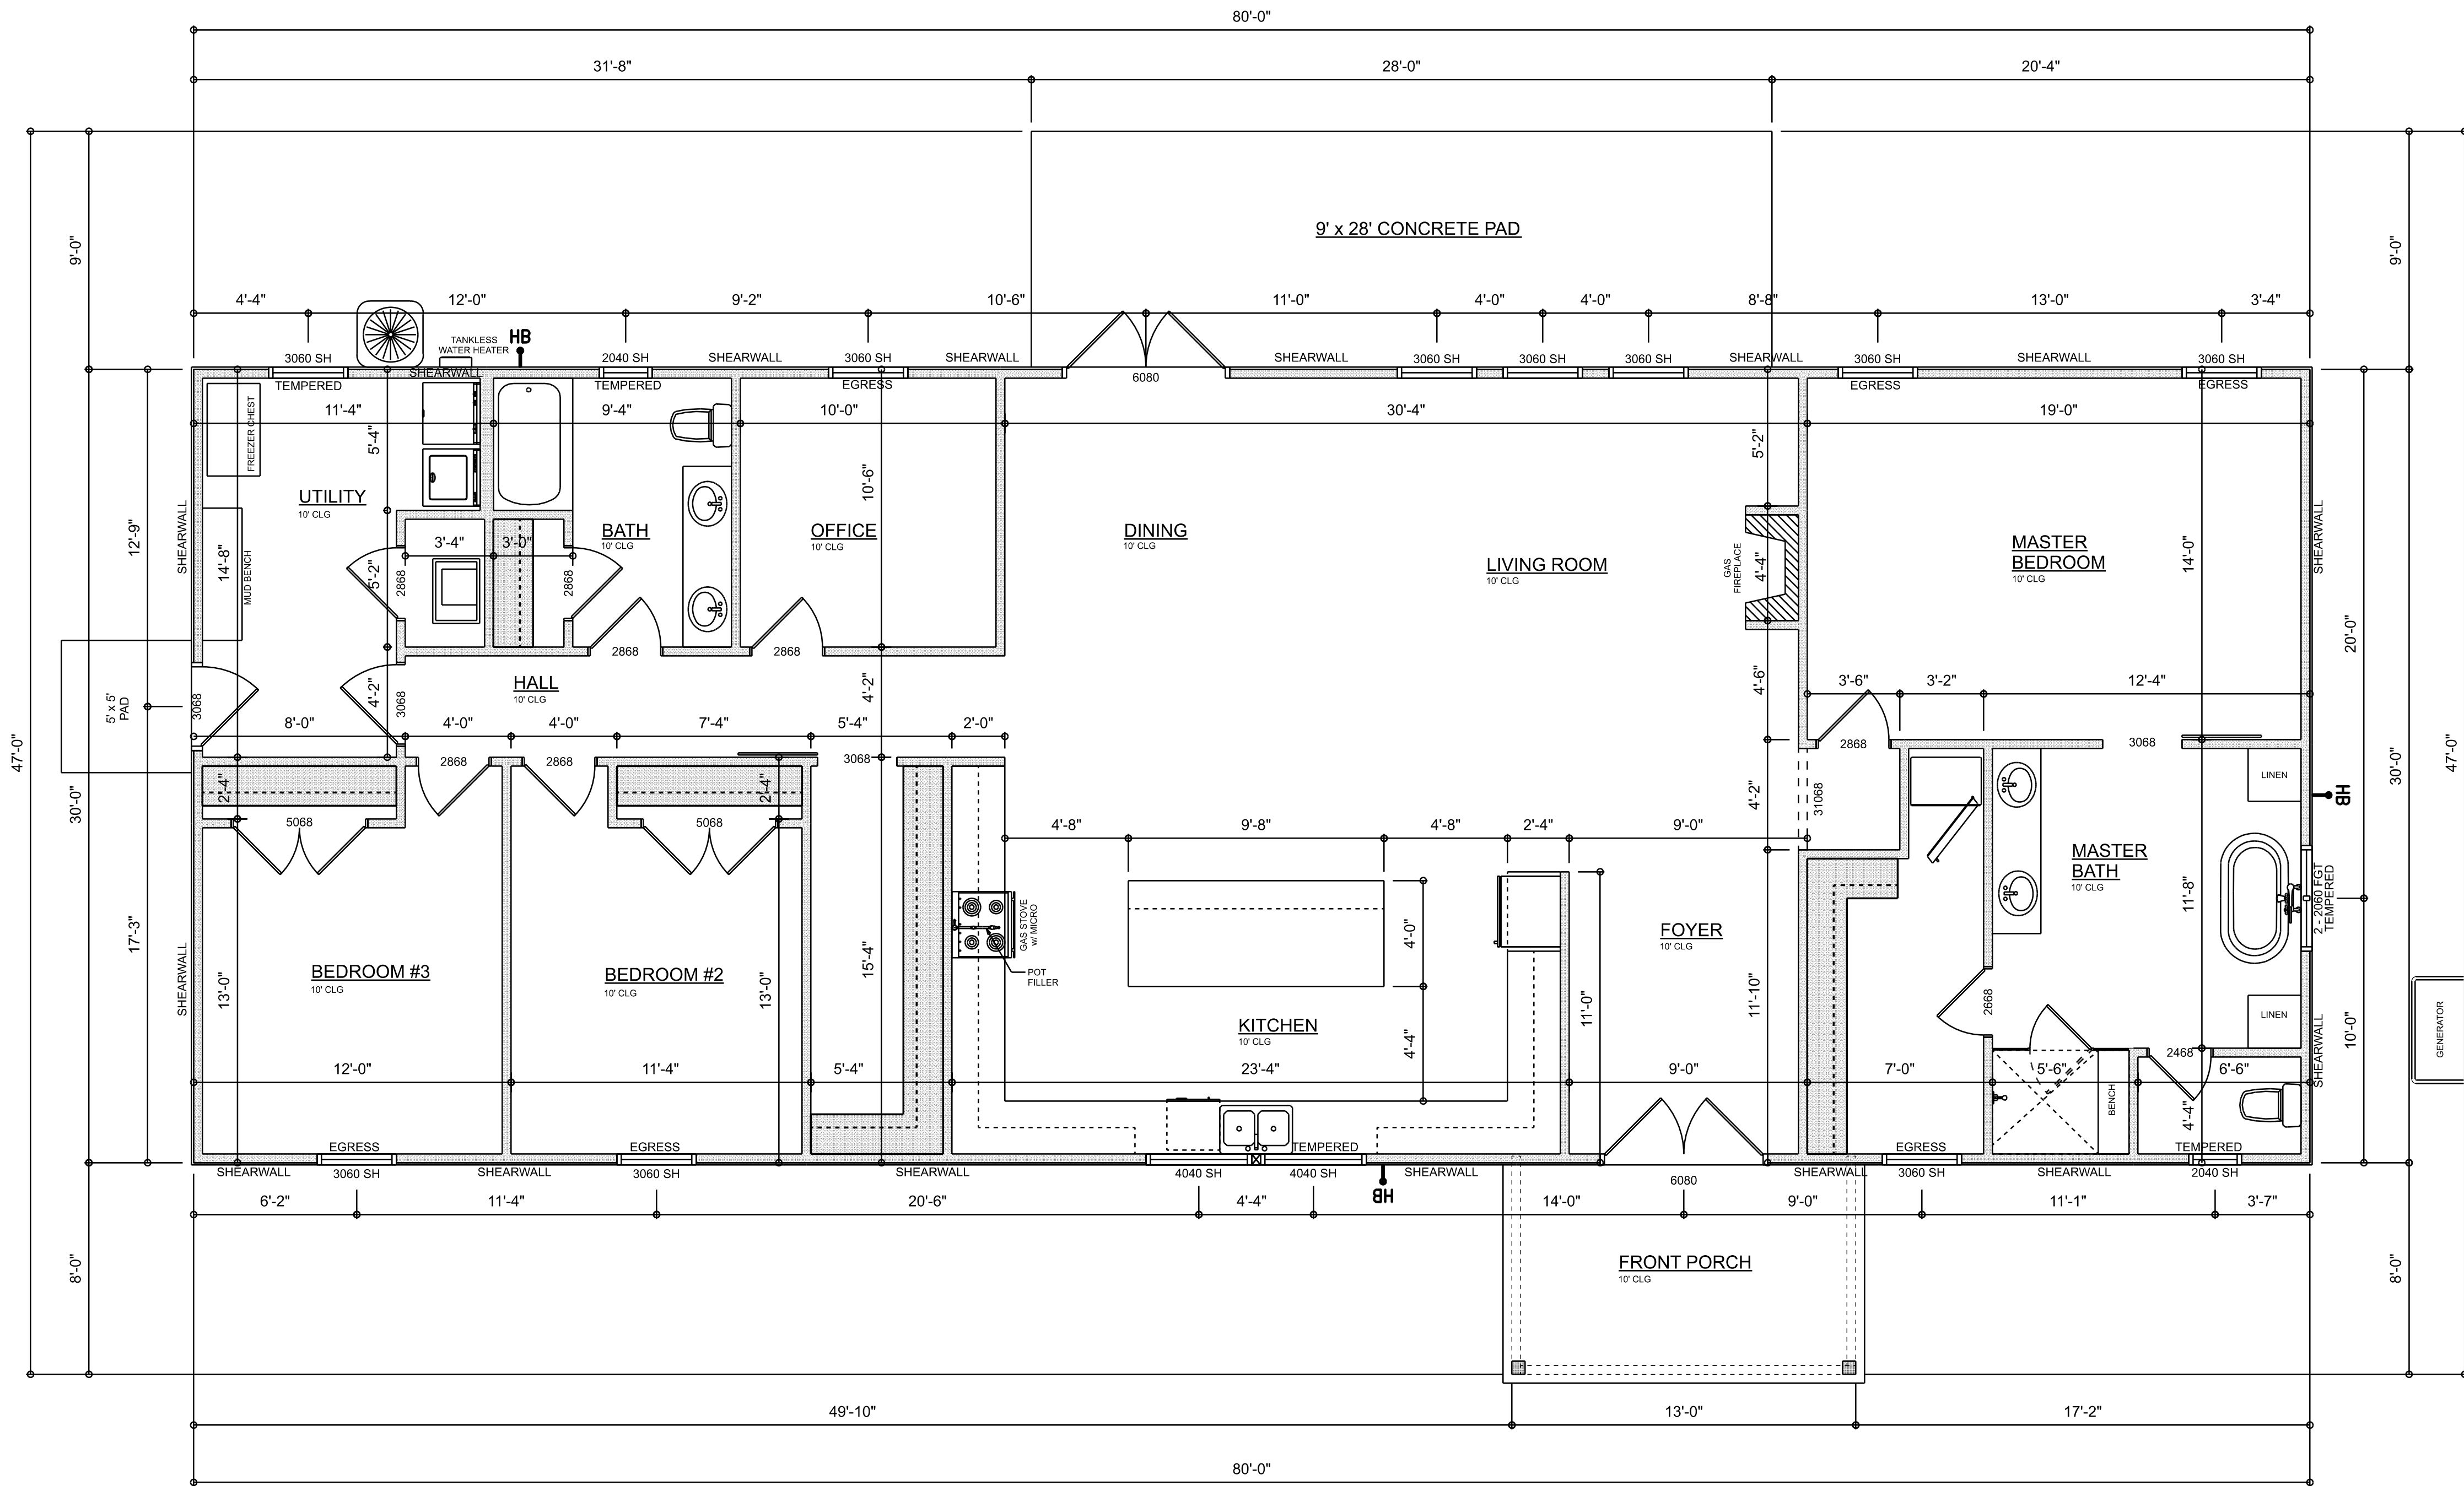

DIMENSIONED FLOOR PLAN
SCALE: 1/4" = 1'-0"
ALL WINDOW HEADER HEIGHTS TO BE AT 8'-0"

AREA SUMMARY

LIVING	2,400	S.F.
FRONT PORCH	104	S.F.
TOTAL AREA	2,504	S.F.

REVISIONS SCHEDULE	
PROPOSAL	Jan. 8th, 2024
REVISIONS	Jan. 23rd, 2024
REVISIONS	June 18th, 2024

CUSTOM HOME FOR:
DEEN RESIDENCE
COLUMBIA COUNTY, FL

RIDGEPOINT DESIGN
566 SW ARLINGTON BLVD. STE 101, LAKE CITY, FL 32025
P: 386-288-1188
E: RIDGEPOINTDESIGN@GMAIL.COM

SHEET NUMBER
A.2
OF 6 SHEETS

ELECTRICAL LEGEND		
ELECTRICAL	COUNT	SYMBOL
CEILING FAN	4	
CAN LIGHT 6inch	27	
LED CEILING LIGHT 1x4	1	
PENDANT LIGHT	3	
EXTERIOR SCONCE	3	
MOTION SECURITY LIGHT	4	
AC DISCONNECT	2	
CABLE TV OUTLET	5	
CARBON DETECTOR	2	
EXHAUST FAN	2	
OUTLET	37	
OUTLET 220v	3	
OUTLET GFI	11	
OUTLET WIP	3	
SMOKE DETECTOR	6	
STANDARD LIGHT	6	
SWITCH	22	
SWITCH 3 WAY	19	
VANITY BAR LIGHT - SMALL	4	
ELECTRIC PANEL	1	
LAN CONNECTION	1	

ELECTRICAL PLAN NOTES:

INSTALLATION SHALL BE PER LATEST NAT'L ELECTRIC CODE.

WIRE ALL APPLIANCES, HVAC UNITS AND OTHER EQUIPMENT PER MANUF. SPECIFICATIONS

CONSULT WITH THE OWNER FOR THE NUMBER OF SEPERATE TELEPHONE LINES TO BE INSTALLED

ALL SMOKE DETECTORS SHALL BE 120v W/ BATTERY BACKUP OF THE PHOTOELECTRIC TYPE, AND SHALL BE INTERLOCKED TOGETHER. INSTALL INSIDE AND NEAR ALL BEDROOMS


TELEPHONE, TELEVISION AND OTHER LOW VOLTAGE DEVICES OR OUTLETS SHALL BE AS PER THE OWNER'S DIRECTIONS, & IN ACCORDANCE W/ APPLICABLE SECTIONS OF NEC-LATEST EDITION.

ALL RECEPTICALS, NOT OTHERWISE NOTED, SHALL BE ARC FAULT INTERRUPTER TYPE, EXCEPT DEDICATED OUTLETS

ALL RECEPTICALS IN WET AREAS SHALL BE GROUND FAULT INTERRUPTER TYPE (GFI)

ALL EXTERIOR RECEPTICALS SHALL BE WEATHERPROOF GROUD FAULT INTERRUPTER TYPE (WIP/GFI)

NOTE:
ELECTRICAL CONTR SHALL PREPARE "AS-BUILT" SHOP DWGS INDICATING ALL ELECTRICAL WORK, INCLUDING ANY CHANGES TO THE ELEC. PLAN, ADD'NS TO THE ELEC. PLAN, RISER DIAGRAM, AS-BUILT PANEL SCHEDULE W/ ALL CKTS IDENTIFIED W/ CKT N#: DESCRIPTION & BRKR, SERVICE ENT. & ALL UNDERGROUND WIRE LOCATIONS/ROUTING / DEPTH. RISER DIA. SHALL INCLUDE WIRE SIZES/TYPE & EQUIPMENT TYPE W/ RATINGS & LOADS.
CONTRACTOR SHALL PROVIDE 1 COPY OF AS-BUILT DWGS TO OWNER & 1 COPY TO THE PERMIT ISSUING AUTHORITY

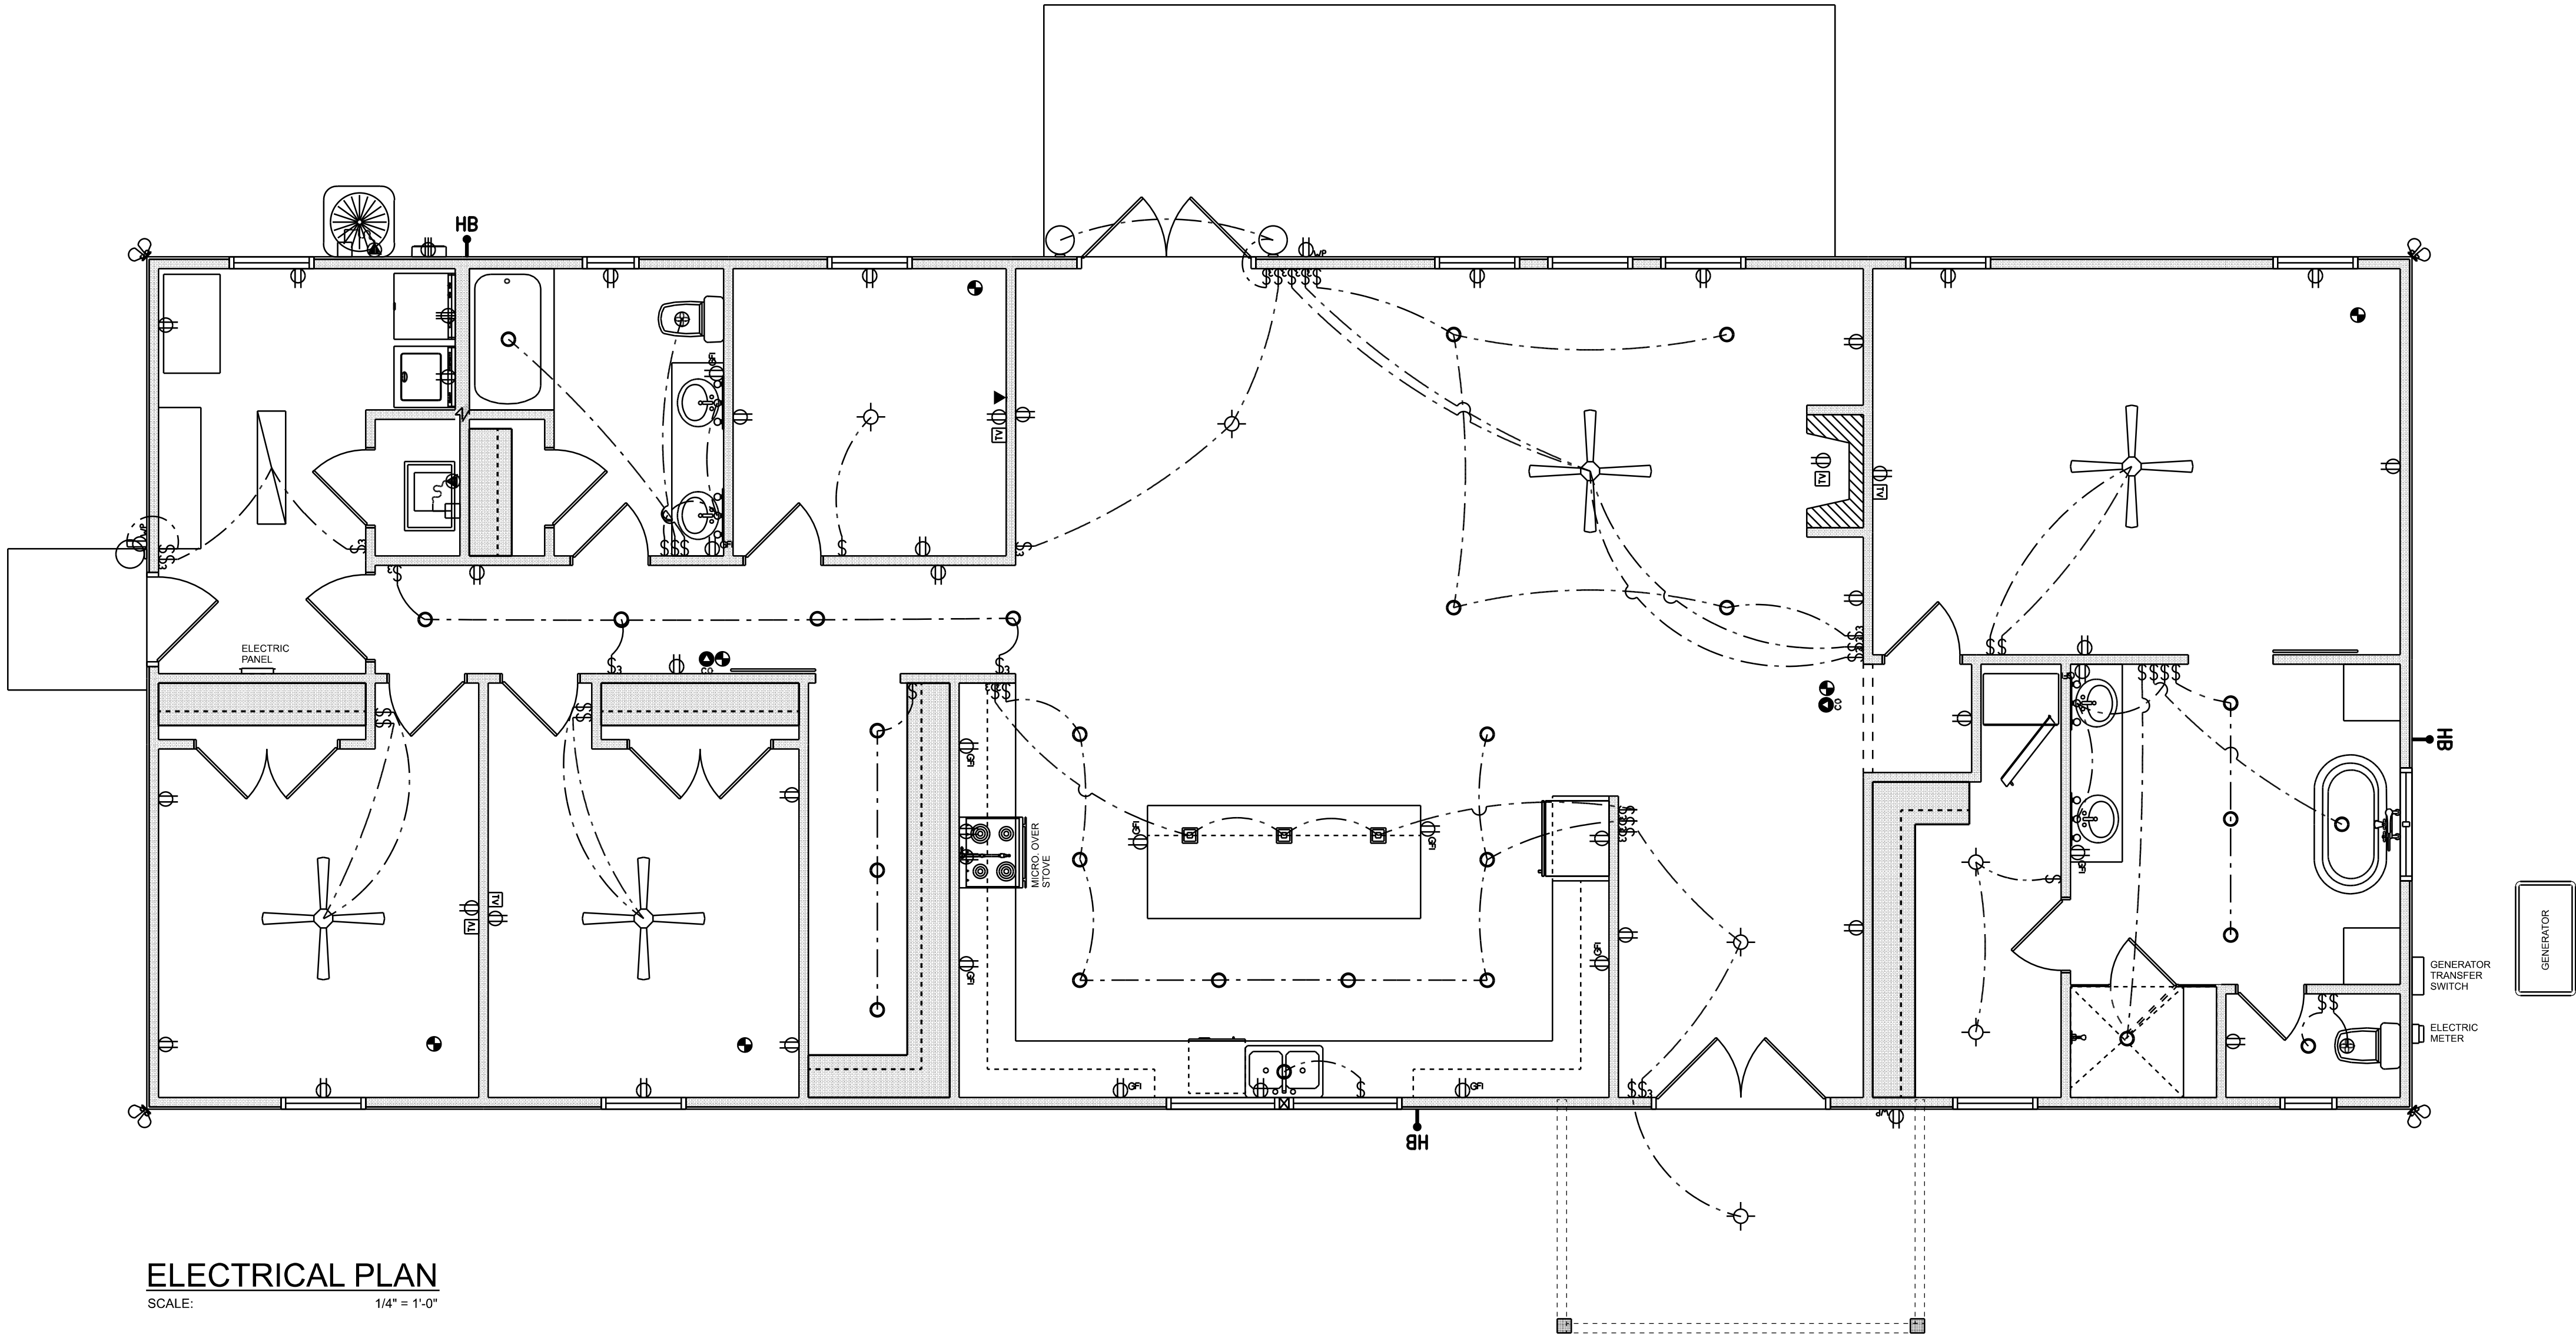

ELECTRICAL PLAN
SCALE: 1/4" = 1'-0"

REVISIONS SCHEDULE	
PROPOSAL	Jan. 8th, 2024
REVISIONS	Jan. 23rd, 2024
REVISIONS	June 18th, 2024

CUSTOM HOME FOR:
DEEN RESIDENCE
COLUMBIA COUNTY, FL

RIDGEPOINT

DESIGN

566 SW ARLINGTON BLVD. STE 101, LAKE CITY, FL 32025

P: 386-288-1188

E: RIDGEPOINTDESIGN@GMAIL.COM