





**RIDGEPOINT
DESIGN, INC.**
496 SW RINGCT. LAKE CITY, FLORIDA, 32005
P. 316-282-1188


SHEET NUMBER
A.1
OF 4 SHEETS

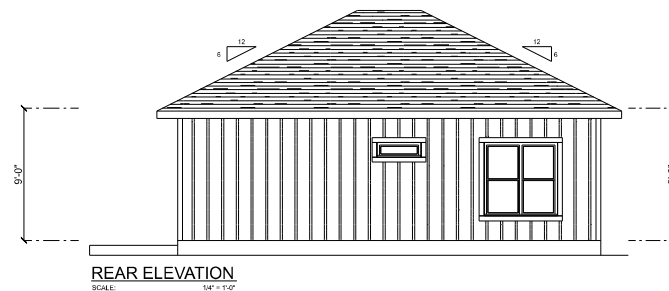

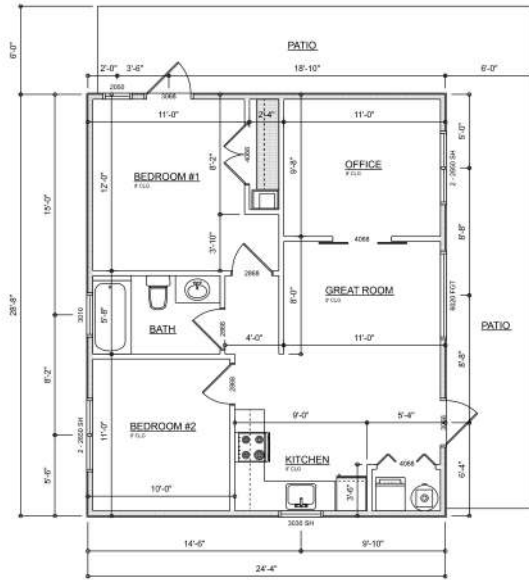

DIMENSIONED FLOOR PLAN
SCALE: 1/8" = 1'-0"

AREA SUMMARY		
LIVING	698	S.F.
TOTAL AREA	698	S.F.

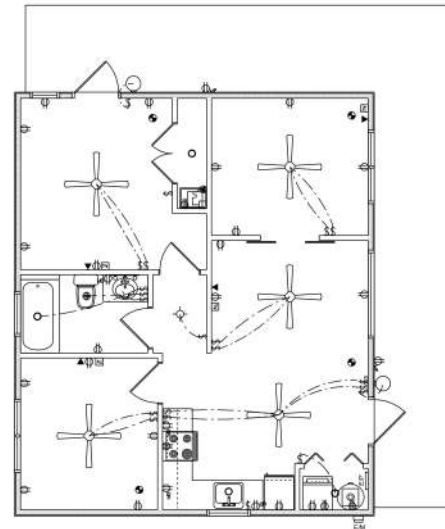

ELECTRICAL FLOOR PLAN
SCALE: 1/8" = 1'-0"

ELECTRICAL LEGEND		
ELECTRICAL	COUNT	SYMBOL
CEILING FAN	5	
CAN LIGHT 6inch	4	
EXTERIOR SCONCE	2	
CABLE TV OUTLET	4	
CATS OUTLET	4	
EXHAUST FAN	1	
OUTLET	20	
OUTLET 220v	4	
OUTLET GFI	4	
OUTLET WP	2	
SMOKE DETECTOR	4	
STANDARD LIGHT	1	
SWITCH	17	
SWITCH 3 WAY	4	
VANITY BAR LIGHT - SMALL	1	
AC DISCONNECT	1	
ELECTRIC PANEL	1	

ELECTRICAL PLAN NOTES:

INSTALLATION SHALL BE PER LATEST NATL. ELECTRIC CODE.
WIRE ALL APPLIANCES, HVAC UNITS AND OTHER EQUIPMENT PER MANUF. SPECIFICATIONS.
CONSULT WITH THE OWNER FOR THE NUMBER OF SEPERATE TELEPHONE LINES TO BE INSTALLED.
ALL SMOKE DETECTORS SHALL BE 120v W/ BATTERY BACKUP OF THE PHOTOELECTRIC TYPE, AND SHALL BE INTERLOCKED TOGETHER. INSTALL INSIDE AND NEAR ALL BEDROOMS.
TELEPHONE, TELEVISION AND OTHER LOW VOLTAGE DEVICES OR OUTLETS SHALL BE AS PER THE OWNER'S DIRECTIONS, & IN ACCORDANCE W/ APPLICABLE SECTIONS OF NEC-LATEST EDITION.
ALL RECEPTICALS, NOT OTHERWISE NOTED, SHALL BE ARC FAULT INTERRUPTER TYPE, EXCEPT DEDICATED OUTLETS.
ALL RECEPTICALS IN WET AREAS SHALL BE GROUND FAULT INTERRUPTER TYPE (GFI).
ALL EXTERIOR RECEPTICALS SHALL BE WEATHERPROOF GROUND FAULT INTERRUPTER TYPE (WVGF).
NOTE:
ELECTRICAL CONTR. SHALL PREPARE "AS-BUILT" SHOP DWGS INDICATING ALL ELECTRICAL WORK, INCLUDING ANY CHANGES TO THE ELEC. PLAN, ADDS TO THE ELEC. PLAN, RISER DIAGRAM, AS-BUILT PANEL SCHEDULE W/ ALL CIRTS IDENTIFIED W/ CIRCT N. DESCRIPTION & BRKR. SERVICE ENT. & ALL UNDERGROUND WIRE LOCATIONS/ROUTING / DEPTH. RISER DIA. SHALL INCLUDE WIRE SIZE/TYPER & EQUIPMENT TYPE W/ RATINGS & LOADS.
CONTRACTOR SHALL PROVIDE 1 COPY OF AS-BUILT DWGS TO OWNER & 1 COPY TO THE PERMIT ISSUING AUTHORITY.

REVISIONS SCHEDULE		
SEP 20th, 2022	PROPOSAL	
NOV 21th, 2022	REVISIONS	

CUSTOM HOME FOR:
BULLARD RESIDENCE
4207 SW County Rd 242, Lake City, FL 32024

RIDGEPOINT DESIGN, INC.
496 SW RING CT. LAKE CITY, FLORIDA 32025
P: 386-288-1188
E: RIDGEPOINTDESIGN@GMAIL.COM

SHEET NUMBER
A.2
OF 4 SHEETS