




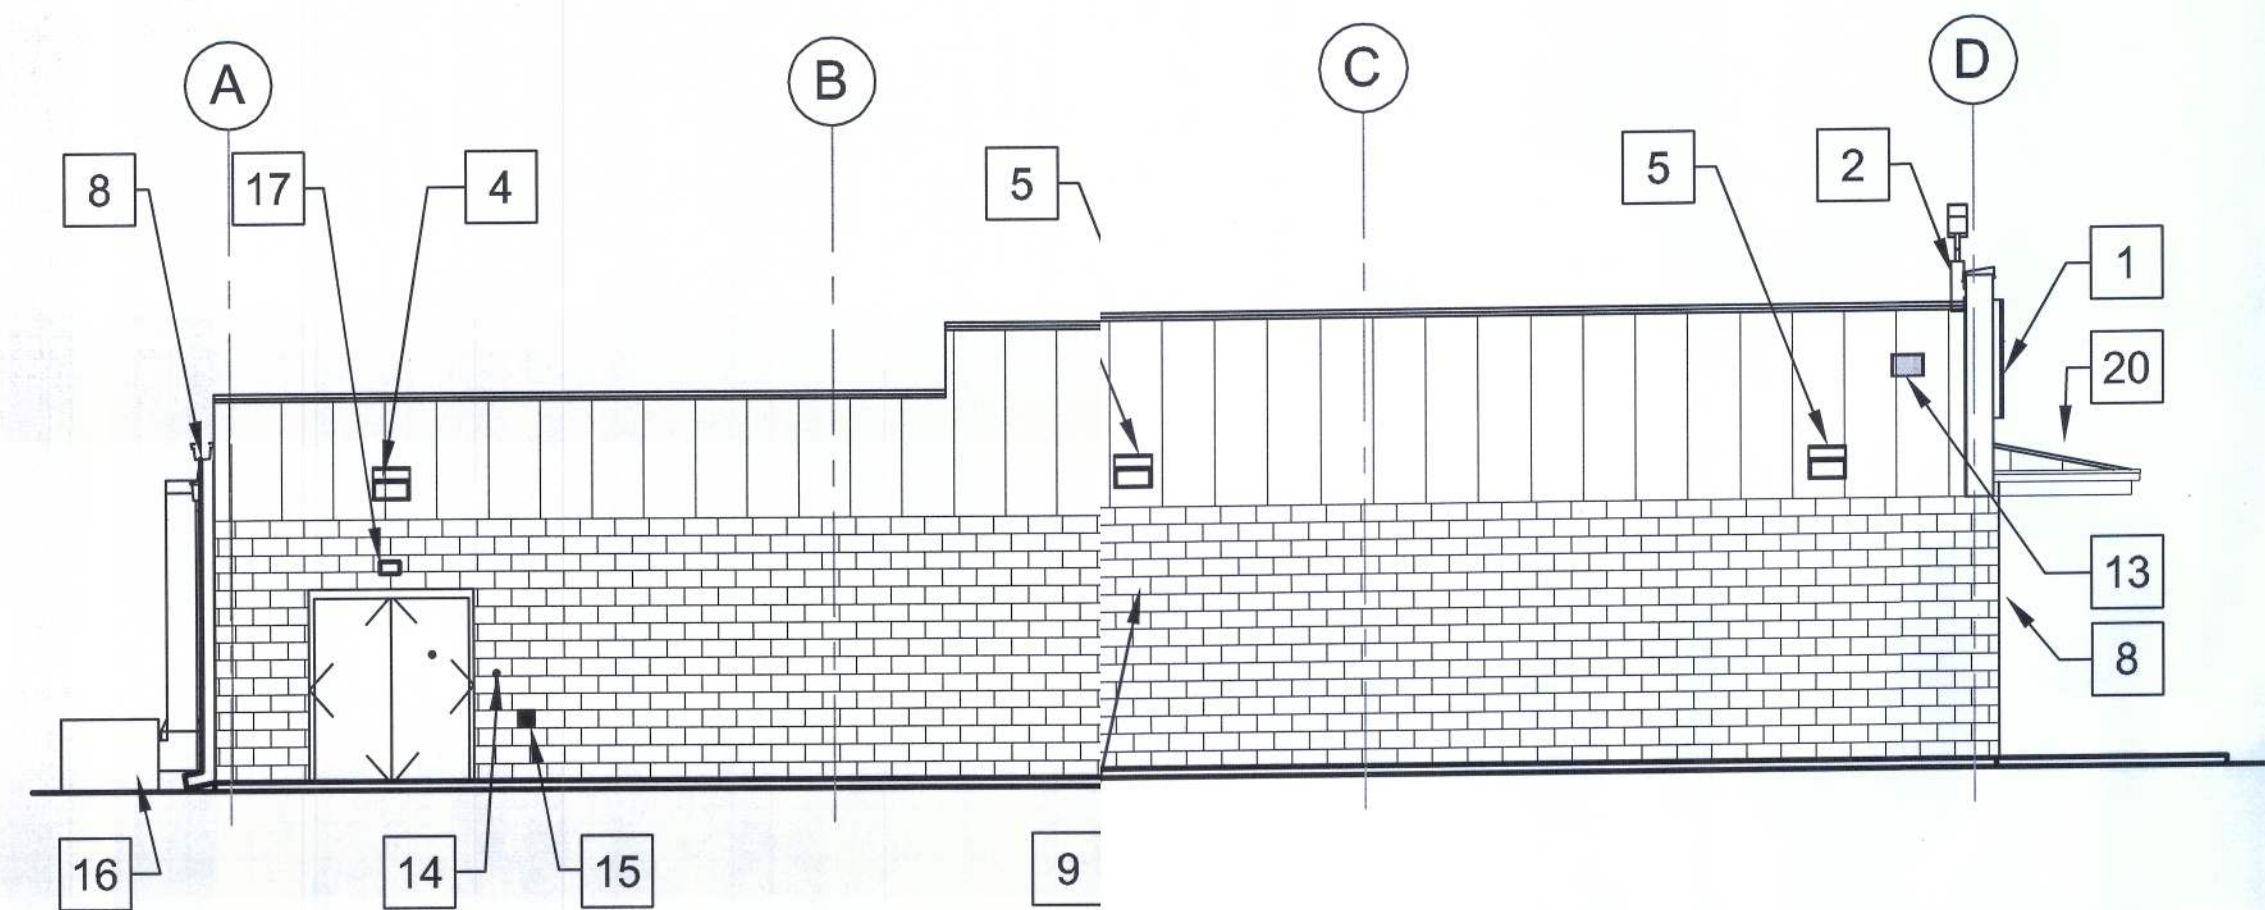


1 LEFT ELEVATION
A2.C N.T.S.

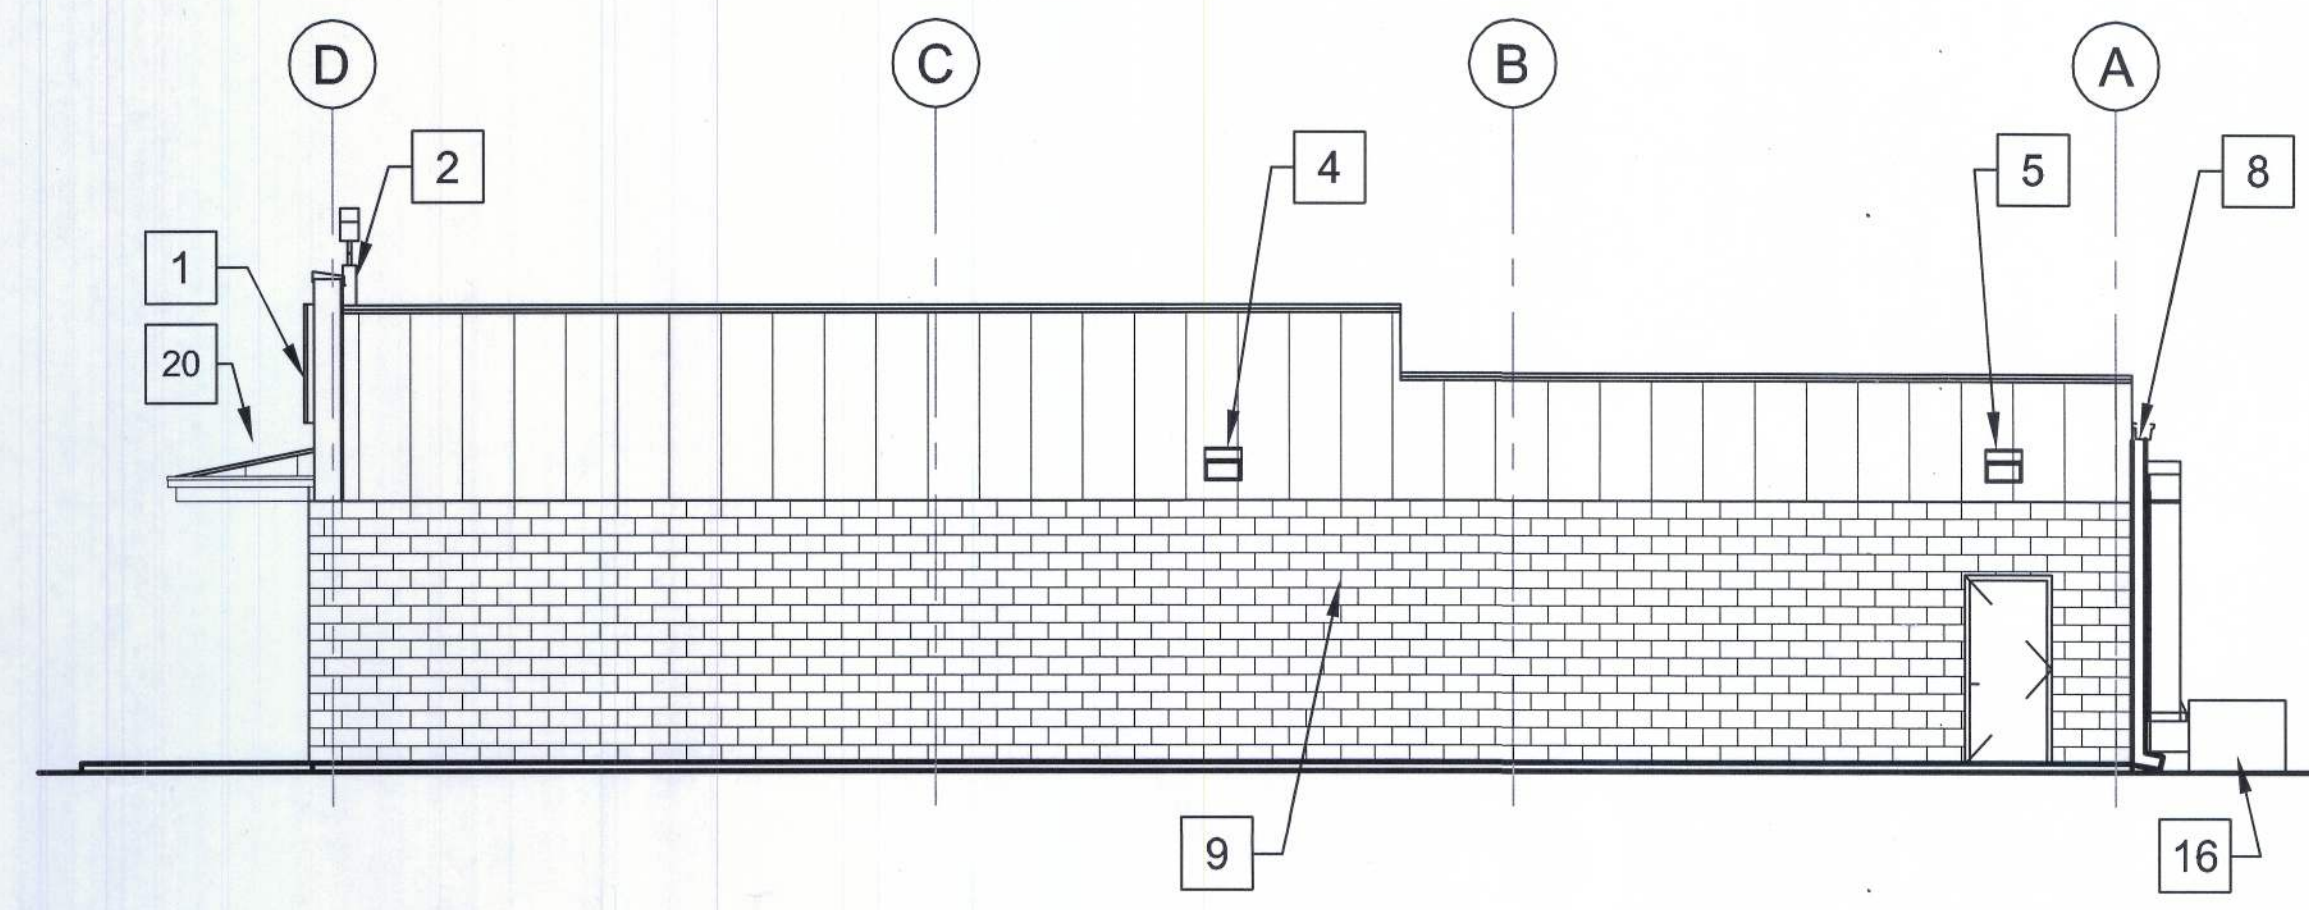

2 RIGHT ELEVATION
A2.C N.T.S.

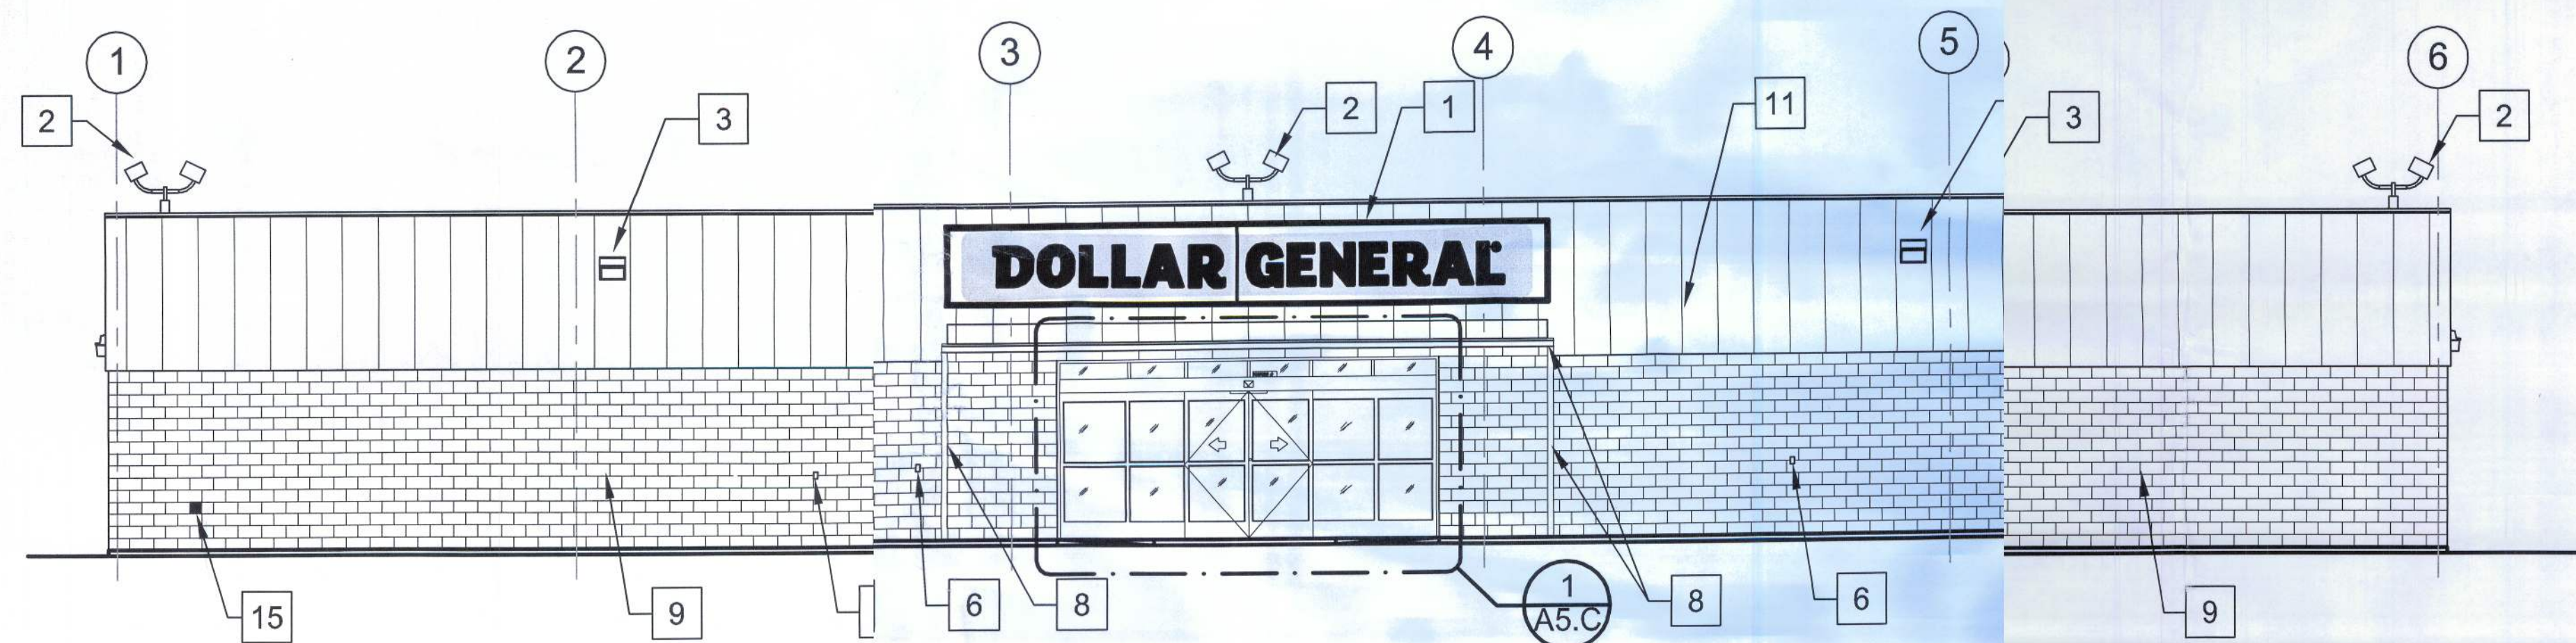

3 FRONT ELEVATION
A2.C N.T.S.

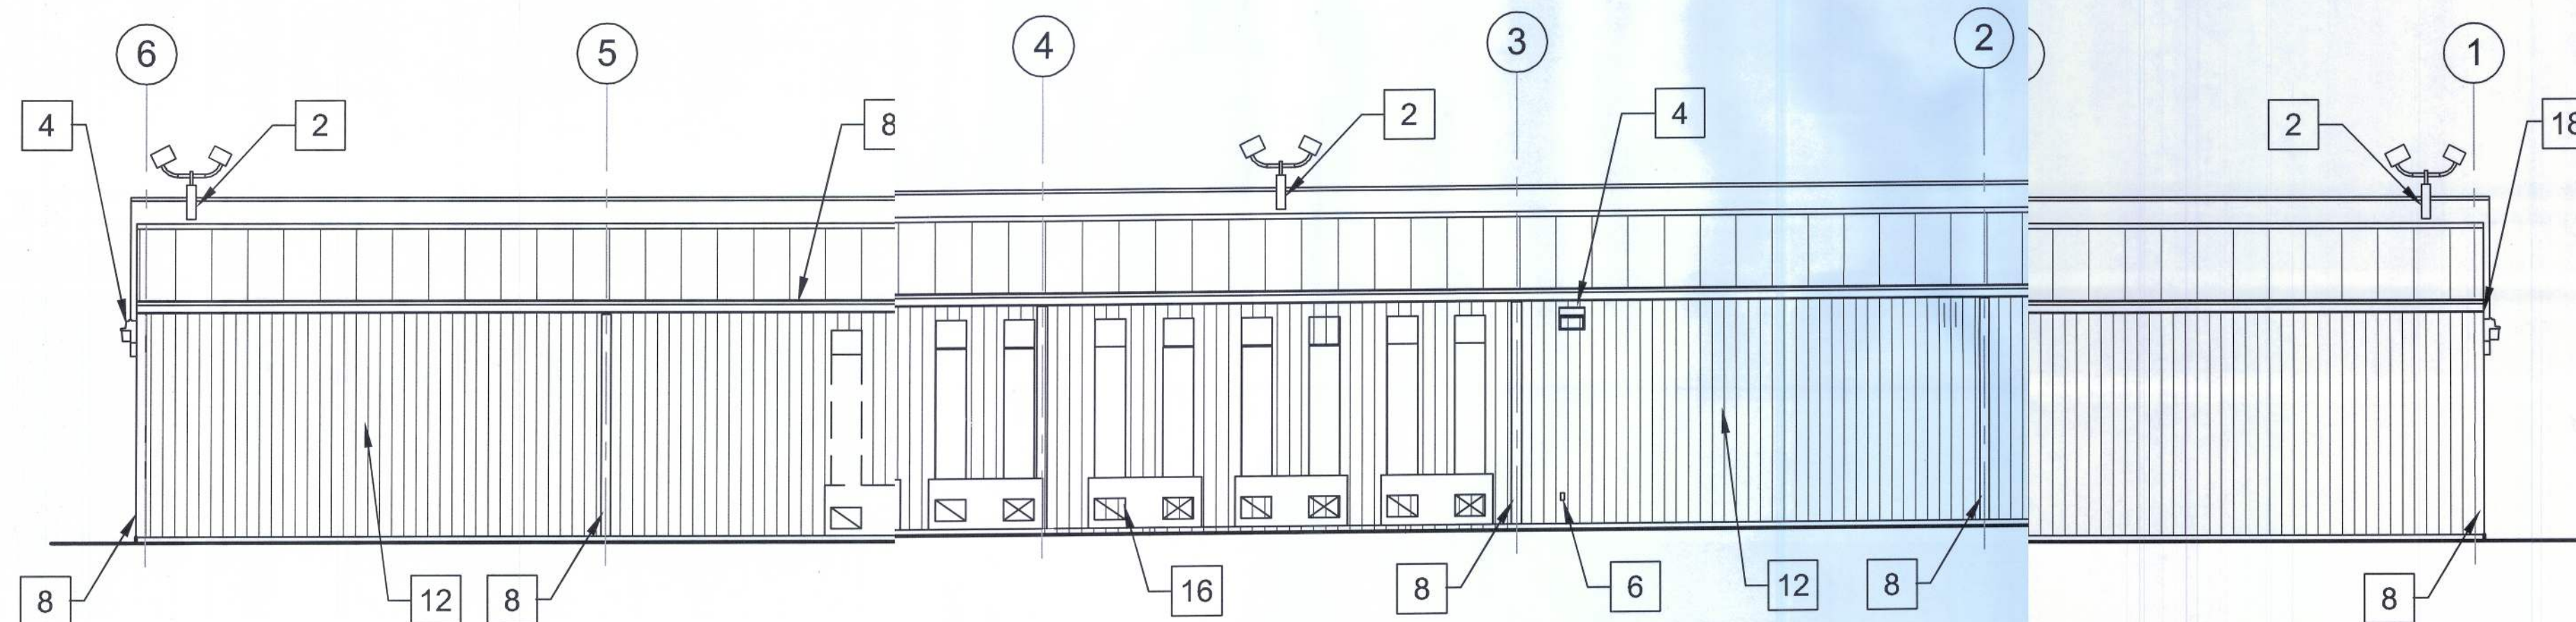

4 REAR ELEVATION
A2.C N.T.S.

ELEVATION KEYED NOTES

- 1 SIGN FURNISHING AND INSTALLATION IS THE RESPONSIBILITY OF DOLLAR GENERAL CORP. WITH CIRCUIT AS NOTED ON ELECTRICAL PLAN TO MEET CITY REQUIREMENTS. SIGN TO BE CENTERED ON FRONT OF BUILDING. CONTRACTOR IS TO PROVIDE ADEQUATE BLOCKING AS REQUIRED BY SIGN MANUFACTURER TO SUPPORT SIGN WEIGHT OF UP TO 1,400 LBS. EXTERIOR CANOPY SIGN SHALL BE SUPPORTED BY THE FACE OF THE CANOPY. COORDINATE THE PROPER SIGNAGE TO BE USED WITH DOLLAR GENERAL.
- 2 BI-DIRECTIONAL SECURITY LIGHT. REFER TO ELECTRICAL DRAWINGS FOR ADDITIONAL INFORMATION.
- 3 WALL PACK. 16'-6" A.F.F. TO TOP OF WALL PACK. REFER TO ELECTRICAL DRAWINGS FOR ADDITIONAL INFORMATION.
- 4 WALL PACK 12'-0" A.F.F. TO TOP OF WALL PACK. (REQUIRED). REFER TO E2 FOR ADDITIONAL INFORMATION.
- 5 WALL PACK. (ALTERNATE PARKING LIGHT) REFER TO ELECTRICAL DRAWINGS FOR ADDITIONAL INFORMATION. REQUIRED ONLY IF THERE IS PARKING THIS SIDE OF BUILDING.
- 6 RECEPTACLE. REFER TO E1 FOR ADDITIONAL INFORMATION.
- 7 TRIM - SEE SHEET S1 FOR COLOR
- 8 GUTTER AND DOWNSPOUT - SEE SHEET S1 FOR COLOR
- 9 8" SPLIT FACE CONCRETE MASONRY UNIT. PAINT TO MATCH SIDE WALL PANELS. SW # 7037 BALANCED BEIGE
- 10 METAL ROOF. GALVALUME FINISH.
- 11 FASCIA PANEL. SEE SHEET S1 FOR COLOR.
- 12 METAL PANEL. SEE SHEET S1 FOR COLOR.
- 13 VENT FOR BATHROOM EXHAUST. REFER TO M1 FOR ADDITIONAL INFORMATION.
- 14 DOOR BUZZER. REFER TO E1 FOR ADDITIONAL INFORMATION.
- 15 WALL HYDRANT. REFER TO P1 FOR ADDITIONAL INFORMATION.
- 16 HVAC UNITS. REFER TO MECHANICAL SHEET M1 FOR MORE INFORMATION.
- 17 OUTSIDE AIR TEMP. SENSOR MOUNTED OVER RECEIVING DOORS @ 8'-0" A.F.F.
- 18 MINIMUM EAVE HEIGHT IS 14'-0" A.F.F.
- 19 WALL PACK 1'-0" BELOW GABLE PEAK.
- 20 IN NORTHERN CLIMATES, PROVIDE SNOW GUARDS ON ROOF PER LOCAL CODE.

EXTERIOR ELEVATIONS



**CCNCEPT
CONSTRUCTION**

License#: CGC1515491
ph: 386-75-8887
fx: 386-75-1919
295 NW Commons Loop
Suite 115-23
Lake City FL 32055
www.conceptconstruction.net

DOLLAR GENERAL®

LAKE CITY, FLORIDA
COUNTY RD 247, LAKE CITY, FL
STORE # 12851

2010 PROTOTYPE - PLAN "C" 9,100

DATE 30 MAR 2010

Design JFB 06/10/10

Revisions JFB 10/20/10

SHEET NUMBER

A2.C