

ITN DOES NOT CLAIM ANY RESPONSIBILITY FOR THE ACCURACY OF THE INFORMATION CONTAINED HEREIN. THE INFORMATION IS PROVIDED AS IS, WITHOUT WARRANTY OF ANY KIND, EXPRESS OR IMPLIED, INCLUDING BUT NOT LIMITED TO THE WARRANTIES OF MERCHANTABILITY, FITNESS FOR A PARTICULAR PURPOSE AND NONINFRINGEMENT. THE INFORMATION IS NOT TO BE USED FOR ANY OTHER PURPOSE.

2030 SOFT.
2030 SOFT.
616 SOFT.
316 SOFT.
521 SOFT.

FIRST FLOOR PLAN
BASEMENT
GARAGE
PORCH
DECK
ROOF FRAMING PLAN

LOG HOME PLANS FOR:
ANTHONY MIKULIC
COLUMBIA CO., FL


LOG PROFILE
FOR THIS LOG HOME

INSIDE
OUTSIDE

8/8 ORIGINAL CYPRESS
CLASSIC D SHAPE

IN THE WOODS
Exceptional Log Homes



DATE: 12-04-01
DRAWN BY: A. ABRAMS
SCALE: AS NOTED
CUST. ID #: 1251571
REVISIONS:
SHEET NO. 2 OF 2

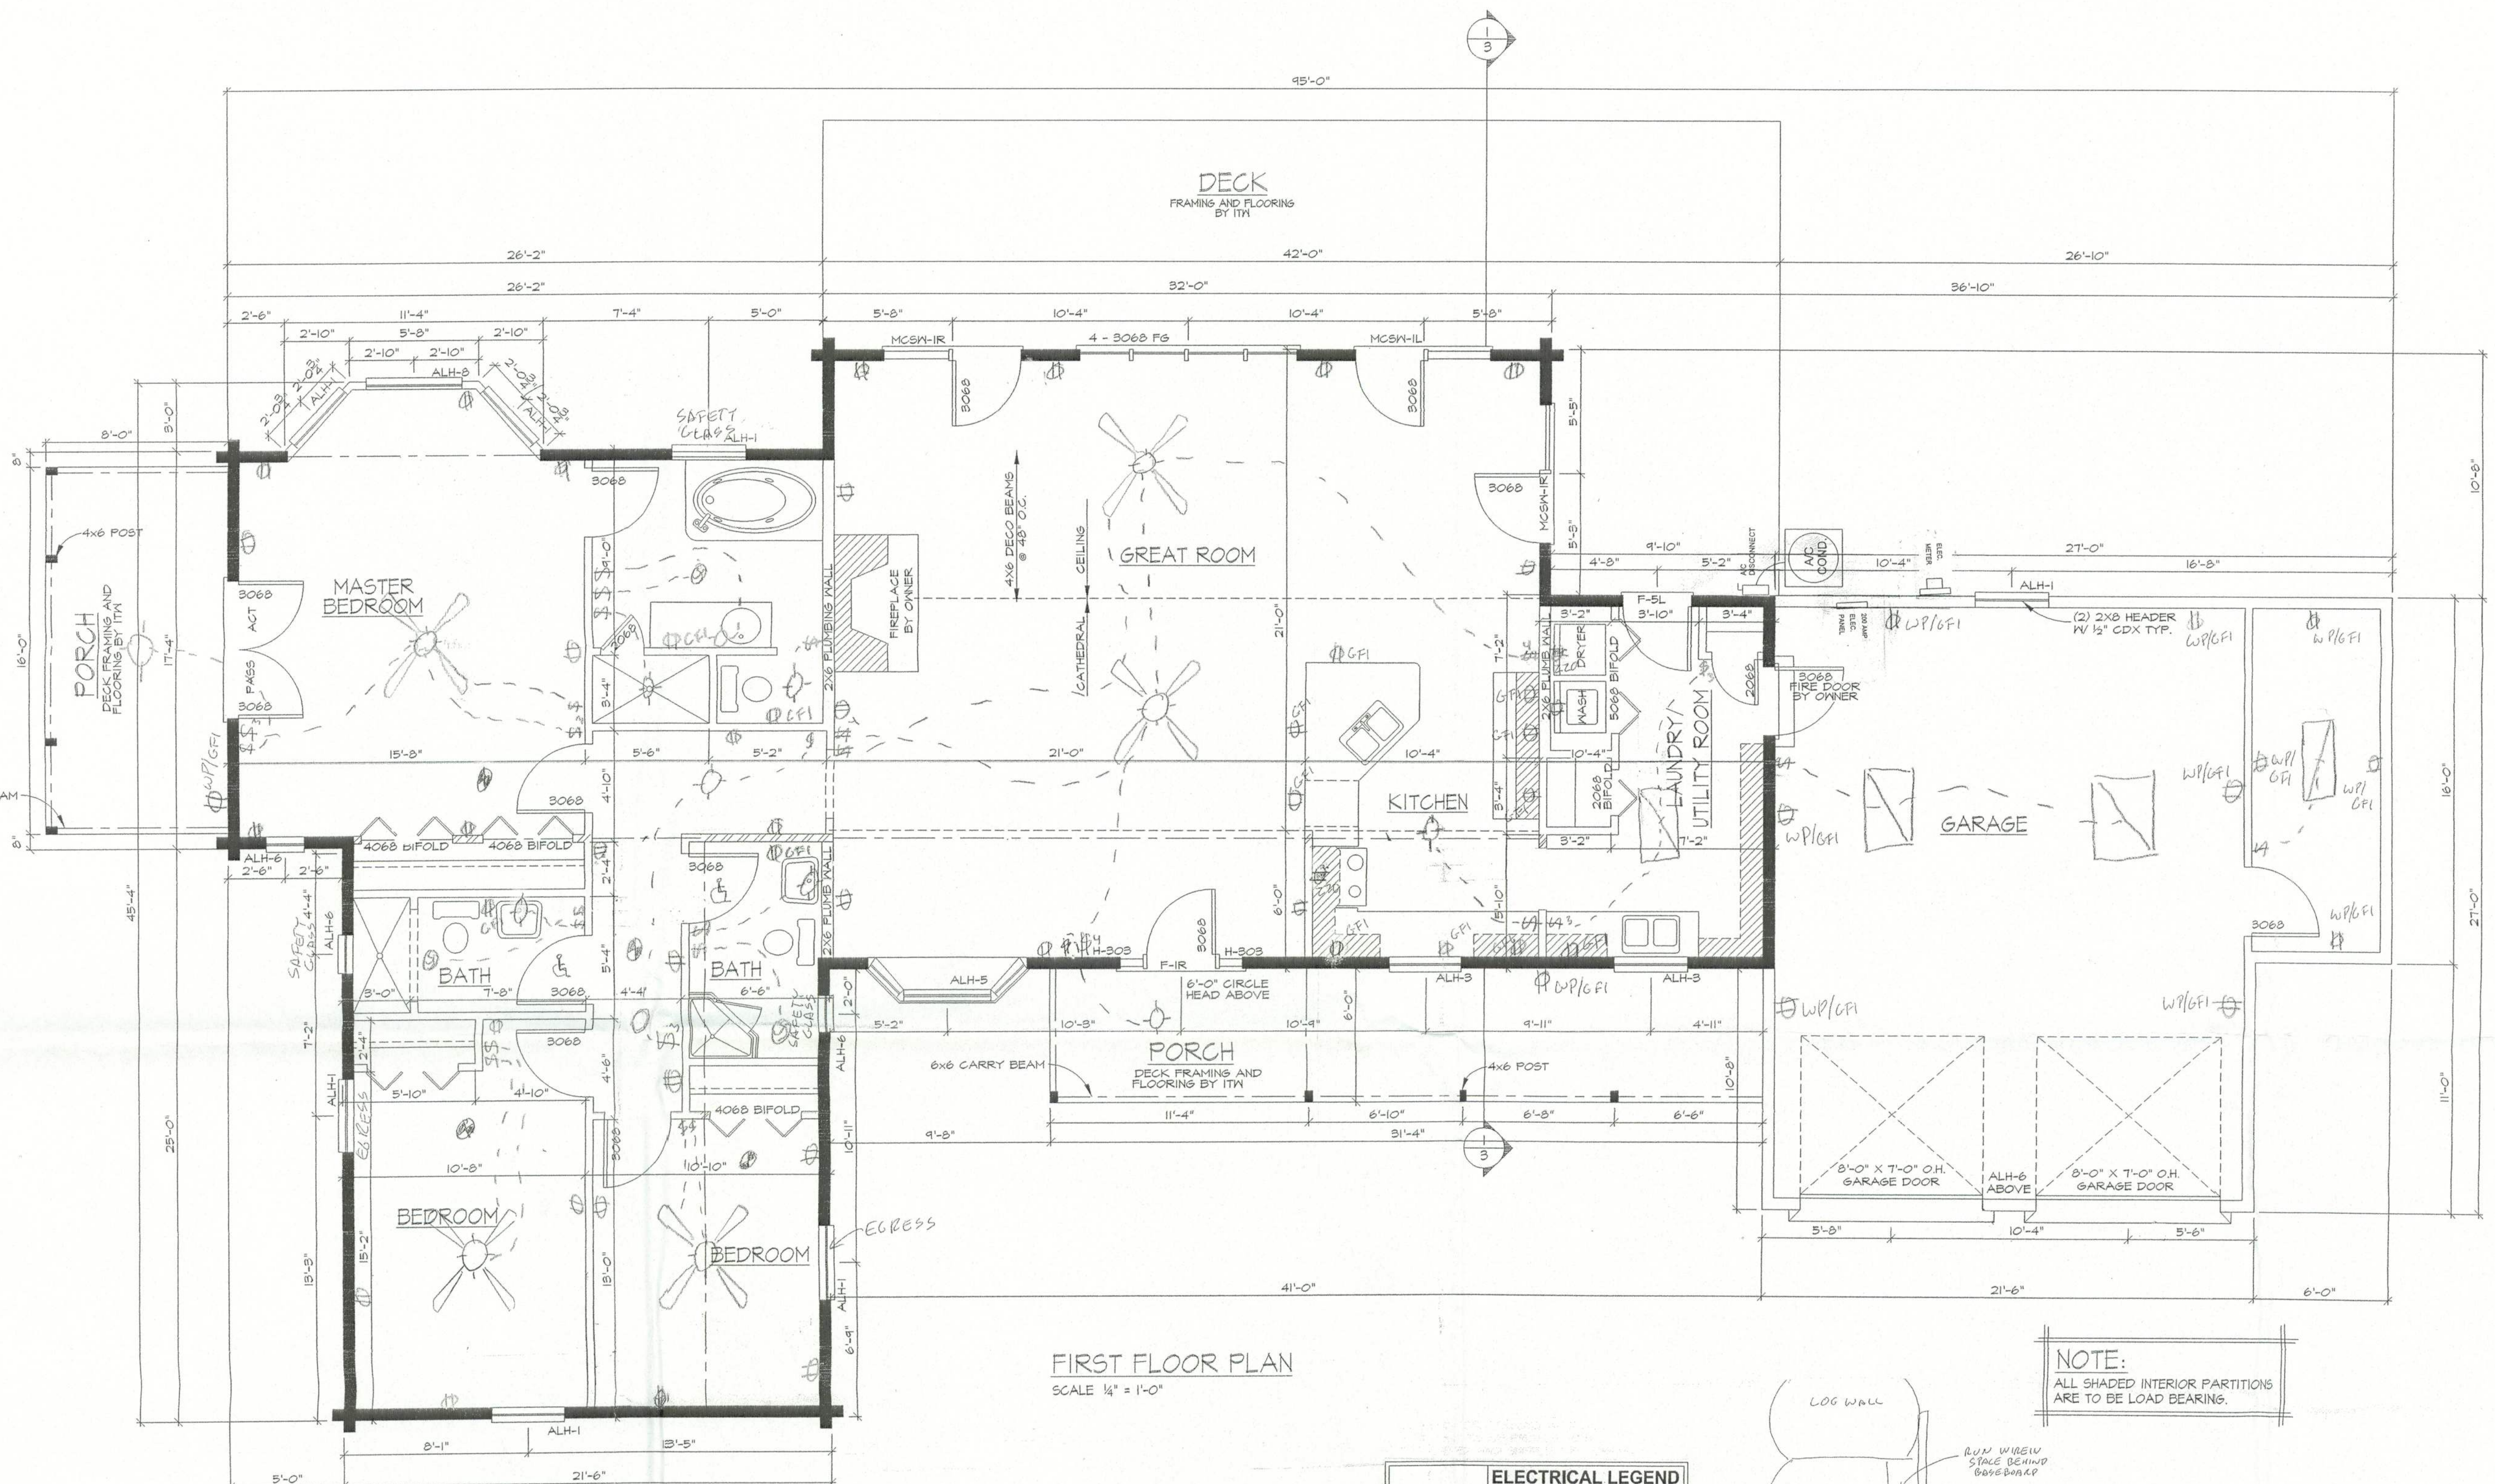


FIRST FLOOR PLAN
SCALE 1/4" = 1'-0"

- ELECTRICAL PLAN NOTES**
- E -1 WIRE ALL APPLIANCES, HVAC UNITS AND OTHER EQUIPMENT PER MANUF. SPECIFICATIONS.
- E -2 CONSULT THE OWNER FOR THE NUMBER OF SEPARATE TELEPHONE LINES TO BE INSTALLED.
- E -3 ALL INSTALLATIONS SHALL BE PER NAT'L. ELECTRIC CODE.
- E -4 ALL SMOKE DETECTORS SHALL BE 120V W/ BATTERY BACKUP OF THE PHOTOELECTRIC TYPE, AND SHALL BE INTERLOCKED TOGETHER. INSTALL INSIDE AND NEAR ALL BEDROOMS.
- E -5 TELEPHONE, TELEVISION AND OTHER LOW VOLTAGE DEVICES OR OUTLETS SHALL BE AS PER THE OWNER'S DIRECTIONS, & IN ACCORDANCE W/ APPLICABLE SECTIONS OF NEC-LATEST EDITION.
- E -6 ELECTRICAL CONTR' SHALL BE RESPONSIBLE FOR THE DESIGN & SIZING OF ELECTRICAL SERVICE AND CIRCUITS.
- E -7 ENTRY OF SERVICE (UNDERGROUND OR OVERHEAD) TO BE DETERMINED BY POWER COMPANY.
- E -8 ALL BEDROOM RECEPTACLES SHALL BE AFCI (ARC FAULT CIRCUIT INTERRUPT)
- E -9 ALL OUTLETS TO BE LOCATED ABOVE BASE FLOOR ELEVATION

ELECTRICAL LEGEND	
	CEILING FAN (PRE-WIRE FOR LIGHT KIT)
	DOUBLE SECURITY LIGHT
	2X4 FLUORESCENT LIGHT FIXTURE
	BATH EXHAUST FAN
	LIGHT FIXTURE
	DUPLEX OUTLET
	220V OUTLET
	GFI DUPLEX OUTLET
	SMOKE DETECTOR
	WALL SWITCH
	3 WAY WALL SWITCH
	WATER PROOF GFI OUTLET

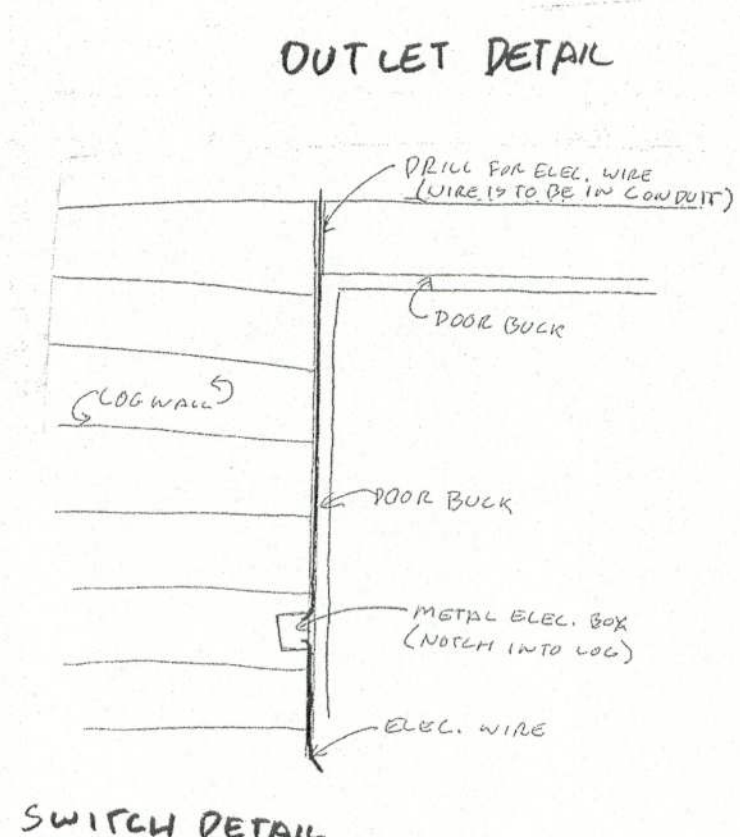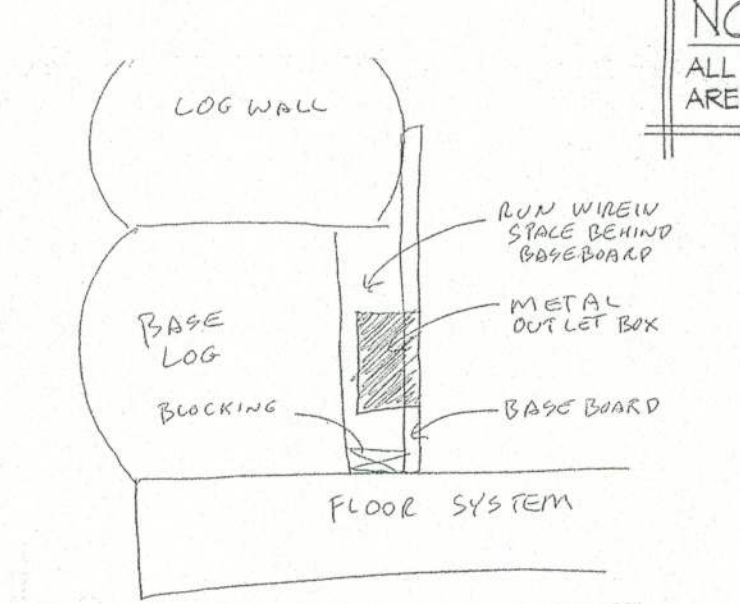

NOTE:
ALL SHADED INTERIOR PARTITIONS ARE TO BE LOAD BEARING.

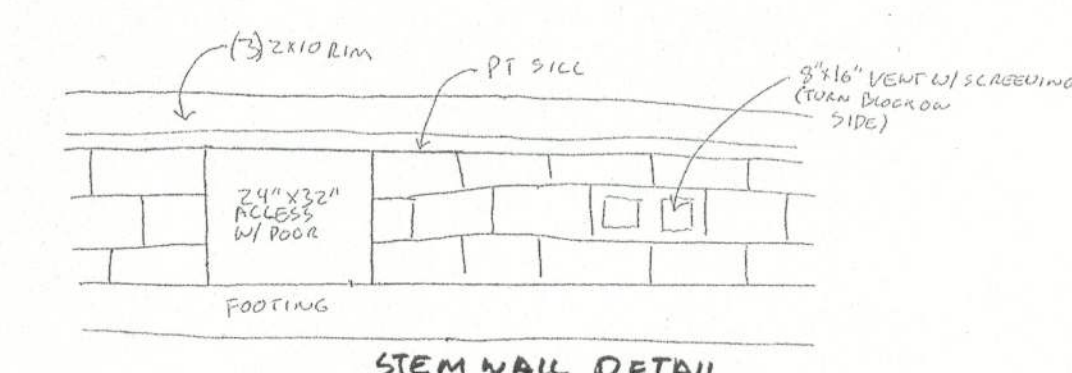

NOTE:
ALL WINDOWS TO BE DP-50 AND TEMPERED.