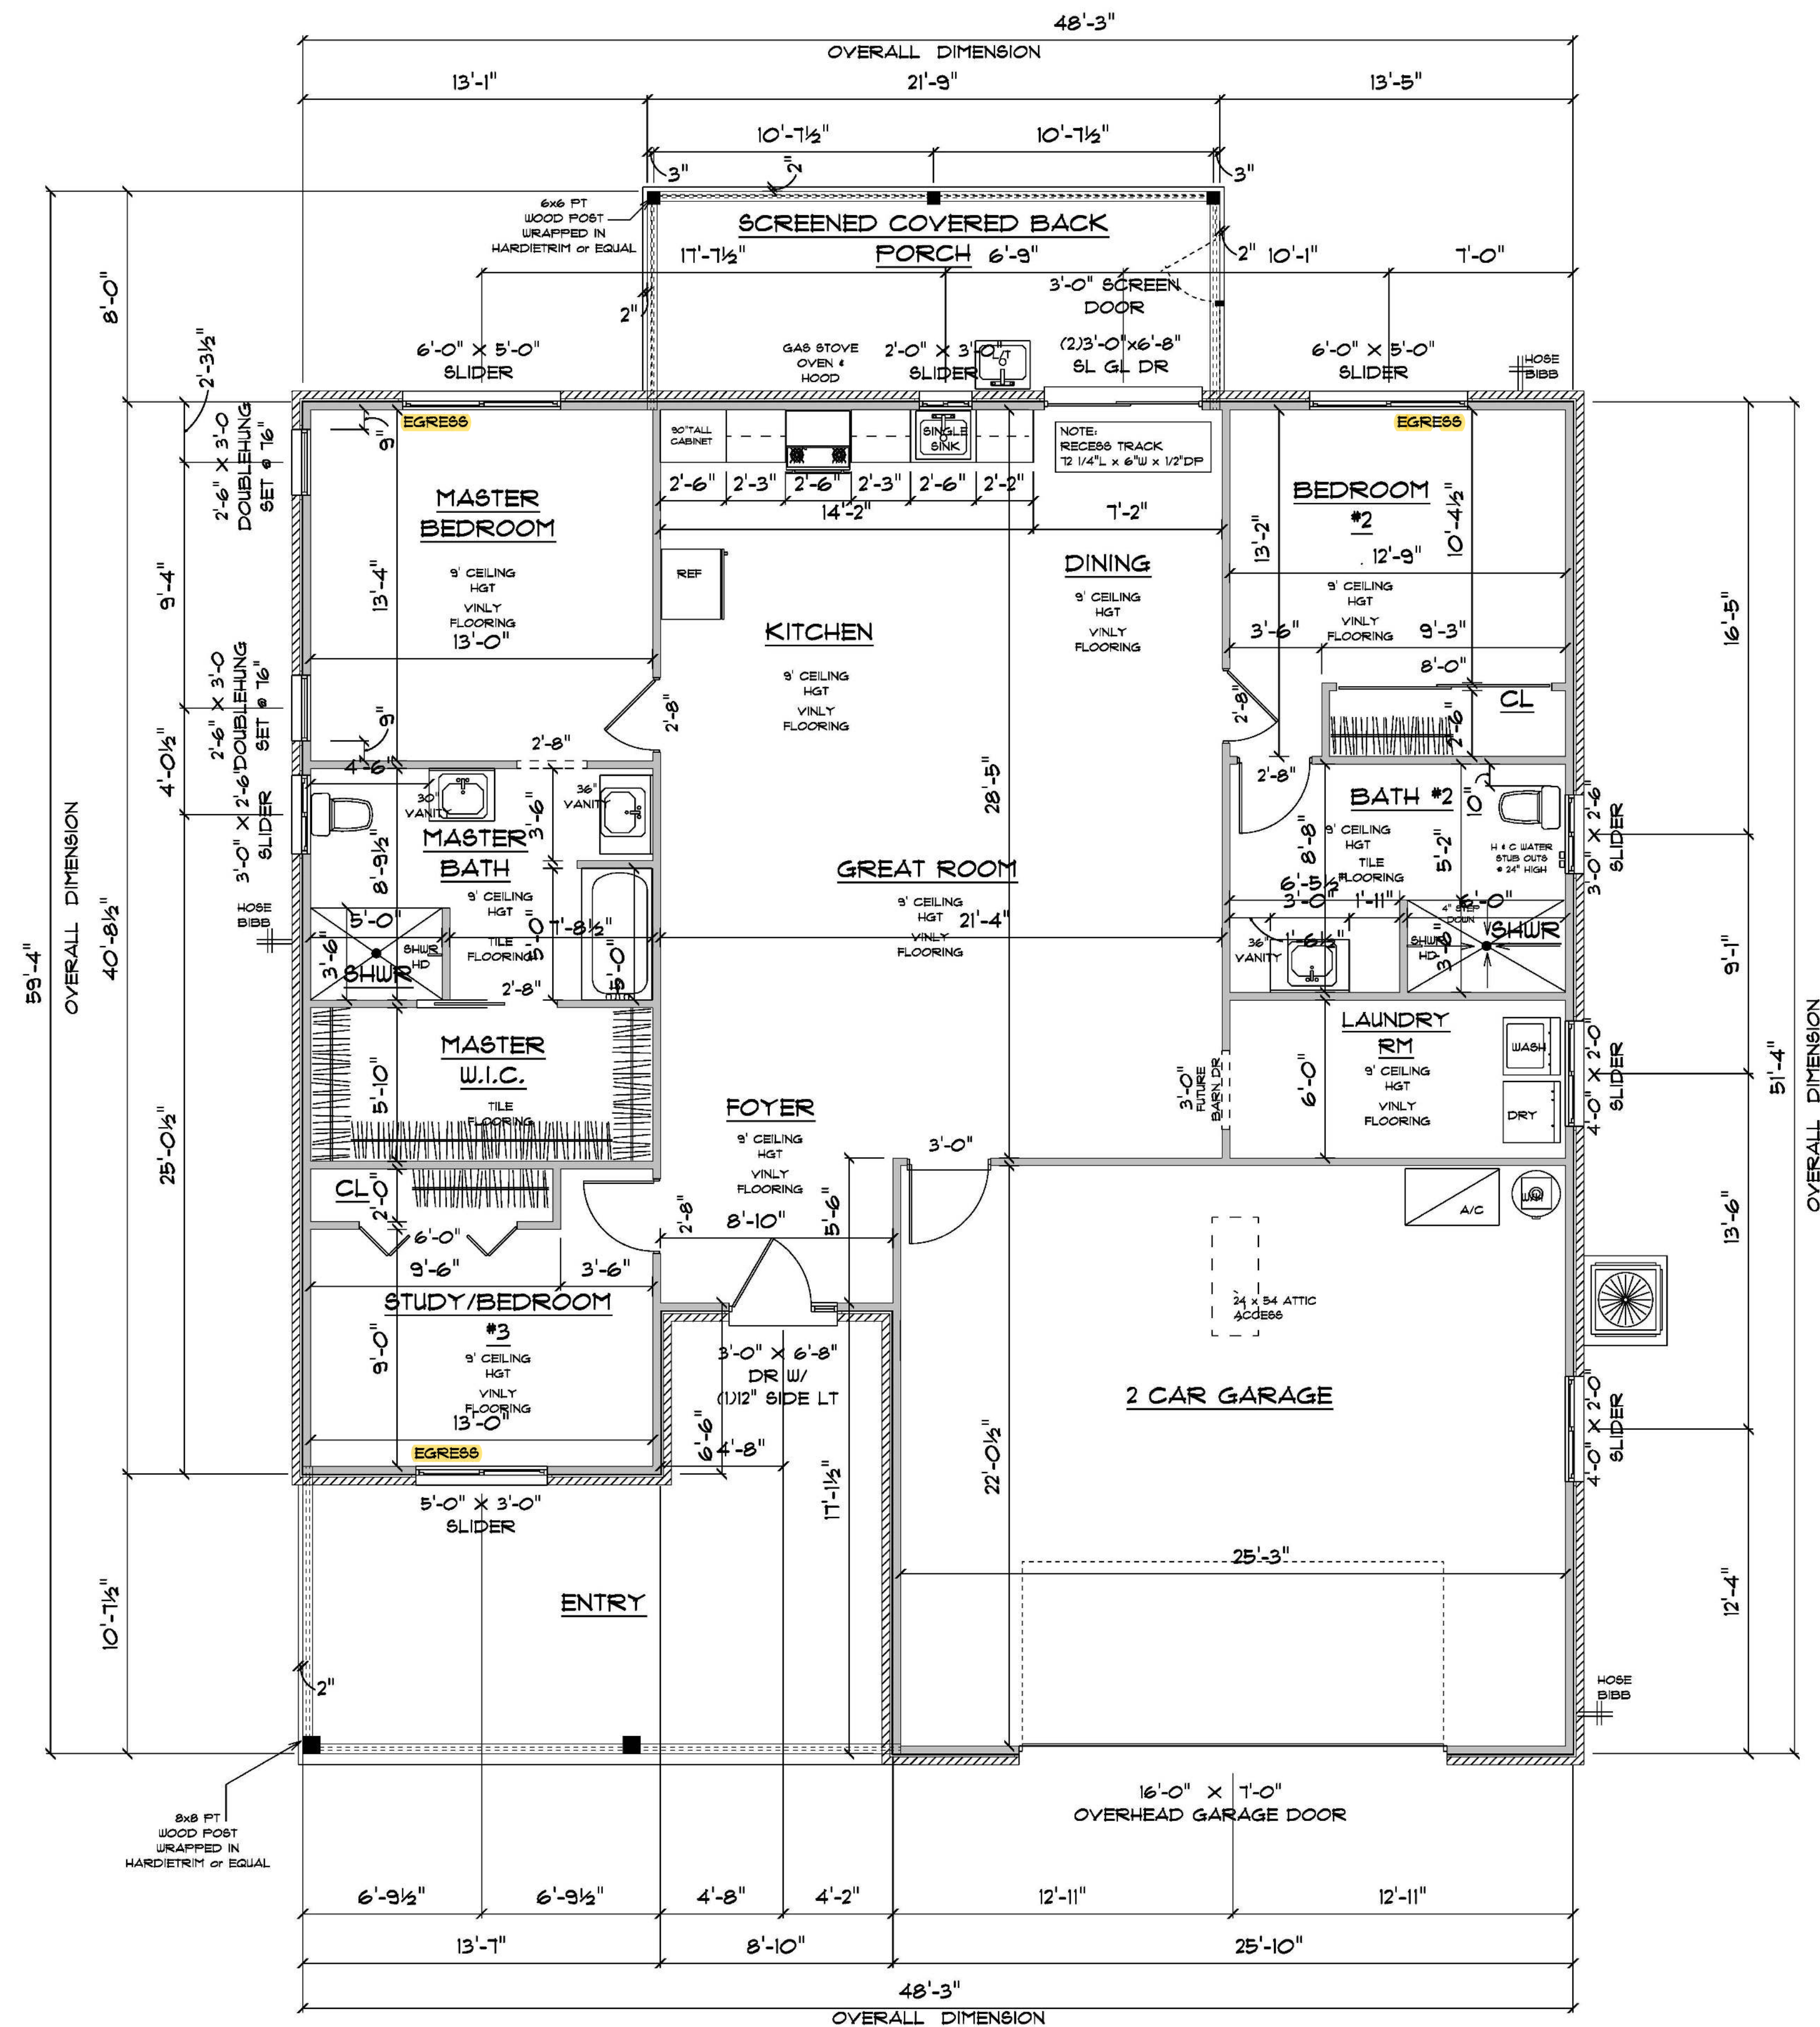




IMPORTANT NOTES:
1. IT IS THE BUILDER'S RESPONSIBILITY TO VERIFY ALL GEOMETRY AND DIMENSIONS BEFORE ORDERING ANY MATERIALS OR BEGINNING CONSTRUCTION.
2. THESE PLANS ARE FOR LAYOUT AND DESIGN PURPOSES ONLY ALL STRUCTURAL NOTES AND DETAILS TO BE PROVIDED BY AN ENGINEER.

* FLOOR PLAN *
SCALE : 1/4" = 1'-0"

A/C LIVING AREA	=	1603 S.F.
COVERED LANAI	=	174 S.F.
ENTRY	=	290 S.F.
TWO CAR GARAGE	=	585 S.F.
TOTAL AREA UNDER ROOF = 2652 S.F.		

RESIDENCE
for
KERRY CLANCY

FLORIDA

Teena M. Ruffo
2925 SW 8R 41
Lake City Florida, 32025
Cell: (386) 861-1191
Email: teenaruffo@gmail.com

PRINTED DATE:
Wednesday, May 6, 2020

DRAWN BY: Teena M. Ruffo
CHECKED BY:

BUILDING CONTRACTOR
BRYAN ZECHER CONSTRUCTION

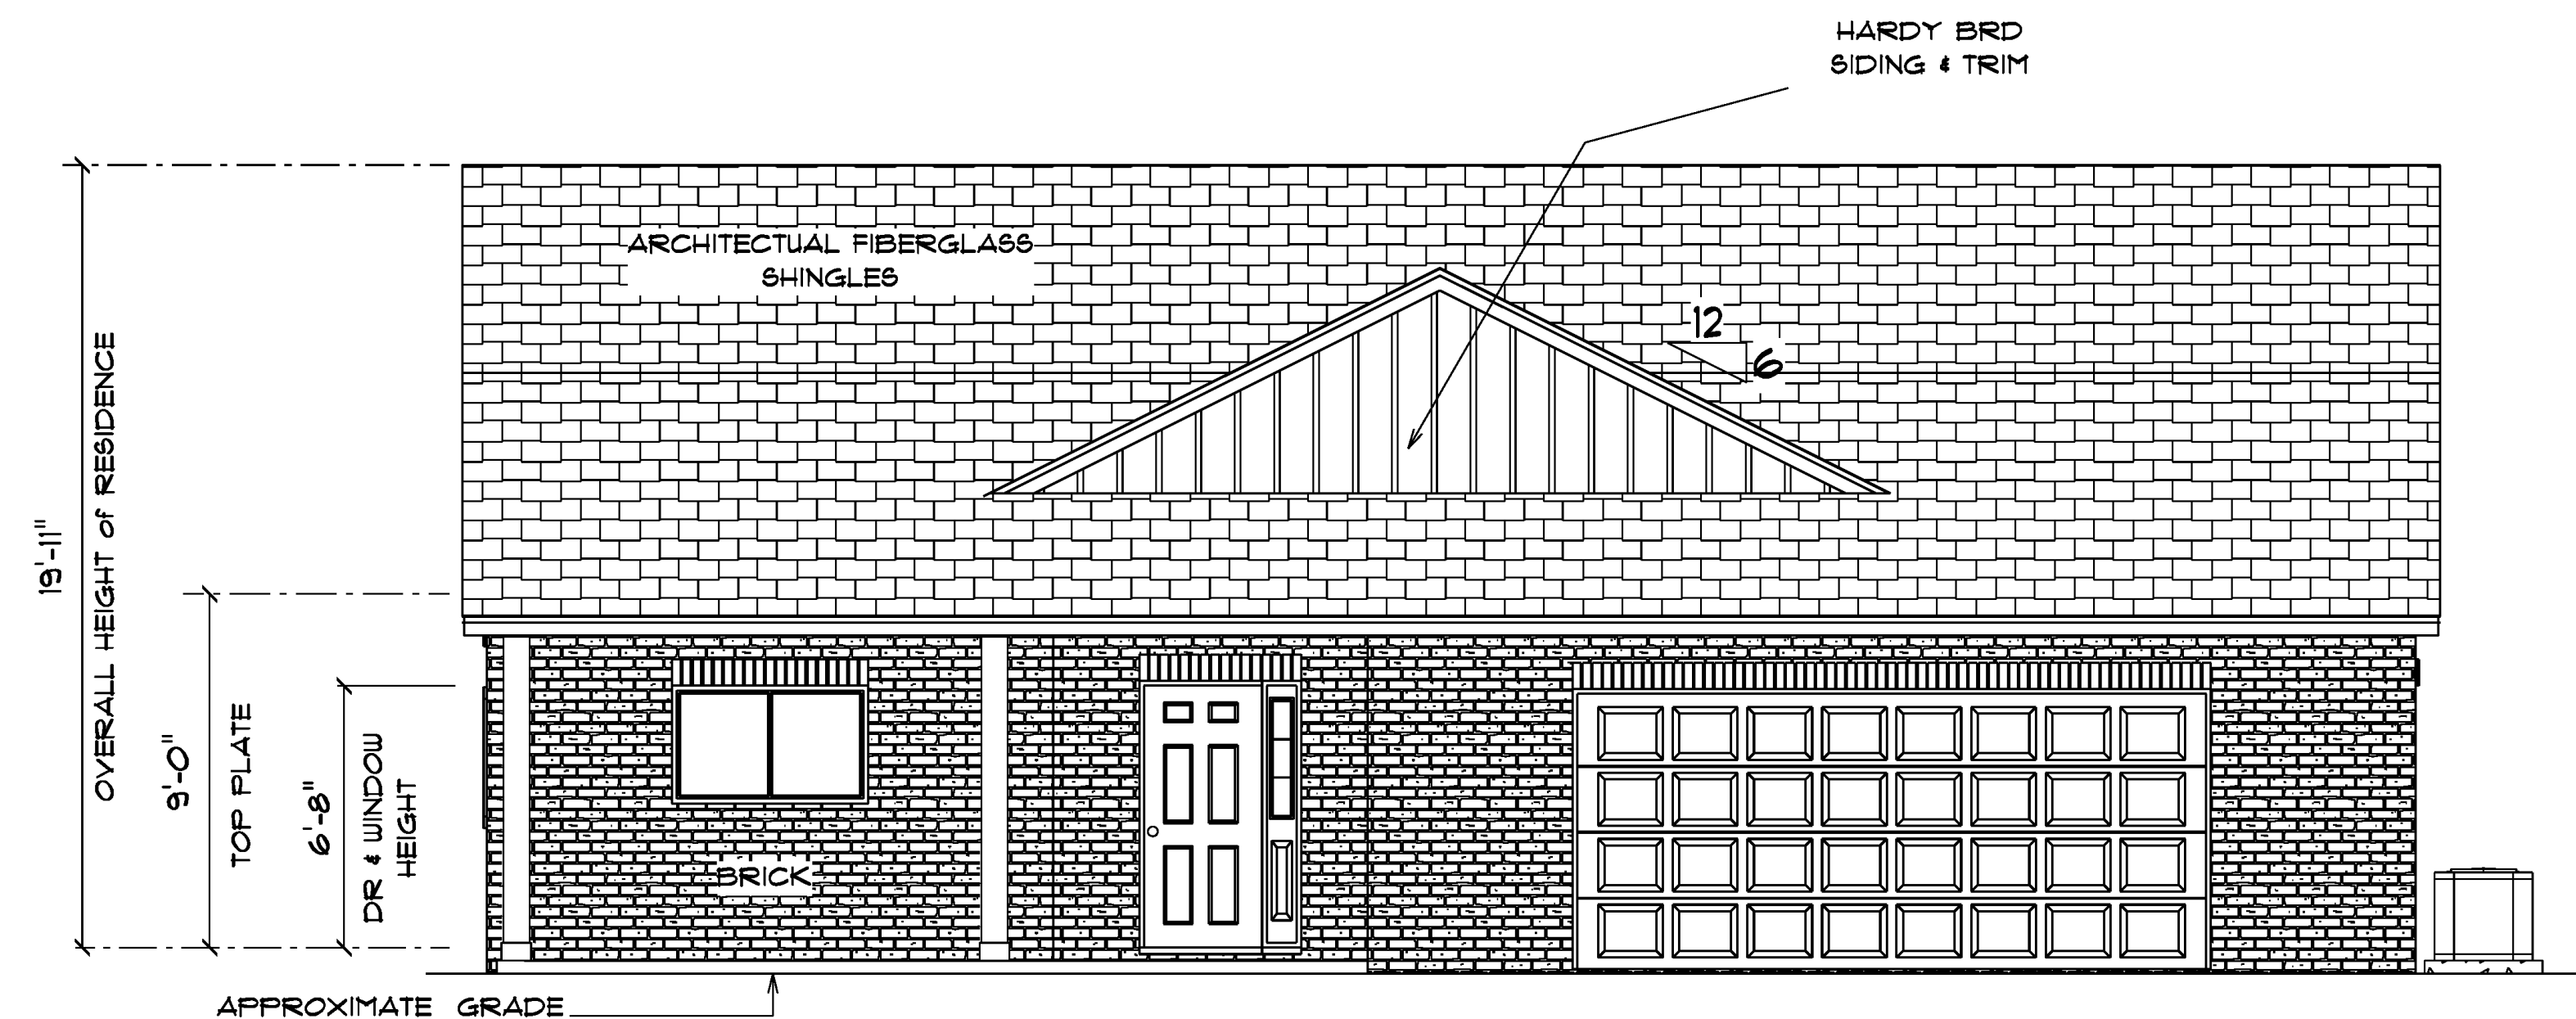
FINAL DATE:

JOB NUMBER:

DRAWING NUMBER

A-2


OF 5 SHEETS



* FRONT ELEVATION *

SCALE : 1/4" = 1'-0"

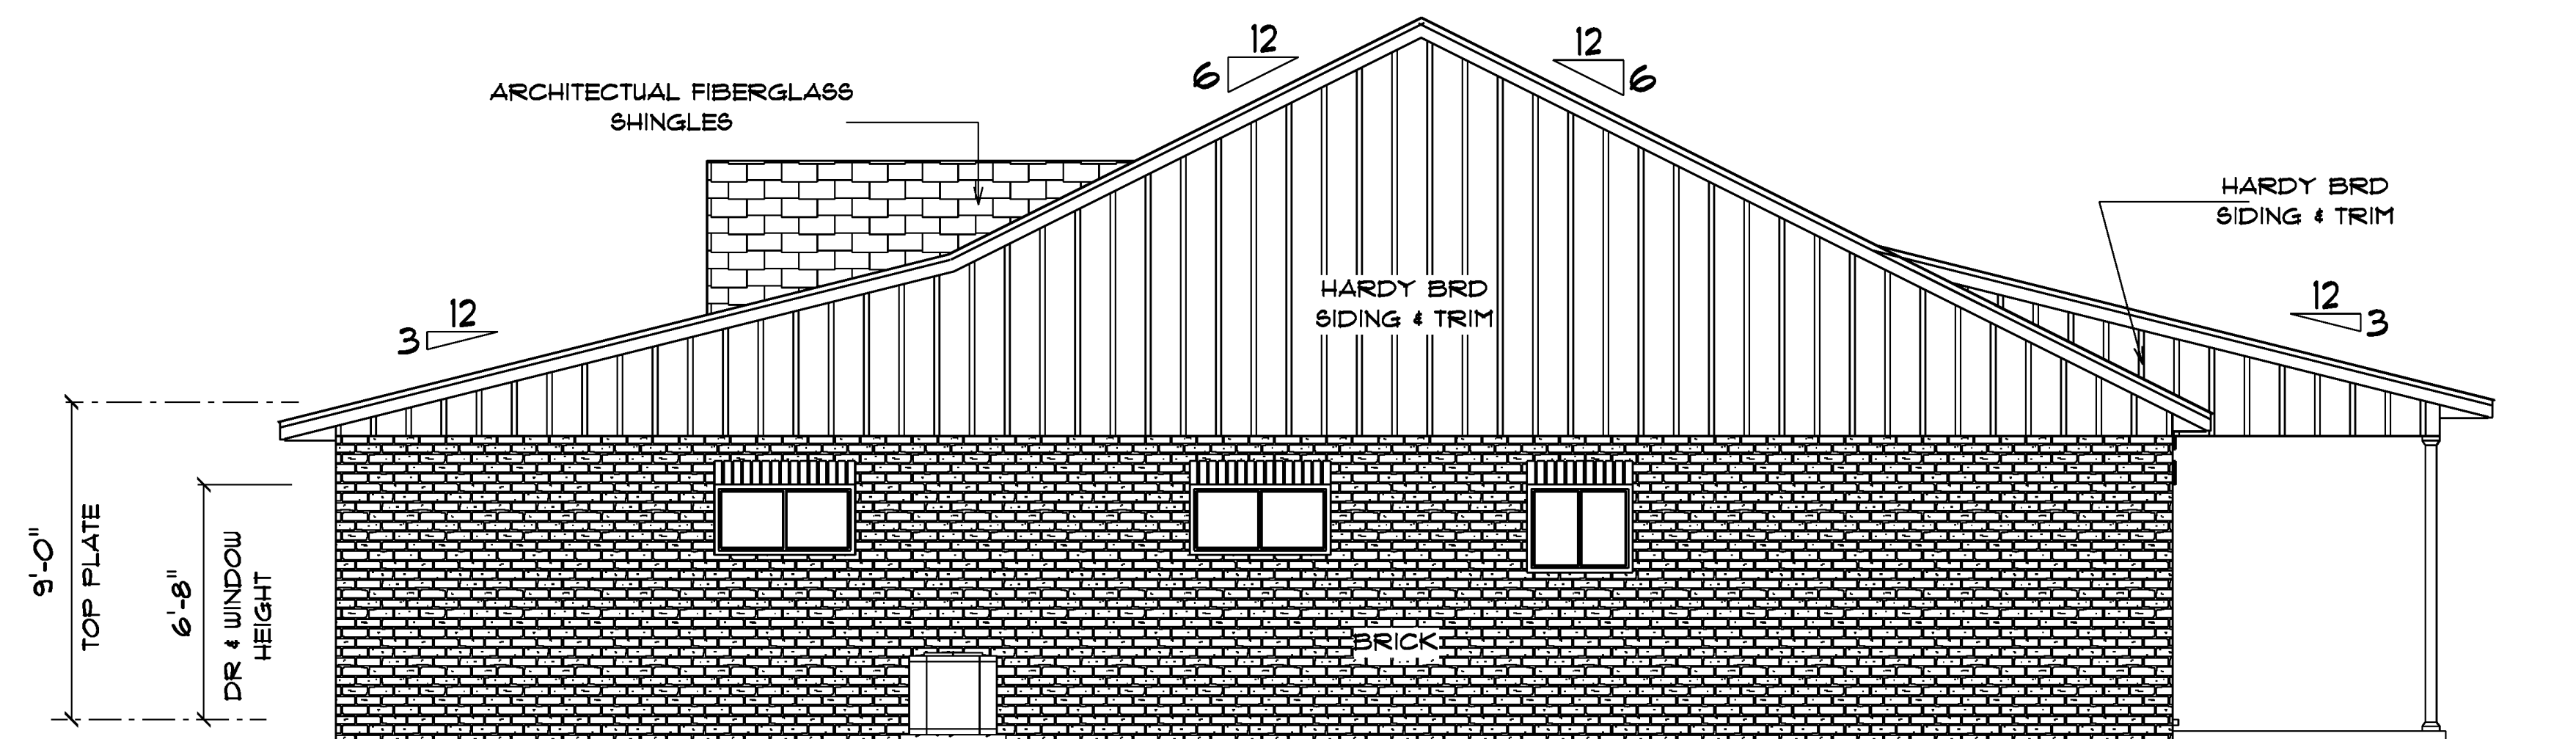NOTE :
12" OVERHANG ON ALL GABLE EAVES
18" OVERHANG ON ALL OTHER EAVES



* RIGHT SIDE ELEVATION *

SCALE : 1/4" = 1'-0"

RESIDENCE
for
KERRY CLANCY

FLORIDA

Teena M. Ruffo
2925 SW 8R 41
Lake City Florida, 32025
Cell: (306) 861 - 1191
Email: teenaruffo@gmail.com

PRINTED DATE:
Wednesday, May 6, 2020

DRAWN BY: Teena M. Ruffo CHECKED BY:

BUILDING CONTRACTOR
BRYAN ZECHER CONSTRUCTION

FINAL DATE:

JOB NUMBER:

DRAWING NUMBER

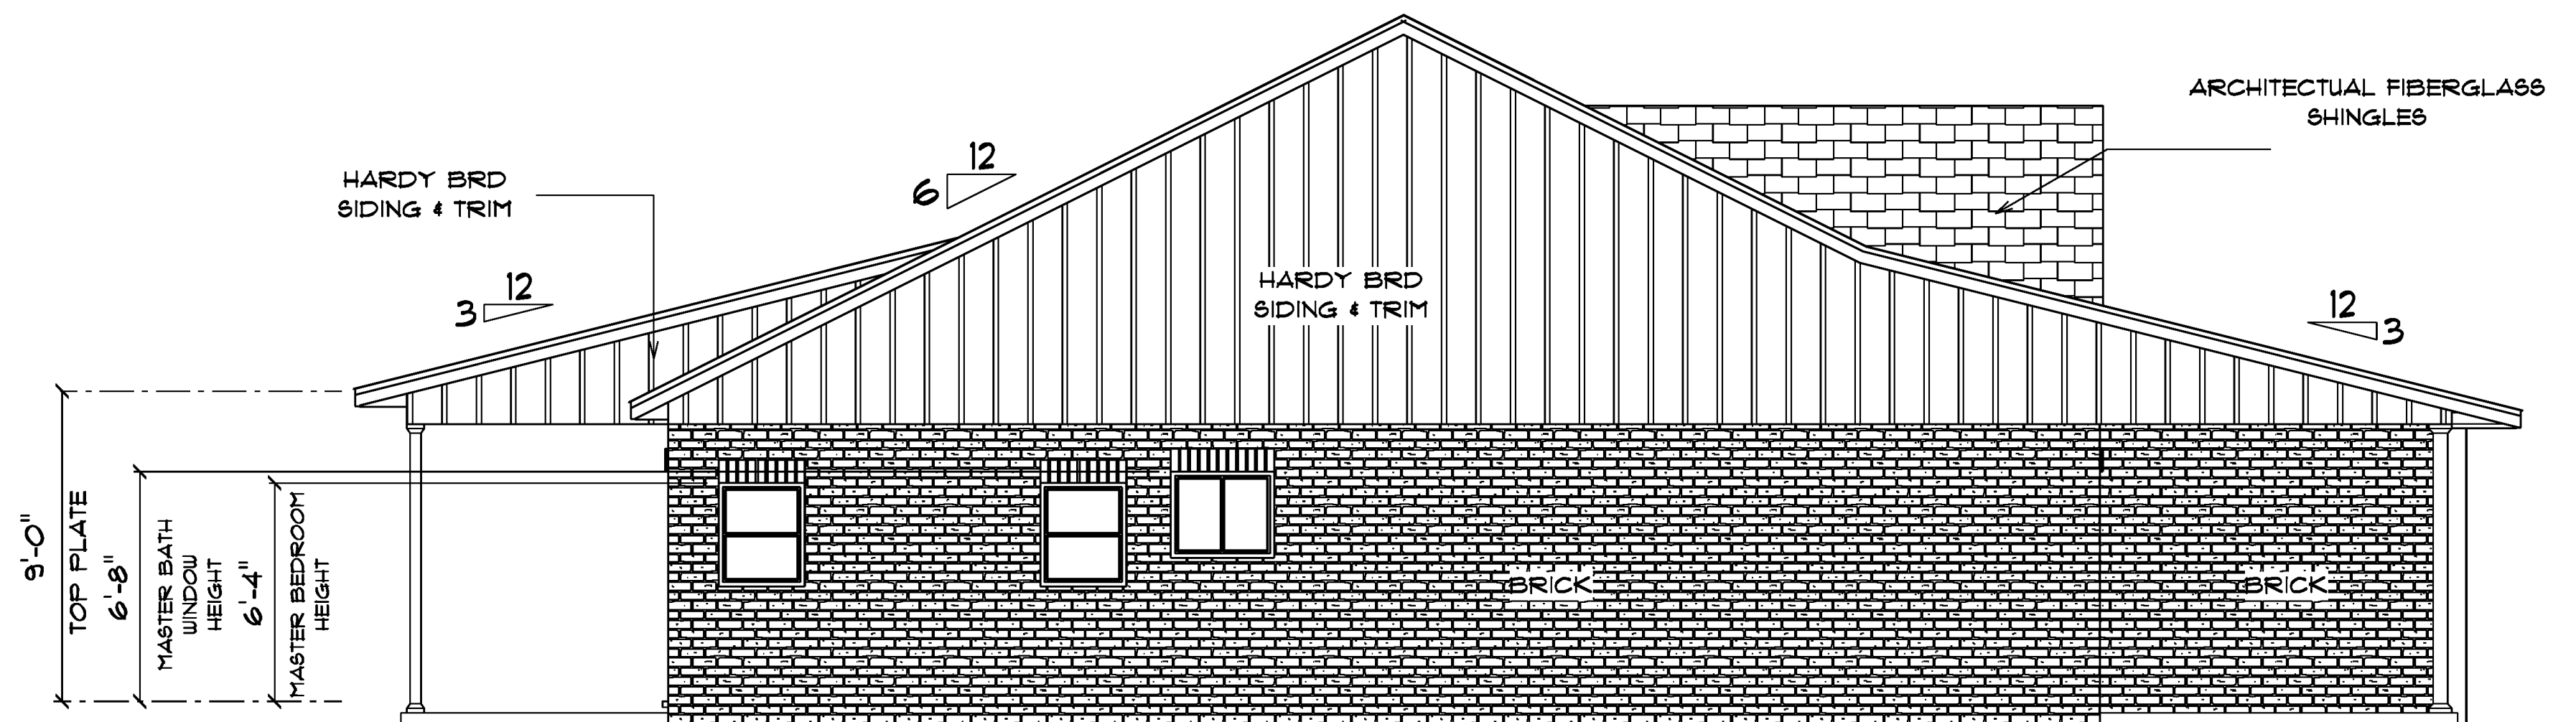
A-3

OF 5 SHEETS



* REAR ELEVATION *

SCALE : 1/4" = 1'-0"














* LEFT SIDE ELEVATION *

SCALE : 1/4" = 1'-0"




RESIDENCE for KERRY CLANCY	
FLORIDA	
Teena M. Ruffo 2925 SW 8R 41 Lake City Florida, 32025 Cell: (386) 861 - 1191 Email: teenaruffo@gmail.com	
PRINTED DATE: Wednesday, May 6, 2020	
DRAWN BY: Teena M. Ruffo	CHECKED BY:
BUILDING CONTRACTOR BRYAN ZECHER CONSTRUCTION	
FINALS DATE:	
JOB NUMBER:	
DRAWING NUMBER A-4 OF 5 SHEETS	

           ELECTRICAL LEGEND		
ELECTRICAL	COUNT	SYMBOL
ceiling fan globe 01	6	
fluorescent light 1 x 4	2	
pot light	8	
spotlight double	4	
Smoke Detector	4	
wall mount 1	9	
electrical meter	1	
electrical panel	1	
telephone jack	1	
Light	1	
automatic garage dr opener	1	
cable tv outlet	1	
exhaust fan	2	
garage dr opener	1	
light	6	
outlet	21	
outlet 220v	5	
outlet gfi	12	
outlet wp	1	
switch	30	
switch 3 way	2	

ELECTRICAL PLAN NOTES

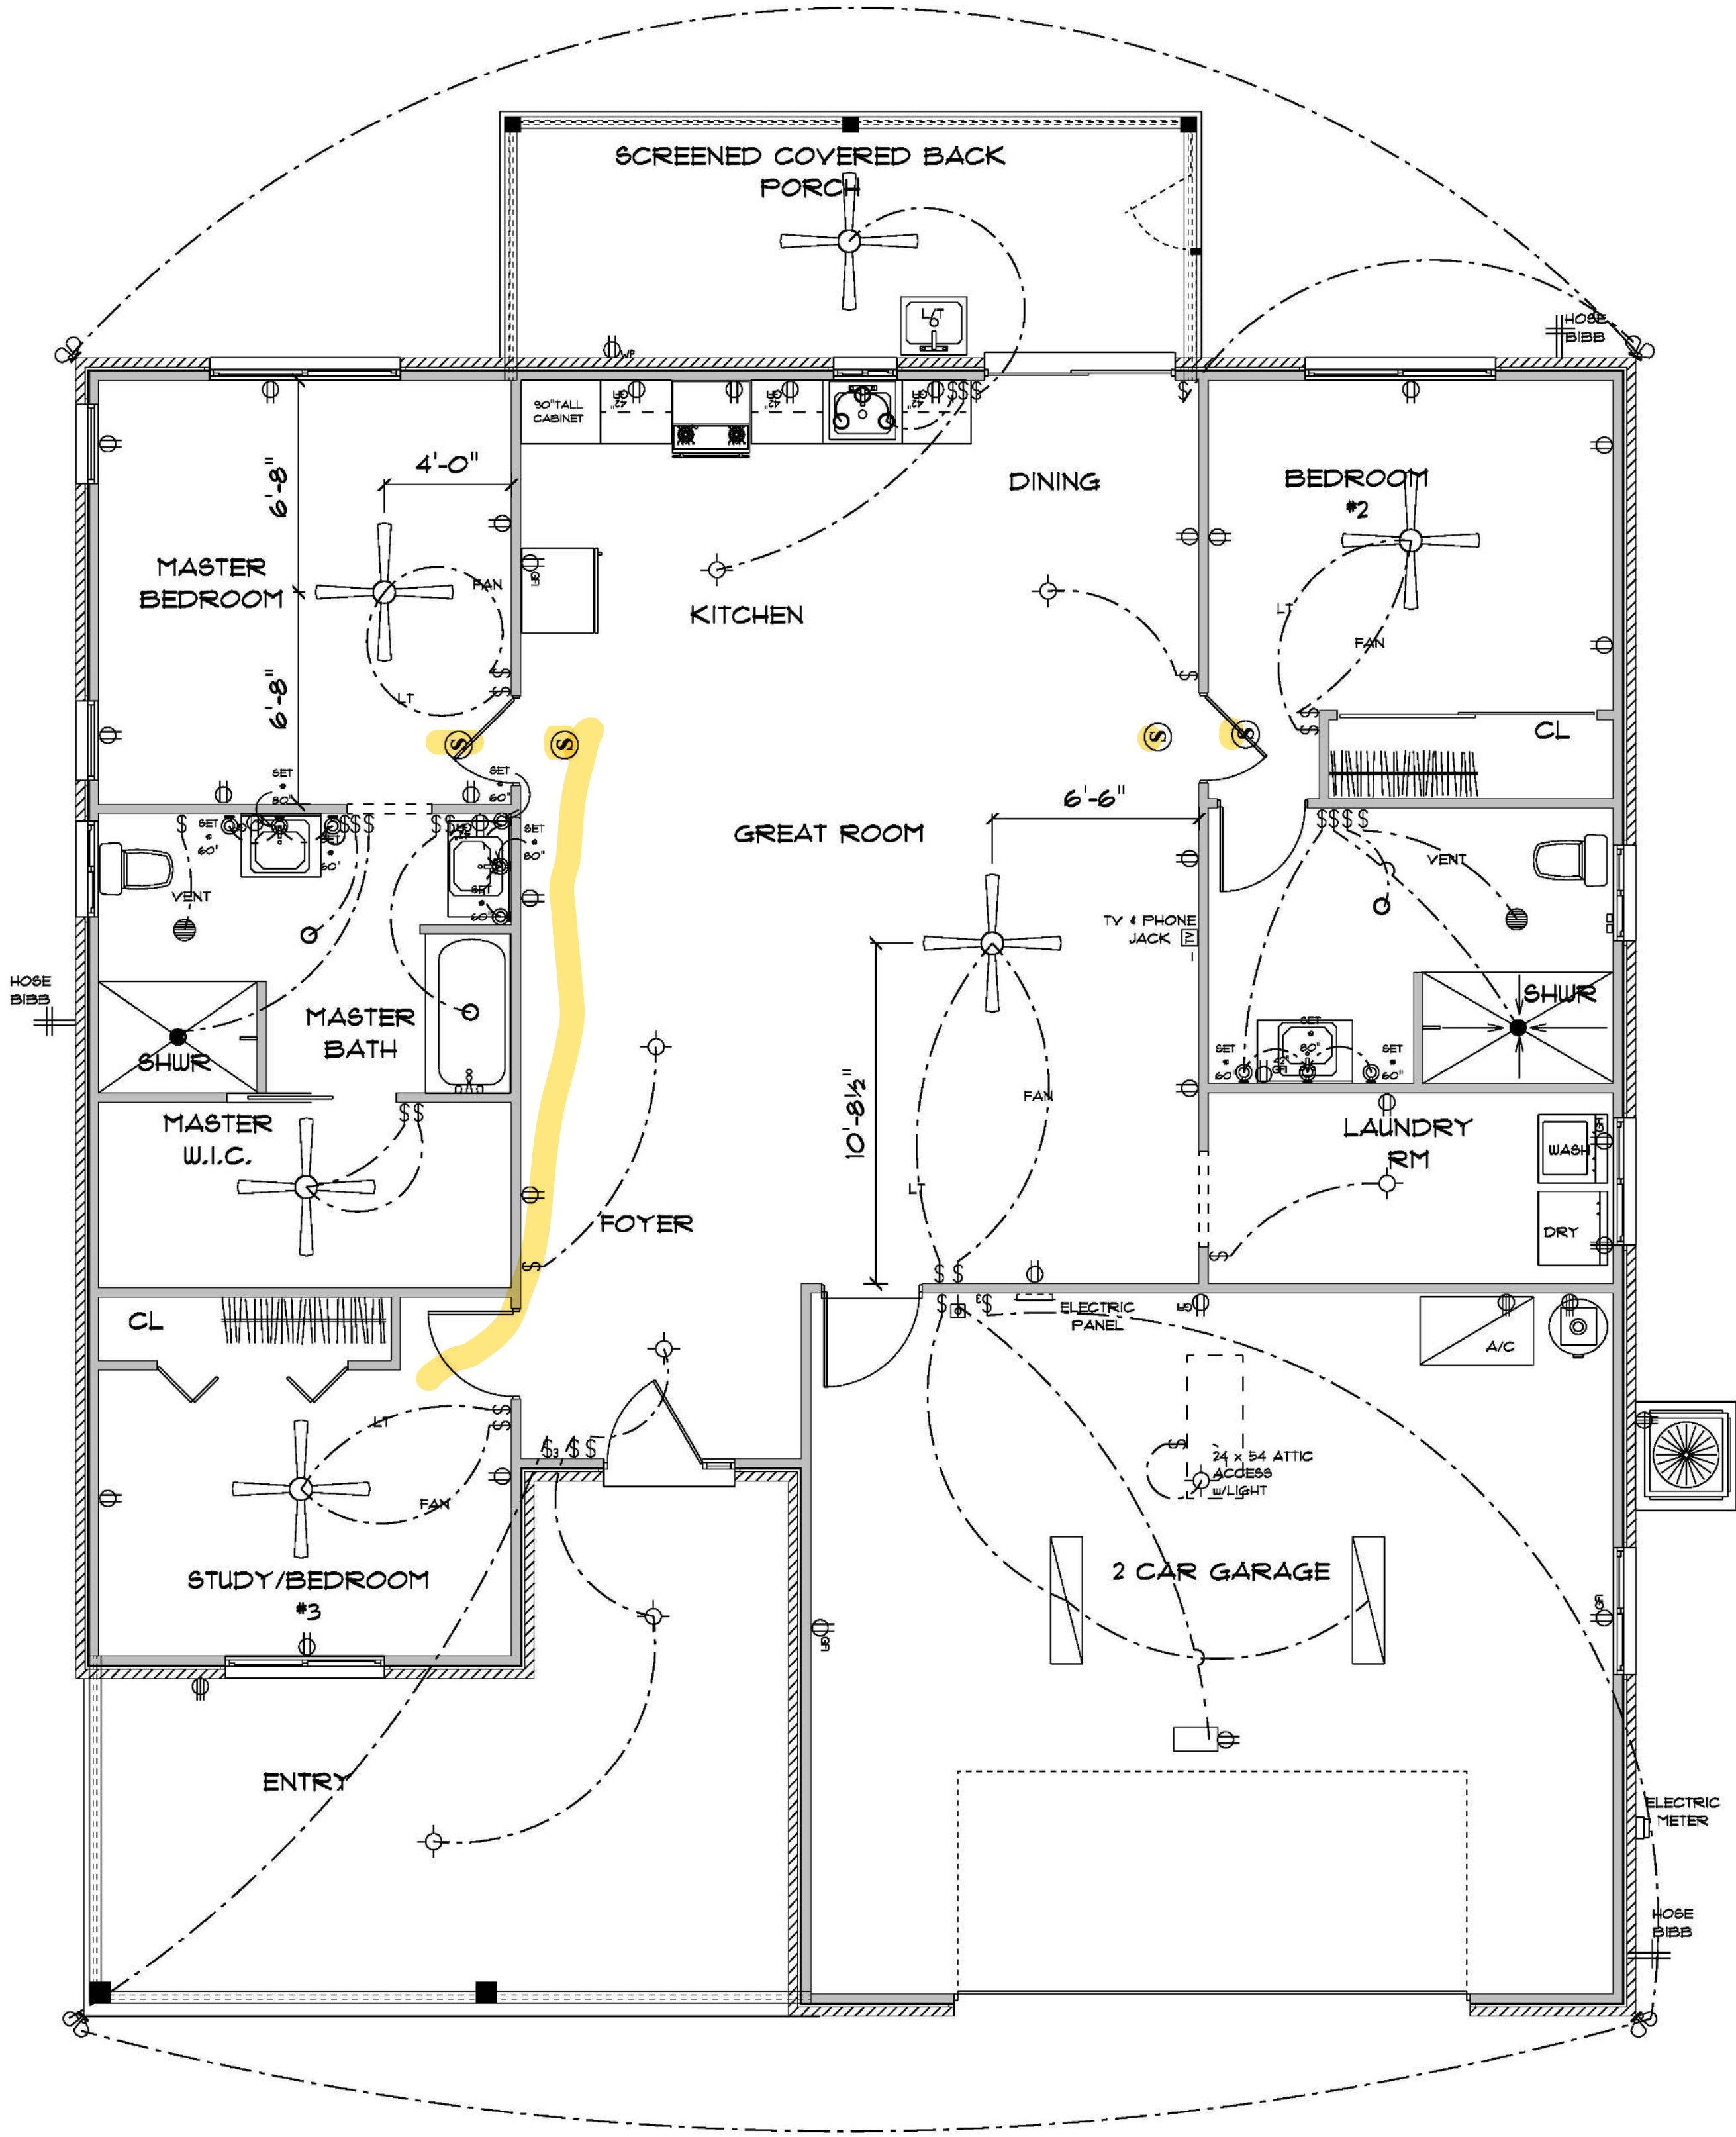- E-1 WIRE ALL APPLIANCES, HVAC UNITS AND OTHER EQUIPMENT PER MANUFACTURER'S SPECIFICATIONS.
- E-2 ALL INSTALLATIONS SHALL BE PER NATIONAL ELECTRIC CODE.
- E-3 ALL SMOKE /CARBON MONOXIDE DETECTORS SHALL BE 120V W/BATTERY BACKUP OF THE PHOTOELECTRIC TYPE, AND SHALL BE INTERLOCKED TOGETHER. INSTALL INSIDE AND NEAR ALL BEDROOMS AS PER CODE.
- E-4 TELEPHONE, TELEVISION AND OTHER LOW VOLTAGE DEVICES OR OUTLETS SHALL BE AS PER THE OWNER'S DIRECTION AND IN ACCORDANCE WITH APPLICABLE SECTIONS OF NATIONAL ELCT. CODE LATEST EDITION.
- E-5 ELECTRICAL CONTRACTOR SHALL BE RESPONSIBLE FOR THE DESIGN AND SIZING OF ELECTRICAL SERVICE AND CIRCUITS.
- E-6 ENTRY OF SERVICE UNDERGROUND OR OVERHEAD) IS TO BE DETERMINED BY THE POWER COMPANY.
- E-7 ALL BEDROOM RECEPTICALS ARE TO BE AFCI (ARC FAULT CIRCUIT INTERRUPT).
- E-8 75% OF ALL PERMANENT LIGHTS TO BE ENERGY EFFICIENT.



* ELECTRICAL PLAN *

SCALE : 1/4" = 1'-0"

RESIDENCE
for
KERRY CLANCY

FLORIDA

Teena M. Ruffo
2925 SW 8R 41
Lake City Florida, 32025
Cell: (386) 861-1191
Email: teenaruffo@gmail.com

PRINTED DATE:
Wednesday, May 6, 2020

DRAWN BY: Teena M. Ruffo CHECKED BY:

BUILDING CONTRACTOR
BRYAN ZECHER CONSTRUCTION

FINAL DATE:

JOB NUMBER:

DRAWING NUMBER

A-5

OF 5 SHEETS