


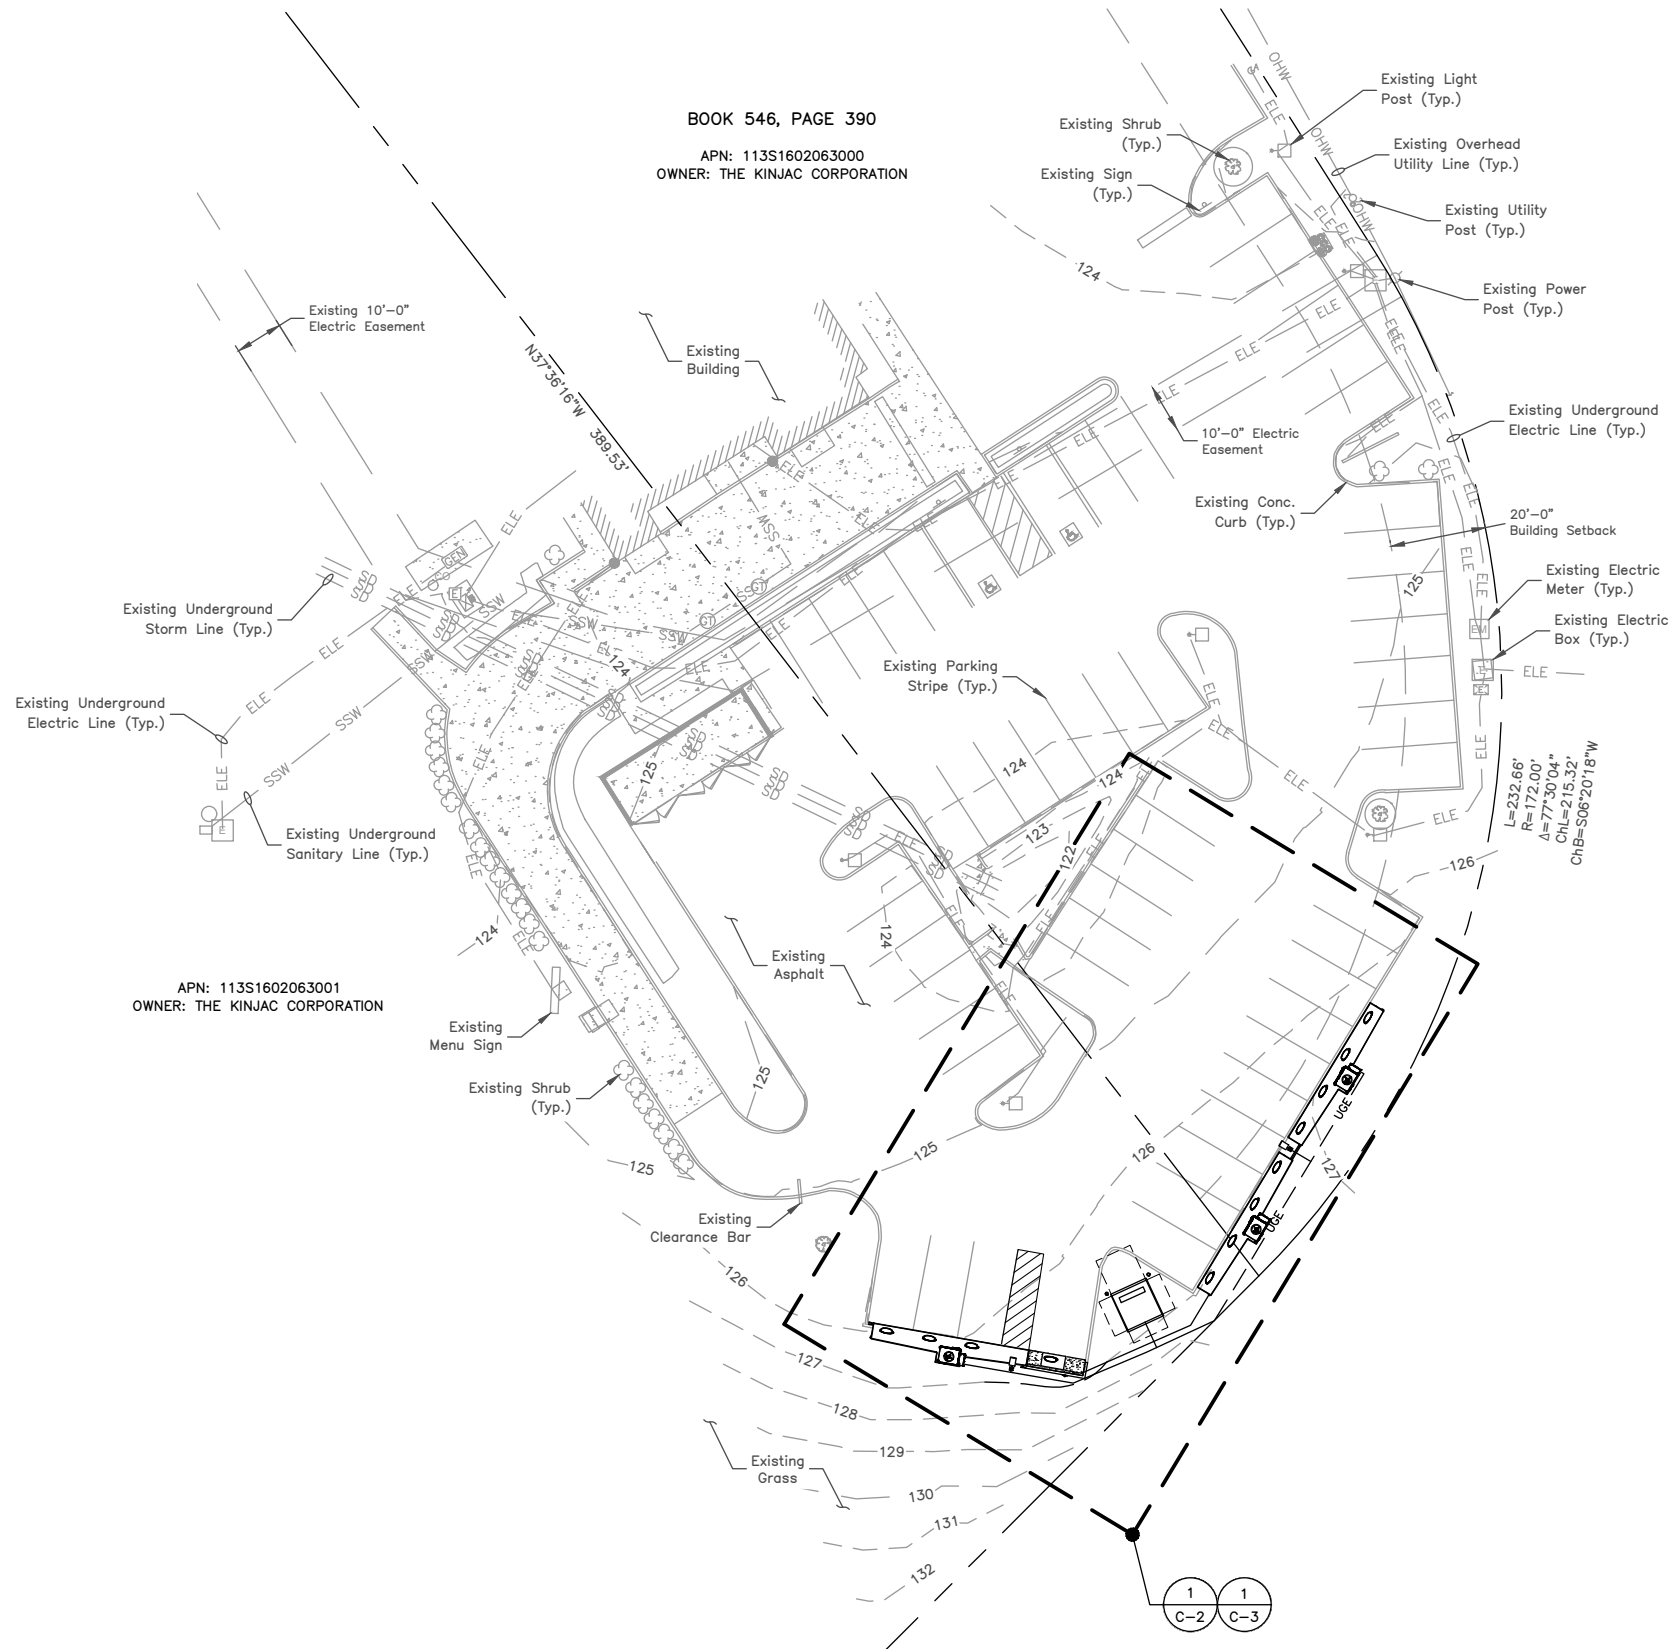


BOOK 546, PAGE 390  
APN: 113S1602063000  
OWNER: THE KINJAC CORPORATION



APN: 113S1602063001  
OWNER: THE KINJAC CORPORATION

#### DETAILED SITE PLAN

 SCALE: 1"=40' FOR 11"x17"  
1"=20' FOR 22"x34"



1

#### LEGEND

	SITE BENCHMARK
	SANITARY MANHOLE
	CLEANOUT
	GREASE TRAP
	LIGHT POLE
	ELECTRIC METER
	ELECTRIC TRANSFORMER
	ELECTRIC BOX
	ELECTRIC CABINET
	GUYWIRE
	ELECTRIC PEDESTAL
	GENERATOR
	UTILITY POLE
	UTILITY POLE W/ TRANSFORMER
	VENT PIPE
	AIR PUMP
	HANDICAP PARKING
	DECIDUOUS TREE WITH DRIPLINES
	SHRUB
	LANDSCAPED AREA
	BOLLARD
	SIGN
	FENCE GATE
	STORM LINE (UNDERGROUND)
	SANITARY LINE (UNDERGROUND)
	ELECTRIC LINE (UNDERGROUND)
	ELECTRIC LINE (OVERHEAD)
	SHRUB LINE
	CONCRETE AREA

#### EQUIPMENT SHIPPED BY TESLA

EQUIPMENT	QTY
PSU 3.0 W/ EVLITE DISCONNECT	3
DISABLED ACCESS, USE LAST SIGN	1
VAN ACCESSIBLE SIGN	1
STAR CENTER KIT	1
CRADLEPOINT ENCLOSURE	1
CRADLEPOINT R1900	1
ARUBA ACCESS POINT KIT	1
V3/V4 POST	12
4" SUPERFLEX CONDUIT (FT)	332
4" SUPERFLEX STRAIGHT COUPLER	10
4" DURALINE CONDUIT (FT)	39
4" ADAPTER -- DURALINE TO PVC	2
V3/V4 FLEX FOUNDATION (PRE-CAST)	1
SLIM WIREWAY, 6" X 8" WIREWAY 72" STRAIGHT SECTION	1
V3/V4 FLEX FOUNDATION (PRE-CAST)	1

#### NOTES:

- SITE PLAN BASED ON ENGINEERING DESIGN SURVEY: A PORTION OF THE NE1/4 OF SECTION 11, TOWNSHIP 3 SOUTH, RANGE 16 EAST, TALLAHASSEE MERIDIAN, COLUMBIA COUNTY, FL BY ASA ENGINEERING & SURVEYING, LLC. DATED 12/04/2023.
- UTILITY CONNECTION TO BE MADE UNDER FPL UTILITIES STANDARDS, CONFIRM FINAL DESIGN PRIOR TO CONSTRUCTION, FPL WORK ORDER TBD.
- EXISTING UNDERGROUND UTILITIES LOCATED WITHIN AREA OF PROPOSED TRENCH & EQUIPMENT SITE AREA. HAND DIG AND RELOCATE AS REQUIRED.
- EXISTING STORM DRAIN INLETS TO BE COVERED WITH SILT BAG DURING CONSTRUCTION.
- CONTRACTOR TO CONFIRM ADA/ACCESSIBLE STRIPING & ASSOCIATED STALLS HAVE <2% GRADE IN ALL DIRECTIONS.



3500 DEER CREEK ROAD  
PALO ALTO, CA 94304  
(650) 681-5000



Dewberry Engineers Inc.

800 NORTH MAGNOLIA AVE.  
SUITE 1000  
ORLANDO, FL 32803  
PHONE: 407.843.5120  
FAX: 407.649.8664  
FLORIDA C.O.A. #8794

NOT FOR  
CONSTRUCTION

DRAWN BY: HMP

CHECKED BY: BG

APPROVED BY: NRK

PROJECT #: 50123704

JOB #: 50167719

#### SUBMITTALS

REV.	DATE	DESCRIPTION
A	01/11/24	ISSUED FOR 90% REVIEW

#### SITE NAME:

LAKE CITY, FL -- US HWY 41  
(BUSY BEE #7)  
(TRT ID: 59032)

#### SITE ADDRESS:

4772 US HWY 41  
LAKE CITY, FL 32055

#### SHEET TITLE

DETAILED SITE PLAN

#### SHEET NUMBER

C-1