

John R. Porfiri
12-27-11

New Residence for
Mr. & Mrs. Wade Schile
319 Singleton Terrace, Columbia County, Florida


Date: July 14, 2011

Project no.
Drawn: JRFP
Checked: JRFP
Revisions:

Sheet title:
ELECTRICAL FLOOR PLAN

Sheet no.

E100

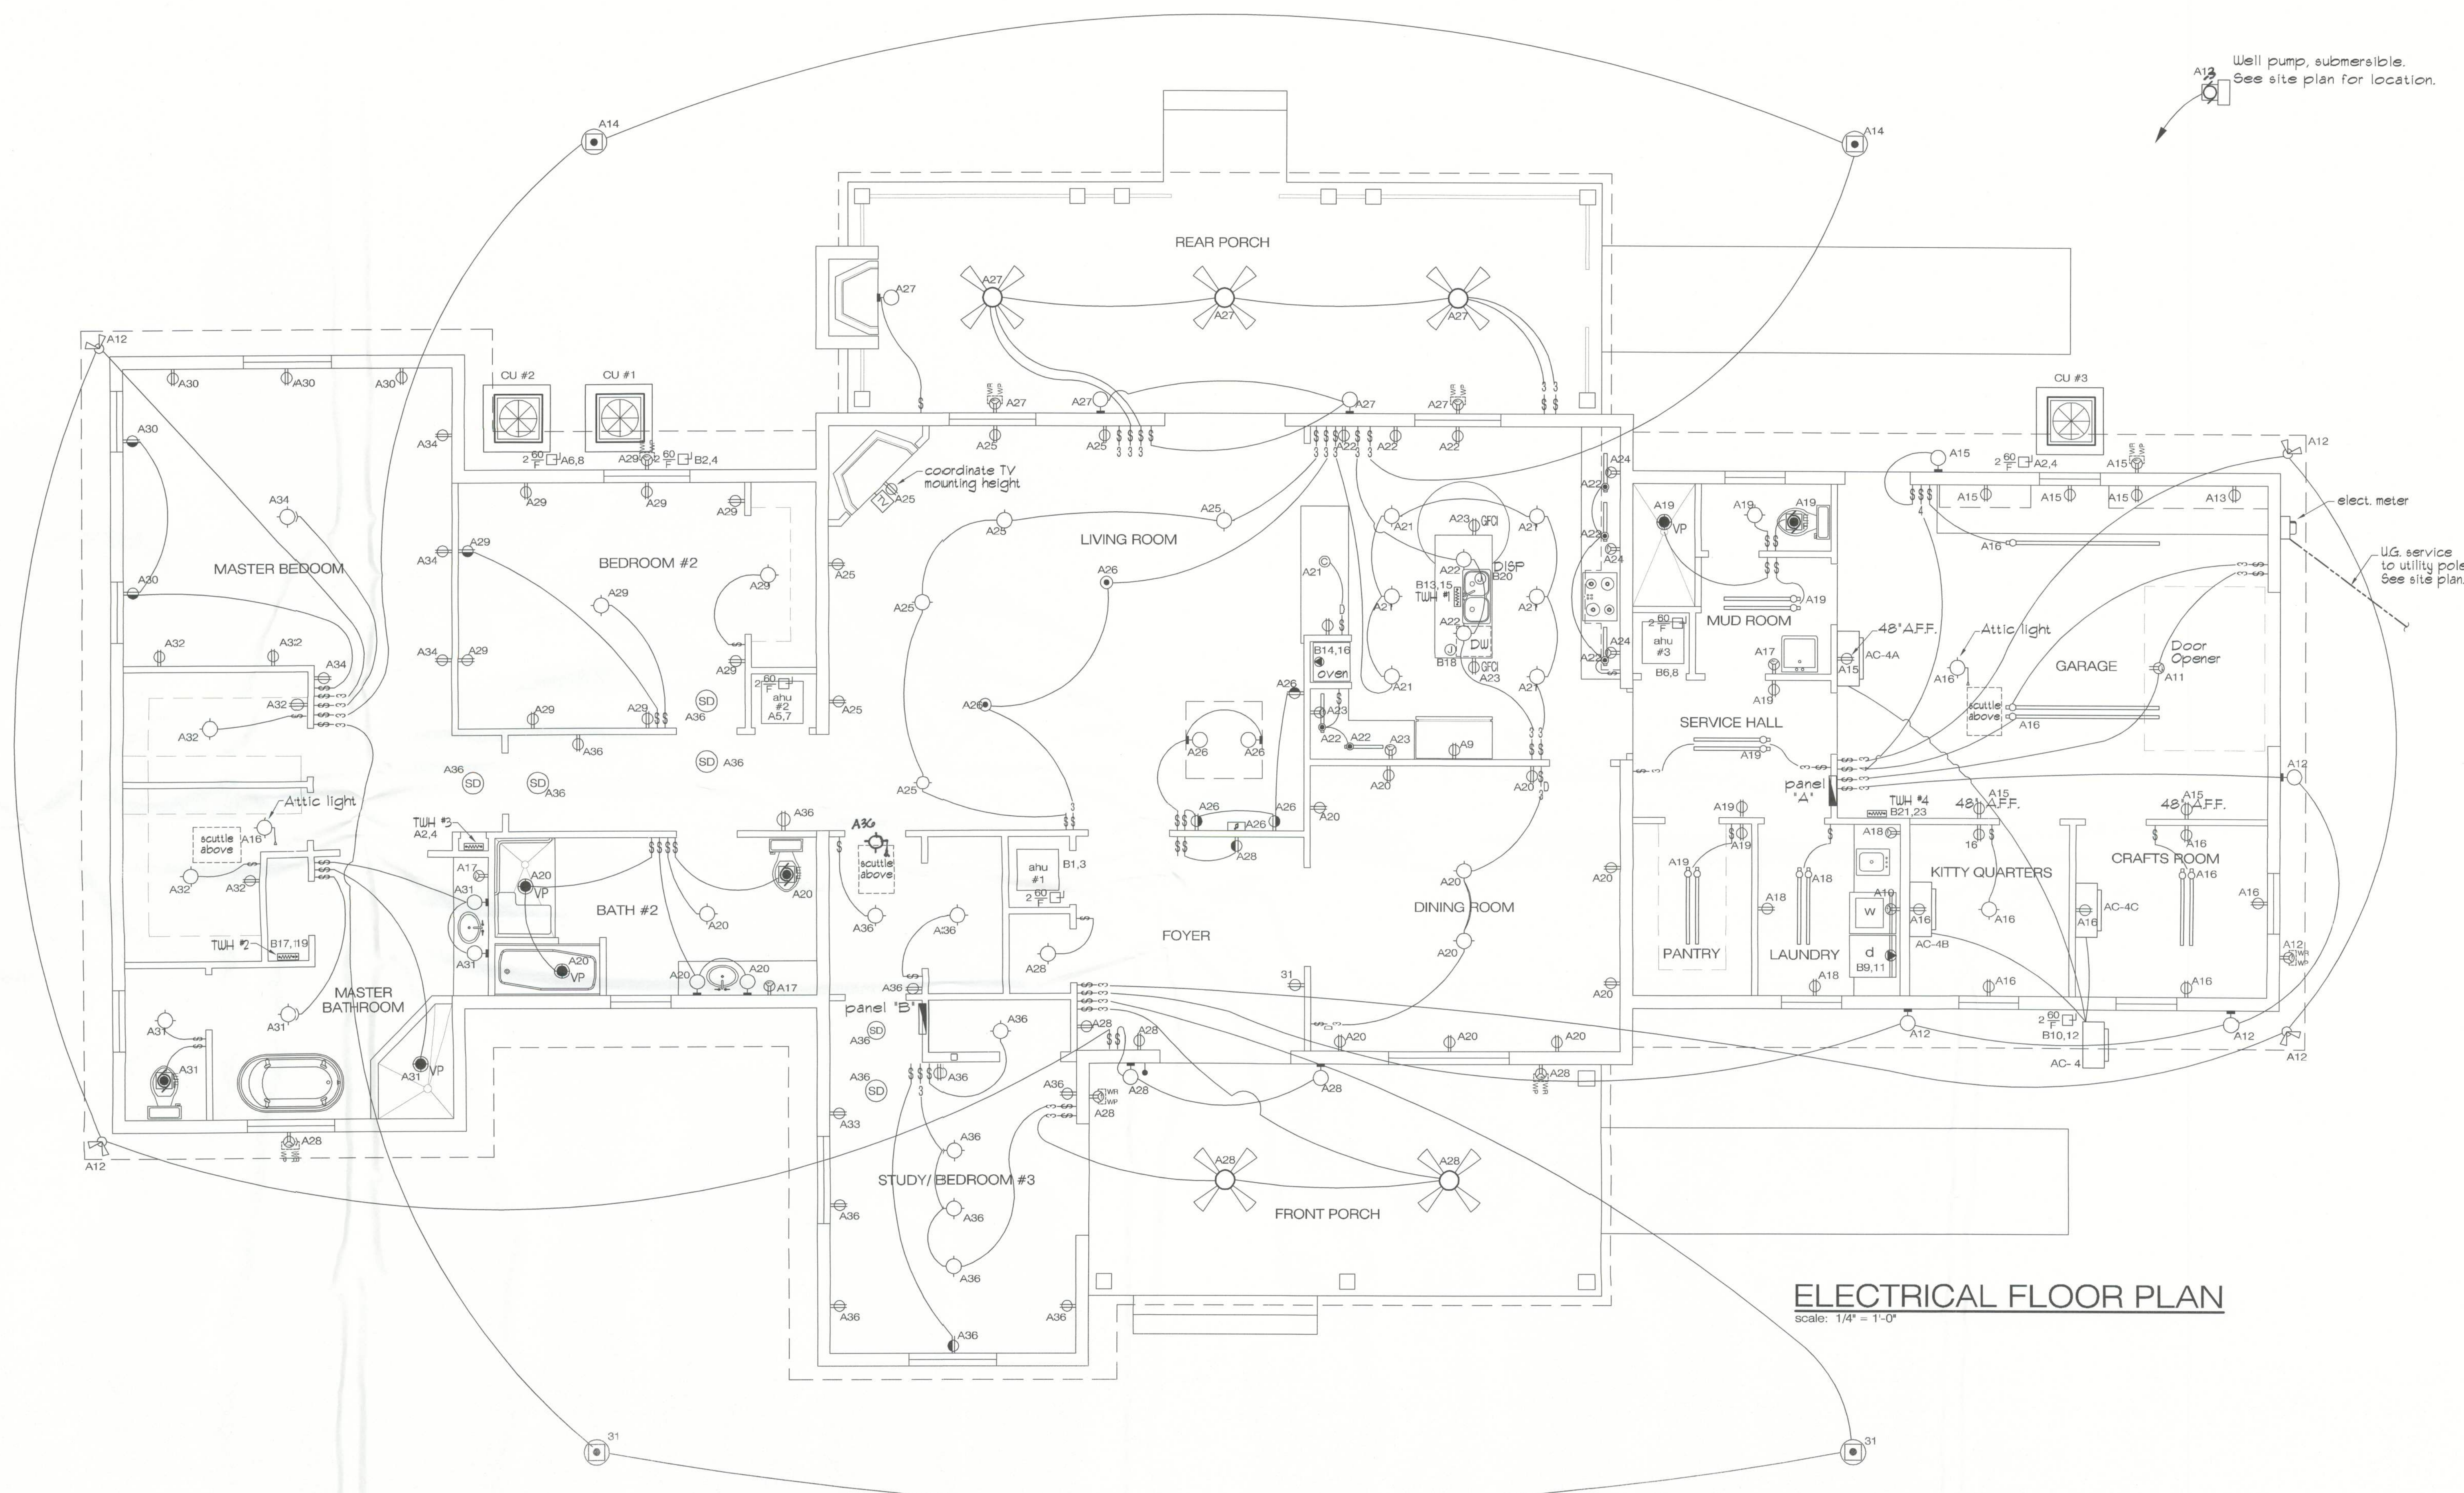

ELECTRICAL FLOOR PLAN
scale: 1/4" = 1'-0"