




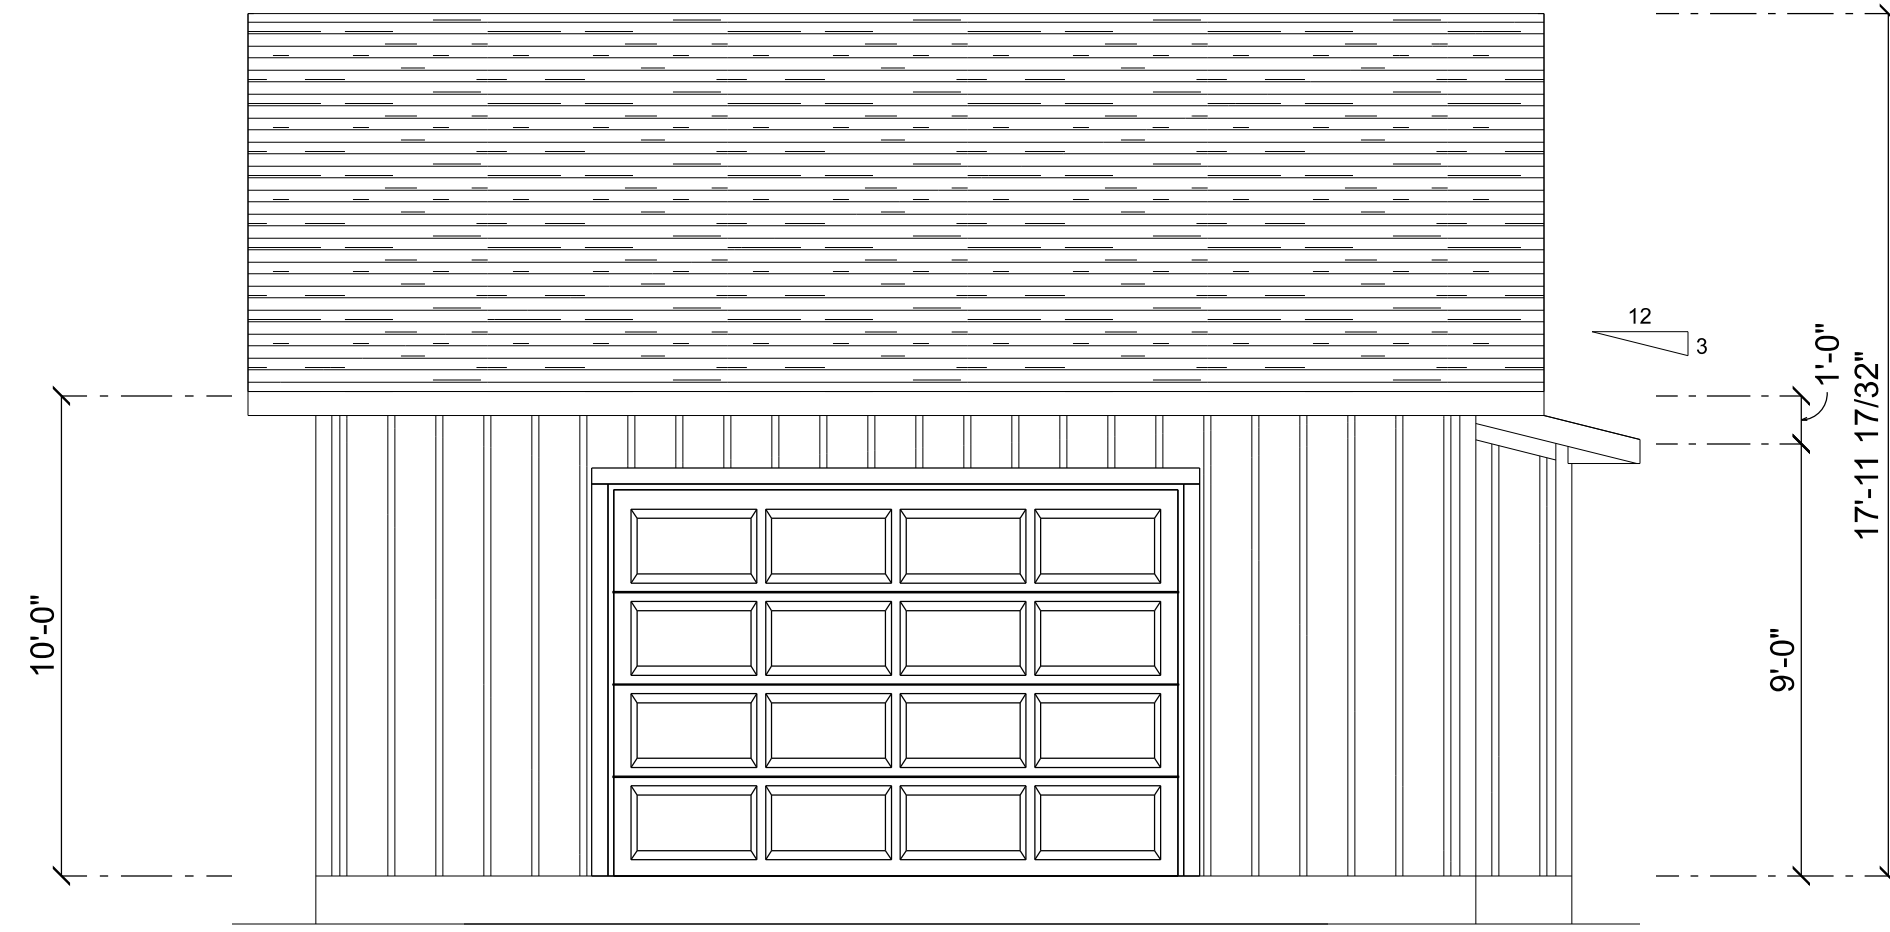


LEFT ELEVATION
SCALE: 1/4" = 1'-0"

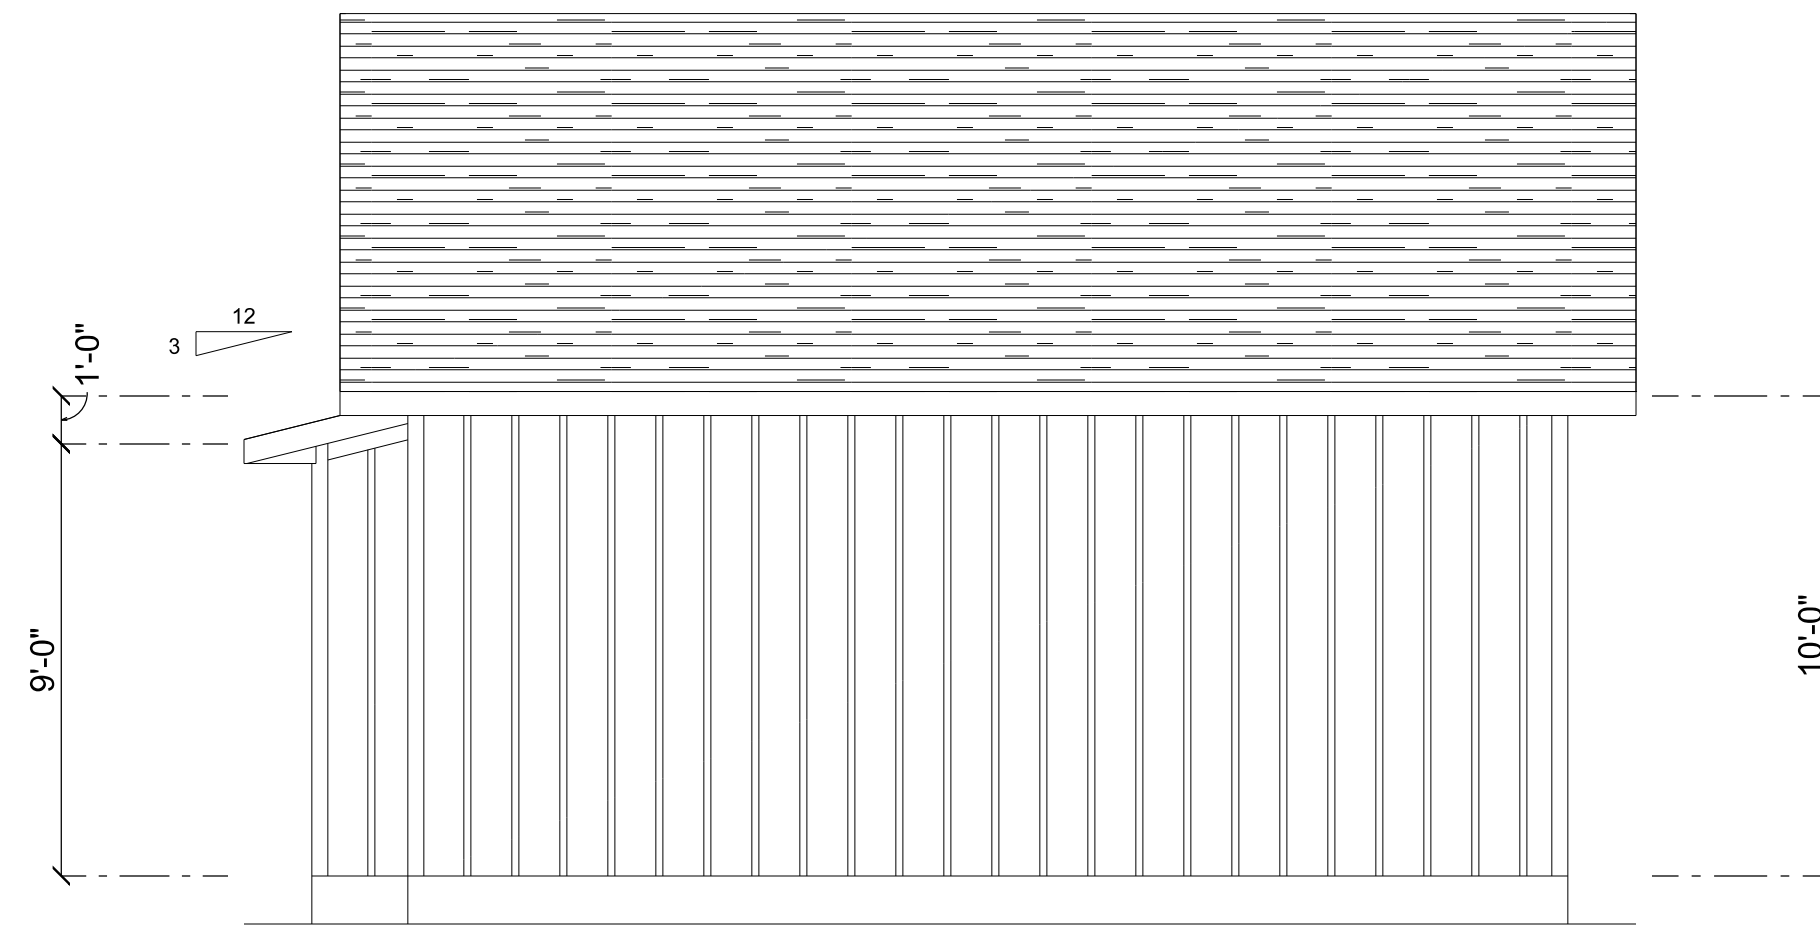

RIGHT ELEVATION
SCALE: 1/4" = 1'-0"

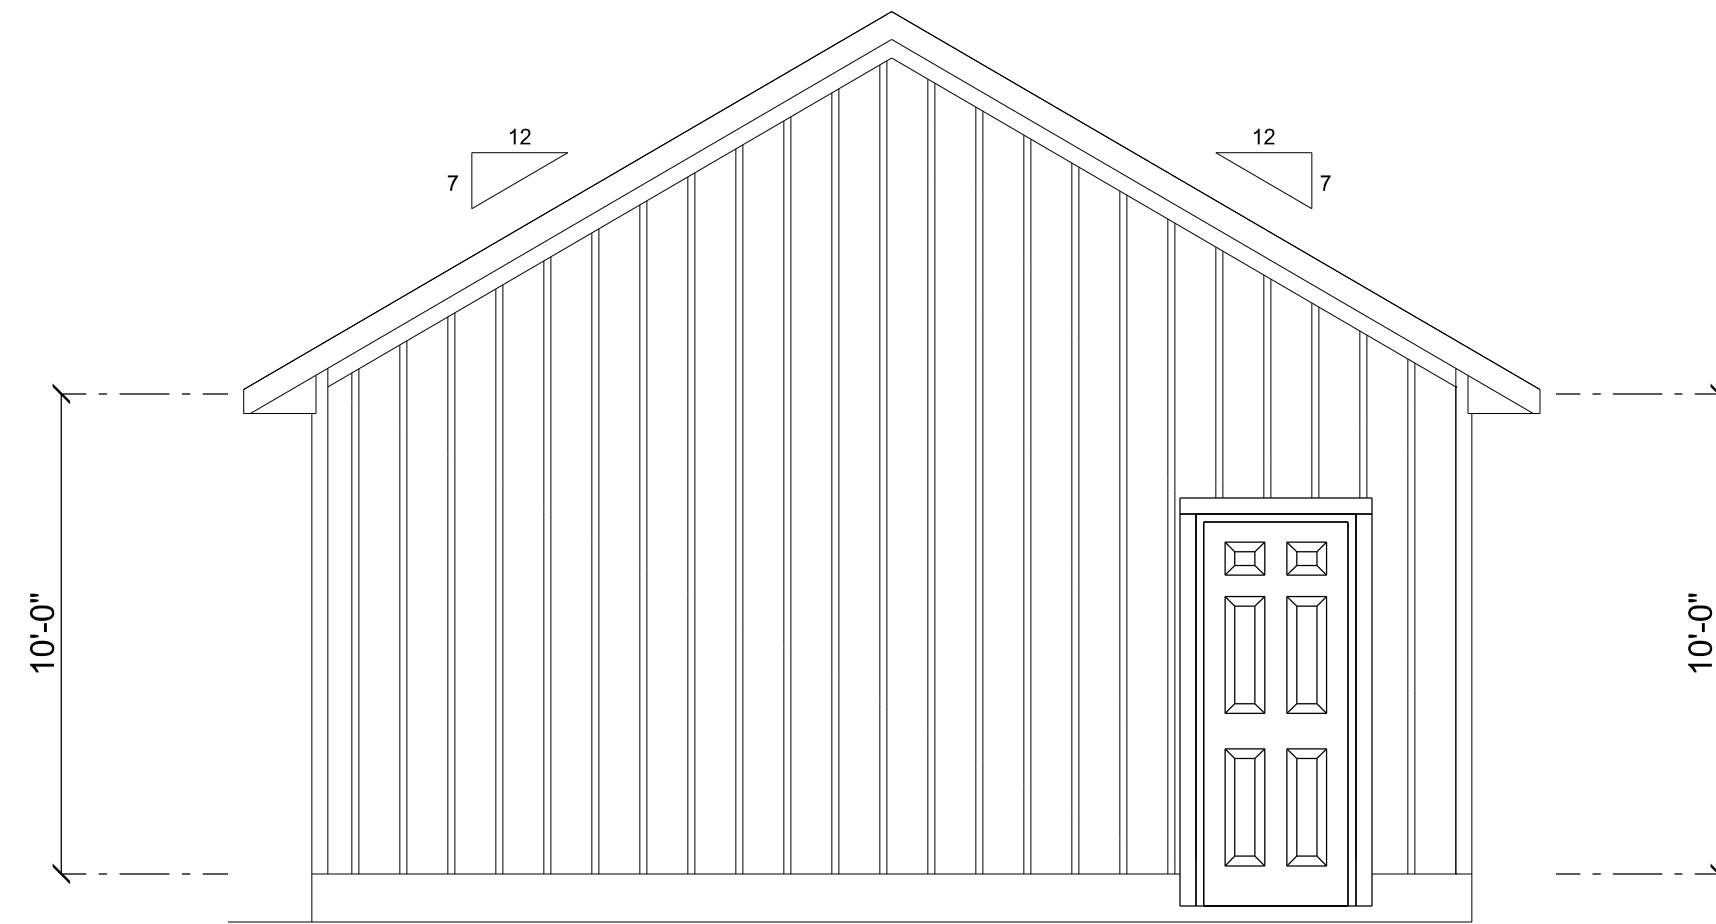

REAR ELEVATION
SCALE: 1/4" = 1'-0"

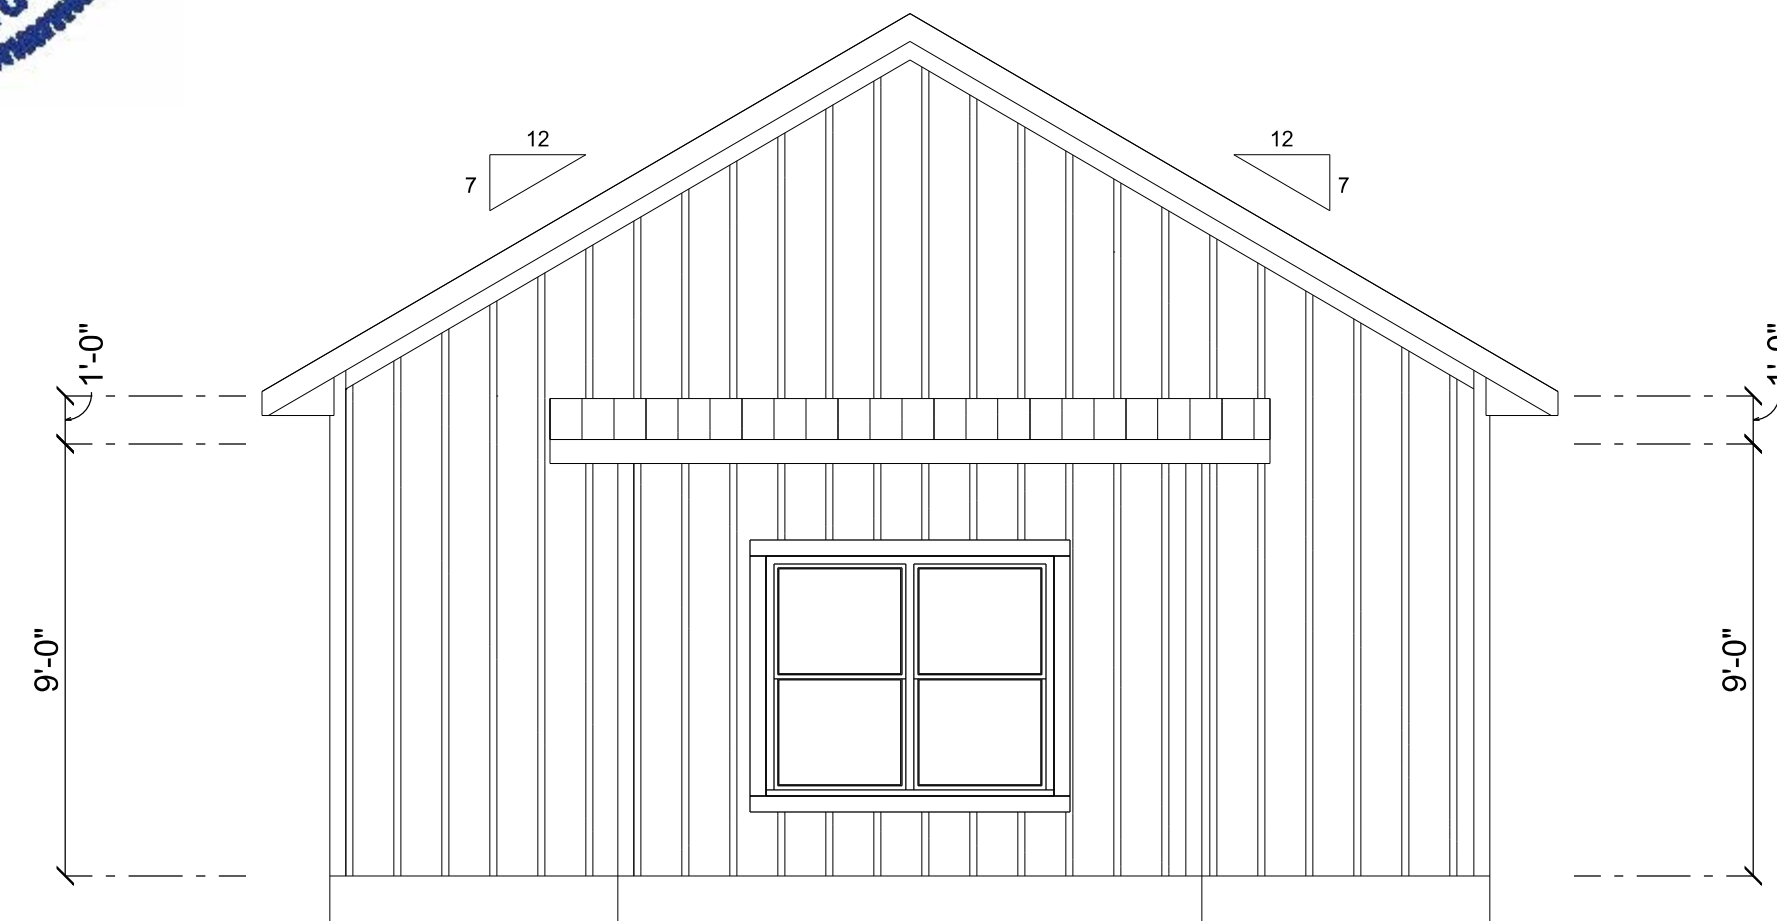

FRONT ELEVATION
SCALE: 1/4" = 1'-0"



REVISIONS SCHEDULE	
Aug 11th, 2022	PROPOSAL


NEW PROPOSAL FOR:
BOB LAVENDER & WENDI MURRY SHOP
LAKE CITY, FLORIDA 32055

**RIDGEPOINT
DESIGN**

566 SW ARINGTON BLVD., STE 101, LAKE CITY, FL 32025
P: 386-288-1188
E: RIDGEPOINTDESIGN@GMAIL.COM


SHEET NUMBER

A.1
OF 2 SHEETS

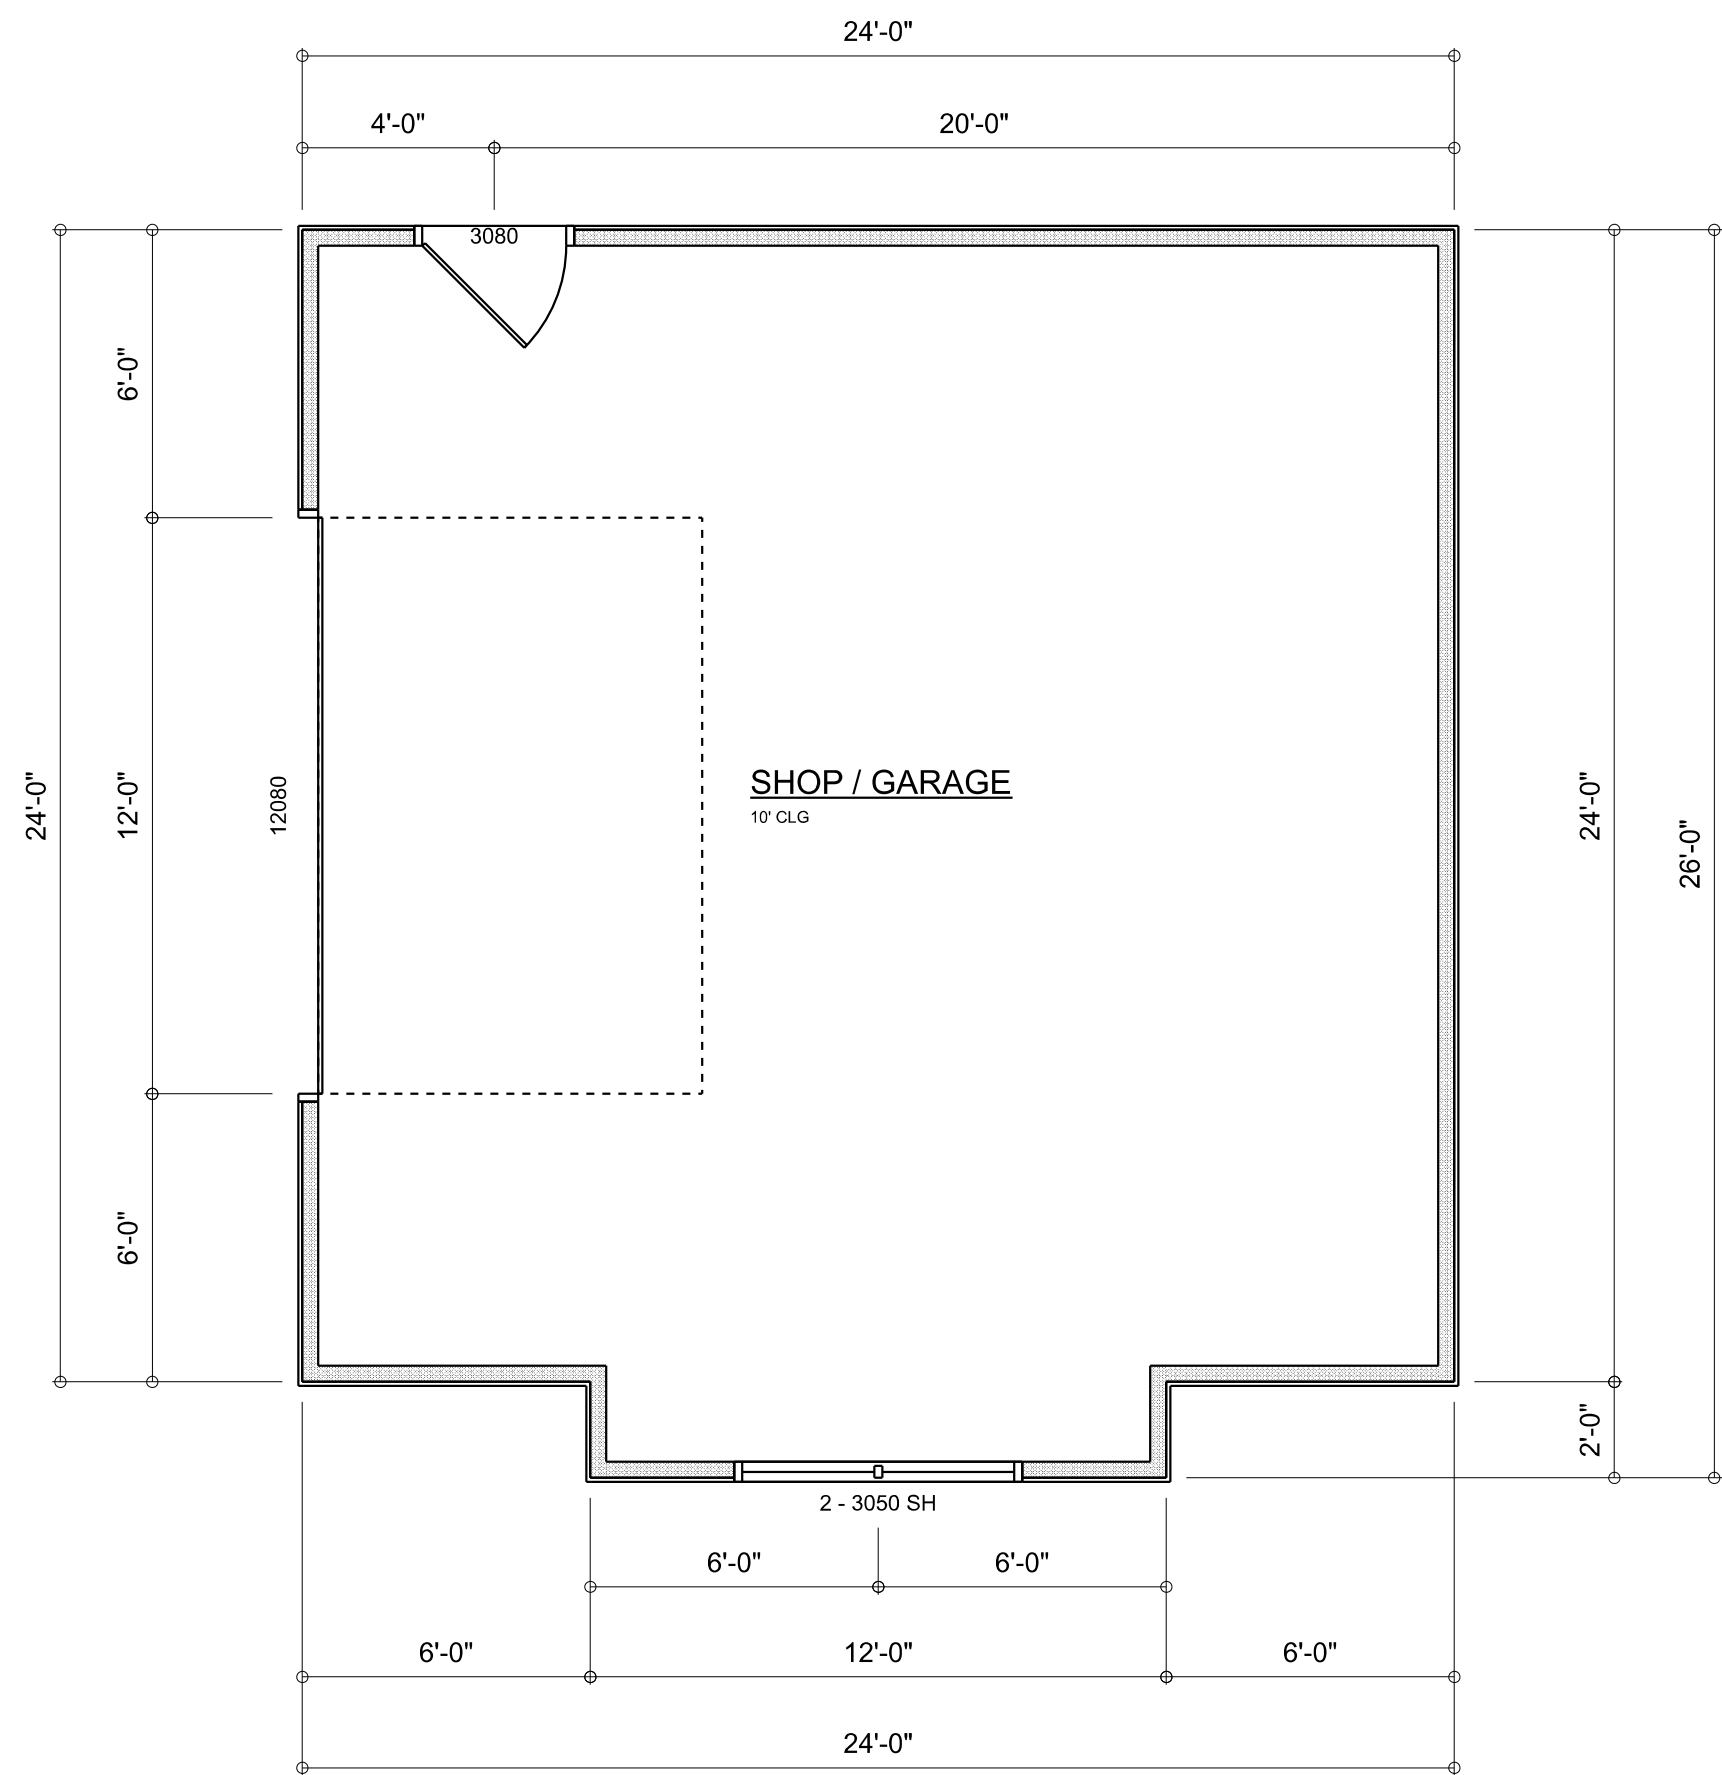

DIMENSIONED FLOOR PLAN
SCALE: 1/4" = 1'-0"

A R E A S U M M A R Y		
SHOP	600	S.F.
TOTAL AREA	600	S.F.

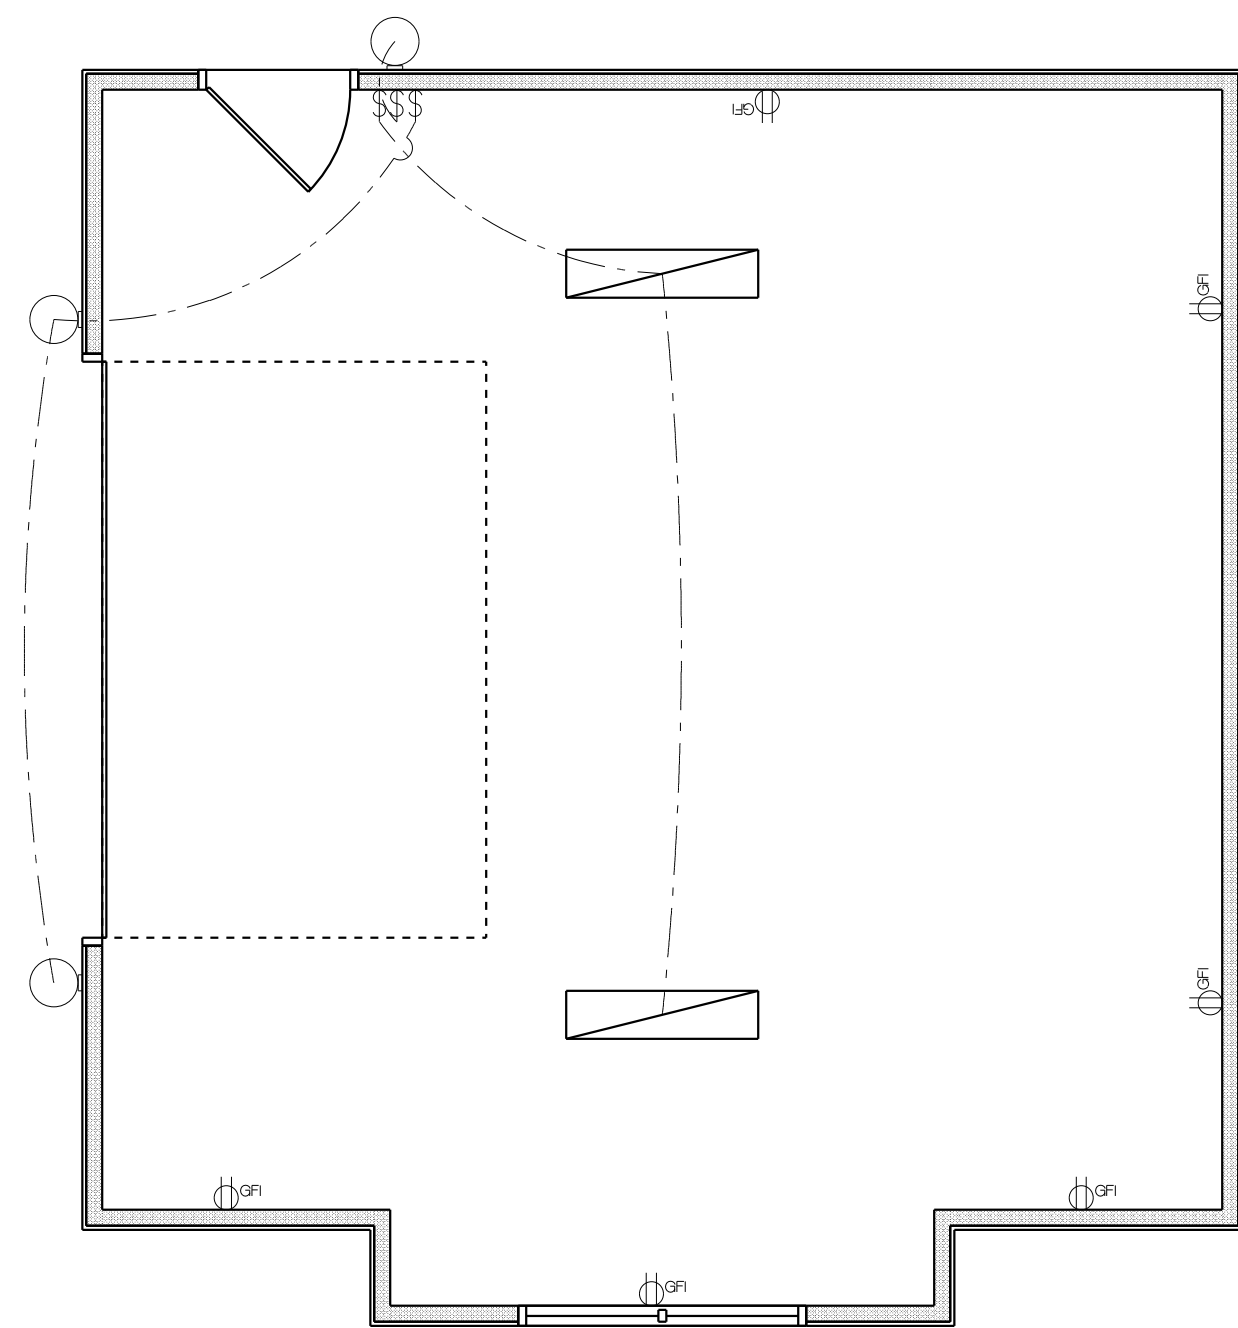

ELECTRICAL FLOOR PLAN
SCALE: 1/4" = 1'-0"

REVISIONS SCHEDULE	
Aug 11th, 2022	PROPOSAL

NEW PROPOSAL FOR:

BOB LAVENDER & WENDI MURRY SHOP

LAKE CITY, FLORIDA 32055

RIDGEPOINT
DESIGN

566 SW ARINGTON BLVD., STE 101, LAKE CITY, FL 32025
P: 386-288-1188
E: RIDGEPOINTDESIGN@GMAIL.COM

SHEET NUMBER

A.2

OF 2 SHEETS