

ARCHITECT

NICHOLAS PAUL GEISLER, ARCHITECT
FL. Reg.: AR0001005
1758 NW BROWN ROAD
LAKE CITY, FLORIDA 32055
386-365-4355
npgeisler@gmail.com

INTERIOR DESIGN

LARRY WILSON, REBECCA DAVISSON
DESIGNMIND
FL. Reg.: ID4563
1814 HENDRICKS AVENUE
JACKSONVILLE, FLORIDA 32207
904-854-2402
info@designmindllc.com

SYSTEMS ENGINEER

LONNIE MYLER, PE
OSSI & MYLER, INC.
FL. Reg.: FE55353
1934 RETAW STREET
JACKSONVILLE, FLORIDA 32210
904-381-8946
lmyler@ossi-myler.com


DEVELOPER

JEREMY CADY
CADY & CADY STUDIOS
1015 KINGS AVENUE
JACKSONVILLE, FLORIDA 32207
904-880-7455
jeremy.cady@cadystudios.com

PROJECT LOCATION


JEREMY CADY
CADY & CADY STUDIOS
496 RING COURT
LAKE CITY, FLORIDA 32025

VICINITY MAP

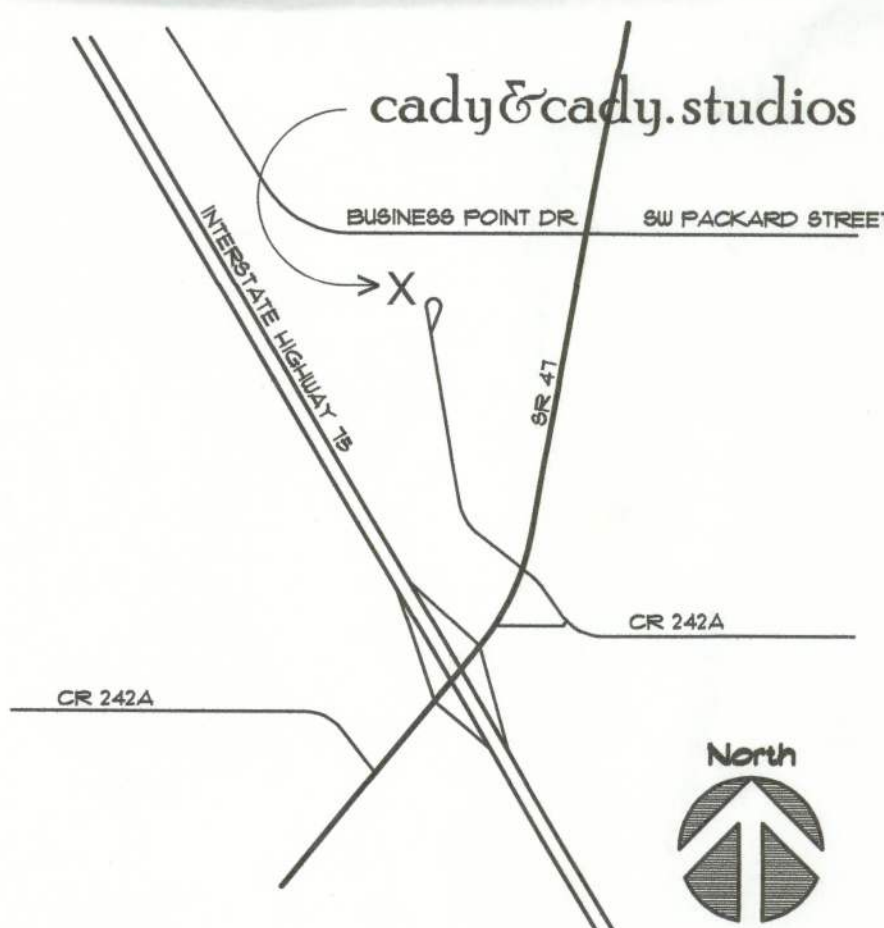

BUILDING USE, CLASSIFICATION & OCCUPANCY AS PER
TABLES 503 & 1003.1, FLORIDA BUILDING CODE, 2007 ED.

BUILDING GROUP OCCUPANCY	GROUP B
TABLE 503 TYPE OF CONSTRUCTION	TYPE V - UNPRO.
TABLE 503 AREA/HEIGHT LIMITATIONS	9.0 KSF/1 STORY
TABLE 500 AREA INCREASE:	110% = 19.8 KSF
OCCUPANCY BUSINESS AREA: PER LIFE SAFETY PLAN	230 OCCUPANTS

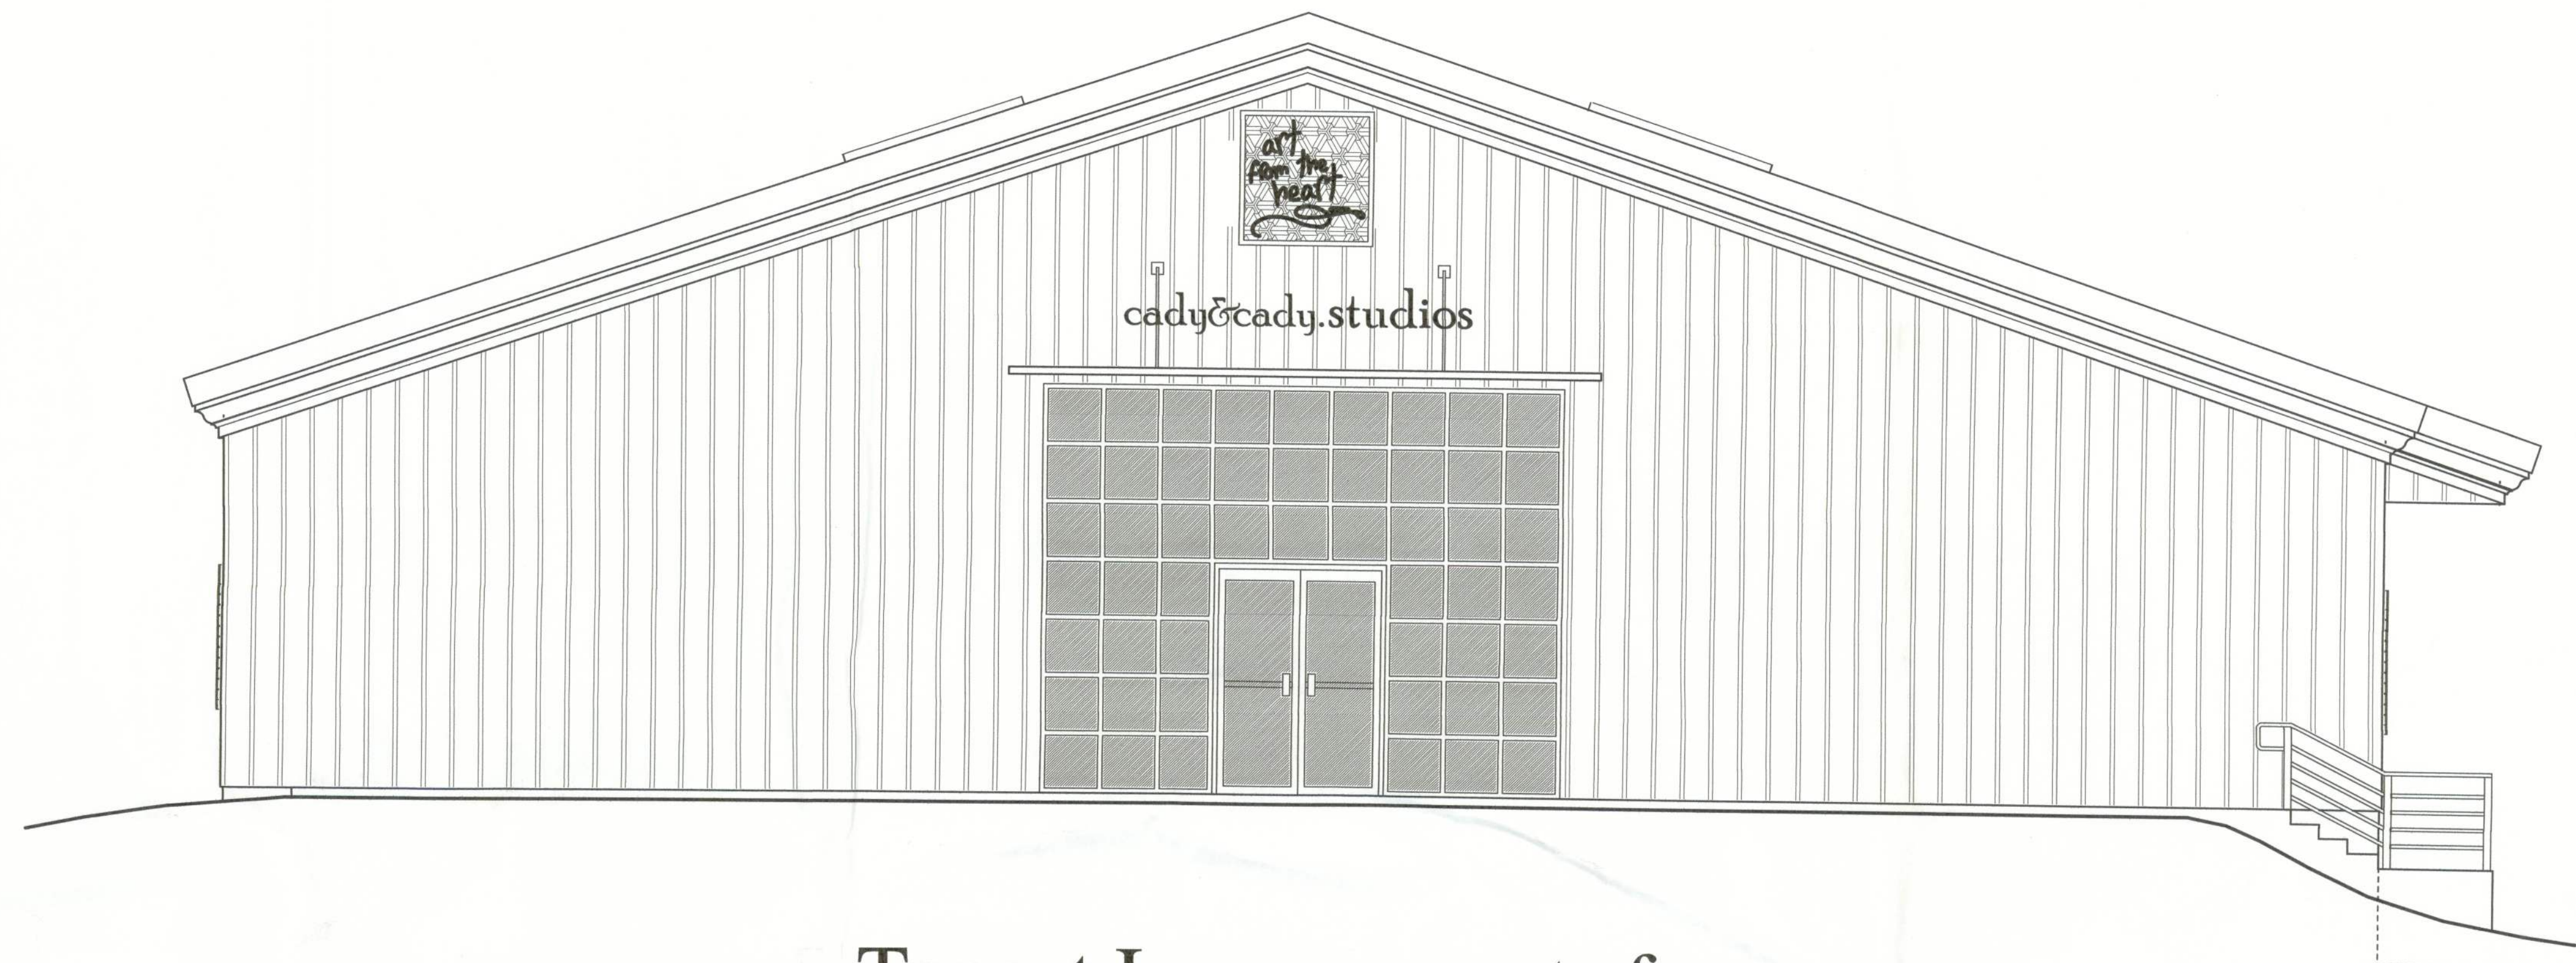

Tenant Improvements for:

cady&cady.studios

Lake City, Columbia County, Florida

art
from the
heart

Drawing Index


DWG. Nr.	NICHOLAS PAUL GEISLER, ARCHITECT AR0001005
CS.1	COVER SHEET, DRAWING INDEX
SP.1	SITE PLAN
A.1	BUILDING ELEVATIONS
A.2	STOREFRONT DETAILS, OPENING DETAILS
A.3	MECHANICAL EQUIPMENT LOFT PLAN & DETAILS
P.1	PLUMBING PLAN, PLUMBING RISER DIAGRAM
P.2	WATER DISTRIBUTION PLAN
P.3	1/4" SCALE PLUMBING PLANS, DETAILS
P.4	GENERAL PLUMBING NOTES

DWG. Nr.	DESIGNMIND INTERIORS
G100	INDEX, NOTES & CODES
G101	DOOR SCHEDULE
ID101	LIFE SAFETY PLAN & NEW CONSTRUCTION PLAN
ID201	ENLARGED NEW CONSTRUCTION PLAN & REFLECTED CEILING PLAN
ID301	POWER & COMMUNICATIONS PLAN & FINISH FLOOR PLAN

DWG. Nr.	MYLER ENGINEERING
M.1	MECHANICAL LEGEND, SCHEDULES AND NOTES
M.2	FLOOR PLAN - MECHANICAL
M.3	DETAILS - MECHANICAL
M.4	SPECIFICATIONS - MECHANICAL
E.1	ELECTRICAL LEGEND, RISER AND DETAILS
E.2	FLOOR PLAN - LIGHTING AND LUMINAIRE SCHEDULE
E.3	FLOOR PLAN - POWER AND SYSTEMS



WILLIAM MYERS
DESIGN
P.O. BOX 1513
LAKE CITY, FL 32056
(386) 758-8406
will@willmyers.net

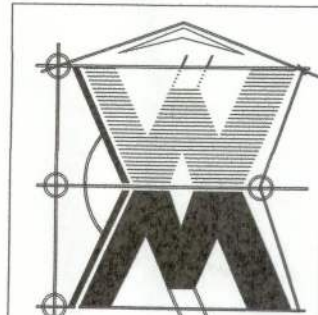

NICHOLAS
PAUL
GEISLER
ARCHITECT
1758 NW Brown Rd.
Lake City, FL 32055
386-365-4355
N.C.A.R.B. Certified

Celebrating
39 Years of Service
1972 - 2011
N.P. Geisler, Architect
AR0007005



TENANT IMPROVEMENTS for:

cady&cady.studios
LAKE CITY, COLUMBIA COUNTY, FLORIDA

REVISIONS

20 JUL 2011
29 JUL 2011
03 AUG 2011

JOB NUMBER
2K1124
DATE:
06 JUL 2011

SHEET NUMBER
CS.1
OF 1 SHEETS