



FRONT ELEVATION
SCALE: 1/4" = 1'-0"




REAR ELEVATION
SCALE: 1/4" = 1'-0"

REVISIONS SCHEDULE	
PROPOSAL	March 2nd, 2022
REVISIONS	Mar. 25th, 2022
PERMIT SET	April 18th, 2022


CUSTOM HOME FOR:
LITTLE RESIDENCE
1542 Little Rd, Lake City, FL 32024

RIDGEPOINT
DESIGN
566 SW ARLINGTON BLVD, STE 101, LAKE CITY, FL 32025
P: 386-288-1188
E: RIDGEPOINTDESIGN@GMAIL.COM


SHEET NUMBER
A.1
OF 8 SHEETS

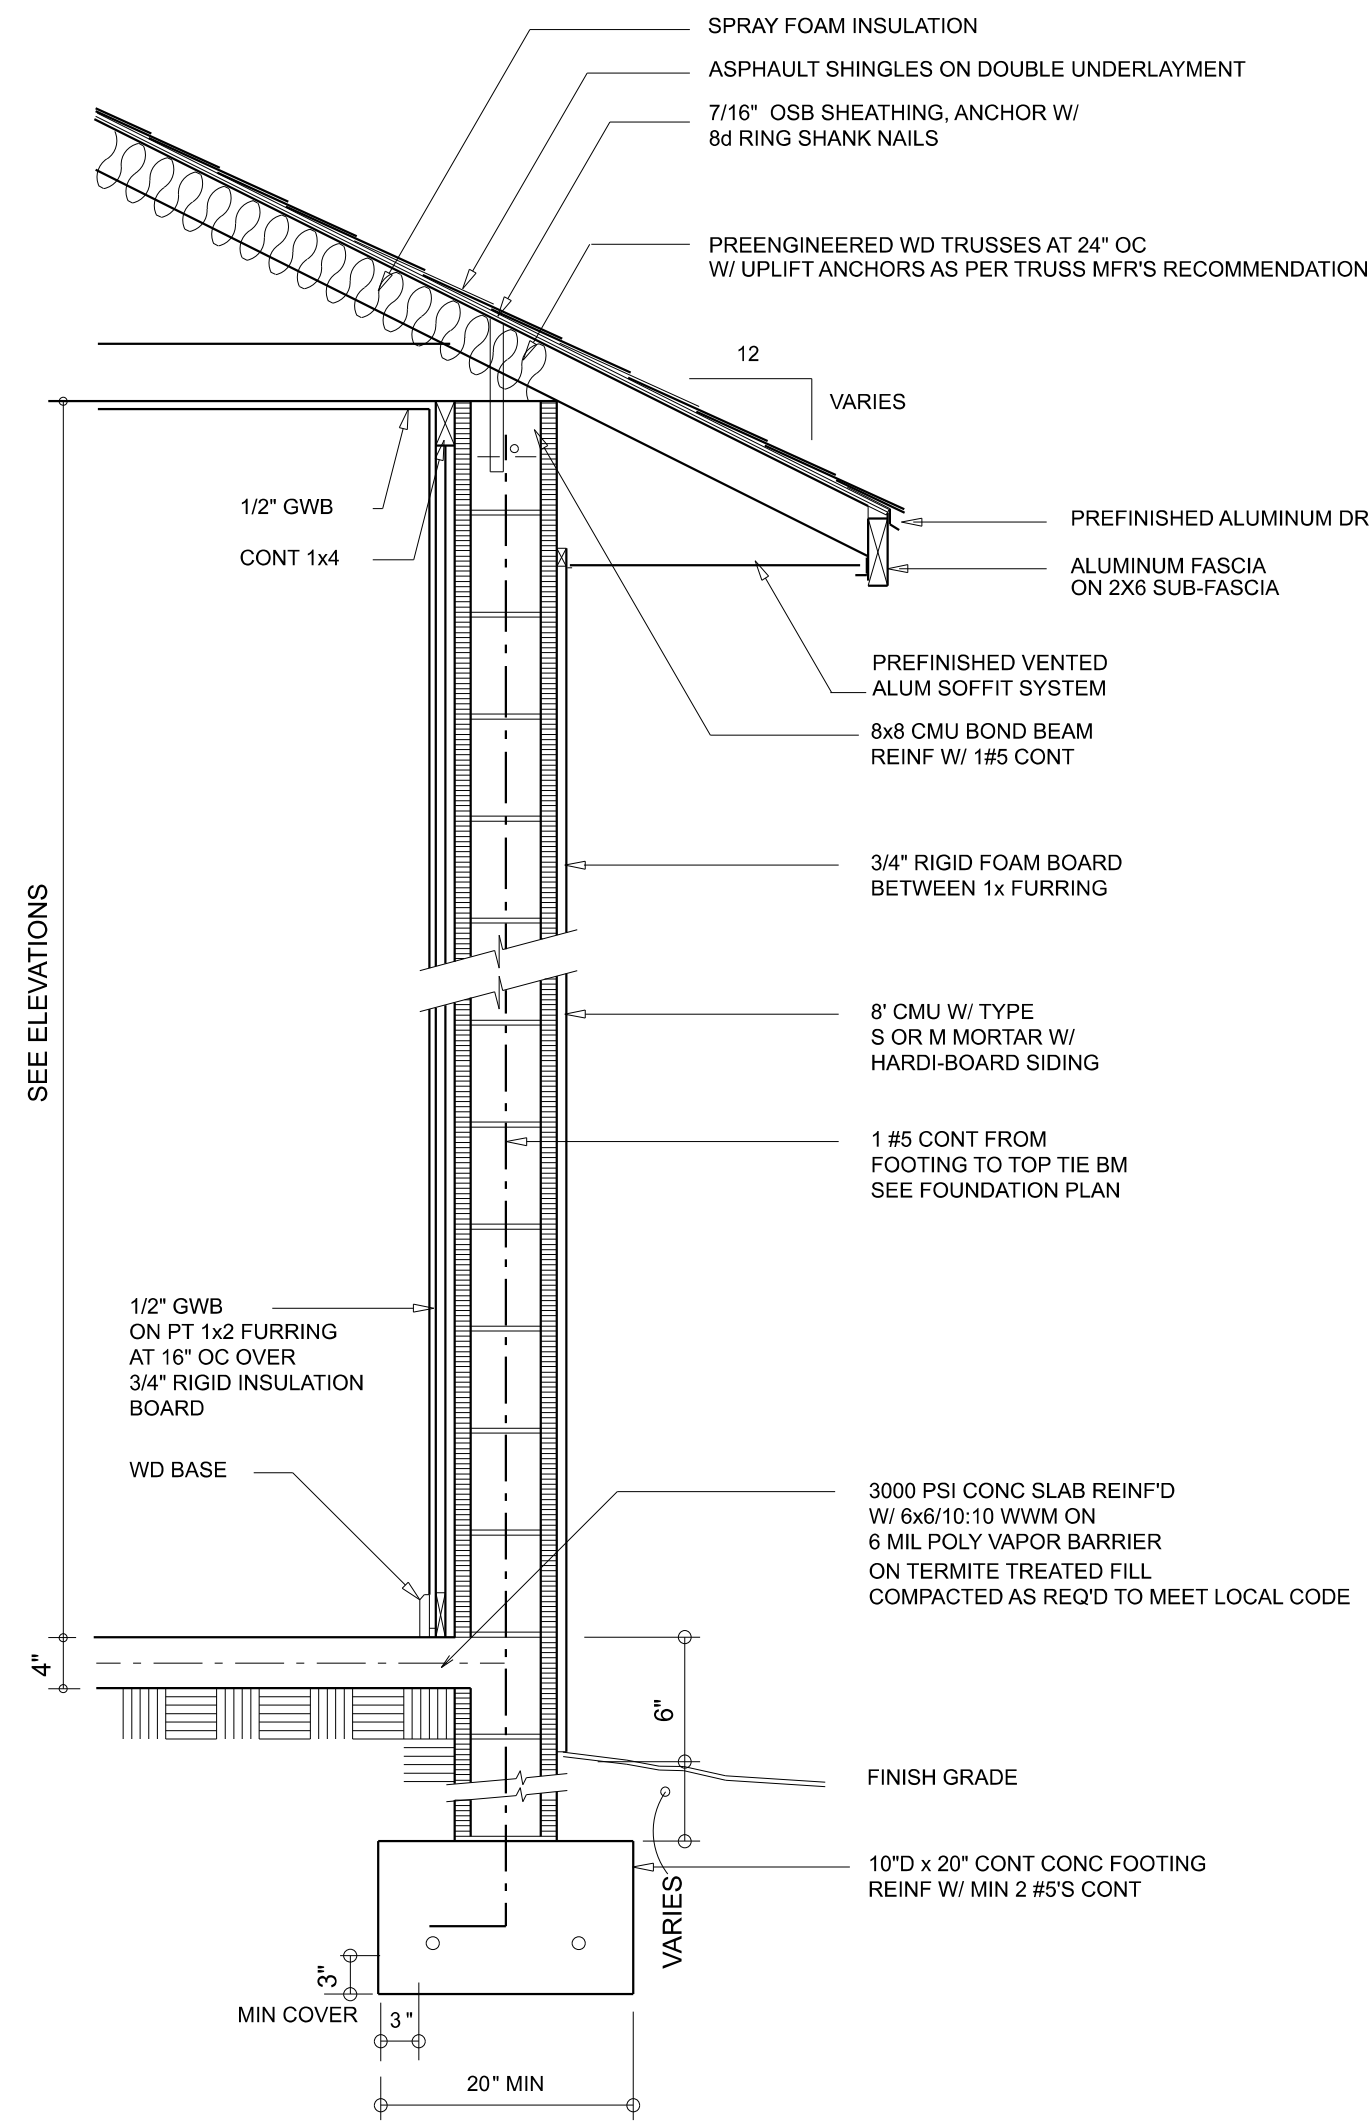

WALL SECTION
3/4" = 1"

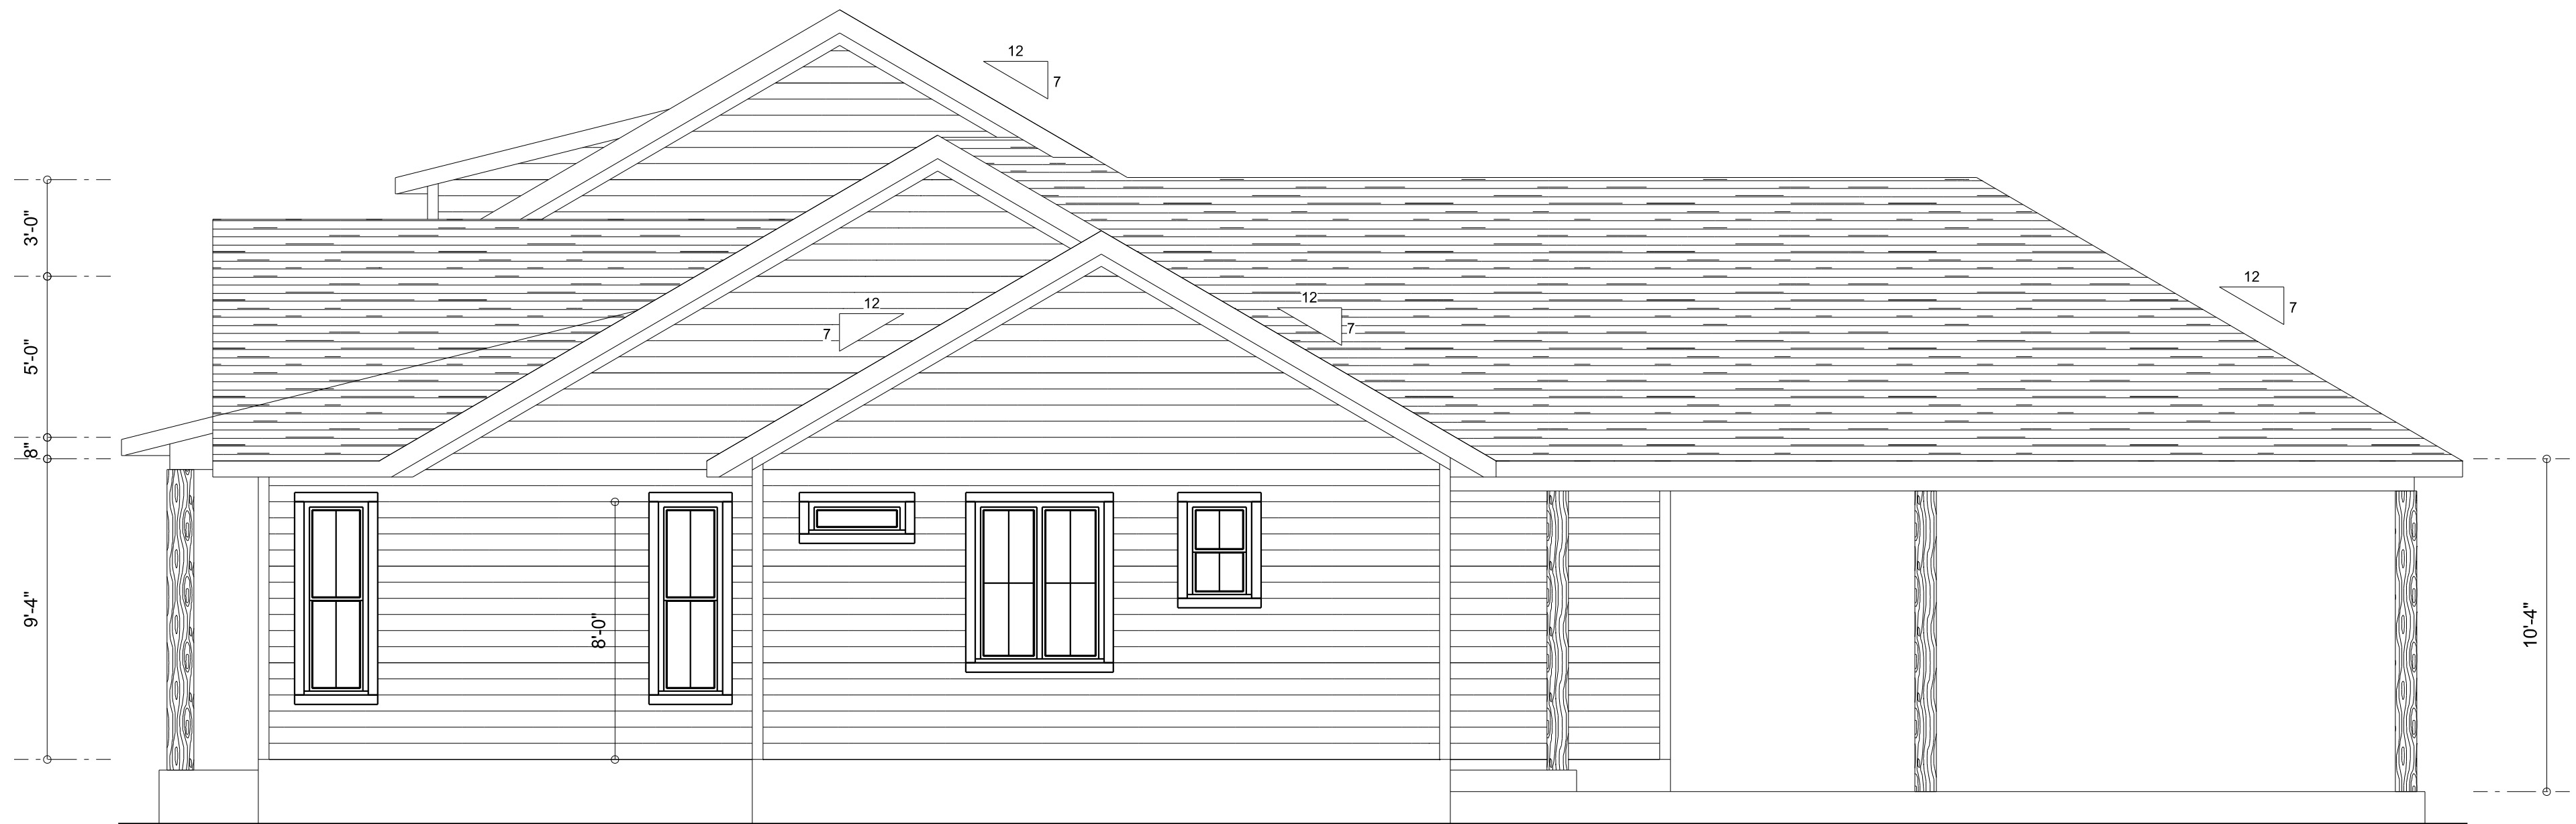

RIGHT ELEVATION
SCALE: 1/4" = 1'-0"

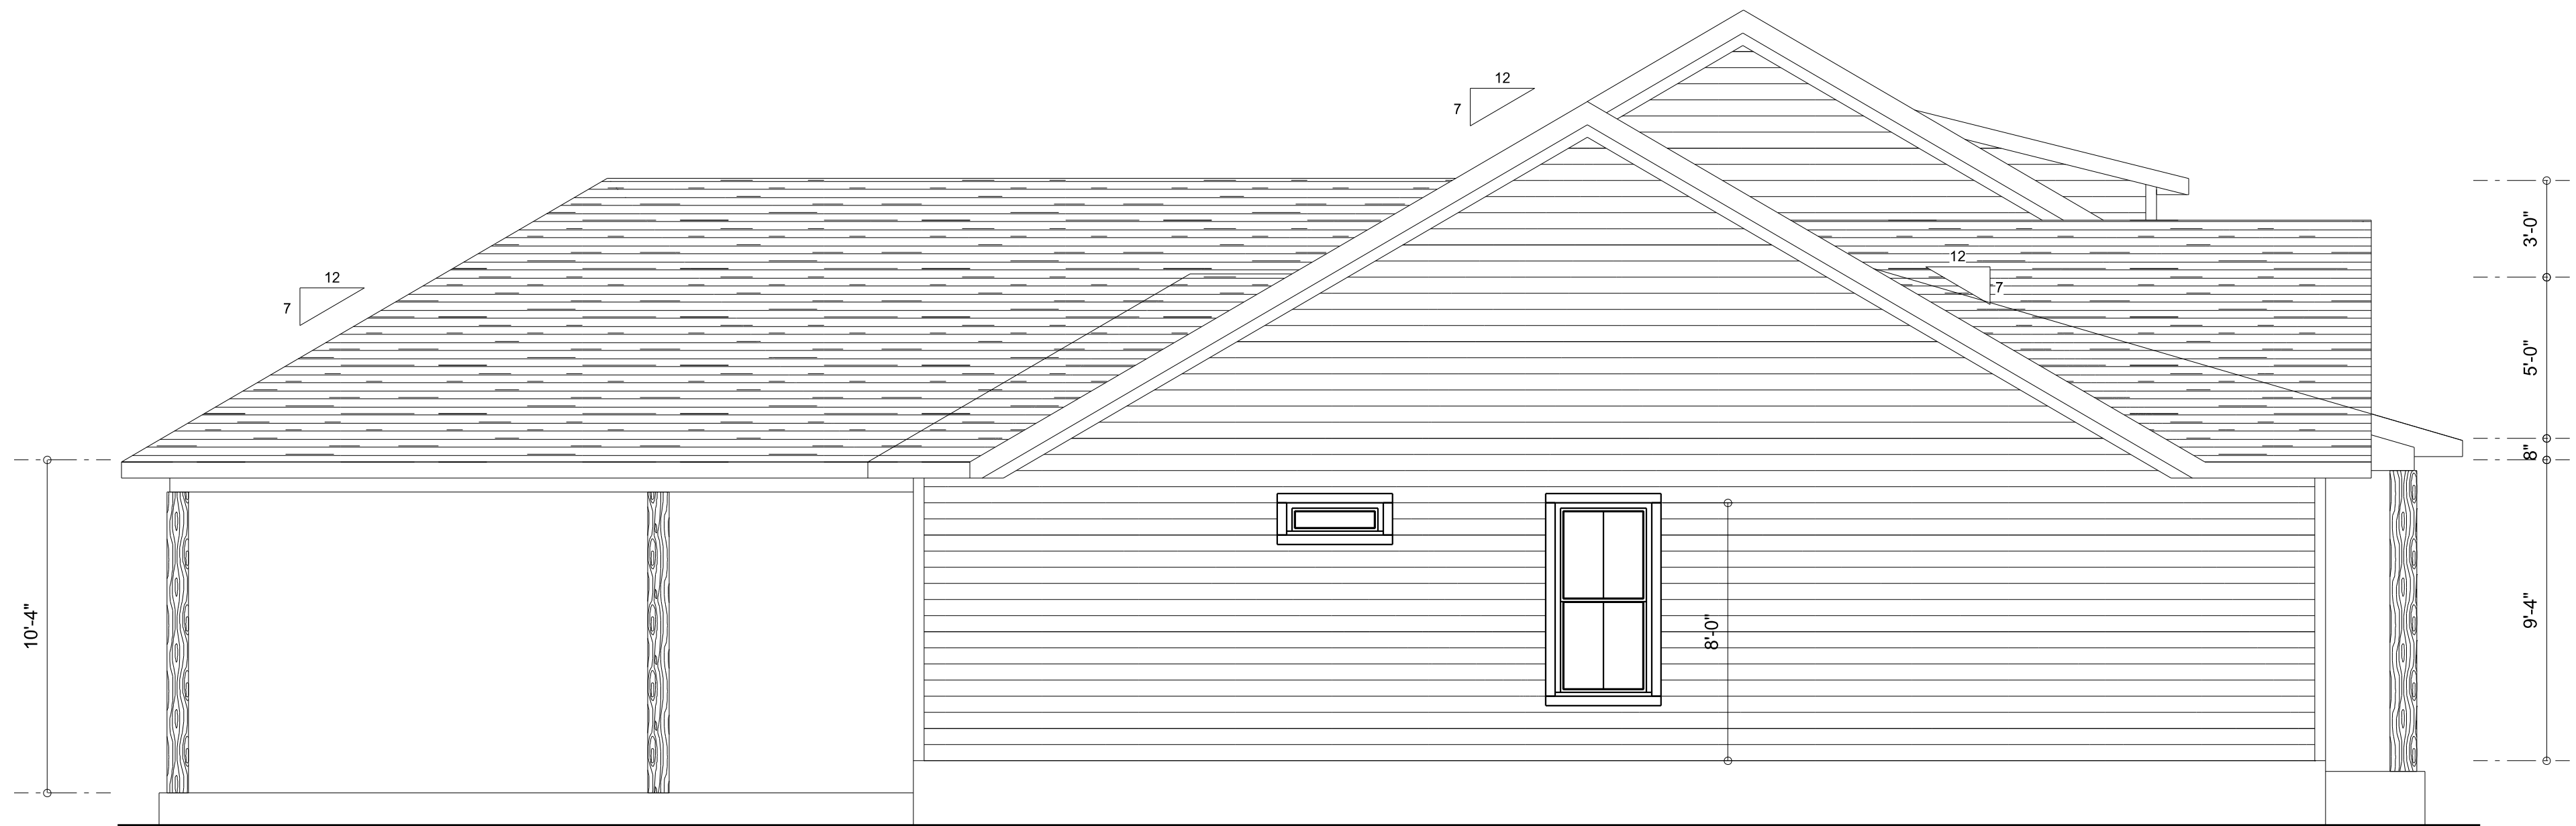

LEFT ELEVATION
SCALE: 1/4" = 1'-0"


REVISIONS SCHEDULE	
PROPOSAL	March 2nd, 2022
REVISIONS	Mar. 25th, 2022
PERMIT SET	April 18th, 2022

CUSTOM HOME FOR:
LITTLE RESIDENCE

1542 Little Rd, Lake City, FL 32024

**RIDGEPOINT
DESIGN**

566 SW ARLINGTON BLVD, STE 101, LAKE CITY, FL 32025
P: 386-288-1188
E: RIDGEPOINTDESIGN@GMAIL.COM

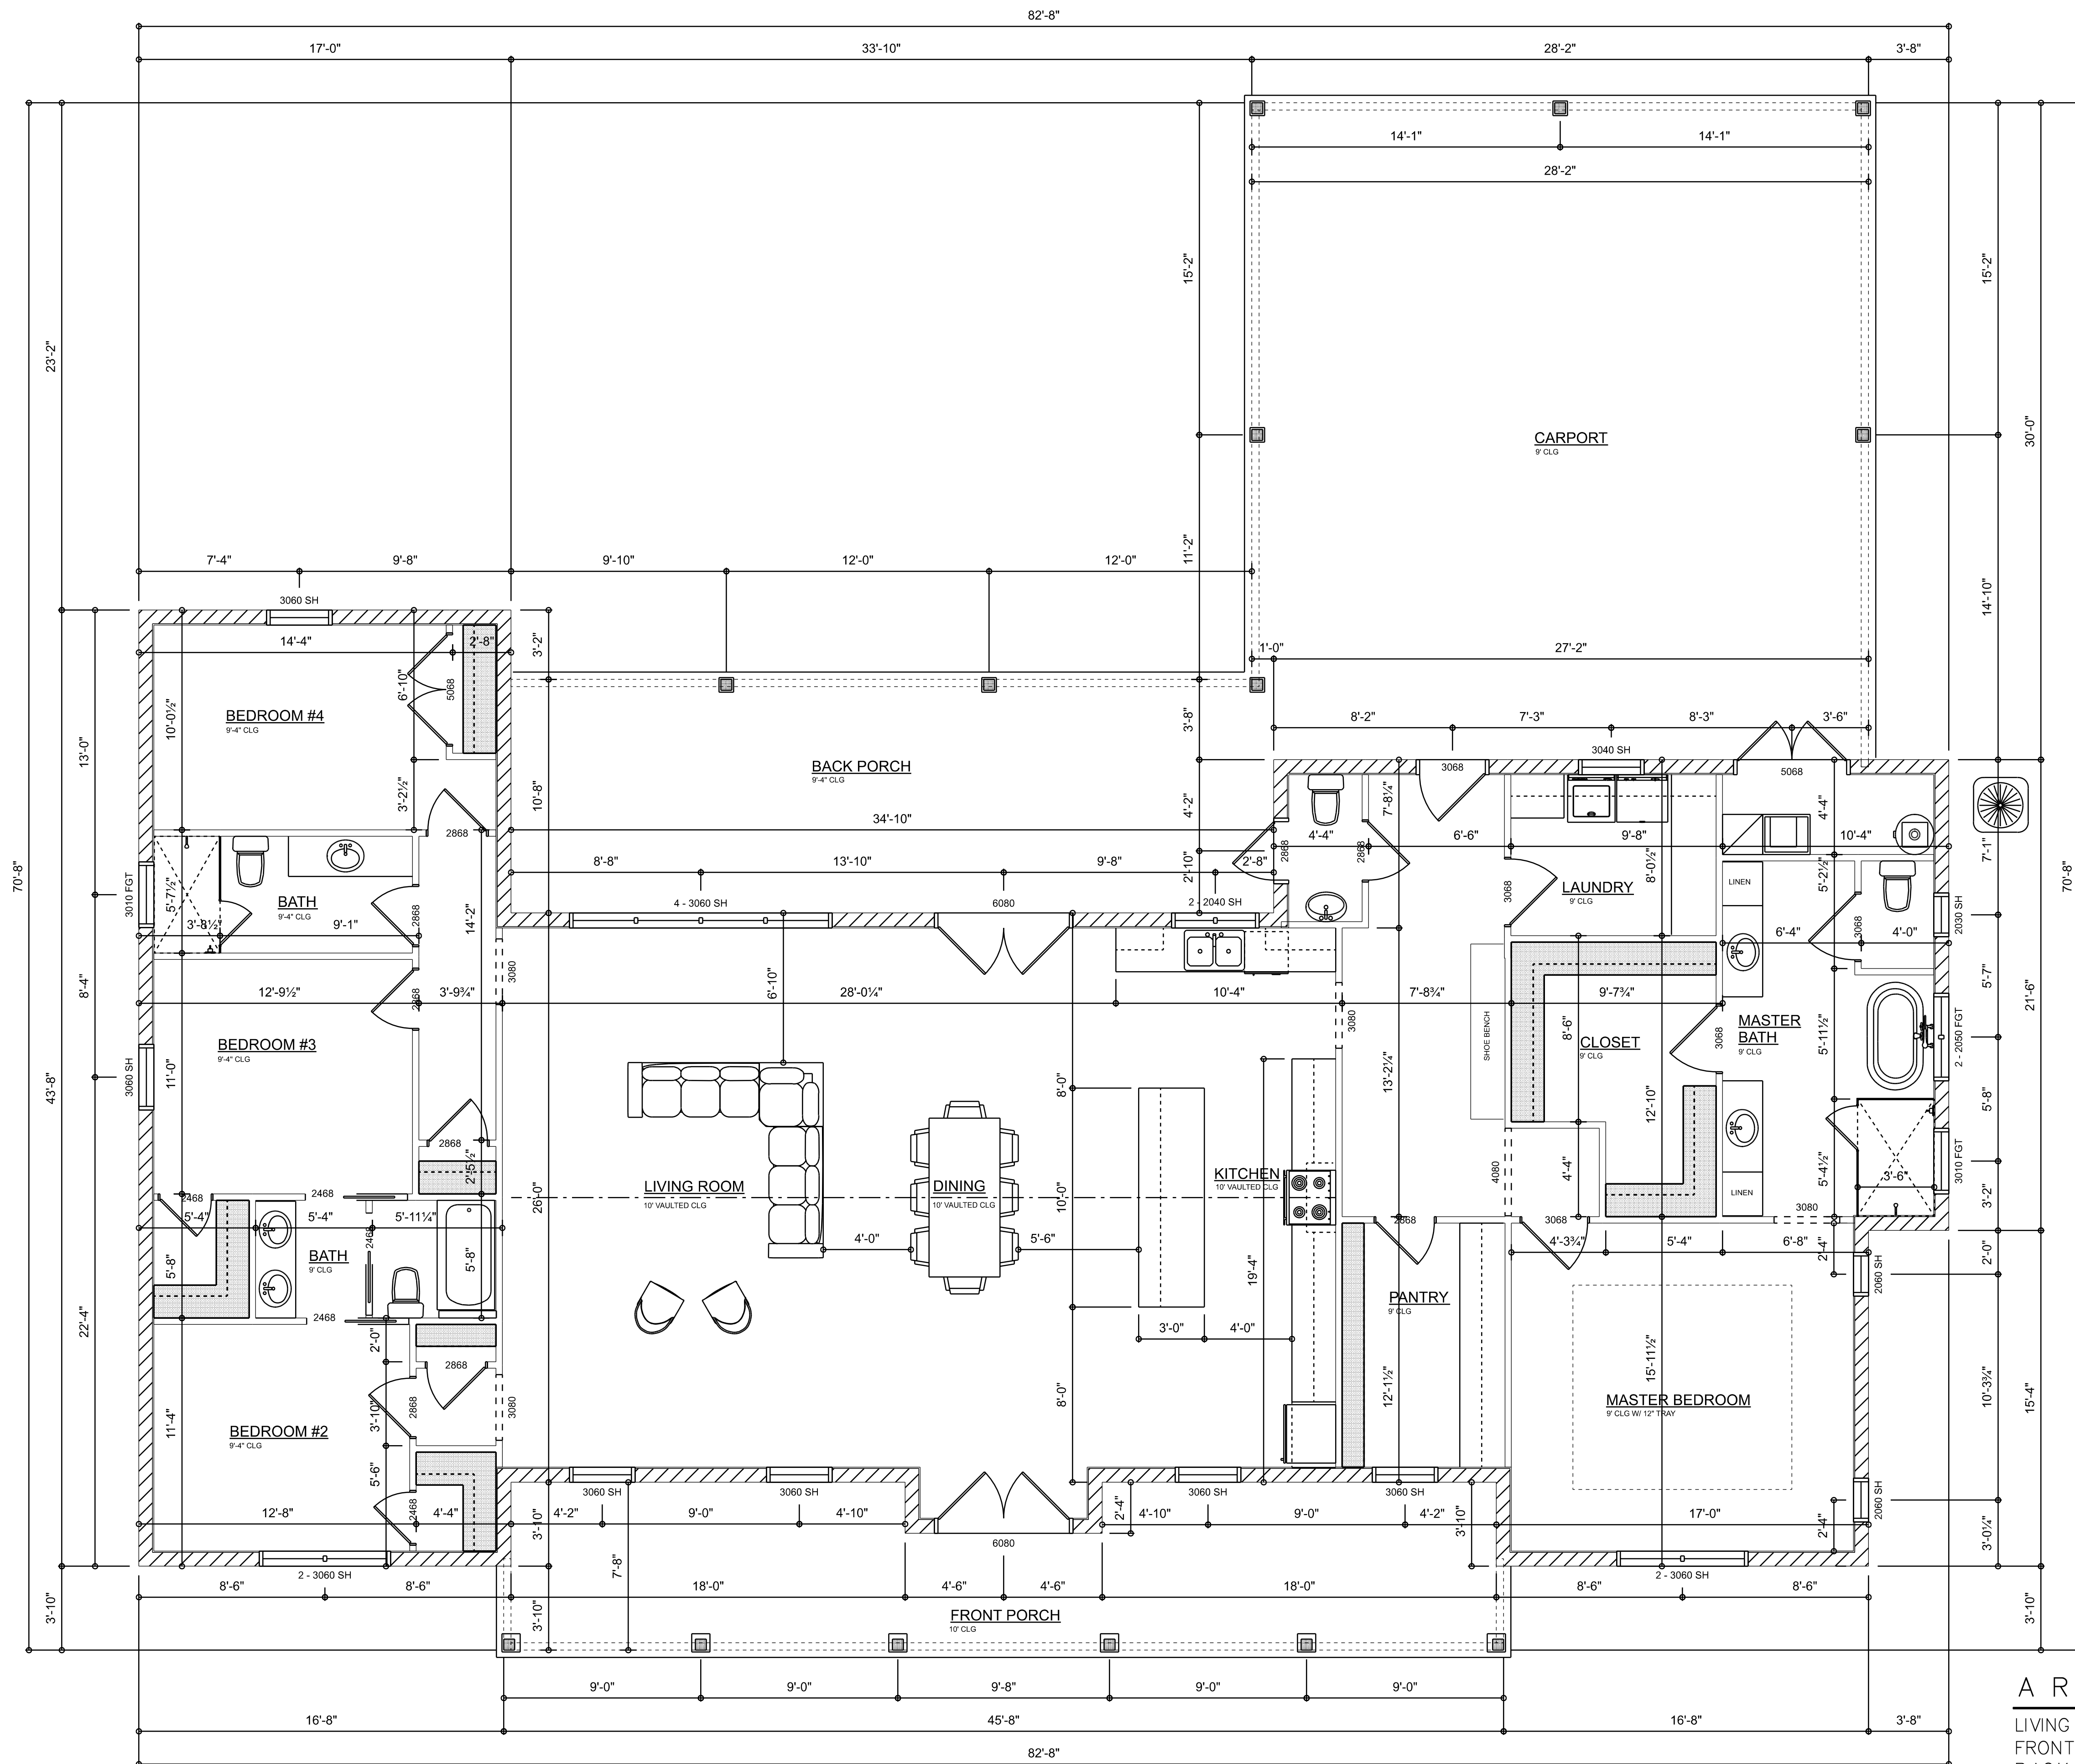

DIMENSIONED FLOOR PLAN
SCALE: 1/4" = 1'-0"



AREA SUMMARY		
LIVING	2,710	S.F.
FRONT PORCH	324	S.F.
BACK PORCH	369	S.F.
CARPORT	848	S.F.
TOTAL AREA	4,251	S.F.

REVISIONS SCHEDULE	
PROPOSAL	March 2nd, 2022
REVISIONS	Mar. 25th, 2022
PERMIT SET	April 18th, 2022

CUSTOM HOME FOR:
LITTLE RESIDENCE
1542 Little Rd, Lake City, FL 32024

RIDGEPOINT DESIGN
566 SW ARLINGTON BLVD, STE 101, LAKE CITY, FL 32025
P: 386-288-1188
E: RIDGEPOINTDESIGN@GMAIL.COM

 SHEET NUMBER
A.3
OF 8 SHEETS

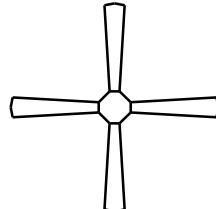ELECTRICAL LEGEND		
ELECTRICAL	COUNT	SYMBOL
CEILING FAN	7	
CAN LIGHT 6inch	44	
CHANDELIER	2	
LED CEILING LIGHT 1x4	4	
PENDANT LIGHT	2	
MOTION SECURITY LIGHT	5	
ELECTRIC PANEL	1	
AC DISCONNECT	2	
CABLE TV OUTLET	7	
CAT6 OUTLET	3	
EXHAUST FAN	4	
FLOOR OULET DUPLEX	1	
OUTLET	31	
OUTLET 220v	3	
OUTLET GFI	18	
OUTLET WP	7	
SMOKE DETECTOR	6	
STANDARD LIGHT	1	
SWITCH	30	
SWITCH 3 WAY	21	
SWITCH 4 WAY	4	
VANITY BAR LIGHT - LARGE	2	
VANITY BAR LIGHT - SMALL	1	
VANITY WALL SCONCE	4	

ELECTRICAL PLAN NOTES:

INSTALLATION SHALL BE PER LATEST NAT'L ELECTRIC CODE.

WIRE ALL APPLIANCES, HVAC UNITS AND OTHER EQUIPMENT PER MANUF. SPECIFICATIONS

CONSULT WITH THE OWNER FOR THE NUMBER OF SEPERATE TELEPHONE LINES TO BE INSTALLED

ALL SMOKE DETECTORS SHALL BE 120v W/ BATTERY BACKUP OF THE PHOTOELECTRIC TYPE, AND SHALL BE INTERLOCKED TOGETHER. INSTALL INSIDE AND NEAR ALL BEDROOMS


TELEPHONE, TELEVISION AND OTHER LOW VOLTAGE DEVICES OR OUTLETS SHALL BE AS PER THE OWNER'S DIRECTIONS, & IN ACCORDANCE W/ APPLICABLE SECTIONS OF NEC-LATEST EDITION.

ALL RECEPTALS, NOT OTHERWISE NOTED, SHALL BE ARC FAULT INTERRUPTER TYPE, EXCEPT DEDICATED OUTLETS

ALL RECEPTALS IN WET AREAS SHALL BE GROUND FAULT INTERRUPTER TYPE (GFI)

ALL EXTERIOR RECEPTALS SHALL BE WEATHERPROOF GROUD FAULT INTERRUPTER TYPE (WP/GFI)


NOTE:
ELECTRICAL CONTR SHALL PREPARE "AS-BUILT" SHOP DWGS INDICATING ALL ELECTRICAL WORK, INCLUDING ANY CHANGES TO THE ELEC. PLAN, ADD'NS TO THE ELEC. PLAN, RISER DIAGRAM, AS-BUILT PANEL SCHEDULE W/ ALL CKTS IDENTIFIED W/ CKT N°. DESCRIPTION & BRKR. SERVICE ENT. & ALL UNDERGROUND WIRE LOCATIONS/ROUTING / DEPTH. RISER DIA. SHALL INCLUDE WIRE SIZES/TYPE & EQUIPMENT TYPE W/ RATINGS & LOADS.
CONTRACTOR SHALL PROVIDE 1 COPY OF AS-BUILT DWGS TO OWNER & 1 COPY TO THE PERMIT ISSUING AUTHORITY

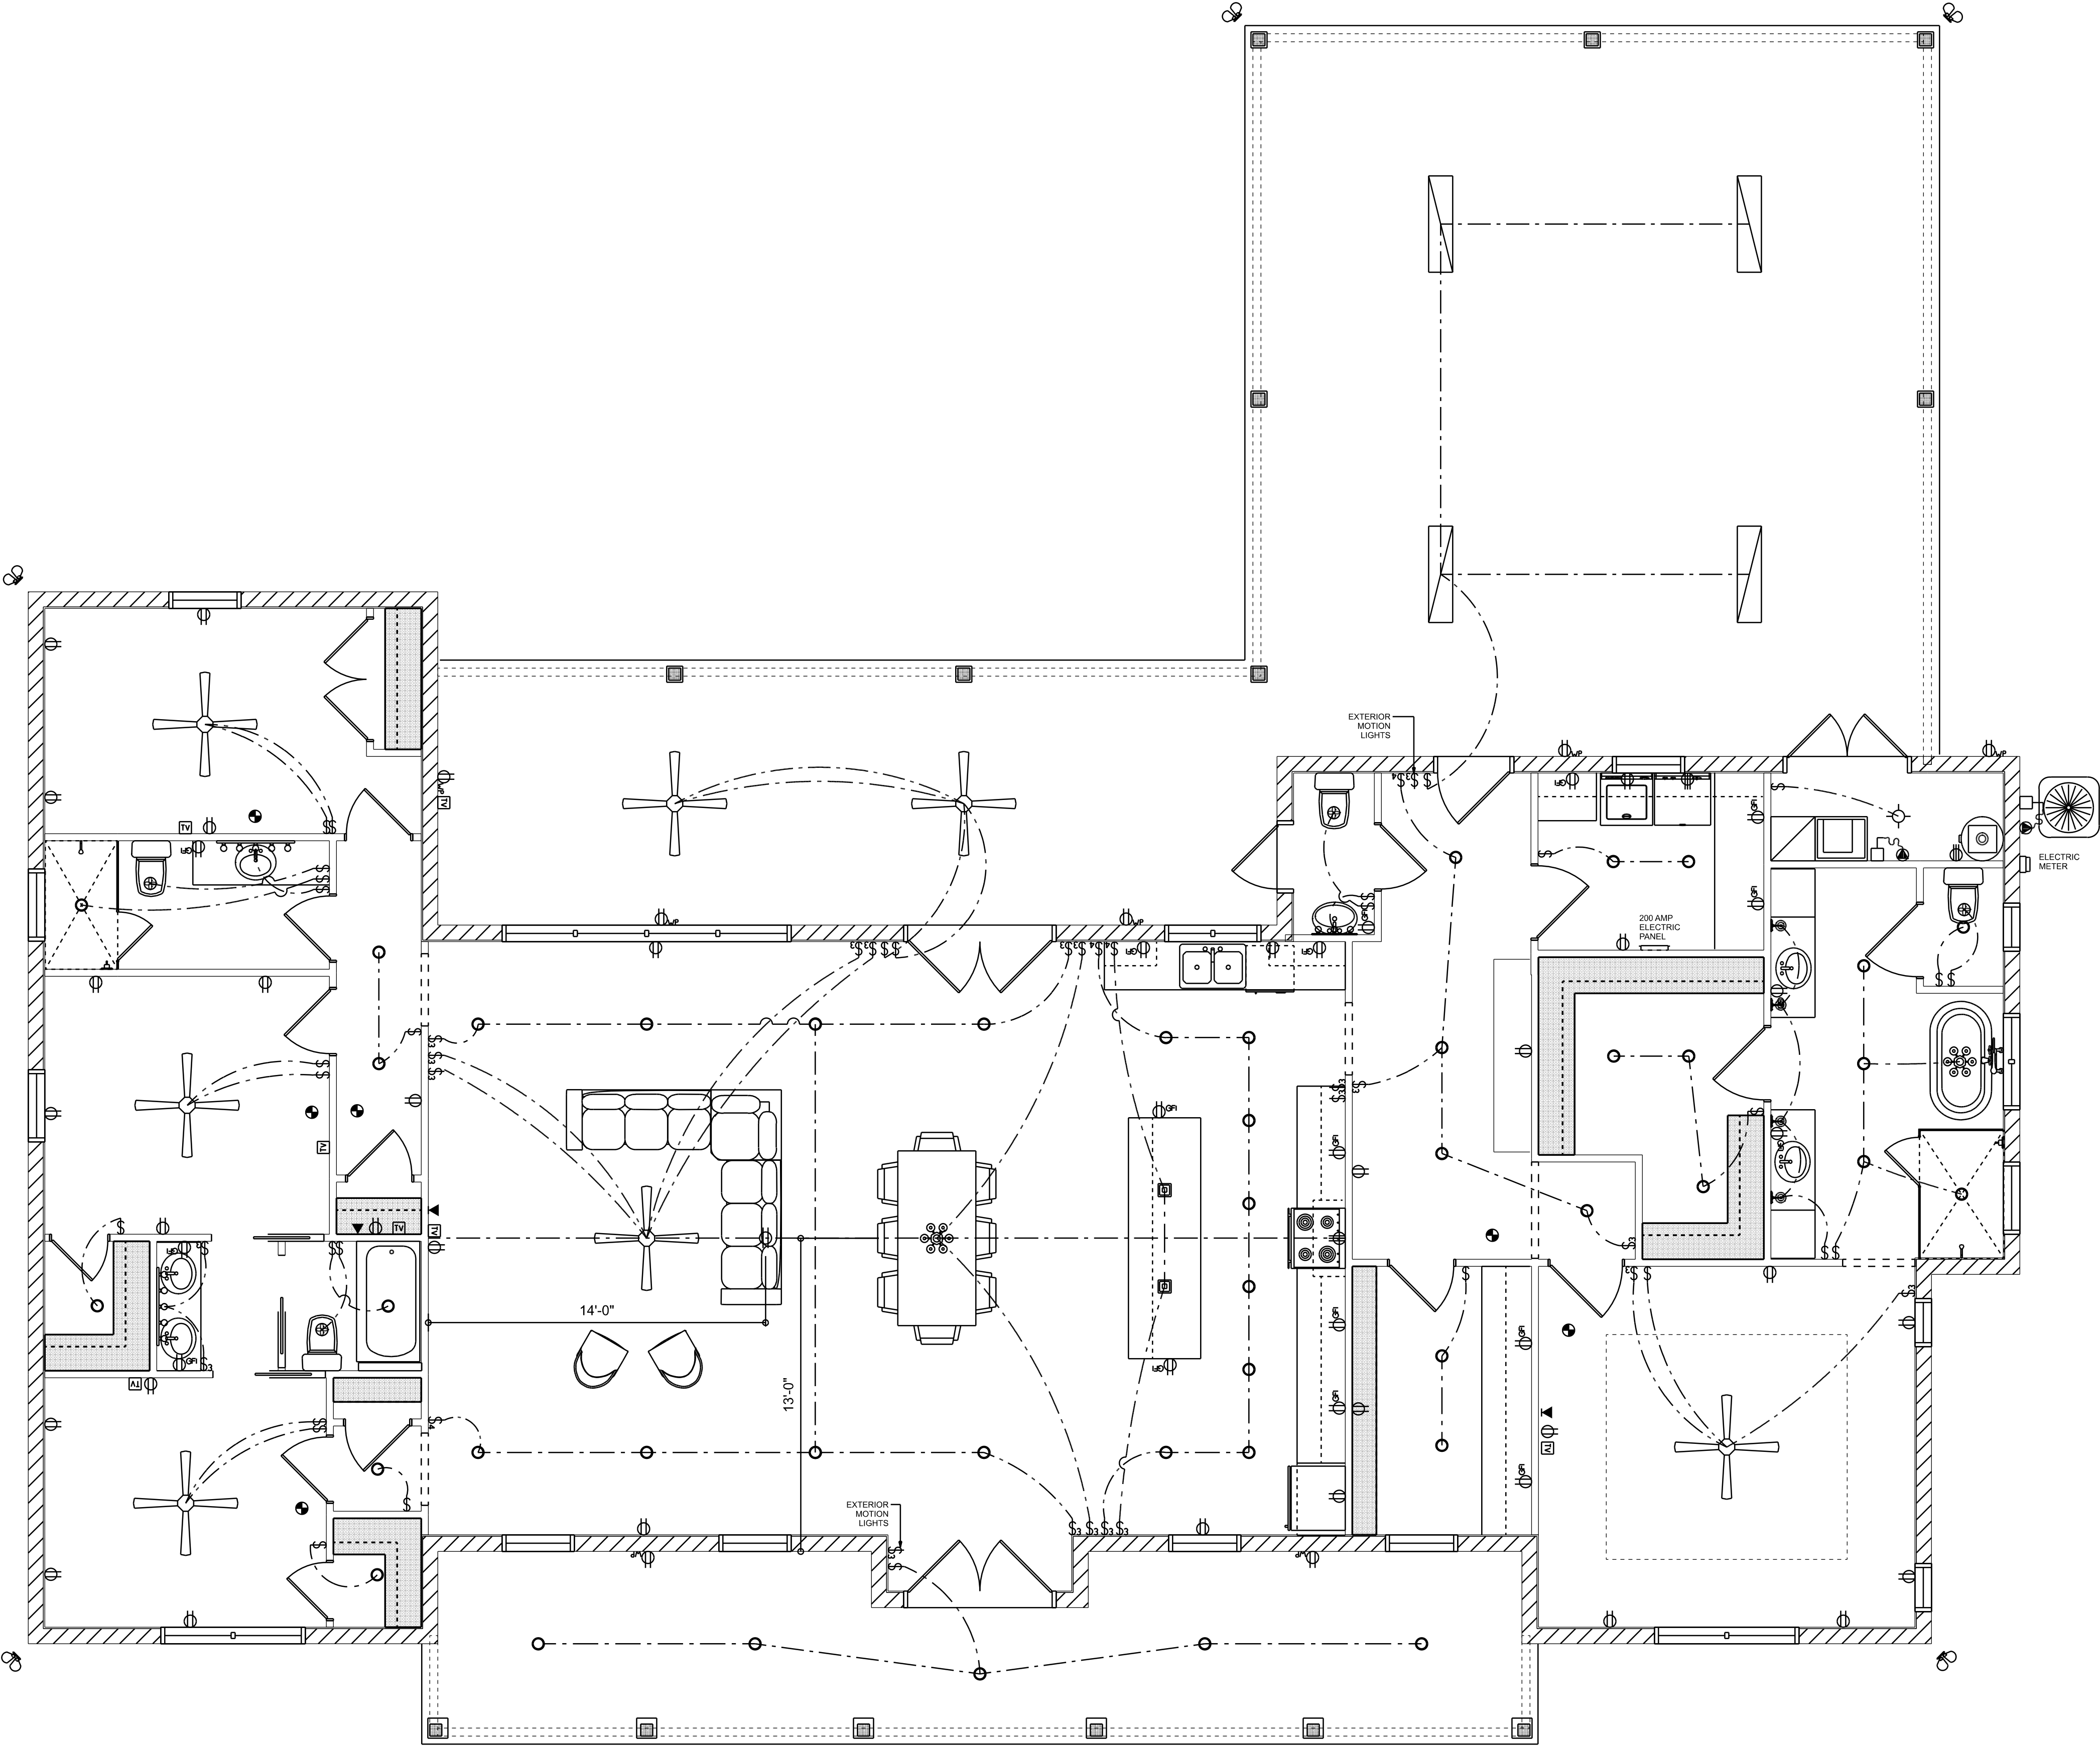

ELECTRICAL PLAN
SCALE: 1/4" = 1'-0"

REVISIONS SCHEDULE	
PROPOSAL	March 2nd, 2022
REVISIONS	Mar. 25th, 2022
PERMIT SET	April 18th, 2022

CUSTOM HOME FOR:
LITTLE RESIDENCE
1542 Little Rd, Lake City, FL 32024

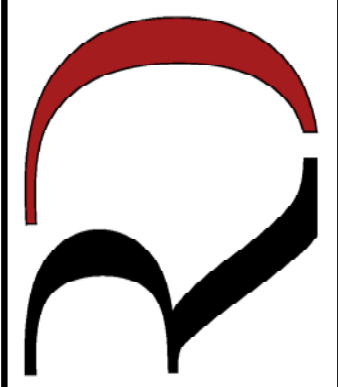**RIDGEPOINT
DESIGN**

566 SW ARLINGTON BLVD. STE 101, LAKE CITY, FL 32025
P: 386-288-1188
E: RIDGEPOINTDESIGN@GMAIL.COM