



FRONT ELEVATION
SCALE: 1/4" = 1'-0"



REAR ELEVATION
SCALE: 1/4" = 1'-0"


REVISIONS SCHEDULE	
June 14th, 2024	Proposal Drawing
Dec. 17th, 2024	Revisions


CONSTRUCTION LLC
(351) 667-0084
818 W DUVAL ST, LAKE CITY, FL 32055

CUSTOM HOME FOR:
RAYMONT RESIDENCE
COLUMBIA COUNTY, FLORIDA


**RIDGEPOINT
DESIGN**
566 SW ARLINGTON BLVD, STE 101, LAKE CITY, FL 32025
P: 386-288-1188
E: RIDGEPOINTDESIGN@GMAIL.COM

SHEET NUMBER
A.1
OF 4 SHEETS

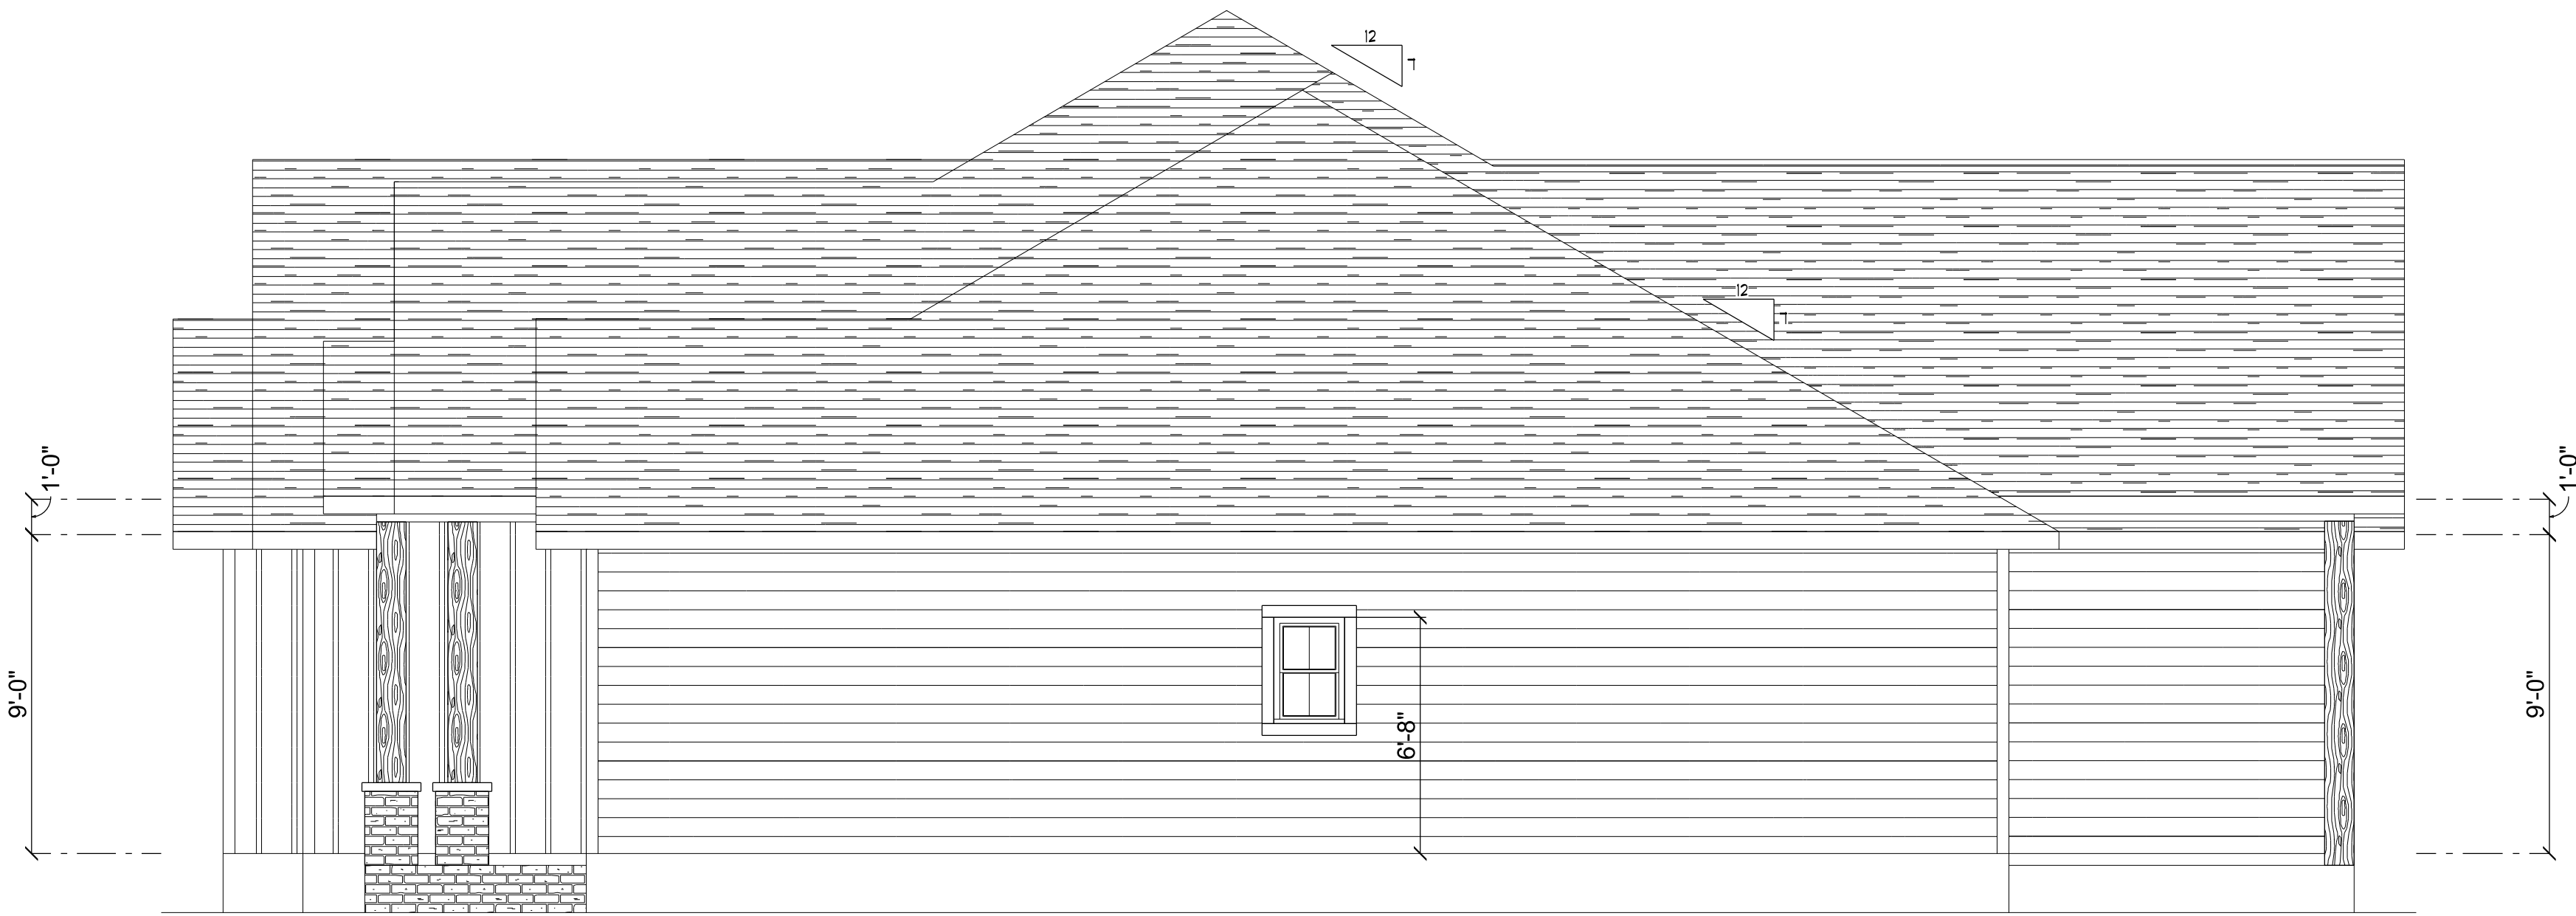

RIGHT ELEVATION
SCALE: 1/4" = 1'-0"



LEFT ELEVATION
SCALE: 1/4" = 1'-0"

REVISIONS SCHEDULE	
June 14th, 2024	Proposal Drawing
Dec. 17th, 2024	Revisions




CONSTRUCTION LLC
(351) 667-0084
818 W DUVAL ST, LAKE CITY, FL 32055

CUSTOM HOME FOR:
RAYMONT RESIDENCE
COLUMBIA COUNTY, FLORIDA



**RIDGEPOINT
DESIGN**
566 SW ARLINGTON BLVD, STE 101, LAKE CITY, FL 32025
P: 386-288-1188
E: RIDGEPOINTDESIGN@GMAIL.COM

SHEET NUMBER
A.2
OF 4 SHEETS

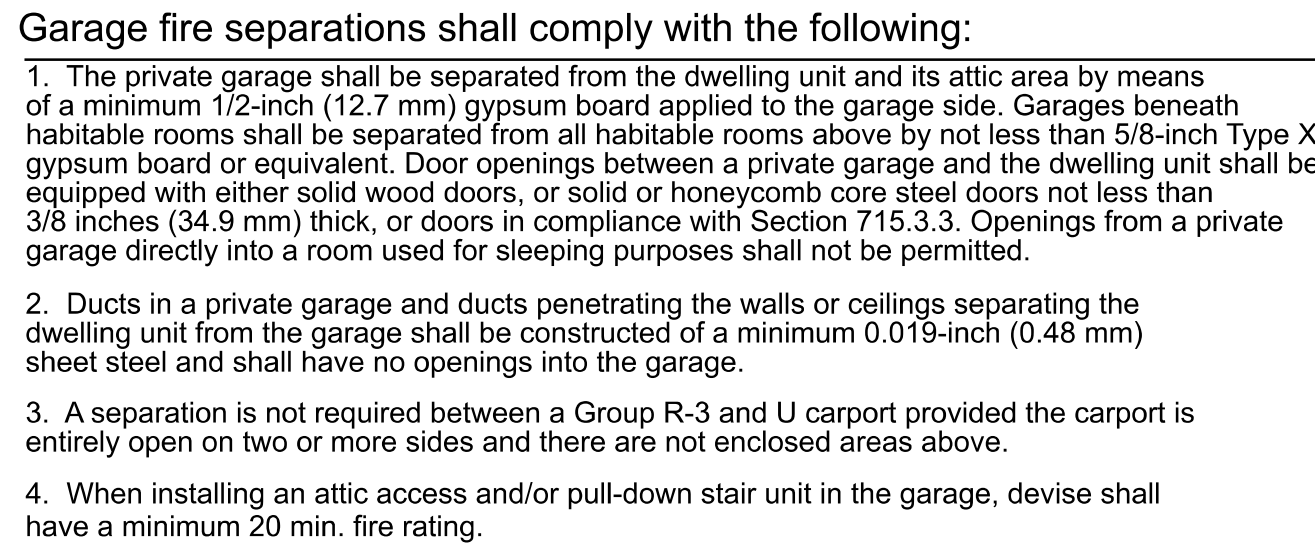

A R E A		S U M M A R Y	
LIVING		2,370	S.F.
ENTRY PORCH		196	S.F.
REAR PORCH		387	S.F.
GARAGE		689	S.F.
TOTAL AREA		3,642	S.F.



REVISIONS SCHEDULE	
June 14th, 2024	Proposal Drawing
Dec. 17th, 2024	Revisions



CUSTOM HOME FOR:
RAYMONT RESIDENCE
COLUMBIA COUNTY, FLORIDA



 SHEET NUMBER
A.3
OF 4 SHEETS

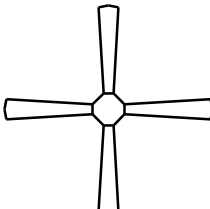ELECTRICAL LEGEND		
ELECTRICAL	COUNT	SYMBOL
CEILING FAN	5	
CAN LIGHT 6inch	50	
CHANDELIER	3	
LED CEILING LIGHT 1x4	2	
PENDANT LIGHT	3	
EXTERIOR SCONCE	2	
MOTION SECURITY LIGHT	5	
AC DISCONNECT	2	
CABLE TV OUTLET	6	
CARBON DETECTOR	2	
EXHAUST FAN	2	
OUTLET	39	
OUTLET 220v	5	
OUTLET GFI	20	
OUTLET WP	5	
SMOKE DETECTOR	5	
STANDARD LIGHT	2	
SWITCH	31	
SWITCH 3 WAY	18	
VANITY BAR LIGHT - SMALL	3	

ELECTRICAL PLAN NOTES:

INSTALLATION SHALL BE PER LATEST NAT'L ELECTRIC CODE.
WIRE ALL APPLIANCES, HVAC UNITS AND OTHER EQUIPMENT
PER MANUF. SPECIFICATIONS

CONSULT WITH THE OWNER FOR THE NUMBER OF SEPERATE
TELEPHONE LINES TO BE INSTALLED

ALL SMOKE DETECTORS SHALL BE 120V W/ BATTERY
BACKUP OF THE PHOTOELECTRIC TYPE, AND SHALL
BE INTERLOCKED TOGETHER. INSTALL INSIDE AND NEAR
ALL BEDROOMS

TELEPHONE, TELEVISION AND OTHER LOW VOLTAGE
DEVICES OR OUTLETS SHALL BE AS PER THE OWNER'S
DIRECTIONS, & IN ACCORDANCE W/ APPLICABLE
SECTIONS OF NEC-LATEST EDITION.


ELECTRICAL CONTR'S SHALL PREPARE "AS-BUILT" SHOP
DWGS INDICATING ALL ELECTRICAL WORK, INCLUDING ANY
CHANGES TO THE ELEC. PLAN, ADD'NS TO THE ELEC. PLAN,
RISER DIAGRAM, AS-BUILT PANEL SCHEDULE W/ ALL CKTS
IDENTIFIED W/ CKT N°, DESCRIPTION & BRKR, SERVICE ENT.
& ALL UNDERGROUND WIRE

LOCATIONS/ROUTING / DEPTH, RISER DIA. SHALL INCLUDE
WIRE SIZES/TYPE & EQUIPMENT TYPE W/ RATINGS & LOADS.

CONTRACTOR SHALL PROVIDE 1 COPY OF AS-BUILT DWGS
TO OWNER & 1 COPY TO THE PERMIT ISSUING AUTHORITY
ALL RECEPTICALS, NOT OTHERWISE NOTED, SHALL BE ARC
FAULT INTERRUPTER TYPE, EXCEPT DEDICATED OUTLETS

ALL RECEPTICALS IN WET AREAS SHALL BE GROUND
FAULT INTERRUPTER TYPE (GFI)

ALL EXTERIOR RECEPTICALS SHALL BE WEATHERPROOF
GROUD FAULT INTERRUPTER TYPE (WP/GFI)

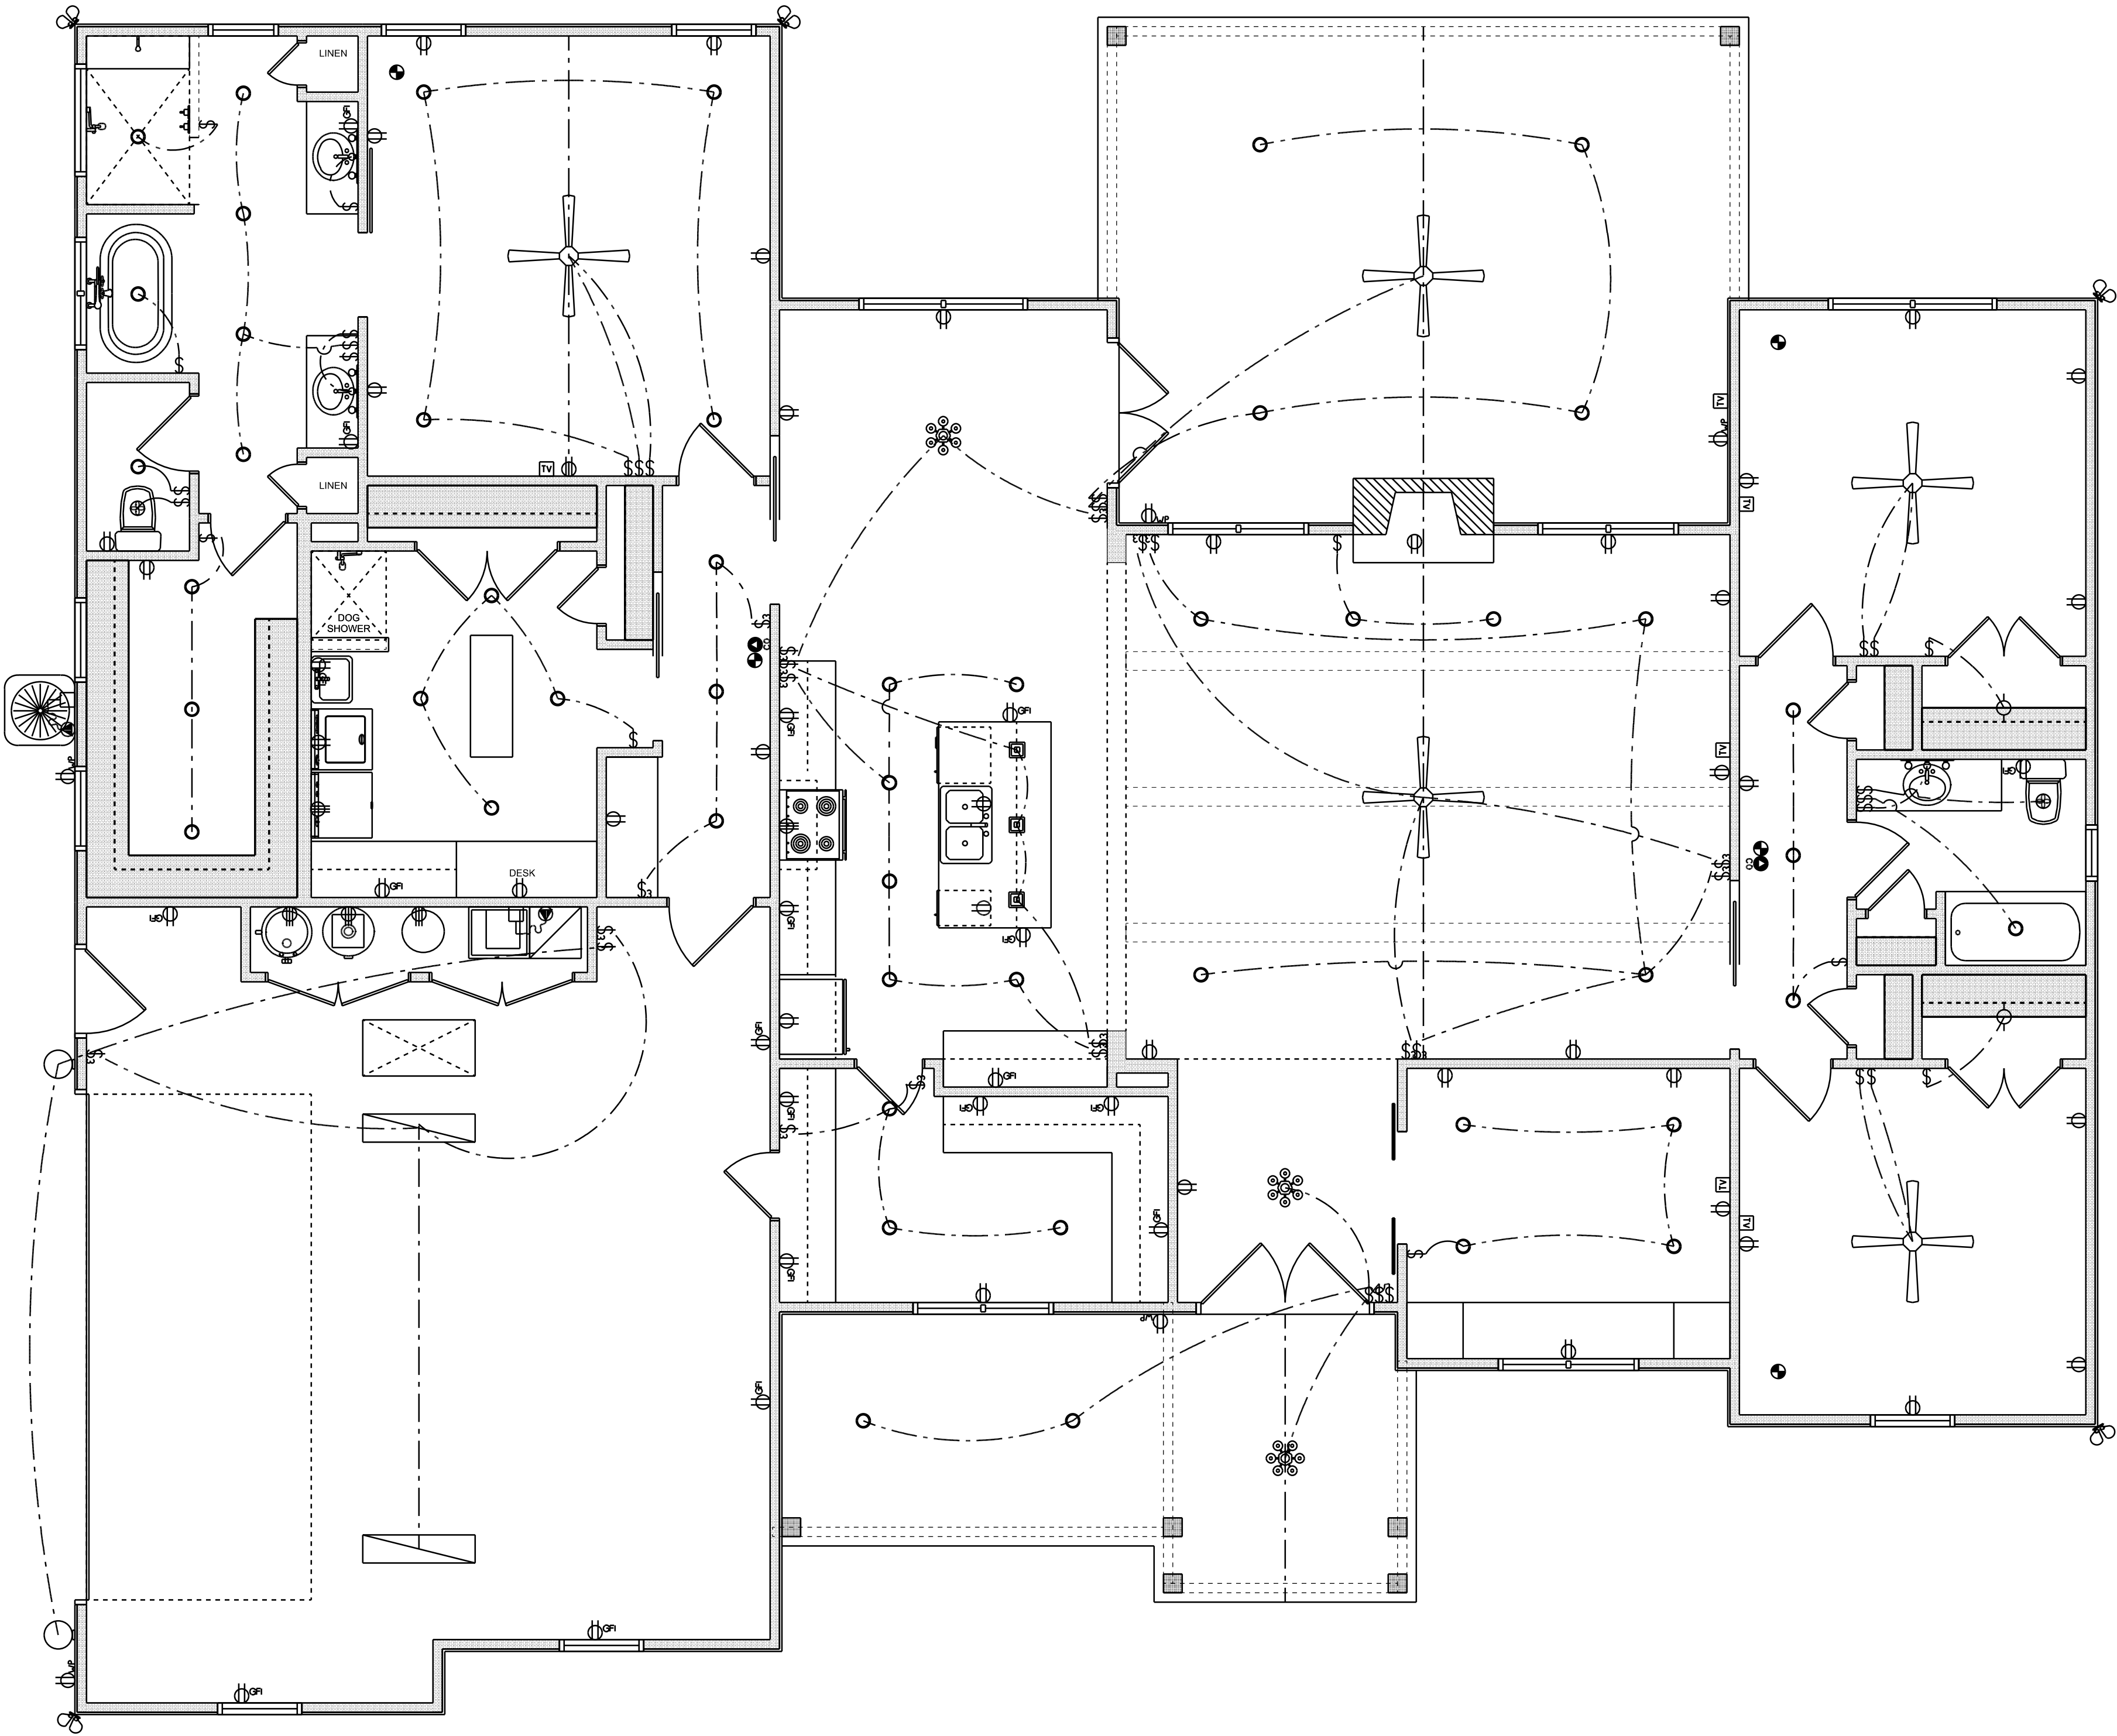

ELECTRICAL PLAN

SCALE: 1/4" = 1'-0"

REVISIONS SCHEDULE	
June 14th, 2024	Proposal Drawing
Dec. 17th, 2024	Revisions



CONSTRUCTION LLC
(351) 667-0084
818 W DUVAL ST, LAKE CITY, FL 32055

CUSTOM HOME FOR:
RAYMONT RESIDENCE
COLUMBIA COUNTY, FLORIDA



**RIDGEPOINT
DESIGN**
566 SW ARLINGTON BLVD, STE 101, LAKE CITY, FL 32055
P: 386-288-1188
E: RIDGEPOINTDESIGN@GMAIL.COM

SHEET NUMBER
A.4
OF 4 SHEETS