


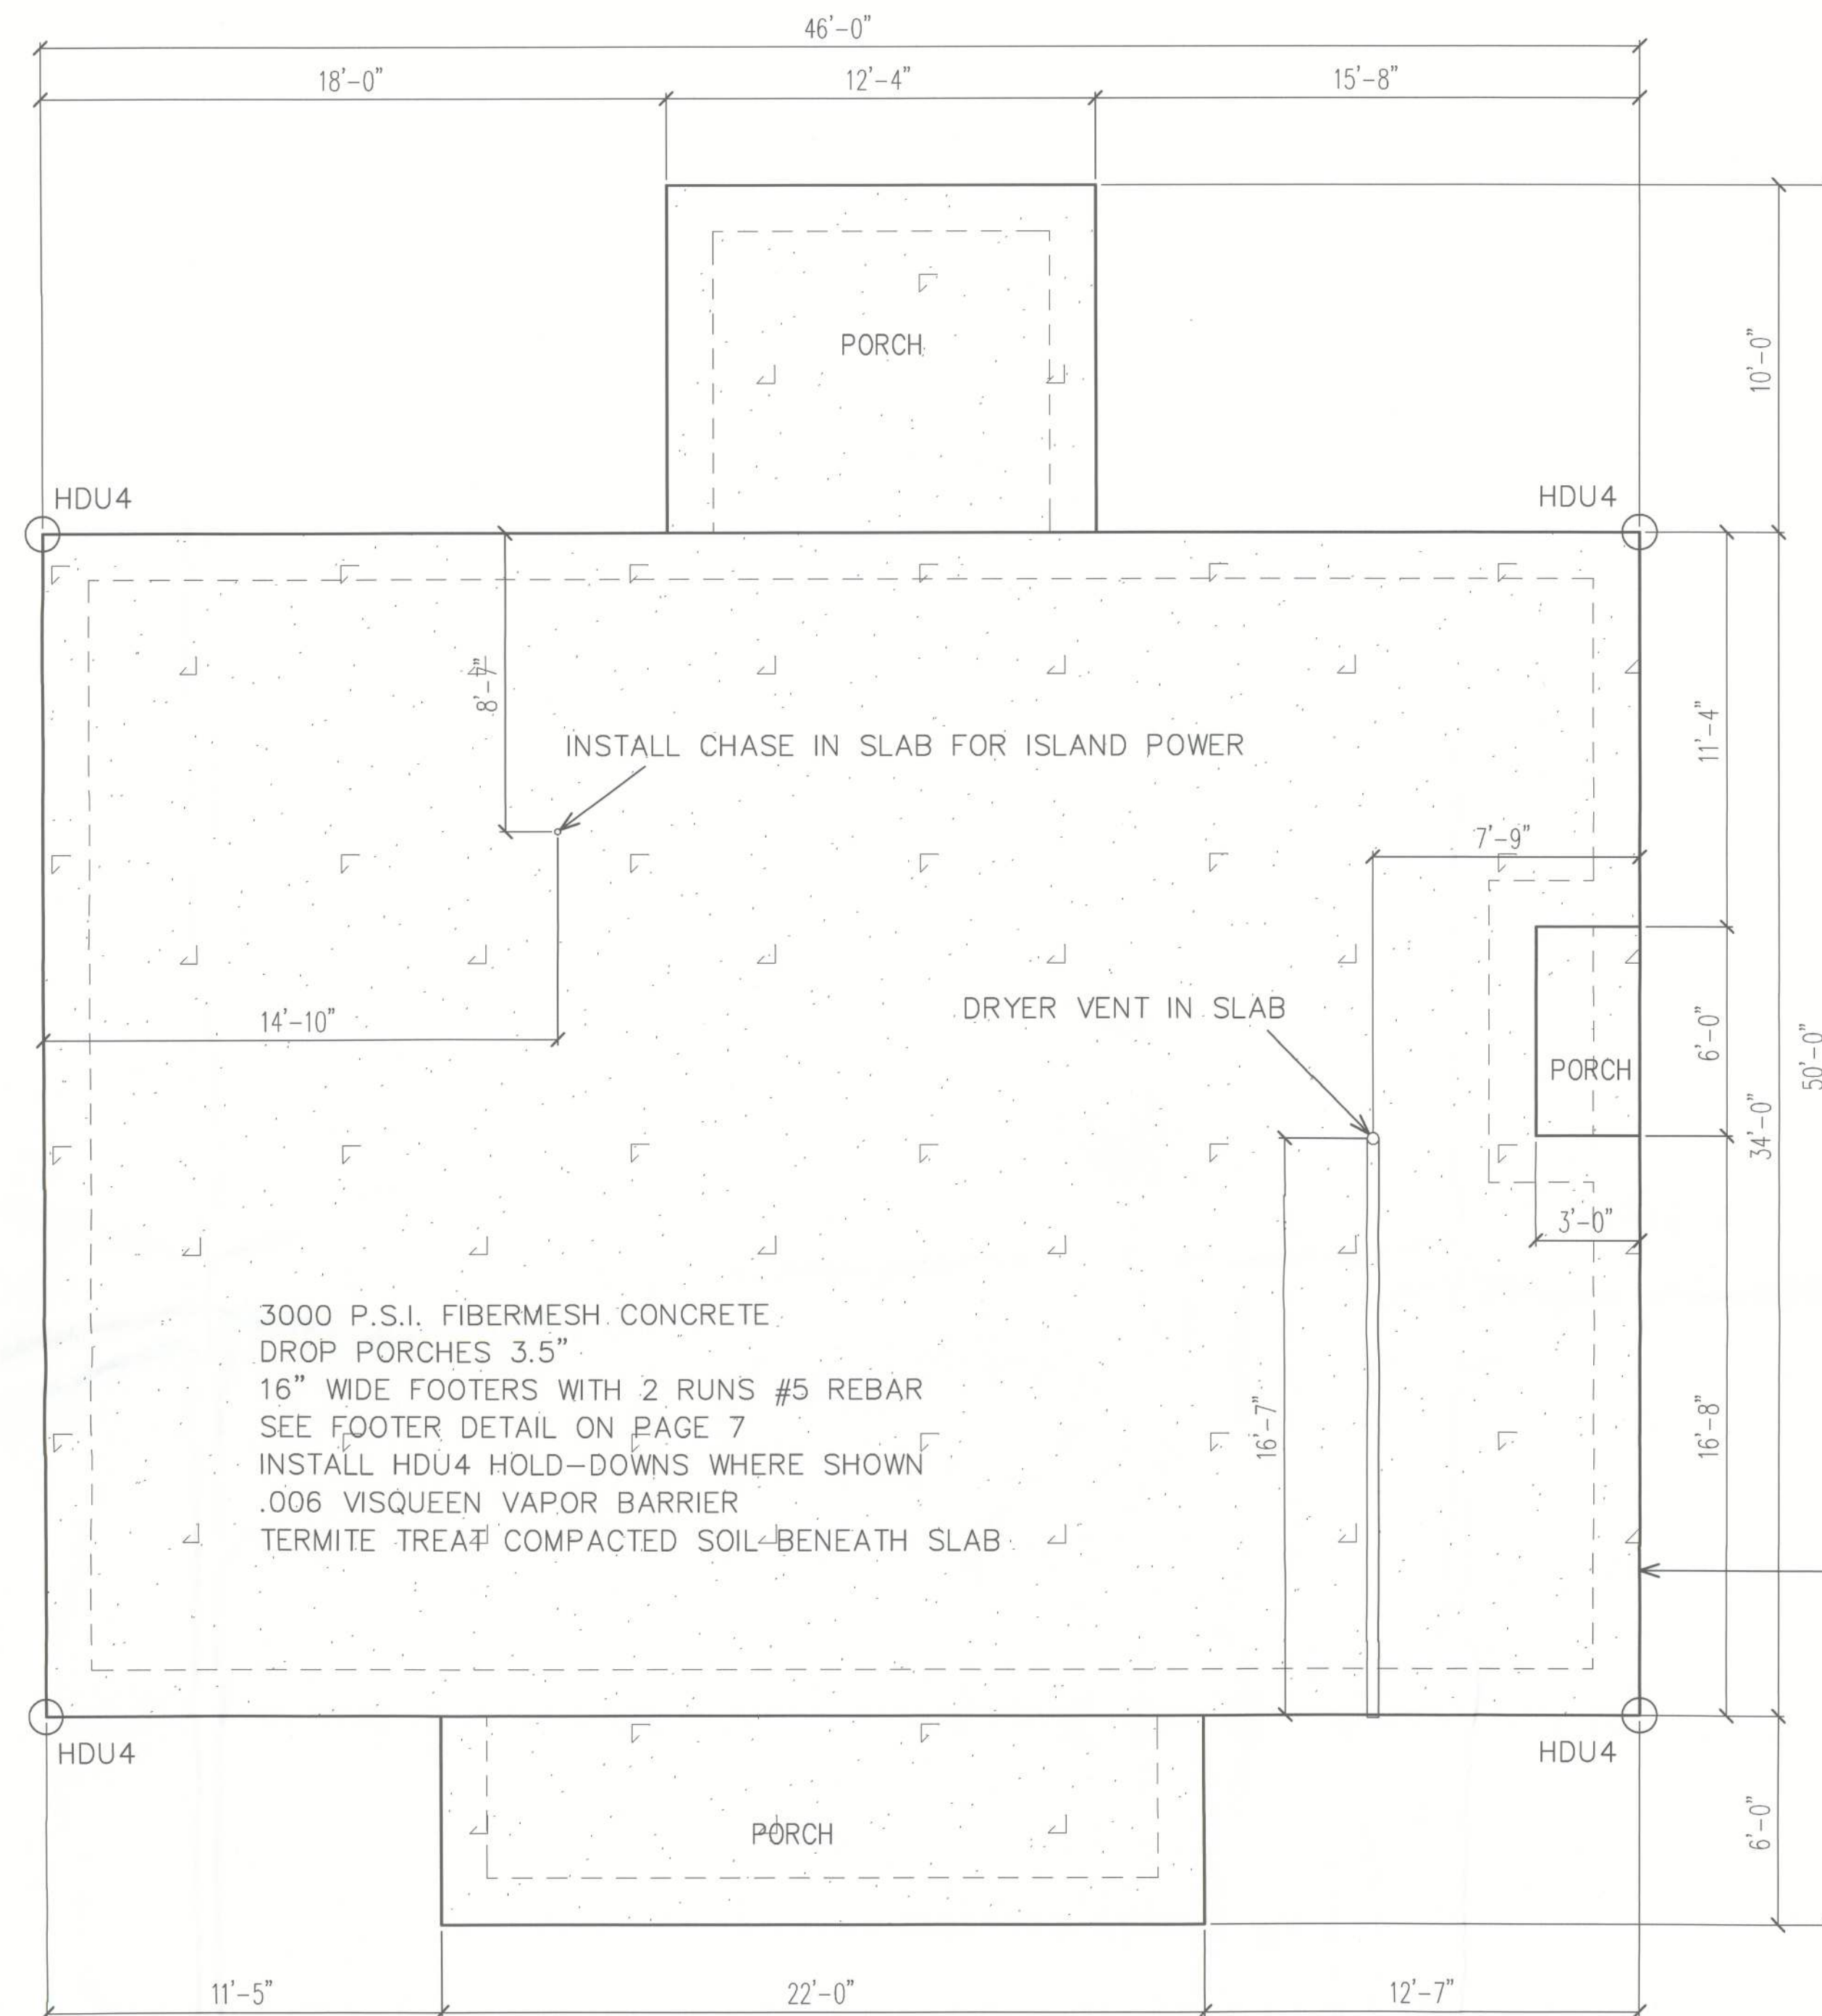

FOUNDATION PLAN

SCALE: 1/4" = 1'-0"

* OVERHEAD PEX PLUMBING *

INSTALL ENCASED GROUNDING ELECTRODE PER 250.52.3 NEC

CONCRETE CONTROL JOINTS SHALL BE LOCATED 15-20' APART. CUT JOINTS 1/4" DEEP INTO SLAB.
METAL KEYWAY SCREED STRIPS MAY BE SUBSTITUTED. JOINTS MAY BE LOCATED NEAR A WALL.

REFERENCE DETAIL "B2" ON PAGE 7 IF FOUNDATION HEIGHT ABOVE GRADE EXCEEDS 16"

These plans comply with 2020 Florida Building Code, 120 mph wind speed (3 sec. gust)

John K. Gentry
5/16/23

John K. Gentry, P.E. #16990
P.O. Box 1034
Perry, FL 32348
(850) 672-0145

DATE: 05-01-2023	
	PAGE 2 OF 8

SQUARE FOOTAGE	
HEATED	1564 S.F.
PORCH	255 S.F.
TOTAL	1819 S.F.

Malak Ali	760 SW Jafus Ave. Lake City, Florida
-----------	--------------------------------------

