


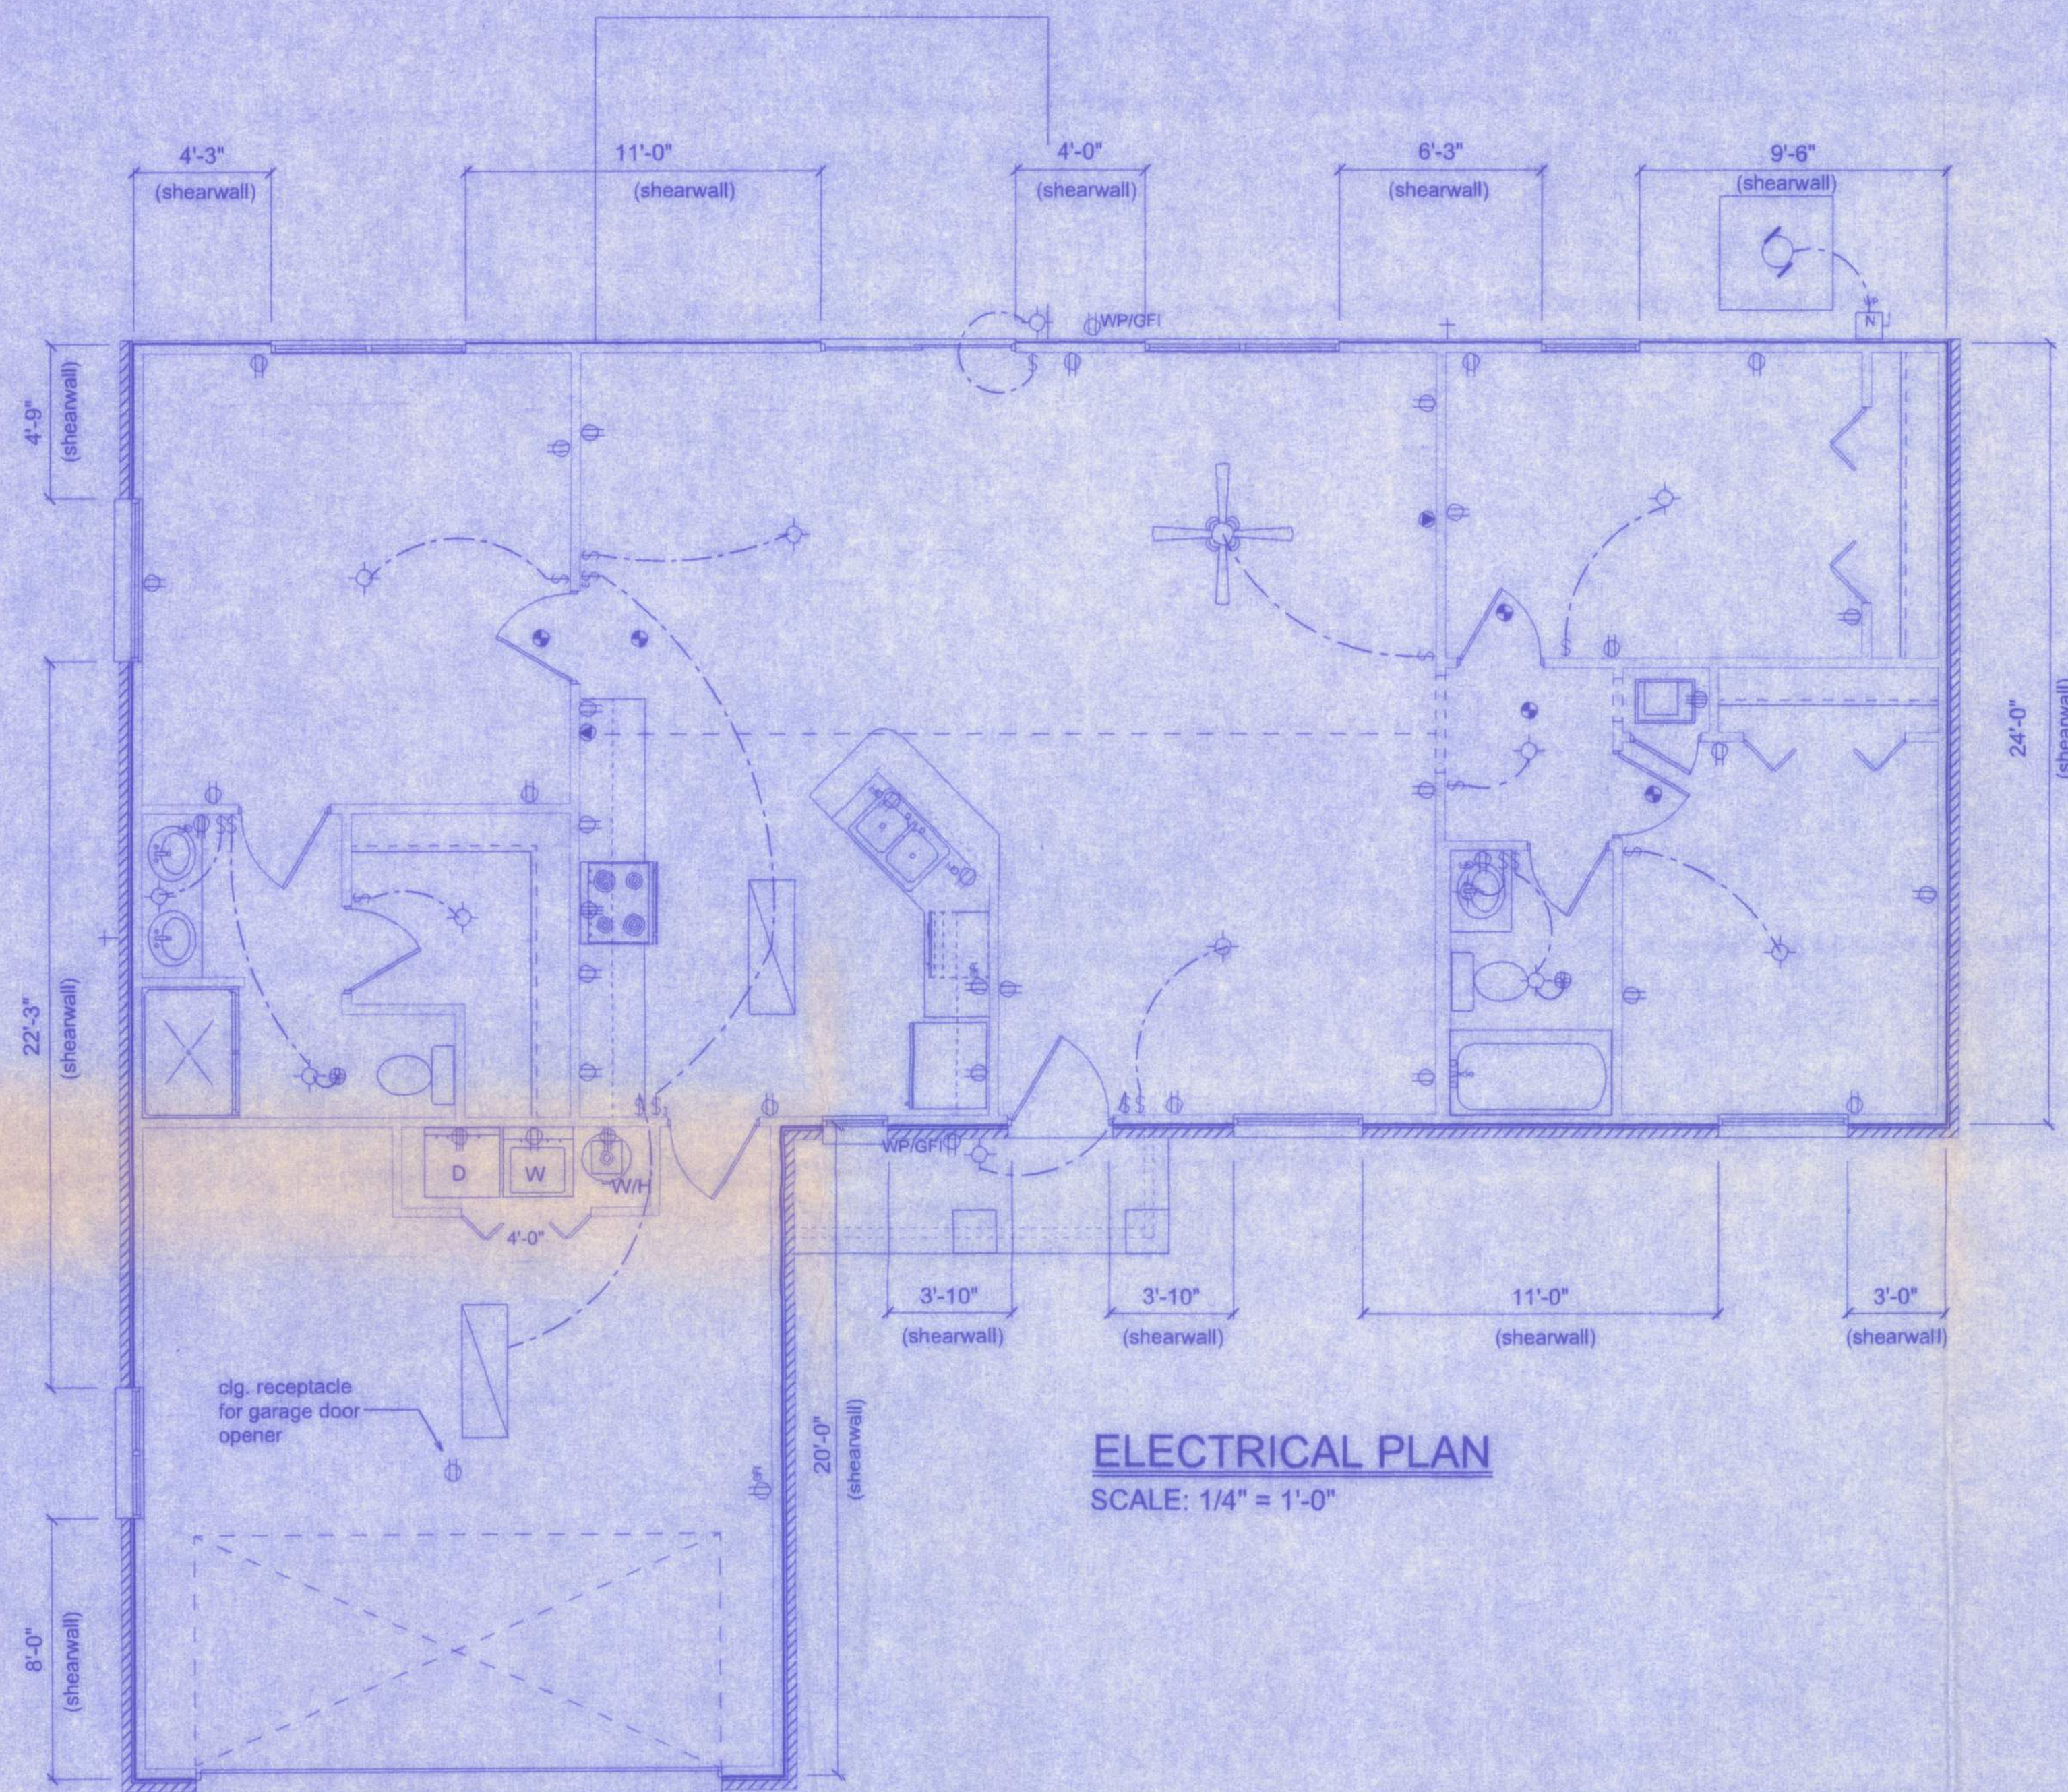


ELECTRICAL PLAN
SCALE: 1/4" = 1'-0"

ELECTRICAL CONTRACTOR SHALL PREPARE "AS-BUILT" SHOP DRAWINGS INDICATING ALL ELECTRICAL WORK, INCLUDING ANY CHANGES TO THE ELECTRICAL PLAN, ADDITIONS TO THE ELECTRICAL PLAN, RISER DIAGRAM, AS-BUILT PANEL SCHEDULE W/ ALL CIRCUITS IDENTIFIED W/ CIRCUIT NUMBER, DESCRIPTION & BREAKER. SERVICE ENTRANCE & ALL UNDERGROUND WIRE LOCATIONS RISER DIAGRAM SHALL INCLUDE WIRE SIZES/TYPE AND EQUIPMENT TYPE WRATINGS & LOADS.

CONTRACTOR SHALL PROVIDE 1 COPY OF AS-BUILT DRAWINGS TO OWNER & 1 COPY TO THE PERMIT ISSUING AUTHORITY. TELEPHONE, TELEVISION AND OTHER LOW VOLTAGE DEVICES OR OUTLETS SHALL BE AS PER THE OWNER'S DIRECTIONS, & IN ACCORDANCE W/ APPLICABLE SECTIONS OF THE NEC-LATEST EDITION.


ALL SMOKE DETECTORS SHALL BE 120V W/ BATTERY BACKUP OF THE PHOTOELECTRIC TYPE, AND SHALL BE INTERLOCKED TOGETHER.

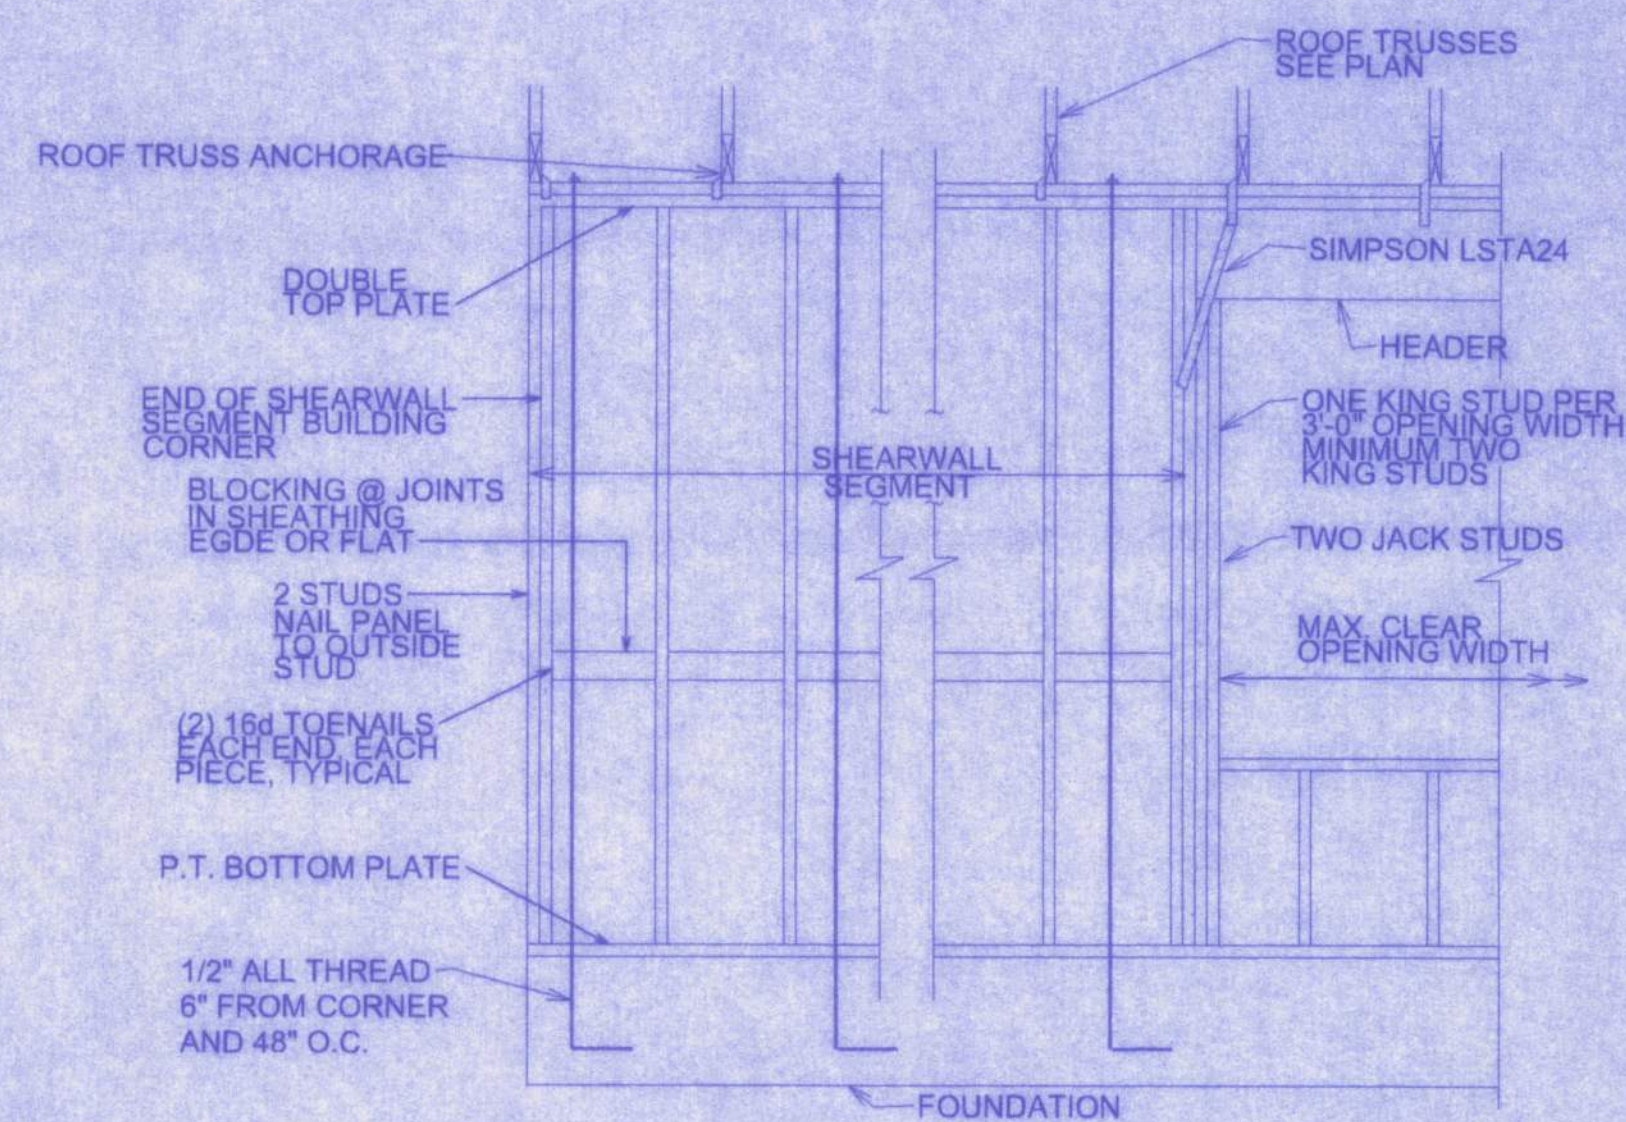


SHEARWALL DETAILS
SCALE: 1/2" = 1'-0"

- SHEARWALL NOTES:**
- ALL SHEARWALLS SHALL BE TYPE 2 SHEARWALLS AS DEFINED BY STD 10-98 SBCI 305.4.3.
 - THE WALL SHALL BE ENTIRELY SHEATHED WITH 7/16" O.S.B. INCLUDING AREAS ABOVE AND BELOW OPENINGS.
 - ALL SHEATHING SHALL BE ATTACHED TO FRAMING ALONG ALL FOUR EDGES WITH JOINTS FOR ADJACENT PANELS OCCURRING OVER COMMON FRAMING MEMBERS OR ALONG BLOCKING.
 - NAIL SPACING SHALL BE 6" O.C. EDGES AND 12" O.C. IN THE FIELD.
 - TYPE 2 SHEARWALLS ARE DESIGNED FOR THE OPENING IT CONTAINS. MAXIMUM HEIGHT OF OPENING SHALL BE 5/8 TIMES THE WALL HEIGHT. THE MINIMUM DISTANCE BETWEEN OPENINGS SHALL BE THE WALL HEIGHT/3.5 FOR 8'-0" WALLS (2'-3").

OPENING WIDTH	SILL PLATES	16d TOE NAILS EACH END
UP TO 6'-0"	(1) 2x4 OR (1) 2x6	1
> 6' TO 9'-0"	(3) 2x4 OR (1) 2x6	2
> 9' TO 12'-0"	(5) 2x4 OR (2) 2x6	3

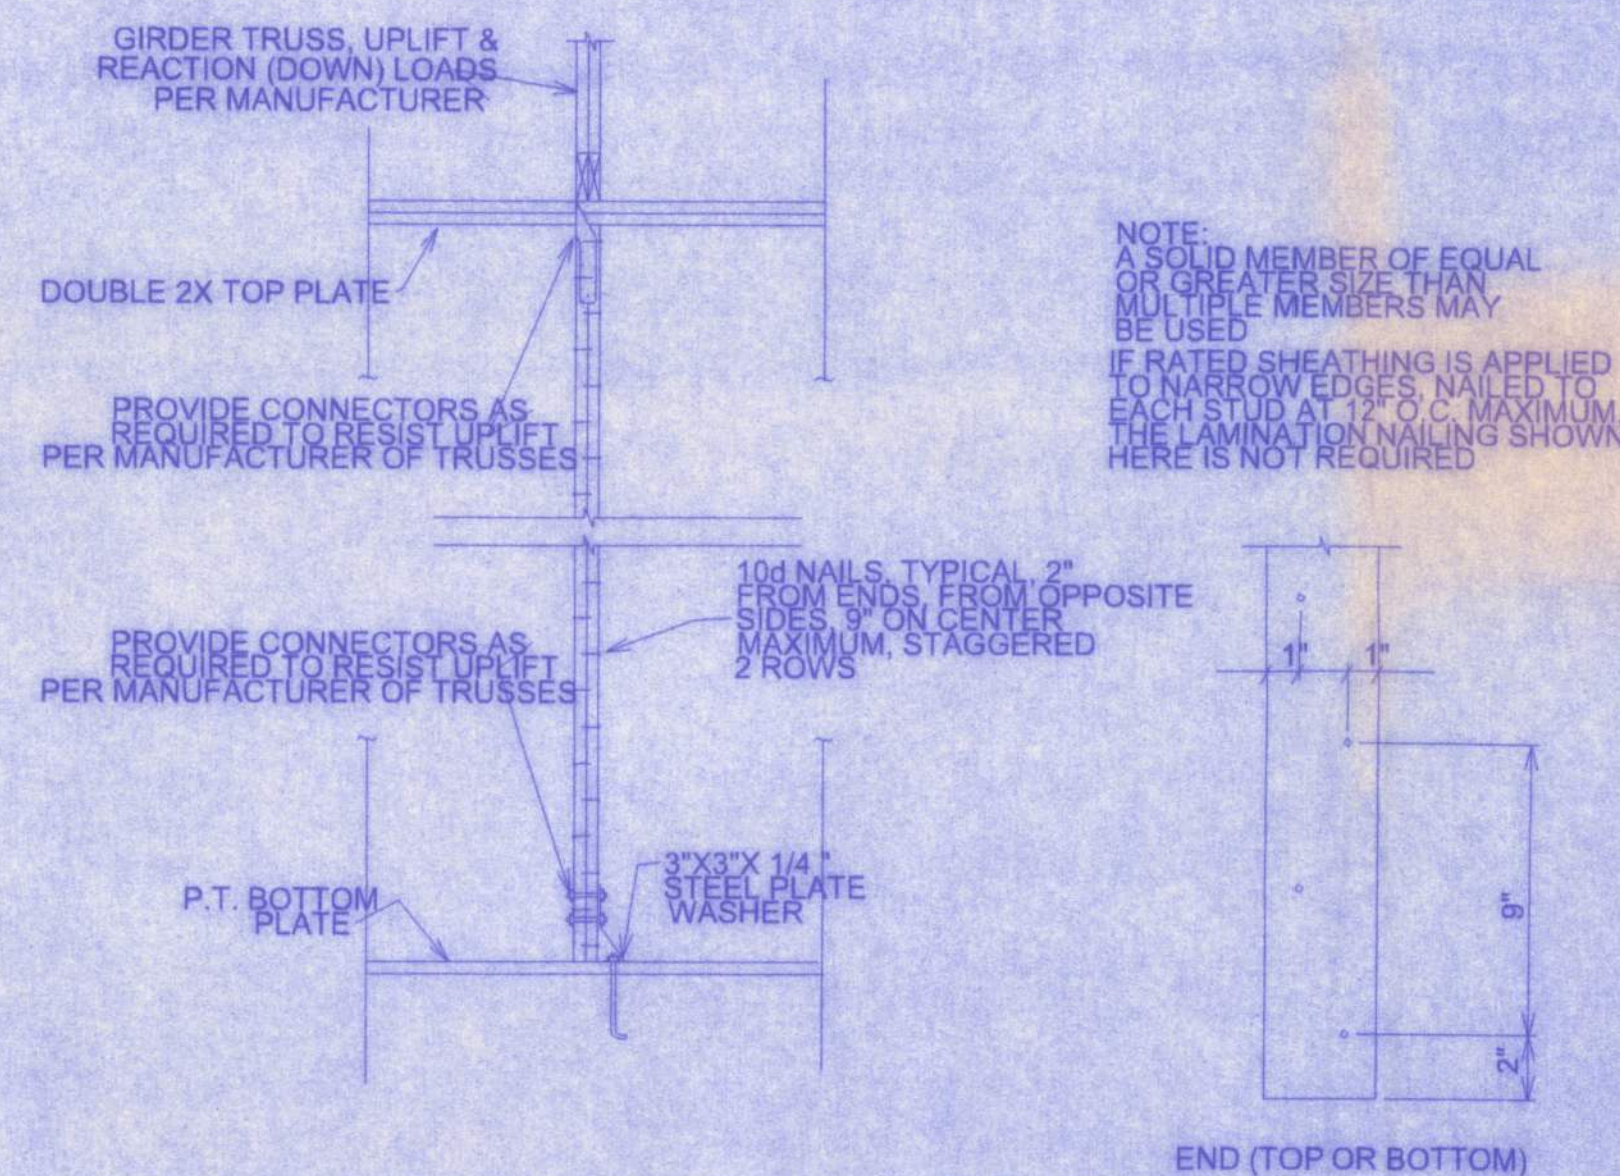


GIRDER COLUMN DETAIL
SCALE: 1/2" = 1'-0"

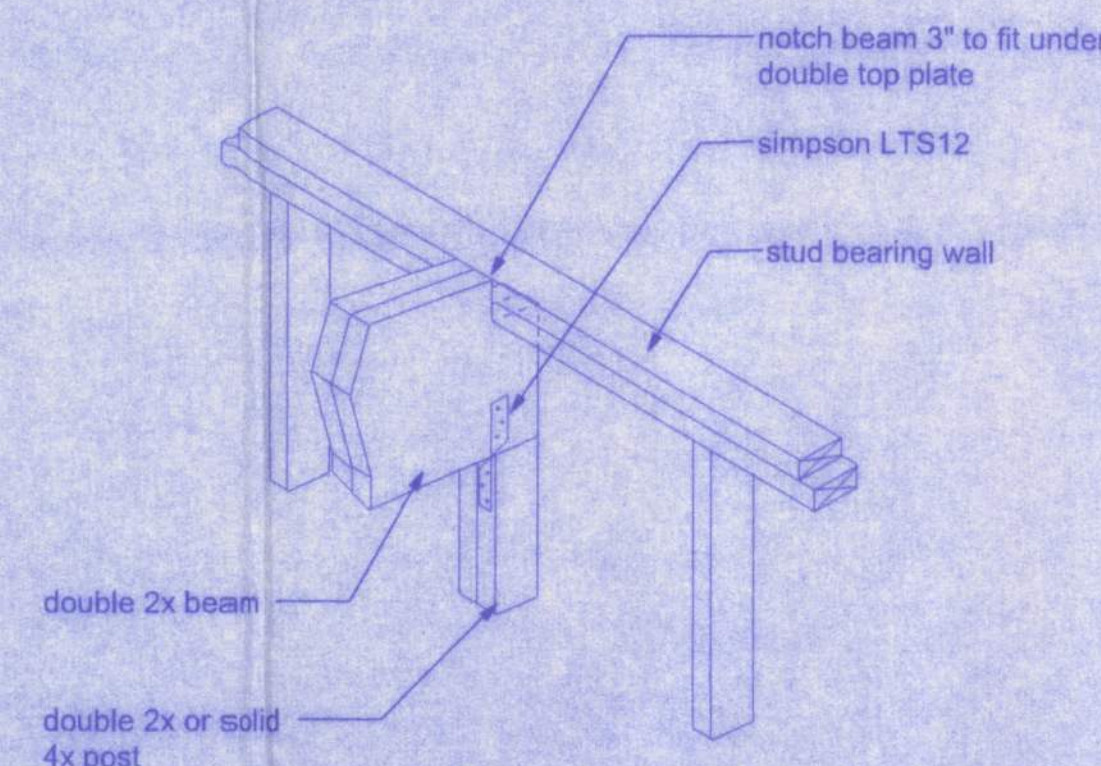

BEAM/WALL CONNECTION
NTS

Electrical	
	ceiling fan with lights
	4-bulb fluorescent lamp
	a/c motor
	non-fused disconnect
	exhaust fan
	incandescent light
	outlet
	outlet 220v
	outlet gfi
	outlet weather proof gfi
	smoke detector
	switch
	switch 3 way
	telephone jack

161 NW MADISON STREET
SUITE #102
LAKE CITY, FL 32085
(386) 558-4203

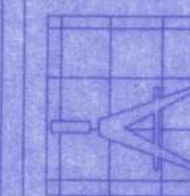

Freeman
Design Group

DATE: 3/20/05
DRAWN BY: W.H.F.

REVISIONS

SHEET: A-5

OF: 5

PROJECT NO.

SUWANNEE MODEL
CANNON CREEK PLACE LOT #44

W.H.F.
9/26/05

CERTIFICATE OF AUTHORIZATION * 000008101