


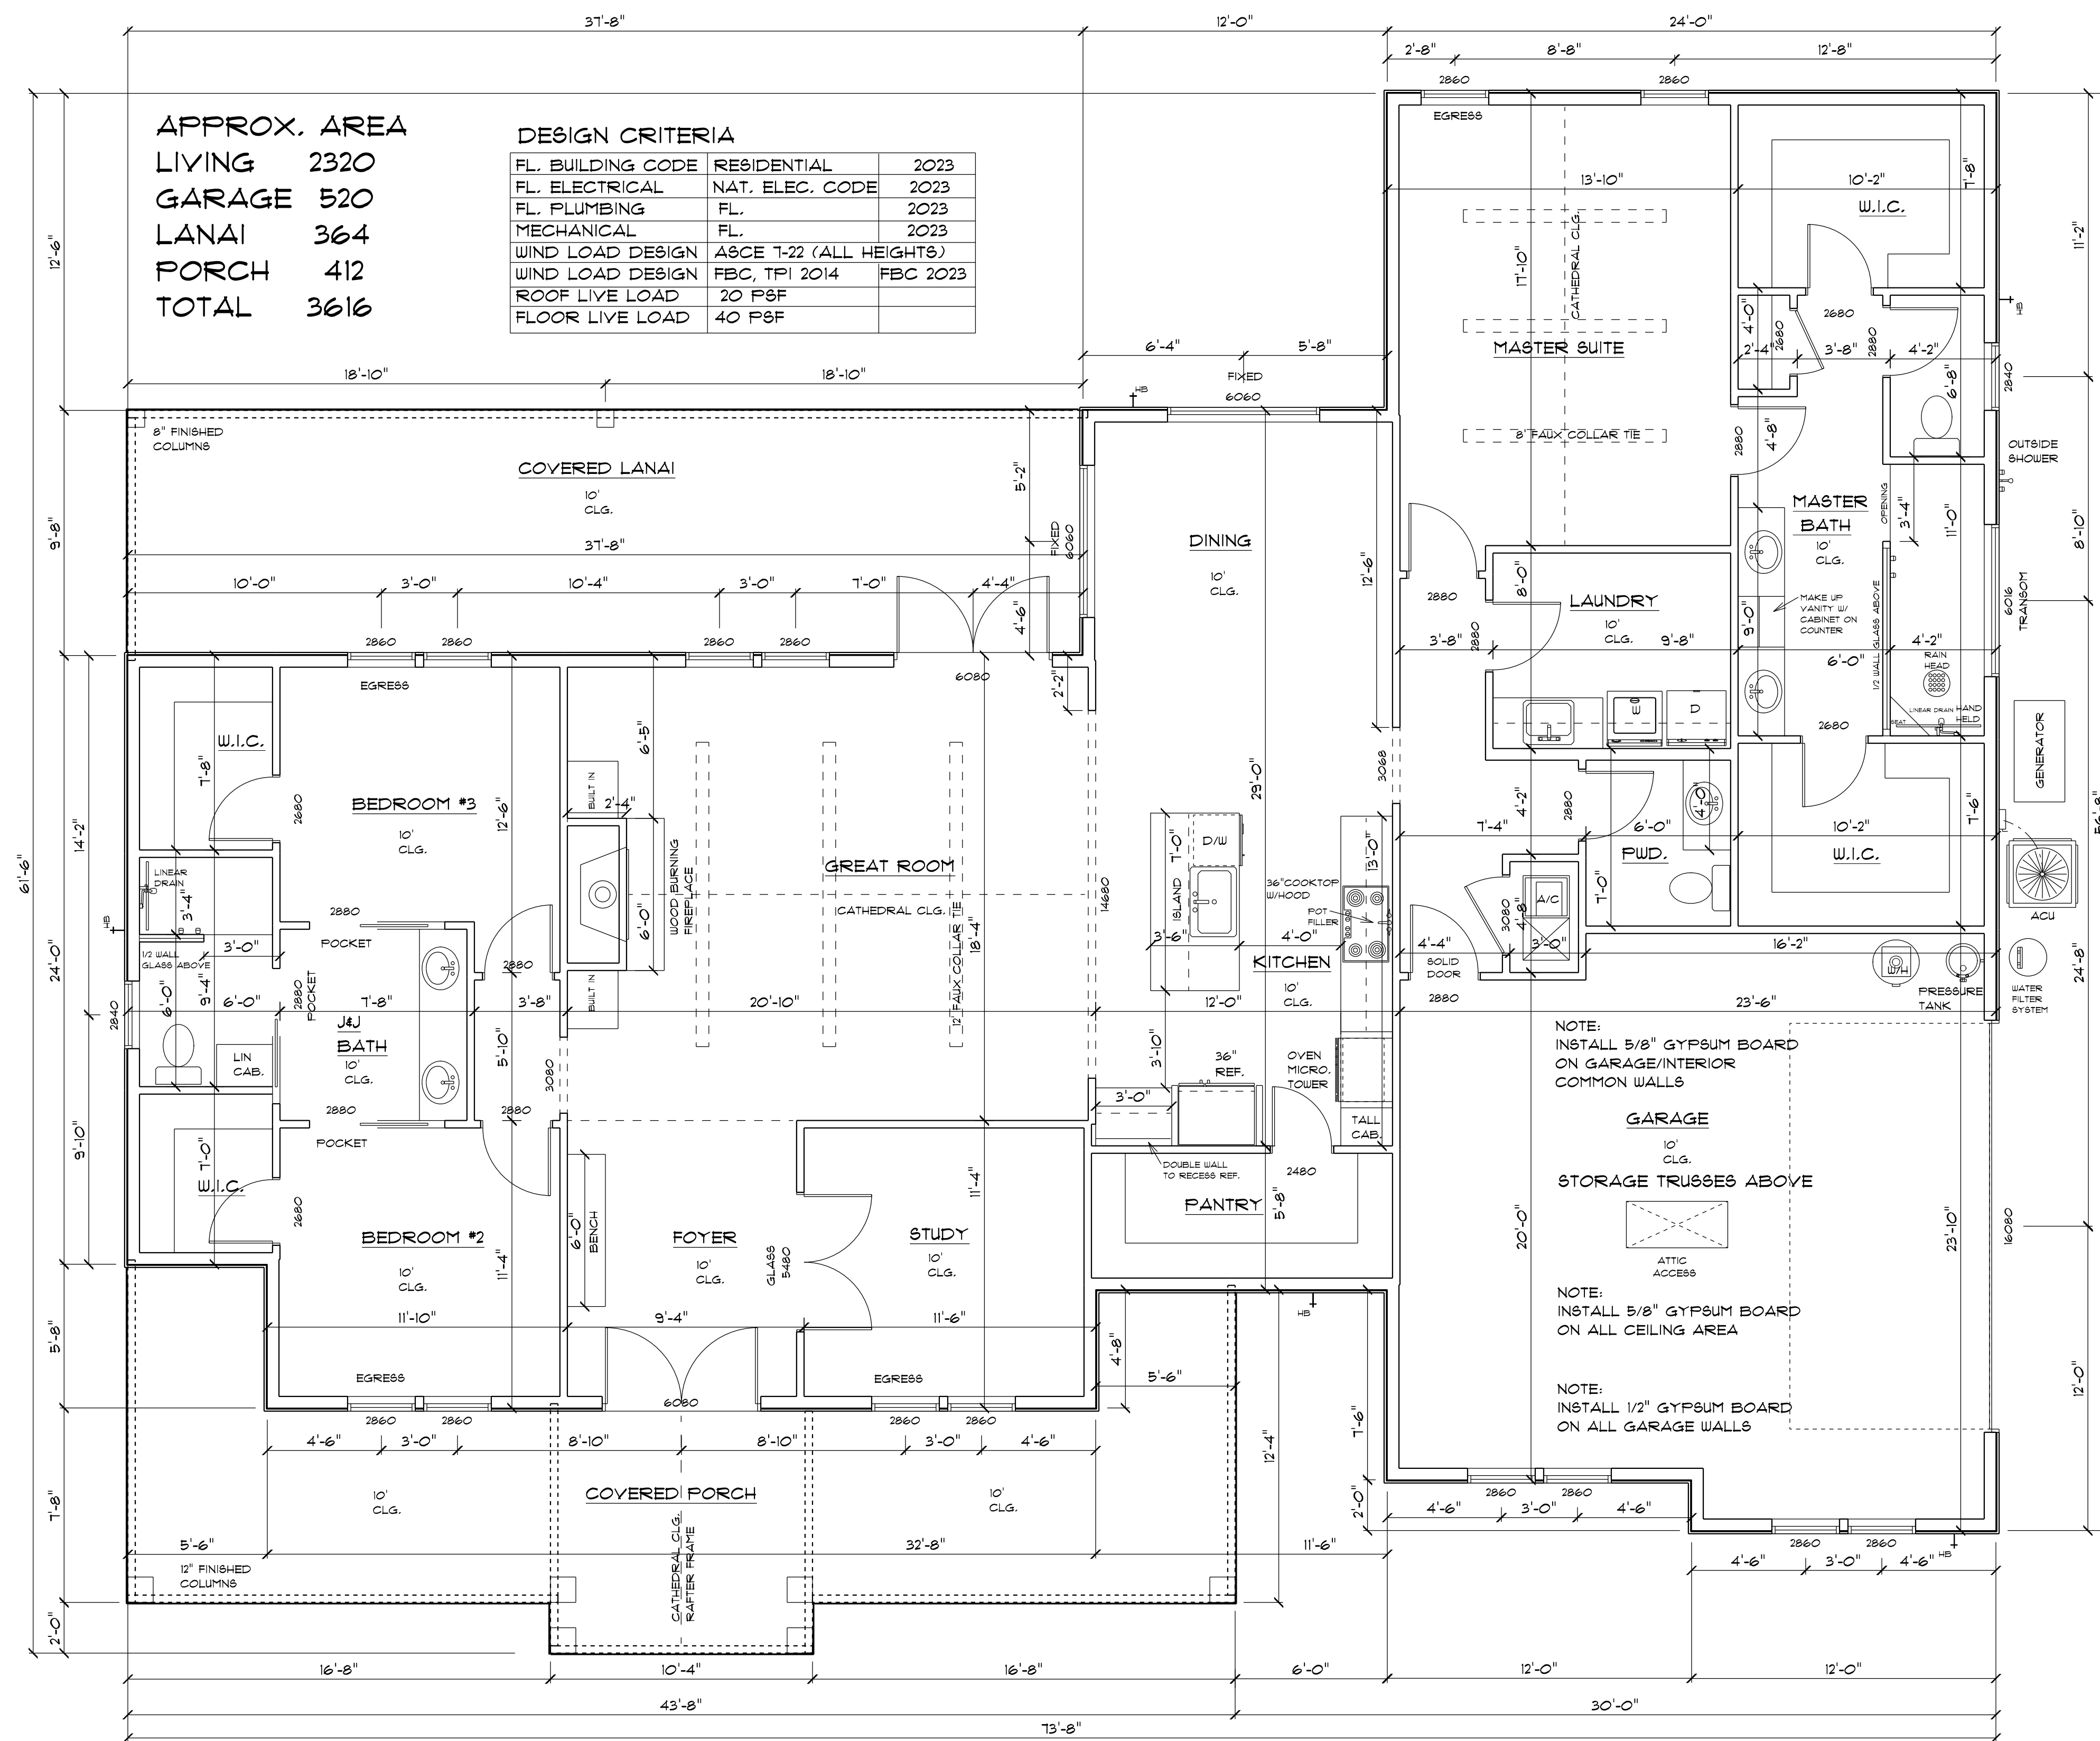


ALL WINDOWS AND DOORS TO BE INSTALLED PER MANUFACTURERS RECOMMENDATIONS AND MUST COMPLY WITH CURRENT CODES. SUBMIT ATTACHMENT WORKSHEET WITH PERMIT DOCUMENTS

MAIN FLOOR PLAN

IT IS THE OWNER AND OR THE CONTRACTORS RESPONSIBILITY TO VERIFY ALL STRUCTURAL ASPECTS OF THESE DRAWINGS. THIS INCLUDES BUT NOT LIMITED TO DIMENSIONS, WALL HEIGHTS AND MATERIAL, WINDOW SIZE AND LOCATION. ALSO ALL STATE AND LOCAL CODES MUST BE FOLLOWED

Review for Code Compliance
Universal Engineering Science
Examiner License No. PX2707 10242024

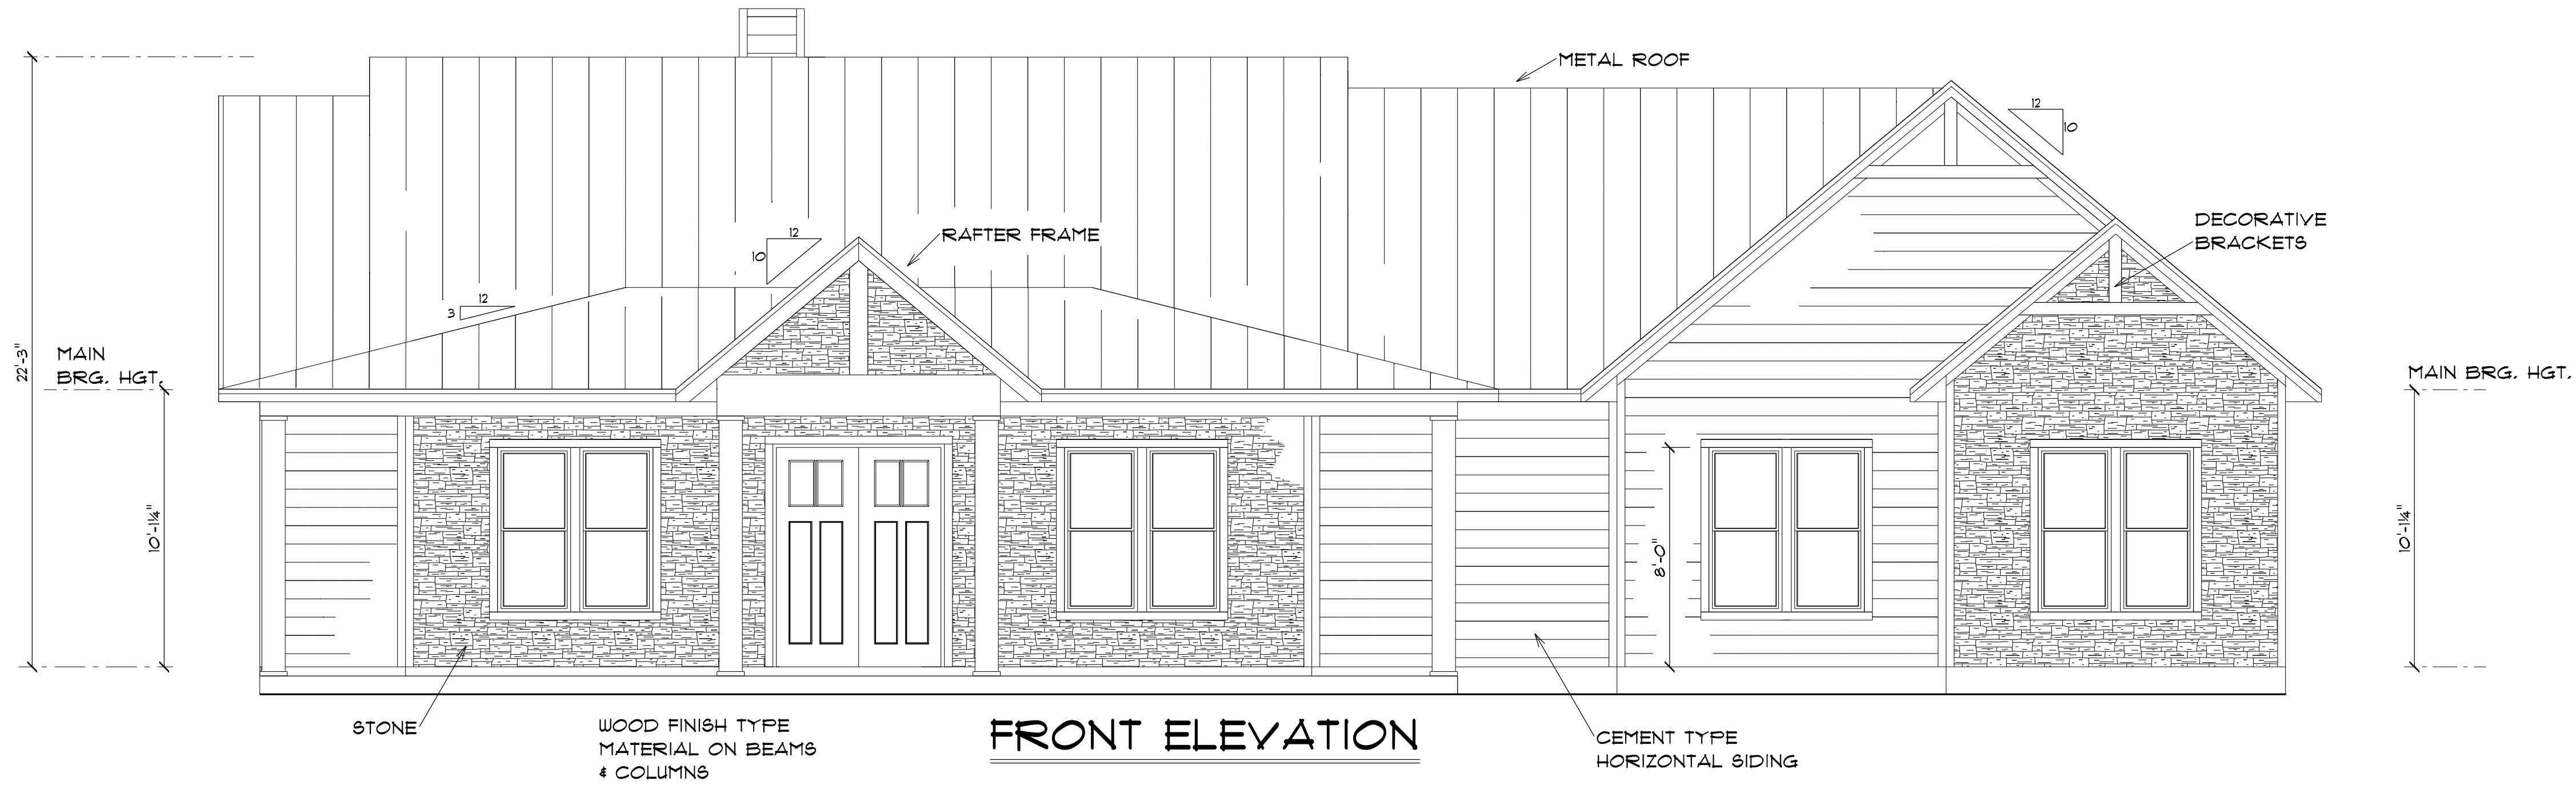

FRONT ELEVATION

Review for Code Compliance
Universal Engineering Science
Lawrence Pennell PX2707 10/24/2024
Examiner License No.



REAR ELEVATION


KLINE RESIDENCE

1/4" = 1'
P.A.C.
APPROVED

COREY AMIRA
CUSTOM HOMES


COLACINO
DRAFTING & DESIGN
PH. 352-472-3462

DATE 8/30/24
REVISED
REVISED

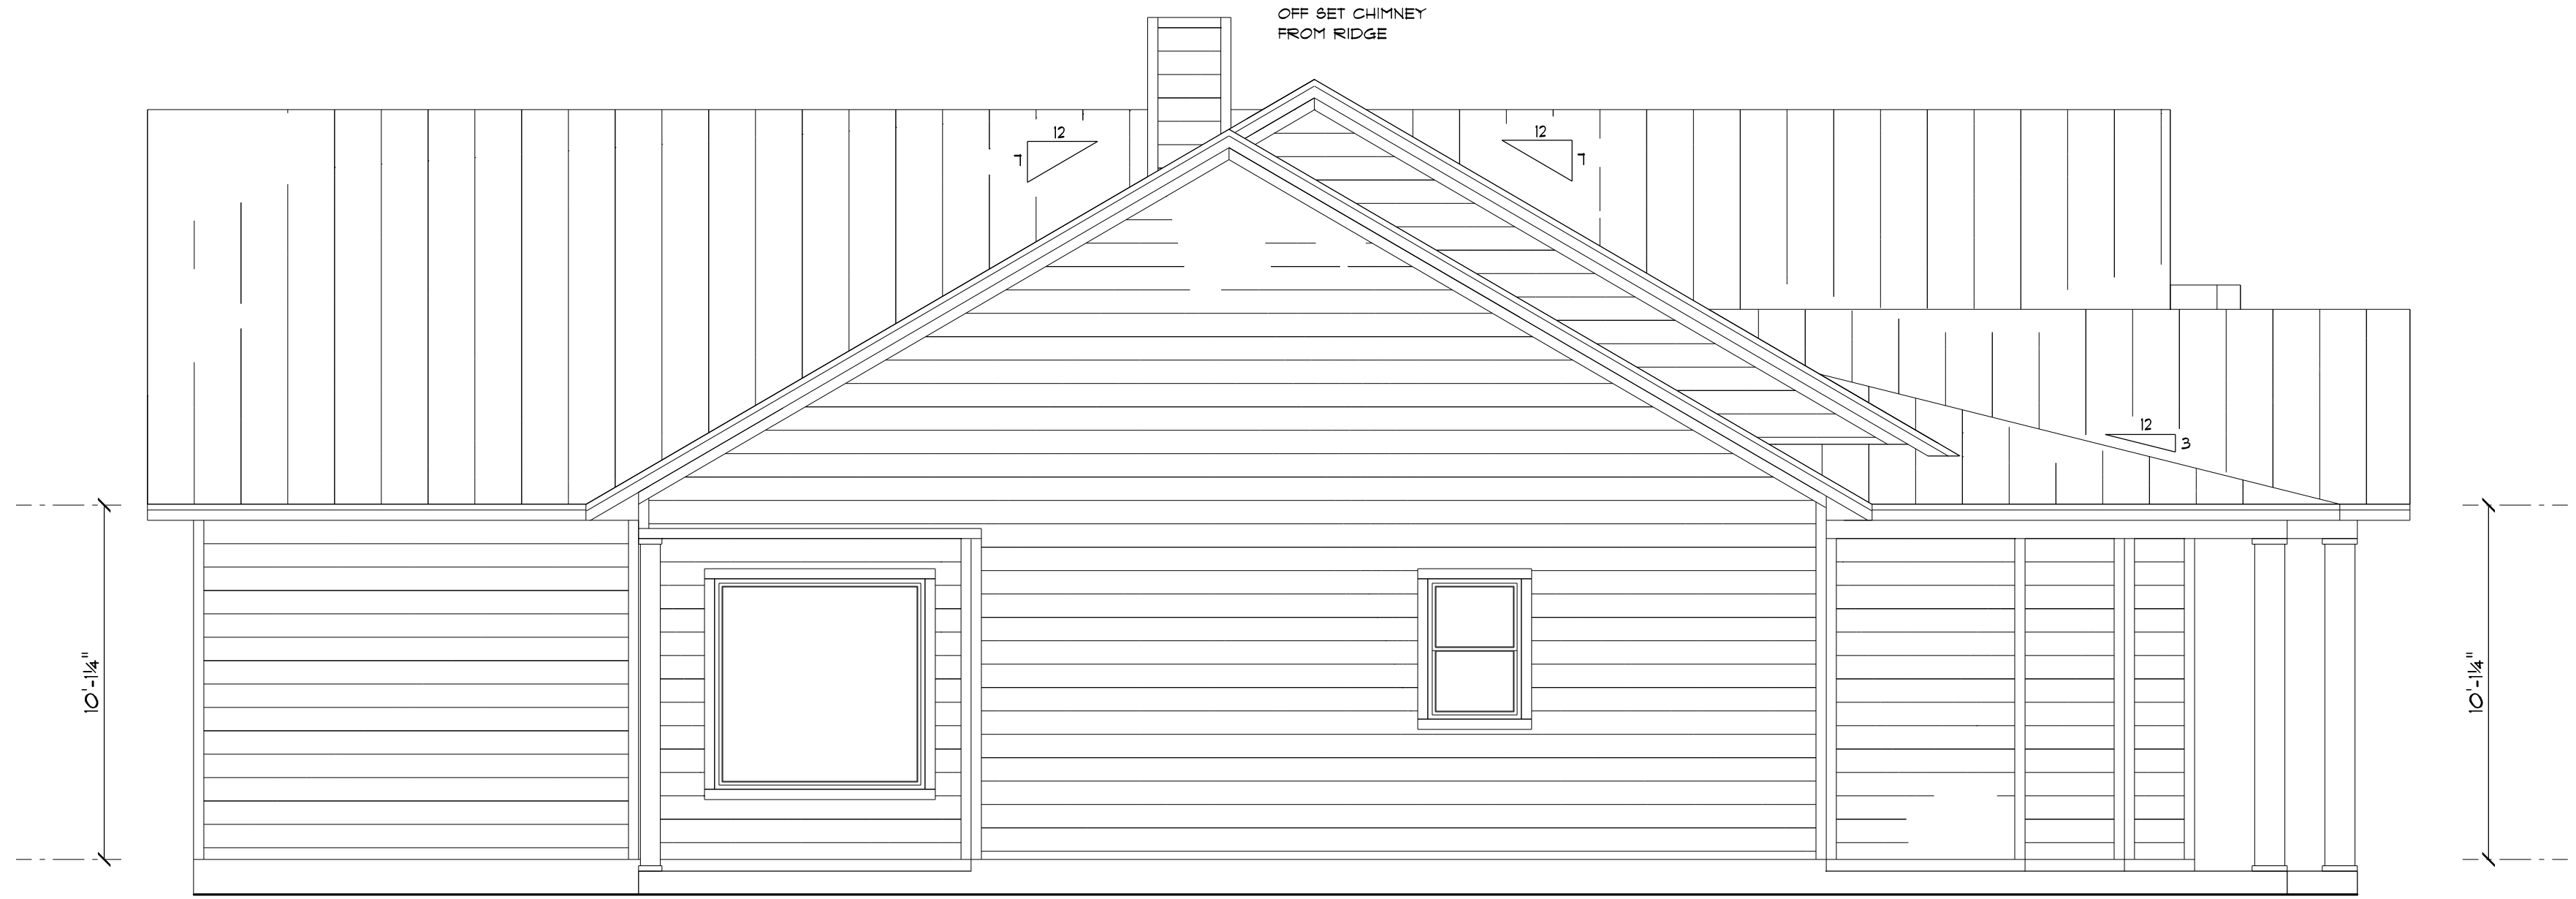


LEFT ELEVATION

Review for Code Compliance
Universal Engineering Science
Lauren Pennell
EXAMINER LICENSE NO. PX2707 1012402024

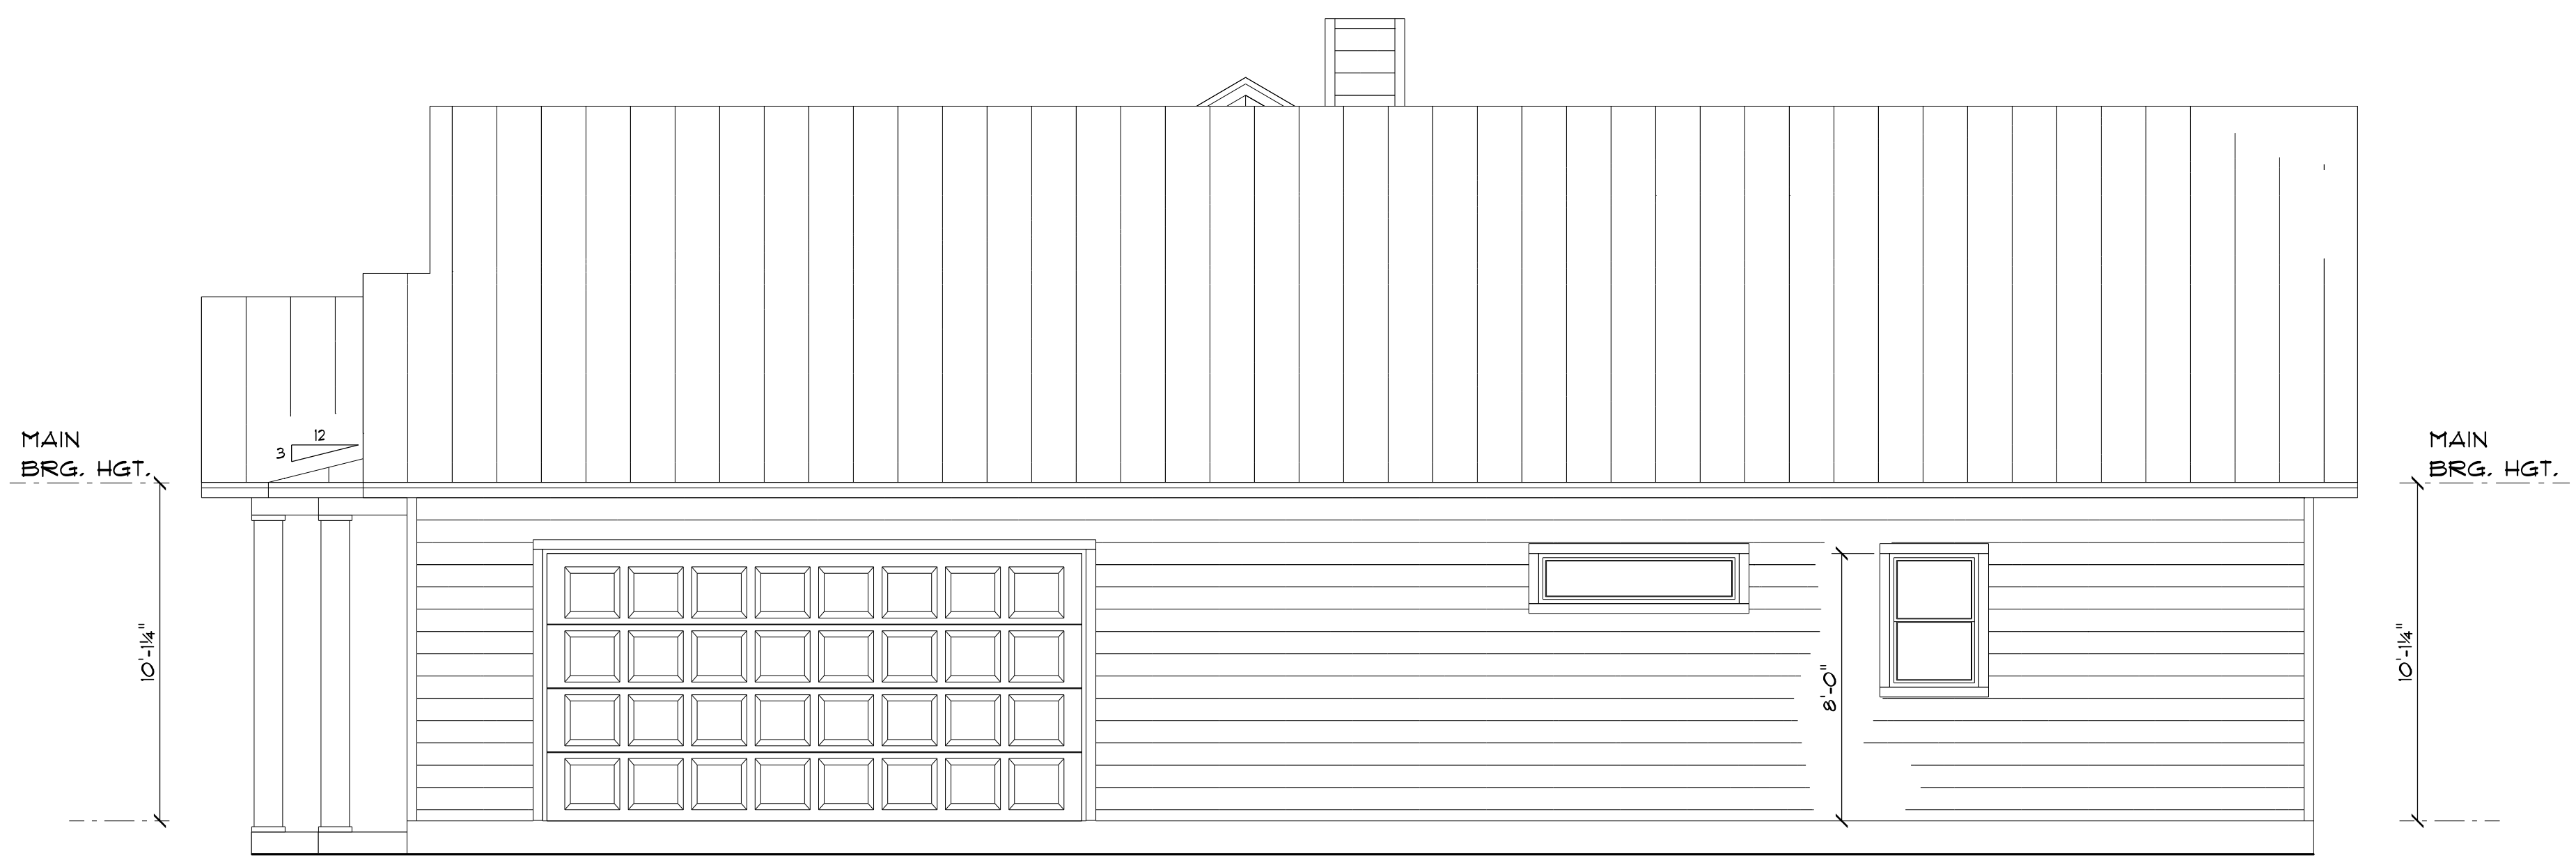

RIGHT ELEVATION

ELECTRICAL	SYMBOL
ceiling fan	
CABINET LIGHT	
exterior light	
spotlight double	
electrical meter	
electrical panel	
A/C DISCONNECT	
ACU	
Carbon Monoxide	
DISPOSAL	
EXHAUST FAN	
RECESS LIGHT	
tv outlet	
light	
outlet	
outlet 220v	
outlet gfi	
outlet up	
smoke detector	
switch	
switch 3 way	
phone/internet	
vanity bar light	

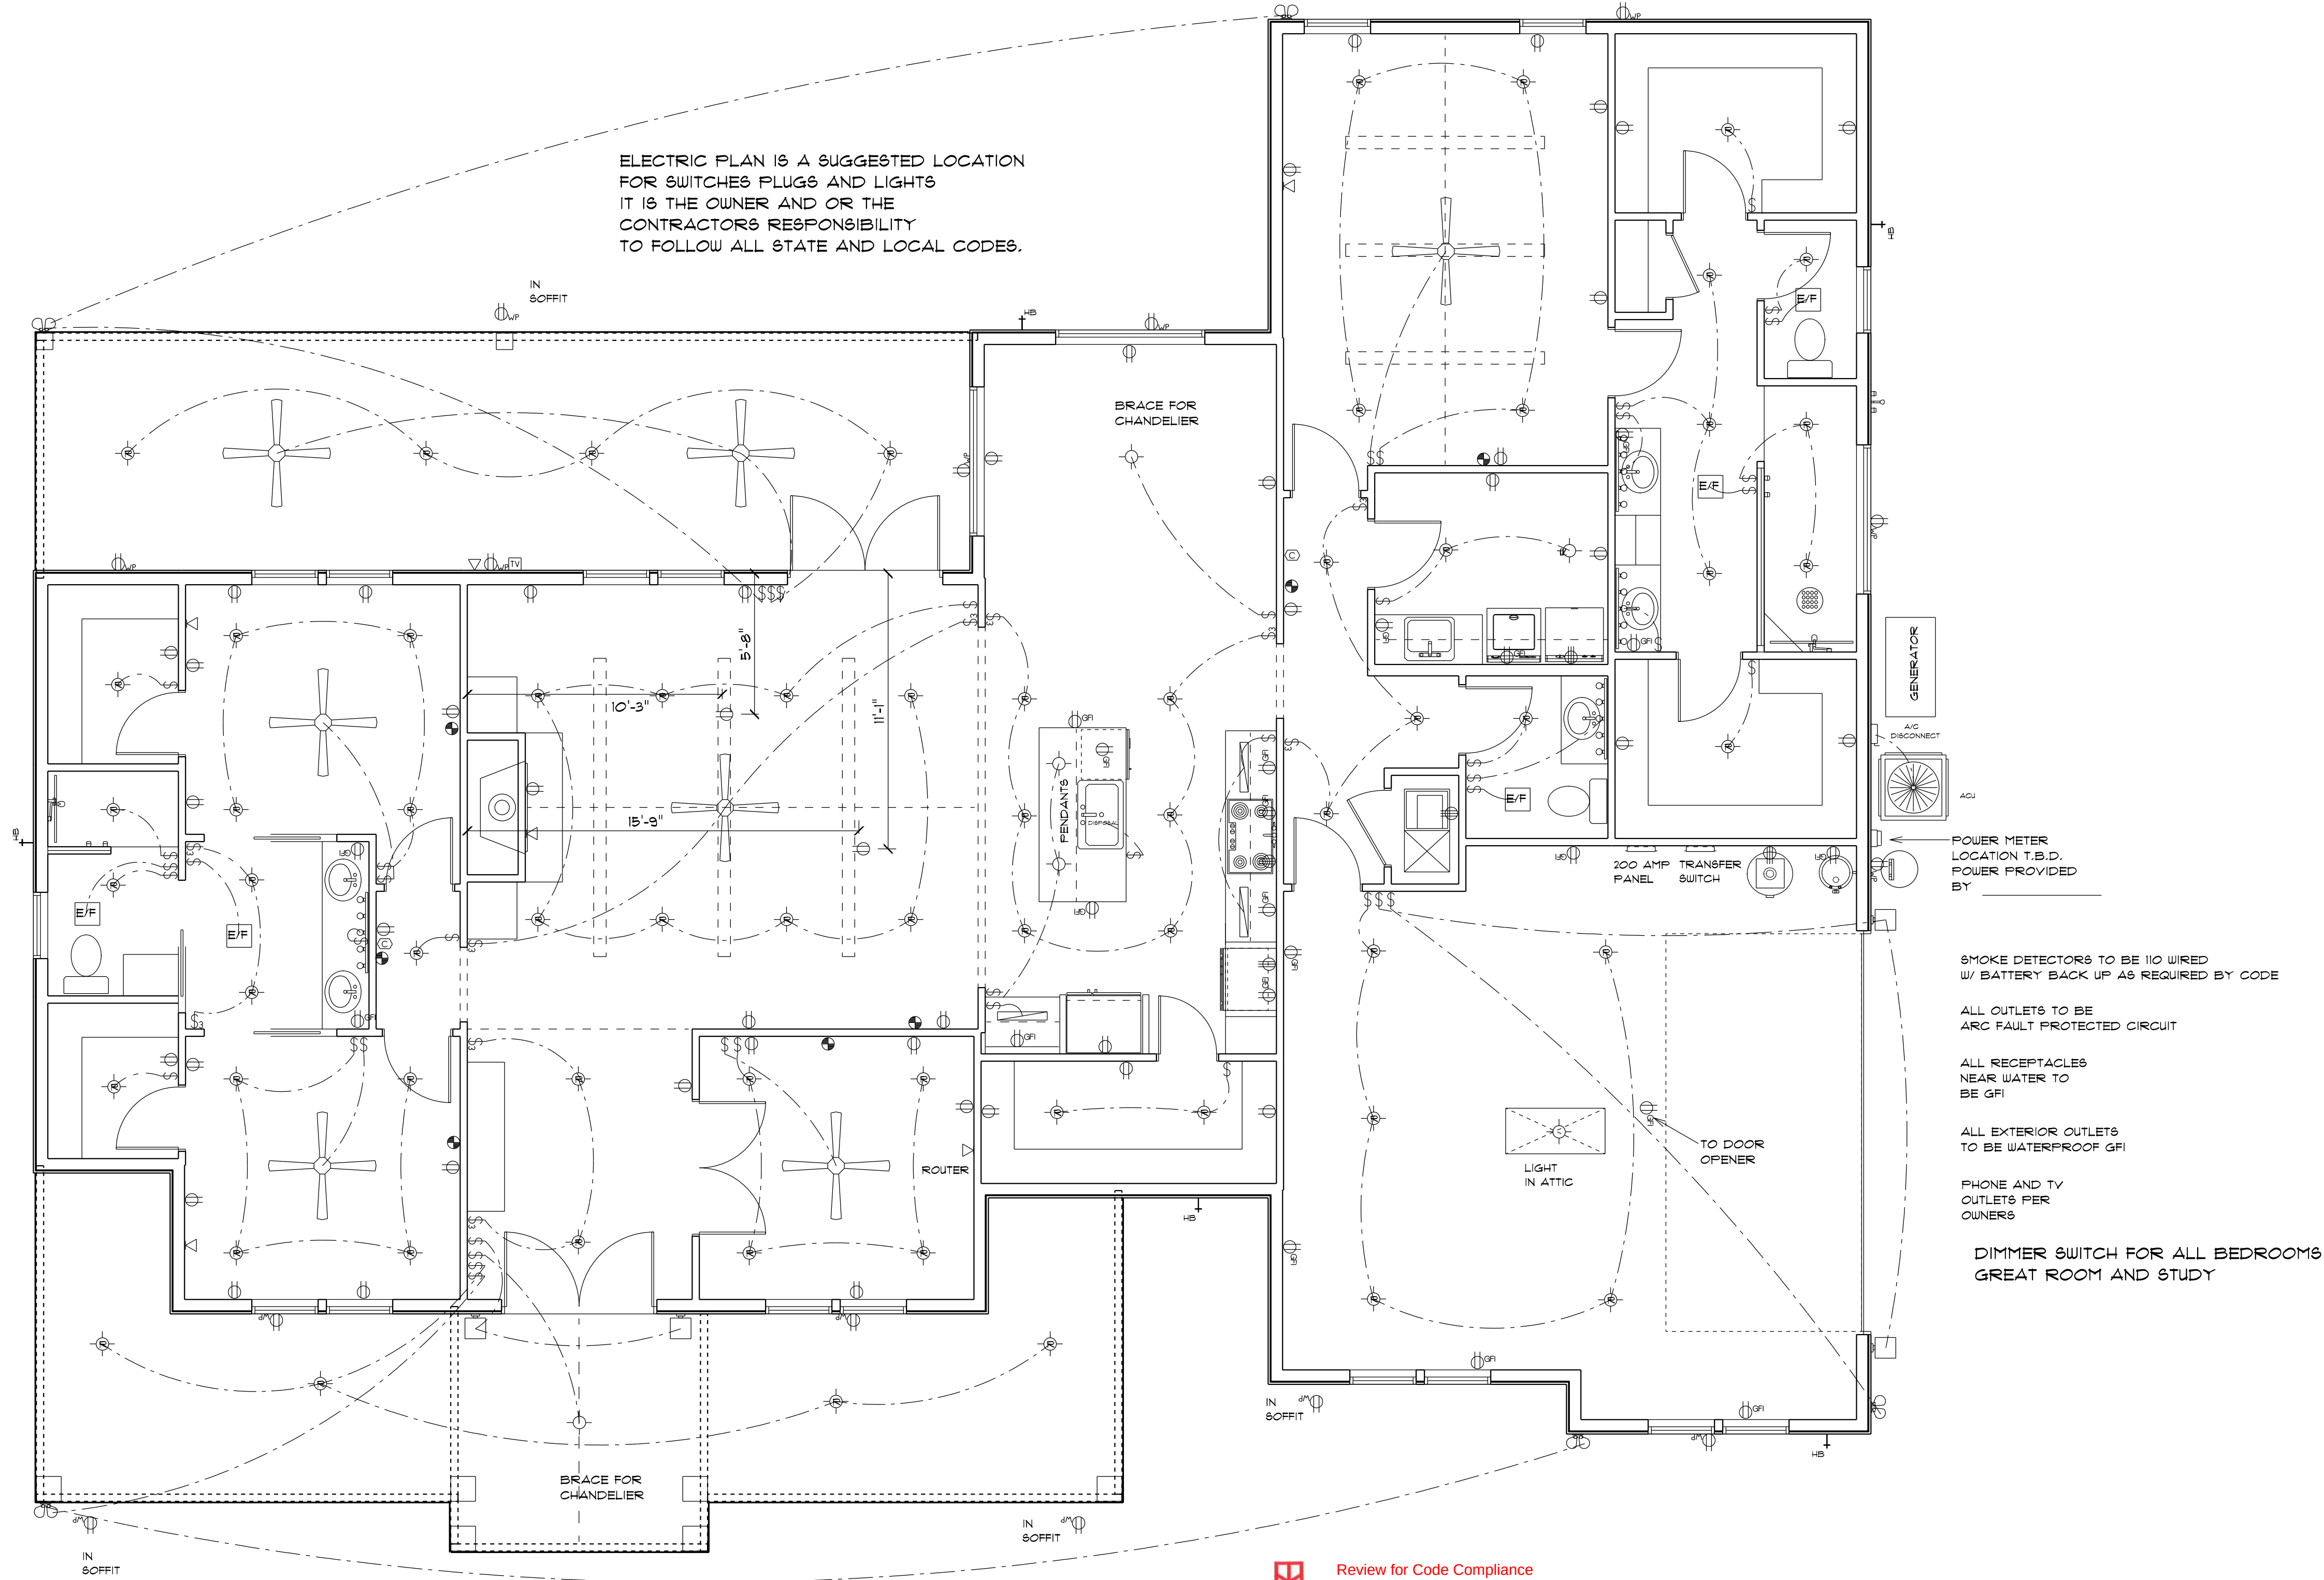

ELECTRICAL PLAN

Review for Code Compliance
Universal Engineering Science
Louanna Pennell
Examiner License No. PX2707 10/24/2024

U



DATE 8/30/24
REVISED
REVISED

COLACINO
DRAFTING+DESIGN
PH. 352-472-3462

COREY AMIRA
CUSTOM HOMES

SCALE 1/4" = 1'
DRAWN BY P.A.C.
APPROVED

KLINE RESIDENCE

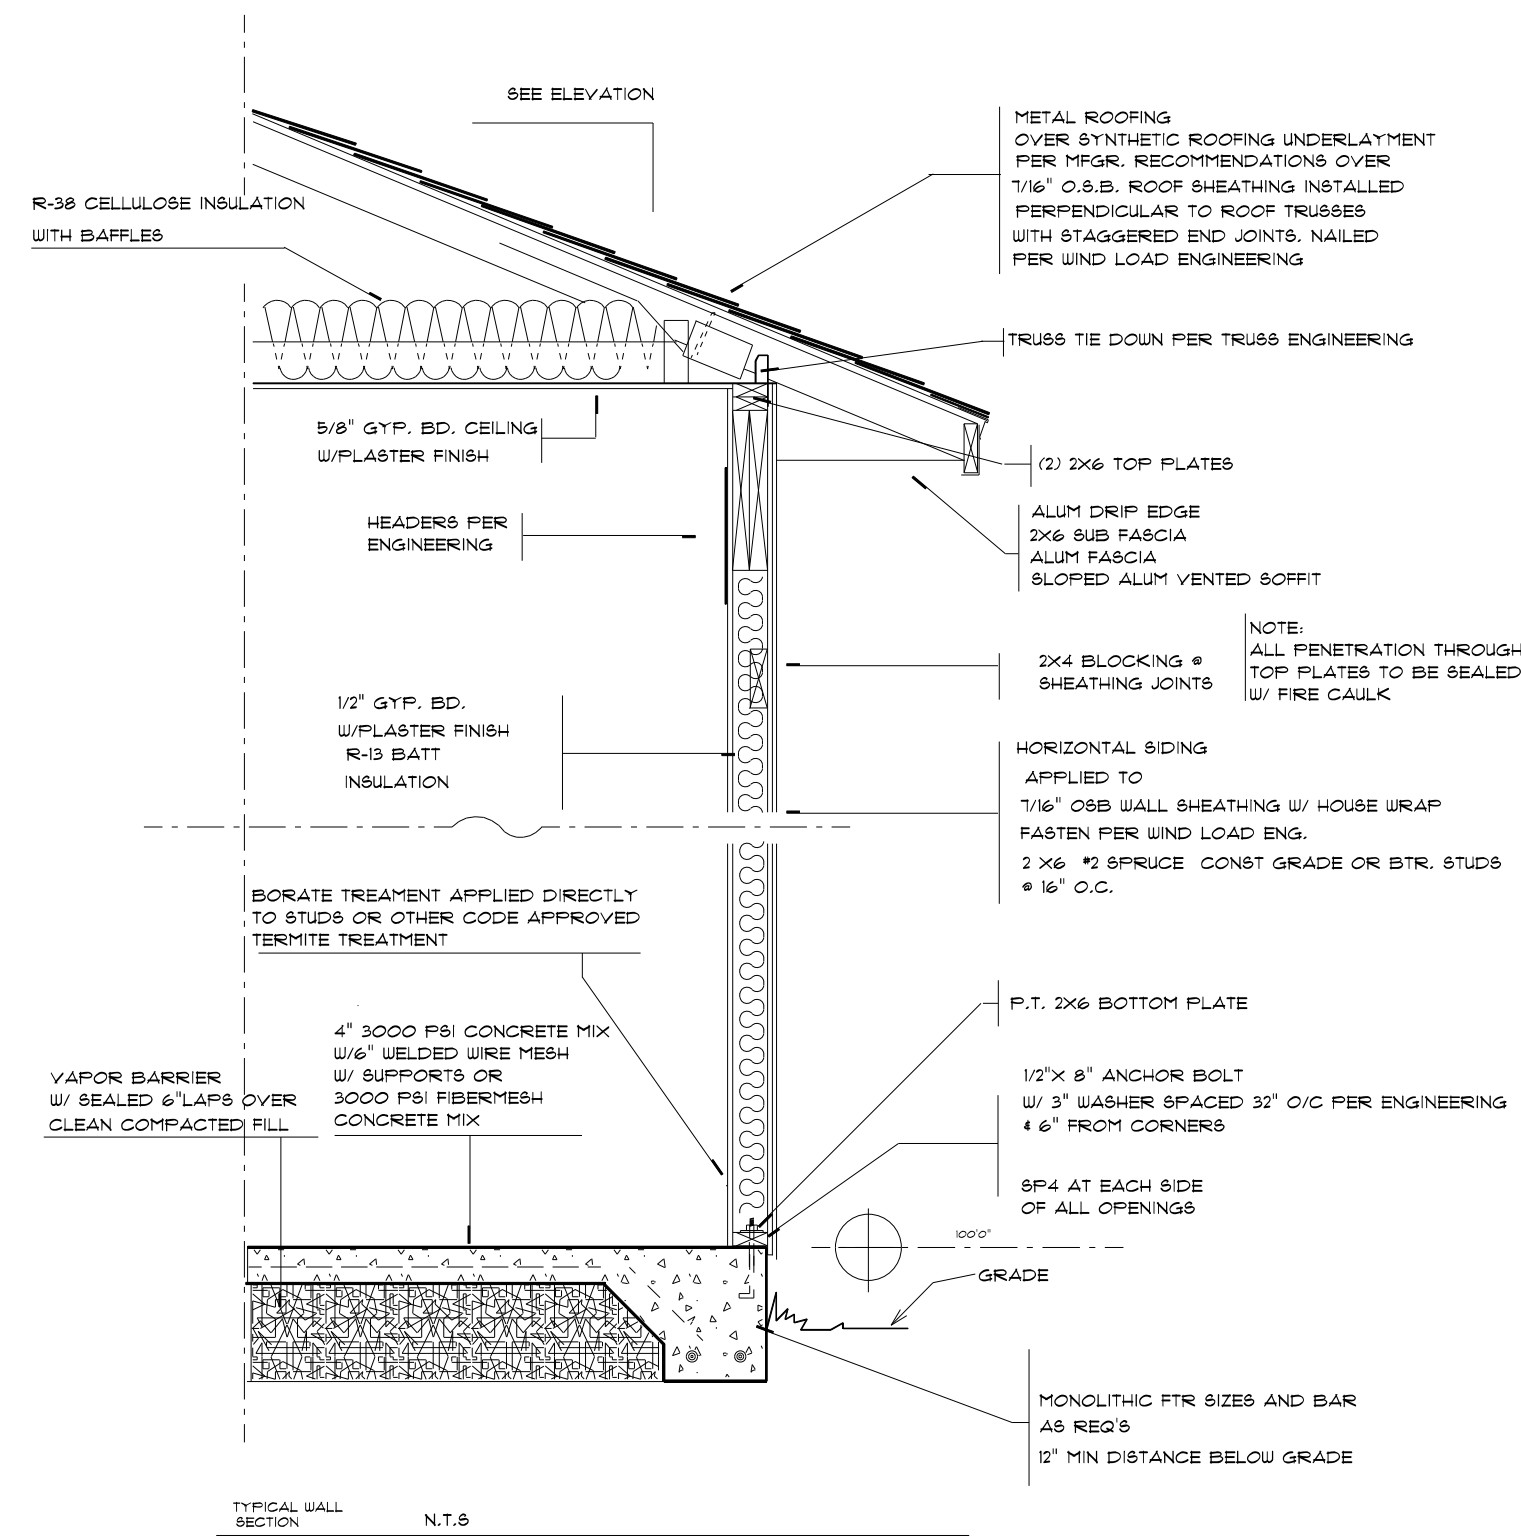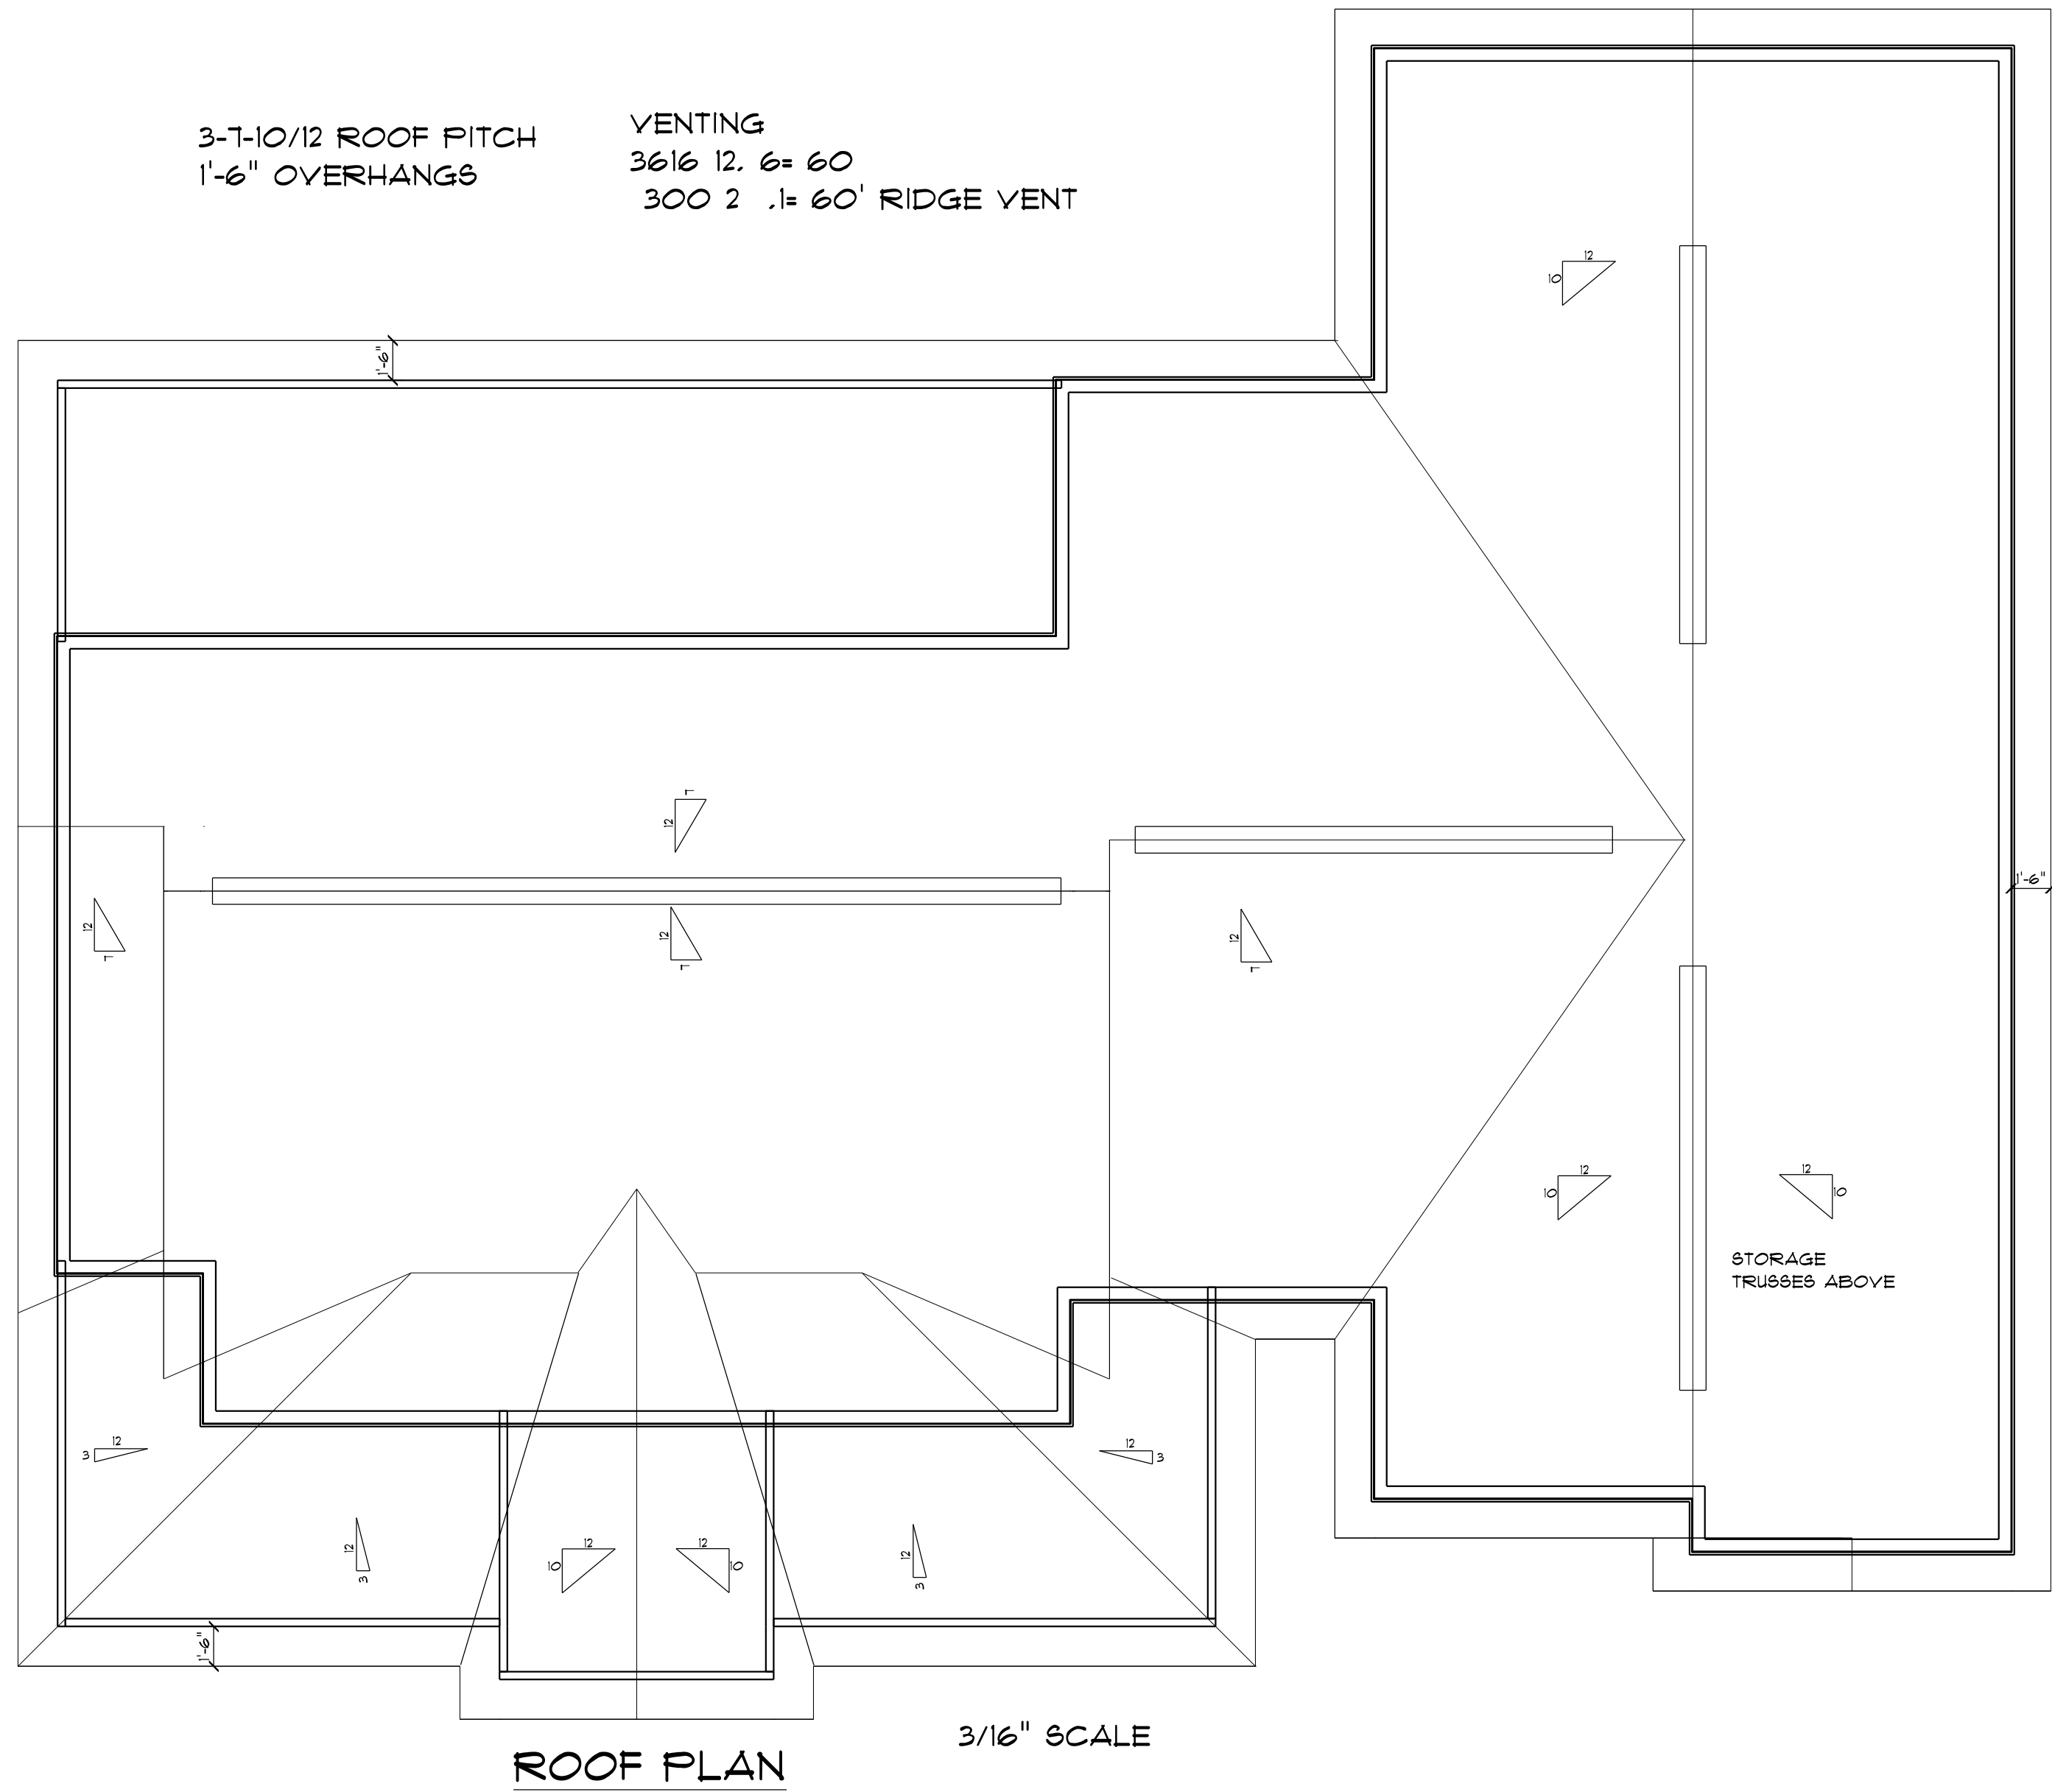

Review for Code Compliance
Universal Engineering Science

Lawrence Powell
Engineer License No. PX2707 10042024

6

DATE 8/30/24
REVISED
REVISED

COLACINO
DRAFTING#DESIGN
PH. 352-472-3462

COREY AMIRA
CUSTOM HOMES

SCALE 1/4" = 1'
DRAWN BY P.A.C.
APPROVED

KLINE RESIDENCE