

PHOTOVOLTAIC ROOF MOUNT SYSTEM

21 MODULES-ROOF MOUNTED - 8.400 kW DC, 6.090 kW AC

131 NW KATELYN WAY, LAKE CITY, FL 32055



LUNEX POWER INC.
4721 N GRADY AVE
TAMPA FL 33614
LIC #: CVC57085
PHONE: 813-540-8807

PROJECT DATA

PROJECT ADDRESS: 131 NW KATELYN WAY, LAKE CITY, FL 32055

OWNER: MARY W WILDS

CONTRACTOR: LUNEX POWER, 4721 N GRADY AVE TAMPA FL 33614 PHONE: 813-540-8807

DESIGNER: ESR

SCOPE: 8.400 KW DC ROOF MOUNT SOLAR PV SYSTEM WITH 21 HANWHA SOLAR: Q.PEAK DUO BLK ML-G10+ 400W PV MODULES WITH 21 ENPHASE: IQ8PLUS-72-2-US (240V) MICROINVERTERS (COMPLIANT WITH RAPID SHUTDOWN)

AUTHORITIES HAVING JURISDICTION:
BUILDING: COLUMBIA COUNTY
ZONING: COLUMBIA COUNTY
UTILITY: FPL


SHEET INDEX

PV-1	COVER SHEET
PV-2	SITE PLAN
PV-3	ROOF PLAN & MODULES
PV-4	ELECTRICAL PLAN
PV-5	STRUCTURAL DETAIL
PV-6	ELECTRICAL LINE DIAGRAM
PV-7	WIRING CALCULATIONS
PV-8	LABELS
PV-9	PLACARD
PV-10	MICRO INVERTER CHART
PV-11+	EQUIPMENT SPECIFICATIONS

GENERAL NOTES

- ALL COMPONENTS ARE UL LISTED AND CEC CERTIFIED, WHERE WARRANTED.
- THE SOLAR PV SYSTEM WILL BE INSTALLED IN ACCORDANCE WITH ARTICLE 690 OF THE NEC 2020.
- THE UTILITY INTERCONNECTION APPLICATION MUST BE APPROVED AND PV SYSTEM INSPECTED PRIOR TO PARALLEL OPERATION.
- ALL CONDUCTORS OF A CIRCUIT, INCLUDING THE EGC, MUST BE INSTALLED IN THE SAME RACEWAY, OR CABLE, OR OTHERWISE RUN WITH THE PV ARRAY CIRCUIT CONDUCTORS WHEN THEY LEAVE THE VICINITY OF THE PV ARRAY.
- WHERE METALLIC CONDUIT CONTAINING DC CONDUCTORS IS USED INSIDE THE BUILDING, IT SHALL BE IDENTIFIED AS "CAUTION: SOLAR CIRCUIT" EVERY 10FT.
- HEIGHT OF THE AC DISCONNECT SHALL NOT EXCEED 6'-7" PER NEC CODE 240.24.
- A GROUNDING ELECTRODE SYSTEM IN ACCORDANCE WITH NEC 2020 690.47 AND 250.50 THROUGH 60 AND 250-166 SHALL BE PROVIDED. PER NEC GROUNDING ELECTRODE SYSTEM OF EXISTING BUILDING MAY BE USED AND BONDED TO THE SERVICE ENTRANCE. IF EXISTING SYSTEM IS INACCESSIBLE OR INADEQUATE A SUPPLEMENTAL GROUNDING ELECTRODE WILL BE USED AT THE INVERTER LOCATION CONSISTING OF A UL LISTED 8 FT. GROUND ROD WITH ACORN CLAMP. GROUNDING ELECTRODE CONDUCTORS SHALL BE NO LESS THAN #8 AWG AND NO LARGER THAN #6 AWG COPPER AND BONDED TO THE EXISTING GROUNDING ELECTRODE TO PROVIDE FOR A COMPLETE SYSTEM.
- PHOTOVOLTAIC MODULES ARE TO BE CONSIDERED NON-COMBUSTIBLE.
- PHOTOVOLTAIC INSTALLATION WILL NOT OBSTRUCT ANY PLUMBING. MECHANICAL, OR BUILDING ROOF VENTS.
- ALL WIRING MUST BE PROPERLY SUPPORTED BY DEVICES OR MECHANICAL MEANS DESIGNED AND LISTED FOR SUCH USE. WIRING MUST BE PERMANENTLY AND COMPLETELY HELD OFF THE ROOF SURFACE.
- ALL SINAGE TO BE PLACED IN ACCORDANCE WITH THE LOCAL BUILDING CODE. IF EXPOSED TO SUNLIGHT, IT SHALL BE UV RESISTANT. ALL PLAQUES AND SINAGE WILL BE INSTALLED AS REQUIRED BY THE NEC AND AHJ.
- INVERTER(S) USED IN UNGROUNDED SYSTEM SHALL BE UL 1741 LISTED.
- THE INSTALLATION OF EQUIPMENT AND ALL ASSOCIATED WIRING AND INTERCONNECTION SHALL BE PERFORMED ONLY BY QUALIFIED PERSONS [NEC 690.4(C)]
- ALL OUTDOOR EQUIPMENT SHALL BE NEMA 3R RATED (OR BETTER), INCLUDING ALL ROOF MOUNTED TRANSITION BOXES AND SWITCHES.
- ALL EQUIPMENT SHALL BE PROPERLY GROUNDED AND BONDED IN ACCORDANCE WITH NEC ARTICLE 250.
- SYSTEM GROUNDING SHALL BE IN ACCORDANCE WITH NEC 690.41.
- PV SYSTEM CIRCUITS INSTALLED ON OR IN BUILDINGS SHALL INCLUDE A RAPID SHUTDOWN FUNCTION IN ACCORDANCE WITH NEC 690.12
- DISCONNECTING MEANS SHALL BE LOCATED IN A VISIBLE, READILY ACCESSIBLE LOCATION WITHIN THE PV SYSTEM EQUIPMENT OR A MAXIMUM OF 10 FEET AWAY FROM THE SYSTEM [NEC 690.13(A)]
- ALL WIRING METHODS SHALL BE IN ACCORDANCE WITH NEC 690.31
- WORK CLEARANCES AROUND ELECTRICAL EQUIPMENT WILL BE MAINTAINED PER NEC 110.26(A)(1), 110.26(A)(2) AND 110.26(A)(3).
- ROOFTOP MOUNTED PHOTOVOLTAIC PANELS AND MODULES SHALL BE TESTED, LISTED & IDENTIFIED IN ACCORDANCE WITH UL1703
- ELECTRICAL CONTRACTOR TO PROVIDE CONDUIT EXPANSION JOINTS AND ANCHOR CONDUIT RUNS AS REQUIRED PER NEC.

VICINITY MAP

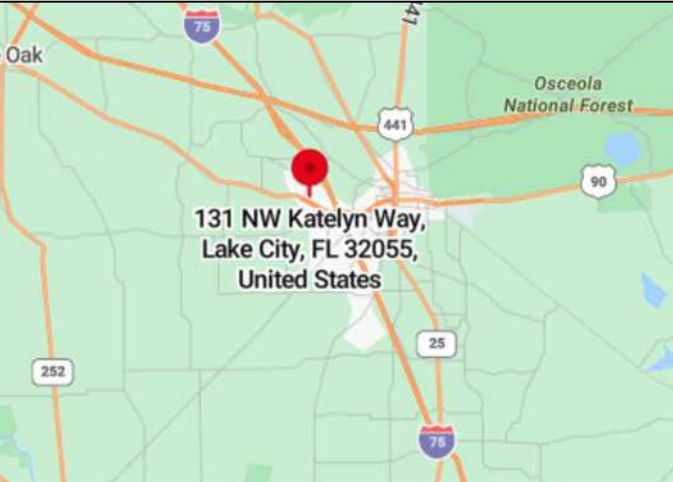

HOUSE PHOTO



CODE REFERENCES


PROJECT TO COMPLY WITH THE FOLLOWING:

FLORIDA RESIDENTIAL CODE, 8TH EDITION 2023 (FRC)
FLORIDA PLUMBING CODE, 8TH EDITION 2023 (FPC)
FLORIDA BUILDING CODE, 8TH EDITION 2023 EDITION (FBC)
FLORIDA MECHANICAL CODE, 8TH EDITION 2023 (FMC)
2020 NATIONAL ELECTRICAL CODE
FLORIDA FIRE PREVENTION CODE, 8TH EDITION 2023 (FFPC)

Andrew D. Leone
Digitally signed by Andrew D. Leone
Date: 2024.02.12 12:34:11 -05'00'

REVISIONS

DESCRIPTION	DATE	REV
CLIENT COMMENT	02/08/2024	A
CLIENT COMMENT	02/12/2024	B

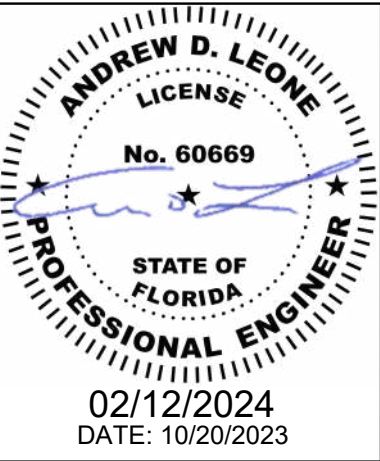

PROJECT NAME & ADDRESS

MARY W WILDS
RESIDENCE
131 NW KATELYN WAY,
LAKE CITY, FL 32055

DRAWN BY

ESR

SHEET NAME

COVER SHEET

SHEET SIZE

ANSI B
11" X 17"

SHEET NUMBER

PV-1

PROFESSIONAL ENGINEER SEAL

This item has been digitally signed and sealed by Andrew D. Leone on the date adjacent to the seal.

Printed copies of this document are not considered signed and sealed and the signature must be verified on any electronic copies.



PROJECT DESCRIPTION:

21 X HANWHA SOLAR: Q.PEAK DUO BLK ML-G10+ 400W PV MODULES
ROOF MOUNTED SOLAR PHOTOVOLTAIC MODULES
DC SYSTEM SIZE: 21 x 400 = 8.400KW DC
AC SYSTEM SIZE: 21 x 290 = 6.090KW AC

EQUIPMENT SUMMARY
21 HANWHA SOLAR: Q.PEAK DUO BLK ML-G10+ 400W MONO MODULES
21 ENPHASE: IQ8PLUS-72-2-US (240V) MICROINVERTERS (COMPLIANT WITH RAPID SHUTDOWN)

ROOF ARRAY AREA #1:- 443.52 SQ FT.

NOTE: VISIBLE, LOCKABLE, LABELED AC DISCONNECT
LOCATED WITHIN 10' OF UTILITY METER

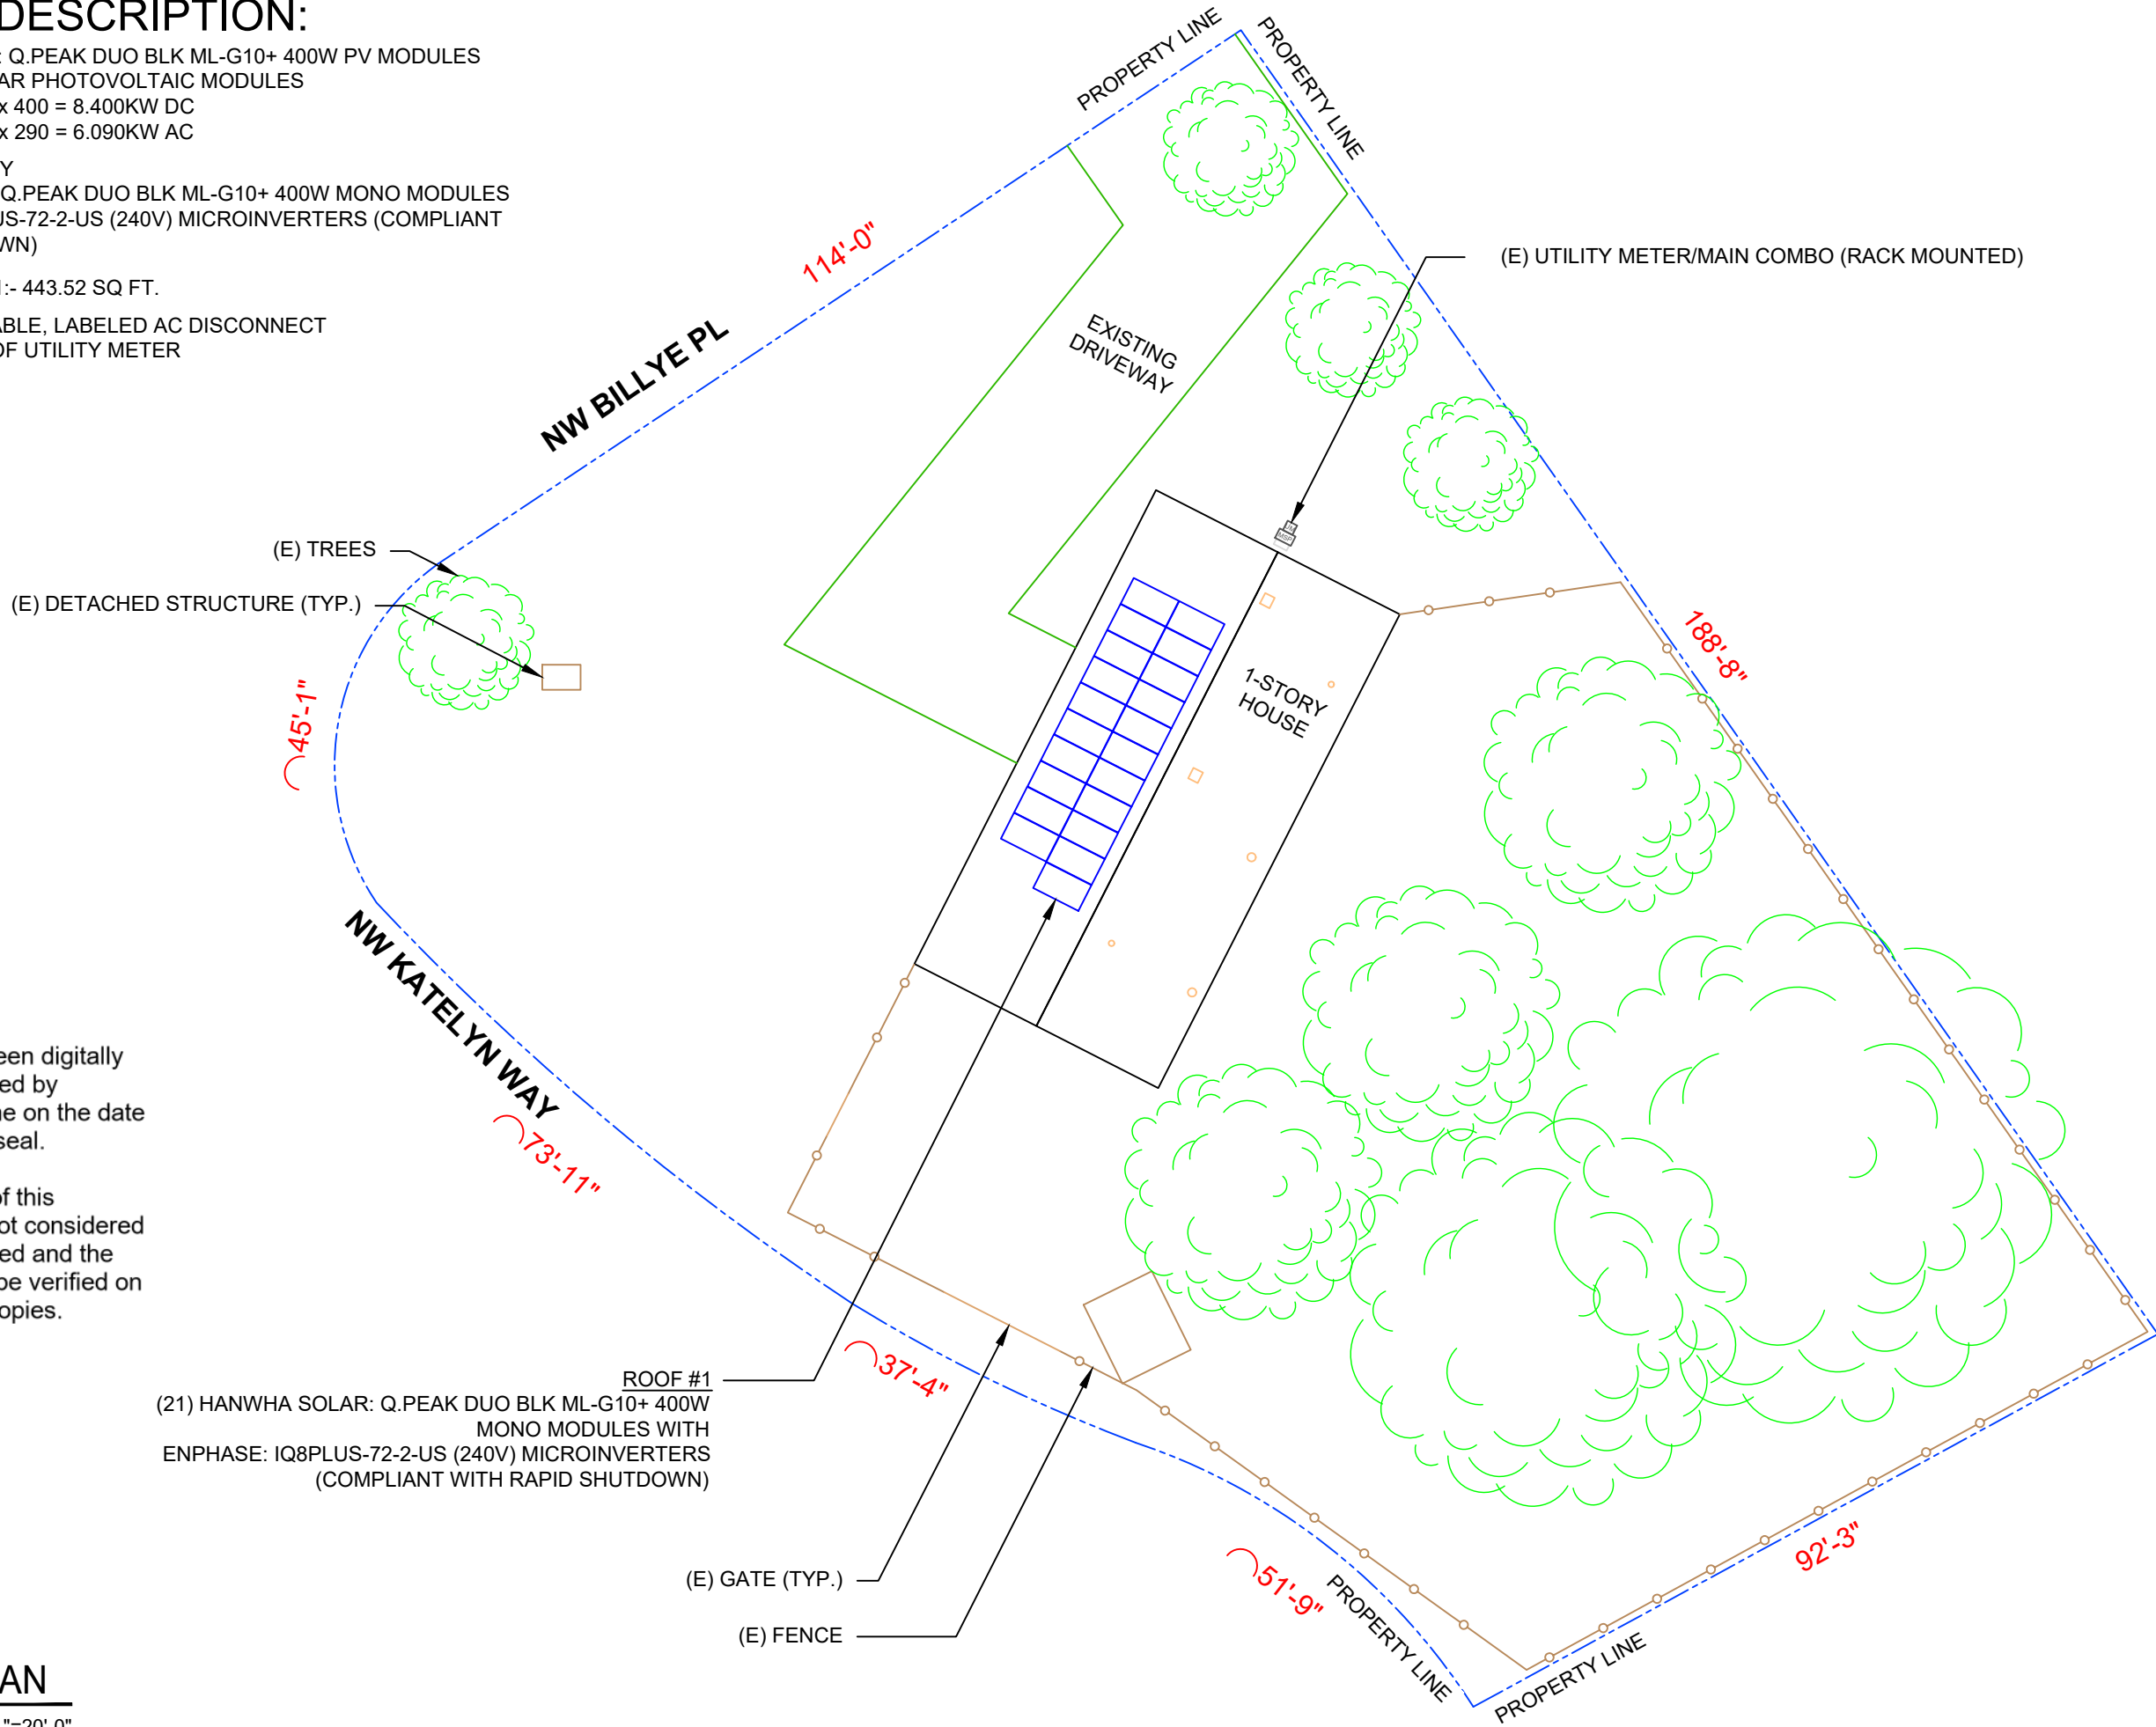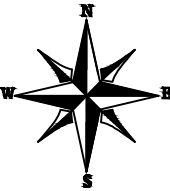

This item has been digitally
signed and sealed by
Andrew D. Leone on the date
adjacent to the seal.

Printed copies of this
document are not considered
signed and sealed and the
signature must be verified on
any electronic copies.

ROOF #1
(21) HANWHA SOLAR: Q.PEAK DUO BLK ML-G10+ 400W
MONO MODULES WITH
ENPHASE: IQ8PLUS-72-2-US (240V) MICROINVERTERS
(COMPLIANT WITH RAPID SHUTDOWN)

LUNEX POWER INC.
4721 N GRADY AVE
TAMPA FL 33614
LIC #: CVC57085
PHONE: 813-540-8807

REVISIONS		
DESCRIPTION	DATE	REV
CLIENT COMMENT	02/08/2024	A
CLIENT COMMENT	02/12/2024	B

02/12/2024
DATE: 10/20/2023

PROJECT NAME & ADDRESS

MARY W WILDS
RESIDENCE
131 NW KATELYN WAY,
LAKE CITY, FL 32055

DRAWN BY
ESR


SHEET NAME
SITE PLAN

SHEET SIZE
ANSI B
11" X 17"

SHEET NUMBER
PV-2

MODULE TYPE, DIMENSIONS & WEIGHT

NUMBER OF MODULES = 21 MODULES
MODULE TYPE = HANWHA SOLAR: Q.PEAK DUO BLK ML-G10+ 400W MONO MODULES
MODULE WEIGHT = 48.5 LBS / 22.0KG.
MODULE DIMENSIONS = 74.0" x 41.1" = 21.12 SF

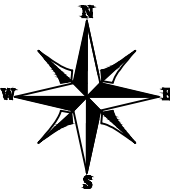

ROOF #1
(21) HANWHA SOLAR: Q.PEAK DUO BLK ML-G10+ 400W
MONO MODULES WITH
ENPHASE: IQ8PLUS-72-2-US (240V) MICROINVERTERS
(COMPLIANT WITH RAPID SHUTDOWN)

(50) S-5! PROTEA BRACKET ATTACHMENTS
(N) EVEREST K2 SYSTEMS MILLRAIL 44-X RAIL 172" MILL

ROOF #1
PITCH - 13°
AZIM. - 297°

ROOF ACCESS POINT


(E) UTILITY METER/MAIN COMBO
(RACK MOUNTED)

ROOF DESCRIPTION			
ROOF TYPE			METAL ROOF
ROOF	ROOF PITCH	AZIMUTH	SEAM SPACING
#1	13°	297°	8"

ARRAY AREA & ROOF AREA CALC'S				
ROOF	# OF MODULES	ARRAY AREA (Sq. Ft.)	ROOF AREA (Sq. Ft.)	ROOF AREA COVERED BY ARRAY (%)
#1	21	443.52	1018.75	44
TOTAL	21	443.52	2037.50	22

This item has been digitally
signed and sealed by
Andrew D. Leone on the date
adjacent to the seal.

Printed copies of this
document are not considered
signed and sealed and the
signature must be verified on
any electronic copies.

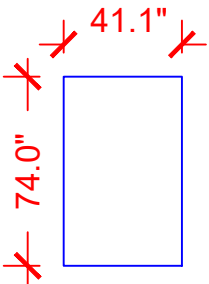


HANWHA SOLAR: Q.PEAK DUO
BLK ML-G10+ 400W MODULES

LEGEND			
SD	- SOLADECK	INV	- INVERTER
PM	- PV PRODUCTION METER	JB	- JUNCTION BOX
CB	- COMBINER BOX		- VENT, ATTIC FAN (ROOF OBSTRUCTION)
ACD	- AC DISCONNECT		- ROOF ATTACHMENT
SLD	- SOLAR LOAD CENTER		- SEAM
UM	- UTILITY METER		- CONDUIT
MSP	- MAIN SERVICE PANEL		



LUNEX POWER INC.
4721 N GRADY AVE
TAMPA FL 33614
LIC #: CVC57085
PHONE: 813-540-8807

REVISIONS		
DESCRIPTION	DATE	REV
CLIENT COMMENT	02/08/2024	A
CLIENT COMMENT	02/12/2024	B

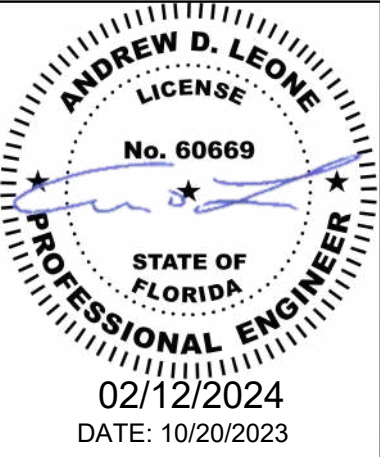

PROJECT NAME & ADDRESS

MARY W WILDS
RESIDENCE
131 NW KATELYN WAY,
LAKE CITY, FL 32055


DRAWN BY
ESR

SHEET NAME
ROOF PLAN &
MODULES

SHEET SIZE
ANSI B
11" X 17"

SHEET NUMBER
PV-3

CIRCUIT LEGENDS	
---	CIRCUIT #1
---	CIRCUIT #2

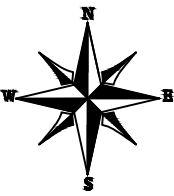

(21) ENPHASE: IQ8PLUS-72-2-US (240V) MICROINVERTERS
(COMPLIANT WITH RAPID SHUTDOWN)

CIRCUIT #1
(11 MODULES)

CIRCUIT #2
(10 MODULES)

- (N) ENPHASE COMBINER BOX
- (N) VISIBLE, LOCKABLE, LABELED
NON-FUSED AC DISCONNECT
(LOCATED WITHIN 10' OF UTILITY METER)
- (E) UTILITY METER/MAIN COMBO
(RACK MOUNTED)

(N) EMT CONDUIT

(N) JUNCTION BOX

JB

CB ACD
UM
MSP

This item has been digitally
signed and sealed by
Andrew D. Leone on the date
adjacent to the seal.

Printed copies of this
document are not considered
signed and sealed and the
signature must be verified on
any electronic copies.


BILL OF MATERIALS		
EQUIPMENT	QTY	DESCRIPTION
SOLAR PV MODULES	21	HANWHA SOLAR: Q.PEAK DUO BLK ML-G10+ 400W MODULE
MICROINVERTERS	21	ENPHASE: IQ8PLUS-72-2-US (240V) MICROINVERTERS (COMPLIANT WITH RAPID SHUTDOWN)
JUNCTION BOX	1	6"X6"X4" UL LISTED, STEEL WATER TIGHT NEMA TYPE 3R, UL LISTED
RAILS	11	EVEREST K2 SYSTEMS MILLRAIL 44-X, 172" MILL
SPLICES	8	SPLICE KIT
MID MODULE CLAMPS	38	MID MODULE CLAMPS
END CLAMPS	8	END CLAMPS / STOPPER SLEEVE
ATTACHMENTS	50	S-5! PROTEA BRACKET ATTACHMENTS

LEGEND	
SD	- SOLADECK
PM	- PV PRODUCTION METER
CB	- COMBINER BOX
ACD	- AC DISCONNECT
SLD	- SOLAR LOAD CENTER
UM	- UTILITY METER
MSP	- MAIN SERVICE PANEL
INV	- INVERTER
JB	- JUNCTION BOX
	- VENT, ATTIC FAN (ROOF OBSTRUCTION)
	- ROOF ATTACHMENT
	- SEAM
	- CONDUIT



LUNEX POWER INC.
4721 N GRADY AVE
TAMPA FL 33614
LIC #: CVC57085
PHONE: 813-540-8807

REVISIONS		
DESCRIPTION	DATE	REV
CLIENT COMMENT	02/08/2024	A
CLIENT COMMENT	02/12/2024	B

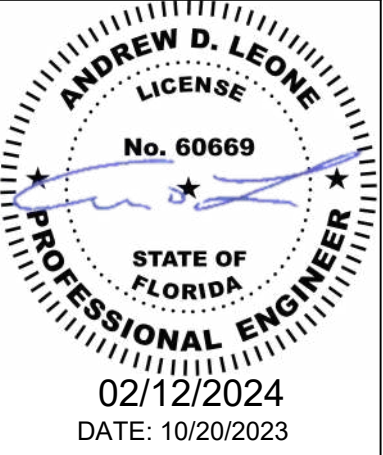

PROJECT NAME & ADDRESS

MARY W WILDS
RESIDENCE
131 NW KATELYN WAY,
LAKE CITY, FL 32055

DRAWN BY
ESR

SHEET NAME
ELECTRICAL PLAN

SHEET SIZE
ANSI B
11" X 17"

SHEET NUMBER
PV-4

1


ELECTRICAL PLAN

PV-4

SCALE: 1/8" = 1'-0"

This item has been digitally signed and sealed by Andrew D. Leone on the date adjacent to the seal.


Printed copies of this document are not considered signed and sealed and the signature must be verified on any electronic copies.

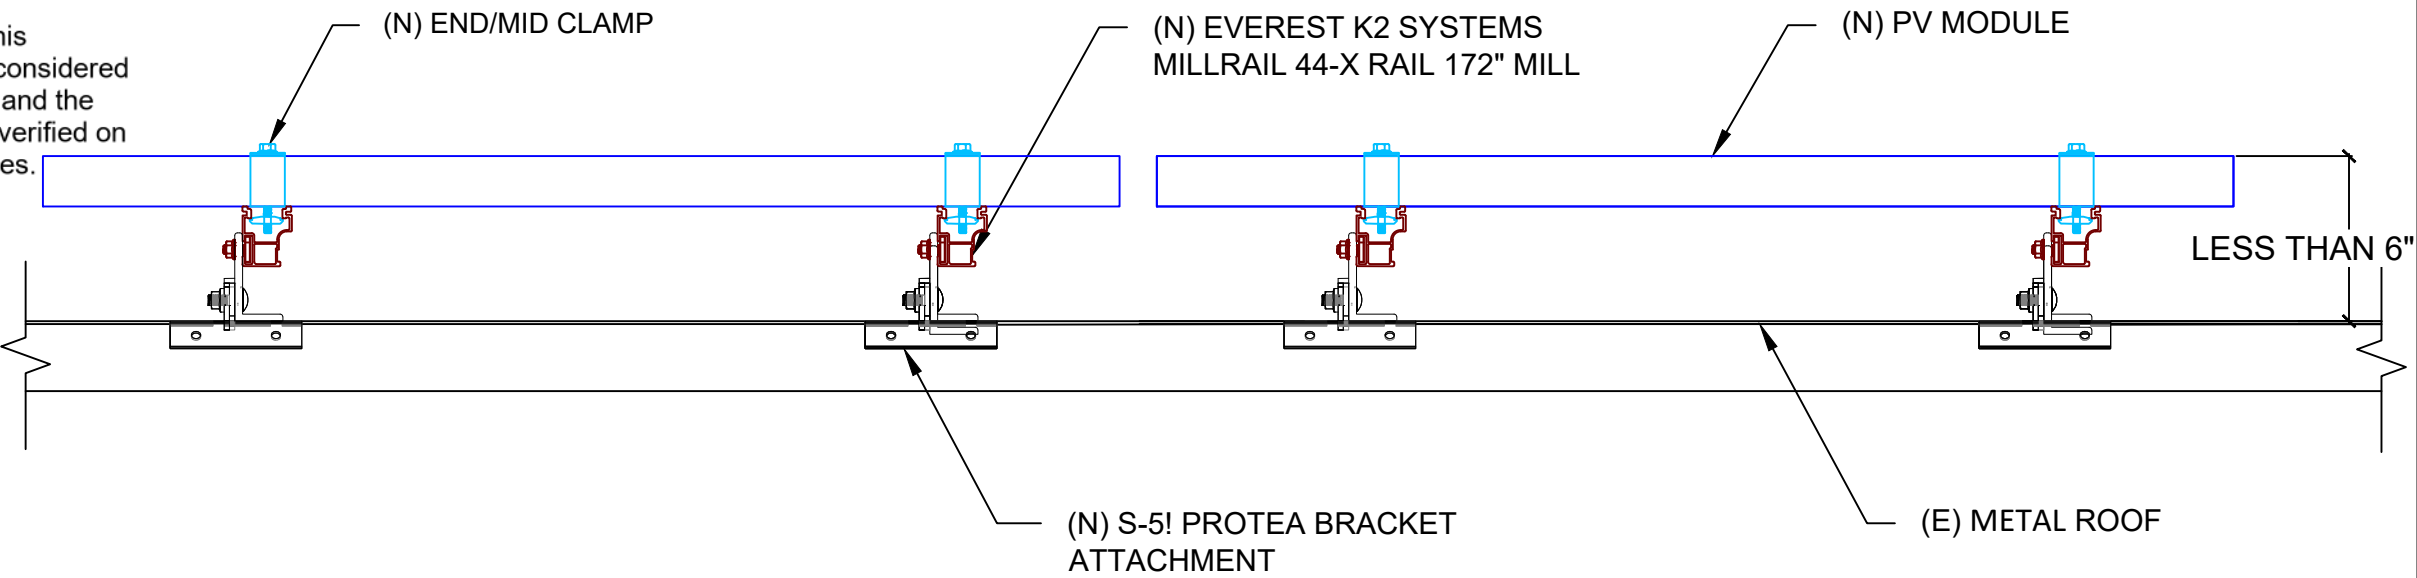

1 STRUCTURAL ATTACMENT (SIDE VIEW)

PV-5

SCALE: N.T.S.

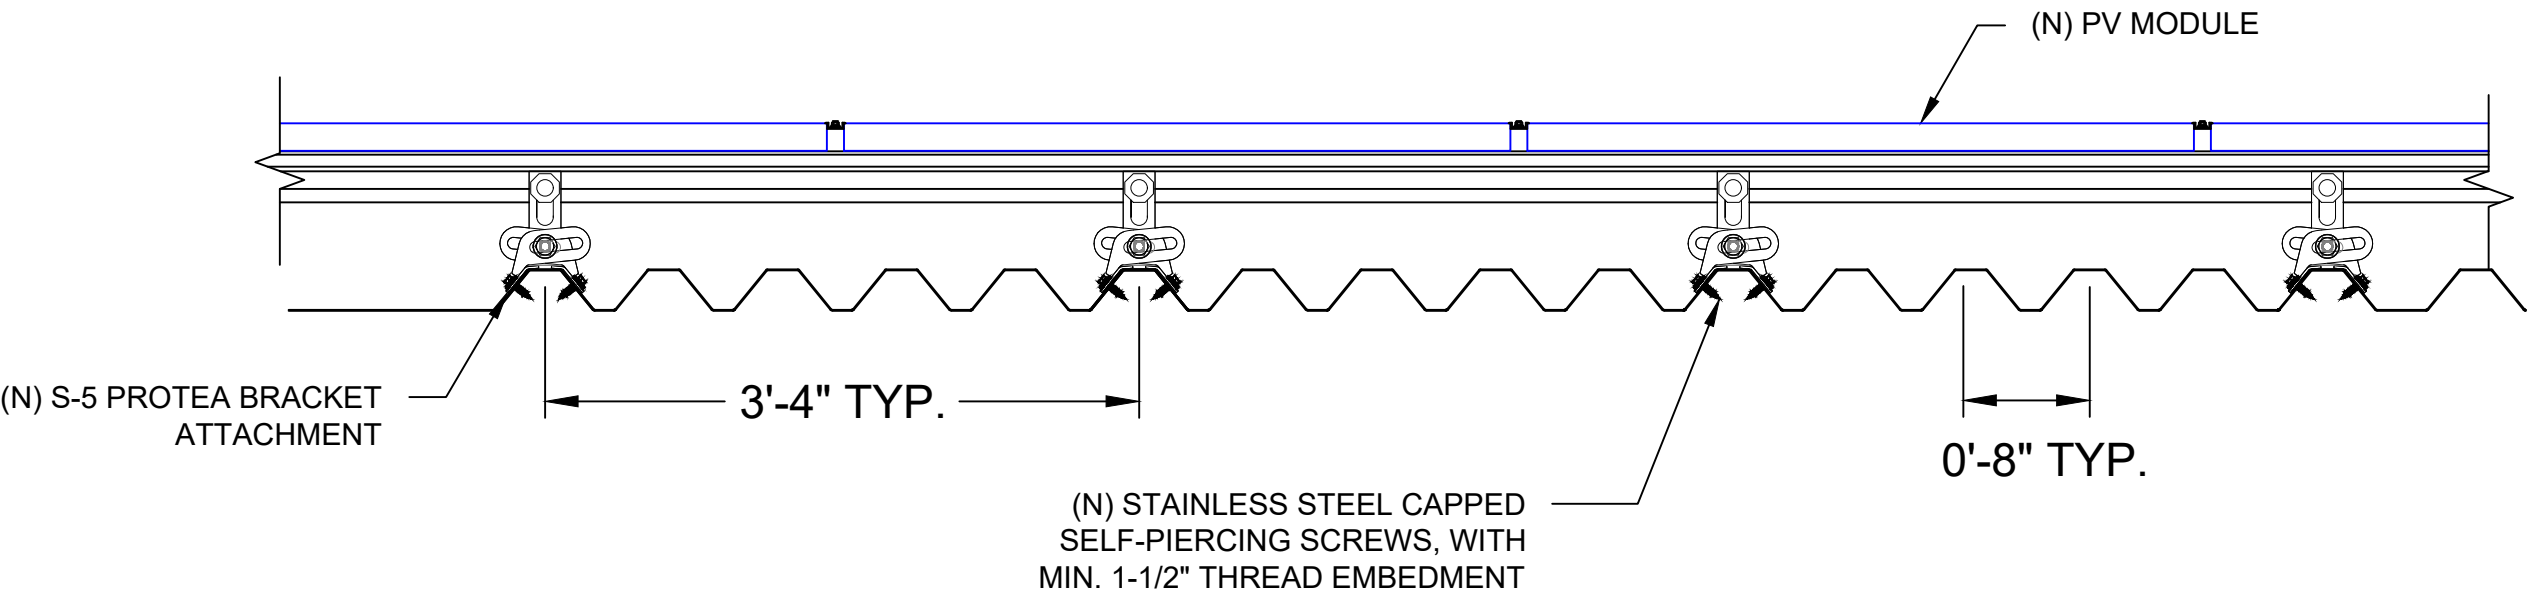

2 ATTACHMENT DETAIL (FRONT VIEW)


PV-5

SCALE: N.T.S.

LUNEX POWER
THE PURE SOURCE

LUNEX POWER INC.
4721 N GRADY AVE
TAMPA FL 33614
LIC #: CVC57085
PHONE: 813-540-8807

REVISIONS		
DESCRIPTION	DATE	REV
CLIENT COMMENT	02/08/2024	A
CLIENT COMMENT	02/12/2024	B

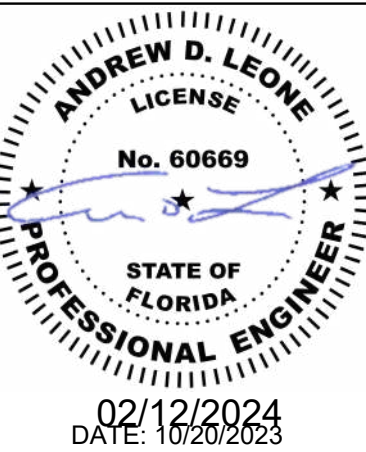

PROJECT NAME & ADDRESS

MARY W WILDS
RESIDENCE
131 NW KATELYN WAY,
LAKE CITY, FL 32055

DRAWN BY
ESR

SHEET NAME
STRUCTURAL DETAIL

 
SHEET SIZE
ANSI B
11" X 17"

SHEET NUMBER
PV-5

(1) BRANCH CIRCUIT OF 11 MODULES AND
(1) BRANCH CIRCUIT OF 10 MODULES ARE CONNECTED IN PARALLEL

6. AC DISCONNECT NOTED IN EQUIPMENT SCHEDULE OPTIONAL IF OTHER AC DISCONNECTING MEANS IS LOCATED WITHIN 10' OF SERVICE DISCONNECT.

7. RACEWAYS AND CABLES EXPOSED TO SUNLIGHT ON ROOFTOPS SHOULD BE INSTALLED MORE THAN 7/8" ABOVE THE ROOF USING CONDUIT SUPPORTS.



QTY	CONDUCTOR INFORMATION		CONDUIT TYPE	CONDUIT SIZE
1	(4)	CU#12AWG - Q CABLE (L1 & L2 NO NEUTRAL)	N/A	N/A
	(1)	CU#6AWG - BARE COPPER IN FREE AIR		
2	(4)	CU#10AWG - THWN-2 (L1,L2) (EXTERIOR) / #12/2 ROMEX IN ATTIC	EMT, LFMC IN ATTIC	3/4"
	(1)	CU#10AWG - THWN-2 GND		
	(2)	CU#8AWG - THWN-2 (L1,L2)		
3	(1)	CU#8AWG - THWN-2 N	EMT, LFMC OR LFNC	3/4"
	(1)	CU#10AWG - THWN-2 GND		
	(2)	CU#8AWG - THWN-2 (L1,L2)		
4	(1)	CU#8AWG - THWN-2 N	EMT, LFMC OR LFNC	3/4"
	(1)	CU#10AWG - THWN-2 GND		

SHEET NUMBER
PV-6

INVERTER SPECIFICATIONS	
MANUFACTURER / MODEL #	ENPHASE: IQ8PLUS-72-2-US (240V) MICROINVERTERS (COMPLIANT WITH RAPID SHUTDOWN)
MIN/MAX DC VOLT RATING	30V MIN/ 58V MAX
MAX INPUT POWER	235W-440W
NOMINAL AC VOLTAGE RATING	240V/ 211-264V
MAX AC CURRENT	1.21A
MAX MODULES PER CIRCUIT	13 (SINGLE PHASE)
MAX OUTPUT POWER	290 VA

SOLAR MODULE SPECIFICATIONS	
MANUFACTURER / MODEL #	HANWHA SOLAR: Q.PEAK DUO BLK ML-G10+ 400W MODULE
VMP	37.13V
IMP	10.77A
VOC	45.30V
ISC	11.14A
TEMP. COEFF. VOC	-0.27%/K
MODULE DIMENSION	74.0"L x 41.1"W x 1.26"D (In Inch)

AMBIENT TEMPERATURE SPECS	
RECORD LOW TEMP	-5°
AMBIENT TEMP (HIGH TEMP 2%)	34°
MODULE TEMPERATURE COEFFICIENT OF Voc	
-0.27%/K	

PERCENT OF VALUES	NUMBER OF CURRENT CARRYING CONDUCTORS IN EMT
.80	4-6
.70	7-9
.50	10-20

AC CALCULATIONS

CIRCUIT ORIGIN	CIRCUIT DESTINATION	VOLTAGE (V)	FULL LOAD AMPS "FLA" (A)	FLA*1.25 (A)	OCPD SIZE (A)	NEUTRAL SIZE	GROUND SIZE	CONDUCTOR SIZE	75°C AMPACITY (A)	AMPACITY CHECK #1	AMBIENT TEMP. (°C)	TOTAL CC CONDUCTORS IN RACEWAY	90°C AMPACITY (A)	DERATION FACTOR FOR AMBIENT TEMPERATURE NEC 310.15(B)(2)(a)	DERATION FACTOR FOR CONDUCTORS PER RACEWAY NEC 310.15(B)(3)(a)	90°C AMPACITY DERATED (A)	AMPACITY CHECK #2	FEEDER LENGTH (FEET)	CONDUCTOR RESISTANCE (OHM/KFT)	VOLTAGE DROP AT FLA (%)	CONDUIT SIZE	CONDUIT FILL (%)
CIRCUIT 1	SOLADECK	240	13.31	16.6375	20	N/A	BARE COPPER #6 AWG	CU #12 AWG	25	PASS	34	2	30	0.96	1	28.8	PASS		0.55	N/A	N/A	
CIRCUIT 2	SOLADECK	240	12.1	15.125	20	N/A	BARE COPPER #6 AWG	CU #12 AWG	25	PASS	34	2	30	0.96	1	28.8	PASS		0.46	N/A	N/A	
JUNCTION BOX	COMBINER BOX	240	13.31	16.6375	20	N/A	CU #10 AWG	CU #10 AWG	35	PASS	34	4	40	0.96	0.8	30.72	PASS	24	1.24	0.330	3/4" EMT	19.79362
COMBINER BOX	AC DISCONNECT	240	25.41	31.7625	35	CU #8 AWG	CU #10 AWG	CU #8 AWG	50	PASS	34	2	55	0.96	1	52.8	PASS	5	0.778	0.082	3/4" EMT	24.5591
AC DISCONNECT	POI	240	25.41	31.7625	35	CU #8 AWG	CU #10 AWG	CU #8 AWG	50	PASS	34	2	55	0.96	1	52.8	PASS	5	0.778	0.082	3/4" EMT	24.5591


Circuit 1 Voltage Drop	1.045
Circuit 2 Voltage Drop	0.955

This item has been digitally signed and sealed by Andrew D. Leone on the date adjacent to the seal.

Printed copies of this document are not considered signed and sealed and the signature must be verified on any electronic copies.


ELECTRICAL NOTES

- ALL EQUIPMENT TO BE LISTED BY UL OR OTHER NRTL, AND LABELED FOR ITS APPLICATION.
- ALL CONDUCTORS SHALL BE COPPER, RATED FOR 600 V AND 90 DEGREE C WET ENVIRONMENT.
- WIRING, CONDUIT, AND RACEWAYS MOUNTED ON ROOFTOPS SHALL BE ROUTED DIRECTLY TO, AND LOCATED AS CLOSE AS POSSIBLE TO THE NEAREST RIDGE, HIP, OR VALLEY.
- WORKING CLEARANCES AROUND ALL NEW AND EXISTING ELECTRICAL EQUIPMENT SHALL COMPLY WITH NEC 110.26.
- DRAWINGS INDICATE THE GENERAL ARRANGEMENT OF SYSTEMS. CONTRACTOR SHALL FURNISH ALL NECESSARY OUTLETS, SUPPORTS, FITTINGS AND ACCESSORIES TO FULFILL APPLICABLE CODES AND STANDARDS.
- WHERE SIZES OF SOLADECK, RACEWAYS, AND CONDUITS ARE NOT SPECIFIED, THE CONTRACTOR SHALL SIZE THEM ACCORDINGLY.
- ALL WIRE TERMINATIONS SHALL BE APPROPRIATELY LABELED AND READILY VISIBLE.
- MODULE GROUNDING CLIPS TO BE INSTALLED BETWEEN MODULE FRAME AND MODULE SUPPORT RAIL, PER THE GROUNDING CLIP MANUFACTURER'S INSTRUCTION.
- MODULE SUPPORT RAIL TO BE BONDED TO CONTINUOUS COPPER G.E.C. VIA WEEB LUG OR ILSCO GBL-4DBT LAY-IN LUG.
- TEMPERATURE RATINGS OF ALL CONDUCTORS, TERMINATIONS, BREAKERS, OR OTHER DEVICES ASSOCIATED WITH THE SOLAR PV SYSTEM SHALL BE RATED FOR AT LEAST 75 DEGREE C.

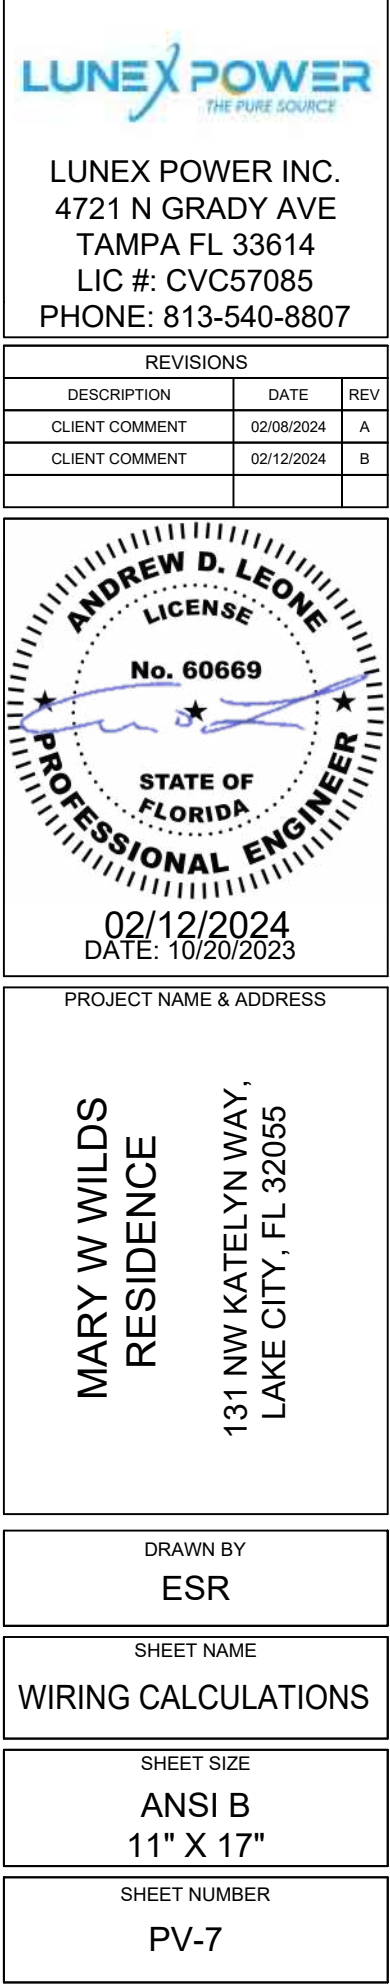

LUNEX POWER INC.
4721 N GRADY AVE
TAMPA FL 33614
LIC #: CVC57085
PHONE: 813-540-8807

REVISIONS		
DESCRIPTION	DATE	REV
CLIENT COMMENT	02/08/2024	A
CLIENT COMMENT	02/12/2024	B

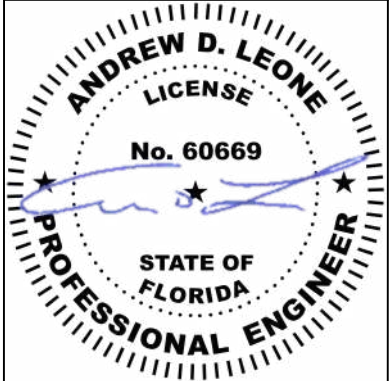

02/12/2024
DATE: 10/20/2023

PROJECT NAME & ADDRESS

MARY W WILDS
RESIDENCE
131 NW KATELYN WAY,
LAKE CITY, FL 32055

DRAWN BY
ESR

SHEET NAME
WIRING CALCULATIONS

SHEET SIZE
ANSI B
11" X 17"

SHEET NUMBER
PV-7

CAUTION:
AUTHORIZED SOLAR
PERSONNEL ONLY!

LABEL-1:
LABEL LOCATION:
AC DISCONNECT

 **WARNING**

ELECTRICAL SHOCK HAZARD

TERMINALS ON THE LINE AND LOAD SIDES MAY
BE ENERGIZED IN THE OPEN POSITION

LABEL- 2:
LABEL LOCATION:
AC DISCONNECT
COMBINER
MAIN SERVICE PANEL
SUBPANEL
MAIN SERVICE DISCONNECT
CODE REF: NEC 690.13(B)

 **WARNING DUAL POWER SOURCE
SECOND SOURCE IS PHOTOVOLTAIC SYSTEM**

LABEL- 3:
LABEL LOCATION:
PRODUCTION METER
UTILITY METER
MAIN SERVICE PANEL
SUBPANEL
CODE REF: NEC 705.12(C) & NEC 690.59

 **WARNING**

**TURN OFF PHOTOVOLTAIC AC
DISCONNECT PRIOR TO
WORKING INSIDE PANEL**

LABEL- 4:
LABEL LOCATION:
MAIN SERVICE PANEL
SUBPANEL
MAIN SERVICE DISCONNECT
COMBINER
CODE REF: NEC 110.27(C) & OSHA 1910.145 (f) (7)

 **CAUTION**

**PHOTOVOLTAIC SYSTEM CIRCUIT IS
BACKFEED**

LABEL- 5:
LABEL LOCATION:
MAIN SERVICE PANEL (ONLY IF SOLAR IS BACK-FED)
SUBPANEL (ONLY IF SOLAR IS BACK-FED)
CODE REF: NEC 705.12(D) & NEC 690.59


 **WARNING**

**POWER SOURCE OUTPUT
CONNECTION. DO NOT
RELOCATE THIS
OVERCURRENT DEVICE**

LABEL- 6:
LABEL LOCATION:
MAIN SERVICE PANEL (ONLY IF SOLAR IS BACK-FED)
SUBPANEL (ONLY IF SOLAR IS BACK-FED)
CODE REF: NEC 705.12(B)(3)(2)

**SOLAR PV SYSTEM EQUIPPED
WITH RAPID SHUTDOWN**

TURN RAPID SHUTDOWN
SWITCH TO THE
"OFF" POSITION TO
SHUT DOWN PV SYSTEM
AND REDUCE
SHOCK HAZARD
IN THE ARRAY

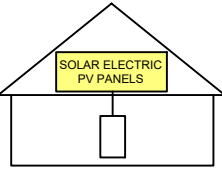

LABEL- 7:
LABEL LOCATION:
AC DISCONNECT
CODE REF: IFC 605.11.3.1(1) & NEC 690.56(C)

**RAPID SHUTDOWN SWITCH
FOR SOLAR PV SYSTEM**

LABEL- 8:
LABEL LOCATION:
AC DISCONNECT
CODE REF: NEC 690.56(C)(2)

PHOTOVOLTAIC

AC DISCONNECT

LABEL- 9:
LABEL LOCATION:
AC DISCONNECT
CODE REF: NEC 690.13(B)

**PHOTOVOLTAIC
AC DISCONNECT**

NOMINAL OPERATING AC VOLATGE **240 V**

RATED AC OUTPUT CURRENT **25.41 A**

LABEL- 10:
LABEL LOCATION:
MAIN SERVICE PANEL
SUBPANEL
AC DISCONNECT
CODE REF: NEC 690.54

**MAIN PHOTOVOLTAIC
SYSTEM DISCONNECT**

LABEL- 11:
LABEL LOCATION:
MAIN SERVICE DISCONNECT (ONLY IF MAIN SERVICE DISCONNECT IS PRESENT)
CODE REF: NEC 690.13(B)

**PRODUCTION
METER**

LABEL- 12:
LABEL LOCATION:
PRODUCTION METER (ONLY IF PRODUCTION METER IS USED)

**CAUTION: PHOTOVOLTAIC SYSTEM
FOR SERVICE : LUNEX POWER
813-540-8807**


LABEL-13:

**WARNING: PHOTOVOLTAIC
POWER SOURCE**

LABEL-14:
LABEL LOCATION:
EMT/CONDUIT RACEWAY
SOLADECK/JUNCTION BOX
CODE REF : NEC 690.31 (D) (14)

**EMERGENCY RESPONDER
THIS SOLAR PV SYSTEM EQUIPPED
WITH RAPID SHUTDOWN**

TURN RAPID SHUTDOWN
SWITCH TO THE 'OFF'
POSITION TO SHUTDOWN
ENTIRE PV SYSTEM.

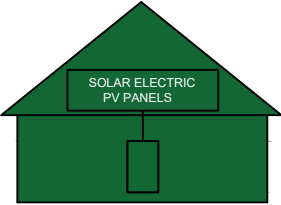

THE LABEL SHALL BE REFLECTIVE, WITH ALL LETTERS CAPITALIZED AND HAVING
A MINIMUM HEIGHT OF 3/8 IN. (9.5 MM), IN WHITE ON A RED BACKGROUND.

LABEL- 15:
LABEL LOCATION:
AC DISCONNECT
CODE REF:NFPA 1 (11.12.2.1.1.1.1)
1. THE RAPID SHUTDOWN LABEL SHALL BE LOCATED ON OR NO MORE
THAN 3 FT (1 M) FROM THE SERVICE DISCONNECTING MEANS
2. (HEIGHT OF LABEL IS 3/8 IN. (9.5 MM), IN WHITE ON A RED BACKGROUND)


This item has been digitally
signed and sealed by
Andrew D. Leone on the date
adjacent to the seal.

Printed copies of this
document are not considered
signed and sealed and the
signature must be verified on
any electronic copies.



LUNEX POWER INC.
4721 N GRADY AVE
TAMPA FL 33614
LIC #: CVC57085
PHONE: 813-540-8807

REVISIONS		
DESCRIPTION	DATE	REV
CLIENT COMMENT	02/08/2024	A
CLIENT COMMENT	02/12/2024	B

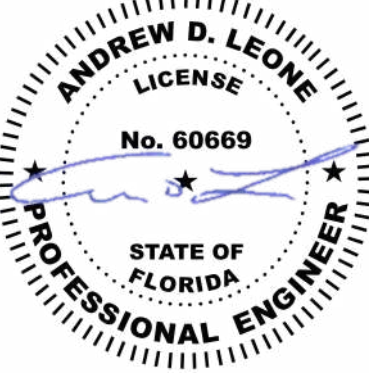


02/12/2024
DATE: 10/20/2023

PROJECT NAME & ADDRESS

MARY W WILDS
RESIDENCE

131 NW KATELYN WAY,
LAKE CITY, FL 32055

DRAWN BY ESR
SHEET NAME LABELS
SHEET SIZE ANSI B 11" X 17"
SHEET NUMBER PV-8

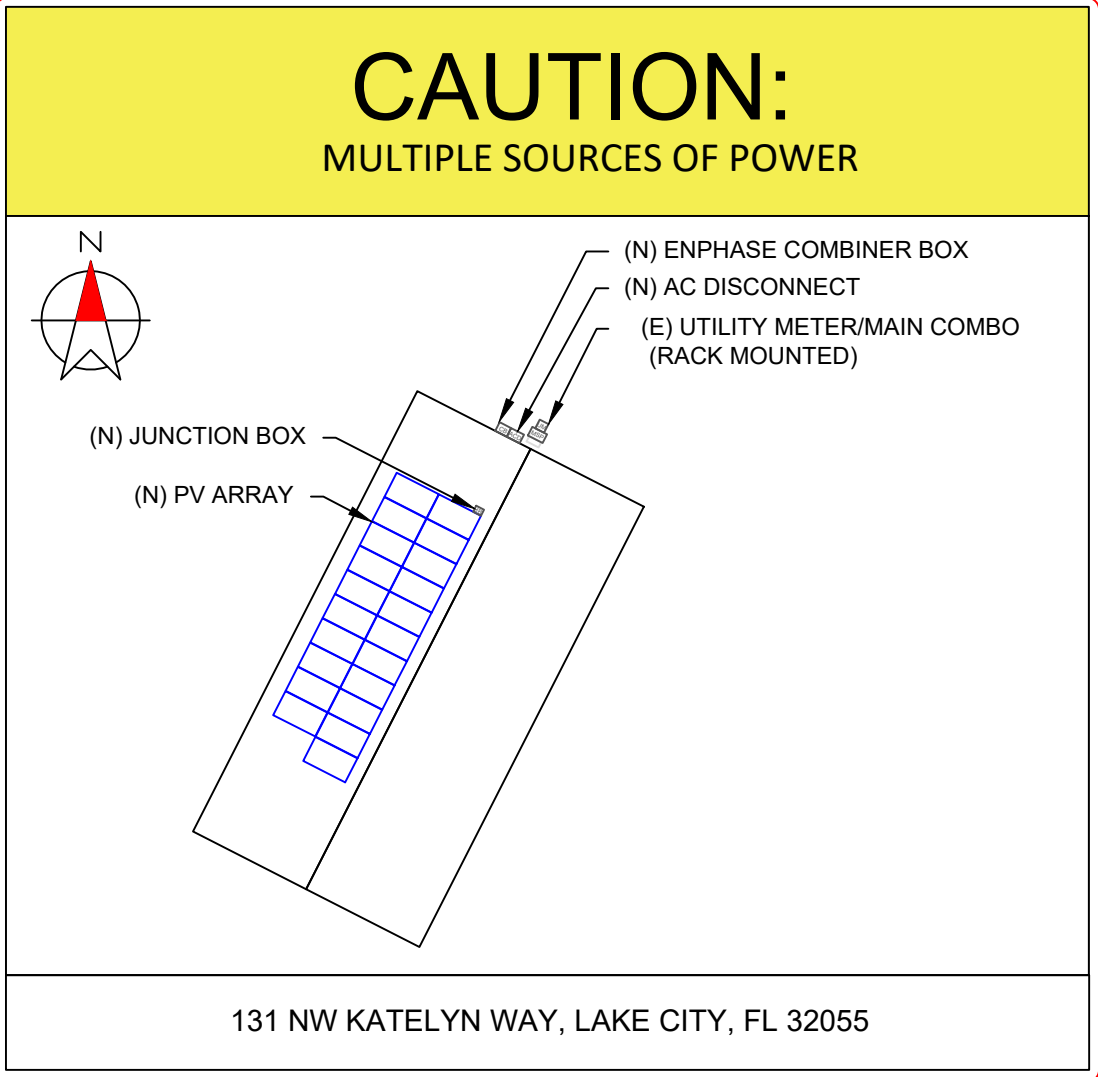

DIRECTORY
PERMANENT PLAQUE OR DIRECTORY PROVIDING THE LOCATION OF THE
SERVICE DISCONNECTING MEANS AND THE PHOTOVOLTAIC SYSTEM.

(ALL PLAQUES AND SIGNAGE WILL BE INSTALLED AS OUTLINED WITHIN:
NEC 690.56(B)&(C), [NEC 705.10])

This item has been digitally
signed and sealed by
Andrew D. Leone on the date
adjacent to the seal.

Printed copies of this
document are not considered
signed and sealed and the
signature must be verified on
any electronic copies.


LABELING NOTES:

1. LABELS CALLED OUT ACCORDING TO ALL COMMON CONFIGURATIONS. ELECTRICIAN TO DETERMINE EXACT REQUIREMENTS IN THE FIELD PER CURRENT NEC AND LOCAL CODES AND MAKE APPROPRIATE ADJUSTMENTS.
2. LABELING REQUIREMENTS BASED ON THE 2020 NATIONAL ELECTRIC CODE, OSHA STANDARD 19010.145, ANSI Z535.
3. MATERIAL BASED ON THE REQUIREMENTS OF THE AUTHORITY HAVING JURISDICTION.
4. LABELS TO BE OF SUFFICIENT DURABILITY TO WITHSTAND THE ENVIRONMENT INVOLVED [NEC 110.21]
5. LABELS TO BE A MINIMUM LETTER HEIGHT OF 3/8", WHITE ON RED BACKGROUND; REFLECTIVE, AND PERMANENTLY AFFIXED [IFC 605.11.1.1]



LUNEX POWER INC.
4721 N GRADY AVE
TAMPA FL 33614
LIC #: CVC57085
PHONE: 813-540-8807

REVISIONS		
DESCRIPTION	DATE	REV
CLIENT COMMENT	02/08/2024	A
CLIENT COMMENT	02/12/2024	B

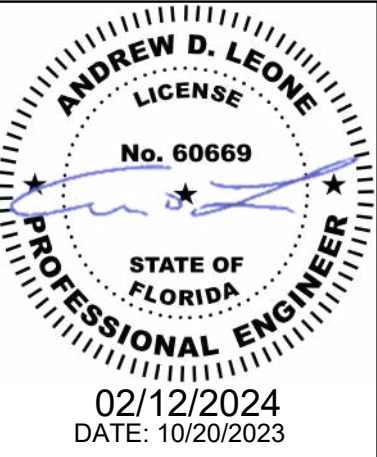

PROJECT NAME & ADDRESS


MARY W WILDS
RESIDENCE
131 NW KATELYN WAY,
LAKE CITY, FL 32055

DRAWN BY
ESR


SHEET NAME
PLACARD

SHEET SIZE
ANSI B
11" X 17"

SHEET NUMBER
PV-9

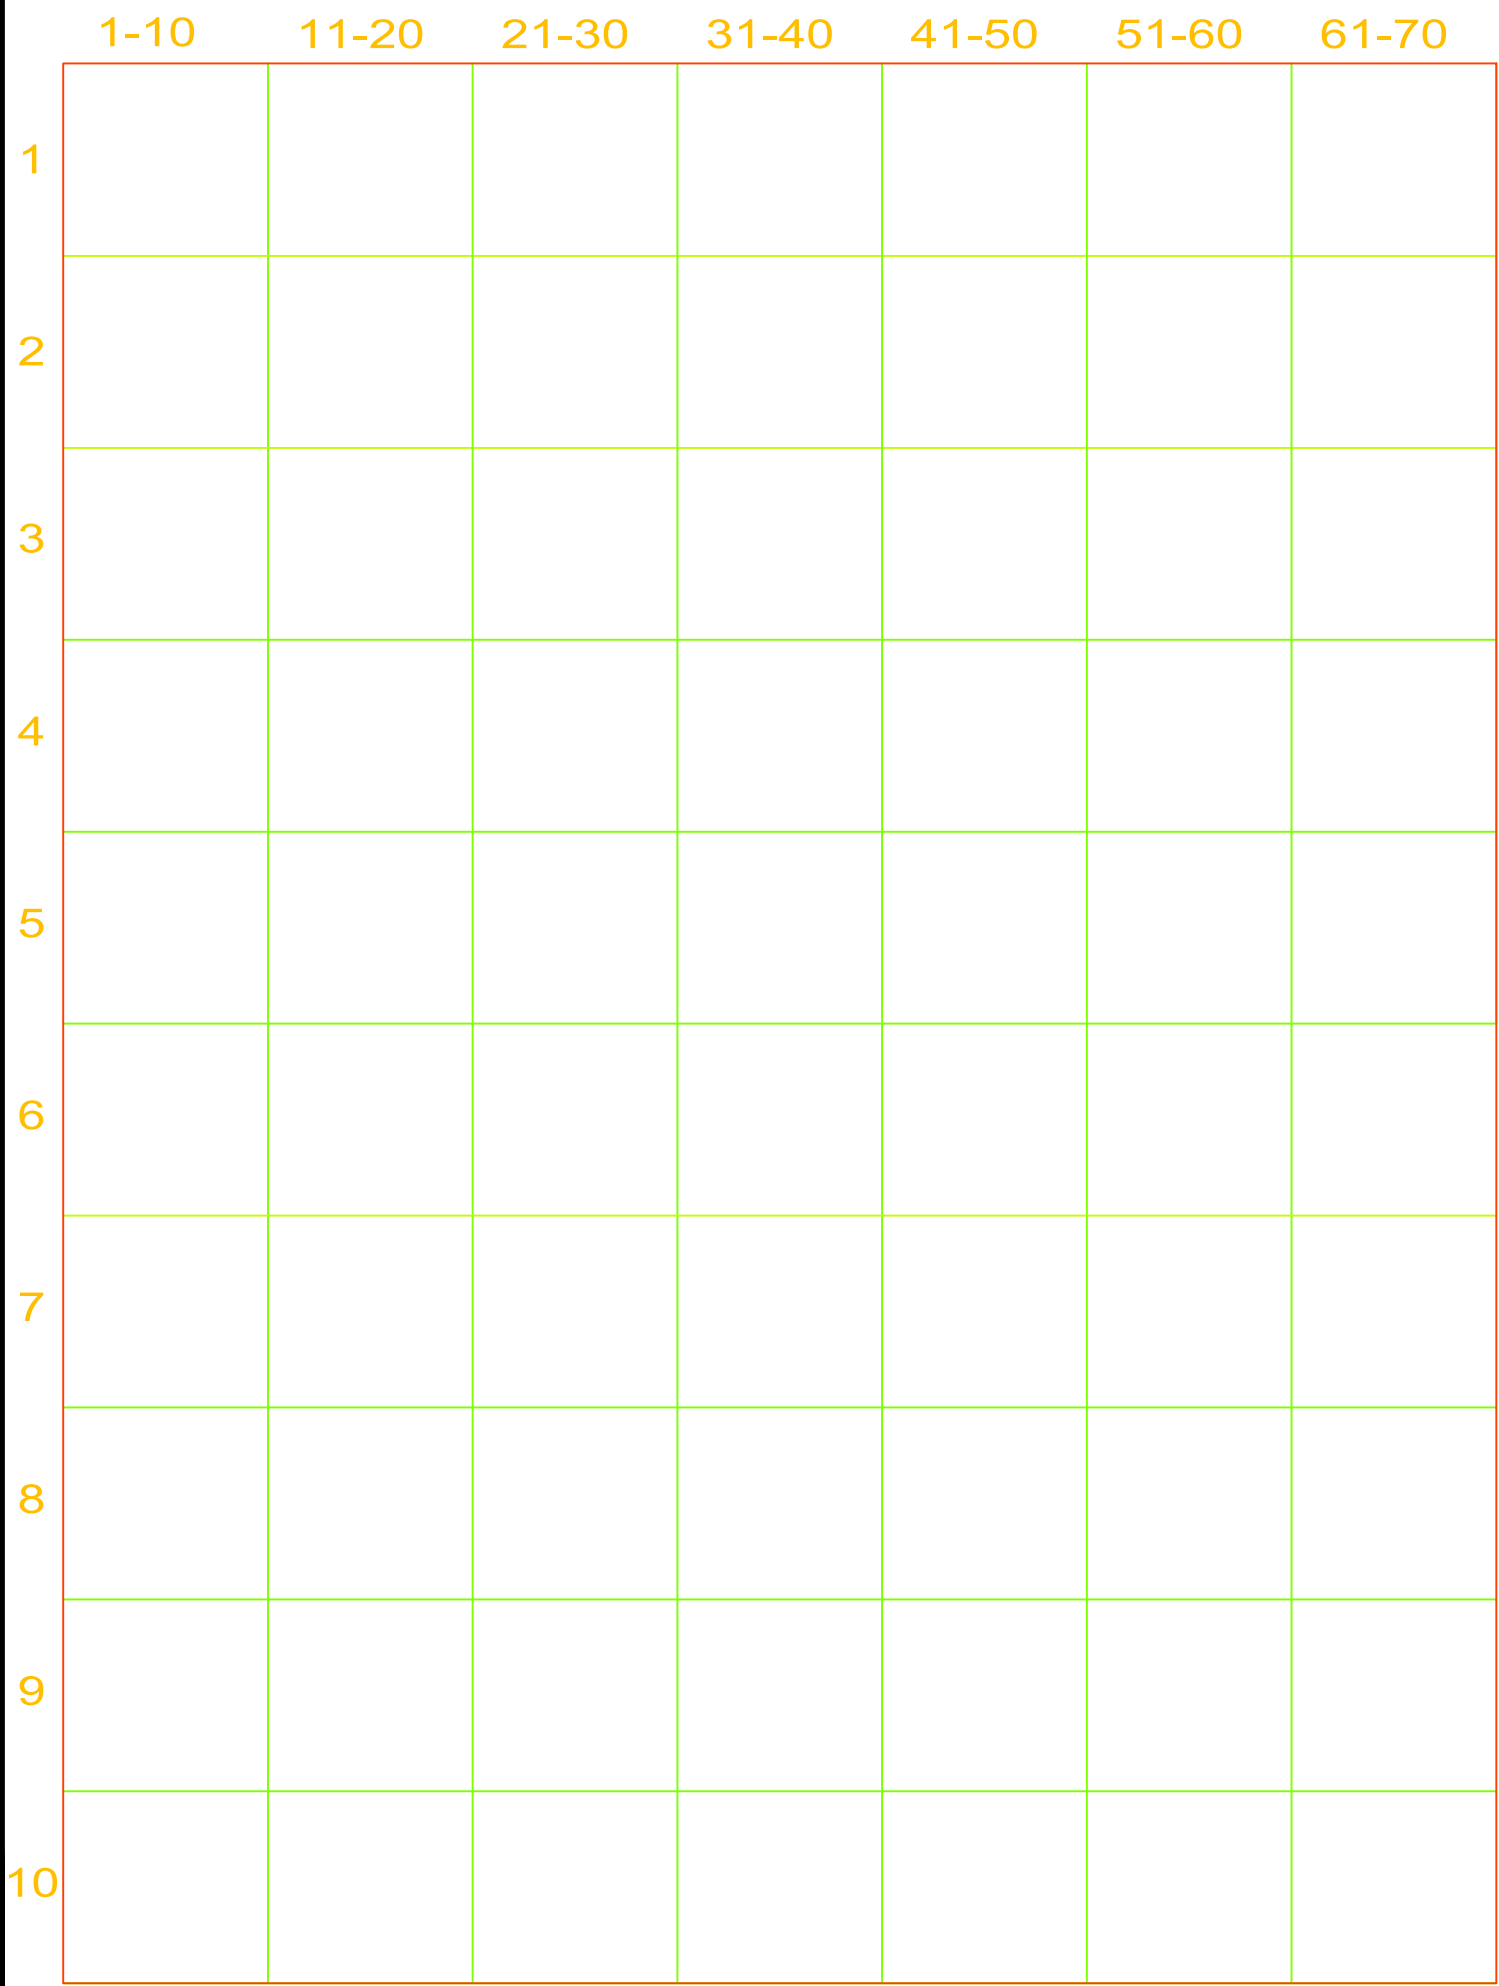

MICRO INVERTER CHART

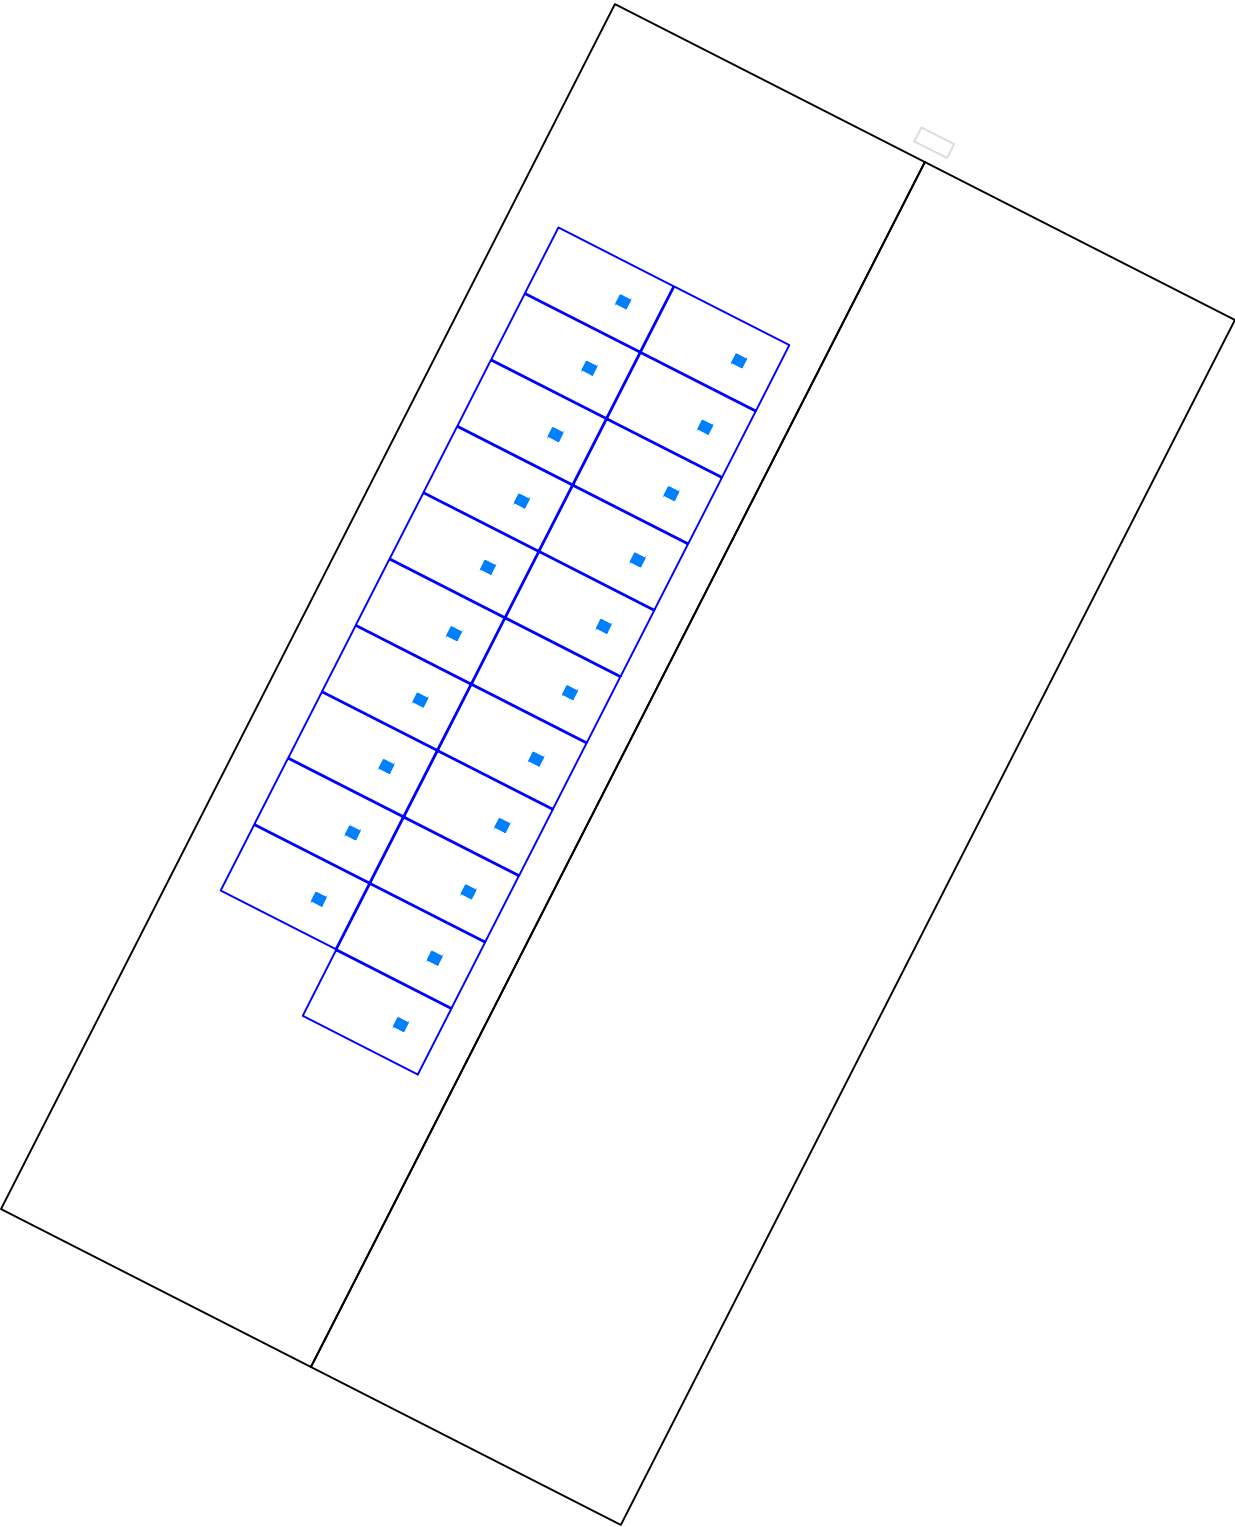



LUNEX POWER INC.
4721 N GRADY AVE
TAMPA FL 33614
LIC #: CVC57085
PHONE: 813-540-8807

REVISIONS		
DESCRIPTION	DATE	REV
CLIENT COMMENT	02/08/2024	A
CLIENT COMMENT	02/12/2024	B

DATE: 10/20/2023

PROJECT NAME & ADDRESS

MARY W WILDS
RESIDENCE

131 NW KATELYN WAY,
LAKE CITY, FL 32055

DRAWN BY

ESR

SHEET NAME


MICRO INVERTER CHART

SHEET SIZE

ANSI B
11" X 17"

SHEET NUMBER

PV-10

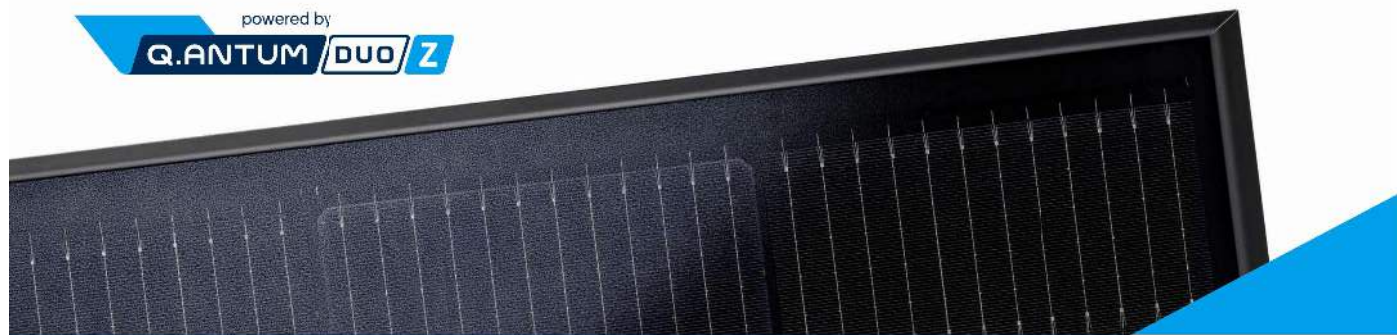

Q.PEAK DUO BLK ML-G10+
385-405
ENDURING HIGH
PERFORMANCE



BREAKING THE 20% EFFICIENCY BARRIER
Q.ANTUM DUO Z Technology with zero gap cell layout boosts module efficiency up to 20.9%.



THE MOST THOROUGH TESTING PROGRAMME IN THE INDUSTRY
Q CELLS is the first solar module manufacturer to pass the most comprehensive quality programme in the industry: The new "Quality Controlled PV" of the independent certification institute TÜV Rheinland.



INNOVATIVE ALL-WEATHER TECHNOLOGY
Optimal yields, whatever the weather with excellent low-light and temperature behavior.



ENDURING HIGH PERFORMANCE
Long-term yield security with Anti LID Technology, Anti PID Technology¹, Hot-Spot Protect and Traceable Quality Tra.Q™.



EXTREME WEATHER RATING
High-tech aluminum alloy frame, certified for high snow (5400 Pa) and wind loads (4000 Pa).



A RELIABLE INVESTMENT
Inclusive 25-year product warranty and 25-year linear performance warranty².

¹ APT test conditions according to IEC/TS 62804-1:2015, method A (-1500 V, 96h)
² See data sheet on rear for further information.



THE IDEAL SOLUTION FOR:




Engineered in Germany



MECHANICAL SPECIFICATION

Format	74.0 in × 41.1 in × 1.26 in (including frame) (1879 mm × 1045 mm × 32 mm)
Weight	48.5 lbs (22.0 kg)
Front Cover	0.13 in (3.2 mm) thermally pre-stressed glass with anti-reflection technology
Back Cover	Composite film
Frame	Black anodized aluminum
Cell	6 × 22 monocrystalline Q.ANTUM solar half cells
Junction Box	2.09-3.98 in × 1.26-2.36 in × 0.59-0.71 in (53-101 mm × 32-60 mm × 15-18 mm), IP67, with bypass diodes
Cable	4 mm ² Solar cable; (+) ≥ 49.2 in (1250 mm), (-) ≥ 49.2 in (1250 mm)
Connector	Stäubli MC4; IP68

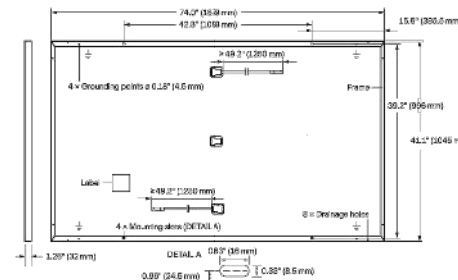


ELECTRICAL CHARACTERISTICS

POWER CLASS		385	390	395	400	405
MINIMUM PERFORMANCE AT STANDARD TEST CONDITIONS, STC ¹ (POWER TOLERANCE +5 W / -0 W)						
Power at MPP ²	P _{MPP} [W]	385	390	395	400	405
Short Circuit Current ⁴	I _{SC} [A]	11.04	11.07	11.10	11.14	11.17
Open Circuit Voltage ⁴	V _{OC} [V]	45.19	45.23	45.27	45.30	45.34
Current at MPP	I _{MPP} [A]	10.59	10.65	10.71	10.77	10.83
Voltage at MPP	V _{MPP} [V]	36.36	36.62	36.88	37.13	37.39
Efficiency ⁴	η [%]	≥ 19.6	≥ 19.9	≥ 20.1	≥ 20.4	≥ 20.6
MINIMUM PERFORMANCE AT NORMAL OPERATING CONDITIONS, NMOT ²						
Power at MPP	P _{MPP} [W]	288.8	292.6	296.3	300.1	303.8
Short Circuit Current	I _{SC} [A]	8.90	8.92	8.95	8.97	9.00
Open Circuit Voltage	V _{OC} [V]	42.62	42.65	42.69	42.72	42.76
Current at MPP	I _{MPP} [A]	8.35	8.41	8.46	8.51	8.57
Voltage at MPP	V _{MPP} [V]	34.59	34.81	35.03	35.25	35.46

¹ Measurement tolerances P_{MPP} ± 3%; I_{SC}, V_{OC} ± 5% at STC: 1000 W/m², 25 ± 2 °C, AM 1.5 according to IEC 60904-3 • ² 800 W/m², NMOT, spectrum AM 1.5


Q CELLS PERFORMANCE WARRANTY

PERFORMANCE AT LOW IRRADIANCE

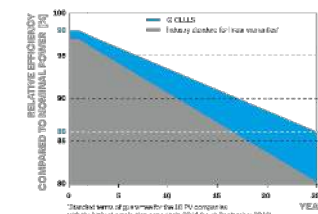

At least 98% of nominal power during first year. Thereafter max. 0.5% degradation per year. At least 93.5% of nominal power up to 10 years. At least 86% of nominal power up to 25 years.

All data within measurement tolerances. Full warranties in accordance with the warranty terms of the Q CELLS sales organisation of your respective country.

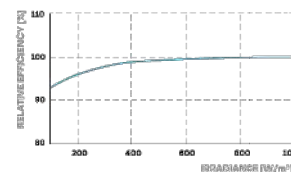

Typical module performance under low irradiance conditions in comparison to STC conditions (25 °C, 1000 W/m²)

TEMPERATURE COEFFICIENTS

Temperature Coefficient of I _{SC}	α [%/K]	+0.04	Temperature Coefficient of V _{OC}	β [%/K]	-0.27
Temperature Coefficient of P _{MPP}	γ [%/K]	-0.34	Nominal Module Operating Temperature	NMOT [°F]	109 ± 5.4 (43 ± 3 °C)

PROPERTIES FOR SYSTEM DESIGN

Maximum System Voltage V _{sys}	[V]	1000 (IEC)/1000 (UL)	PV module classification	Class II
Maximum Series Fuse Rating	[A DC]	20	Fire Rating based on ANSI / UL 61730	TYPE 2
Max. Design Load, Push / Pull ³	[lbs/ft ²]	75 (3600 Pa) / 55 (2660 Pa)	Permitted Module Temperature on Continuous Duty	-40 °F up to +185 °F (-40 °C up to +85 °C)
Max. Test Load, Push / Pull ³	[lbs/ft ²]	113 (5400 Pa) / 84 (4000 Pa)		

³ See Installation Manual

QUALIFICATIONS AND CERTIFICATES

UL 61730, CE-compliant,
Quality Controlled PV - TÜV Rheinland,
IEC 61215:2016, IEC 61730:2016,
U.S. Patent No. 9,893,215 (solar cells),
QCPV Certification ongoing.



	Horizontal packaging	Vertical packaging	Vertical packaging	Weight	Pallets	Modules
	76.4 in 1940 mm	43.3 in 1100 mm	48.0 in 1220 mm	1856 lbs 761 kg	24 pallets	32 modules

Note: Installation instructions must be followed. See the installation and operating manual or contact our technical service department for further information on approved installation and use of this product.

Hanwha Q CELLS America Inc.

400 Spectrum Center Drive, Suite 1400, Irvine, CA 92618, USA | TEL +1 949 748 59 96 | EMAIL inquiry@us.q-cells.com | WEB www.q-cells.us



LUNEX POWER INC.
4721 N GRADY AVE
TAMPA FL 33614
LIC #: CVC57085
PHONE: 813-540-8807

REVISIONS

DESCRIPTION	DATE	REV
CLIENT COMMENT	02/08/2024	A
CLIENT COMMENT	02/12/2024	B

DATE: 10/20/2023

PROJECT NAME & ADDRESS

MARY W WILDS
RESIDENCE
131 NW KATELYN WAY,
LAKE CITY, FL 32055

DRAWN BY
ESR

SHEET NAME
EQUIPMENT
SPECIFICATION

SHEET SIZE
ANSI B
11" X 17"

SHEET NUMBER
PV-11

Specifications subject to technical changes © Q CELLS Q.PEAK DUO BLK ML-G10+ 385-405 2021.05 Rev01_1A



DATA SHEET



IQ8 and IQ8+ Microinverters

Our newest IQ8 Microinverters are the industry’s first microgrid-forming, software-defined microinverters with split-phase power conversion capability to convert DC power to AC power efficiently. The brain of the semiconductor-based microinverter is our proprietary application-specific integrated circuit (ASIC) which enables the microinverter to operate in grid-tied or off-grid modes. This chip is built in advanced 55nm technology with high speed digital logic and has super-fast response times to changing loads and grid events, alleviating constraints on battery sizing for home energy systems.



Part of the Enphase Energy System, IQ8 Series Microinverters integrate with the Enphase IQ Battery, Enphase IQ Gateway, and the Enphase App monitoring and analysis software.



IQ8 Series Microinverters redefine reliability standards with more than one million cumulative hours of power-on testing, enabling an industry-leading limited warranty of up to 25 years.



Connect PV modules quickly and easily to IQ8 Series Microinverters using the included Q-DCC-2 adapter cable with plug-n-play MC4 connectors.



IQ8 Series Microinverters are UL Listed as PV Rapid Shut Down Equipment and conform with various regulations, when installed according to manufacturer’s instructions.

© 2022 Enphase Energy. All rights reserved. Enphase, the Enphase logo, IQ8 Microinverters, and other names are trademarks of Enphase Energy, Inc. Data subject to change.

IQ8SP-DS-0002-01-EN-US-2022-03-17

Easy to install

- Lightweight and compact with plug-n-play connectors
- Power Line Communication (PLC) between components
- Faster installation with simple two-wire cabling

High productivity and reliability

- Produce power even when the grid is down*
- More than one million cumulative hours of testing
- Class II double-insulated enclosure
- Optimized for the latest high-powered PV modules

Microgrid-forming

- Complies with the latest advanced grid support**
- Remote automatic updates for the latest grid requirements
- Configurable to support a wide range of grid profiles
- Meets CA Rule 21 (UL 1741-SA) requirements

* Only when installed with IQ System Controller 2, meets UL 1741.

** IQ8 and IQ8Plus supports split phase, 240V installations only.

IQ8 and IQ8+ Microinverters

INPUT DATA (DC)		IQ8-60-2-US	IQ8PLUS-72-2-US
Commonly used module pairings ¹	W	235 – 350	235 – 440
Module compatibility		60-cell/120 half-cell	60-cell/120 half-cell, 66-cell/132 half-cell and 72-cell/144 half-cell
MPPT voltage range	V	27 – 37	29 – 45
Operating range	V	25 – 48	25 – 58
Min/max start voltage	V	30 / 48	30 / 58
Max input DC voltage	V	50	60
Max DC current ² [module Isc]	A	15	
Overvoltage class DC port		II	
DC port backfeed current	mA	0	
PV array configuration		1x1 Ungrounded array; No additional DC side protection required; AC side protection requires max 20A per branch circuit	
OUTPUT DATA (AC)		IQ8-60-2-US	IQ8PLUS-72-2-US
Peak output power	VA	245	300
Max continuous output power	VA	240	290
Nominal (L-L) voltage/range ³	V	240 / 211 – 264	
Max continuous output current	A	1.0	1.21
Nominal frequency	Hz	60	
Extended frequency range	Hz	50 – 68	
AC short circuit fault current over 3 cycles	Arms	2	
Max units per 20 A (L-L) branch circuit ⁴		16	13
Total harmonic distortion		<5%	
Overvoltage class AC port		III	
AC port backfeed current	mA	30	
Power factor setting		1.0	
Grid-tied power factor (adjustable)		0.85 leading – 0.85 lagging	
Peak efficiency	%	97.5	97.6
CEC weighted efficiency	%	97	97
Night-time power consumption	mW	60	
MECHANICAL DATA			
Ambient temperature range		-40°C to +60°C (-40°F to +140°F)	
Relative humidity range		4% to 100% (condensing)	
DC Connector type		MC4	
Dimensions (HxWxD)		212 mm (8.3") x 175 mm (6.9") x 30.2 mm (1.2")	
Weight		1.08 kg (2.38 lbs)	
Cooling		Natural convection – no fans	
Approved for wet locations		Yes	
Pollution degree		PD3	
Enclosure		Class II double-insulated, corrosion resistant polymeric enclosure	
Environ. category / UV exposure rating		NEMA Type 6 / outdoor	
COMPLIANCE			
Certifications		CA Rule 21 (UL 1741-SA), UL 62109-1, UL1741/IEEE1547, FCC Part 15 Class B, ICES-0003 Class B, CAN/CSA-C22.2 NO. 107.1-01 This product is UL Listed as PV Rapid Shut Down Equipment and conforms with NEC 2014, NEC 2017, and NEC 2020 section 690.12 and C22.1-2018 Rule 64-218 Rapid Shutdown of PV Systems, for AC and DC conductors, when installed according to manufacturer's instructions.	

(1) No enforced DC/AC ratio. See the compatibility calculator at <https://link.enphase.com/module-compatibility>
(2) Maximum continuous input DC current is 10.6A (3) Nominal voltage range can be extended beyond nominal if required by the utility. (4) Limits may vary. Refer to local requirements to define the number of microinverters per branch in your area.

IQ8SP-DS-0002-01-EN-US-2022-03-17



LUNEX POWER INC.
4721 N GRADY AVE
TAMPA FL 33614
LIC #: CVC57085
PHONE: 813-540-8807

REVISIONS		
DESCRIPTION	DATE	REV
CLIENT COMMENT	02/08/2024	A
CLIENT COMMENT	02/12/2024	B

DATE: 10/20/2023

PROJECT NAME & ADDRESS

MARY W WILDS
RESIDENCE
131 NW KATELYN WAY,
LAKE CITY, FL 32055

DRAWN BY
ESR

SHEET NAME
EQUIPMENT
SPECIFICATION

SHEET SIZE
ANSI B
11" X 17"

SHEET NUMBER
PV-12

Enphase IQ Combiner 4/4C

X-IQ-AM1-240-4
X-IQ-AM1-240-4C



To learn more about Enphase offerings, visit enphase.com

The **Enphase IQ Combiner 4/4C** with Enphase IQ Gateway and integrated LTE-M1 cell modem (included only with IQ Combiner 4C) consolidates interconnection equipment into a single enclosure and streamlines IQ microinverters and storage installations by providing a consistent, pre-wired solution for residential applications. It offers up to four 2-pole input circuits and Eaton BR series busbar assembly.

Smart

- Includes IQ Gateway for communication and control
- Includes Enphase Mobile Connect cellular modem (CELLMODEM-M1-06-SP-05), included only with IQ Combiner 4C
- Includes solar shield to match Enphase IQ Battery aesthetics and deflect heat
- Flexible networking supports Wi-Fi, Ethernet, or cellular
- Optional AC receptacle available for PLC bridge
- Provides production metering and consumption monitoring

Simple

- Centered mounting brackets support single stud mounting
- Supports bottom, back and side conduit entry
- Up to four 2-pole branch circuits for 240 VAC plug-in breakers (not included)
- 80A total PV or storage branch circuits

Reliable

- Durable NRTL-certified NEMA type 3R enclosure
- Five-year limited warranty
- Two years labor reimbursement program coverage included for both the IQ Combiner SKU's
- UL listed



Enphase IQ Combiner 4/4C

MODEL NUMBER	
IQ Combiner 4 (X-IQ-AM1-240-4)	IQ Combiner 4 with Enphase IQ Gateway printed circuit board for integrated revenue grade PV production metering (ANSI C12.20 +/- 0.5%) and consumption monitoring (+/- 2.5%). Includes a silver solar shield to match the IQ Battery system and IQ System Controller 2 and to deflect heat.
IQ Combiner 4C (X-IQ-AM1-240-4C)	IQ Combiner 4C with Enphase IQ Gateway printed circuit board for integrated revenue grade PV production metering (ANSI C12.20 +/- 0.5%) and consumption monitoring (+/- 2.5%). Includes Enphase Mobile Connect cellular modem (CELLMODEM-M1-06-SP-05), a plug-and-play industrial-grade cell modem for systems up to 60 microinverters. (Available in the US, Canada, Mexico, Puerto Rico, and the US Virgin Islands, where there is adequate cellular service in the installation area.) Includes a silver solar shield to match the IQ Battery and IQ System Controller and to deflect heat.
ACCESSORIES AND REPLACEMENT PARTS (not included, order separately)	
Ensemble Communications Kit COMMS-CELLMODEM-M1-06 CELLMODEM-M1-06-SP-05 CELLMODEM-M1-06-AT-05	- Includes COMMS-KIT-01 and CELLMODEM-M1-06-SP-05 with 5-year Sprint data plan for Ensemble sites - 4G based LTE-M1 cellular modem with 5-year Sprint data plan - 4G based LTE-M1 cellular modem with 5-year AT&T data plan
Circuit Breakers BRK-10A-2-240V BRK-15A-2-240V BRK-20A-2P-240V BRK-15A-2P-240V-B BRK-20A-2P-240V-B	Supports Eaton BR210, BR215, BR220, BR230, BR240, BR250, and BR260 circuit breakers. Circuit breaker, 2 pole, 10A, Eaton BR210 Circuit breaker, 2 pole, 15A, Eaton BR215 Circuit breaker, 2 pole, 20A, Eaton BR220 Circuit breaker, 2 pole, 15A, Eaton BR215B with hold down kit support Circuit breaker, 2 pole, 20A, Eaton BR220B with hold down kit support
EPLC-01	Power line carrier (communication bridge pair), quantity - one pair
XA-SOLARSHIELD-ES	Replacement solar shield for IQ Combiner 4/4C
XA-PLUG-120-3	Accessory receptacle for Power Line Carrier in IQ Combiner 4/4C (required for EPLC-01)
XA-ENV-PCBA-3	Replacement IQ Gateway printed circuit board (PCB) for Combiner 4/4C
X-IQ-NA-HD-125A	Hold down kit for Eaton circuit breaker with screws.
ELECTRICAL SPECIFICATIONS	
Rating	Continuous duty
System voltage	120/240 VAC, 60 Hz
Eaton BR series busbar rating	125 A
Max. continuous current rating	65 A
Max. continuous current rating (input from PV/storage)	64 A
Max. fuse/circuit rating (output)	90 A
Branch circuits (solar and/or storage)	Up to four 2-pole Eaton BR series Distributed Generation (DG) breakers only (not included)
Max. total branch circuit breaker rating (input)	80A of distributed generation / 95A with IQ Gateway breaker included
Envoy breaker	10A or 15A rating GE/Siemens/Eaton included
Production metering CT	200 A solid core pre-installed and wired to IQ Gateway
Consumption monitoring CT (CT-200-SPLIT)	A pair of 200 A split core current transformers
MECHANICAL DATA	
Dimensions (WxHxD)	37.5 x 49.5 x 16.8 cm (14.75" x 19.5" x 6.63"). Height is 21.06" (53.5 cm) with mounting brackets.
Weight	7.5 kg (16.5 lbs)
Ambient temperature range	-40° C to +46° C (-40° to 115° F)
Cooling	Natural convection, plus heat shield
Enclosure environmental rating	Outdoor, NRTL-certified, NEMA type 3R, polycarbonate construction
Wire sizes	• 20 A to 50 A breaker inputs: 14 to 4 AWG copper conductors • 60 A breaker branch input: 4 to 1/0 AWG copper conductors • Main lug combined output: 10 to 2/0 AWG copper conductors • Neutral and ground: 14 to 1/0 copper conductors Always follow local code requirements for conductor sizing.
Altitude	To 2000 meters (6,560 feet)
INTERNET CONNECTION OPTIONS	
Integrated Wi-Fi	802.11b/g/n
Cellular	CELLMODEM-M1-06-SP-05, CELLMODEM-M1-06-AT-05 (4G based LTE-M1 cellular modem). Note that an Enphase Mobile Connect cellular modem is required for all Ensemble installations.
Ethernet	Optional, 802.3, Cat5E (or Cat 6) UTP Ethernet cable (not included)
COMPLIANCE	
Compliance, IQ Combiner	UL 1741, CAN/CSA C22.2 No. 107.1, 47 CFR, Part 15, Class B, ICES 003 Production metering: ANSI C12.20 accuracy class 0.5 (PV production) Consumption metering: accuracy class 2.5
Compliance, IQ Gateway	UL 60601-1/CANCSA 22.2 No. 61010-1

To learn more about Enphase offerings, visit enphase.com

© 2022 Enphase Energy. All rights reserved. Enphase, the Enphase logo, IQ Combiner 4/4C, and other names are trademarks of Enphase Energy, Inc. Data subject to change. 02-14-2022



LUNEX POWER INC.
4721 N GRADY AVE
TAMPA FL 33614
LIC #: CVC57085
PHONE: 813-540-8807

REVISIONS		
DESCRIPTION	DATE	REV
CLIENT COMMENT	02/08/2024	A
CLIENT COMMENT	02/12/2024	B

DATE: 10/20/2023

PROJECT NAME & ADDRESS

MARY W WILDS
RESIDENCE
131 NW KATELYN WAY,
LAKE CITY, FL 32055

DRAWN BY
ESR

SHEET NAME
EQUIPMENT
SPECIFICATION


SHEET SIZE
ANSI B
11" X 17"

SHEET NUMBER
PV-13

CrossRail 44-X



DATA SHEET

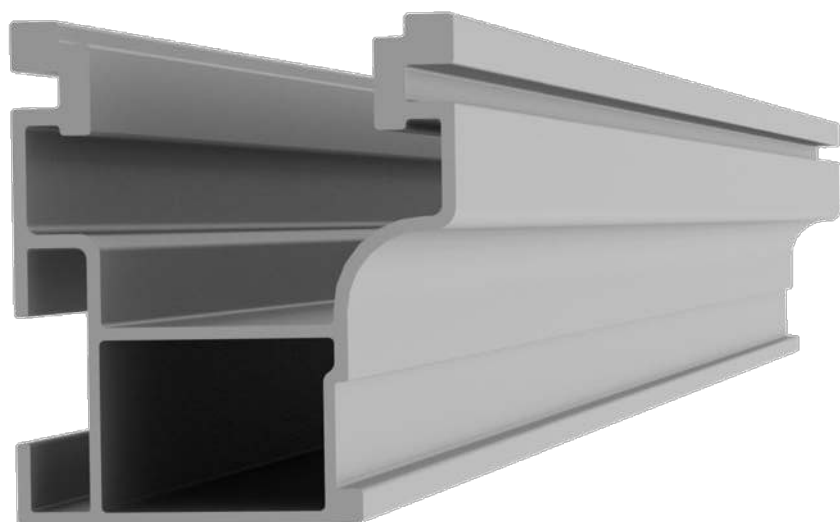

TECHNICAL DATA

Mechanical Properties

	CrossRail 44-X
Material	6000 Series Aluminum
Ultimate Tensile Strength	37.7 ksi (260 MPa)
Yield Strength	34.8 ksi (240 MPa)
Weight	.47 lbs/ft (0.699 kg/m)


Sectional Properties

	CrossRail 44-X
Sx	0.149 in ³ (0.3785 cm ³)
Sy	0.145 in ³ (0.3683 cm ³)
A (X-Section)	0.405 in ² (1.0287 cm ²)

LOAD		RAIL SPAN									
SNOW (psf)	WIND (mph)	32"	4'	64"	6'	80"	8'	112"	10'	12'	
0	120										
0	140										
0	160										
10	120										
10	140										
10	160										
20	140										
20	160										
30	160										
40	160										
80	160										
100	160										

44X/MAX 48X 48XL CR80

Units: [mm] in

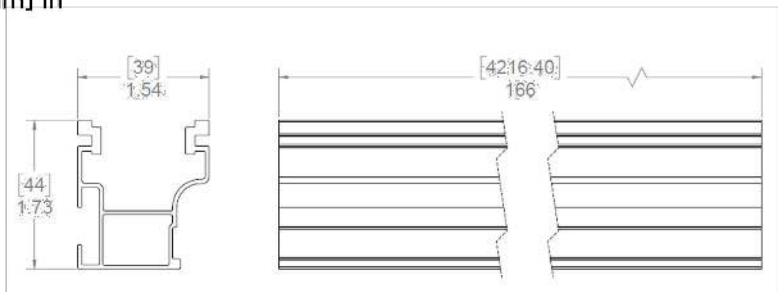

Notes:

- Structural values and span charts determined in accordance with Aluminum Design Manual and ASCE 7-16
- UL2703 Listed System for Fire and Bonding



LUNEX POWER INC.
4721 N GRADY AVE
TAMPA FL 33614
LIC #: CVC57085
PHONE: 813-540-8807

REVISIONS

DESCRIPTION	DATE	REV
CLIENT COMMENT	02/08/2024	A
CLIENT COMMENT	02/12/2024	B

DATE: 10/20/2023

PROJECT NAME & ADDRESS

MARY W WILDS
RESIDENCE
131 NW KATELYN WAY,
LAKE CITY, FL 32055

DRAWN BY

ESR

SHEET NAME

EQUIPMENT
SPECIFICATION

SHEET SIZE

ANSI B
11" X 17"

SHEET NUMBER

PV-14

The right way to attach almost anything to metal roofs!

S-5!®

The Right Way!

ProteaBracket™


ProteaBracket™ is the most versatile standing seam metal roof attachment solution on the market, fitting most trapezoidal sheet profiles with and without intermediate insulation. It features an adjustable attachment base and multiple solar module attachment options (illustrated on back) to accommodate varying widths and heights. There are no messy sealants to apply and no chance for leaks; the ProteaBracket comes with factory-applied, adhesive rubber sealant to ensure quick installation and a weather-proof fit.

Installation is simple! The ProteaBracket is mounted directly onto the crown of the panel, straddling the profile. No surface preparation is necessary; simply wipe away excess oil and debris, align, and apply. Secure ProteaBracket through its pre-punched holes, using the hardened drill point S-5!® screws.

ProteaBracket is the perfect match for our S-5-PV Kit and spares you the hassle of cold-bridging! For a solar attachment solution that is both economical and easy to use, choose ProteaBracket.*

*When ProteaBracket is used in conjunction with the S-5-PV Kit, an additional nut is required during installation.

S-5!® ProteaBracket™ is a versatile bracket that adjusts easily to most trapezoidal roof profiles.

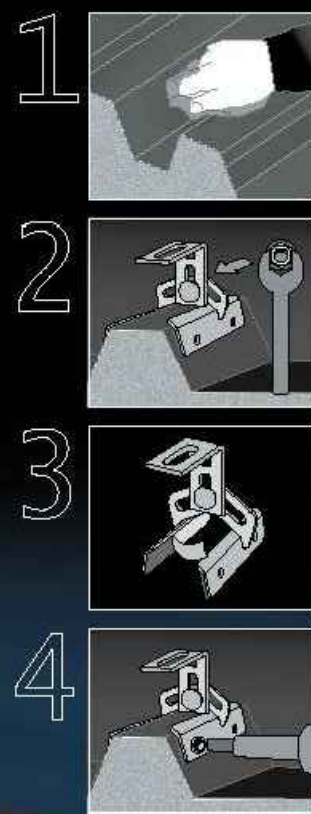

ProteaBracket™

888-825-3432 | www.S-5.com | 

S-5!®

The Right Way!

ProteaBracket™ is the perfect solar attachment solution for most trapezoidal exposed-fastened metal roof profiles! No messy sealants to apply. The factory-applied adhesive rubber sealant weather-proofs and makes installation easy!

Each ProteaBracket™ comes with a factory-applied, adhesive rubber sealant on the base. A structural A2 stainless steel bimetal attachment bracket, ProteaBracket is compatible with most common metal roofing materials. All four pre-punched holes must be used to achieve tested strength. Mounting hardware is furnished with the ProteaBracket. For design assistance, ask your distributor, or visit www.S-5.com for the independent lab test data that can be used for load-critical designs and applications. Also, please visit our website for more information including metallurgical compatibilities and specifications. S-5!® holding strength is unmatched in the industry.

Multiple Attachment Options:

Side Rail Option




Top Rail Option



S-5-PV Kit Option



ProteaBracket™

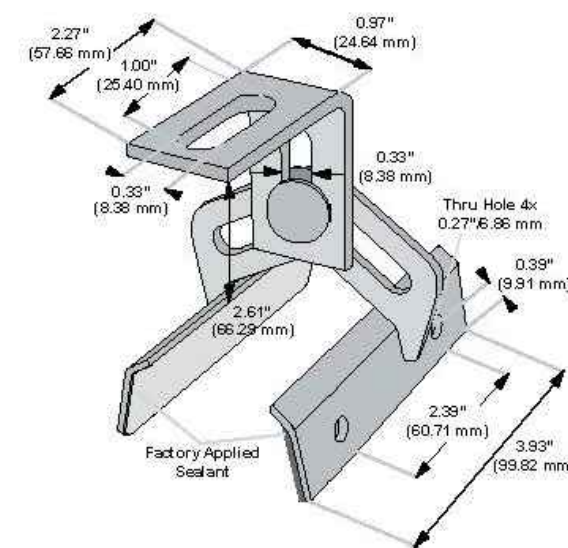

Please note: All measurements are rounded to the second decimal place.

Example Applications



S-5-PV Kit demonstrated with a ProteaBracket on a trapezoidal profile.

Example Profile



Distributed by

S-5!® Warning! Please use this product responsibly!

Products are protected by multiple U.S. and foreign patents. For published data regarding holding strength, bolt torque, patents, and trademarks, visit the S-5! website at www.S-5.com.

Copyright 2015, Metal Roof Innovations, Ltd. S-5! products are patent protected. S-5! aggressively protects its patents, trademarks, and copyrights. Version 052115.

LUNEX POWER
THE PURE SOURCE

LUNEX POWER INC.
4721 N GRADY AVE
TAMPA FL 33614
LIC #: CVC57085
PHONE: 813-540-8807

REVISIONS

DESCRIPTION	DATE	REV
CLIENT COMMENT	02/08/2024	A
CLIENT COMMENT	02/12/2024	B

DATE: 10/20/2023

PROJECT NAME & ADDRESS

MARY W WILDS
RESIDENCE
131 NW KATELYN WAY,
LAKE CITY, FL 32055

DRAWN BY
ESR

SHEET NAME
EQUIPMENT
SPECIFICATION

SHEET SIZE
ANSI B
11" X 17"

SHEET NUMBER
PV-15