


Jordan Residence

LOT 4 - HILLS of WINDSOR

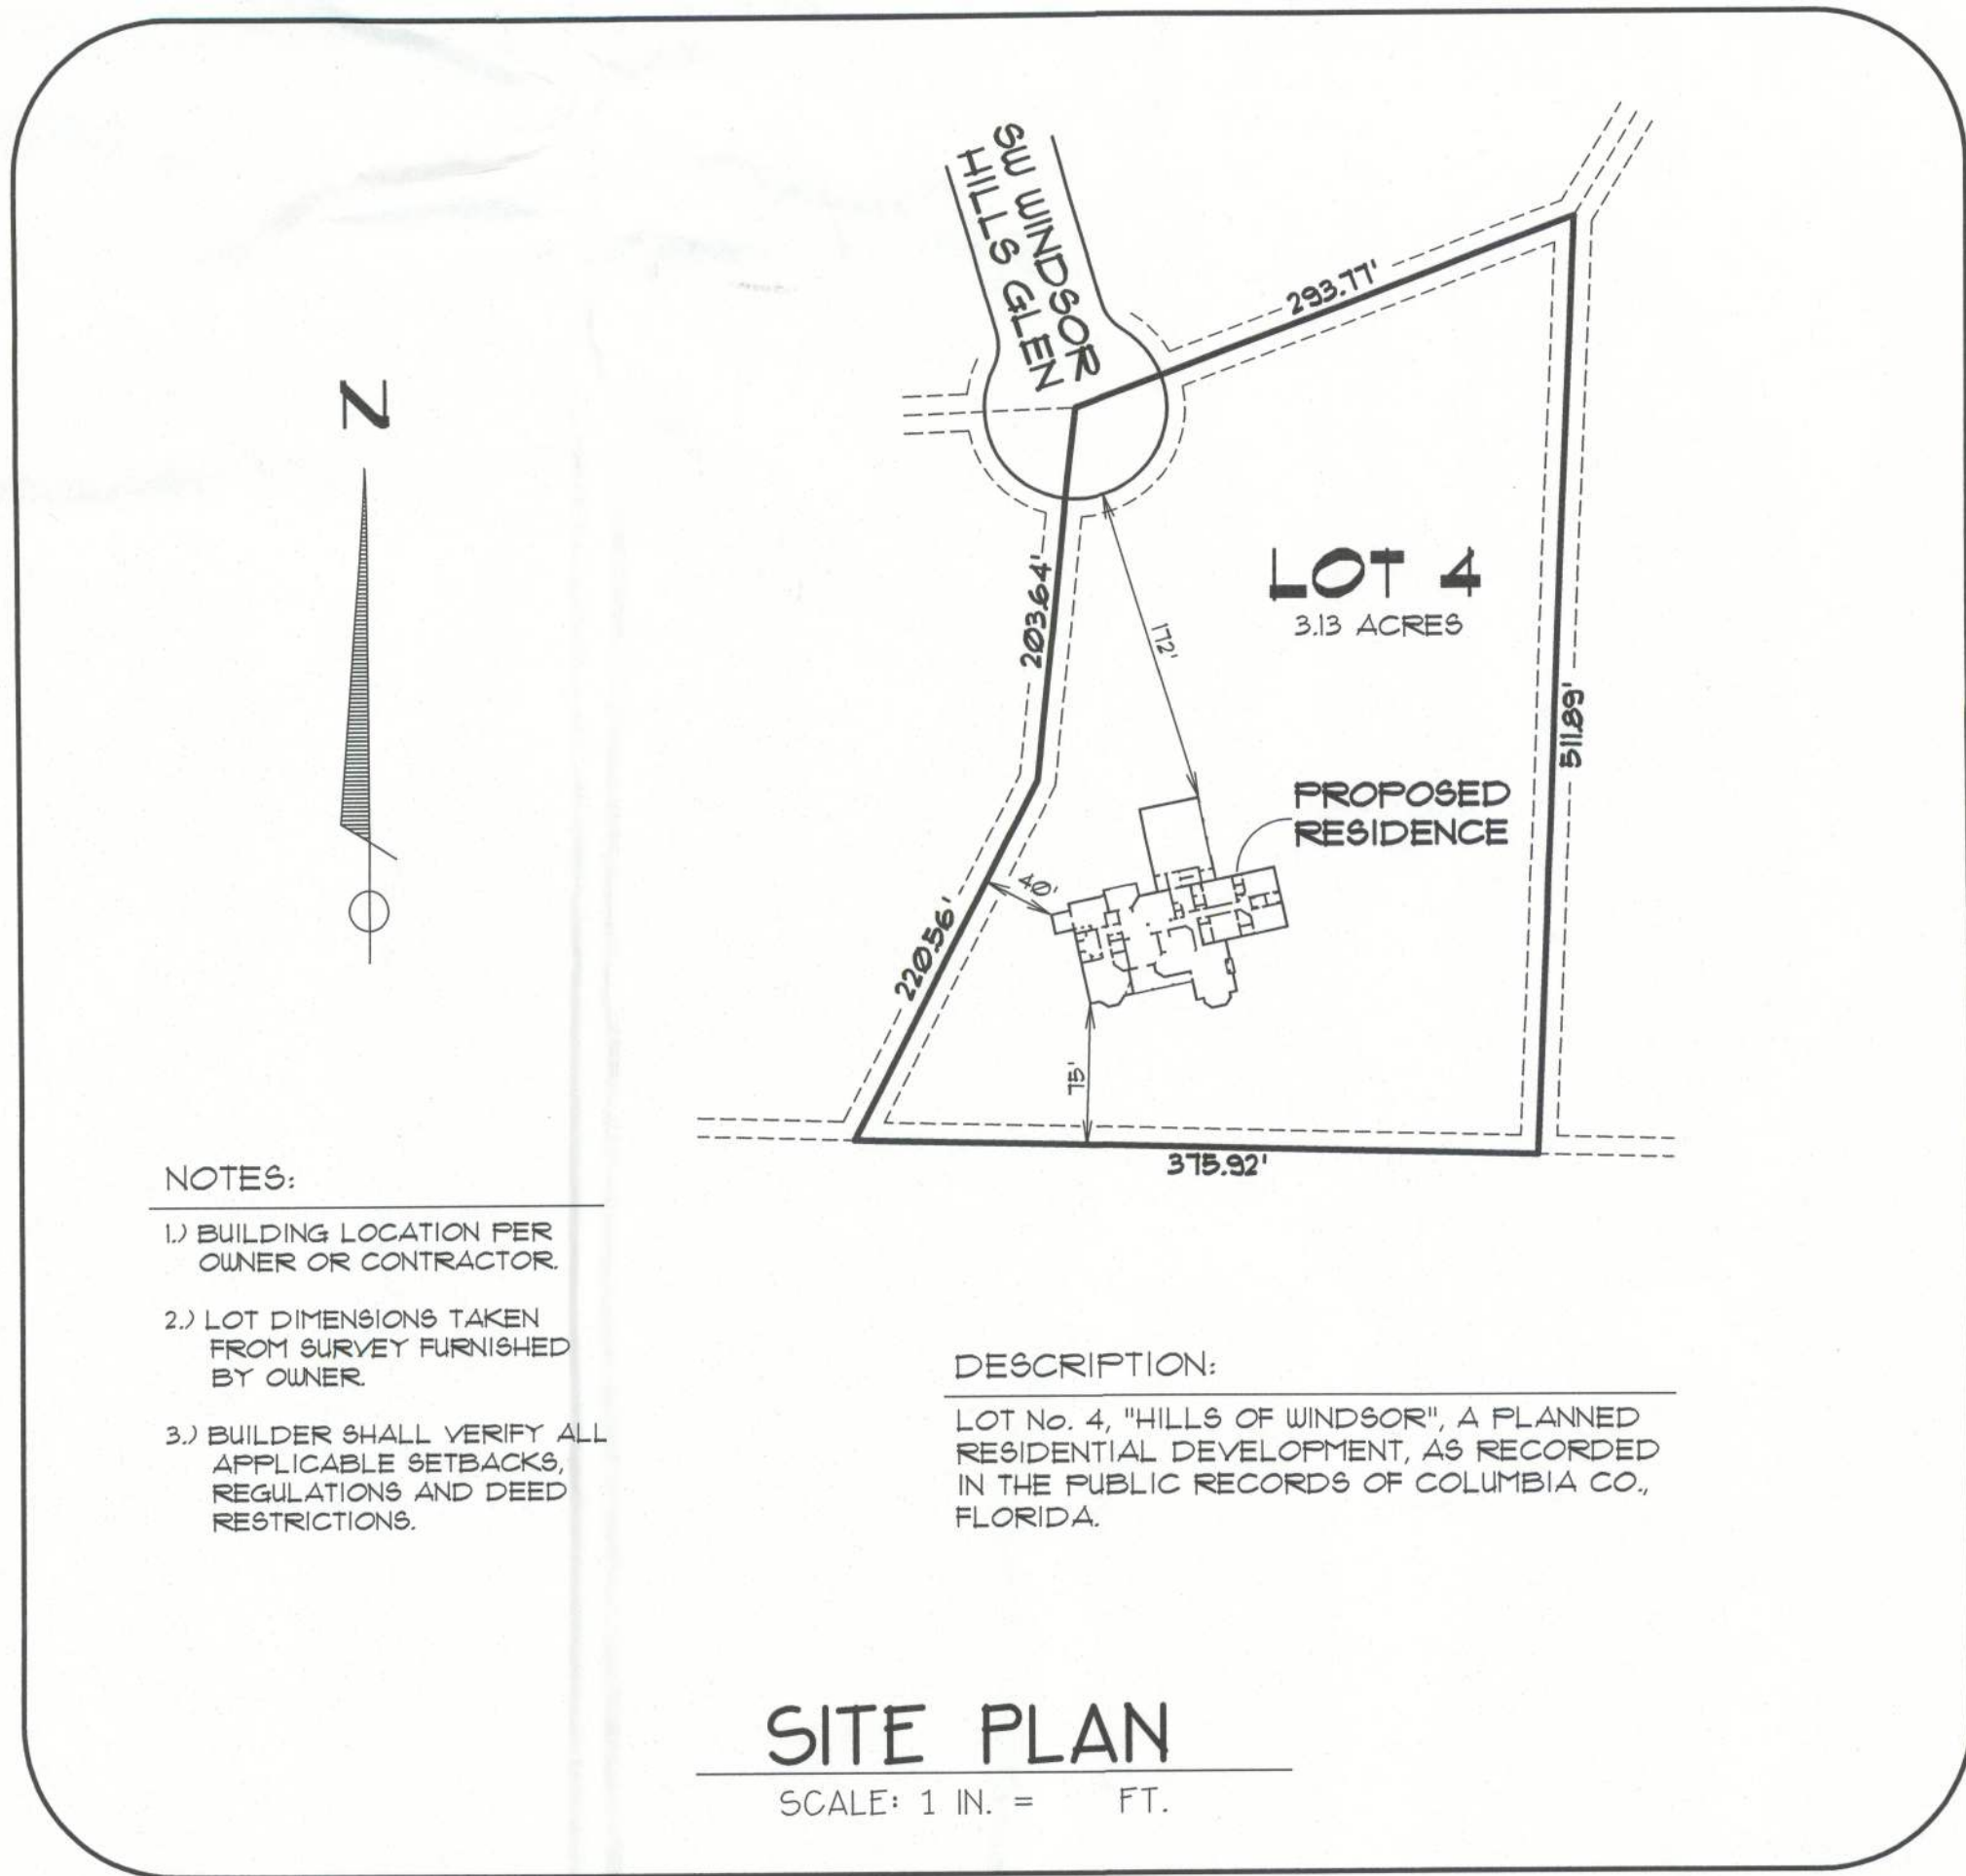

INDEX of SHEETS

SHEET	DESCRIPTION
1	FRONT / RIGHT ELEVATIONS
2	REAR / LEFT ELEVATIONS
3	MAIN FLOOR PLAN
4	GARAGE & BONUS ROOM
5	MAIN FOUNDATION PLAN
6	GARAGE FOUNDATION & DETAILS
7	BASEMENT WALL & TYP. SECTION
8	HVAC & PLUMBING INFORMATION
9	MAIN FLOOR ELECTRICAL PLAN
10	GARAGE, BONUS & BASEMENT ELECTRICAL

FILE: 11-007	JORDAN RESIDENCE	SHEET: COVER
DATE: 11/29/11		CAD FILE: 11-007
DRAWN: T A D	PREPARED BY: TIM DELBENE Residential Drafting + Design Rt. 4, Box 330, Lake City, FL 32055 Phone (904) 755-5891	REV:
CHECK: T A D		REV: