


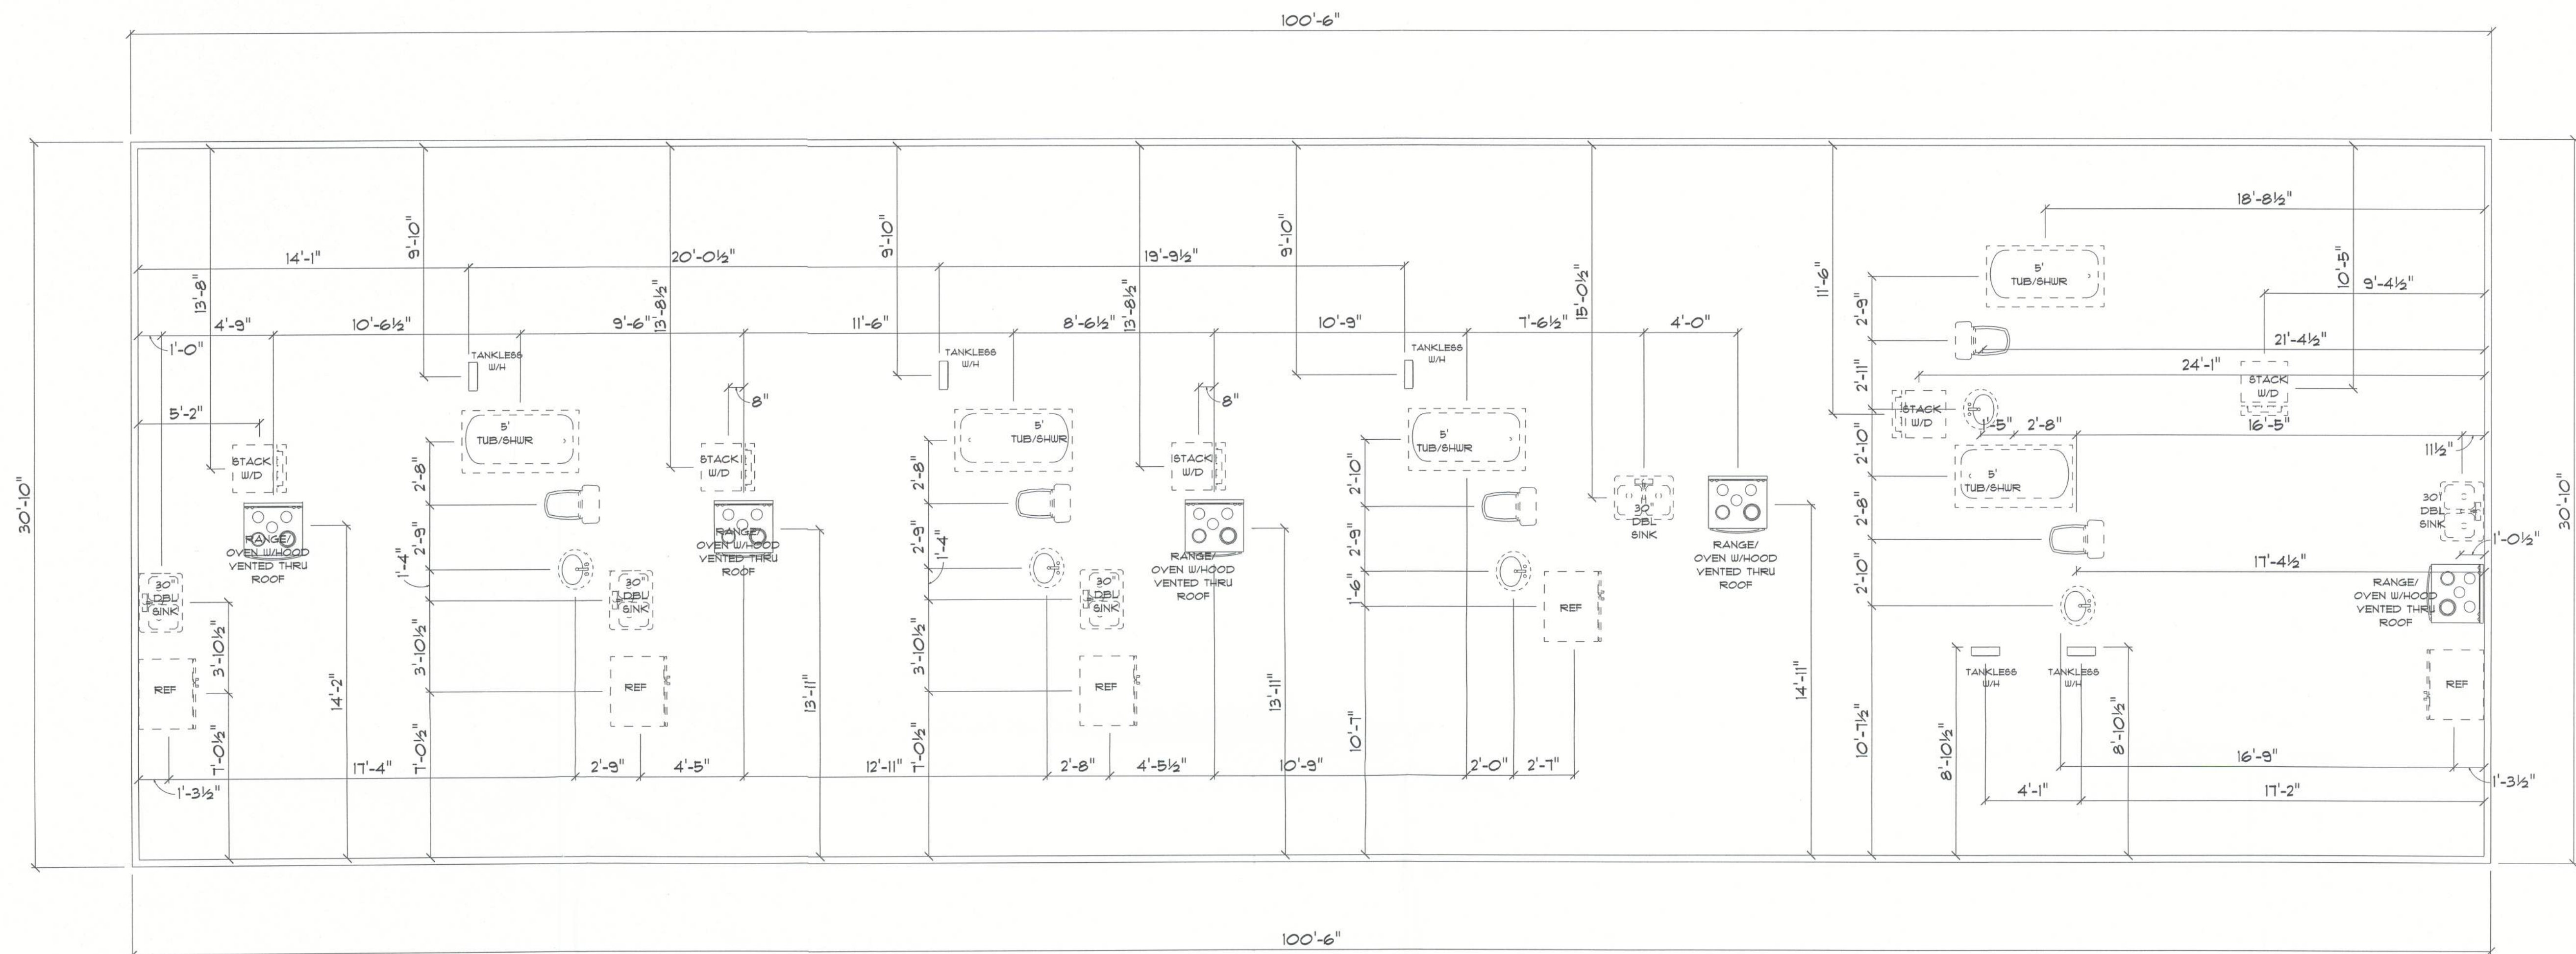

\* PROPOSED \*  
\* PLUMBING PLAN \*

SCALE : 1/4" = 1'-0"

IMPORTANT NOTES:  
1. IT IS THE BUILDER'S RESPONSIBILITY TO VERIFY ALL GEOMETRY AND DIMENSIONS BEFORE ORDERING ANY MATERIALS OR BEGINNING CONSTRUCTION.  
2. THESE PLANS ARE FOR LAYOUT AND DESIGN PURPOSES ONLY ALL STRUCTURAL NOTES AND DETAILS TO BE PROVIDED BY AN ENGINEER.



Digitally signed by Carol Chadwick  
DN: c=US, o=Florida, dnQualifier=A01410D0000018D46384E7500032FE  
E, cn=Carol Chadwick  
Date: 2024.03.17 20:41:05 -04'00'

REMODEL  
for  
DUVAL 5  
SUITE 5

1580 EAST DUVAL ST  
LAKE CITY, FLORIDA

ENGINEER:

CAROL CHADWICK, P.E.  
1208 S.W. FAIRFAX GLEN  
LAKE CITY, FL 32025  
307.680.1172

ccpswyo@gmail.com

PRINTED DATE:  
Monday, March 11, 2024

|                     |                       |
|---------------------|-----------------------|
| DRAWN BY:<br>THR    | CHECKED BY:<br>CCP.E. |
| BUILDING CONTRACTOR |                       |

FINALS DATE:

JOB NUMBER:

DRAWING NUMBER

A-2

OF 1 SHEETS