



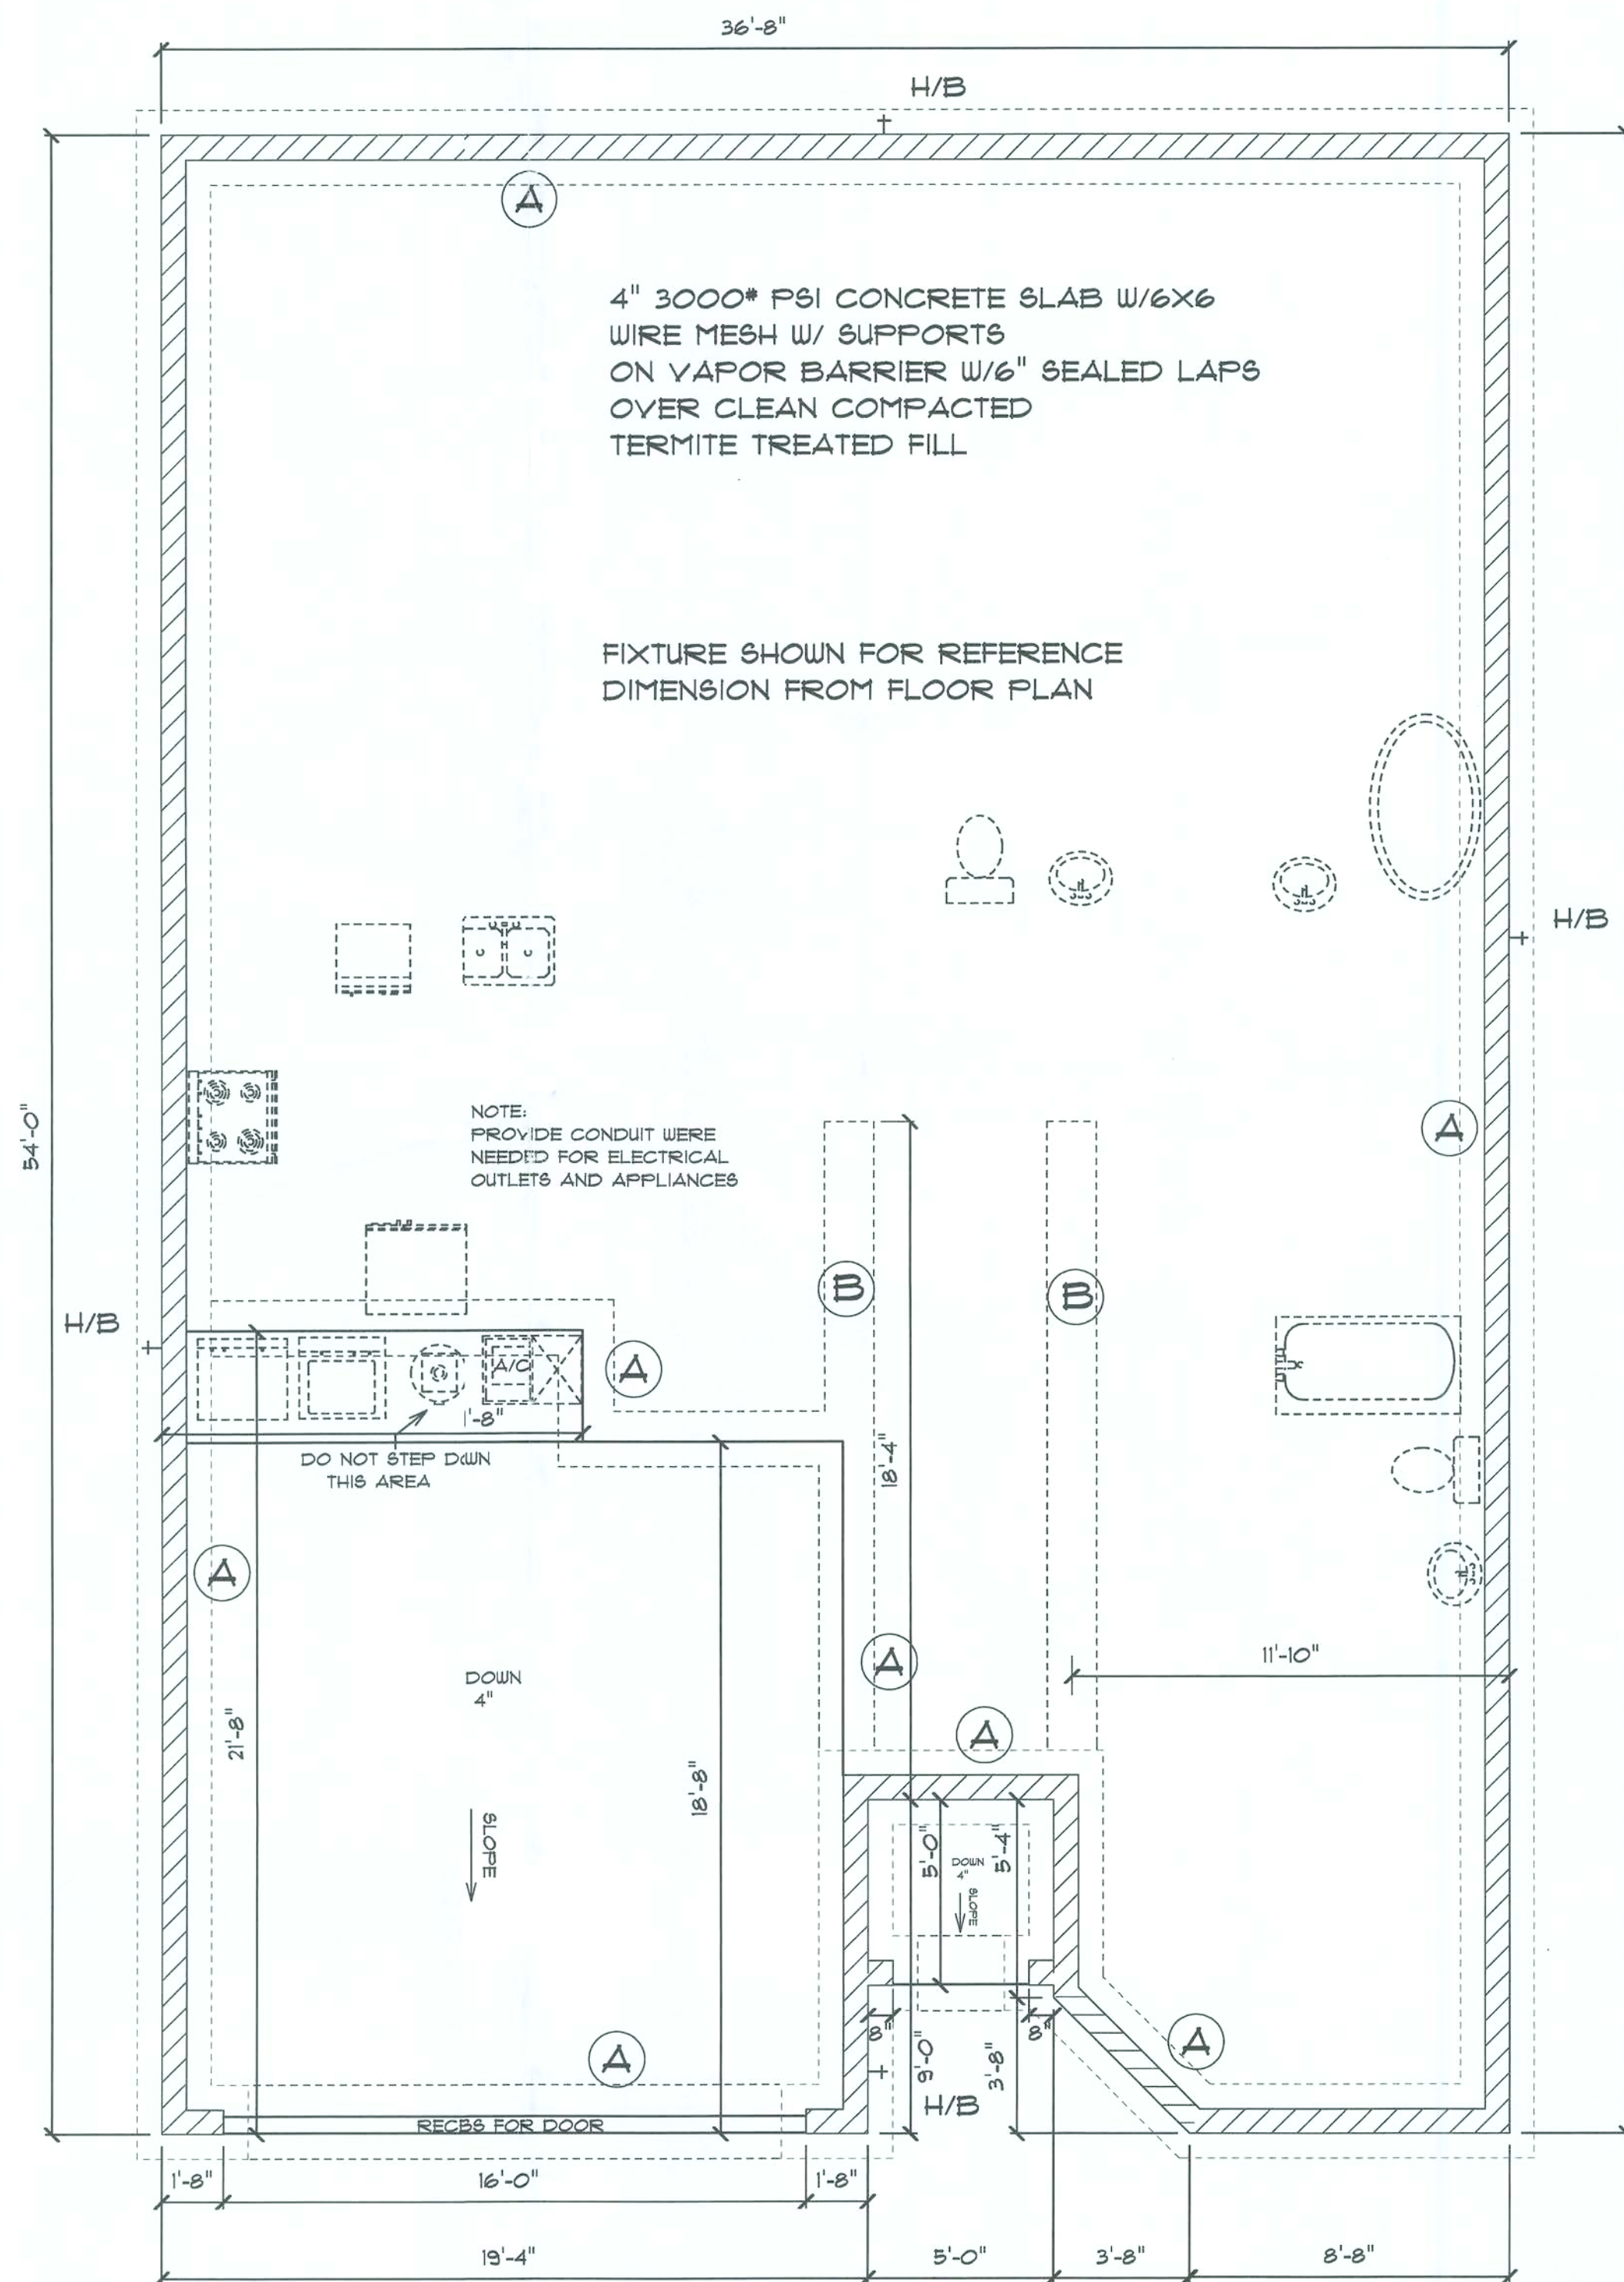

NOTE:
ALL FOOTING SIZES SHOWN ARE FOR STANDARD
CONSTRUCTION AND MUST BE REVIEWED AND VERIFIED
BY STRUCTURAL ENGINEER TO ASSURE ALL SIZES ARE
ADEQUATE FOR SPECIFIC LOADING SITUATIONS OF BUILDING

FOUNDATION PLAN

- (A) 20" WIDE X 12" DEEP FOOTING WITH 2-#5 CONT. REBAR
(B) 16" WIDE X 12" DEEP THICKENED SLAB WITH 2-#5 CONT. REBAR
(VERIFY ALL WITH ENGINEERING)

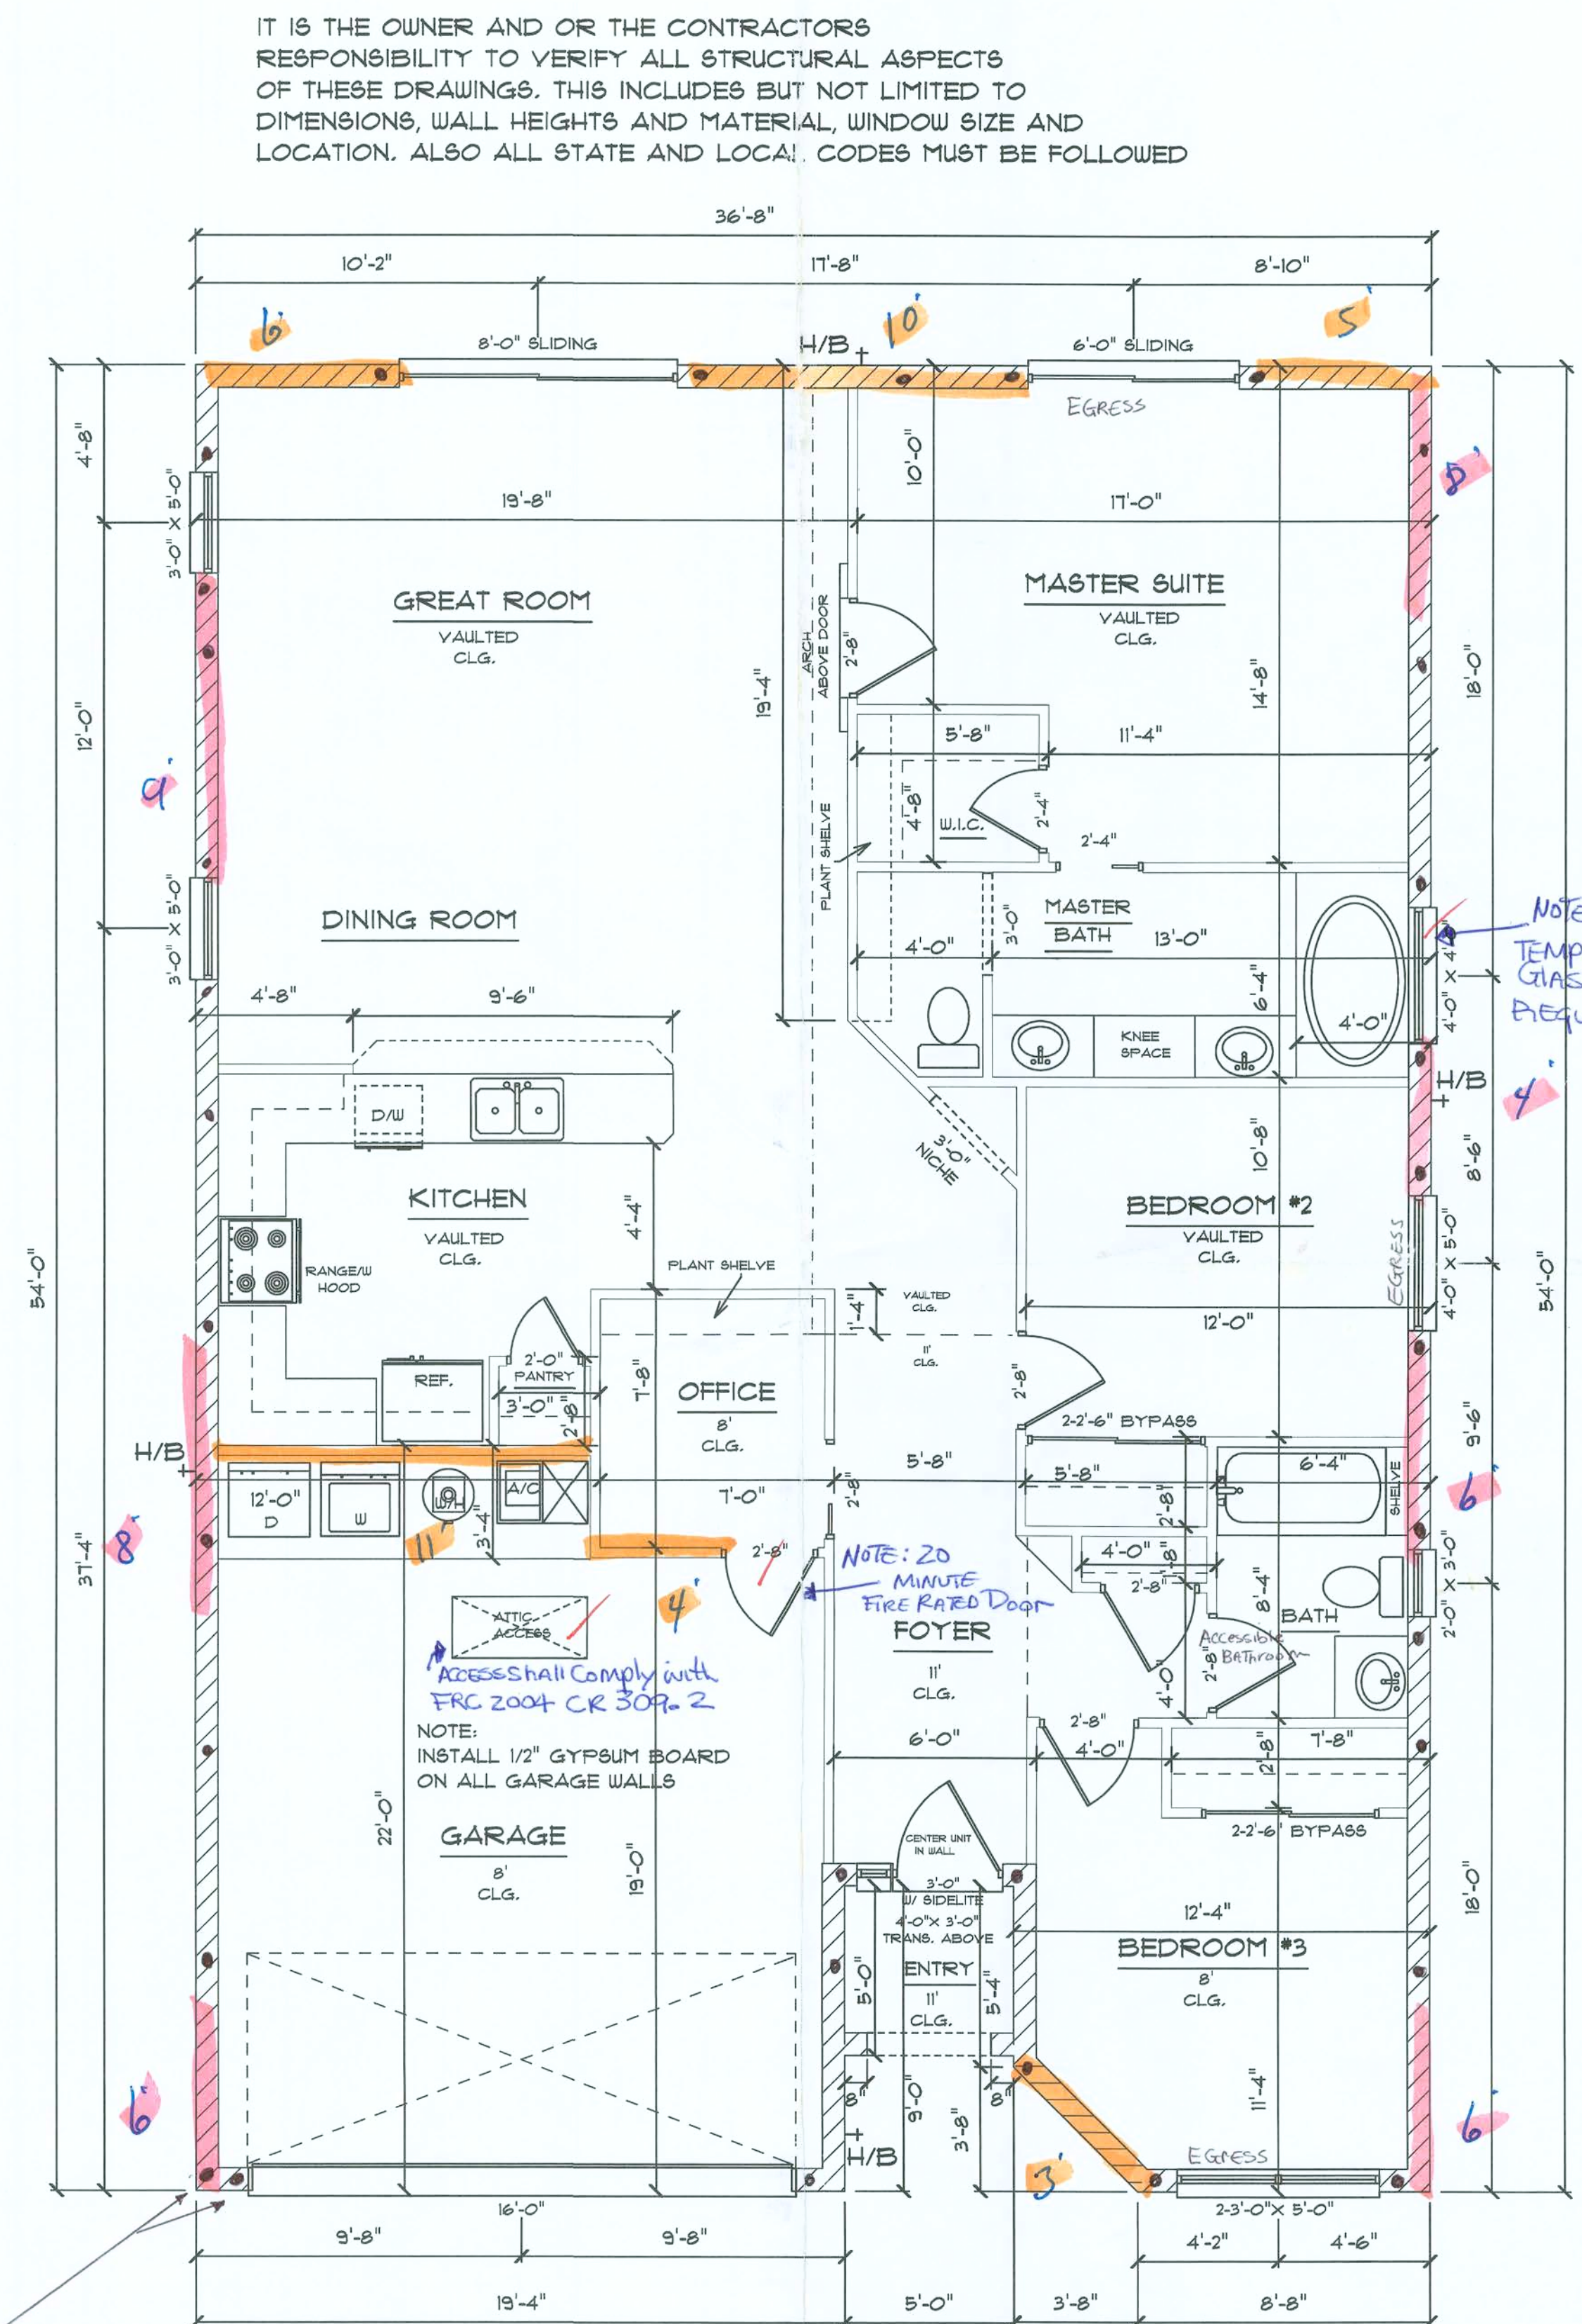

APPROX. AREA
LIVING 1538
GARAGE 402
ENTRY 25
TOTAL 1965

MAIN FLOOR PLAN

ALL WINDOWS AND DOORS TO
BE INSTALLED PER MANUFACTURERS
RECOMMENDATIONS AND MUST COMPLY
WITH CURRENT CODES. SUBMIT ATTACHMENT
WORKSHEET WITH PERMIT DOCUMENTS

IT IS THE OWNER AND OR THE CONTRACTORS
RESPONSIBILITY TO VERIFY ALL STRUCTURAL ASPECTS
OF THESE DRAWINGS. THIS INCLUDES BUT NOT LIMITED TO
DIMENSIONS, WALL HEIGHTS AND MATERIAL, WINDOW SIZE AND
LOCATION. ALSO ALL STATE AND LOCAL CODES MUST BE FOLLOWED

NOTES ON ELECTRICAL PLAN

TAYLOR RESIDENCE

1/4" = 1'
DRAWN BY F.A.C.
APPROVED

ONEIL
CONSTRUCTION


COLACINO
DRAFTING&DESIGN
PH. 352-472-3462

03/16/06
REVISION
REVISION


1

Office 10/1/06

TR-39
606-47

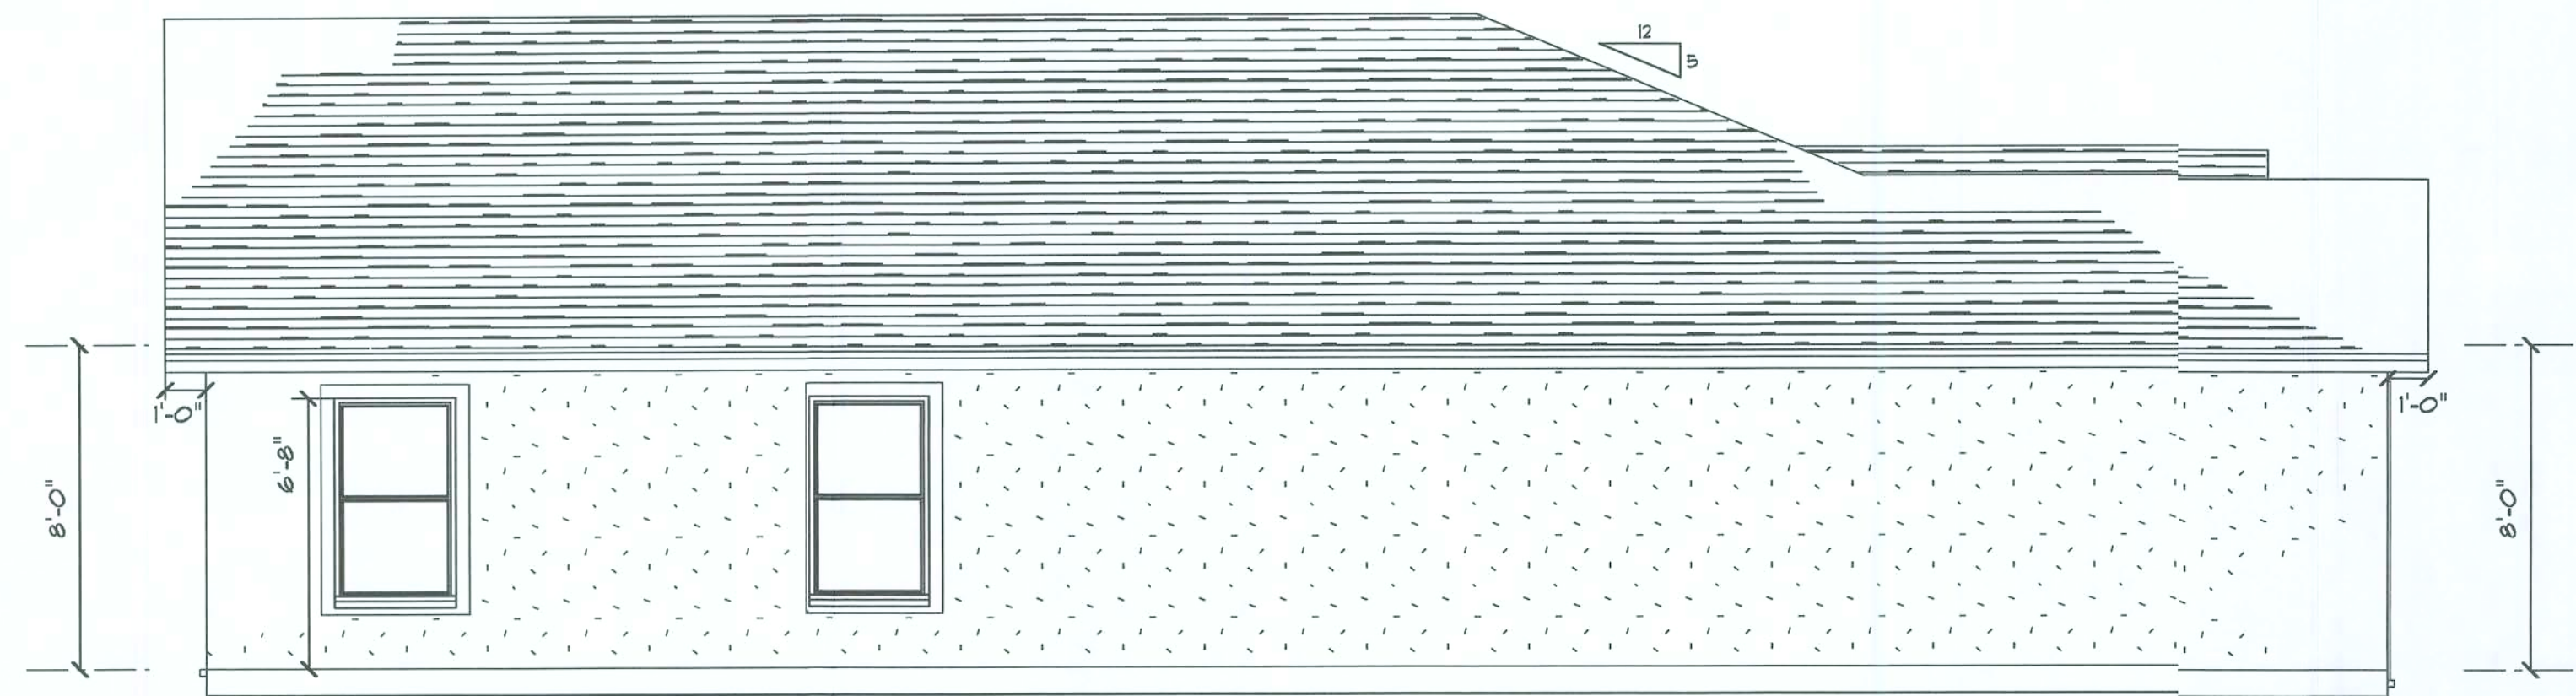


LEFT ELEVATION

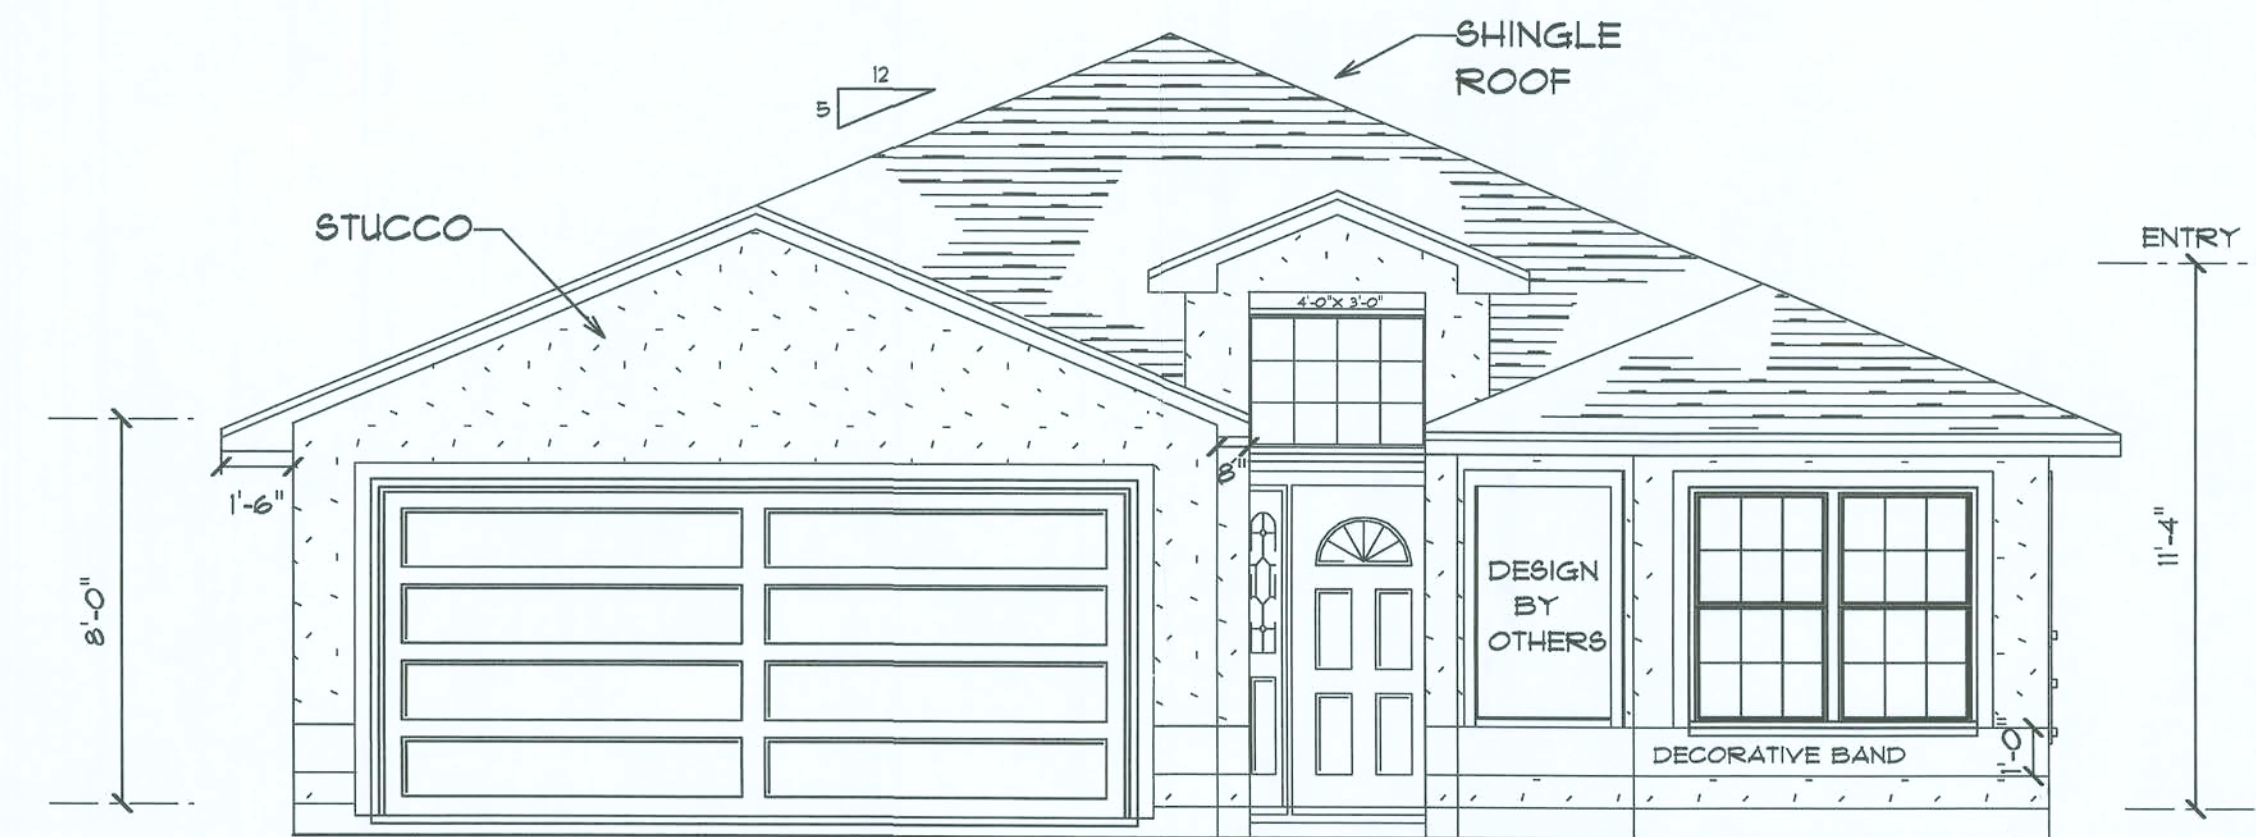

FRONT ELEVATION



REAR ELEVATION

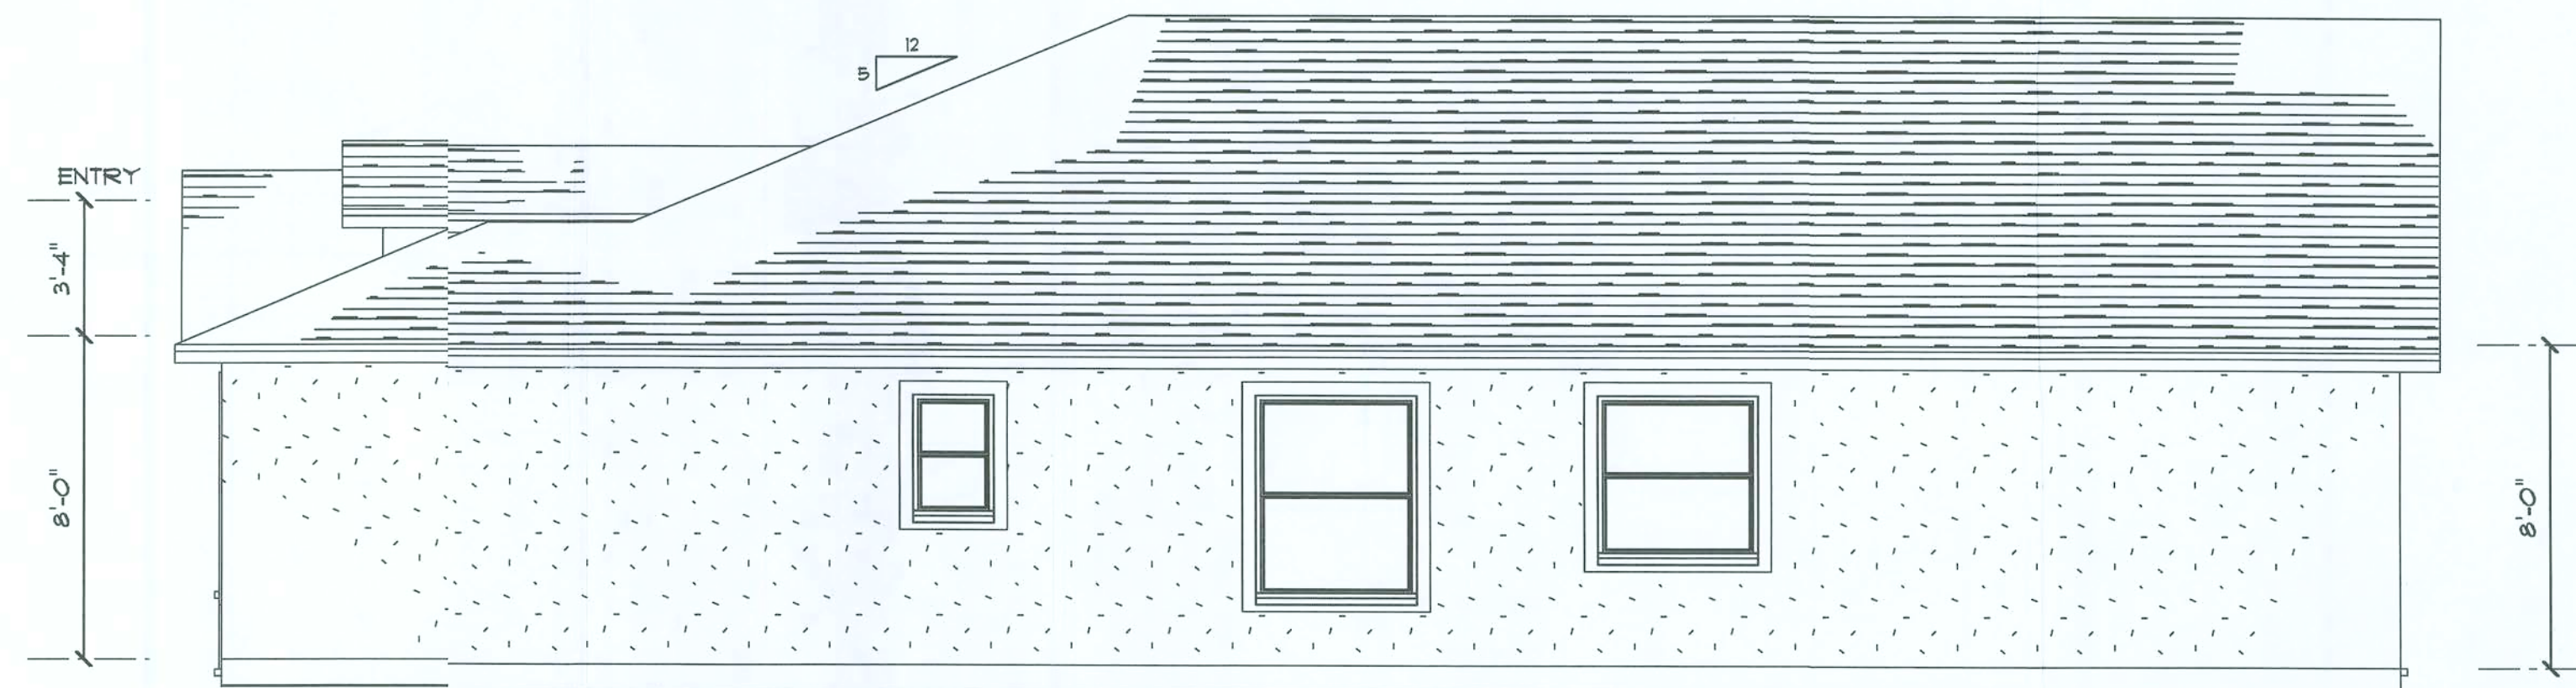

RIGHT ELEVATION

VENTING

1965	6.55	3.275	= 4.51
300	2	.72	= 5-4' OFF RIDGE VENTS



ELECTRICAL SYMBOLS	
OUTLET	
220 OUTLET	
SWITCH	
LIGHT	
RECESS LIGHT	
PULL CHAIN	
FLUORESCENT	
CEILING FAN	
WALL MOUNT LIGHT	
VANITY LIGHT	
FLOOD LIGHT	
CLG. LITE/FAN	
PANEL	
SMOKE DETECTOR	
TELEPHONE	
TV/CABLE	

POWER METER
LOCATION T.B.D.
POWER PROVIDED
BY

Provide
Disconnect
AS Requ

ALL EXTERIOR OUTLETS
TO BE WATERPROOF GFI


ALL RECEPTACLES
NEAR WATER TO
BE GFI

ALL BEDROOMS OUTLETS TO BE
ARC FAULT PROTECTED CIRCUIT

SMOKE DETECTORS TO BE IIO WIRED
W/ BATTERY BACK UP AS REQUIRED BY CODE

PHONE AND TV
OUTLETS PER
OWNERS

Overcurrent protection device shall be installed on the exterior of structures to serve as a disconnecting means. Conductors used from the exterior disconnecting means to a panel or sub panel shall have four-wire conductors, of which one conductor shall be used as an equipment ground.

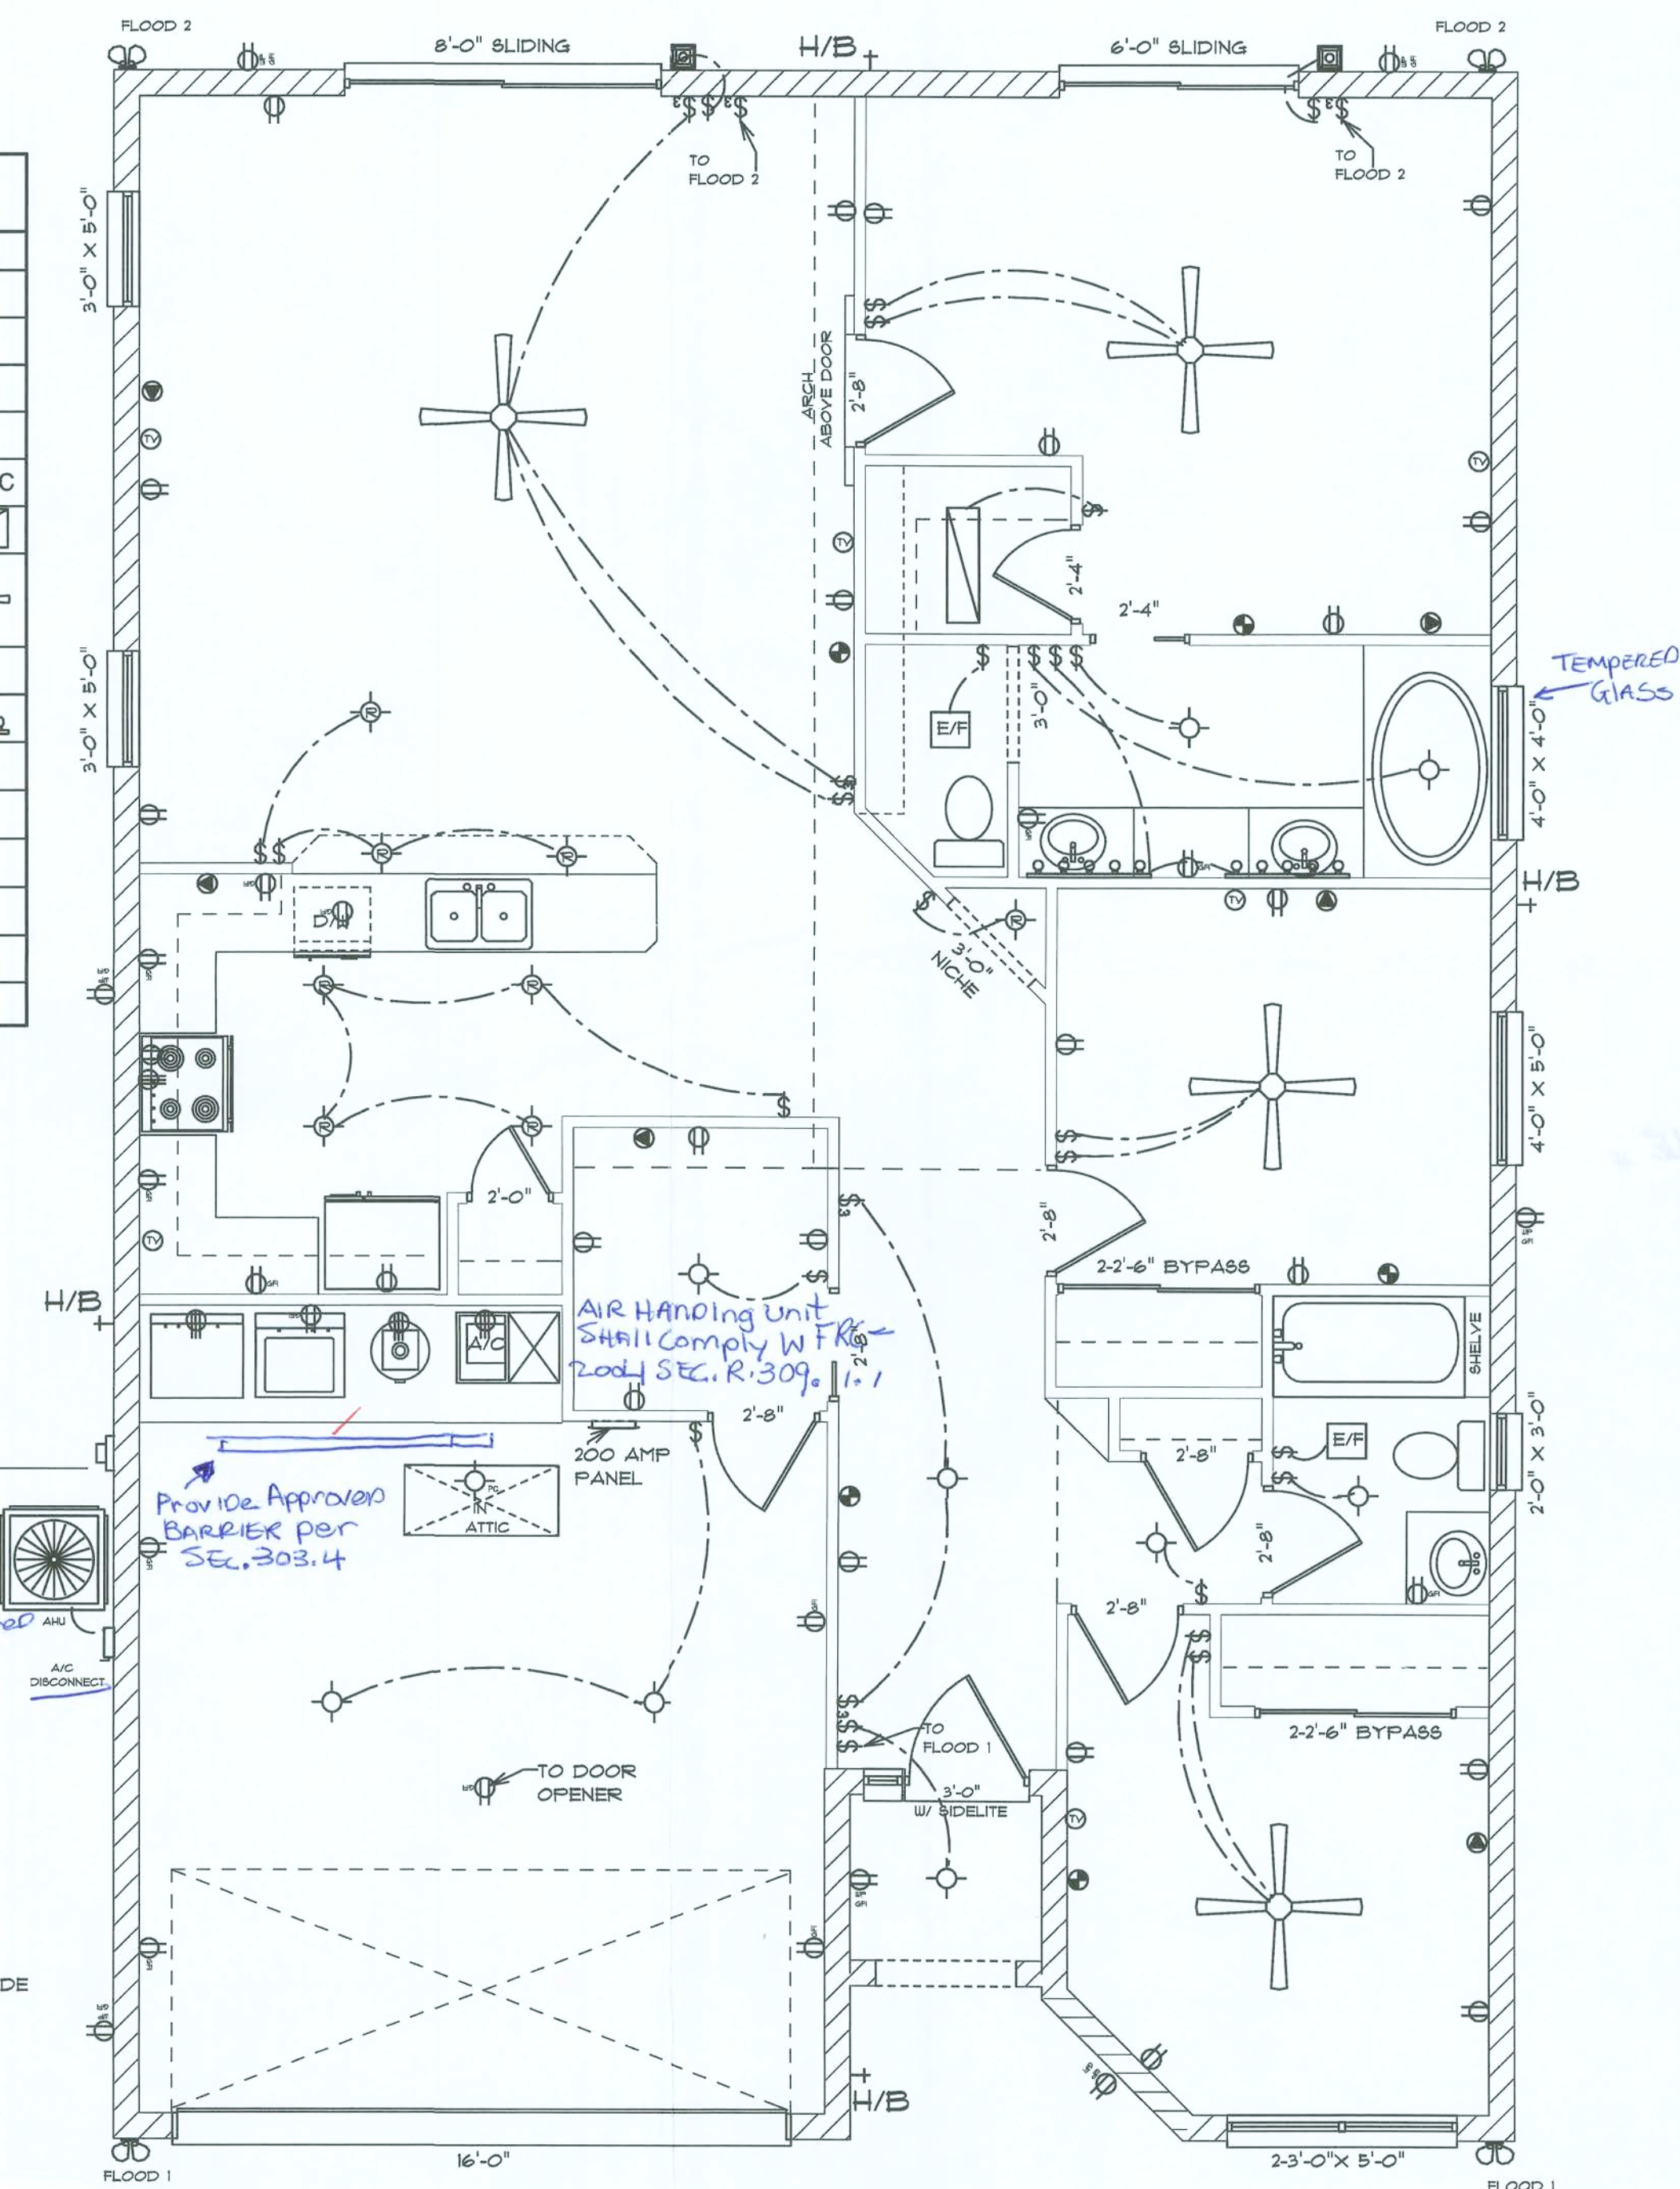

ELECTRICAL PLAN