



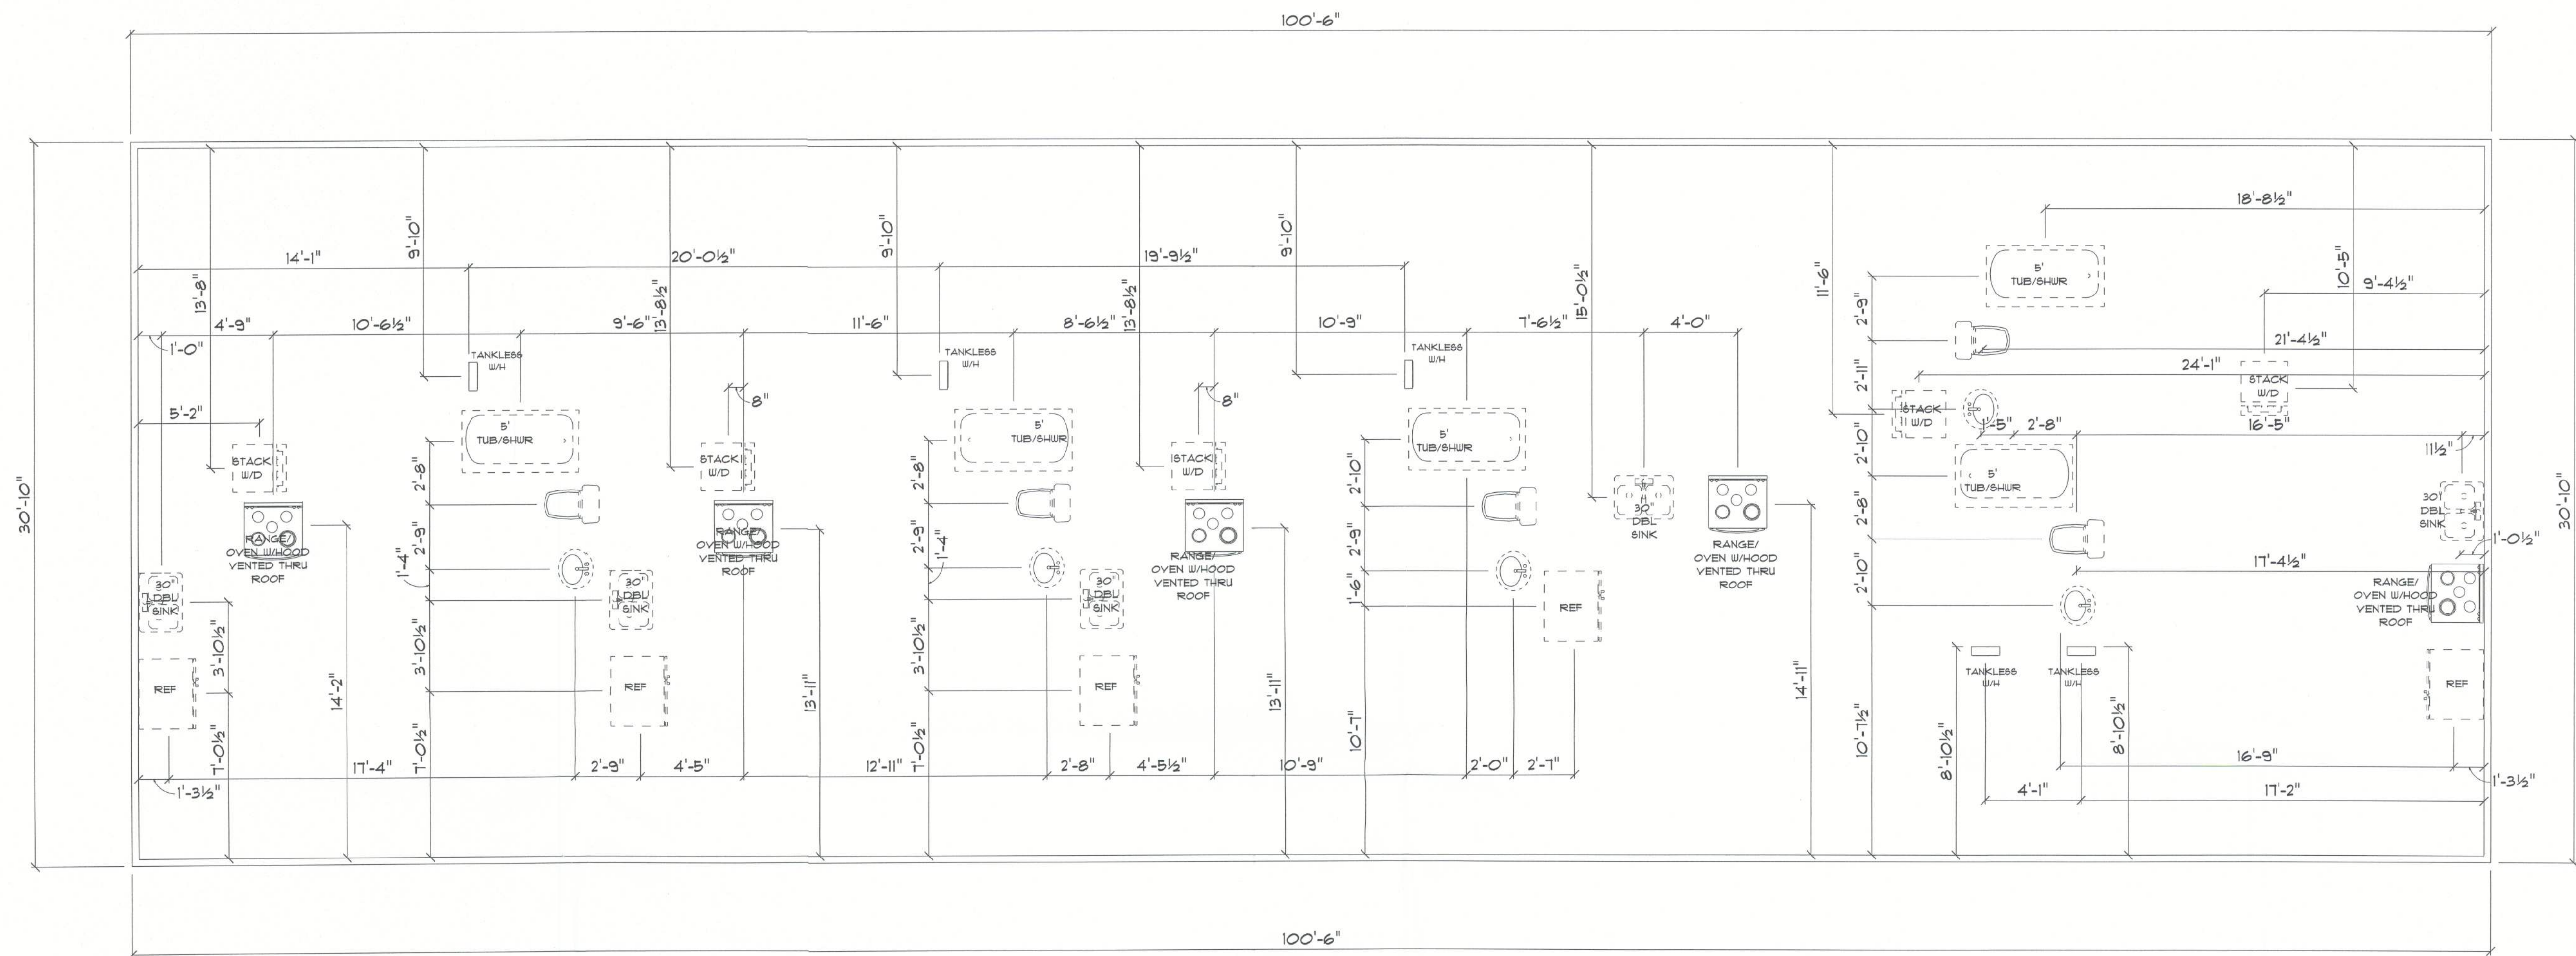

* PROPOSED *
* PLUMBING PLAN *

SCALE : 1/4" = 1'-0"

IMPORTANT NOTES:
1. IT IS THE BUILDER'S RESPONSIBILITY TO VERIFY ALL GEOMETRY AND DIMENSIONS BEFORE ORDERING ANY MATERIALS OR BEGINNING CONSTRUCTION.
2. THESE PLANS ARE FOR LAYOUT AND DESIGN PURPOSES ONLY ALL STRUCTURAL NOTES AND DETAILS TO BE PROVIDED BY AN ENGINEER.

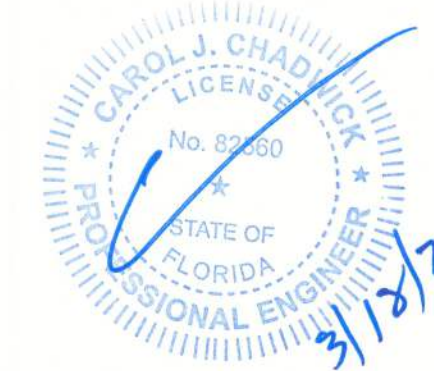

Digitally signed by Carol Chadwick
DN: c=US, o=Florida, dnQualifier=A01410D0000018D46384E7500032FE
E, cn=Carol Chadwick
Date: 2024.03.17 20:41:05 -0400

REMODEL	
for	
DUVAL 5	
SUITE 8	
1580 EAST DUVAL ST LAKE CITY, FLORIDA	
ENGINEER:	
CAROL CHADWICK, P.E. 1208 S.W. FAIRFAX GLEN LAKE CITY, FL 32025 307.680.1172 ccpswyo@gmail.com	
PRINTED DATE: Monday, March 11, 2024	
DRAWN BY: THR	CHECKED BY: CCP.E.
BUILDING CONTRACTOR	
FINALS DATE:	
JOB NUMBER:	
DRAWING NUMBER A-2	
OF 1 SHEETS	