


RUTHERFORD RENTALS, INC.
2304 MAIN BLVD., LAKE CITY FL 32025
3,580 RENTABLE SQ. FT.
3,105 USABLE SQ. FT.



FLOOR PLAN

SCALE: 1/4" = 1'-0"

PAPER SIZE: 24" X 36"

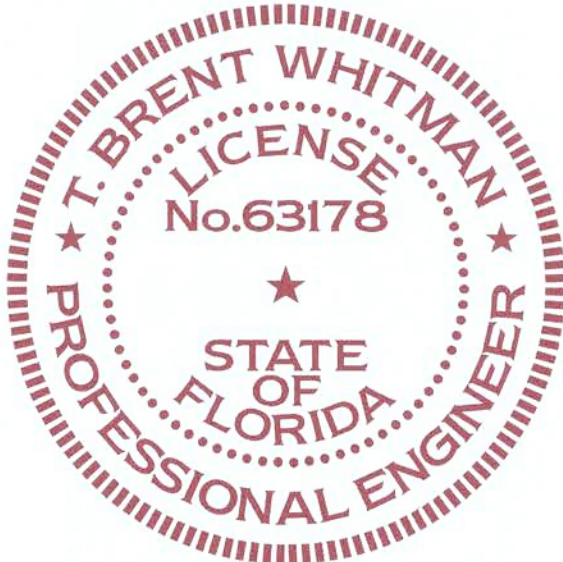

T. BRENT WHITMAN, PE
cn=T. BRENT WHITMAN, PE, o=T. BRENT WHITMAN, PE - This item has been electronically signed and sealed by T. BRENT WHITMAN using a Digital Signature. Printed copies of this document are not considered signed and sealed and the signature must be verified on any electronic copies., ou, email=brent@madisonengineer.com, c=US
2021.06.21 09:23:17 -04'00'




T. BRENT WHITMAN, P.E.
FL P.E. REG. NO. 63178
SHEET NO.
1

MADISON ENGINEERING, LLC
CONSULTING CIVIL & ENVIRONMENTAL ENGINEERING
269 NE Ridge Loop
Madison, Florida 32340
Phone 650.973.7864
www.madisonengineer.com
COA No. 27216

DESIGNED: TBW
DRAWN: DVD
CHECKED: TBW
APPROVED: RUTHERFORD RENTALS
JOB NO.: 9719121
DATE: JUNE 2021
COLUMBIA COUNTY

App# 49828

RUTHERFORD RENTALS, INC.
2304 MAIN BLVD., LAKE CITY FL 32025
3,580 RENTABLE SQ. FT.
3,105 USABLE SQ. FT.

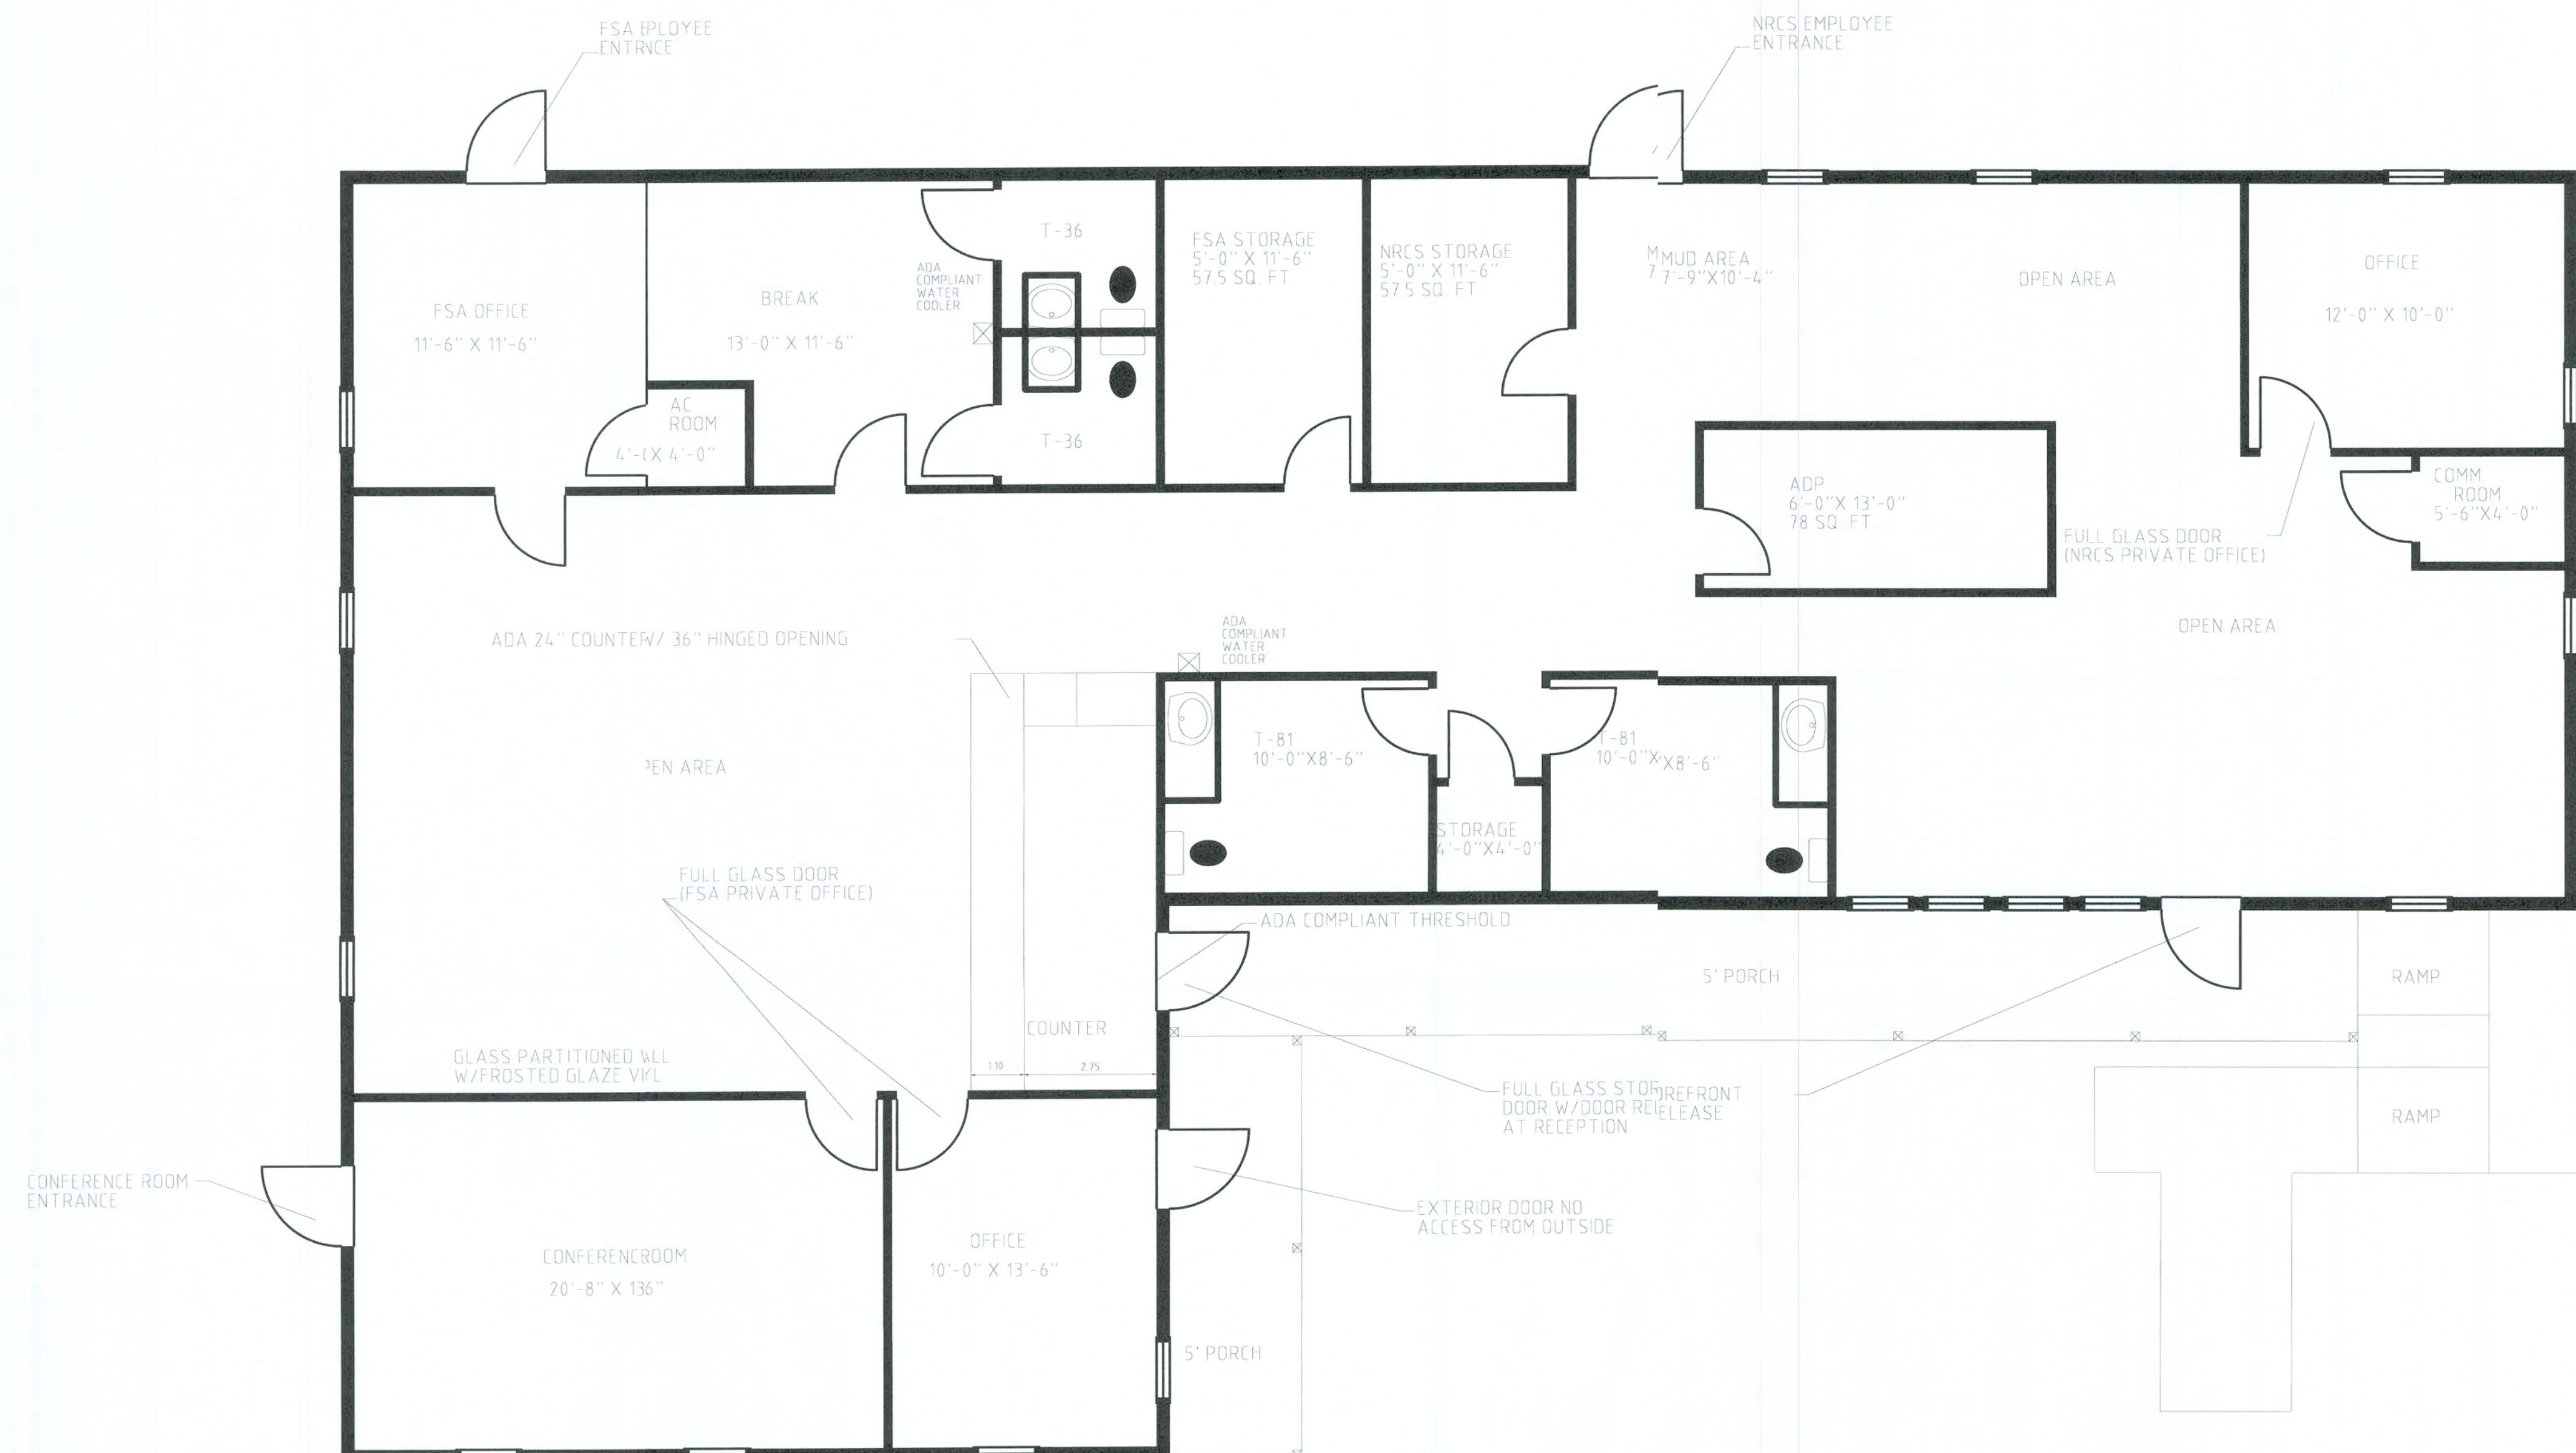

FLOOR PLAN

SCALE: $1/4" = 1'-0"$

PAPER SIZE: 24" X 36"



T. BRENT WHITMAN, PE
cn=T. BRENT WHITMAN, PE, o=T. BRENT
WHITMAN, PE - This item has been
electronically signed and sealed by T.
BRENT WHITMAN using a Digital
Signature. Printed copies of this
document are not considered signed
and sealed and the signature must be
verified on any electronic copies., ou,
email=brent@madisonengineer.com,
c=US
2021.06.21 09:22:22 -04'00'

LUTHERFORD RENTALS, INC.
PROPOSED FLOOR PLAN

NRCS REMODEL PLAN

LAKE CITY, FLORIDA

MADISON ENGINEERING, LLC
CONSULTING CIVIL & ENVIRONMENTAL ENGINEERING

269 NE Ridge Loop
Madison, Florida 32340
Phone 850.973.7864
27216 www.madisonengr.com

Phone 850.973.7864
COA No.: 27216 www.madisonengineer.com


DESIGNED	TBW
DRAWN	DVD
CHECKED	TBW
APPROVED	RUTHE

JOB NO.: 9731917
DATE: JUNE 2004

JOB NO.: 973191


RUTHERFORD RENTALS, INC.
2304 MAIN BLVD., LAKE CITY FL 32025
3,580 RENTABLE SQ. FT.
3,105 USABLE SQ. FT.

ELECTRICAL LEGEND	
●	EXISTING POWER
⊕	NEW POWER
▶	EXISTING DATA
▷	NEW DATA

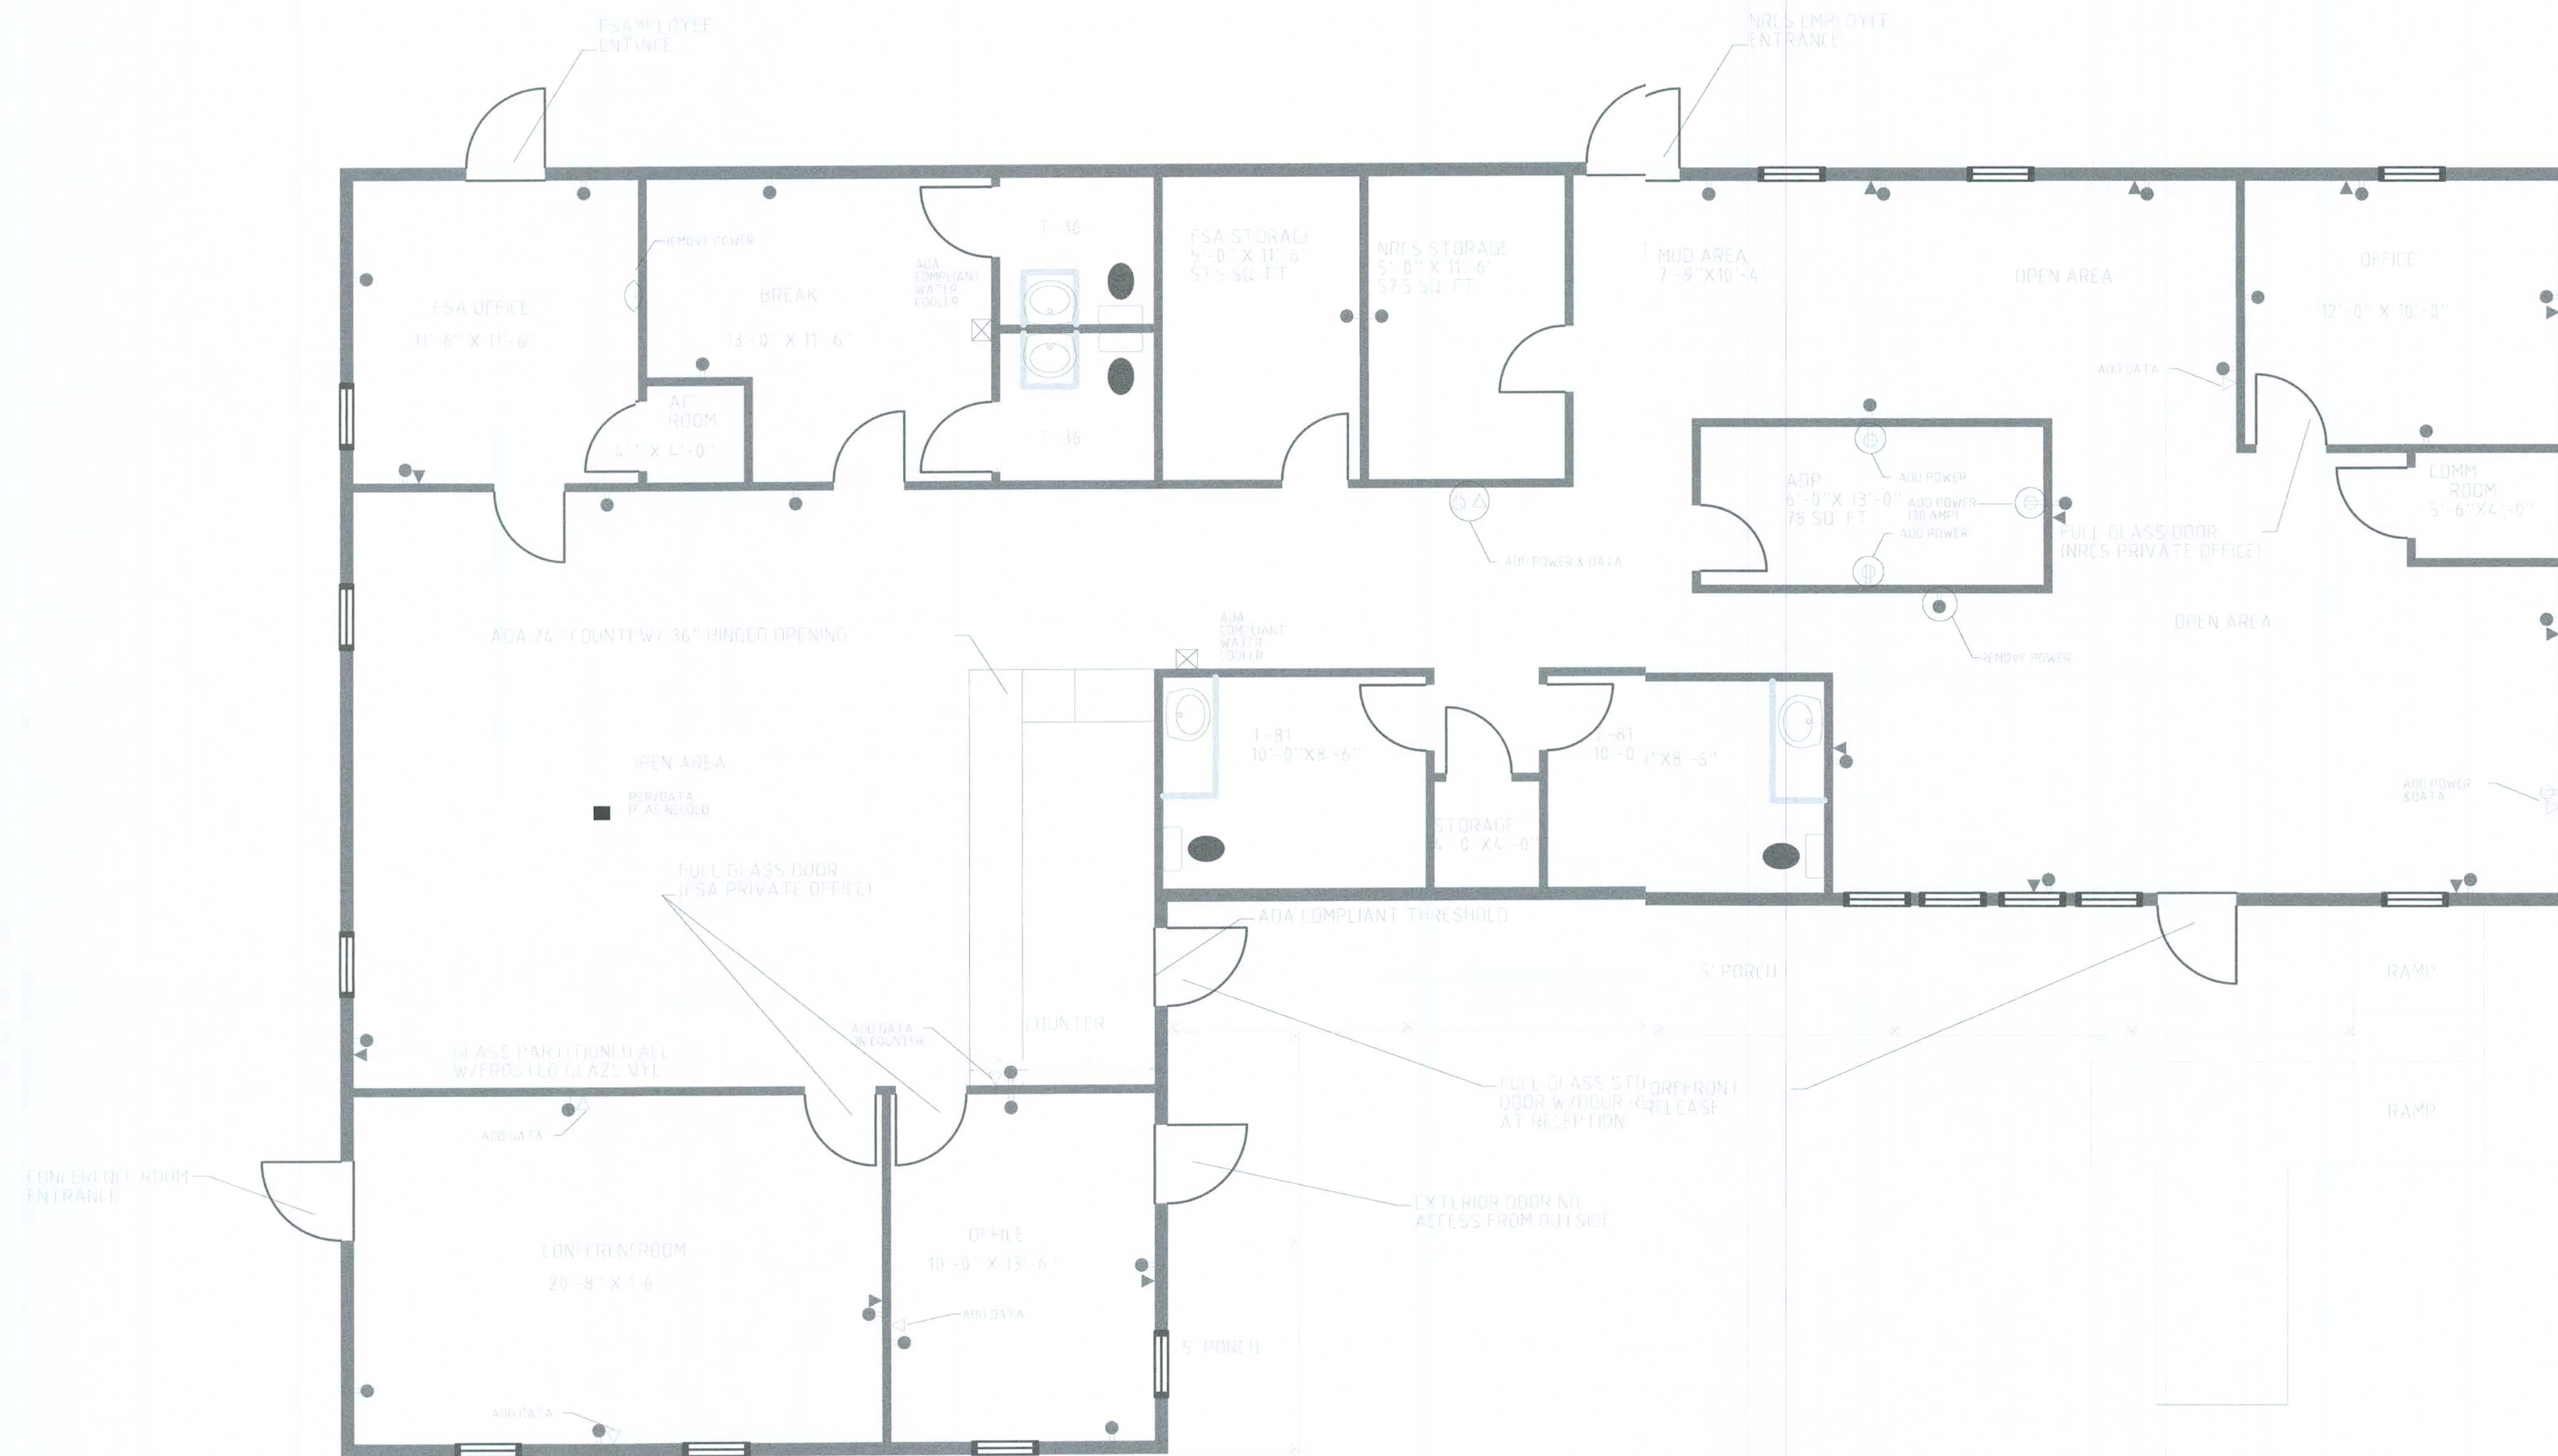

FLOOR PLAN

SCALE: 1/4" = 1'-0"
PAPER SIZE: 24" X 36"

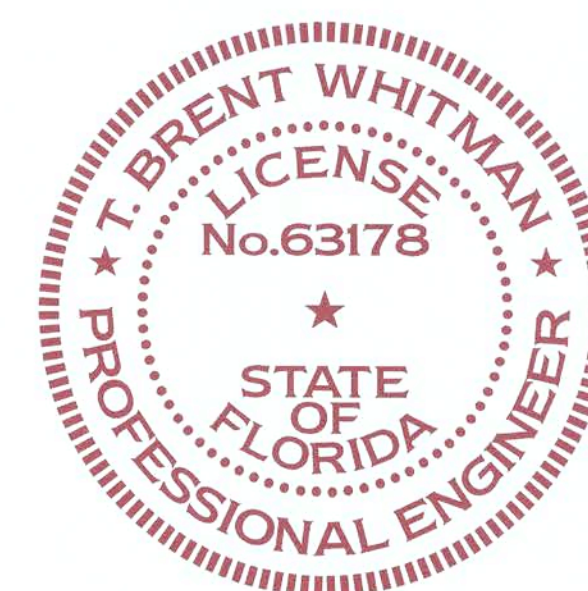

T. BRENT WHITMAN, PE
cn=T. BRENT WHITMAN, PE, o=T. BRENT WHITMAN, PE - This item has been electronically signed and sealed by T. BRENT WHITMAN using a Digital Signature. Printed copies of this document are not considered signed and sealed and the signature must be verified on any electronic copies., ou, email=brent@madisonengineer.com, c=US
2021.06.21 09:24:05 -04'00'

MADISON ENGINEERING, LLC
CONSULTING CIVIL & ENVIRONMENTAL ENGINEERING



NRCS DATA & ELECTRICAL DROPS

RUTHERFORD RENTALS, INC.
PROPOSED FLOOR PLAN

COPYRIGHT 2021 ME

VALID ONLY WITH DIGITAL
SIGNATURE, SIGNATURE AND
EMBEDDED SEAL

T. BRENT WHITMAN, P.E.
FL P.E. REG. NO. 63178

SHEET NO.

3