


OF 4 SHEETS



* FRONT ELEVATION *

SCALE : 1/4" = 1'-0"

NOTE: 18" OVERHANG ALL EAVES

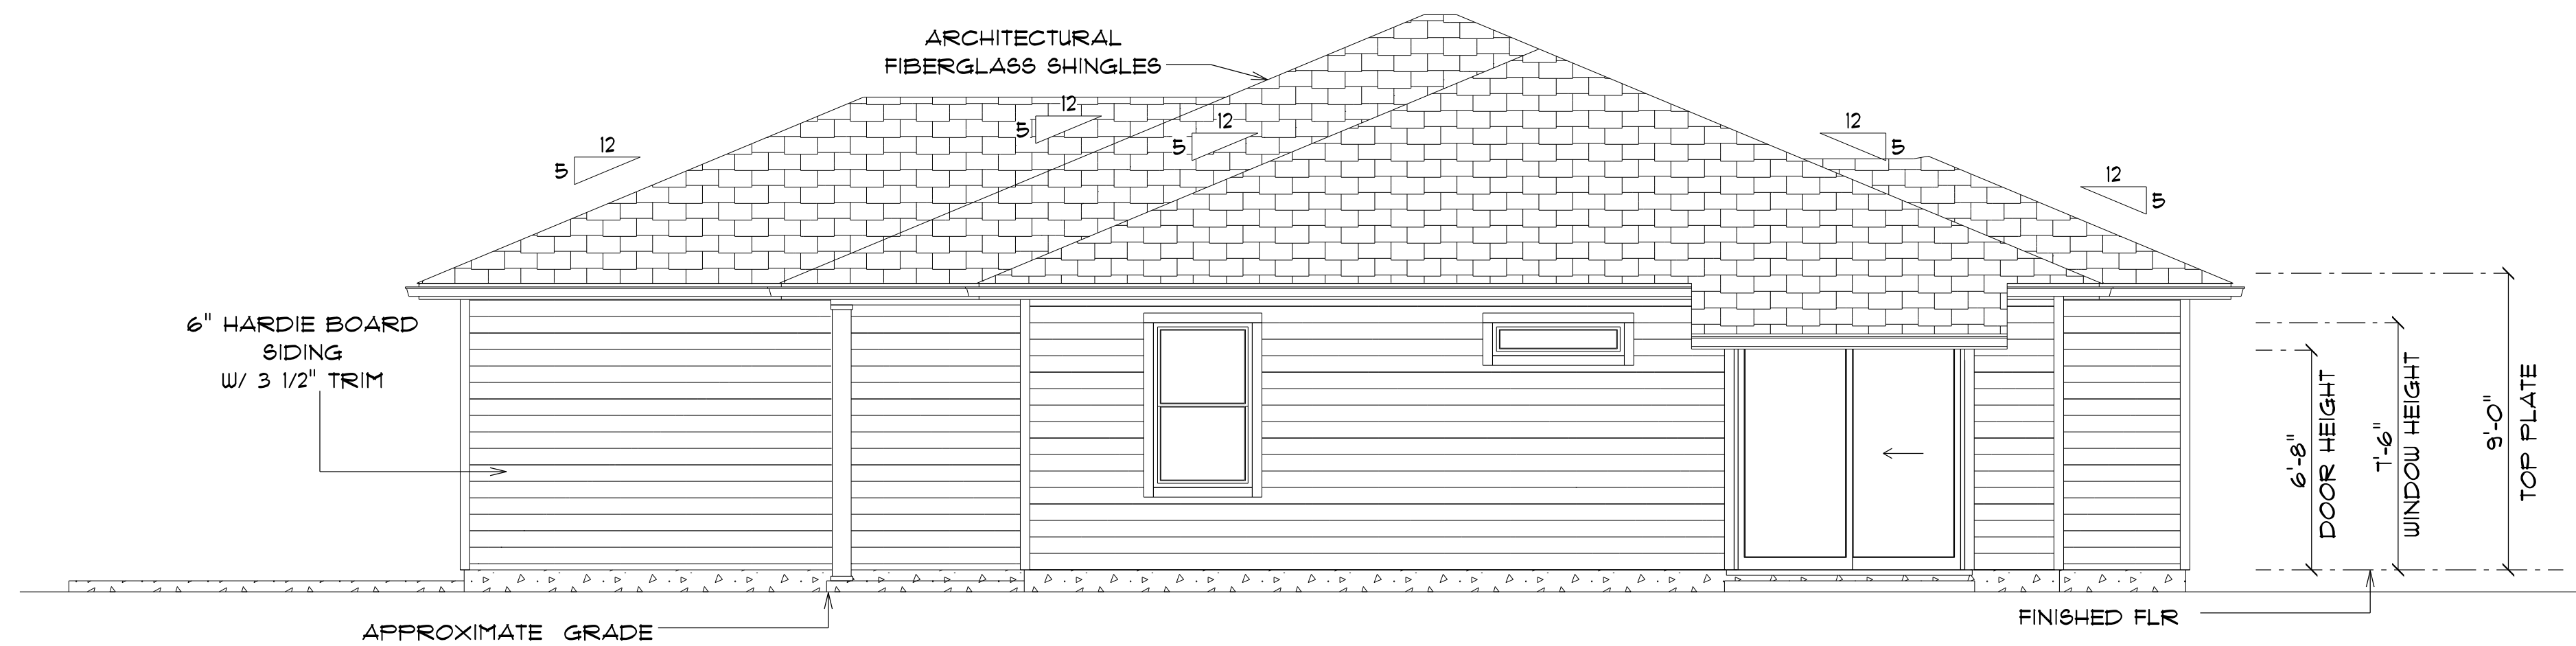

* RIGHT ELEVATION *

SCALE : 1/4" = 1'-0"

NOTE: 18" OVERHANG ALL EAVES

NEW RESIDENCE
for
MC DOUGHERTY &
CARLA FRESE

LAKE CITY, FLORIDA

Teena M. Ruffo
2925 SW SR 47
Lake City Florida, 32025
Cell: (386) 867-1191
Email: teenaruffo@gmail.com

PRINTED DATE:
Monday, March 4, 2024

DRAWN BY: Teena M. Ruffo CHECKED BY:

BUILDING CONTRACTOR
Zacher Construction


FINAL DATE:

JOB NUMBER:

DRAWING NUMBER

A-2


OF 4 SHEETS

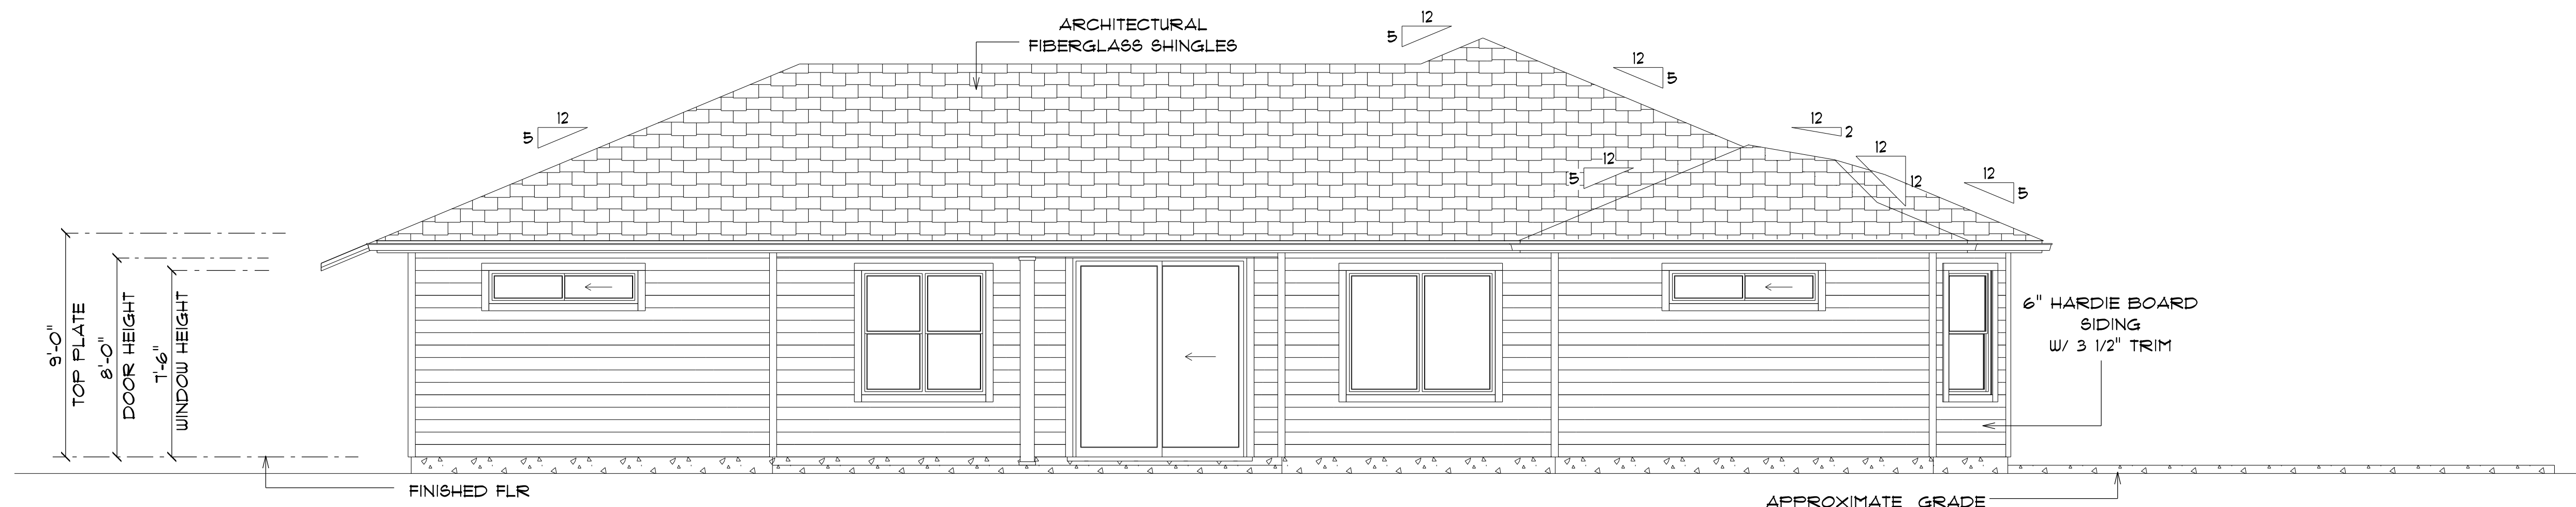

* REAR ELEVATION *

SCALE : 1/4" = 1'-0"

NOTE: 18" OVERHANG ALL EAVES

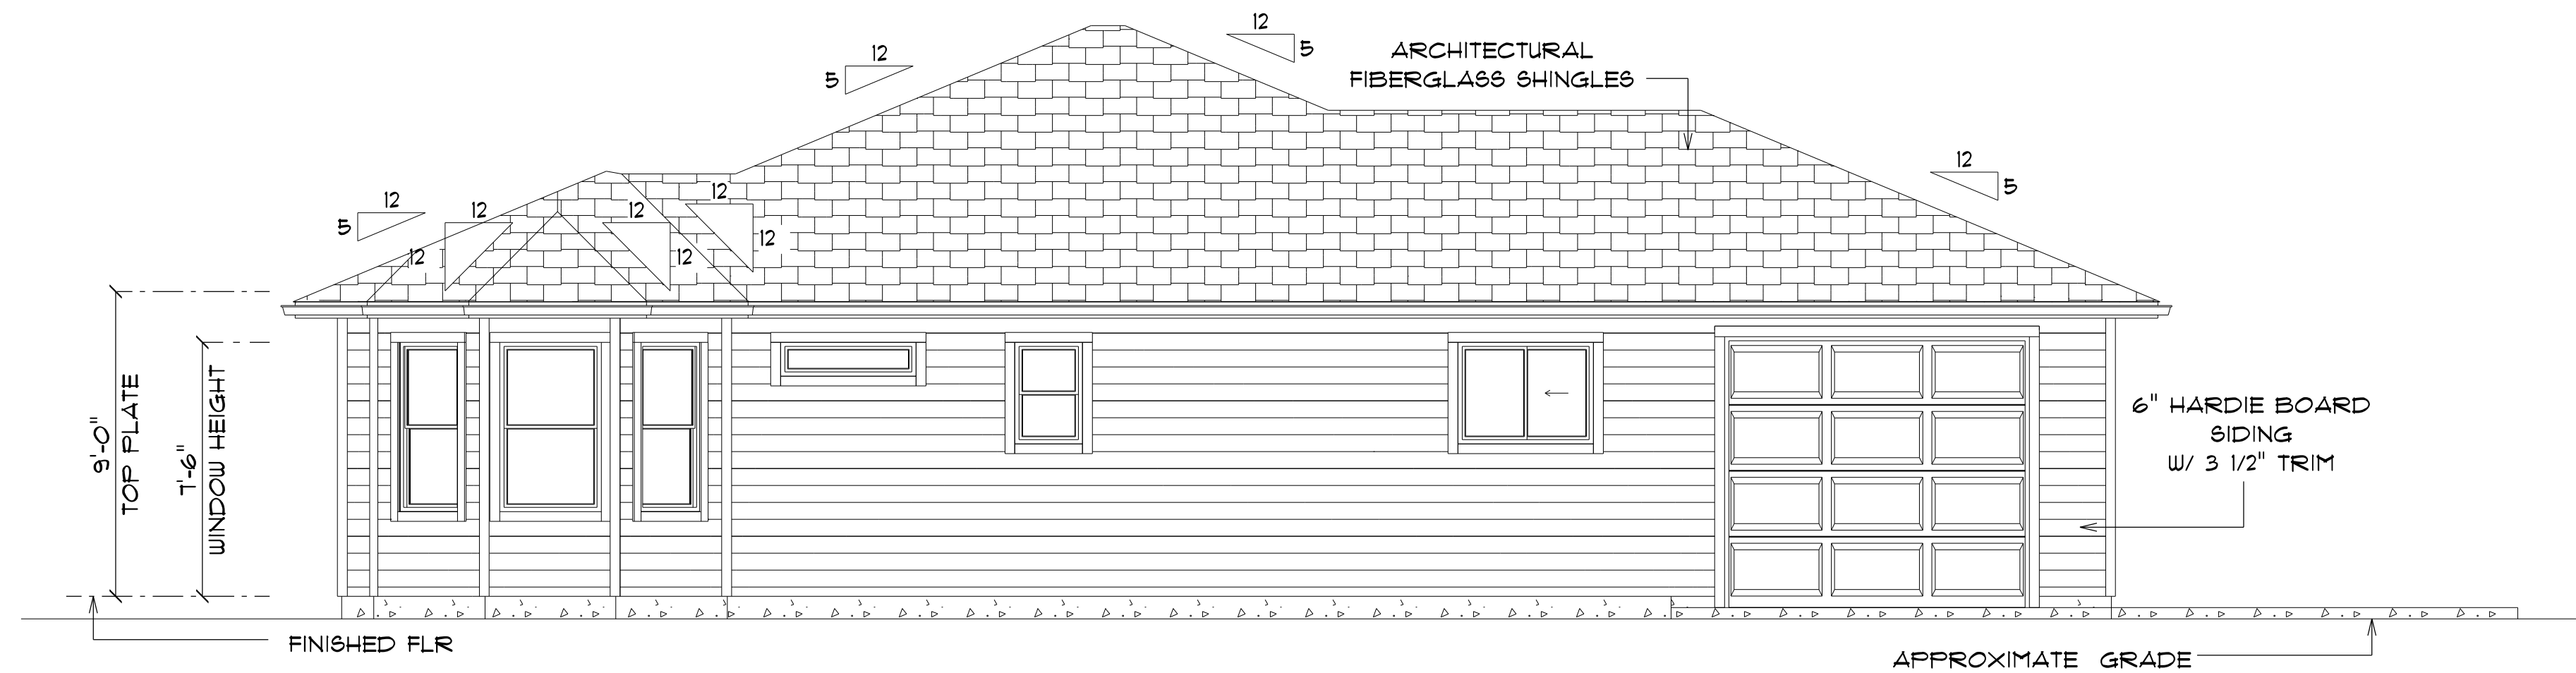

* LEFT ELEVATION *

SCALE : 1/4" = 1'-0"

NOTE: 18" OVERHANG ALL EAVES

NEW RESIDENCE
for
MC DOUGHERTY &
CARLA FRESE

LAKE CITY, FLORIDA

Teena M. Ruffo
2925 SW SR 47
Lake City Florida, 32025
Cell: (386) 861 - 1191
Email: teenaruffo@gmail.com

PRINTED DATE:
Monday, March 4, 2024

DRAWN BY: Teena M. Ruffo

CHECKED BY:

BUILDING CONTRACTOR
Zacher Construction


FINAL DATE:

JOB NUMBER:

DRAWING NUMBER

A-3

OF 4 SHEETS

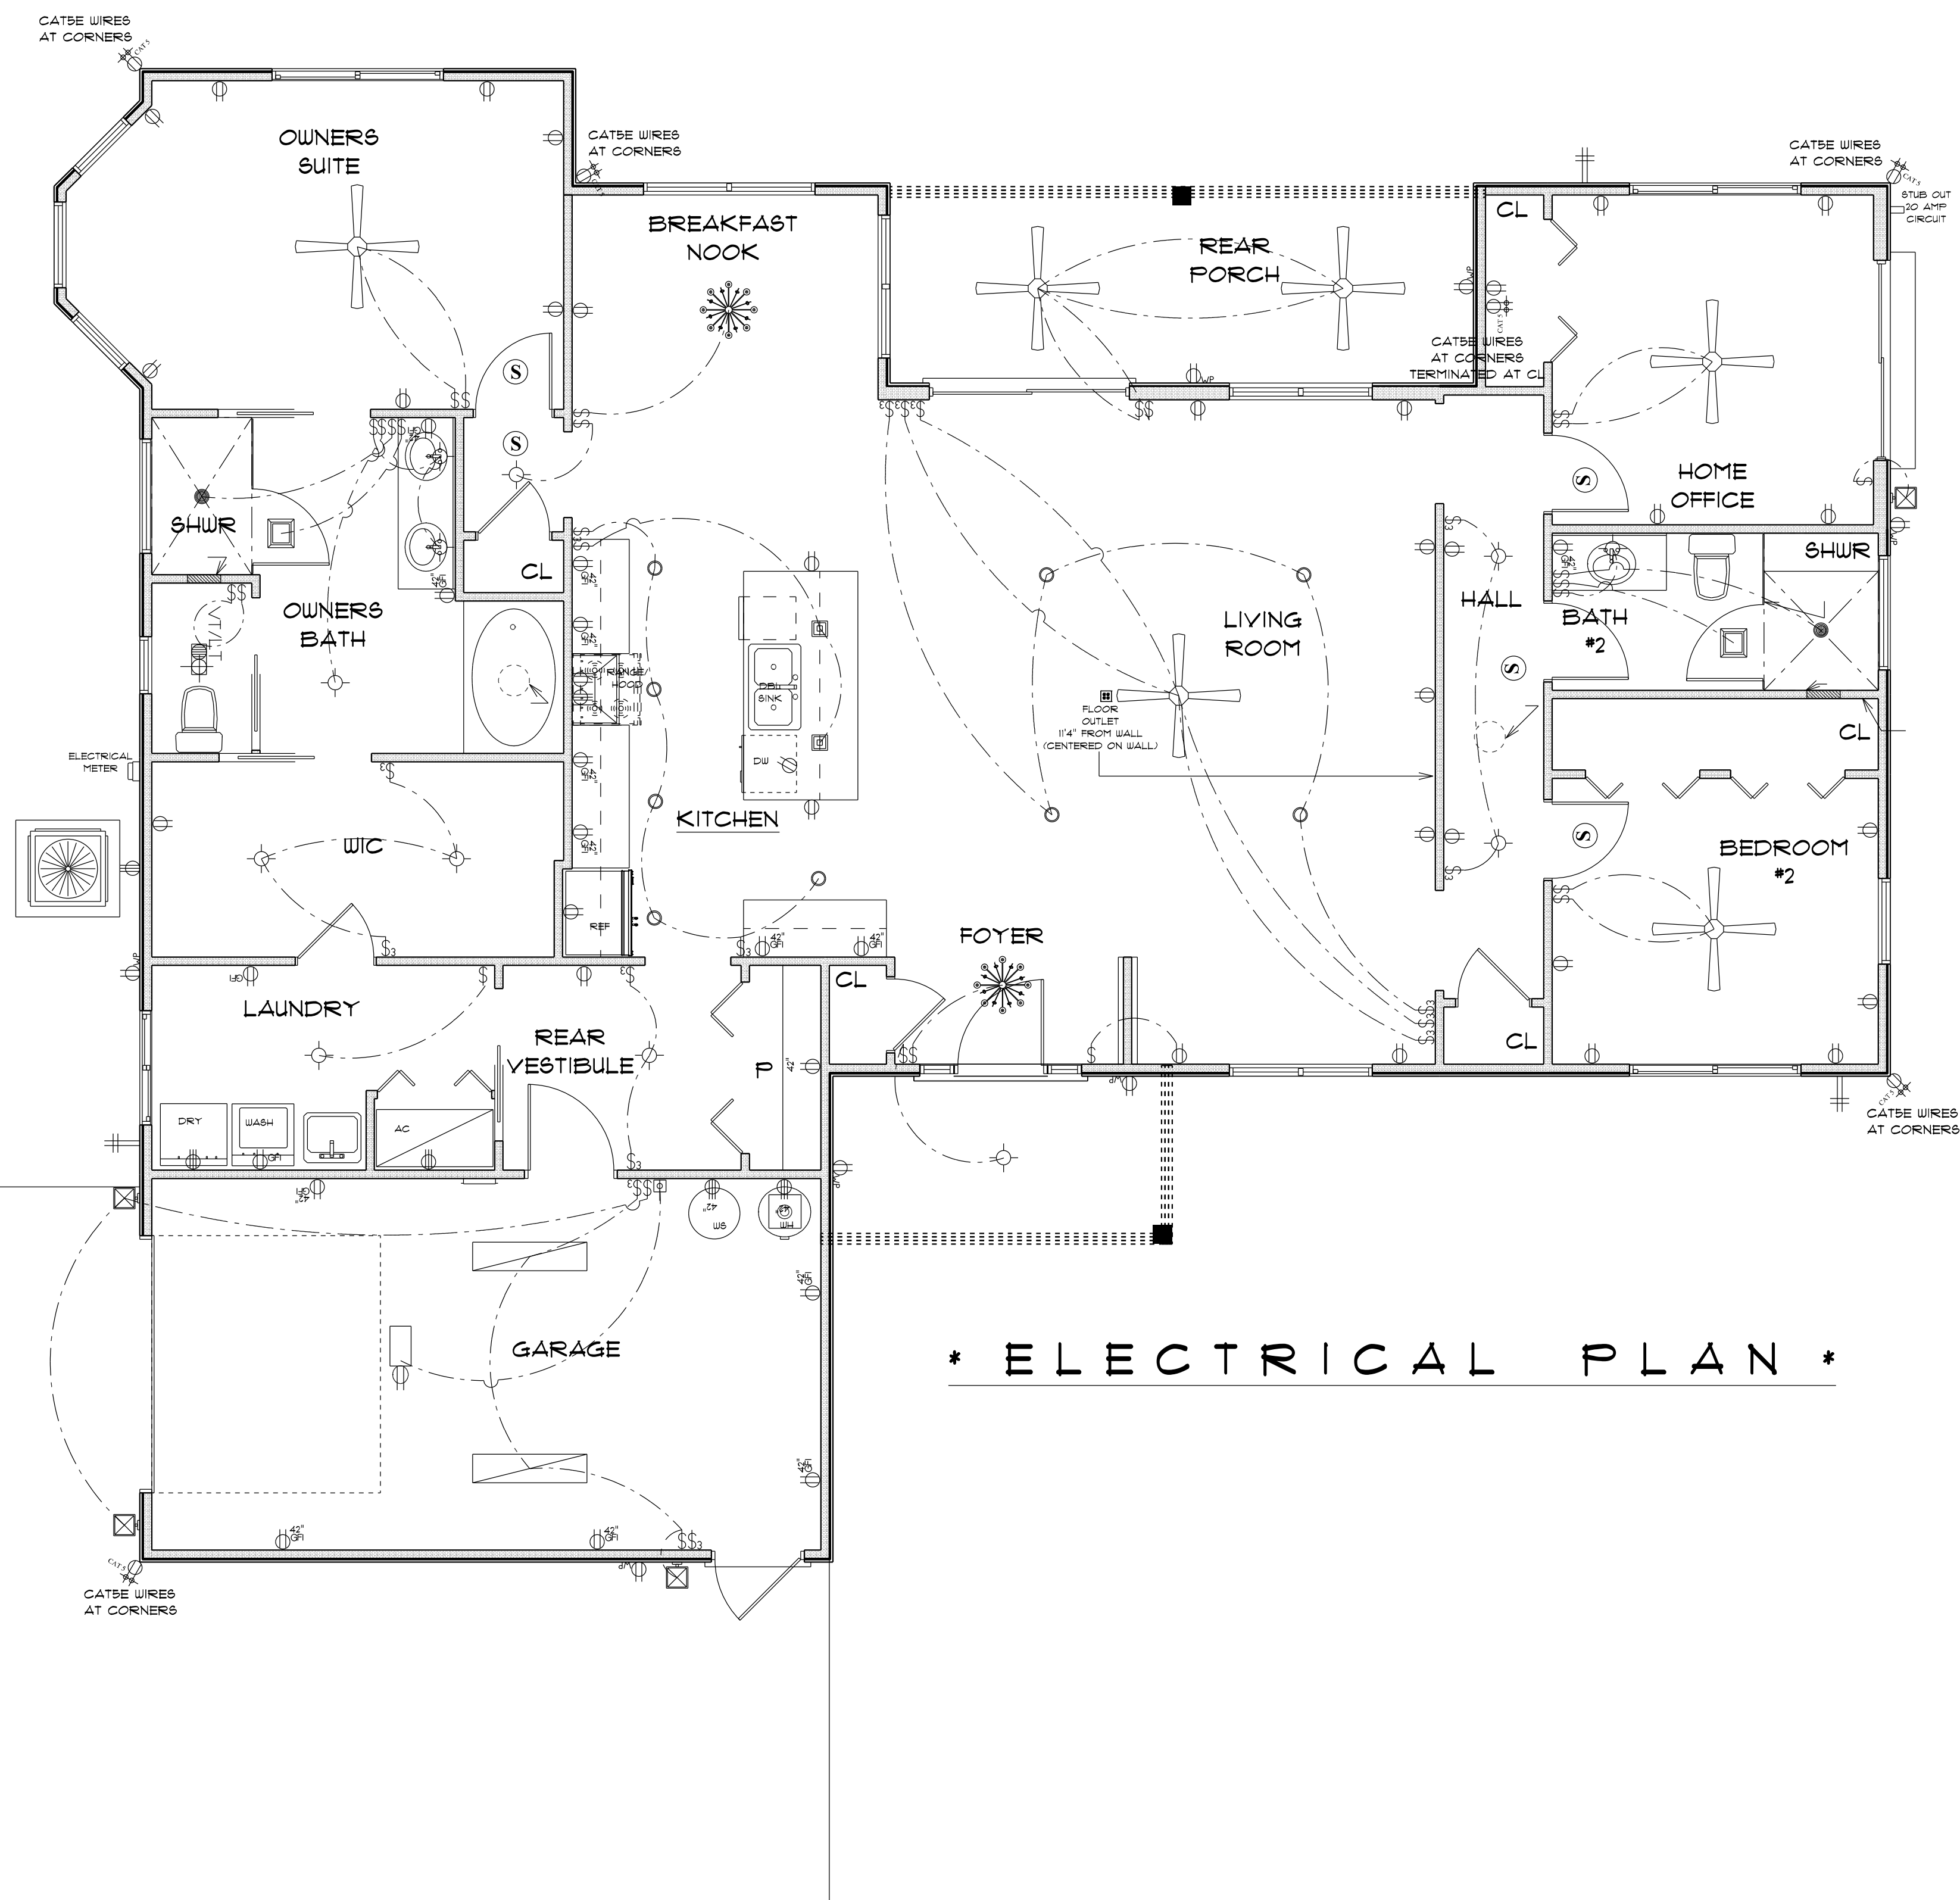

* ELECTRICAL PLAN *

ELECTRICAL LEGEND		
ELECTRICAL	COUNT	SYMBOL
ceiling fan	6	
ceiling classic	2	
vent	2	
fluorescent light 1 x 4	2	
pendant large	2	
pot light	12	
exterior light 03	4	
Smoke Detector	5	
electrical panel	1	
automatic garage dr opener	1	
garage dr opener	1	
light	11	
outlet	32	
outlet 220v	6	
catse		
outlet gfi	16	
outlet wp	7	
switch	25	
switch 3 way	18	
vent light combo	1	

ELECTRICAL PLAN NOTES

- E-1 WIRE ALL APPLIANCES, HVAC UNITS AND OTHER EQUIPMENT PER MANUFACTURERS SPECIFICATIONS.
- E-2 CONSULT THE OWNER FOR THE NUMBER OF SEPERATE TELEPHONE LINES TO BE INSTALLED.
- E-3 ALL INSTALLATIONS SHALL BE PER NATIONAL ELECTRIC CODE.
- E-4 ALL SMOKE DETECTORS SHALL BE 120V W/BATTERY BACKUP OF THE PHOTOELECTRIC TYPE, AND SHALL BE INTERLOCKED TOGETHER. INSTALL INSIDE AND NEAR ALL BEDROOMS.
- E-5 TELEPHONE, TELEVISION AND OTHER LOW VOLTAGE DEVICES OR OUTLETS SHALL BE AS PER THE OWNERS DIRECTION AND IN ACCORDANCE WITH AFFLICABLE SECTIONS OF NATIONAL ELCT. CODE LATEST EDITION.
- E-6 ELECTRICAL CONTRACTOR SHALL BE RESPONSIBLE FOR THE DESIGN AND SIZING OF ELECTRICAL SERVICE AND CIRCUITS.
- E-7 ENTRY OF SERVICE UNDERGROUND OR OVERHEAD) IS TO BE DETERMINED BY THE POWER COMPANY.
- E-8 ALL BEDROOM RECEPTALS ARE TO BE AFCI (ARC FAULT CIRCUIT INTERRUPT).

NEW RESIDENCE
for
MC DOUGHERTY &
CARLA FREEE

LAKE CITY, FLORIDA

Teena M. Ruffo
2925 SW SR 47
Lake City Florida, 32025
Cell: (386) 867 - 1191
Email: teenaruffo@gmail.com

PRINTED DATE: Monday, March 4, 2024	
DRAWN BY: Teena M. Ruffo	CHECKED BY:
BUILDING CONTRACTOR Zacher Construction	
FINAL& DATE:	
JOB NUMBER:	
DRAWING NUMBER A-4	
OF 4 SHEETS	