



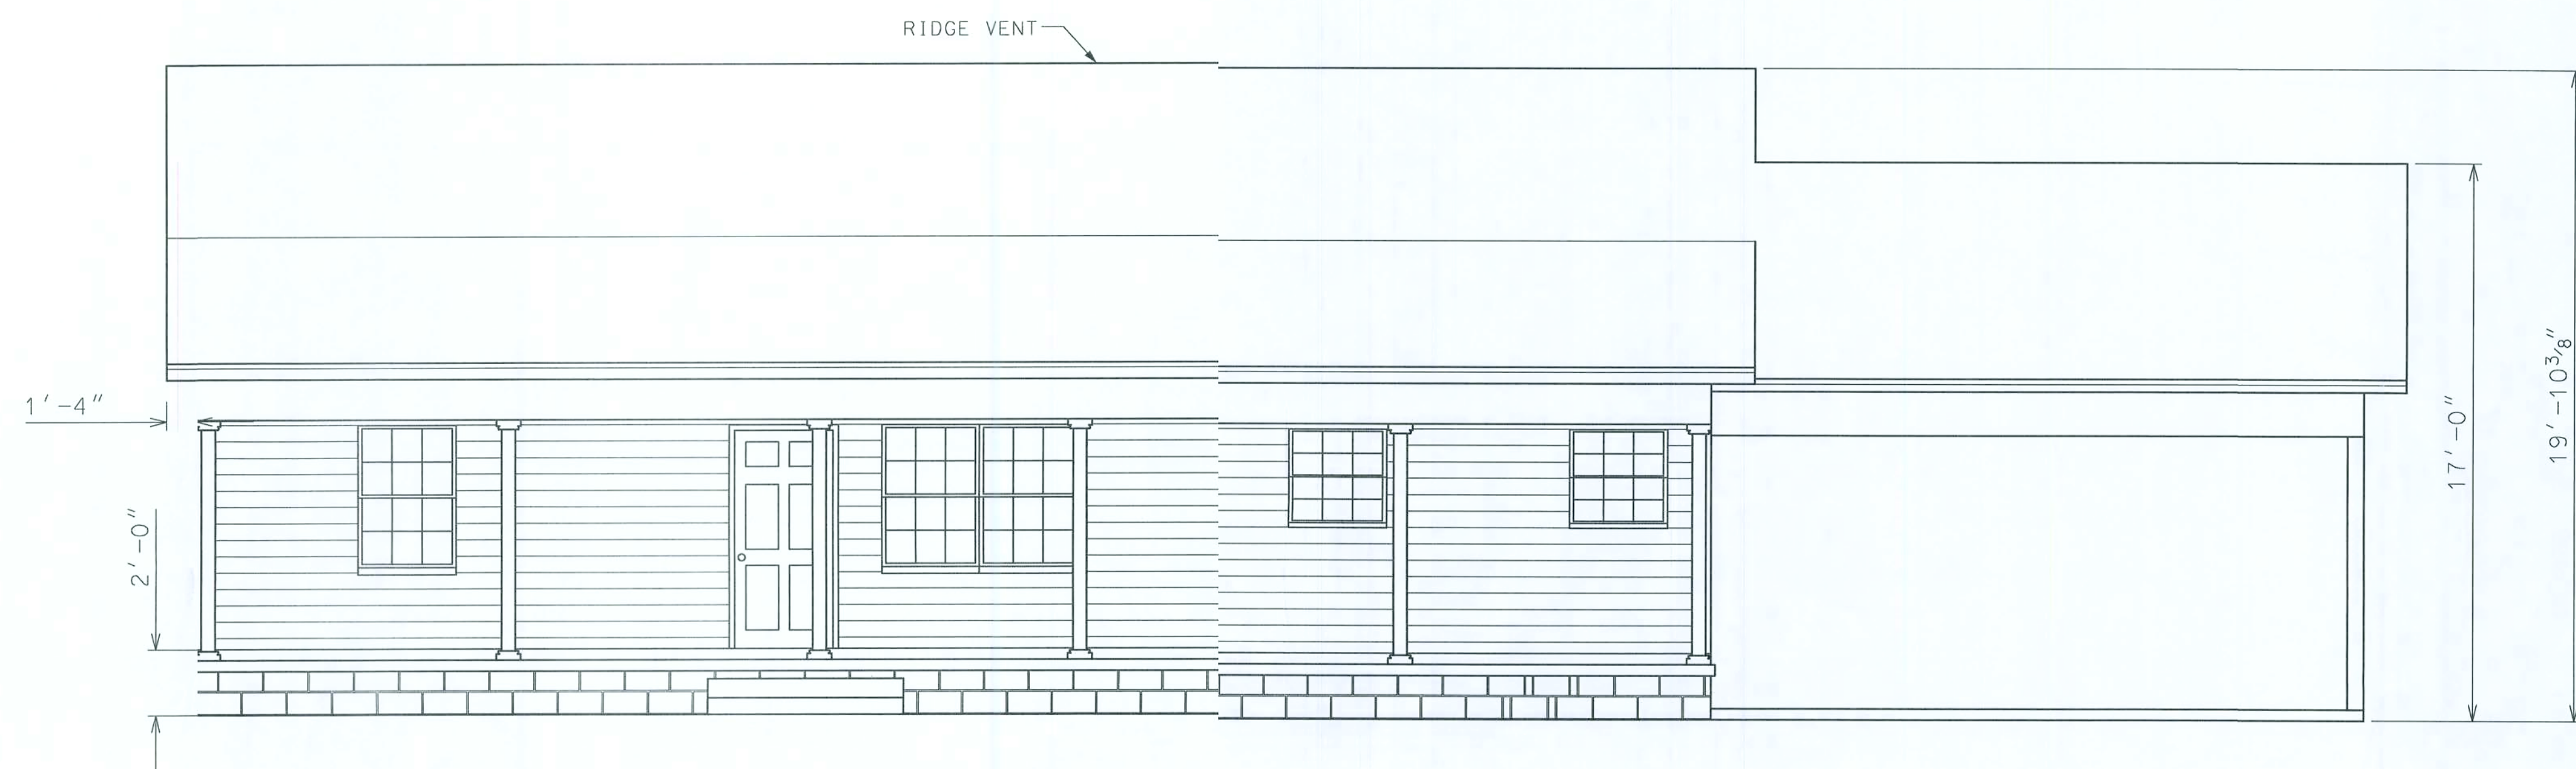

FRONT ELEVATION

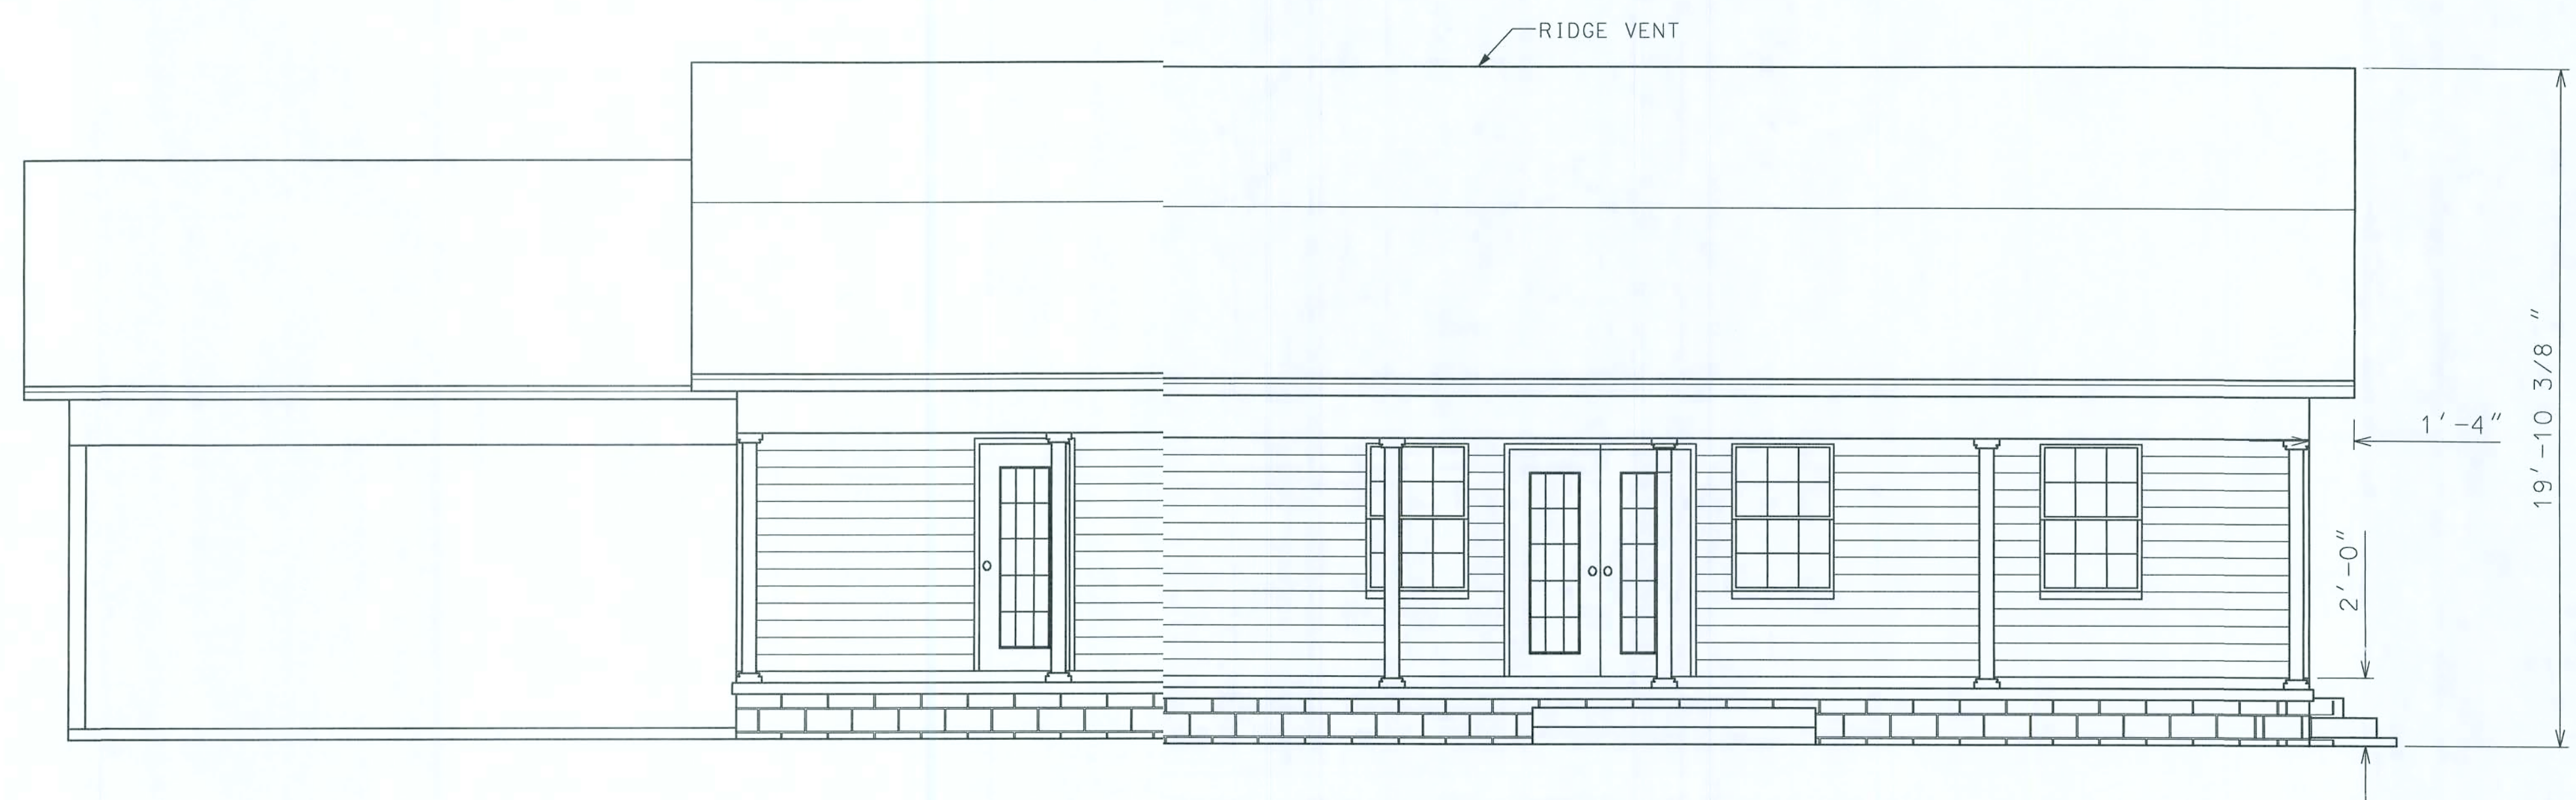

REAR ELEVATION

THERES DRAWINGS, AS INSTRUMENTS OF SERVICE, ARE THE SOLE PROPERTY OF HAYGOOD HOKS, INC., AND ARE MAY NOT BE USED, COPIED OR REPRODUCED IN WHOLE OR IN PART FOR USE ON OR INCORPORATED WITHIN ANY OTHER JOB WITHOUT SPECIF; AND INDIVIDUAL AUTHORIZATION BY HAYGOOD HOMES, INC.,



HAYGOOD HOMES INC.

File


12592 So. U.S. HWY 441
LAKE CITY FL. 32025
OFFICE (386) 752-3496
MOBILE (386) 303-1981
CR-C1326715

Dusty McCray


Lake City Florida

ELEVATION

PLAN No.	SCALE	DATE	SHEET NO.
P 0706	1/4" = 1'	11/10/07	1

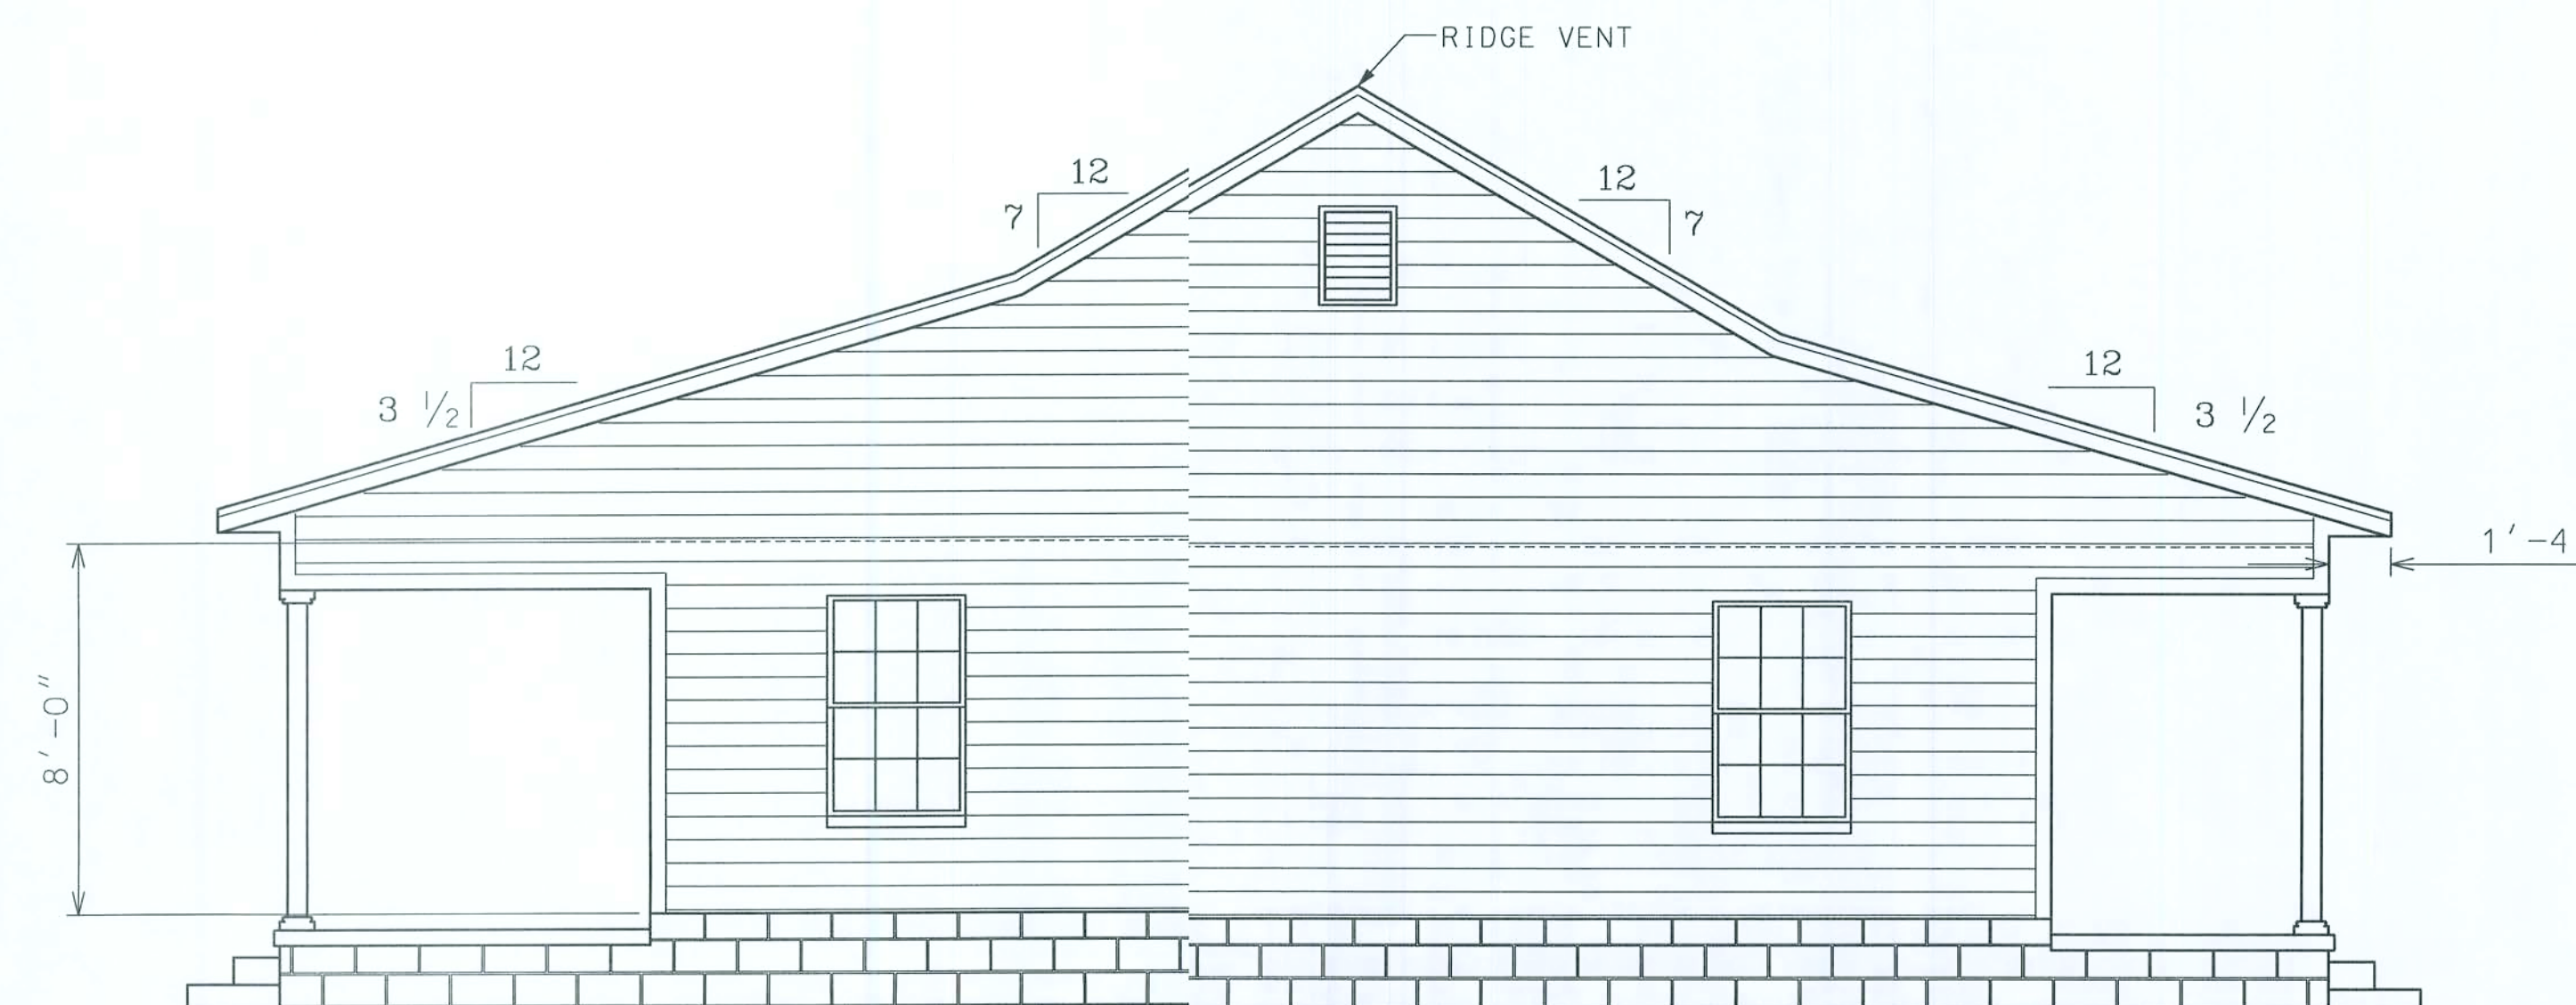

LEFT ELEVATION

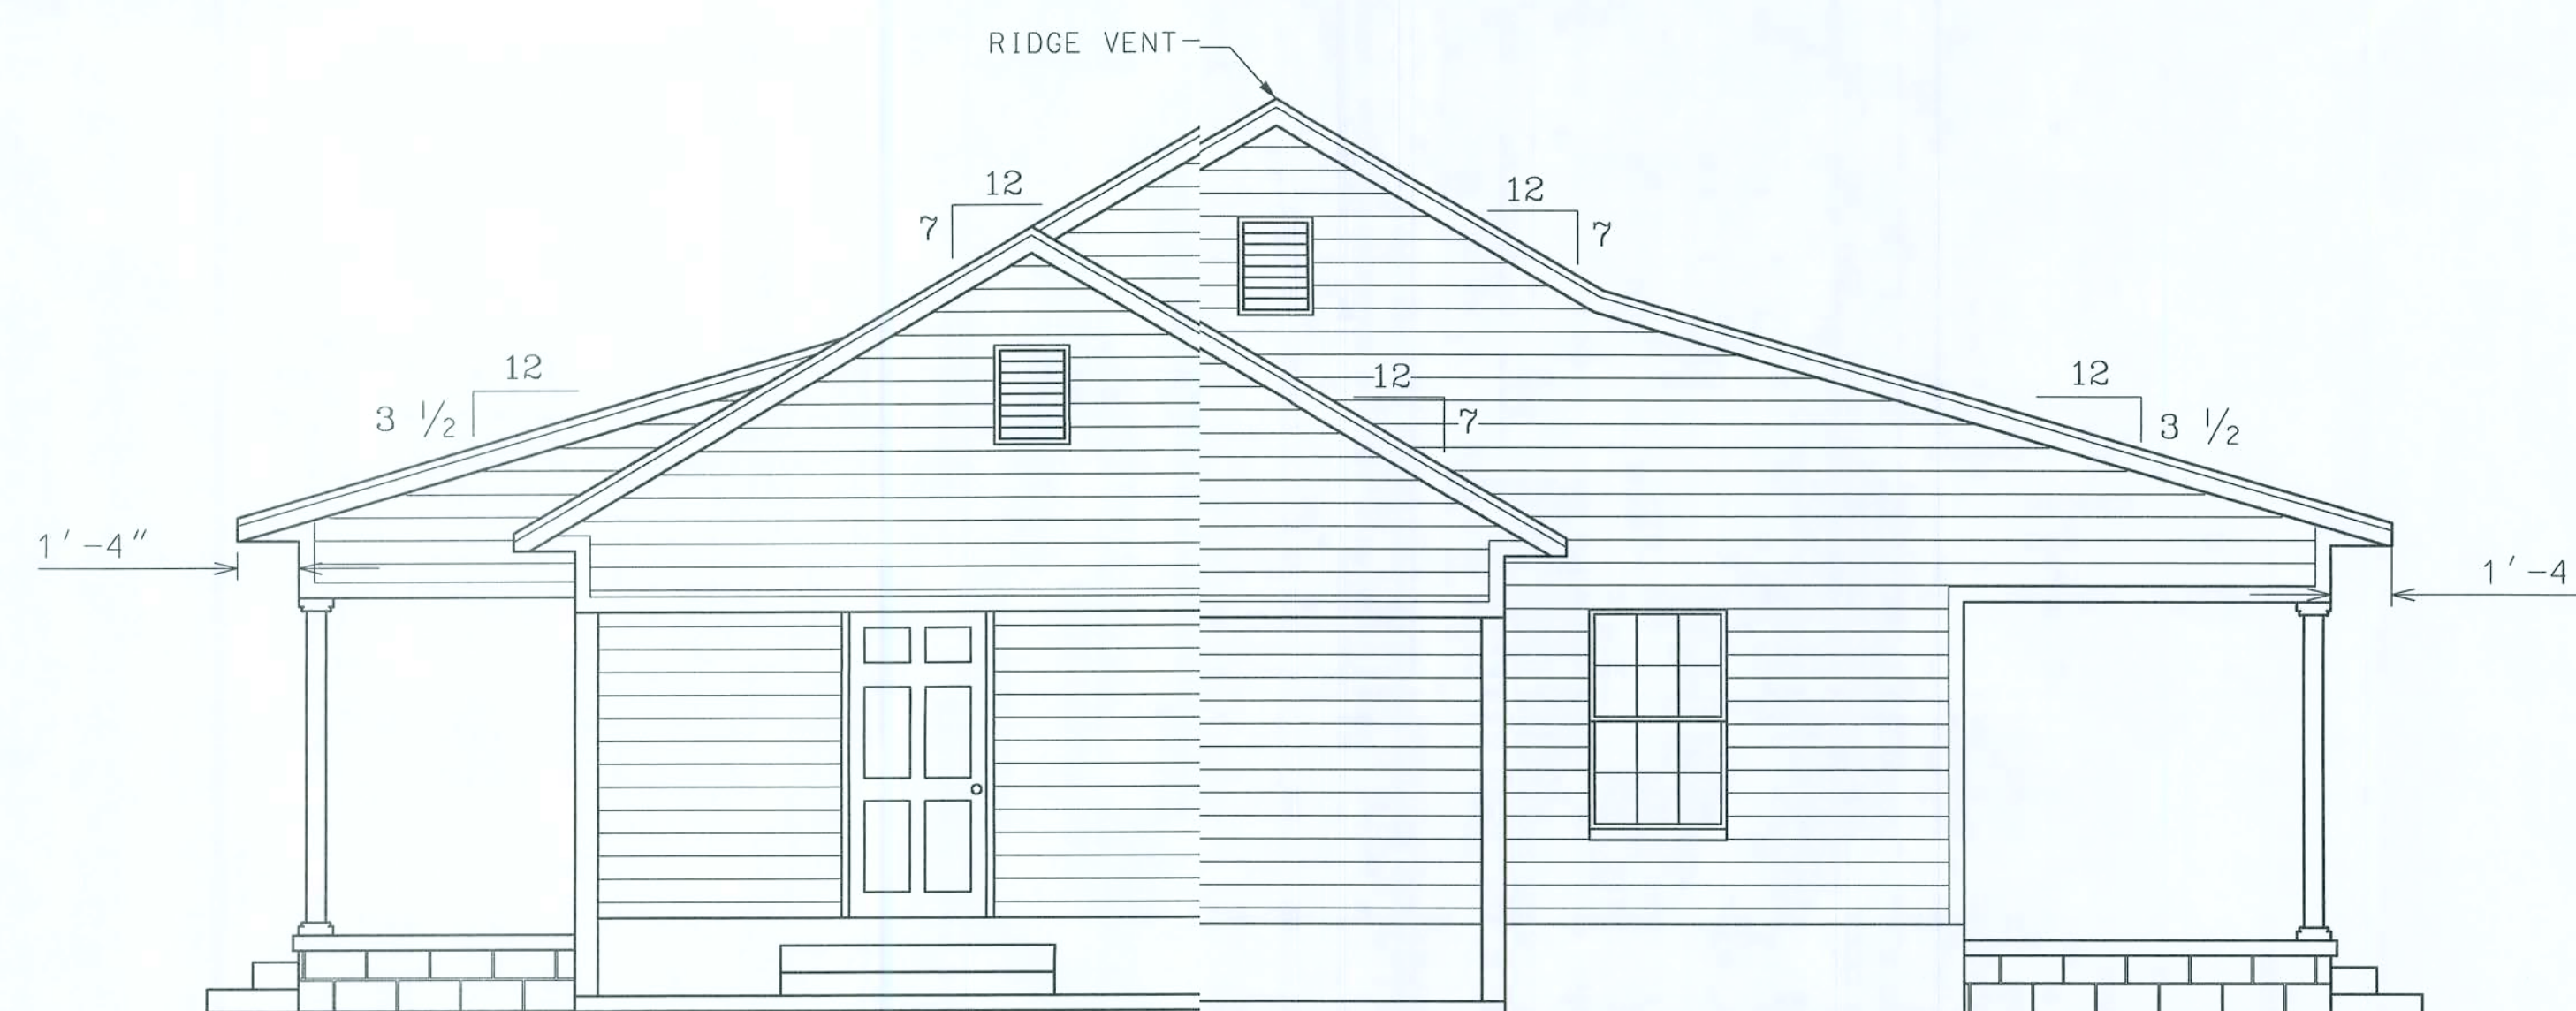

RIGHT ELEVATION

THESE DRAWINGS, AS INSTRUMENTS OF SERVICE, ARE THE SOLE PROPERTY OF HAYGOOD HOMES, INC., AND ARE MAY NOT BE USED, COPIED OR REPRODUCED IN WHOLE OR IN PART FOR USE ON OR INCORPORATED WITHIN ANY OTHER JOB WITHOUT SPECIFIC AND INDIVIDUAL AUTHORIZATION BY HAYGOOD HOMES, INC..



HAYGOOD HOMES INC.


12592 So. U.S. HWY 441
LAKE CITY FL. 32025
OFFICE (386) 752-3496
MOBILE (386) 303-1981
CR-C1326715

Dusty McCray

Lake City Florida

ELEVATION

PLAN No.	SCALE	DATE	SHEET NO.
P 0707	1/4" = 1'	11/10/07	2

 

FLOOR AREA	1470 SF
PORCHES	686 SF
TOTAL	2156 SF

THESE DRAWINGS, AS INSTRUMENTS OF SERVICE, ARE THE SOLE PROPERTY OF HAYGOOD HOME, INC., AND ARE MAY NOT BE USED, COPIED OR REPRODUCED IN WHOLE OR IN PART FOR USE ON OR INCORPORATED WITHIN ANY OTHER JOB WITHOUT SPECIFIC AND INDIVIDUAL AUTHORIZATION BY HAYGOOD HOMES, INC.,



HAYGOOD HOMES INC.

12592 So. U.S. HWY 441
LAKE CITY FL 32025
OFFICE (386) 752-3496
MOBILE (386) 303-1981
CR-C1326715


Dusty McCray

Lake Cityy Florida

FLOOR PLAN

PLAN No.	SCALE	DATE	SHEET NO.
P 0706	1/4" = 1'	11/10/07	3

- - HVAC UNIT
- 200 A
- 200 AMP BRAKER BOX
- - METER BASE
- - VANITY LIGHT AS SPECIFIED
- ⊕ - LIGHT FIXTURE
- ⊕ - LIGHT FIXTURE
- \$ - SINGLE POLE SWITCH
- \$3 - THREE-WAY SWITCH
- ⊕ - RECEPT.
- ☼ - SECURITY LIGHT
- ⊗ - EXHAUST
- ▲ - 220 V.
- Ⓢ - SMOKE DETECTOR
(AC/DC and interconnected)
- ☐ - TELEPHONE
- ⊥TV - TELEVISION

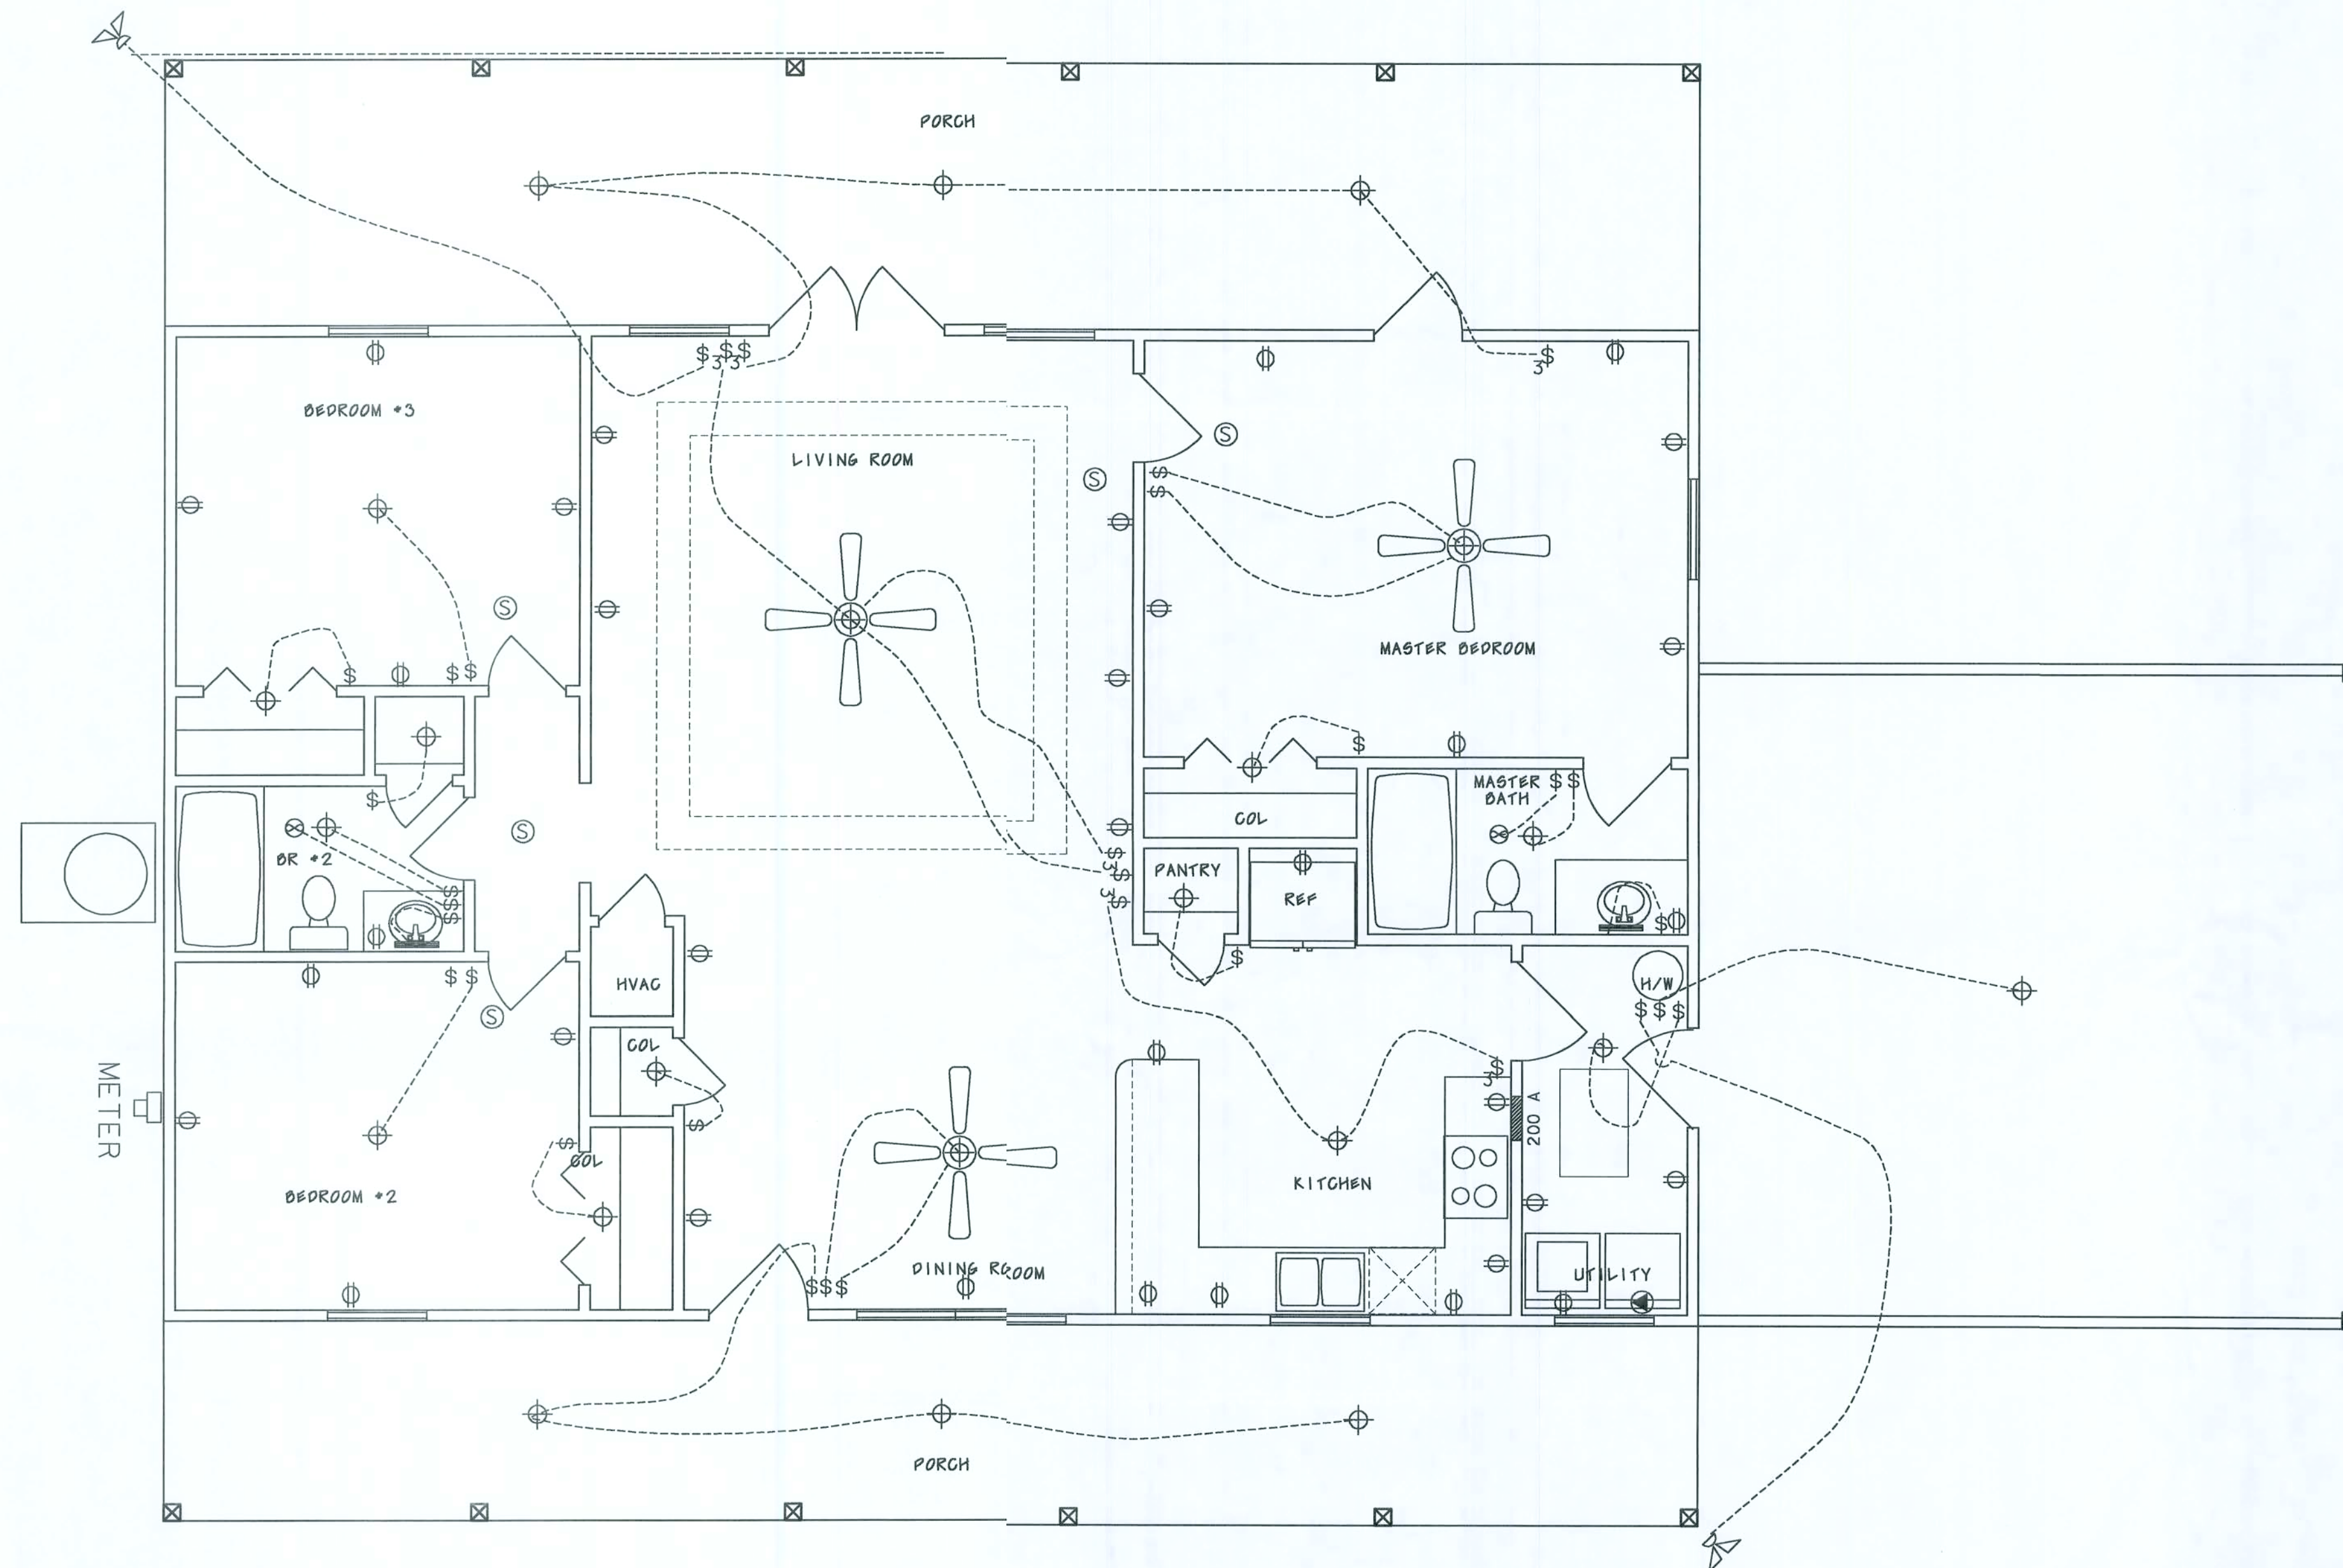

NOTES:

- 1.) ALL EXTERIOR RECEPTACLES SHALL EITHER BE GFI OUTLETS OR PART OF A GFI CIRCUIT. ALL EXTERIOR RECEPTACLES SHALL BE WEATHERPROOF.
- 3.) ALL BATHROOM, KITCHEN, AND GARAGE RECEPTACLES SHALL BE PART OF A GFI CIRCUIT.
- 4.) ALL BEDROOM RECEPTACLES SHALL BE PART OF AN AFI CIRCUIT.

THESE DRAWINGS, AS INSTRUMENTS OF SERVICE, ARE THE SOLE PROPERTY OF HAYGOOD HOMES, INC., AND ARE MAY NOT BE USED, COPIED OR REPRODUCED IN WHOLE OR IN PART FOR USE ON OR INCORPORATED WITHIN ANY OTHER JOB WITHOUT SPECIFIC AND INDIVIDUAL AUTHORIZATION BY HAYGOOD HOMES, INC.



HAYGOOD HOMES INC.


12592 So. U.S. HWY 441
LAKE CITY FL. 32025
OFFICE (386) 752-3496
MOBILE (386) 303-1981
CR-C1326715

Dusty McCray


Lake City Florida

ELECTRICAL PLAN

PLAN No.	SCALE	DATE	SHEET NO.
P 0706	1/4" = 1'	11/10/07	4

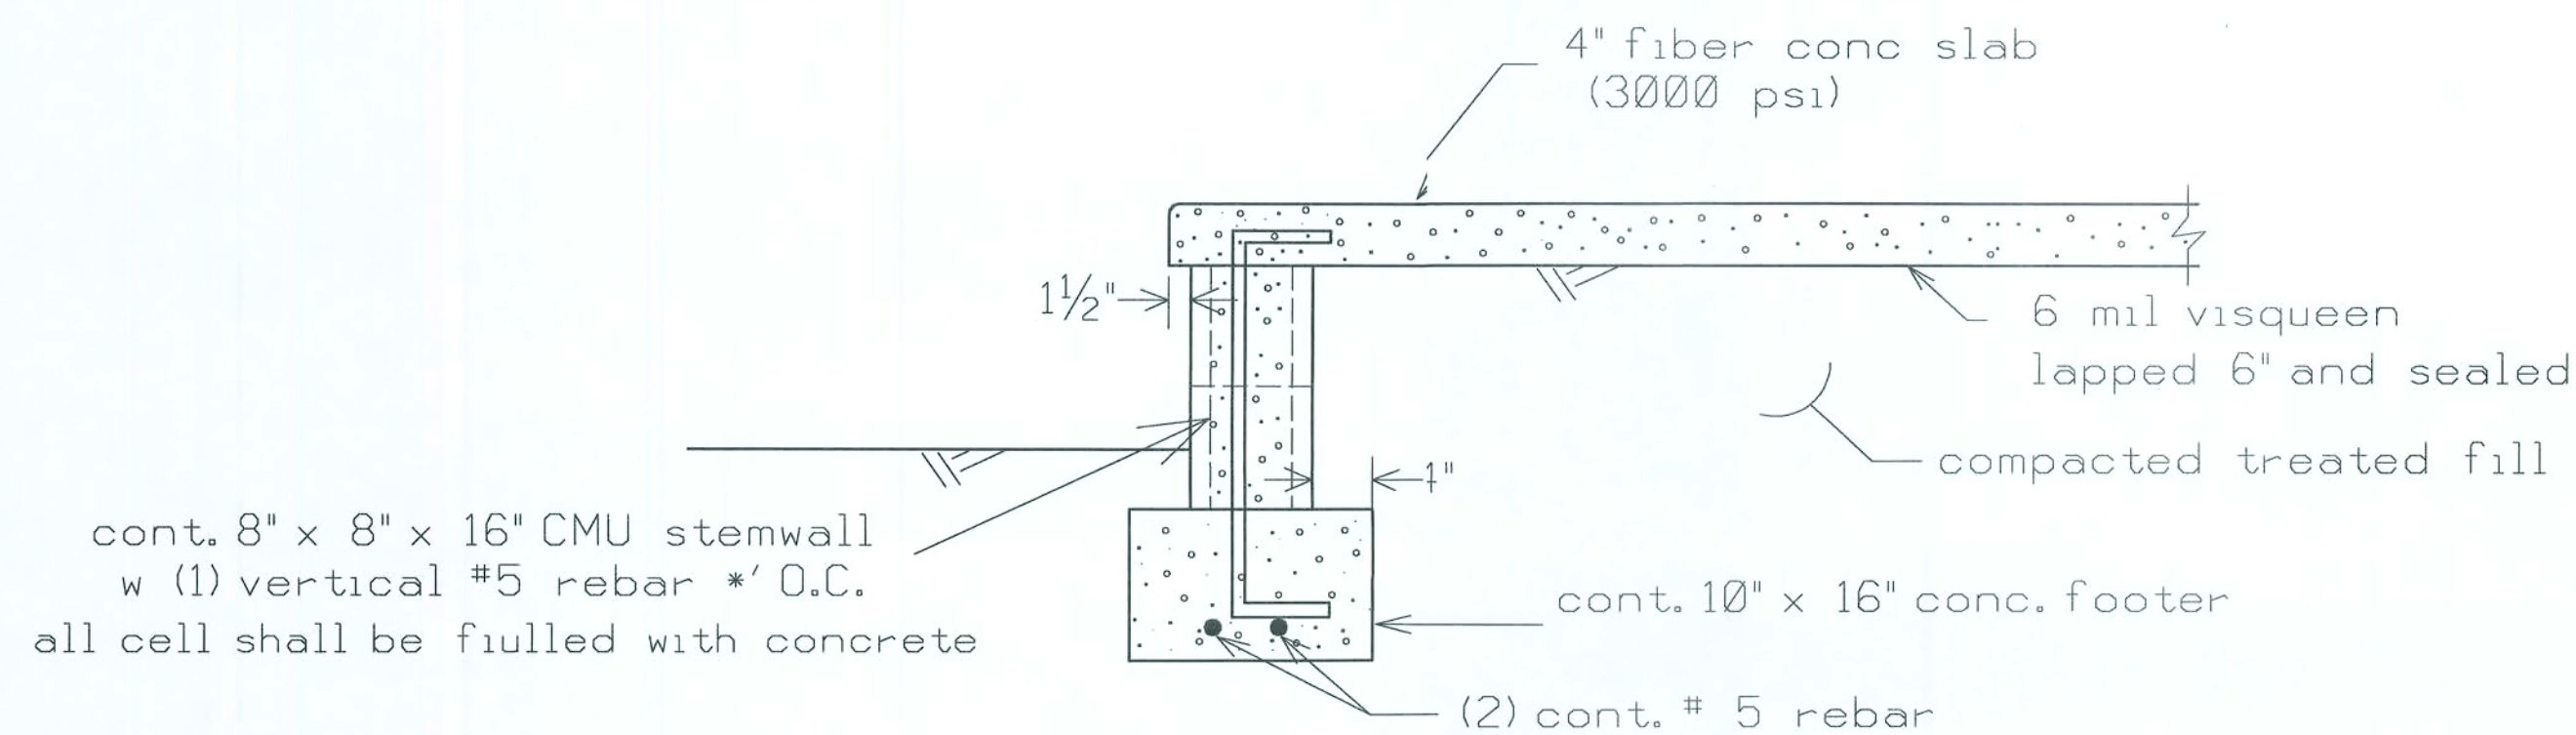

PORCH FOUNDATION(N.T.S.)

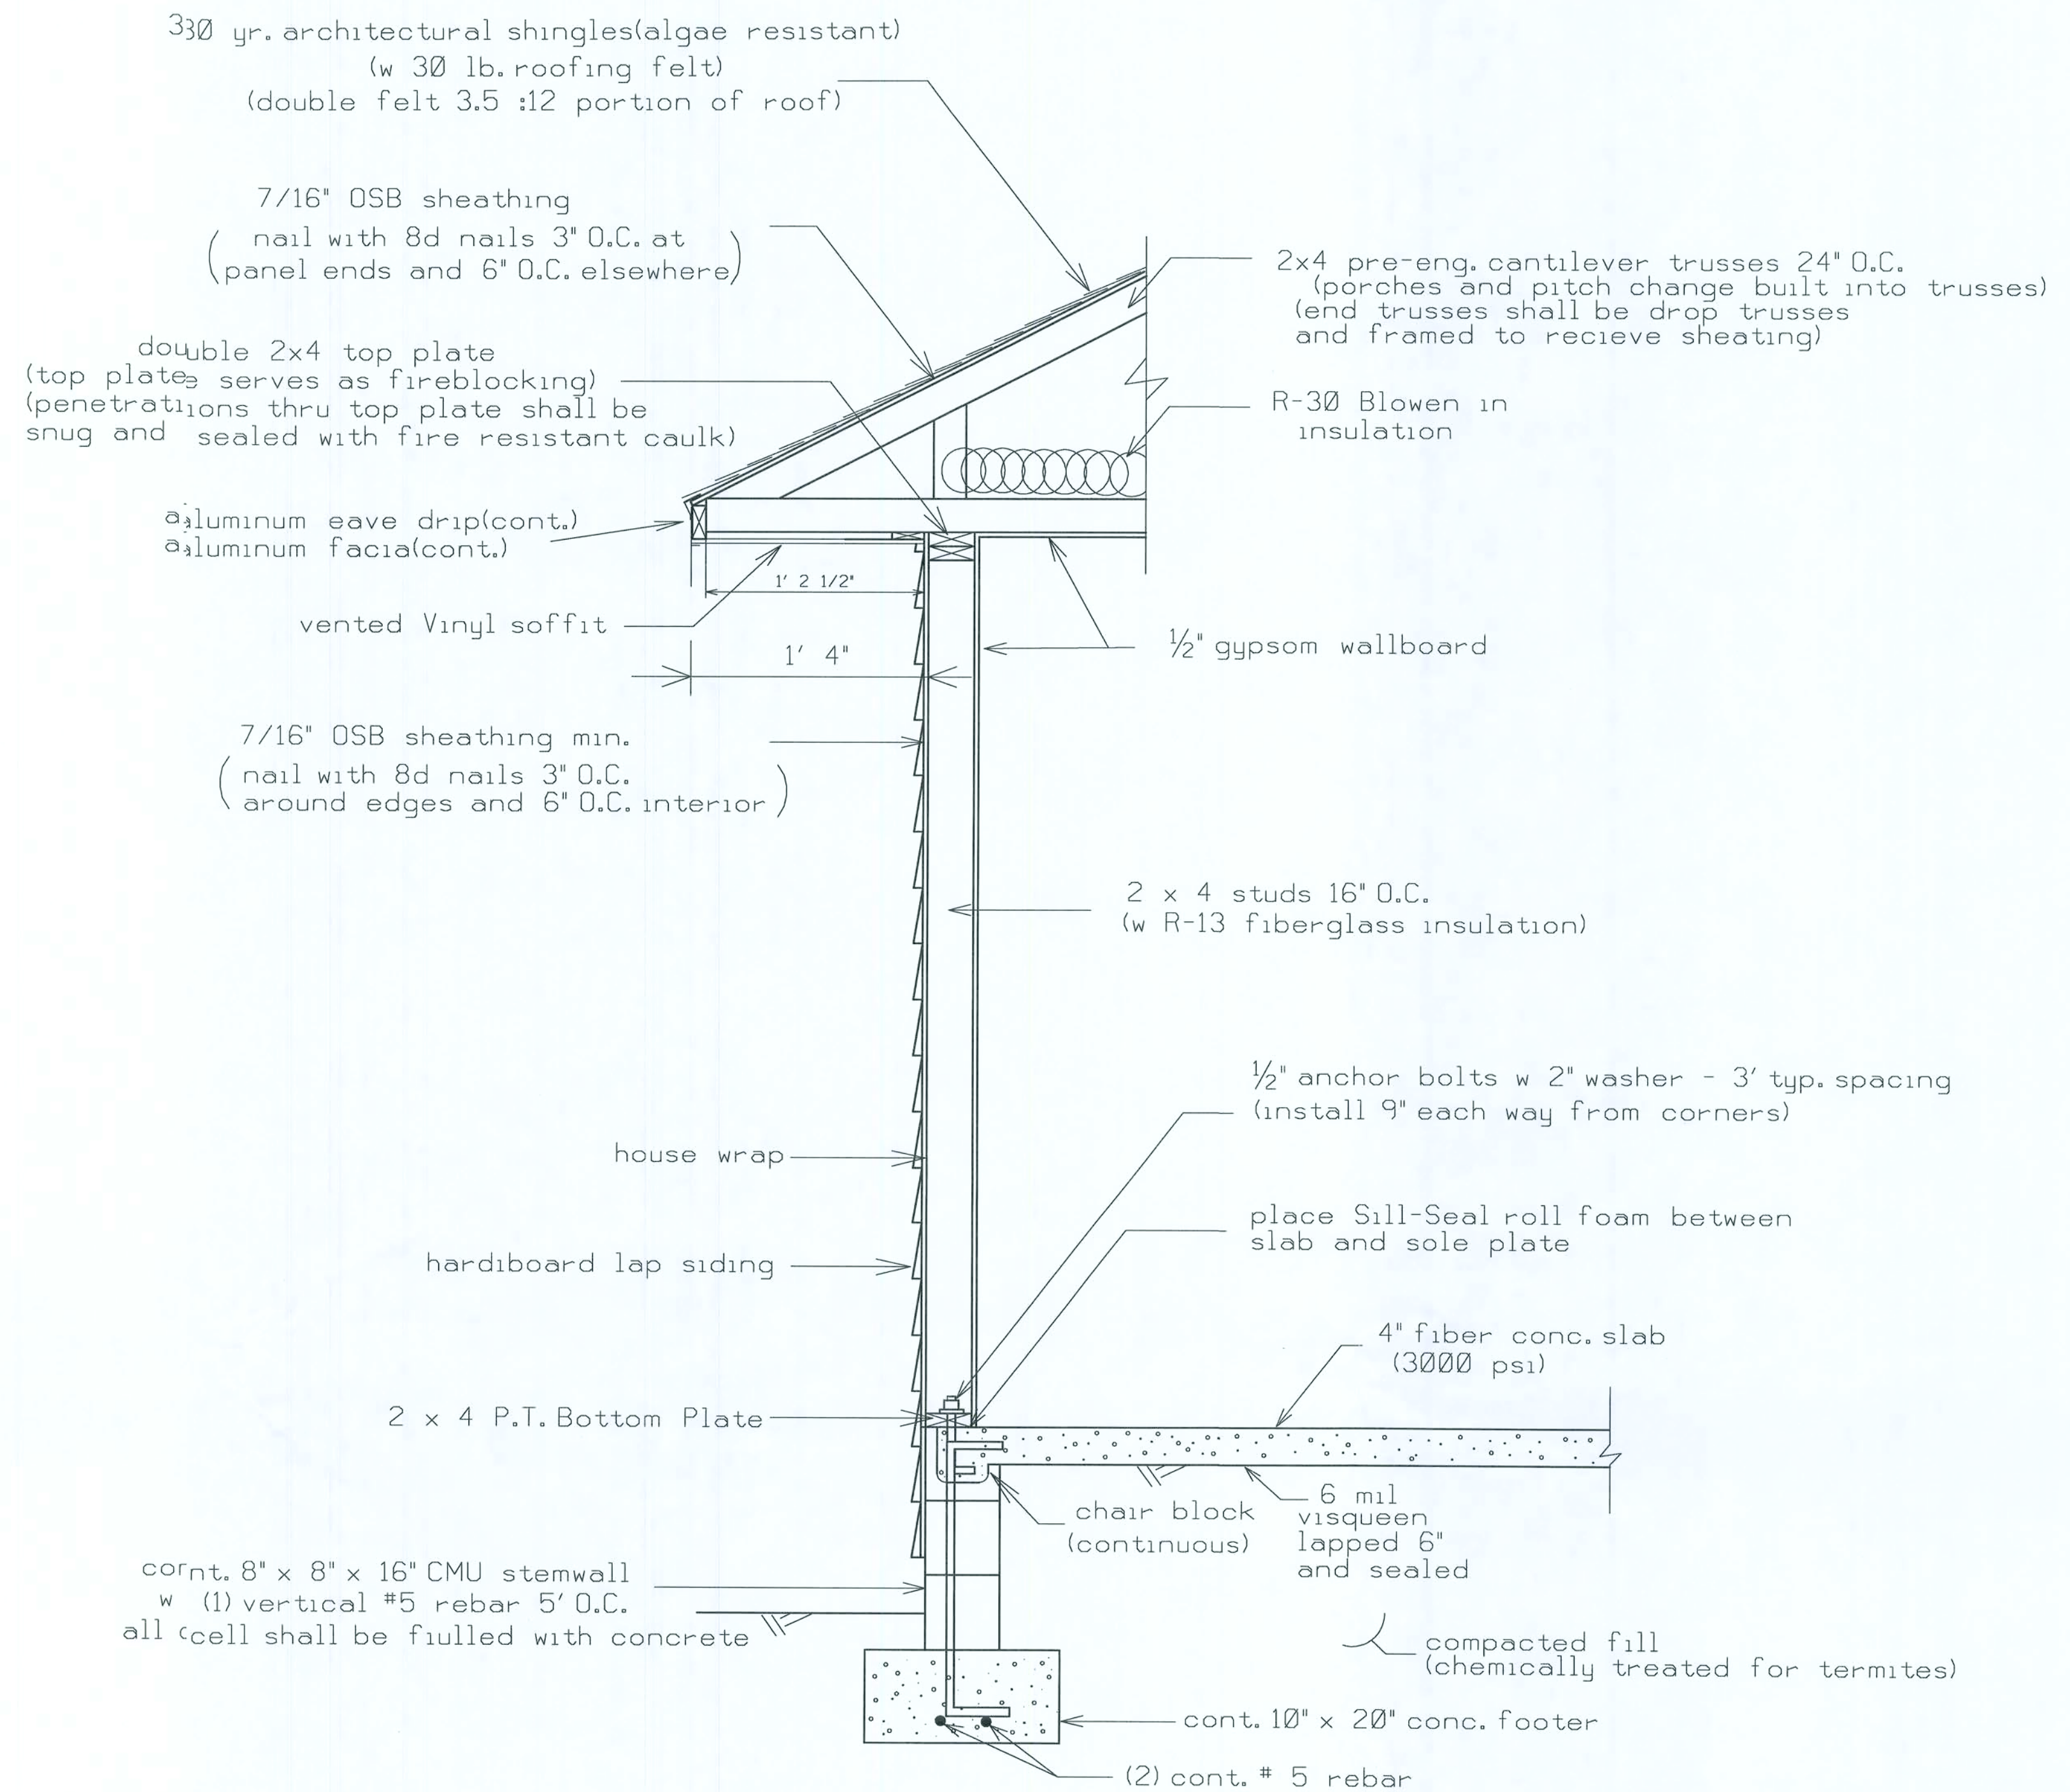

FOOTER DESIGN 1000 PSF

WALL DETAIL(TYP.) (N.T.S.)

HEADER SIZES/MATERIAL SHALL BE AS FOLLOWS:

WINDOW AND DOOR OPENINGS(2 - #2 SYP 2X12's with 1/2" plywood between)
PORCH BEAMS (2 - #2 SYP 2X10's with 1/2" plywood between)

THESE DRAWINGS, AS INSTRUMENTS OF SERVICE, ARE THE SOLE PROPERTY OF HAYGOOD HOME, INC., AND ARE MAY NOT BE USED, COPIED OR REPRODUCED IN WHOLE OR IN PART FOR USE ON OR INCORPORATED WITHIN ANY OTHER JOB WITHOUT SPECIFIC AND INDIVIDUAL AUTHORIZATION BY HAYGOOD HOMES, INC.



HAYGOOD HOMES INC.


12592 So. U.S. HWY 441
LAKE CITY FL 32025
OFFICE (386) 752-3496
MOBILE (386) 303-1981
CR-C1326715

Dusty McCray

Lake City Florida

DETAILS

PLAN No.	SCALE	DATE	SHEET NO.
P 0706	1/4" = 1'	11/10/07	5

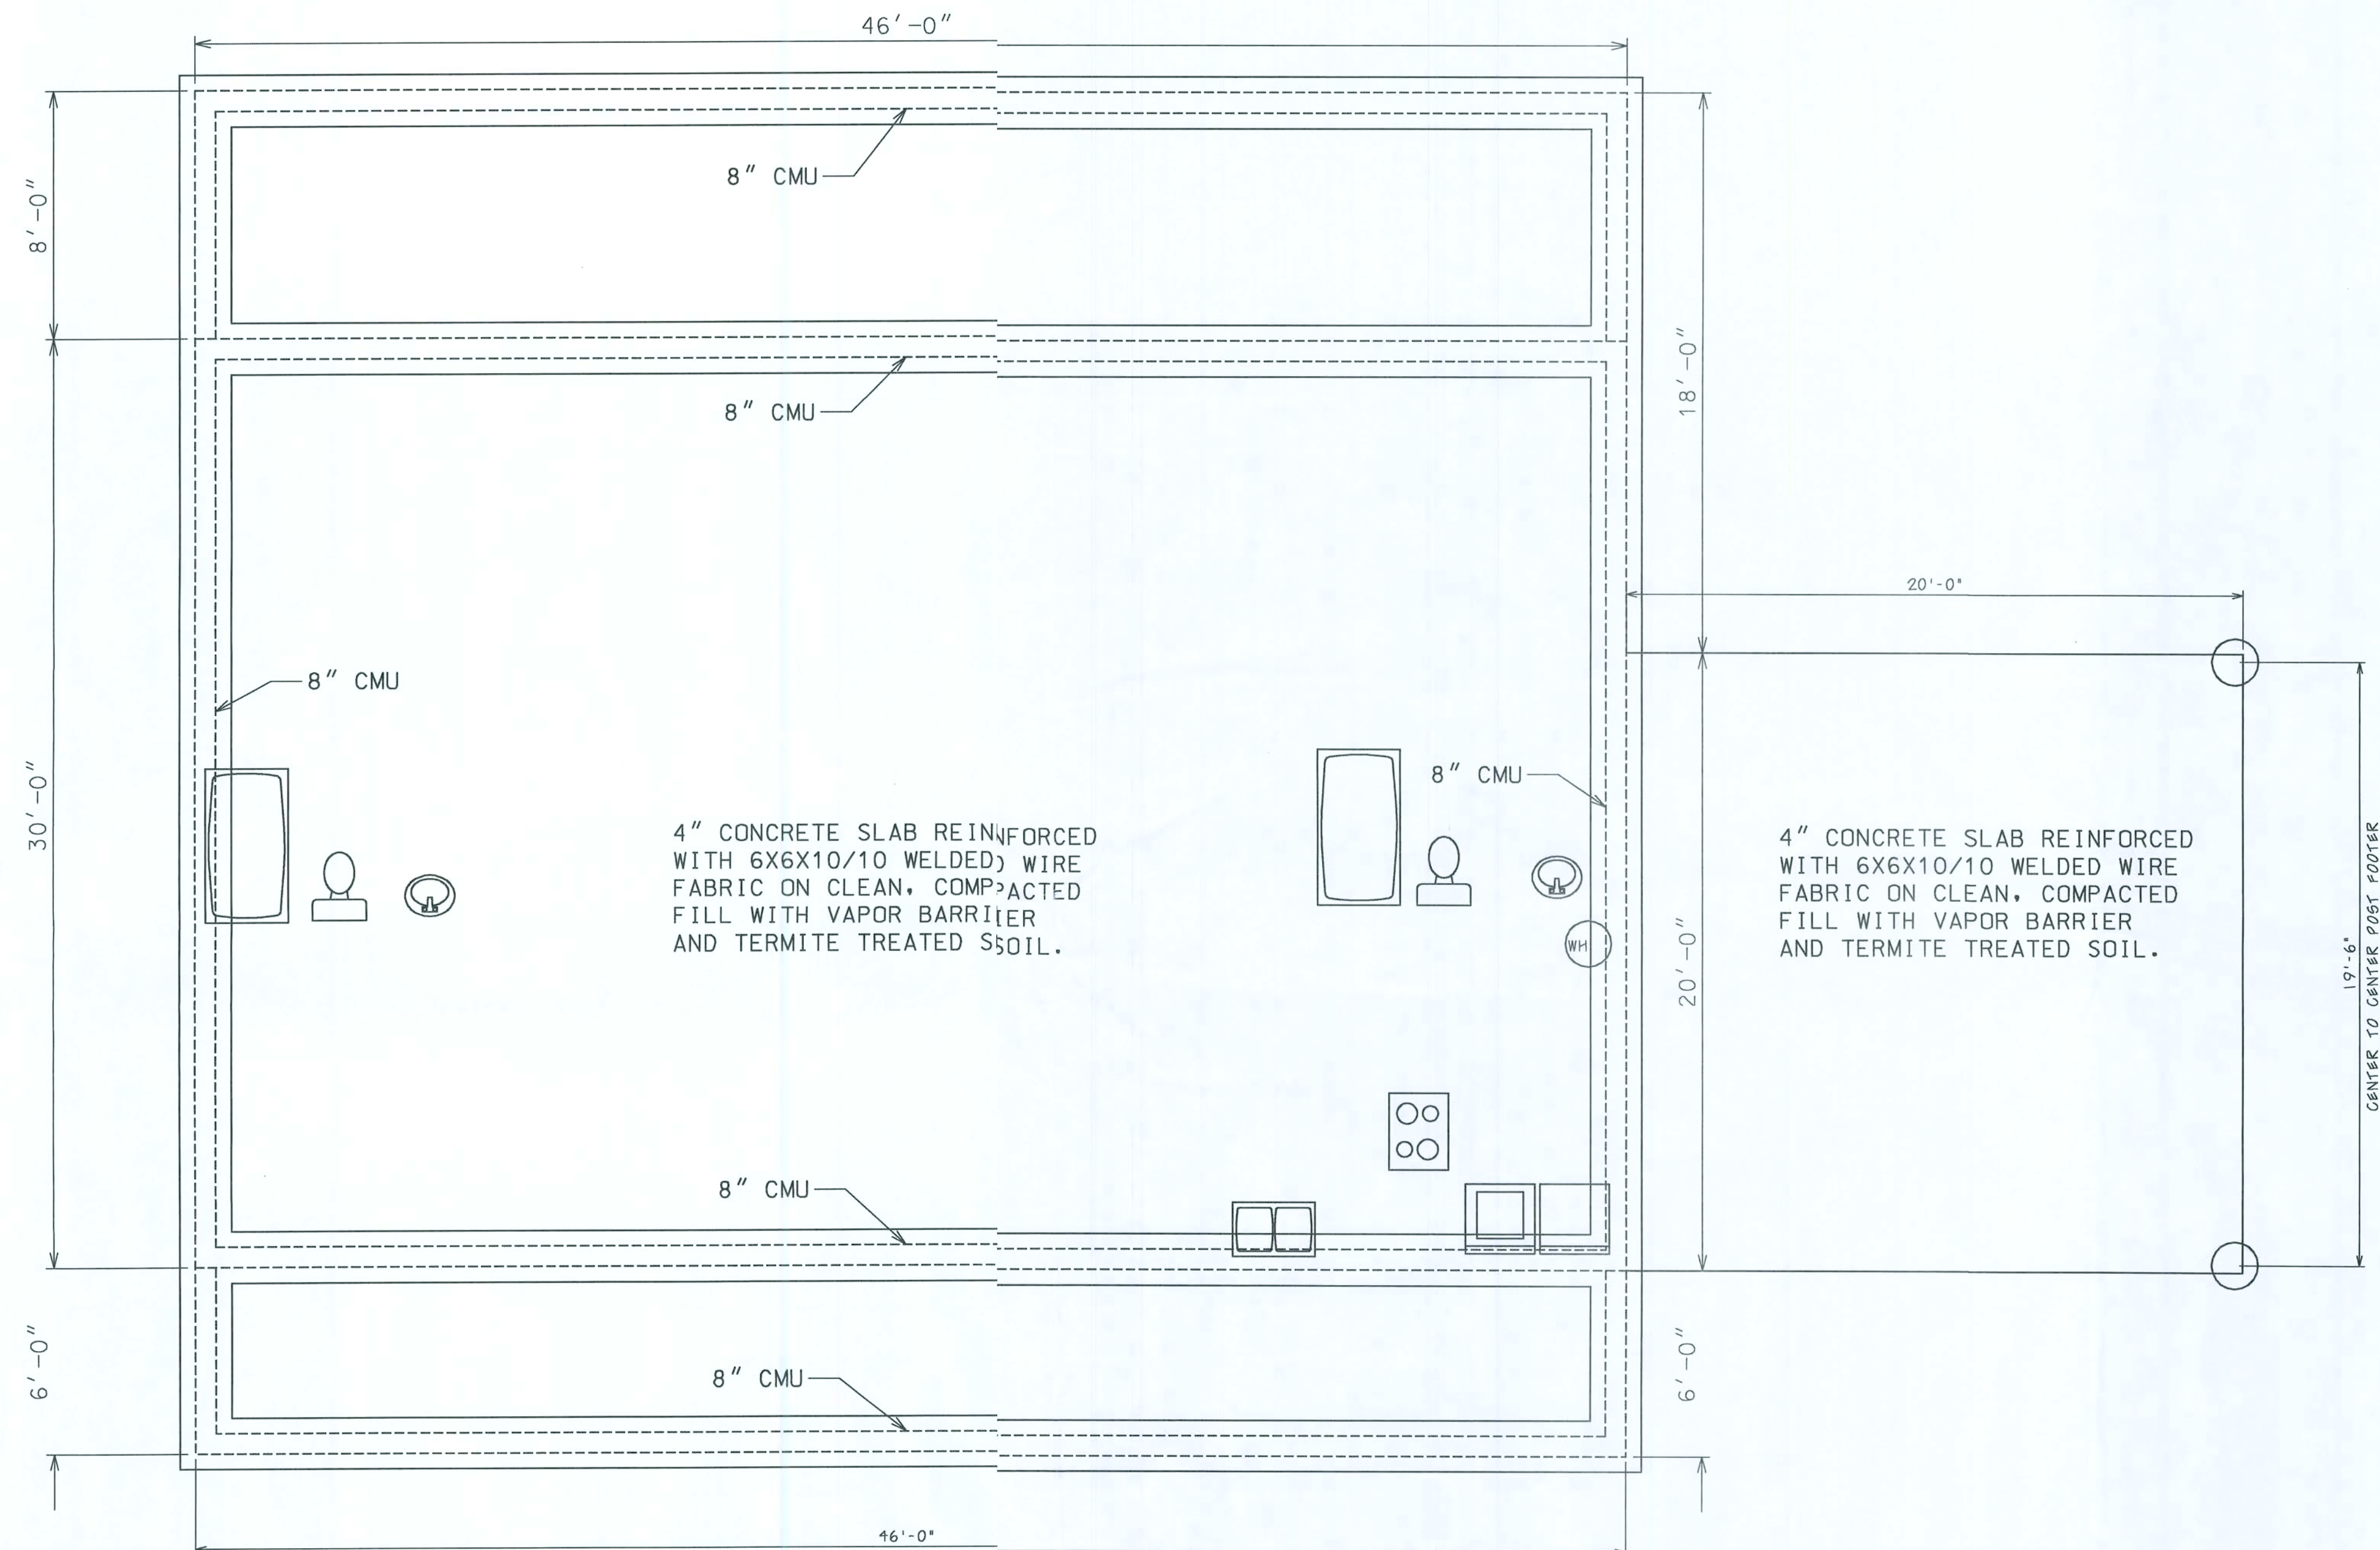

THESE DRAWINGS, AS INSTRUMENTS OF SERVICE, ARE THE SOLE PROPERTY OF HAYGOOD HOMES, INC., AND ARE MAY NOT BE USED, COPIED OR REPRODUCED IN WHOLE OR IN PART FOR USE ON OR INCORPORATED WITHIN ANY OTHER JOB WITHOUT SPECIFIC AND INDIVIDUAL AUTHORIZATION BY HAYGOOD HOMES, INC.,



HAYGOOD HOMES INC.

12592 So. U.S. HWY 441
LAKE CITY FL 32025
OFFICE (386) 752-3496
MOBILE (386) 303-1981
CR-C1326715

Dusty McCray

Lake City Florida

FOUNDATION

PLAN No.	SCALE	DATE	SHEET NO.
P 0706	1/4" = 1'	11/10/07	6