

PROFESSIONAL  
BUILDING DESIGN


JANUARY S. JERNIGAN

119 SW JOHN STREET

LIVE OAK, FL 32064

PHONE: 386-208-1340

E-MAIL: skydesigns@alltel.net

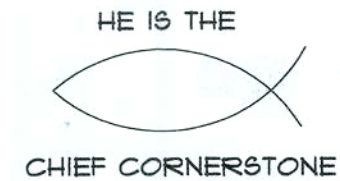

GTC DESIGN GROUP

Gary Gill, P.E.

Lic#51942 Auth#9461

130 West Howard Street

Live Oak, FL 32064

Phone: 386-362-3678

J.L. DUPREE CONSTRUCTION  
ADDITION FOR:  
RALPH RODRIGUEZ



SHEET INDEX:


FLOOR PLAN 1

ELECTRICAL PLAN 1

FOUNDATION PLAN 2

ELEVATIONS 3

DETAILS PROVIDED BY GTC DESIGN GROUP

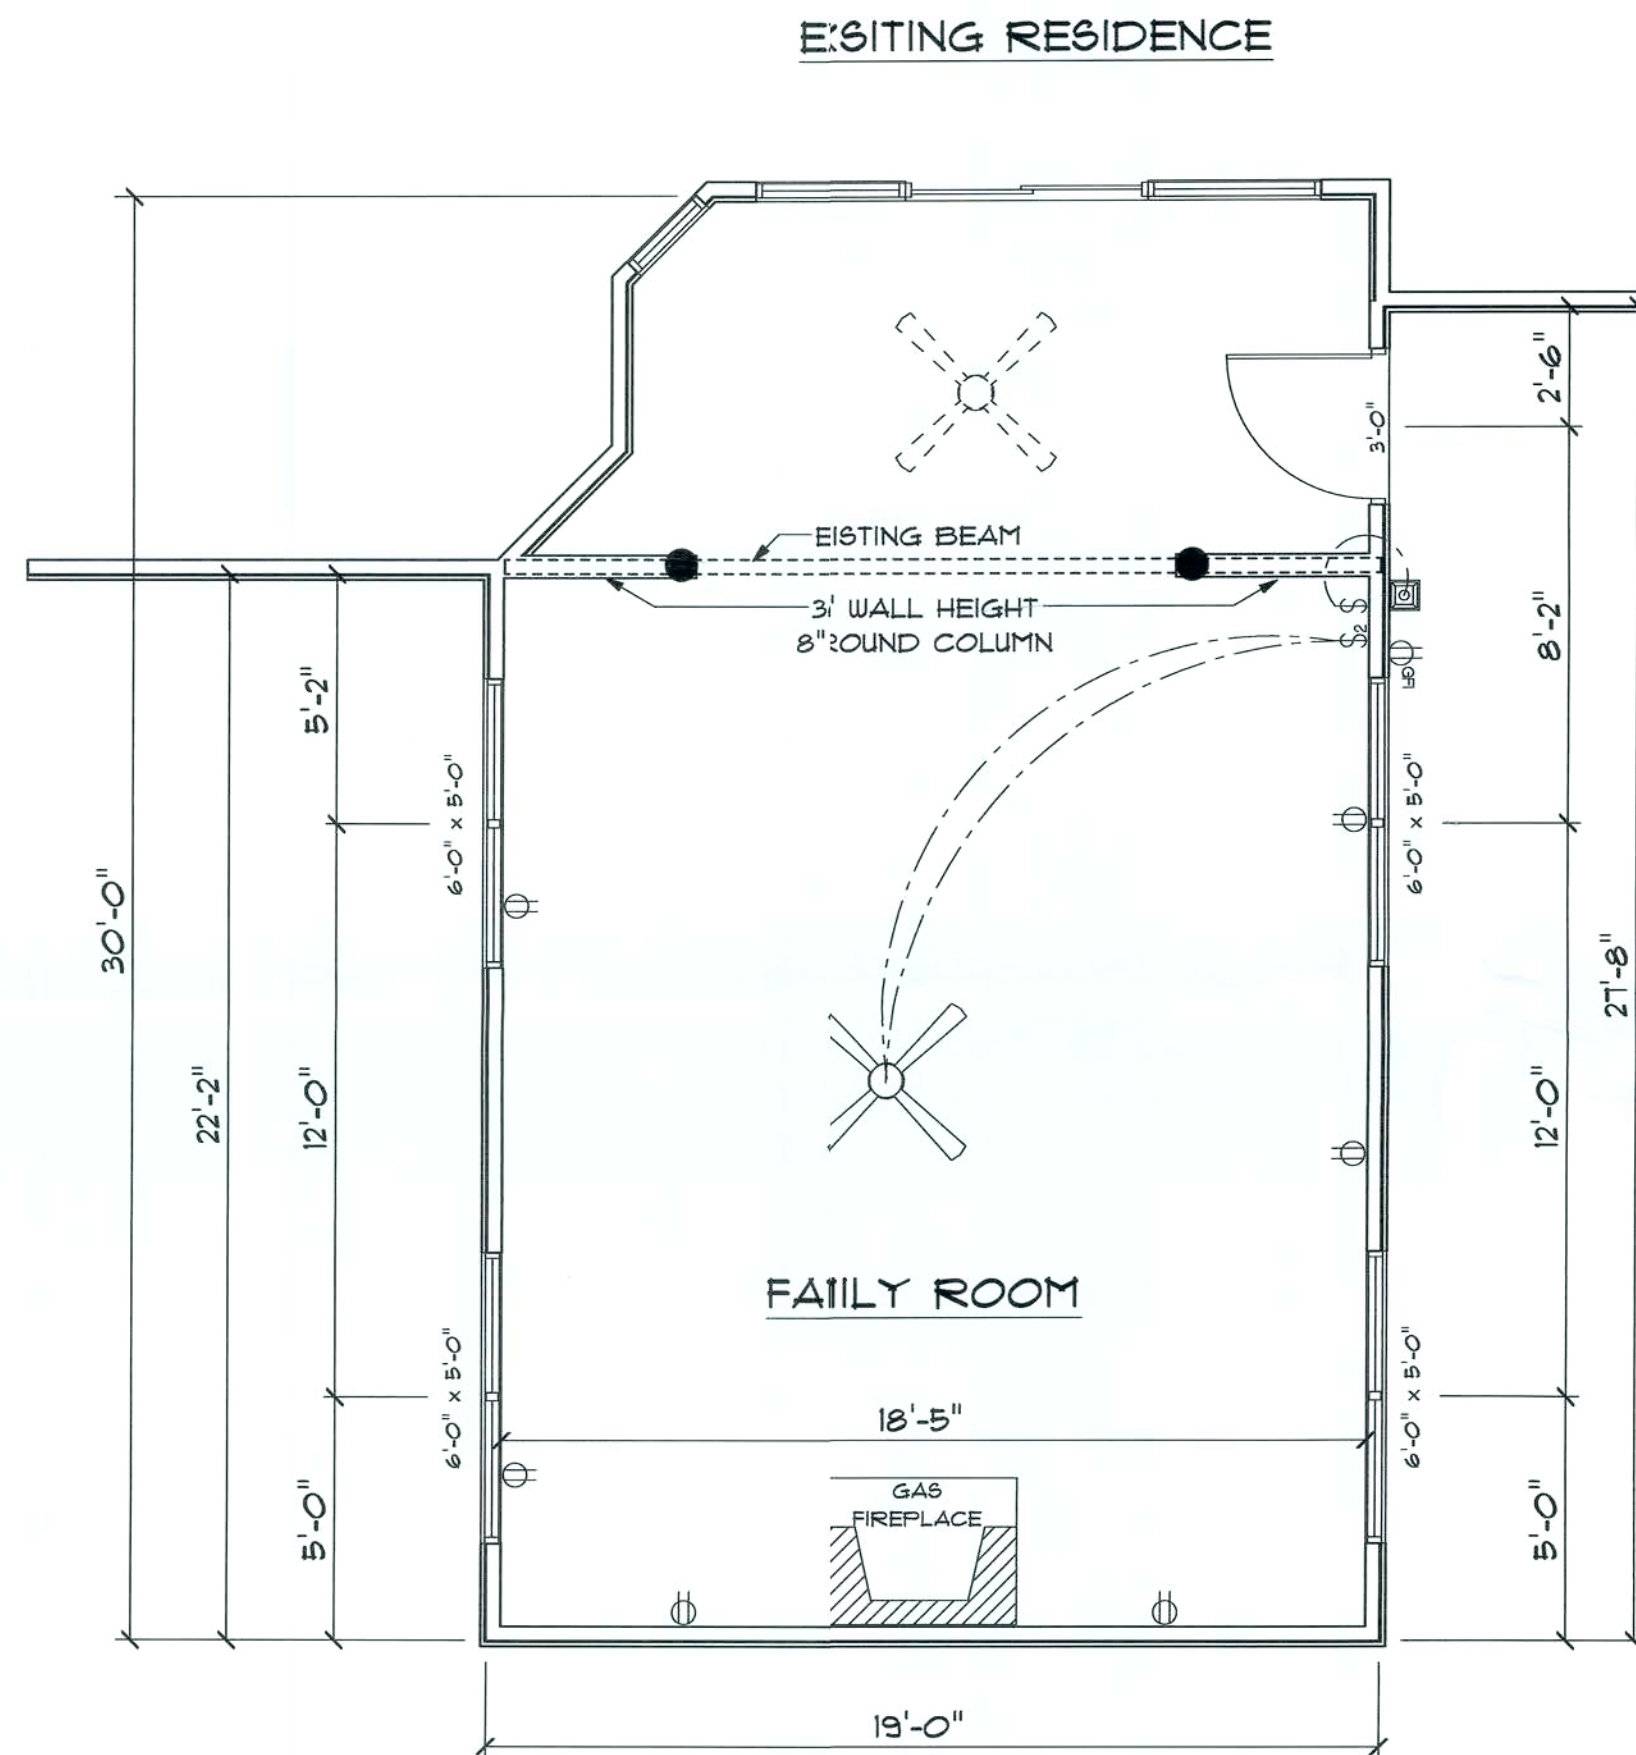

| PRODUCT CODE        | SIZE          | COUNT |
|---------------------|---------------|-------|
| 36X80 GLASS 1       | 3'-0"         | 1     |
| 36X60 SINGLE HUNG 1 | 3'-0" x 5'-0" | 8     |

| ELECTRICAL          | COUNT | SYMBOL |
|---------------------|-------|--------|
| ceiling fan globe 1 | 1     |        |
| wall mount 2        | 1     |        |
| outlet              | 6     |        |
| outlet gfi          | 1     |        |
| switch              | 1     |        |
| switch double       | 1     |        |

NOTE: LICENSED ELECTRICIAN MUST VERIFY THAT ADDITIONAL LOAD MAY BE ADDED TO MAIN PANEL

- NOTE:
1. ALL OUTLETS SHALL BE A MINIMUM OF 12" A.F.F. UNLESS OTHERWISE SPECIFIED.
  2. PLACE SWITCH PLATES A MINIMUM OF 2 1/2" FROM DOOR TRIM
  3. ALL PHONE/MULTIMEDIA OUTLETS SHALL BE PLACED PER OWNER
  4. SMOKE ALARMS SHALL BE BATTERY OPERATED AND HARD-WIRED INTO THE ELECTRICAL SYSTEM (ONE CIRCUIT CONNECTION TO PANEL) OR TO BE PLUG-IN ALARM

HE IS THE  
CHIEF  
CORNERSTONE

**SKY DESIGNS**  
January S. Jernigan  
119 SW 10th Street  
Live Oak, FL 32064  
Phone: 386-362-3610  
E-Mail: skydesigns@aol.com

DUPREE/RODRIGUEZ

**GTC  
DESIGN GROUP**  
Gary Gill, P.E.  
Lic#19142 Auth#1461  
130 West Howard Street  
Live Oak, FL 32064  
Phone: 386-362-3618

FLOORPLAN  
ELECTRICAL


Date: 3/2009

Sheet Number:

1

Drawn By: J&J

Scale: 1/4" = 1'

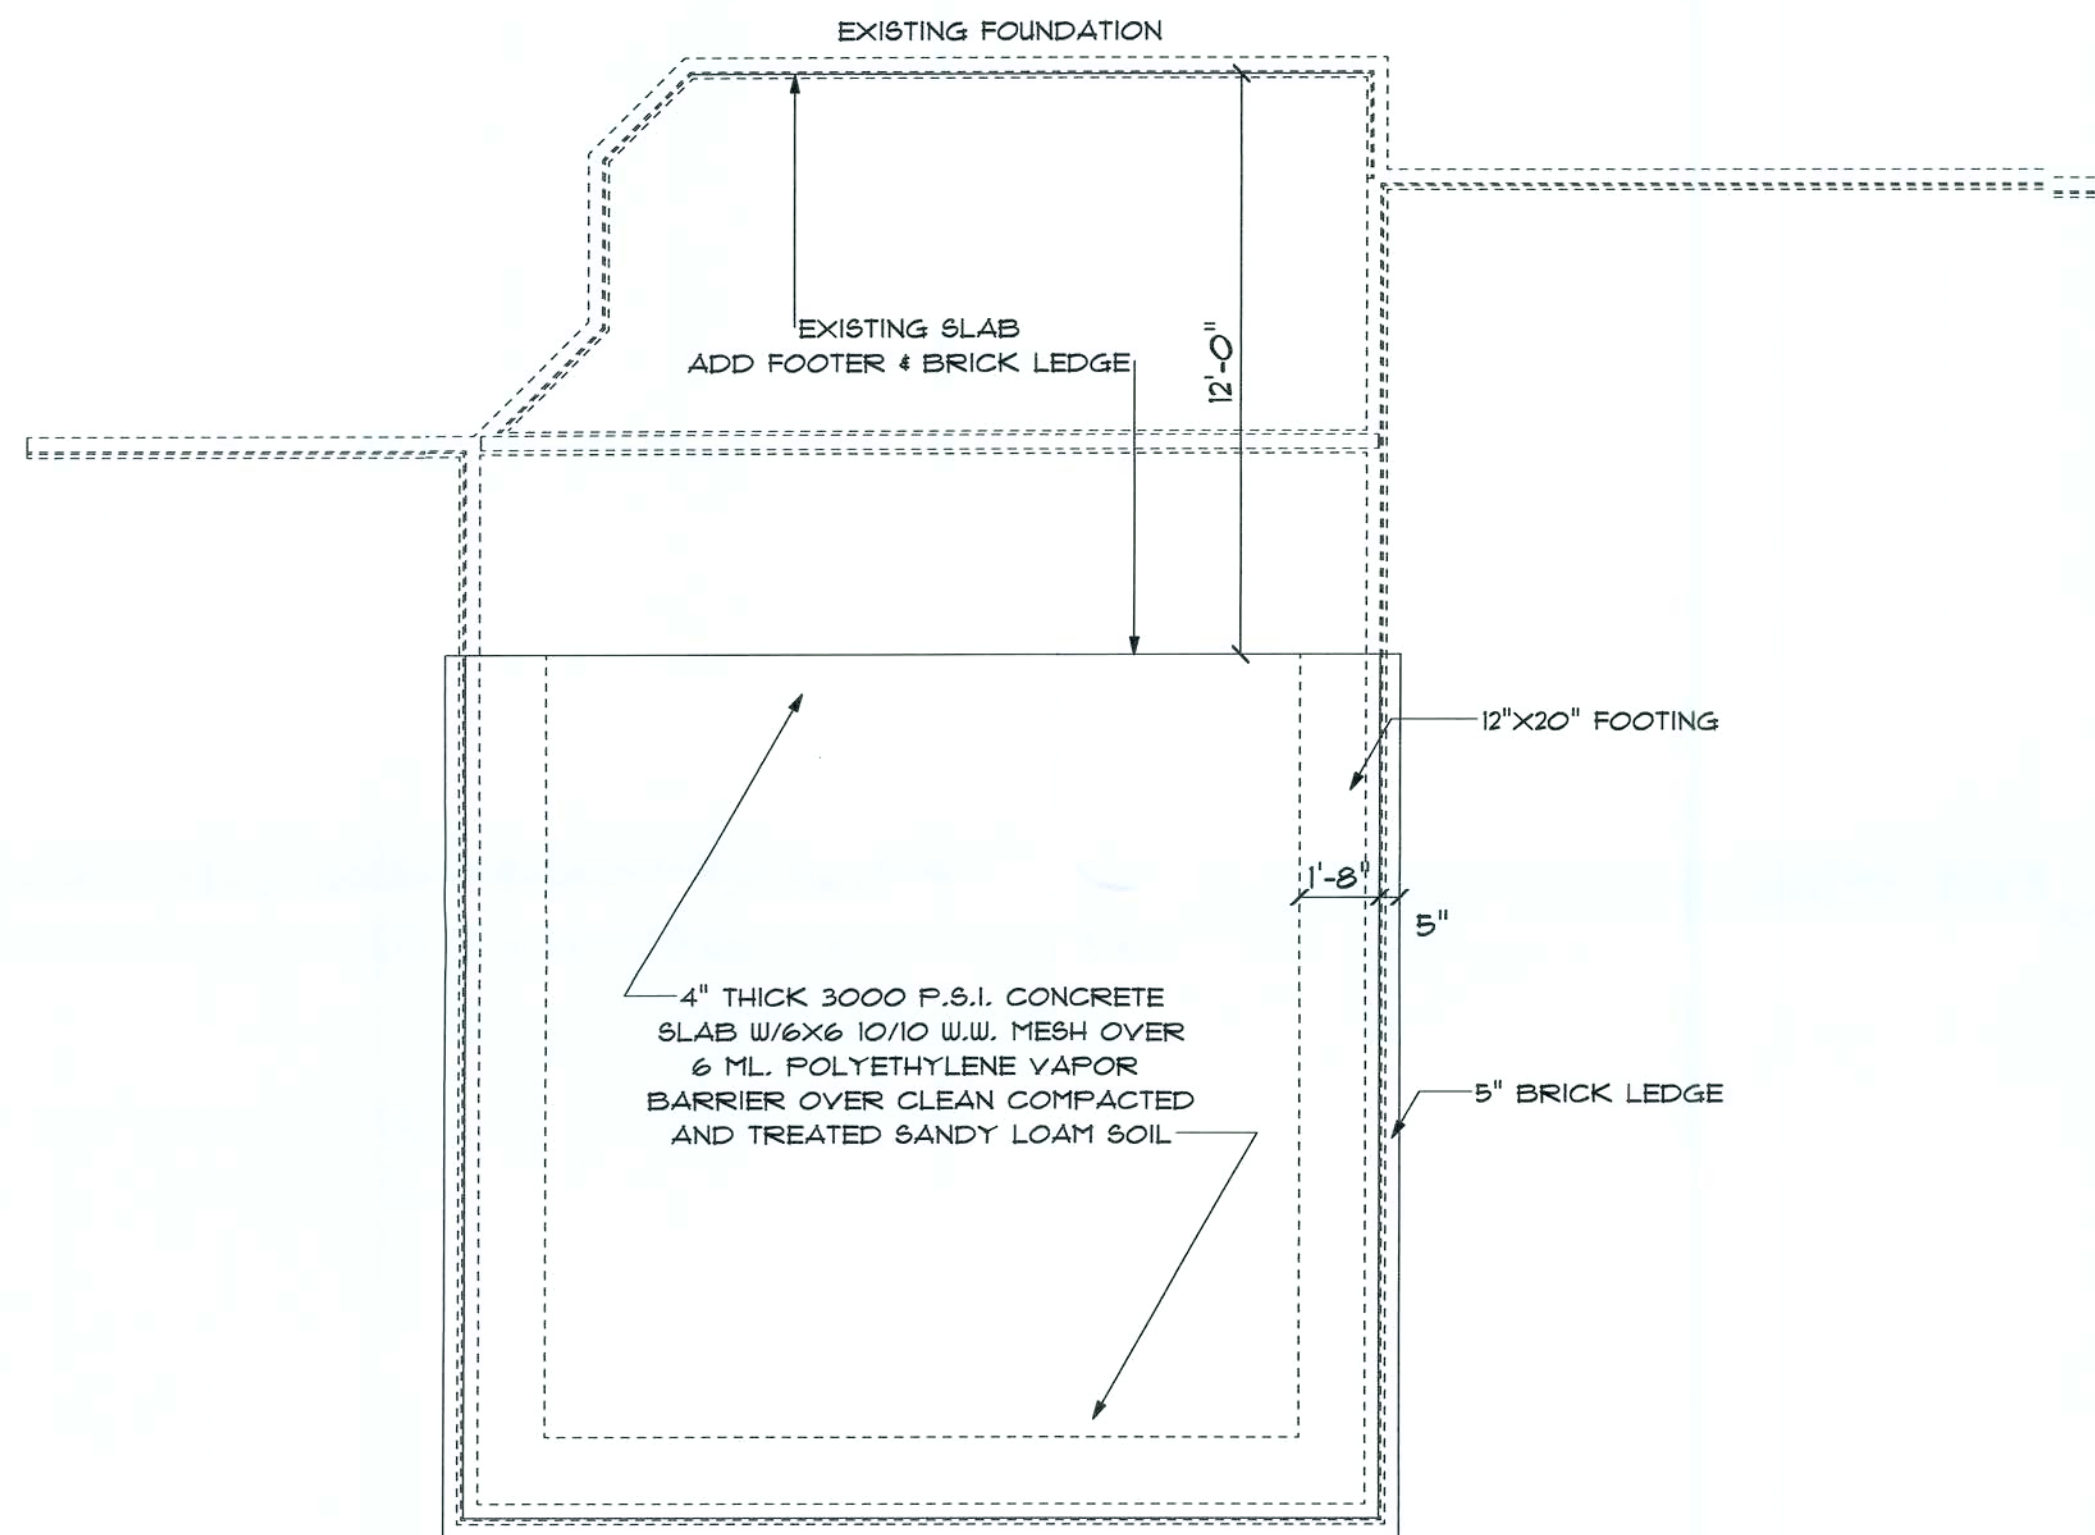

HE IS THE  
CHIEF  
CORNERSTONE

SKY DESIGNS

January S. Jernigan  
119 SW John Street  
Lima Oak, FL 32064  
Phone: 386-208-1340  
E-Mail: skydesigns@alltel.net

DUPREE/RODRIGUEZ

GTC  
DESIGN GROUP

Gary Gill, P.E.  
Lic#19342, Exp#19461  
190 West Howard Street  
Lima Oak, FL 32064  
Phone: 386-362-3618

FOUNDATION


Date: 3/2009

Sheet Number:


2

Drawn By: JSJ


Scale: 1/4" = 1'

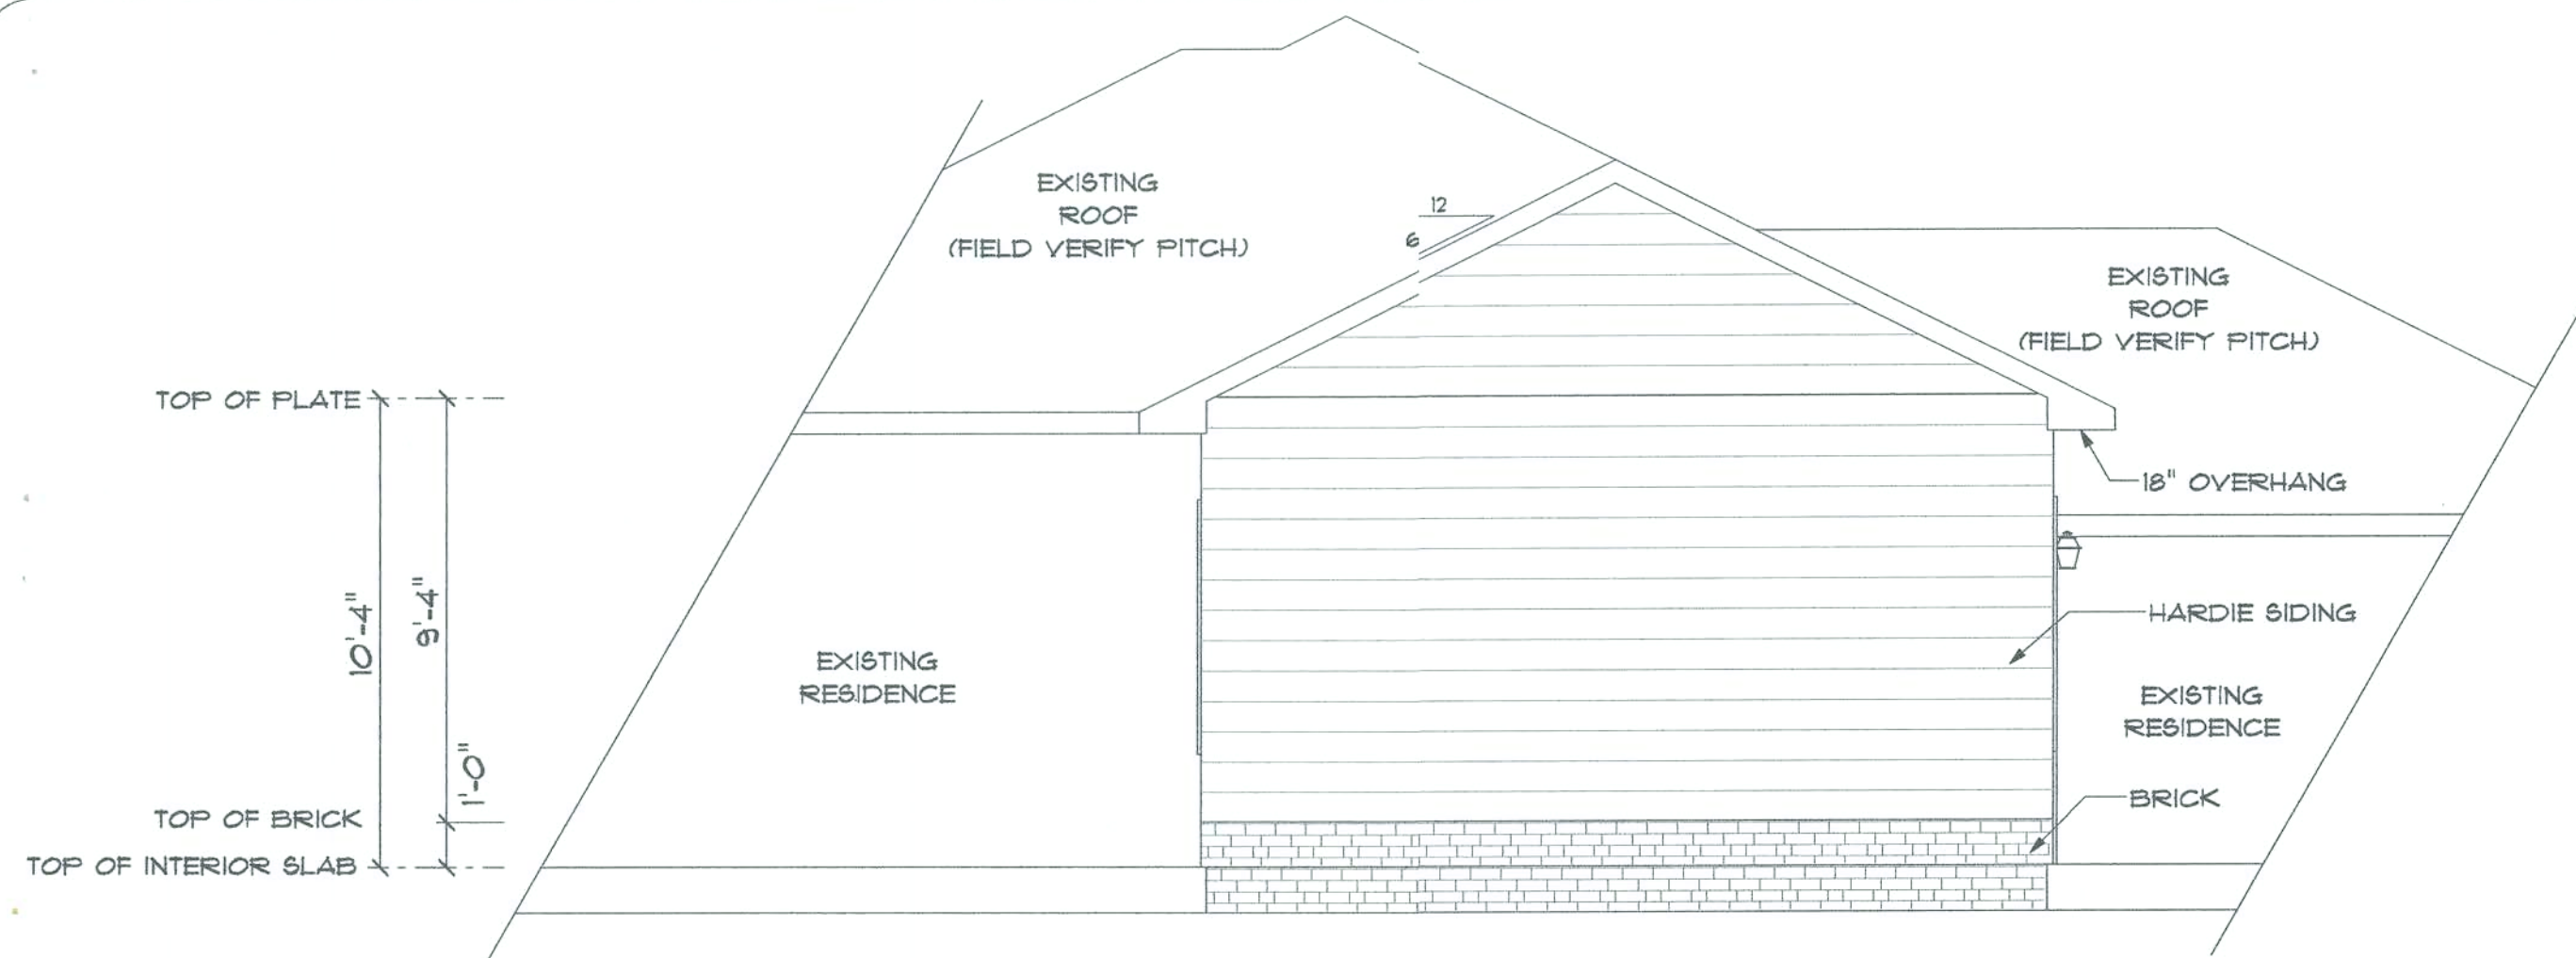


FRONT ELEVATION

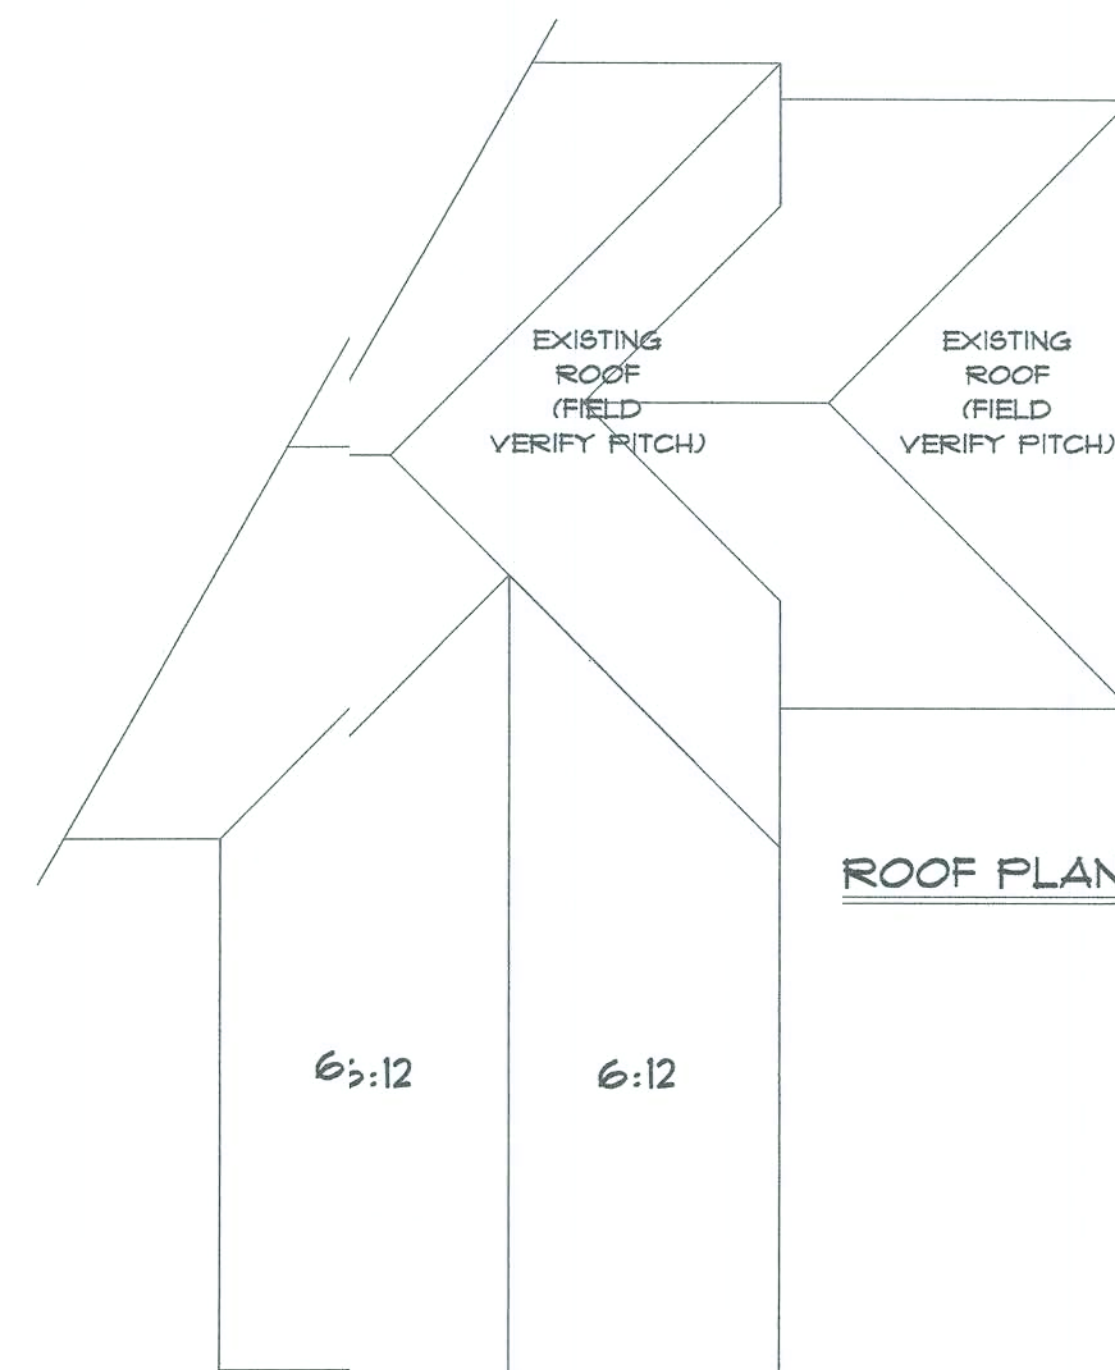

ROOF PLAN

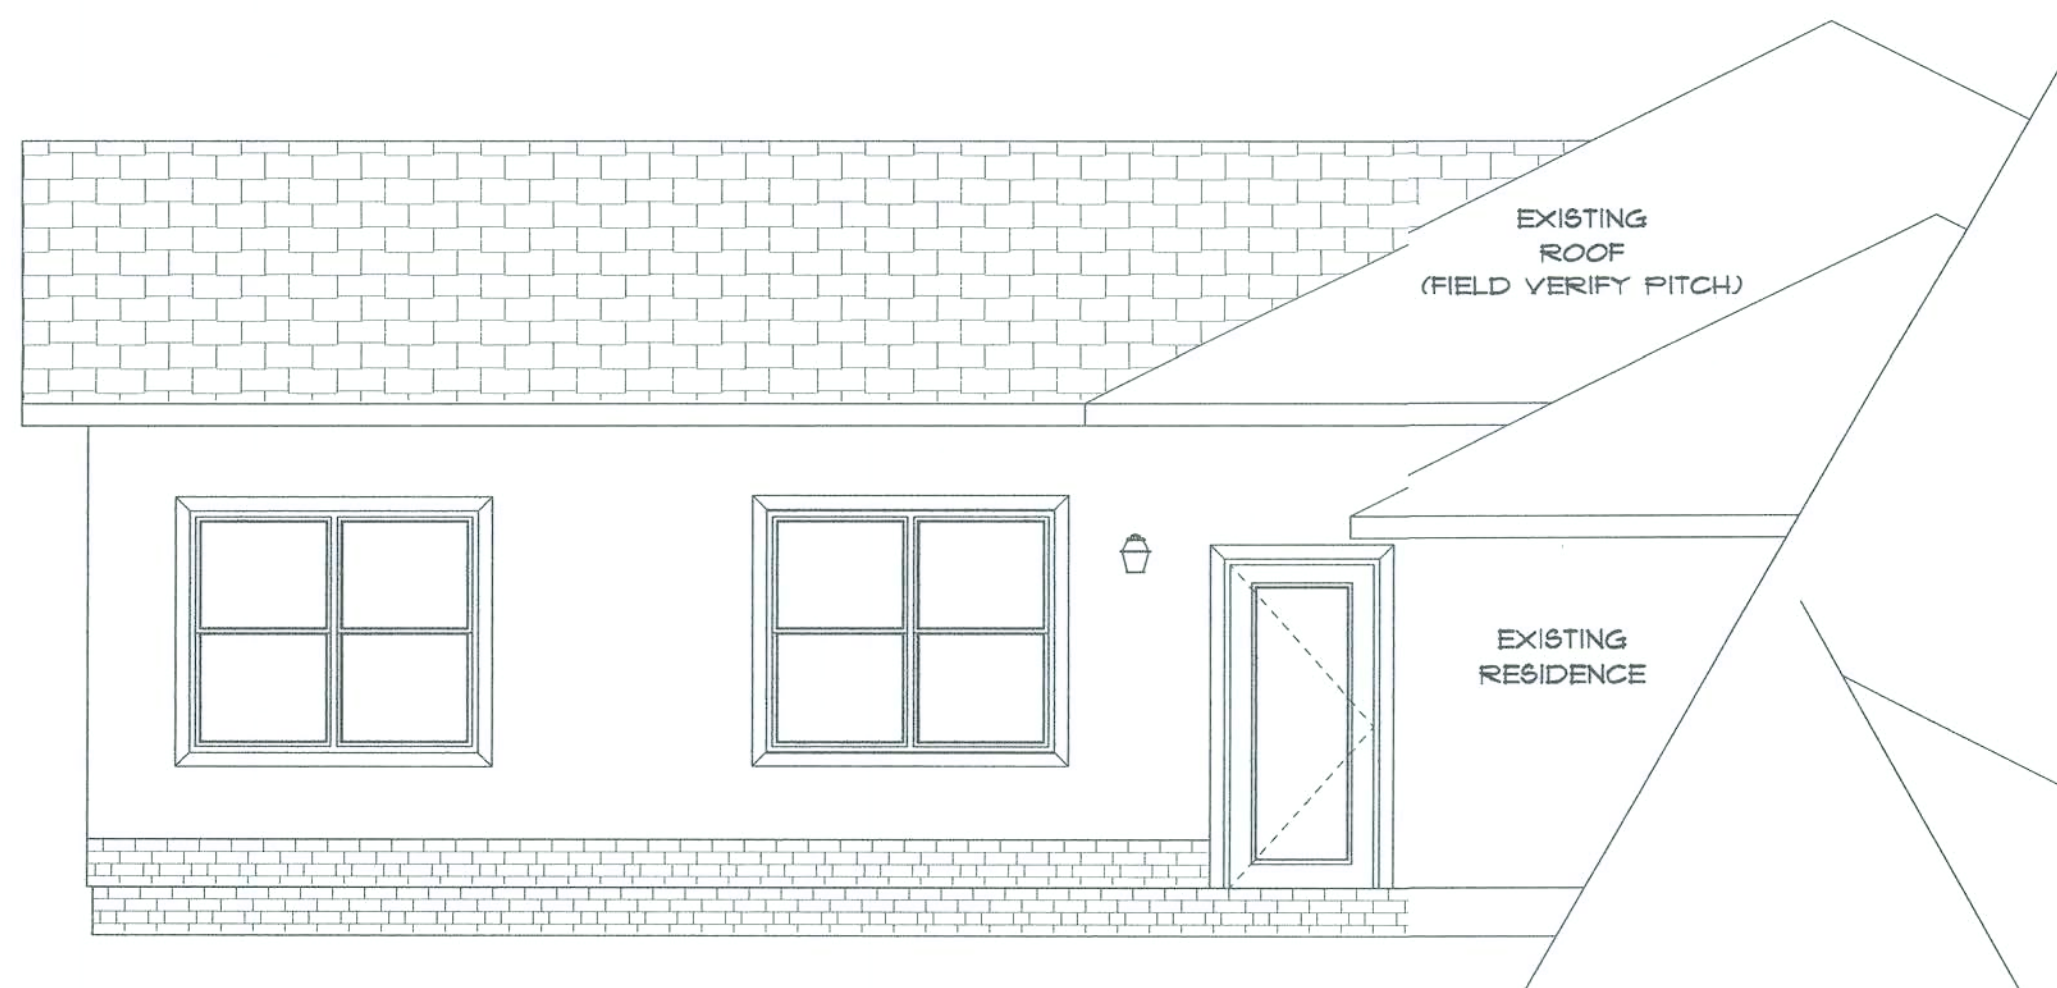

RIGHT ELEVATION

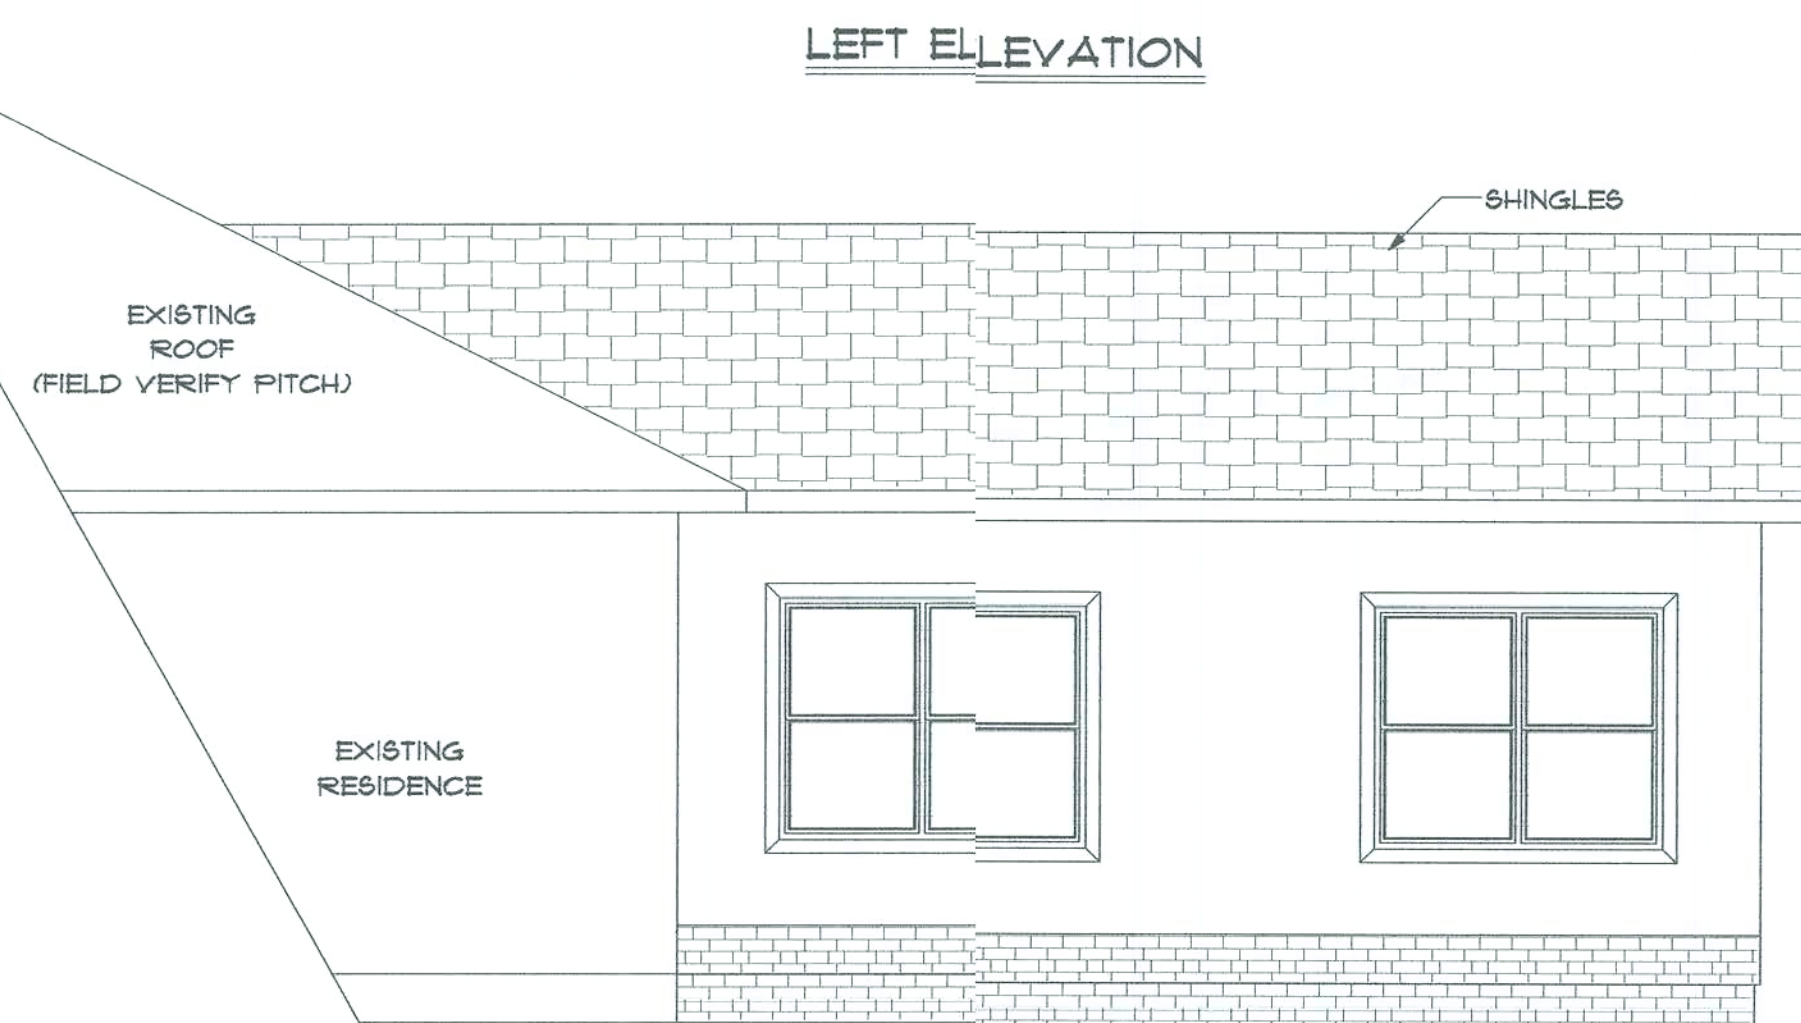

LEFT ELEVATION

HE IS THE  
  
 CHIEF  
 CORNERSTONE

**SKY DESIGNS**

January S. Jernigan  
 115 SW John Street  
 Live Oak, FL 32064  
 Phone: 386-206-1340  
 E-Mail: skydesigns@att.net

**DUPREE/RODRIGUEZ**

**GTC  
 DESIGN GROUP**

Gary Gill, P.E.  
 Lic#19342 Auth#3461  
 130 West Howard Street  
 Live Oak, FL 32064  
 Phone: 386-362-3618

ELEVATIONS

Date: 3/2009

Sheet Number:

**3**

Drawn By: JSJ

Scale: 1/4" = 1'