


SCALE NOTE:  
PLAN VIEW: 1/8" = 1'-0"

9263 CR 417  
LIVE OAK, FLORIDA 32060  
386-362-4787  
ENG. LIC. EB 3761

RECORD STORAGE OF LAKE CITY  
LAKE CITY, FLORIDA

ACU-1

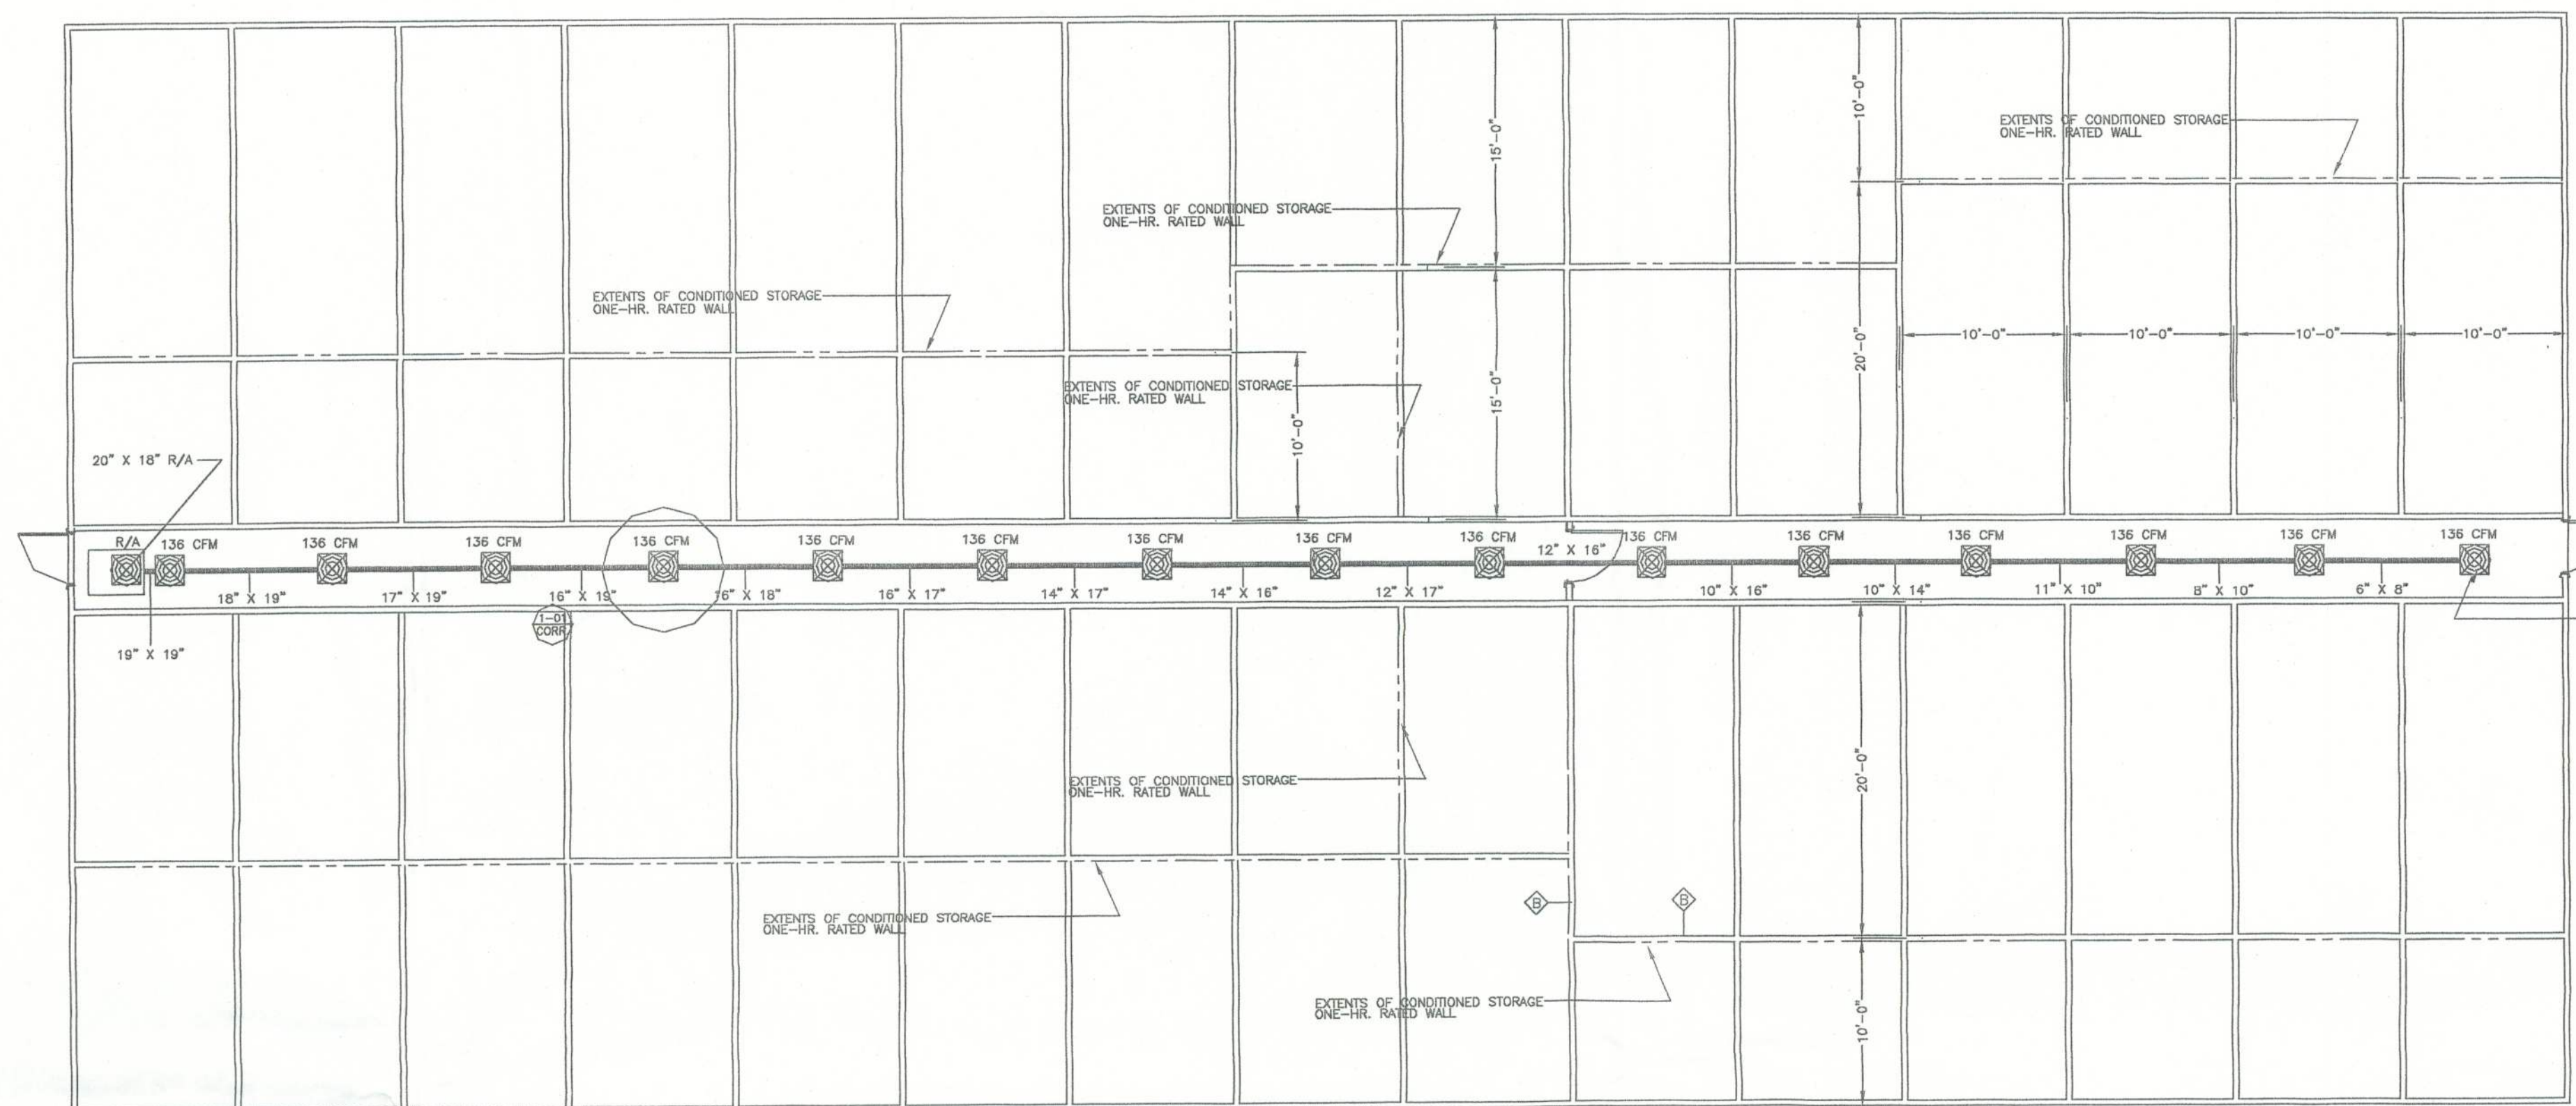

TYPICAL DIFFUSER IN CORRIDORS SHALL BE 2 - SIDED &  
THROW CONDITIONED AIR @ 55 CFM EACH SIDE

AHU-1	5.0 TON	2050 CFM	SEER 10.5	COP	3.00	TRANE TWED60 OR EQUAL
ACU-1	5.0 TON	2050 CFM	SEER 10.5	COP	3.00	TRANE 2TWR106GA OR EQUAL

- ① BASED UPON 96" AIR ENTERING CONDENSER  
② PROVIDE FLEXIBLE CONNECTIONS @ ALL AIR HANDLING UNITS

CONTRACTOR TO PROVIDE FOR ADEQUATE CONDENSATION DRAINAGE TO PREVENT FREE WATER FLOW FROM HEAT PUMP UNITS AND TO THOROUGHLY SEAL/GASKET HEAT PUMP UNIT PENETRATION AGAINST MOISTURE AND AIR INFILTRATION.

 $R^4$ 

STORAGE BUILDING MECHANICAL FLOOR PLAN VIEW  
MISC. NOTES, REFERENCES & INSTRUCTIONS  
SCHEDULES

PROJECT No. RECORD03-M2.0.D.DWG	DRAWN BY:
SHEET No. M200	DATE 11/04/03

Curtis Keen  
11/10/03