


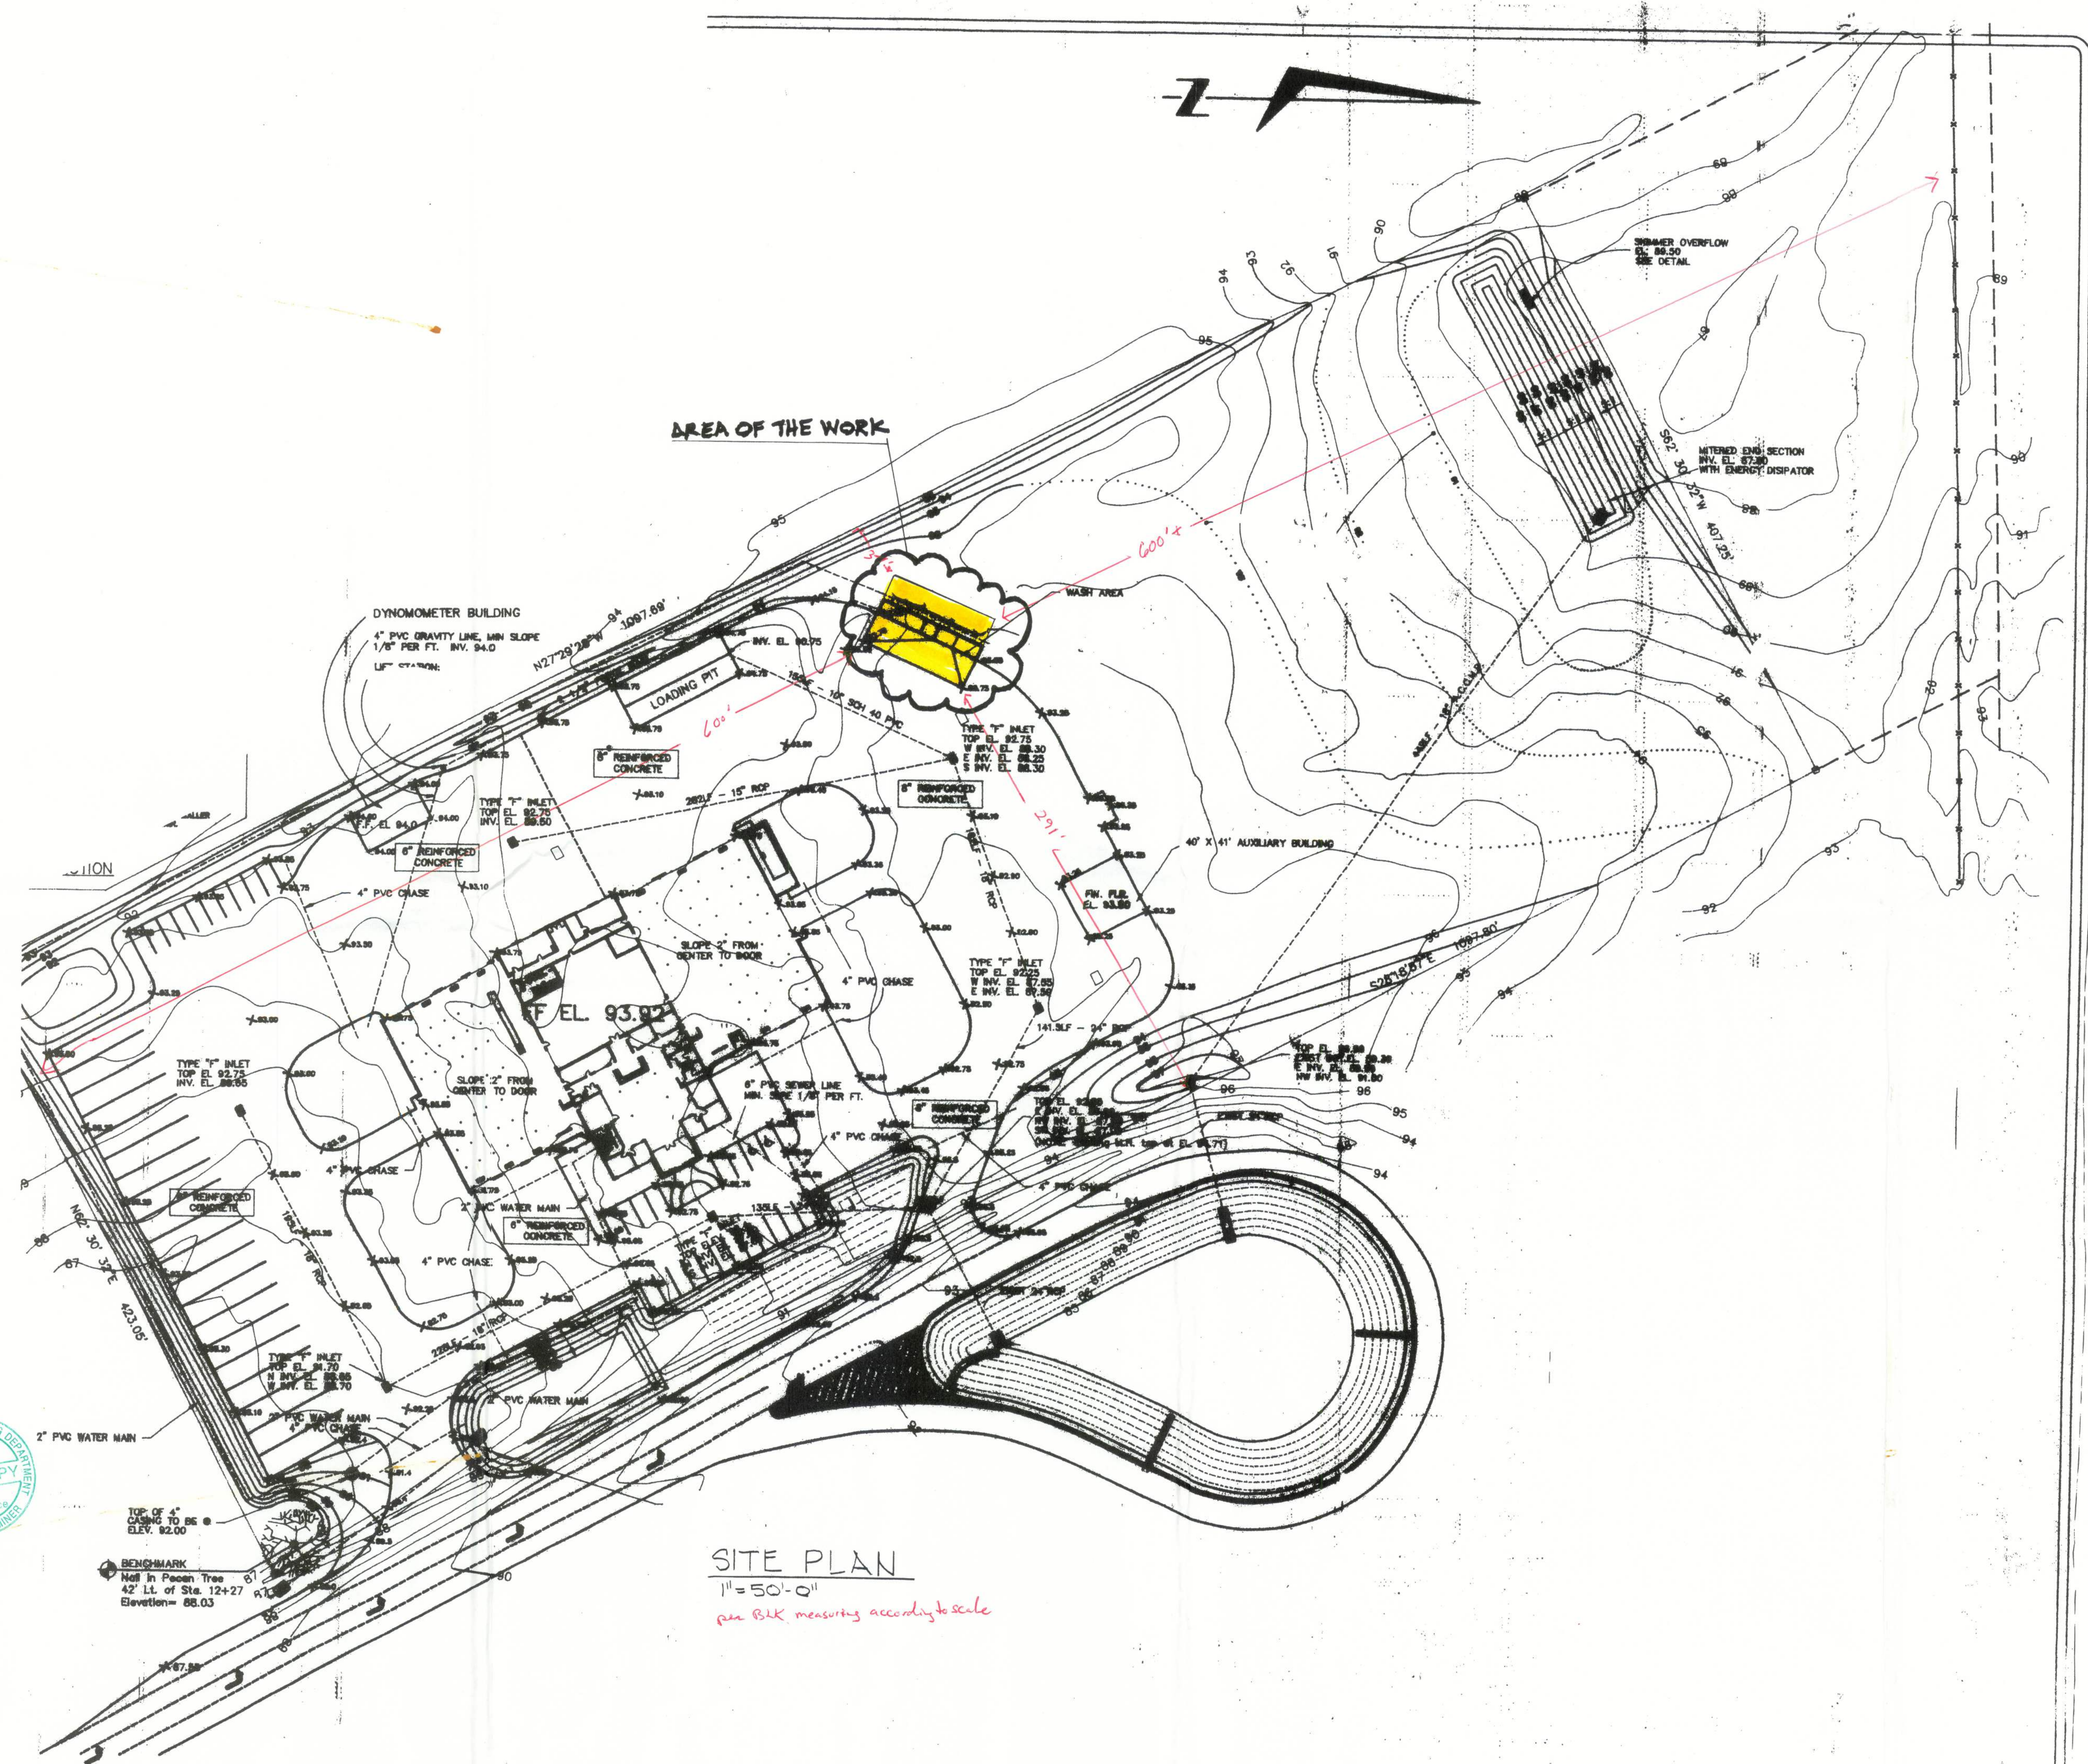

SITE PLAN
1" = 50'-0"
per B.L.K. measuring according to scale

NEW METAL BUILDING STRUCTURE FOR
RINGPOWER CORPORATION
CANNON CREEK - I-75 AND CR 47
COLUMBIA COUNTY, FLORIDA

Contract Stage:
CONSTRUCTION DRAWINGS
Revisions:

Drawn By:
Checked By:
Sheet Title:

SITE PLAN

Sheet No:

A1.0

Last Plot Date: 04/04/2011

29361