

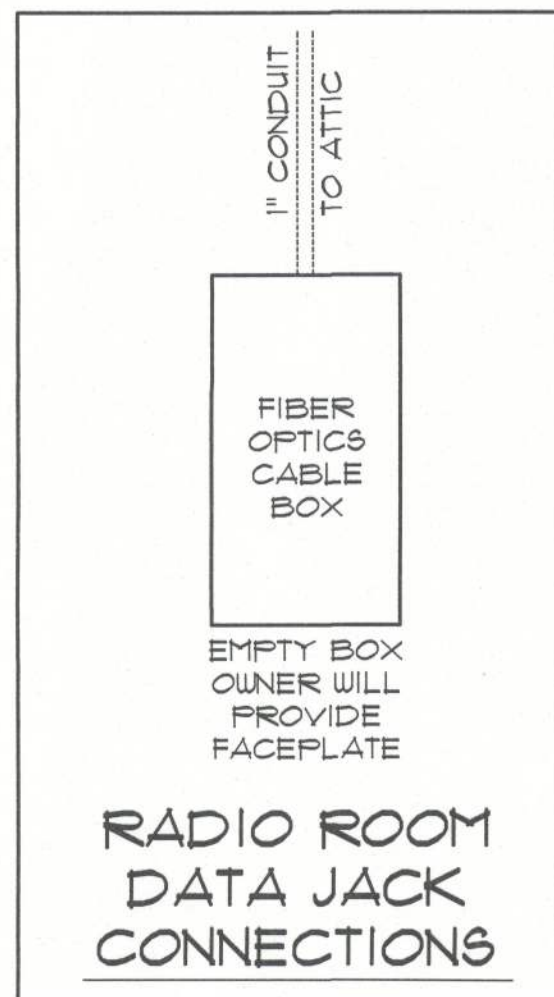
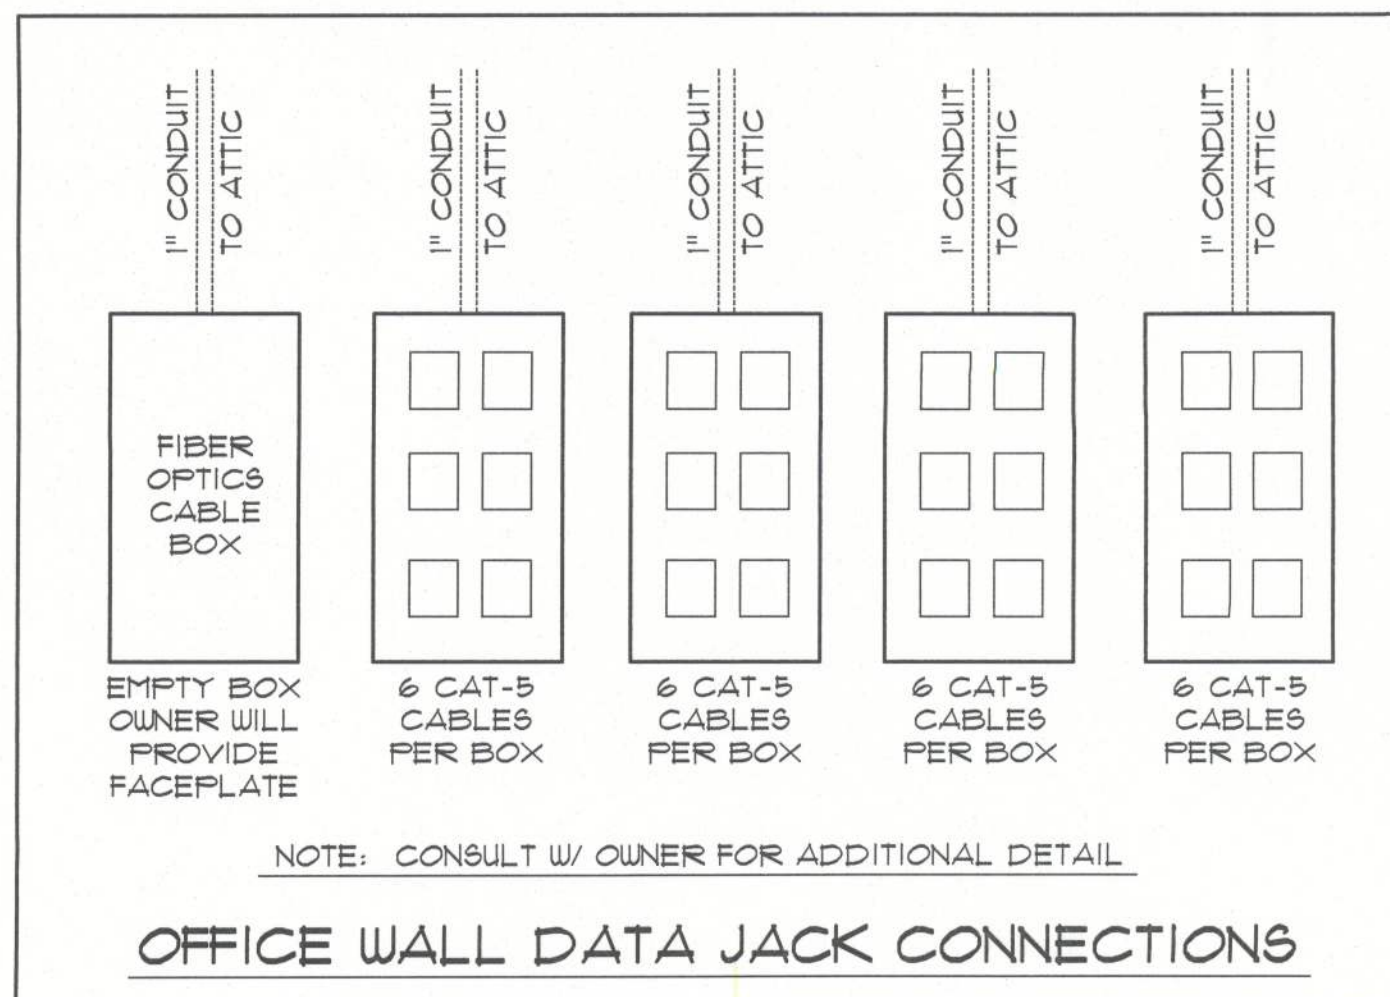


CONDUIT - SEE RADIO ROOM WALL SECTION THIS SHEET (VERIFY W/ OWNER)

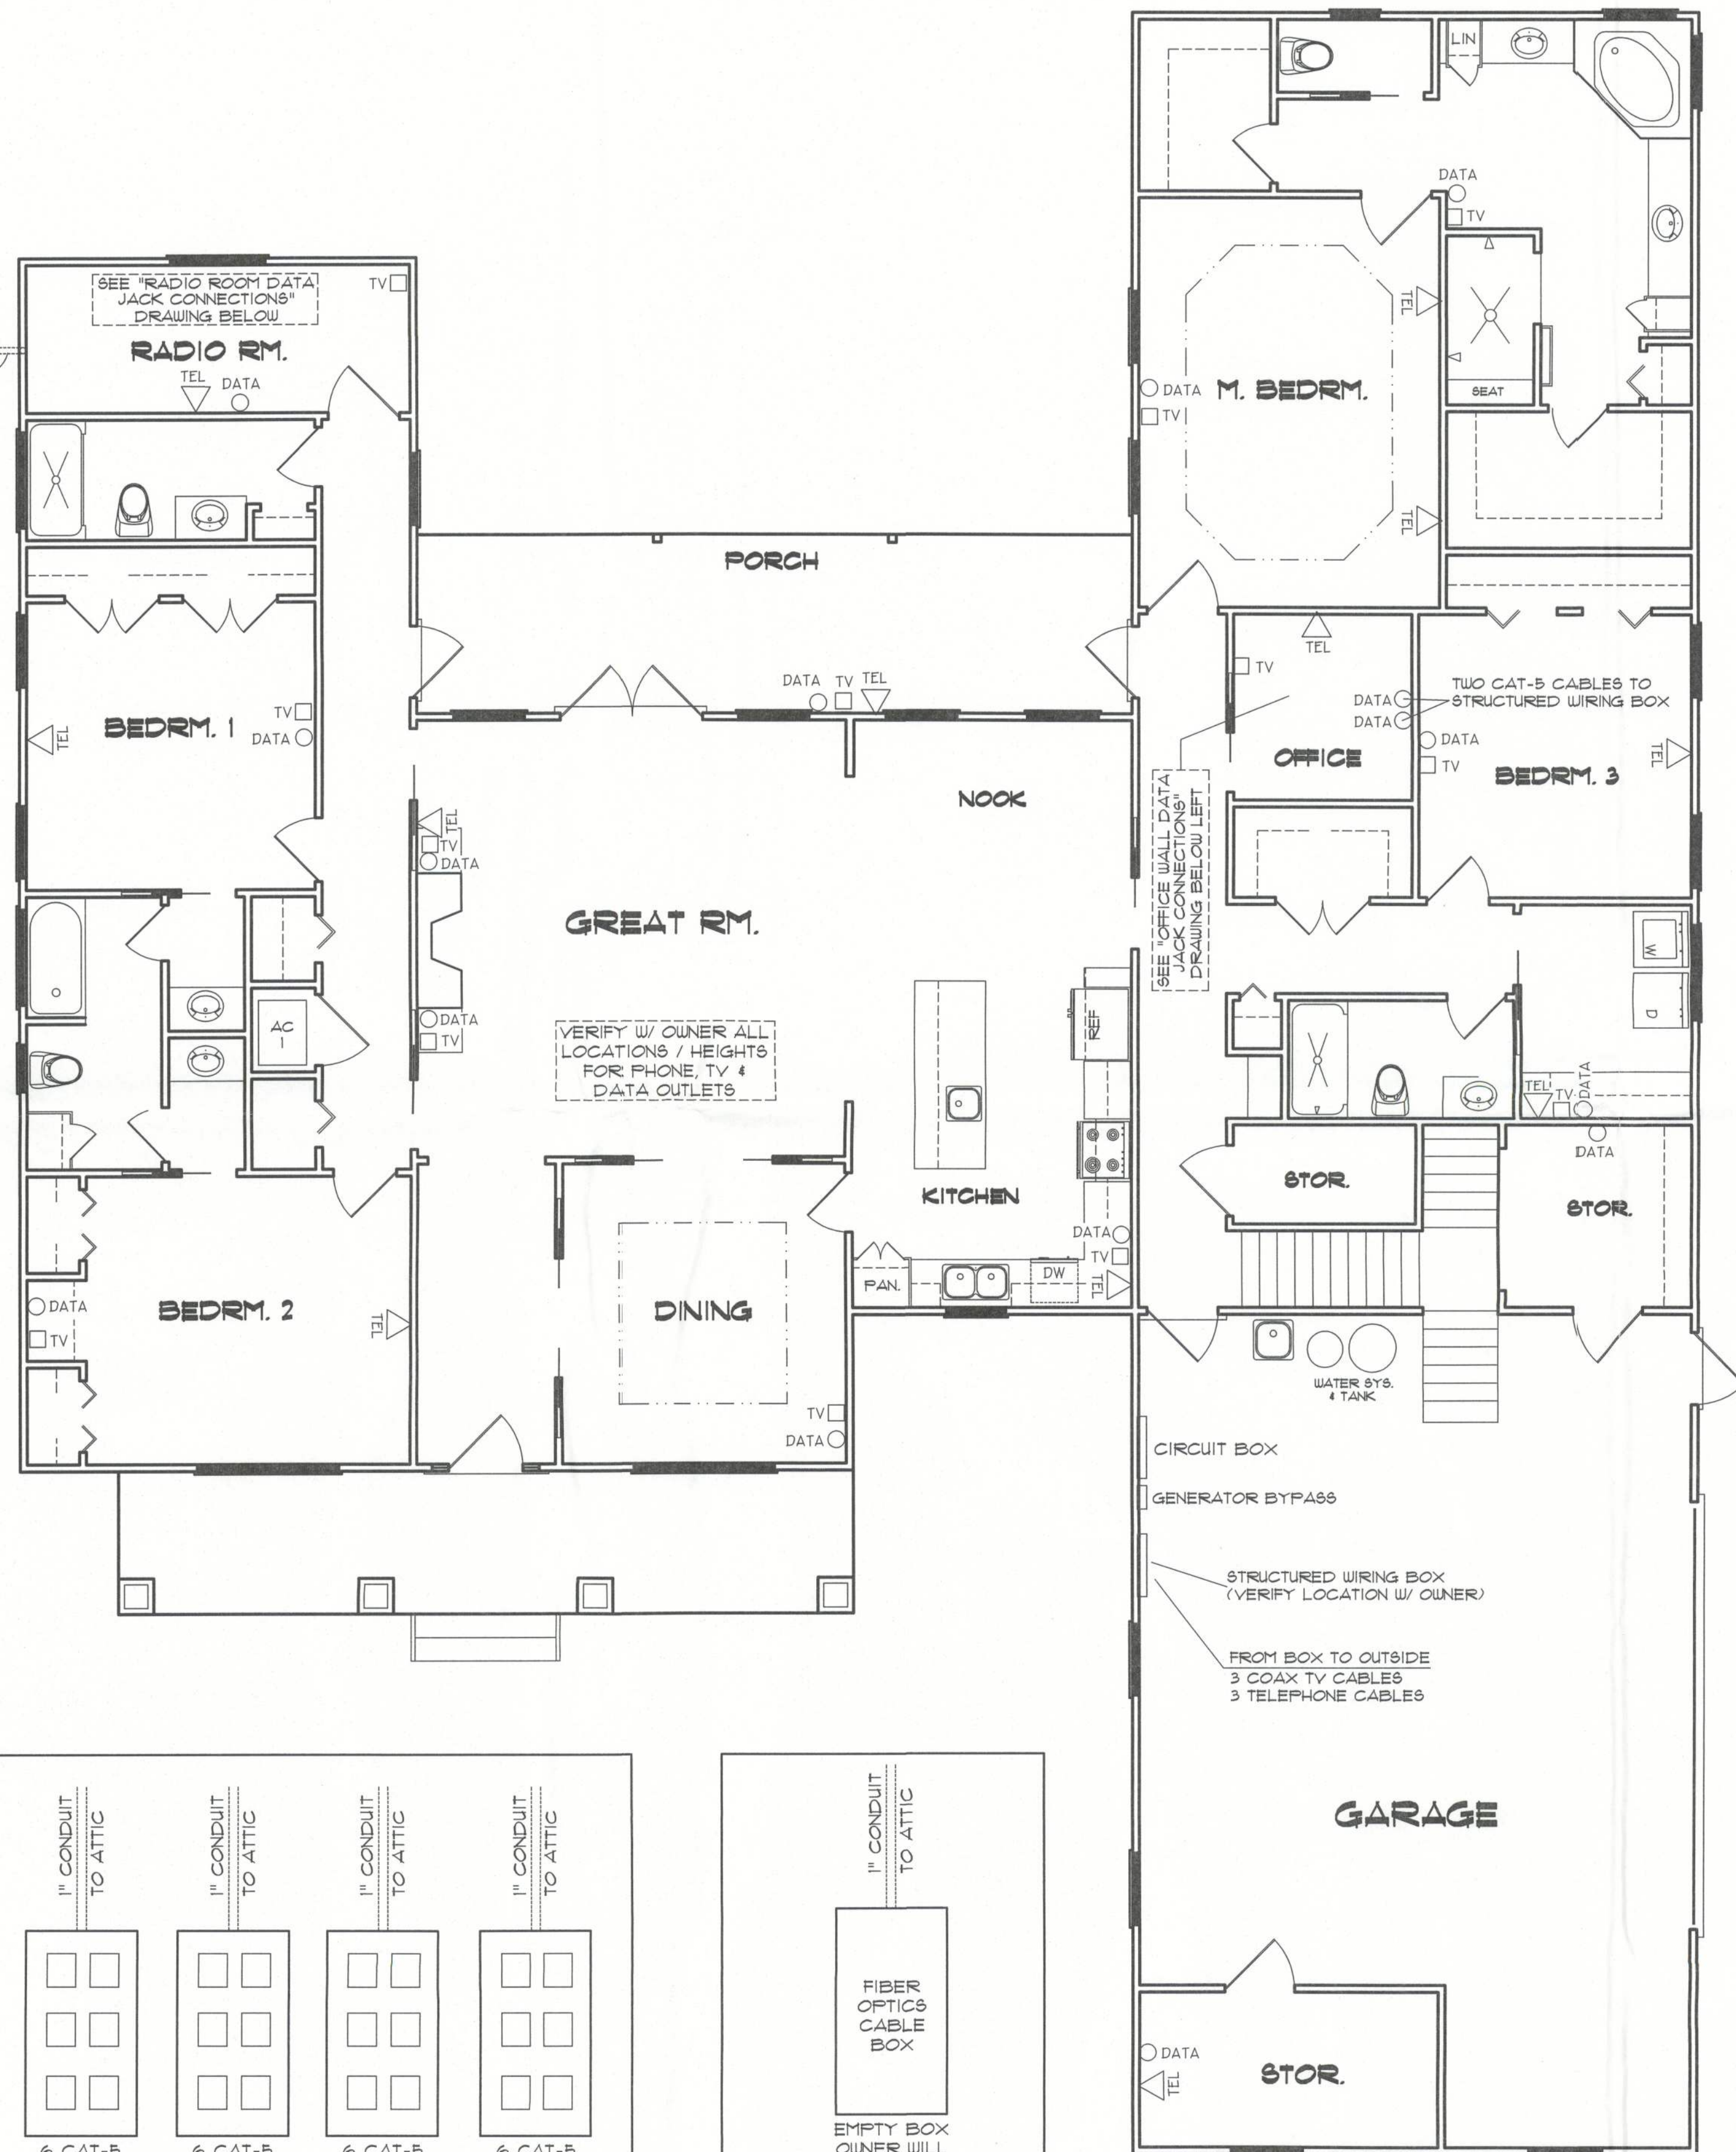


TV, PHONE, DATA
NOT TO SCALE

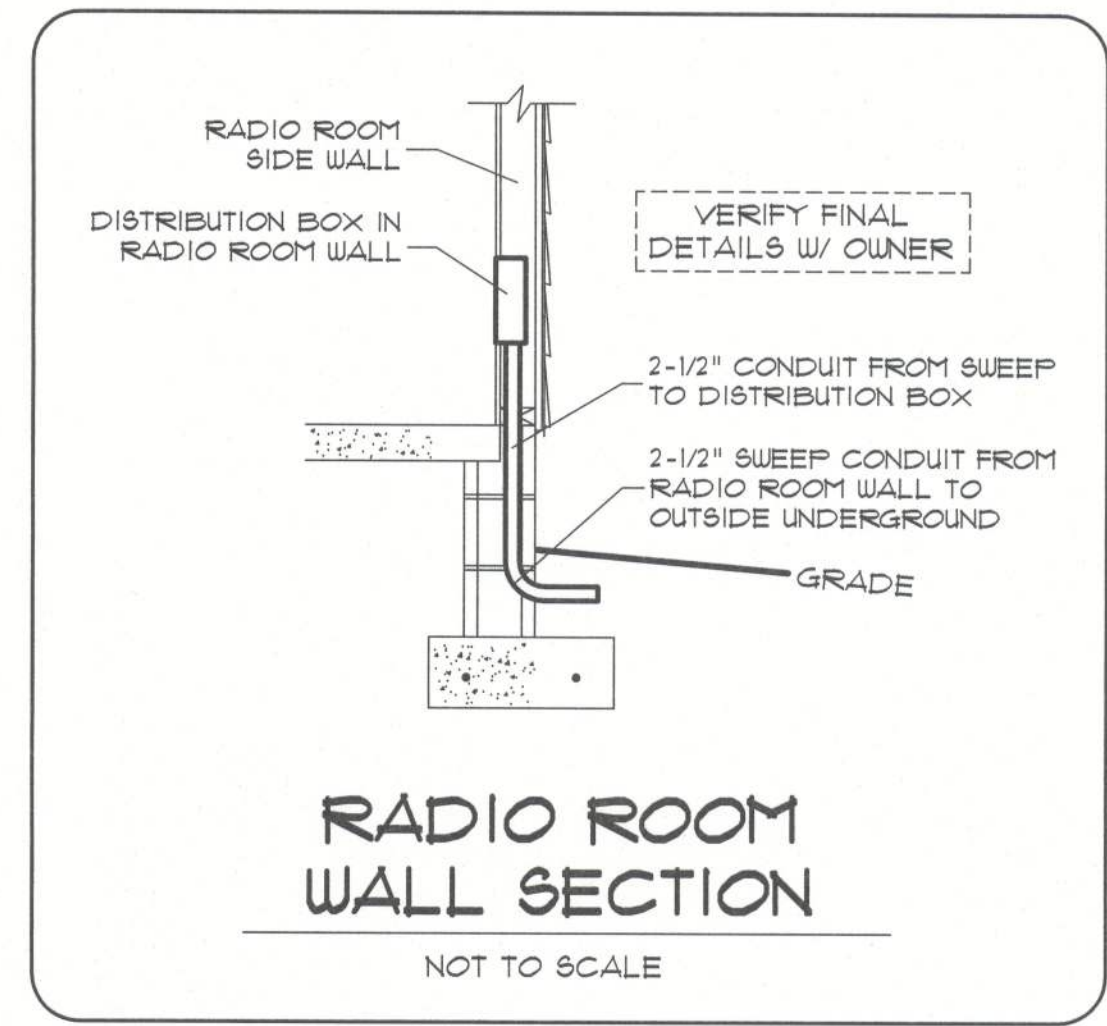

SYMBOL LEGEND	
TEL	TELEPHONE OUTLET
TV	TV OUTLET LOCATION
DATA	DATA CABLE - CAT-5

NOTE:
ALL CABLE TV OUTLETS AND PHONE CABLES GO TO STRUCTURED WIRING BOX. CAT-5 CABLES GO TO OFFICE WALL JACKS.
SEE OWNER FOR ALL FINAL DETAILS.

GENERAL NOTES
- TELEPHONE, TELEVISION AND OTHER LOW VOLTAGE DEVICES OR OUTLETS SHALL BE AS PER THE OWNER'S DIRECTIONS, & IN ACCORDANCE W/ APPLICABLE SECTIONS OF NEC-LATEST EDITION 2008.
- CONSULT THE OWNER FOR THE NUMBER OF SEPARATE TELEPHONE LINES TO BE INSTALLED.
- LOW VOLTAGE ITEMS (TELEPHONE, CATV, DATA CABLING) IS SHOWN, IF REQUESTED BY OWNER / BUILDER. CONSULT OWNER FOR REQUIREMENTS IF NOT SHOWN ON ELECTRICAL PLAN.

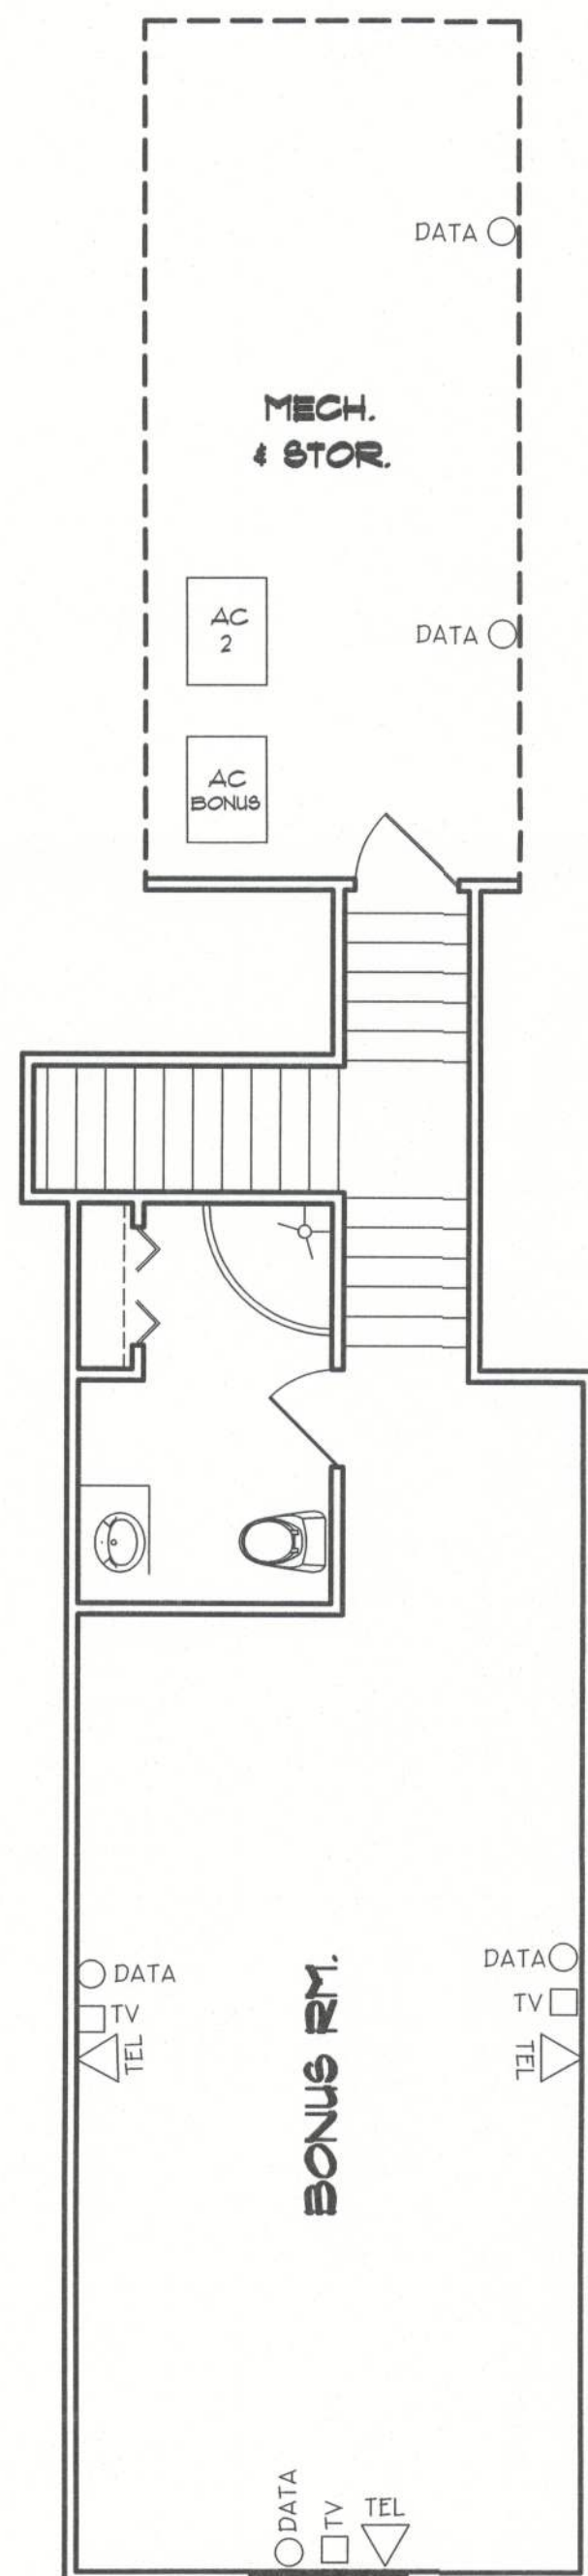

A-7

FILE: 11-004	ELLIOTT RESIDENCE	SHEET: 7 OF 7
DATE: 4-23-12		CAD FILE: 11-004
DRAWN: T A D		REV: 7/2/12
CHECK: T A D		REV:

PREPARED BY:
TIM DELBENE
Drafting + Technical Services
192 SW Sagewood Gln. Lake City, FL 32024
Phone (386) 755-5891