

DESIGN INFORMATION

USE GROUP	R-3 RESIDENTIAL
CONSTRUCTION	WOOD FRAME UNPROTECTED
FLOOR LOAD(S)	1ST 40/10 2ND 40/10
ROOF LOAD	20/10
WIND ZONE	(3 SEC. GUST) 130 (SEE FLOOR PLAN APPLICABLE WIND ZONE)
SEISMIC GROUP:	0
EXPOSURE:	B
INT. PRESSURE COEFFICIENT:	-0.18
IMPORTANCE FACTOR	1.0 COMPONENTS & CLADDING: SEE PAGES: 32 & 33 OF 46

NOTE: ACTUAL CONSTRUCTION OF UNITS CONFORM TO 110 MPH (3-SEC GUST) OPTIONAL 130 MPH - 140 MPH - 150 MPH - 160 MPH & 175 MPH AVAILABLE TO INCLUDE SITE RELATED CONSTRUCTION. CONSTRUCTION IN OPTIONAL WIND ZONES MUST BE CONFORMED WITH BY THE PURCHASER IN ACCORDANCE WITH STATE & LOCAL CODES, SUBJECT TO INSPECTION BY LOCAL JURISDICTION.

NOTICE:
IT IS THE PURCHASER'S RESPONSIBILITY TO INSURE THE ATTACHED PLANS CONFORM TO LOCAL ORDINANCES IN RESPECT TO BUILDING SIZE, HEIGHT, SETBACK OR AESTHETICS WHICH IS ENFORCED BY LOCAL JURISDICTIONS.

CODE CONFORMANCE

FLORIDA

2004 FBC W/2005-2006-2007 AMENDMENTS
2004 FMC
2004 FEC (ENERGY CODE)
ASCE 7-02 / WFCM 2001
2005 NEC
RULE 9B-72 FAC

CERTIFICATION INFORMATION

REFER TO "NOTE-1" ON FLOOR PLAN:
CERTIFICATION INFORMATION LOCATED
ON INSIDE COVER OF ELECT. PANEL
A) DATA PLATE
B) 3RD PARTY INSPECTION LABEL
C) STATE LABEL (IF REQ'D)

REFER TO "NOTE-2" ON FLOOR PLAN:
CERTIFICATION INFORMATION LOCATED
IN ADJACENT SECTIONS ON
CLOSET WALL
A) 3RD PARTY INSPECTION LABEL



© COPYRIGHT 2002 NATIONWIDE CUSTOM HOMES
ALL RIGHTS RESERVED

NATIONWIDE CUSTOM HOMES HOME PLANS AND GENERAL NOTES

LOCATION: 1100 RIVES ROAD / P.O. BOX 5511 MARTINSVILLE, VIRGINIA 24115

DP RATINGS FOR HIGH WIND ZONE

SINGLE WINDOW INTERIOR	30.4 - 33.0
SINGLE WINDOW EDGE	30.4 - 40.7
TWIN WINDOW / DOOR INTERIOR	29.0 - 31.6
TWIN WINDOW / DOOR EDGE	29.0 - 38.0
DBL. DOOR/GARAGE DOOR INT.	21.2 - 29.8
DBL. DOOR/GARAGE DOOR EDGE	21.2 - 34.3

EXPOSURE CATEGORY B

NOTE: SITE INSTALLED ITEMS REQUIRING COMPLIANCE CERTIFICATION

THE FOLLOWING ITEMS ARE TO BE SUPPLIED & SITE INSTALLED BY THE PURCHASER & CANNOT BE CERTIFIED TO COMPLY FOR COMPONENT PRODUCT APPROVAL AS PER RULE 9B-72:

- 1 - HURRICANE SHUTTERS (IF REQUIRED)
- 2 - SITE CONNECTIONS OF LIVING UNIT TO FOUNDATION & MODULAR TO MODULAR UNITS CONNECTIONS (TO COMPLY WITH WINDZONE REQUIREMENTS)
- 3 - SITE CONNECTION OF ELECTRICAL, WATER & SEWER
- 4 - STRUCTURE IS NOT TO BE LOCATED CLOSER THAN 6'-0" FROM PROPERTY LINE OR INTERIOR LOT LINE - ORIENTATION OF STRUCTURE PER STATE LOCAL CODES, SUBJECT TO INSPECTION LOCATION JURISDICTION
- 5 - COMPLIANCE WITH THE CURRENT FLORIDA FIRE PREVENTION CODE IS THE RESPONSIBILITY OF THE LOCAL CODE OFFICIAL HAVING JURISDICTION
- 6 - HVAC SYSTEM SUPPLIED & SITE INSTALLED BY PURCHASER

NUMBER OF MODULAR UNITS: 3

PLANS MAY BE REVERSED

FOR WIND BORNE DEBRIS AREAS:

HURRICANE SHUTTERS (IF REQUIRED) SUPPLIED & SITE INSTALLED BY THE PURCHASER. (PER CURRENT FBC) PURCHASER RESPONSIBLE TO NOTIFY NATIONWIDE HOMES OF FRAMING REQUIREMENTS FOR INSTALLATION OF SHUTTERS - ADDITIONAL FRAMING REQUIREMENTS TO BE ACCOMPLISHED IN THE FACTORY AT THE TIME OF CONSTRUCTION

NOTE: BASEMENT PLANS: SMOKE DETECTOR WIRE COILED UNDER FLOOR FOR SITE INST. OF SMOKE DETECTOR BY PURCHASER IN THE BASEMENT AREA. SMOKE DETECTORS WIRED FOR SIMULTANEOUS OPERATION.

NOTE: EXTERIOR WP GFCI RECEPT MUST BE ACCESSIBLE FROM GRADE LEVEL AT FRONT & REAR OF DWELLING UNIT. ANY RECEPT (AS DETERMINED BY LOCAL JURISDICTION) BY PURCHASER AS PER CURRENT NEC.

REV: 11/22/06

TYPICAL FOUNDATION NOTES

FOOTING NOTES:

1. FOOTING DESIGN BASED ON AN ALLOWABLE SOIL BEARING VALUE OF 2000 PSF AND MUST BE REVISED IF SITE CONDITIONS INDICATE A LOWER VALUE.
2. BOTTOM OF ALL FOOTINGS TO BE BELOW FROST LINE AS DETERMINED BY LOCAL BUILDING CODES. (NO LESS THAN 12")
3. CONCRETE TO DEVELOP A MINIMUM 28 DAY COMPRESSIVE STRENGTH OF 2500 PSI

TYPICAL TERRACE NOTES:

1. EXTERIOR CONCRETE TO BE AIR ENTRAINED WITH A MIN. 28 DAY COMPRESSIVE STRENGTH OF 3000 PSI (OR LOCAL REQUIREMENT)
2. 4" CONC. OVER 6"X6" #3 WIRE MESH.
3. OFFSET CAP TO CARRY SLAB.
4. INSTALL METAL FLASHING BETWEEN CONC. & WOOD MEMBERS.
5. TERRACES TO BE CONSTRUCTED AFTER HOUSE IS SET ON FOUNDATION.
6. PURCHASER RESPONSIBLE FOR ACCESSIBILITY INTO LIVING UNIT PER STATE AND LOCAL CODE.

OPTIONAL BASEMENT NOTES:

1. ALL BASEMENT DOORS AND WINDOWS ARE SUPPLIED AND INSTALLED BY PURCHASER. (IF OPT. BASEMENT PLAN SELECTED)
2. DOOR AND WINDOW SIZE & LOCATION SUBJECT TO CHANGE WITHIN BSMT. AREA ACCORDING TO SITE CONDITIONS.
3. BACKFILL TO BE IN AND TAMPED PRIOR TO ARRIVAL OF HOUSE.
4. FOUNDATION WATER PROOFING AND DAMPPROOFING TO CONFORM TO CURRENT FLORIDA BUILDING CODE
5. ALL ELECTRICAL, PLUMBING AND MECHANICAL INSTALLATION WITHIN THE BASEMENT ARE THE RESPONSIBILITY OF THE PURCHASER AND SUBJECT TO APPROVAL & INSPECTION BY THE LOCAL JURISDICTION.

UNIT FASTENING REQUIREMENTS:

- 110 MPH AREAS AND LESS:
SEE DETAILS FOR ADDITIONAL HIGH WIND ZONE FASTENING REQUIREMENTS.
1. PURCHASER TO TOENAIL PERIMETER OF FLOOR RIM TO SILL PLATE W/ 16d NAILS (NON-CORROSIVE TYPE) @ 16" OC ENTIRE PERIMETER OF HOUSE.
2. NATIONWIDE SET CREW TO BOLT MATING WALL GIRDER TOGETHER W/ 1/2" DIA. BOLTS @ 4'-0" SPACING. WHEN CONDITIONS DO NOT PERMIT SET CREW TO INSTALL BOLTS DUE TO HEIGHT OR CRAWLSPACE CLEARANCE, PURCHASER IS RESPONSIBLE FOR INSTALLATION OF BOLTS.
3. SECOND LEVEL OF 2 STORY MODELS TO BE TOENAILED TO THE FIRST LEVEL CEILING PERIMETER PLATE W/ 16d NAILS @ 16" OC. ENTIRE PERIMETER OF THE HOUSE.
4. PURCHASER TO REFER TO THE "BUILDER RESPONSIBILITY BULLETIN" FOR INSTRUCTION ON JOB SITE PREPARATION AND EQUIPMENT NEEDS FOR UNIT SETTING.

GENERAL FOUNDATION NOTES:

1. PURCHASER TO USE MORTAR TYPES FOR FOUNDATION CONSTRUCTION AS REQUIRED BY STATE AND LOCAL CODES.
 2. CRAWLSPACE VENTILATION SHALL CONFORM TO CURRENT STATE BUILDING CODE
 3. ALL EXTERIOR FINISH UNDERNEATH THE UNITS TO BE SITE INSTALLED BY PURCHASER PER STATE & LOCAL CODES SUBJECT TO INSPECTION BY LOCAL & STATE JURISDICTION
 4. VENTS TO BE WITHIN 3'-0" OF EACH CORNER
 5. THIS IS TO CERTIFY THAT THIS STRUCTURE IS DESIGNED FOR INSTALLATION ON A SITE BUILT PERMANENT FOUNDATION IN ACCORDANCE WITH THE PROVISIONS OF SECTION 428.4 OF THE 2004 FBC AND IS DESIGNED NOT TO BE MOVED ONCE INSTALLATION IS COMPLETE.
 6. 18"X24" MINIMUM FOUNDATION ACCESS.
 7. ALL FOUNDATIONS ARE TO BE DESIGNED & ENGINEERED BY A CERTIFIED FLORIDA REGISTERED ENGINEER SUBJECT TO INSPECTION BY STATE & LOCAL JURISDICTION.
- BRICK CASED DIMENSION NOTES: (IMPORTANT)
1. AN ALLOWANCE OF 5" MUST BE INCORPORATED TO EACH SIDE OF THE FOUNDATION DIMENSIONS IF BRICK CASED EXTERIOR IS SELECTED. NOTE THAT LIVING UNIT SIZES ARE NOT ADJUSTED. VERIFY DIMENSIONS W/ NATIONWIDE ENGINEERING DEPARTMENT IF CLARIFICATION OF DIMENSIONS ARE NEEDED PRIOR TO CONSTRUCTION.

TYPICAL PLUMBING NOTES

1. ALL SUPPLY, DRAIN, WASTE & VENT LINES TO BE SUPPORTED @ 4'-0" OC.
2. PURCHASER TO SUPPLY AND INSTALL ALL DWV AND SUPPLY LINE MATERIALS FOR SITE COMPLETION OF PLUMBING CONNECTIONS UNDER FLOOR AND BETWEEN 2 STORY STACK-ON SECTIONS. CONNECTIONS TO BE MADE AT WALL ACCESS ON 2 STORIES AS NOTED ON THE FLOOR PLAN. ALL CONN. SUBJECT TO INSPECTION BY LOCAL JURISDICTION.
3. ALL VENTS SHALL TERMINATE MIN. 12" ABOVE THE ROOF.
4. ALL FITTINGS, DRAIN, WASTE & VENT PIPES SHALL BE PVC/DWV PIPE W/ SOLVENT WELDED JOINTS PER MANUF. INSTALLATION INSTRUCTIONS.
5. ALL PLUMBING (ON 1ST LEVEL) WILL BE FACTORY INSTALLED TO BOTTOM OF THE FLOOR JOIST. PURCHASER RESPONSIBLE FOR PLUMBING COMPLETION TO CONFORM TO CURRENT STANDARD PLUMBING CODE.
6. ALL CLEAN-OUTS BY PURCHASER PER CURRENT STANDARD PLUMBING CODE.
7. ALL PVC/DWV TO CONFORM TO ASTM-D2665-89a.
8. ALL SUPPLY LINES SIZED PER CURRENT FLORIDA PLUMBING CODE.
9. ANTI-SCALD FAUCETS INSTALLED ON ALL SHOWER FAUCETS.
10. PURCHASER RESPONSIBLE FOR FIRESTOPPING ALL FLOOR CUTOUTS AT TUB TRAPS.

PLAN NAME: G:NUH/COVERSHEETS/FLCOVER
SERIES: ALL SERIES
DESIGN DATE: 4-23-99 DWG BY: J.S.S. CK BY: D.A.
REV. DATE: 3-01-2002 REV. BY: J.S.S.

PAGE NO.
1
OF
46



NATIONWIDE
Custom Homes
P.O. BOX 5511 MARTINSVILLE, VA. 24115
1100 RIVES ROAD, MARTINSVILLE, VA. 24115
(216) 632-1100
FAX (216) 632-1181
WWW.NATIONWIDECUSTOMHOMES.COM

NOTE: WHERE THE OPENING OF AN OPERABLE WINDOW IS LOCATED MORE THAN 7' ABOVE FIN. GRADE OR SURFACE BELOW, OPENINGS WILL BE PROVIDED W/ WINDOW GUARDS THAT COMPLY W/ ASTM F2006 OR F2090 - SUPPLIED & INST. BY THE PURCHASER - REF 2006 IRC SECT 6102, EXCEPTION 2.

NOTES:

- 3/4" T&G PLYWOOD SUB-FLR
- 1/2" PLYWOOD ROOF SHEATHING
- 8'-9 3/4" CLG HGT. - 8'-5 1/4" STUD LENGTH
- UPSCALE INT. TRIM
- CHIT FLOOR INSULATION
- CHIT RETURN AIR GRILLE
- CHIT HUNG HIGH WIND ZONE WOODS. - LOW "E"
- ALL C-TOP TO BE BOREHOLE IN PLACE (NO GLUE)

7/16" OBB EXT.
(BLOCKED) W/ 1/2" GLUB
INT. W/ Bd COMMON NAILS
SPACED @ 2" EDGE
FRAMING @ ADJOINING
PANEL EDGES TO BE 3"
NOMINAL OR WIDER AND
NAILS SHALL BE
STAGGERED

WIND RATING FOR HIGH WIND ZONE

SINGLE WINDOW INTERIOR	30/4 - 33/0
SINGLE WINDOW EDGE	30/4 - 40/1
TWIN WINDOW / DOOR INTERIOR	23/0 - 31/6
TWIN WINDOW / DOOR EDGE	23/0 - 30/0
2BL DOOR/GARAGE DOOR INT.	71/2 - 24/8
2BL DOOR/GARAGE DOOR EDGE	71/2 - 34/3

EXPOSURE CATEGORY B

CERTIFICATION INFORMATION	
NOTE-1	NOTE-2
U DATA PLATE A) 3rd PARTY MRP. LABEL B) STATE LABEL FOR MD / NJ / TN / GA C) STATE LABEL (F RECD) D) IMILATION (NC ONLY)	A) 3rd PARTY MRP. LAB B) STATE LABEL FOR MD / NJ / TN / GA

GENERAL PLAN NOTES:

1. THIS UNIT TO MEET 130 MPH (3-SEC. GUST) HIGH WIND ZONE AS DETAILED ON THE BUILDING SECTION
2. 1/2" PLYWOOD EXTERIOR SHEATHING.
3. HORIZONTAL BLOCKING AT ALL EXTERIOR PLYWOOD JOINTS

NOTE: ONLY ONE HOUSE
MAY BE BUILT UTILIZING
THE PLANS THAT ARE
DESIGNATED FOR THIS
CONTRACT JOB



NATIONWIDE
Custom Homes
P.O. BOX 5511 MARTINSVILLE, VA. 24115
1100 RIVES ROAD, MARTINSVILLE, VA. 24115
(276) 632-1100
FAX (276) 632-1101
WWW.NATIONWIDECUSTOMHOMES.COM

PLAN NAME: WINSTON	
COLLECTION/SERIES: STANDARD / LEGACY	
DESIGN DATE: 2/21/06	DWG. BY
REV. DATE:	REV. BY
REV. DATE:	REV. BY

PFS ¹⁻⁴ **APPROVED**
DATE 7/12/07
PFS CORPORATION
Cottage Grove, WI

[illegible]

DETAIL HH-

[illegible]


PAGE NO. 2

OF
46

pm

7/19/07

U:\FLORIDA\WINSTON #91636 KENT HARRISS\91636.dwg, 7/3/2007 2:03:45 PM, Printed by: Eddie Williams

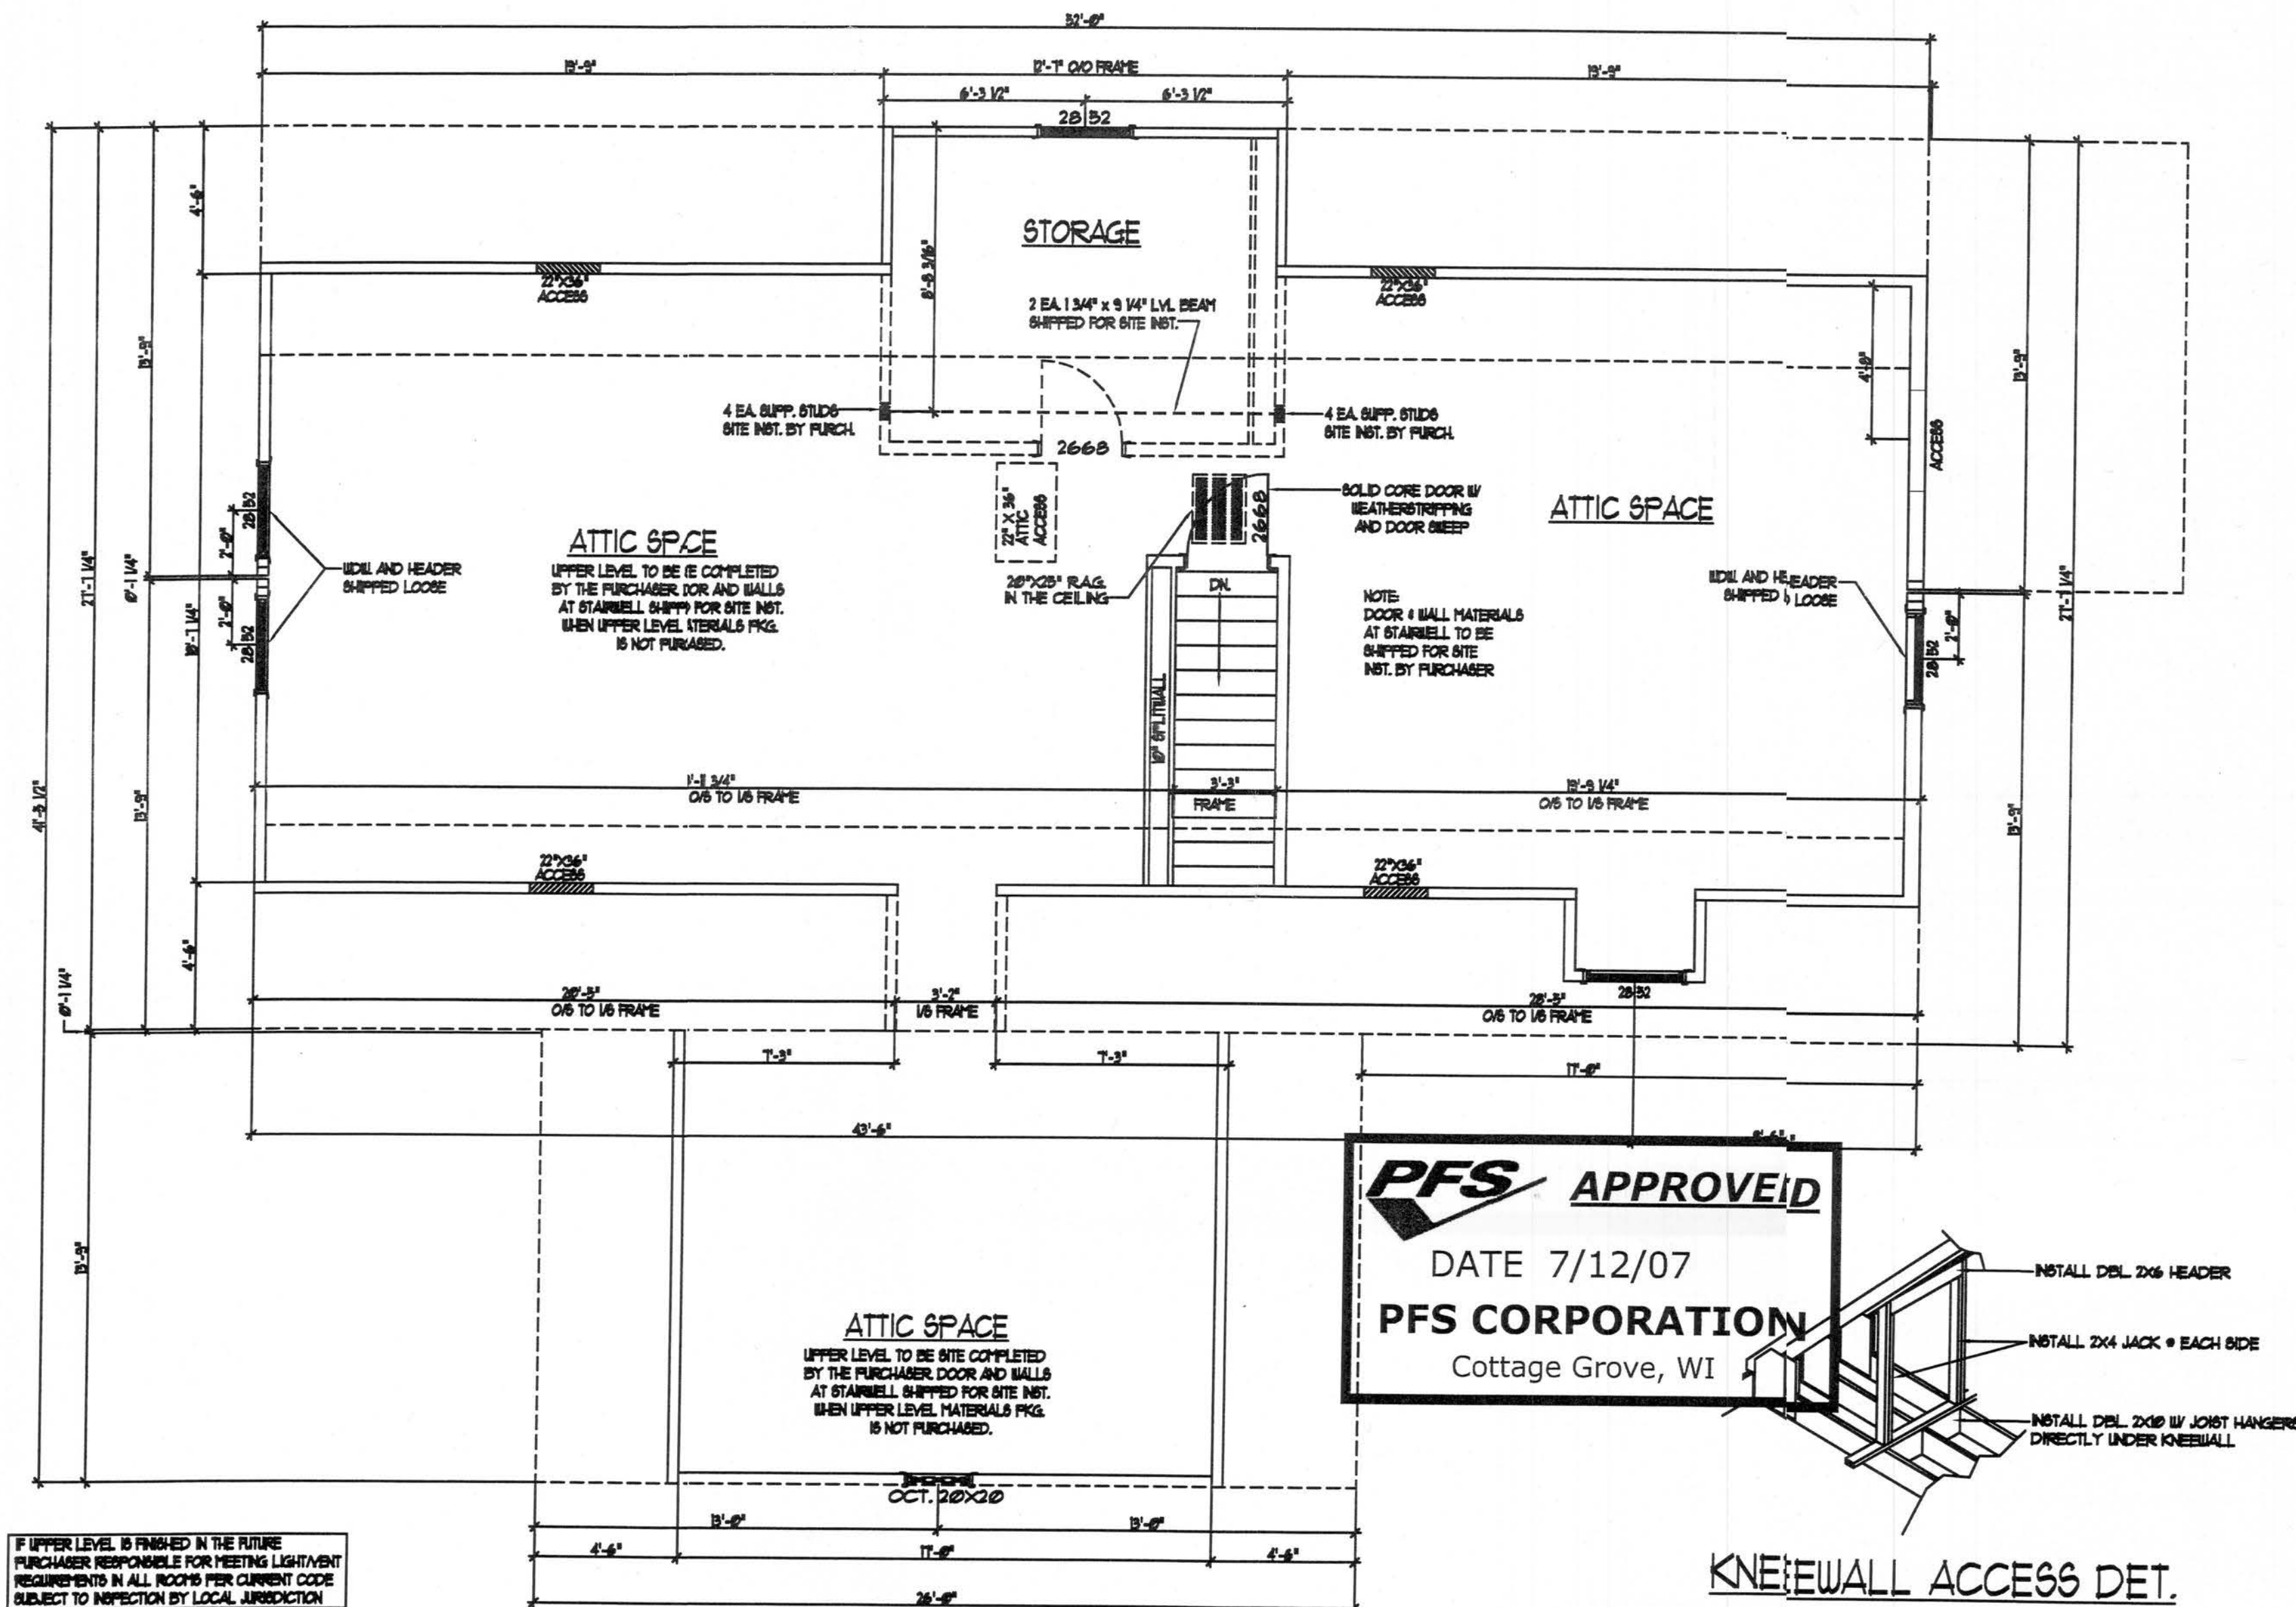

NOTE: ONLY ONE HOUSE MAY BE BUILT UTILIZING THE PLANS THAT ARE DESIGNATED FOR THIS CONTRACT JOB



NATIONWIDE
Custom Homes
P.O. BOX 5511 MARYSVILLE, VA. 24113
1100 RIVES ROAD, MARTINSVILLE, VA. 24113
(716) 632-1000
FAX (716) 632-1181
WWW.NATIONWIDECUSTOMHOMES.COM

PLAN NAME: WINSTON

COLLECTION/SERIES: STANDARD / LEGACY

DESIGN DATE: 2/2/06

REV. DATE:

REV. DATE:

DWG. BY: CR

REV. BY:

REV. BY:

CHK. BY:

PURCHASER: KENT HARRISS

JOB NO: MS-1-07

PROCESS DATE: 6-11-07

CHANGE ORDER DATE: 06/25/07 CLH 7/3/07 (GUB EIW)

CONTRACT NO: 91636

DWG. BY: TODD A. CHK. BY:

PAGE NO.

3



OF

46

2/2/07
1/9/07

U:\FLORIDA\WINSTON #91636 KENT HARRISS\91636.dwg, 7/13/2007 2:19:25 PM, Printed by: Eddie Williams

VENTILATION CALCULATIONS:
RIDGE ENT: 9.8 Sq. Ft. Net Free Air
VENTILATED
BOFFIT = 4.4 Sq. Ft. Ventilated Boffit

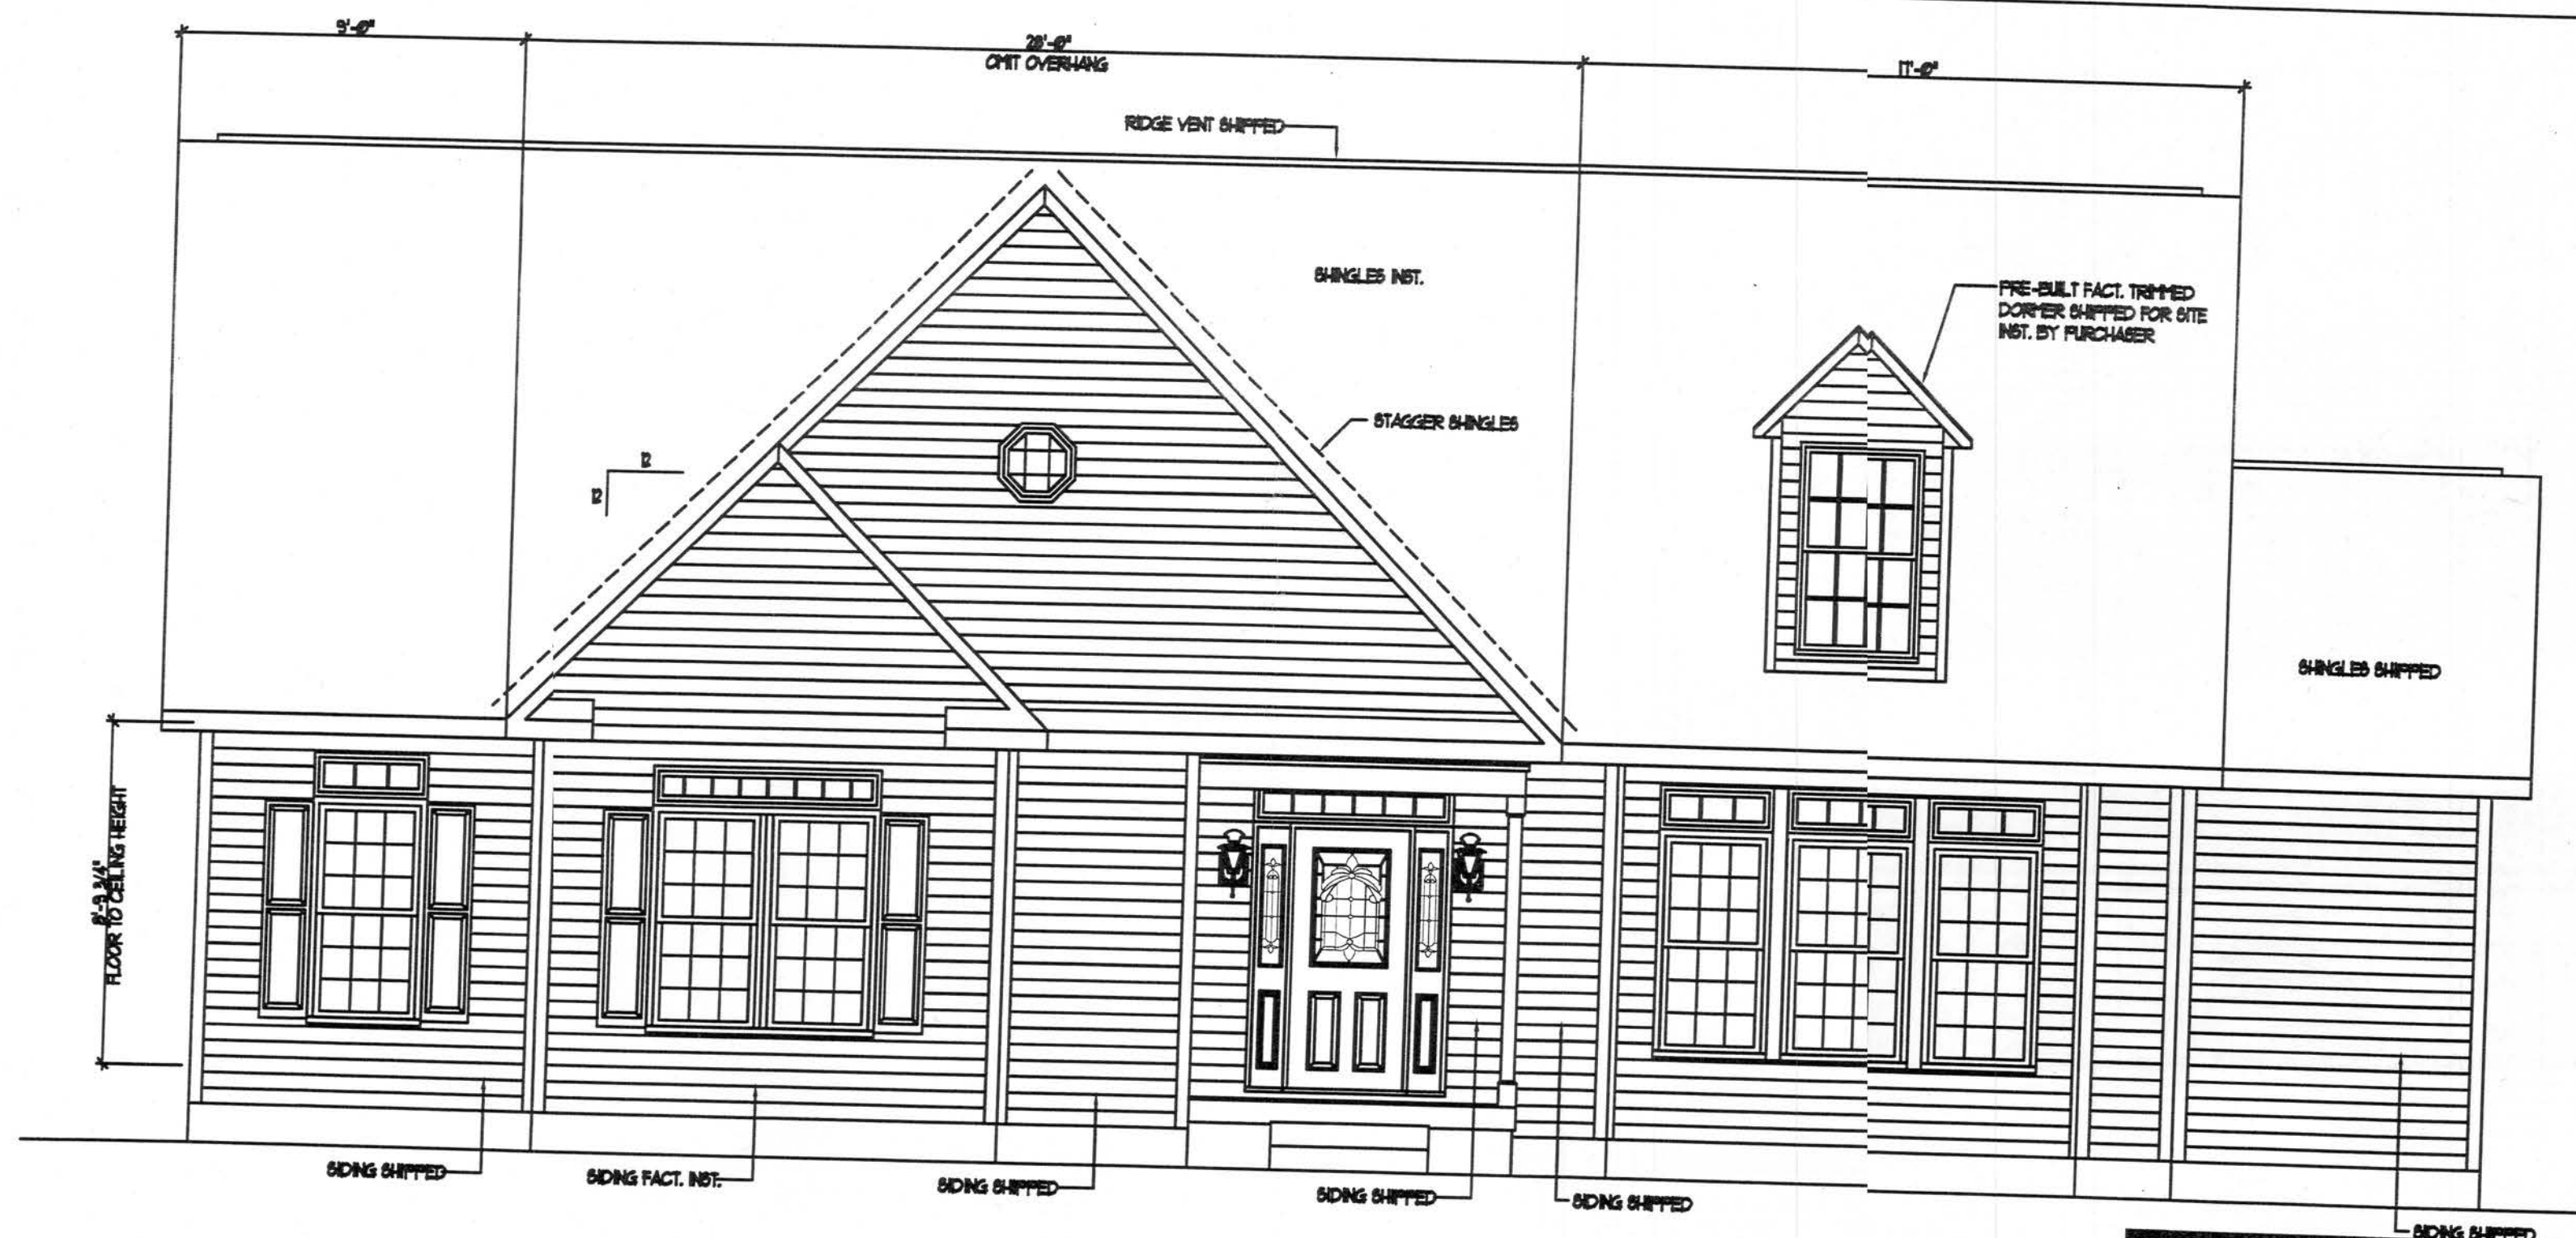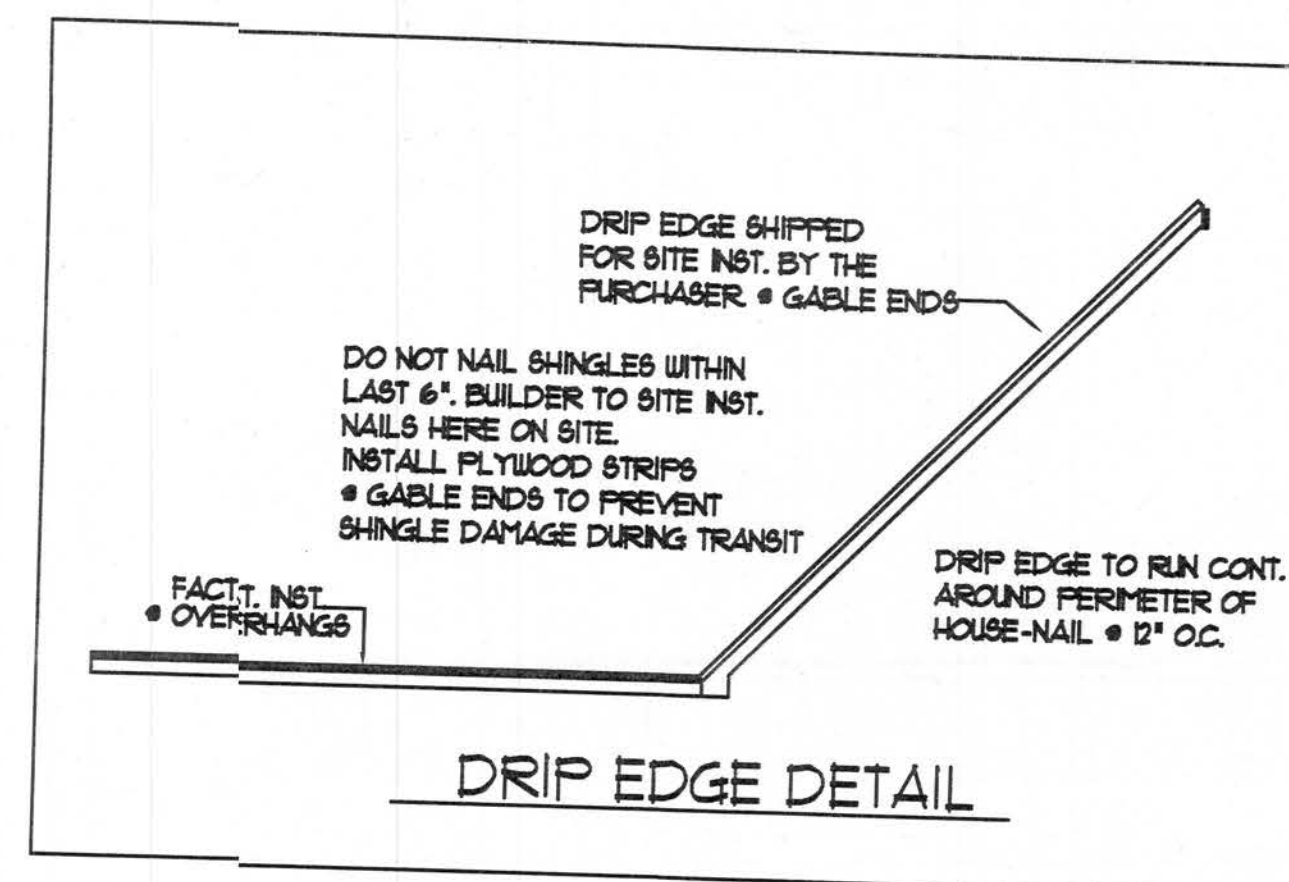

Front Elevation

SCALE - 1/4" = 1'-0"

NOTES:
• 12" OVERHANGS

PFS APPROVED
DATE 7/12/07
PFS CORPORATION
Cottage Grove, WI

NOTE: ONLY ONE HOUSE
MAY BE BUILT UTILIZING
THE PLANS THAT ARE
DESIGNATED FOR THIS
CONTRACT JOB



NATIONWIDE
Custom Homes
P.O. BOX 5511 MARTINSVILLE, VA 24115
1100 RIVES ROAD, MARTINSVILLE, VA 24115
(276) 632-1100
FAX (276) 632-1101
WWW.NATIONWIDECUSTOMHOMES.COM

PLAN NAME: WINSTON

COLLECTION/SERIES: STANDARD / LEGACY

DESIGN DATE: 2/21/06

REV. DATE:

REV. DATE:

DWG. BY: CR

REV. BY:

REV. BY:

CHK. BY:

PURCHASER: KENT HARRISS

JOB NO: MS-1-1-07

PROCESS DATE: 6-11-07

CHANGE ORDER DATE: 06/25/07 CLH

PRODUCTION DATE:

CONTRACT NO: 91636

DWG. BY: T.A

CHK. BY:

DATE BY:

PAGE NO.


4

OF

46

Handwritten signature and date: 7/19/07

U:\FLORIDA\WINSTON #21636 KENT HARRISS\21636.dwg, 7/3/2007 2:21:04 PM, Printed by: Eddie Williams

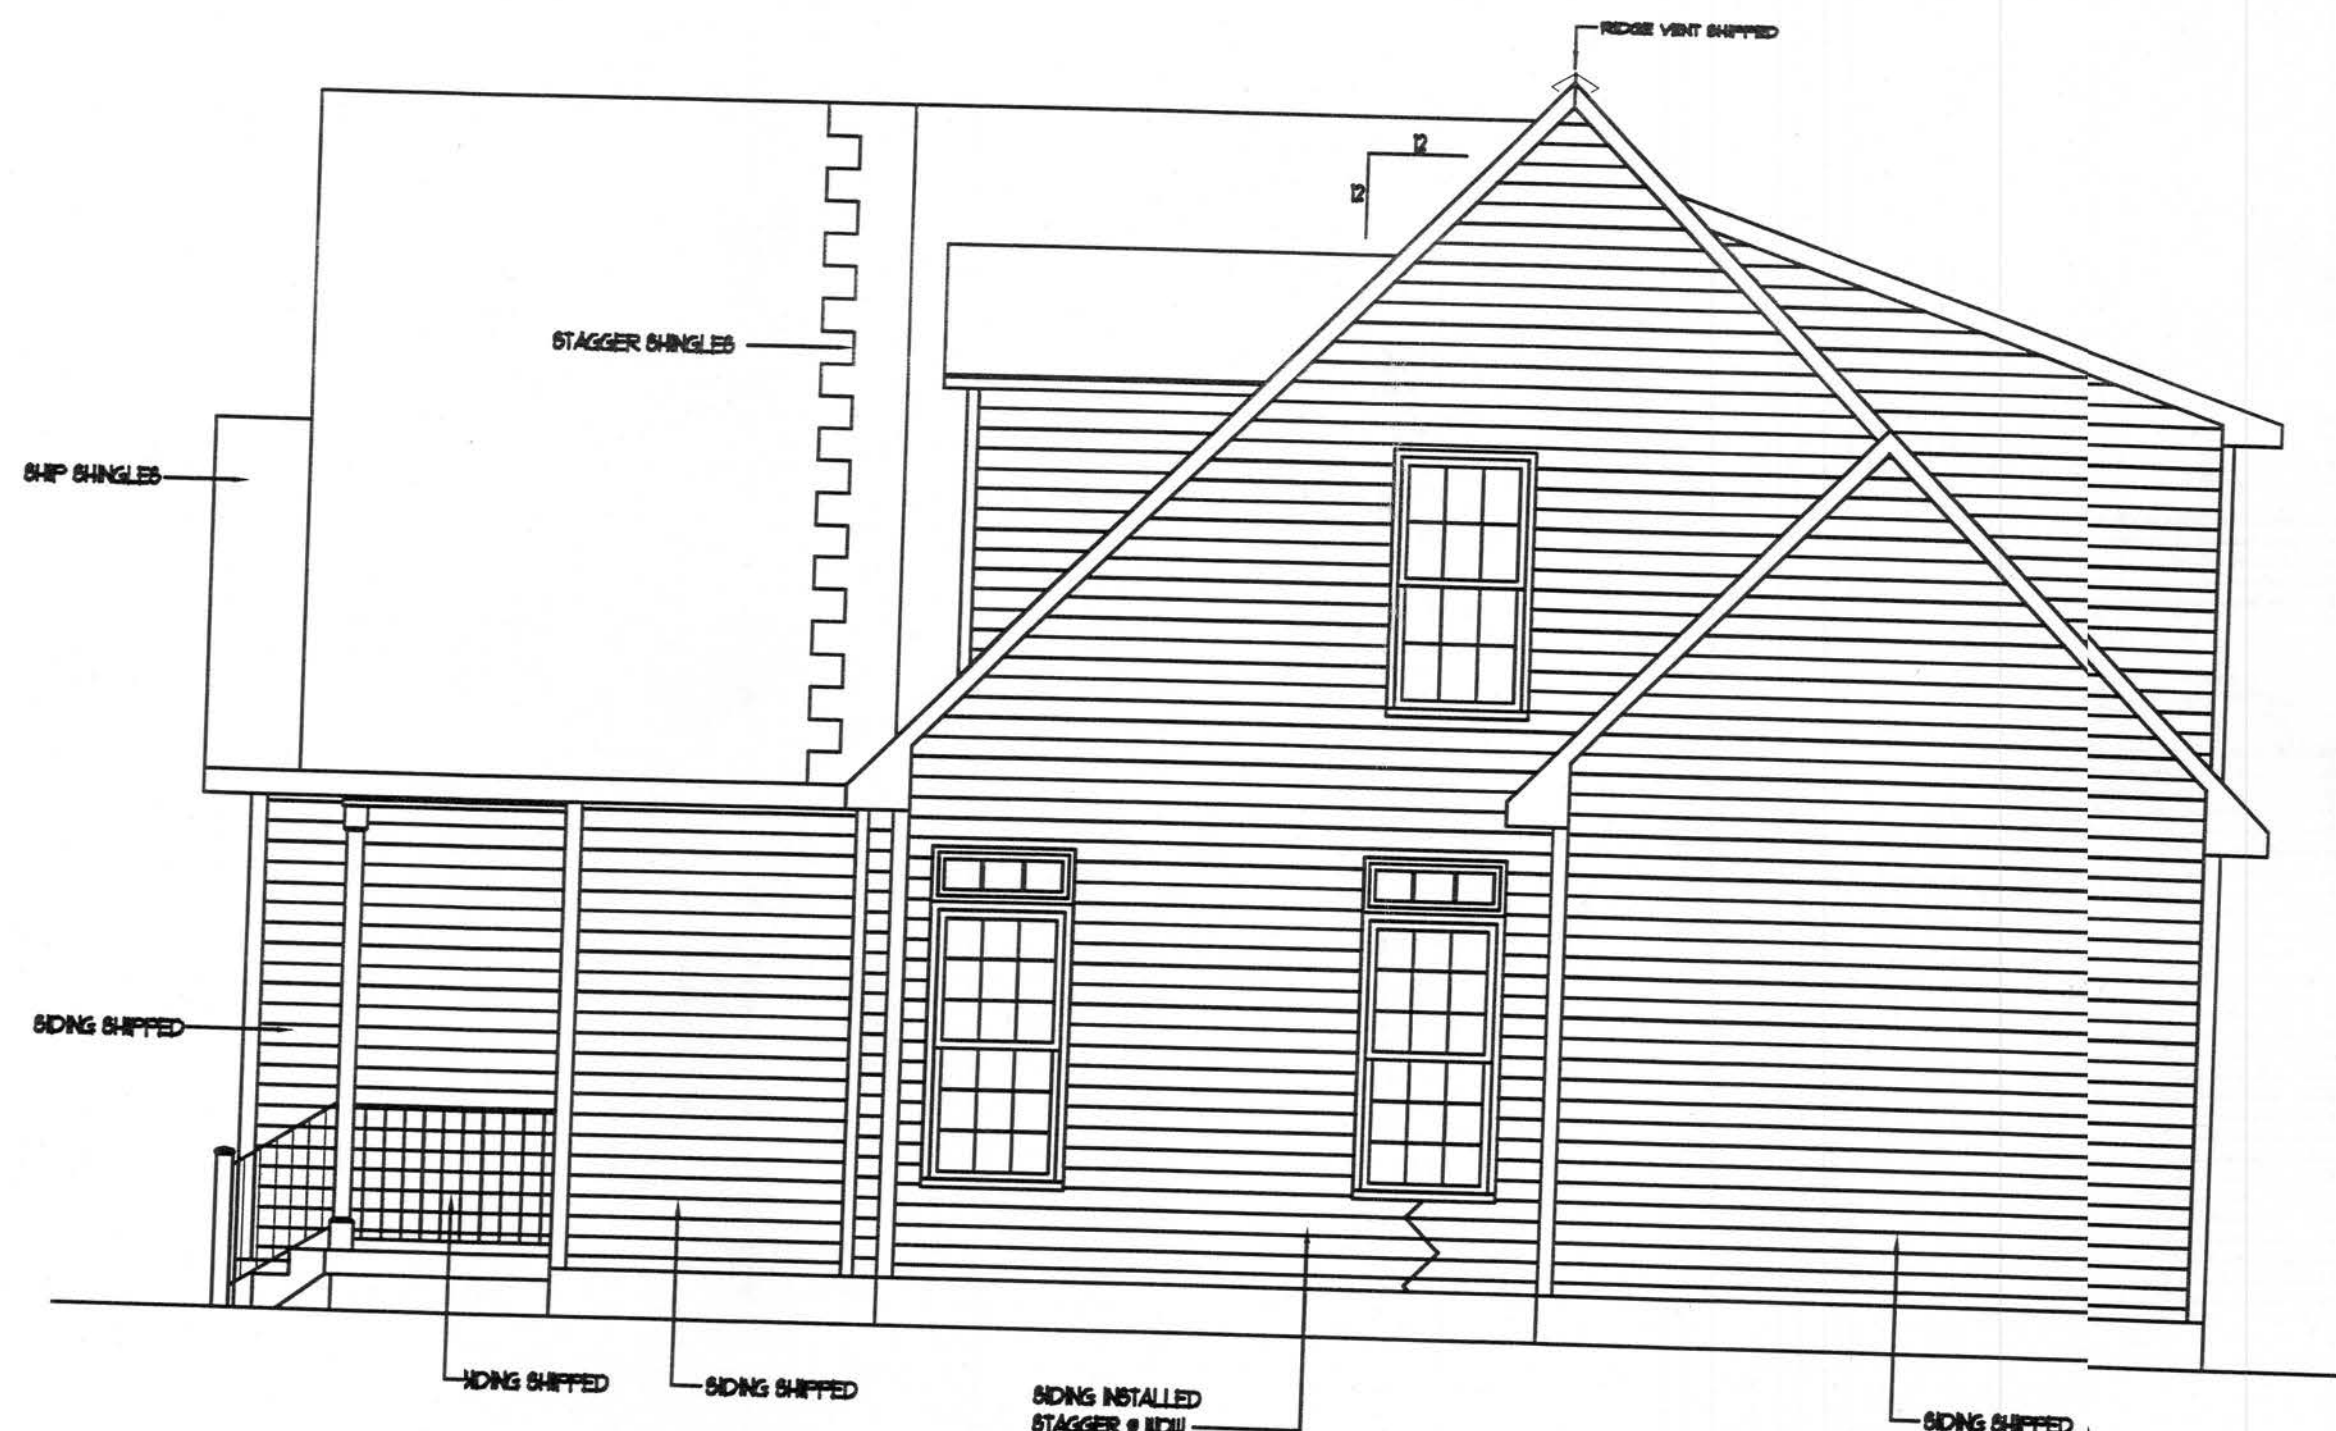

Right Elevation

SCALE - 1/4" = 1'-0"



NOTE: ONLY ONE HOUSE
MAY BE BUILT UTILIZING
THE PLANS THAT ARE
DESIGNATED FOR THIS
CONTRACT JOB



NATIONWIDE
Custom Homes
P.O. BOX 5511 MARTINSVILLE, VA. 24115
1100 RIVES ROAD, MARTINSVILLE, VA. 24115
(216) 62-1100
FAX (216) 632-1181
WWW.NATIONWIDECUSTOMHOMES.COM

PLAN NAME: WINSTON

COLLECTION/SERIES: STANDARD / LEGACY

DESIGN DATE: 2/2/06

REV. DATE:

REV. DATE:

DWG. BY: CR

REV. BY:

REV. BY:

CHK. BY:

PURCHASER: KENT HARRISS

JOB NO: MS-1-07

PROCESS DATE: 6-11-07

CHANGE ORDER DATE: 06/25/07 CLH

CONTRACT NO: 91636

DWG. BY: T.A.

CHK. BY:

PAGE NO.
5

OF
46

Handwritten signature and date: 7/9/07


U:\FLORIDA\WINSTON #91636 KENT HARRISS\91636.dwg, 7/3/2007 2:21:21 PM, Printed by: Eddie Williams



Left Elevation
SCALE - 1/4" = 1'-0"



NOTE: ONLY ONE HOUSE
MAY BE BUILT UTILIZING
THE PLANS THAT ARE
DESIGNATED FOR THIS
CONTRACT JOB

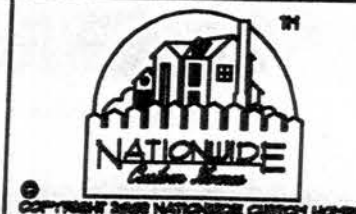

NATIONWIDE
Custom Homes
P.O. BOX 511 MARTINSVILLE, VA 24115
1100 RIVES ROAD, MARTINSVILLE, VA 24115
(26) 632-1100
FA: (216) 632-1181
WWW.NATIONWIDECUSTOMHOMES.COM

PLAN NAME: WINSTON

COLLECTION/SERIES: STANDARD / LEGACY

DESIGN DATE: 2/21/06

REV. DATE:

REV. DATE:

DWG. BY: CR

CHK. BY:

REV. BY:

REV. BY:

PURCHASER: KENT HARRISS

JOB NO: MS-1-07

PROCESS DATE: 6-11-07

CHANGE ORDER DATE: 06/25/07 CLH

CONTRACT NO: 91636

DWG. BY: T.A.

CHK. BY:

PAGE NO.

6

OF

46


7/12/07

U:\FLORIDA\WINSTON #91636 KENT HARRISS\91636.dwg, 7/3/2007 2:21:48 PM, Printed by: Eddie Williams



Rear Elevation

SCALE - 1/4" = 1'-0"

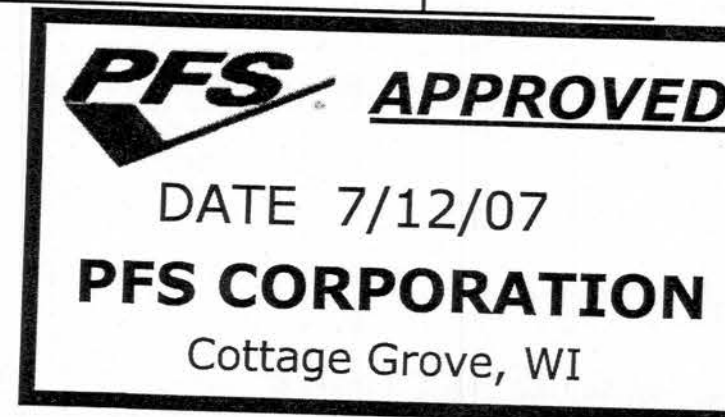

NOTE: ONLY ONE HOUSE
MAY BE BUILT UTILIZING
THE PLANS THAT ARE
DESIGNATED FOR THIS
CONTRACT JOB



NATIONWIDE
Custom Homes
P.O. BOX 5511 MARTINSVILLE, VA. 24115
1100 RIVES ROAD, MARTINSVILLE, VA. 24115
(276) 632-1100
FAX (26) 632-1181
WWW.NATIONWIDECUSTOMHOMES.COM

PLAN NAME: WINSTON
COLLECTION/SERIES: STANDARD / LEGACY
DESIGN DATE: 2/21/06
REV. DATE:
REV. DATE:

DWG. BY: CR
REV. BY:
REV. BY:

CHK. BY:

PURCHASER: KENT HARRISS

JOB NO: MS-1-07

CONTRACT NO: 91636

PROCESS DATE: 6-11-07

DWG. BY: T.A.

CHK. BY:

CHANGE ORDER DATE: 06/25/07 CLH


PRODUCTION DATE:

CHK. BY:

PAGE NO.
7
OF
46

Handwritten signature and date: 7/19/07

U:\FLORIDA WINSTON #91636 KENT HARRIS 5/9/16 3:36 PM, Printed by: Eddie Williams

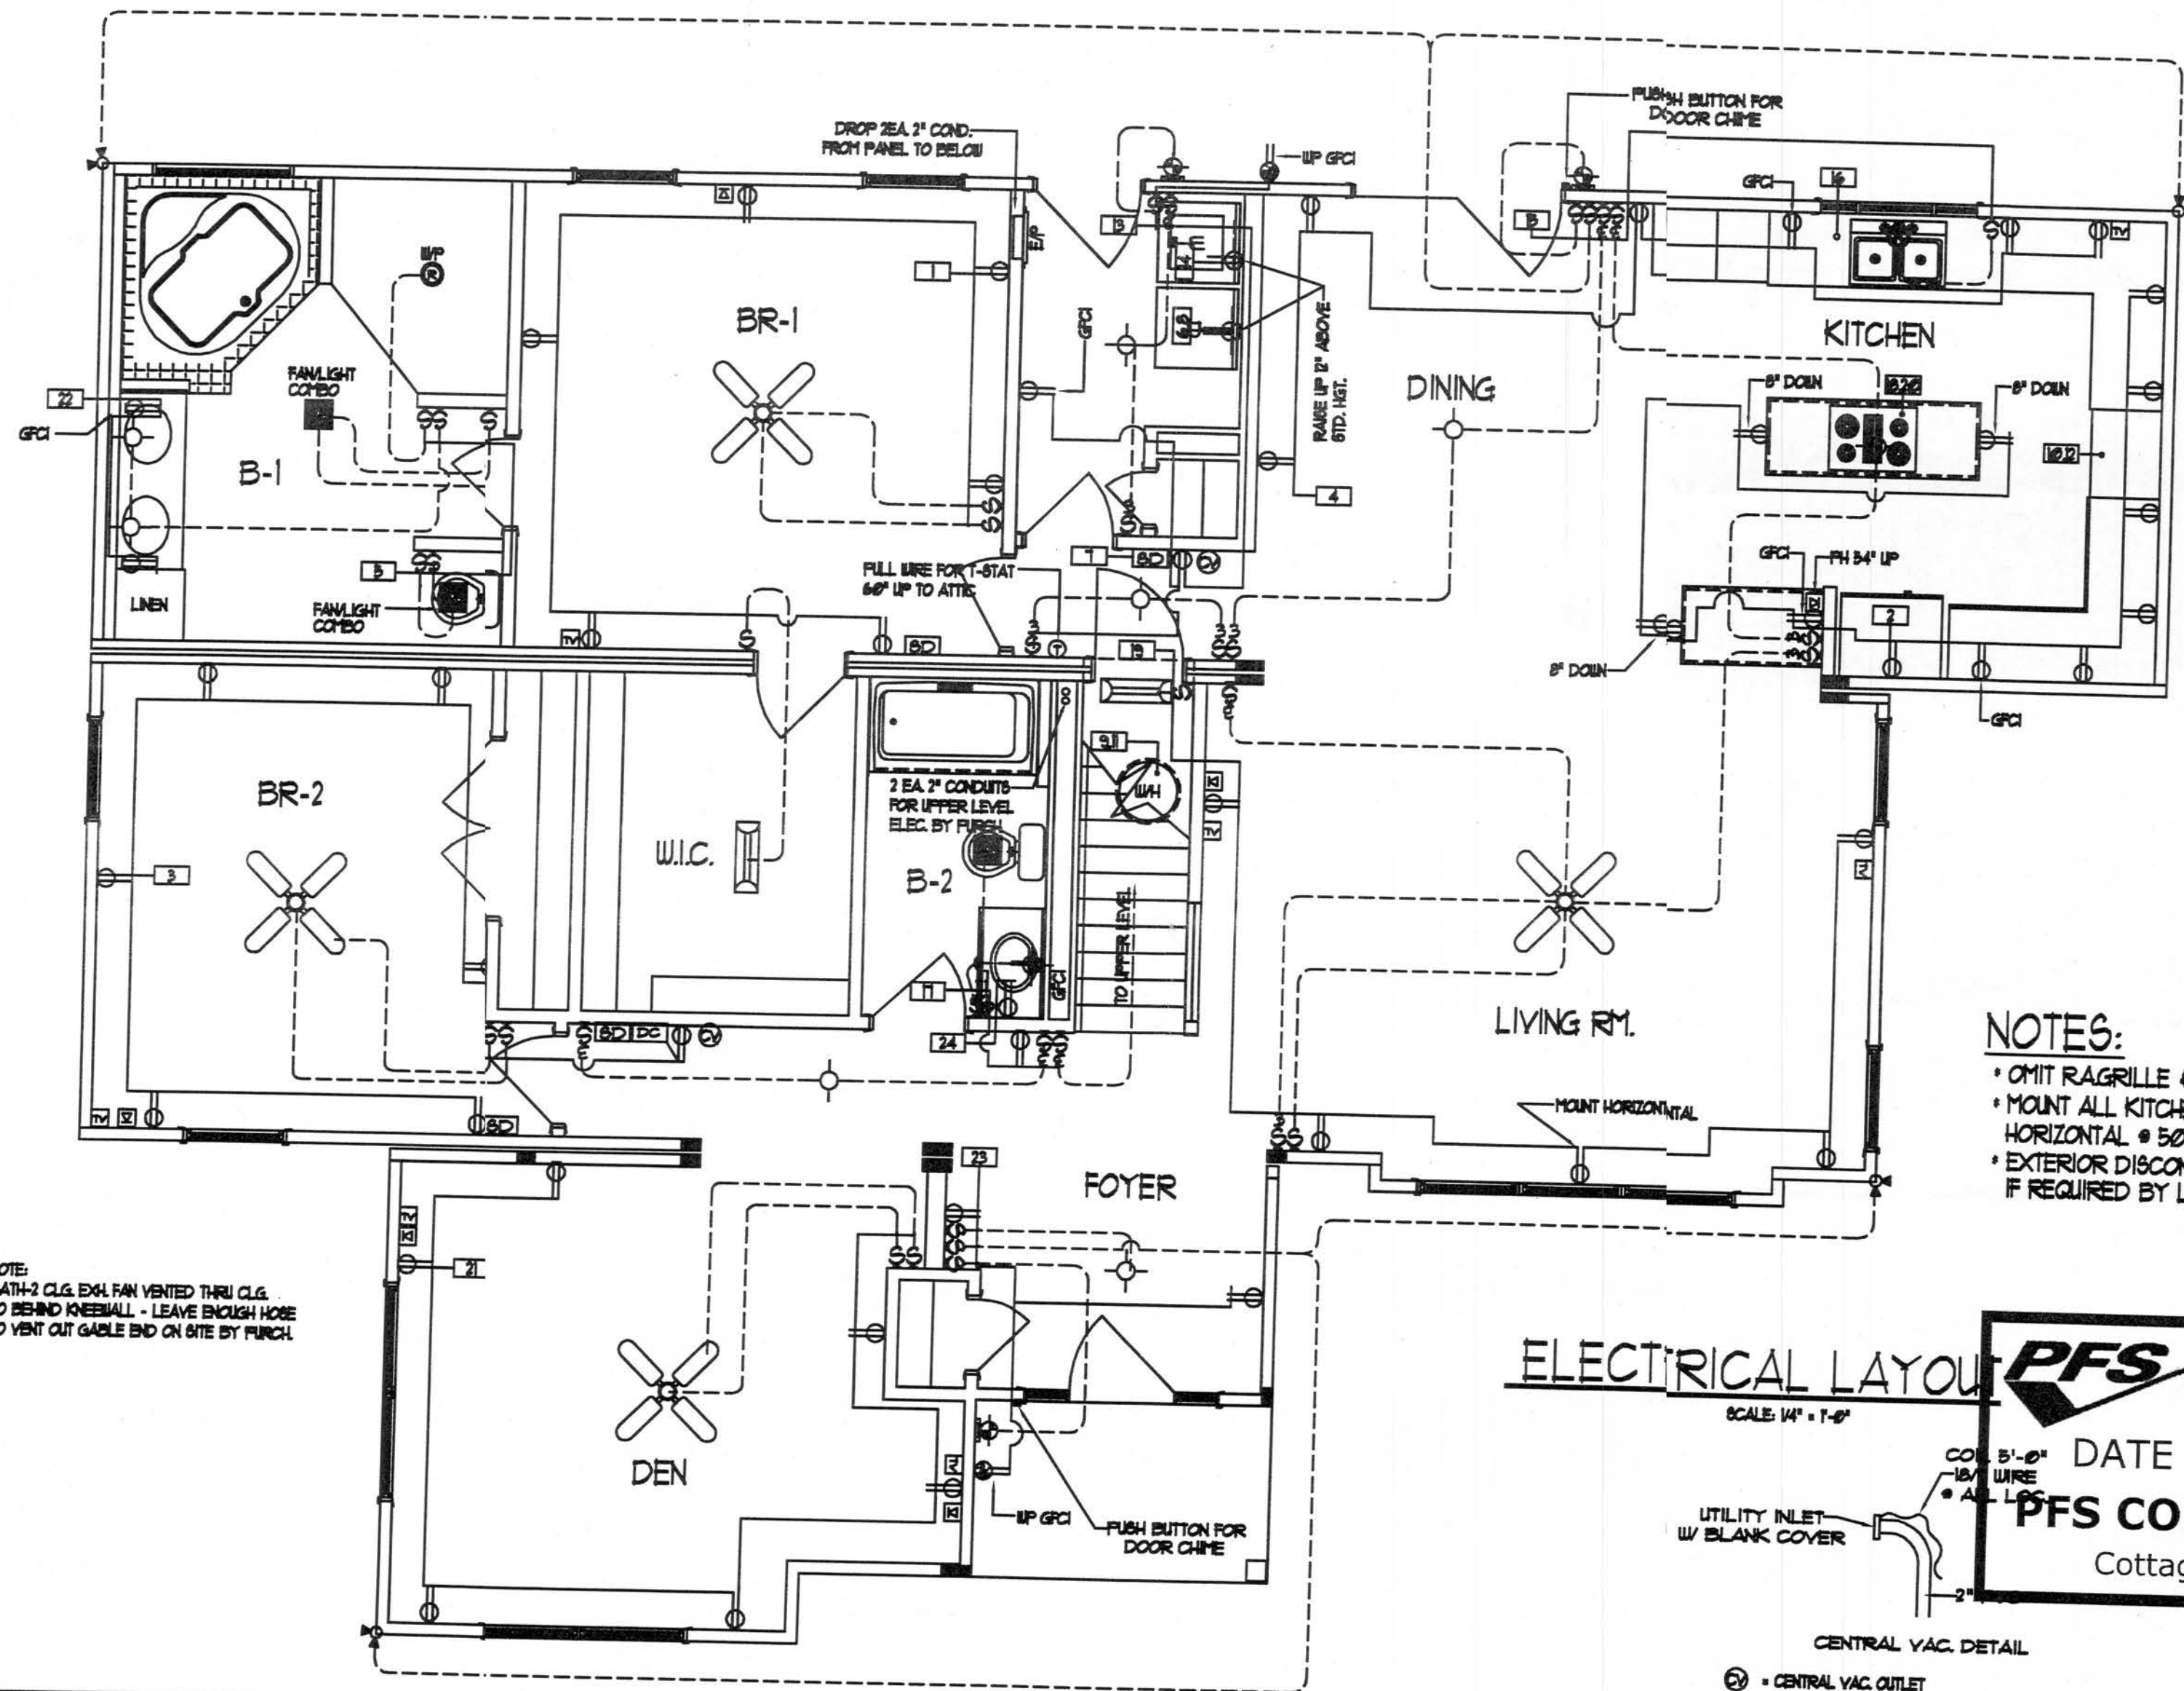

NOTES:

- * OMIT RAGRILLE & FLOOR REGISTERS
- * MOUNT ALL KITCHEN C-TOP RECEPTS HORIZONTAL @ 50" AFF.
- * EXTERIOR DISCONNECT BY PURCHASER IF REQUIRED BY LOCAL JURISDICTION

ELECTRICAL LAYOUT

SCALE: 1/4" = 1'-0"

PFS APPROVED

DATE 7/12/07

PFS CORPORATION

Cottage Grove, WI

UTILITY INLET
W/ BLANK COVER

CENTRAL VAC. DETAIL

⊙ = CENTRAL VAC. OUTLET

- A) Purchaser responsible for all service entry connections to dwelling unit main service panel.
- B) Purchaser responsible for performing complete circuit testing prior to service connection for all site wiring.
- C) Exterior weatherproof recepts and light fixtures shipped for site installation by purchaser.
- D) All gas pipe lines for gas appliances by purchaser.
- E) All heating / cooling systems supplied and installed by purchaser per state and local codes.
- F) When washer/dryer are located in basement, all int./conn. shall be by Purch to meet current Bldg/Elec. codes.

- G) All wiring to be per National Electric Code (Current Addition).
- H) Unless other wise specified, min. recept. 14" from subfloor to bottom of boxes, switches 2", Thermostat 60"
- I) AC/DC smoke detectors wired & simultaneous operation.
- J) GFCI recepts wired with feed thru for ground fault protection to all (Load side) lunch circuit recept.
- K) Range hoods are ventless unless otherwise specified.
- L) All exhaust fans in baths and dryer shall be vented to the outside air by the purchaser unless otherwise specified.
- M) Lock-Out clip on meter heater.

- N) Switches & Recept. in bathrooms and dressing rooms over lavatories to be 42" up.
- O) Switches and recepts. over counter to be 44" up unless otherwise specified.
- P) All electrical boxes on exterior walls to be sealed with foam to eliminate air infiltration.
- Q) Batt insulation glued to attic access cover.
- R) Insulation shipped for site installation by Purch to be installed in gaps at mating wall seams, and at floor & ceiling areas.

- S) Ceiling angles to be caulked behind crown mould (If crown mould is purchased).
- T) All exterior wall horizontal sheathing joints to be sealed.
- U) Interior walls around the perimeter of basement openings to be insulated with R-15.
- V) Wiring for phone and TV outlets are the responsibility of the purchaser. NCH to provide the outlet, jack and 2x4 box with 1/2" conduit below subfloor.

• Duplex Receptacle	• Single pole switch	• Carbon Monoxide Det.
• Weatherproof duplex	• Three-way switch	• Paddle Fan
• 240v Receptacle	• Four-way switch	• Exterior Light
• Overhead light	• Television outlet	• Heat/Fan/Light
• Recessed Light	• Telephone outlet	
• Weatherproof light	• Home Office Box	
• Fluorescent light	• Thermostat	
• Clg. Exh. fan (50 CFM Min)	• Electric door chime	
• Push button for chime	• Smoke Detector	

NOTE: ONLY ONE HOUSE MAY BE BUILT UTILIZING THE PLANS THAT ARE DESIGNATED FOR THIS CONTRACT JOB



NATIONWIDE
Custom Homes

P.O. BOX 5511 MARTINSVILLE, VA 24115
1100 RIVES ROAD MARTINSVILLE, VA 24115
(716) 32-1100
FAX (25) 632-1101
WWW.NATIONWIDECUSTOMHOMES.COM

PLAN NAME: WINSTON

COLLECTION/SERIES: STANDARD / LEGACY

DESIGN DATE: 2/21/06

REV. DATE:

REV. DATE:

DWG. BY: CR

REV. BY:

REV. BY:

CHK BY:

PURCHASER: KENT HARRIS

JOB NO: PMS-1-07

PROCESS DATE: 6-11-07

CHANGE ORDER DATE: 06/25/07 CLH 7/3/07 (SUB EWW)

CONTRACT NO: 91636

DWG. BY: TODD A

CHK BY:


PAGE NO.
8

OF


46

Handwritten signature and date: 7/19/07

U:\FLORIDA\WINSTON #91636 KENT HARRISS\91636.dwg, 7/13/2007 2:32:38 PM, Printed by: Eddie Williams

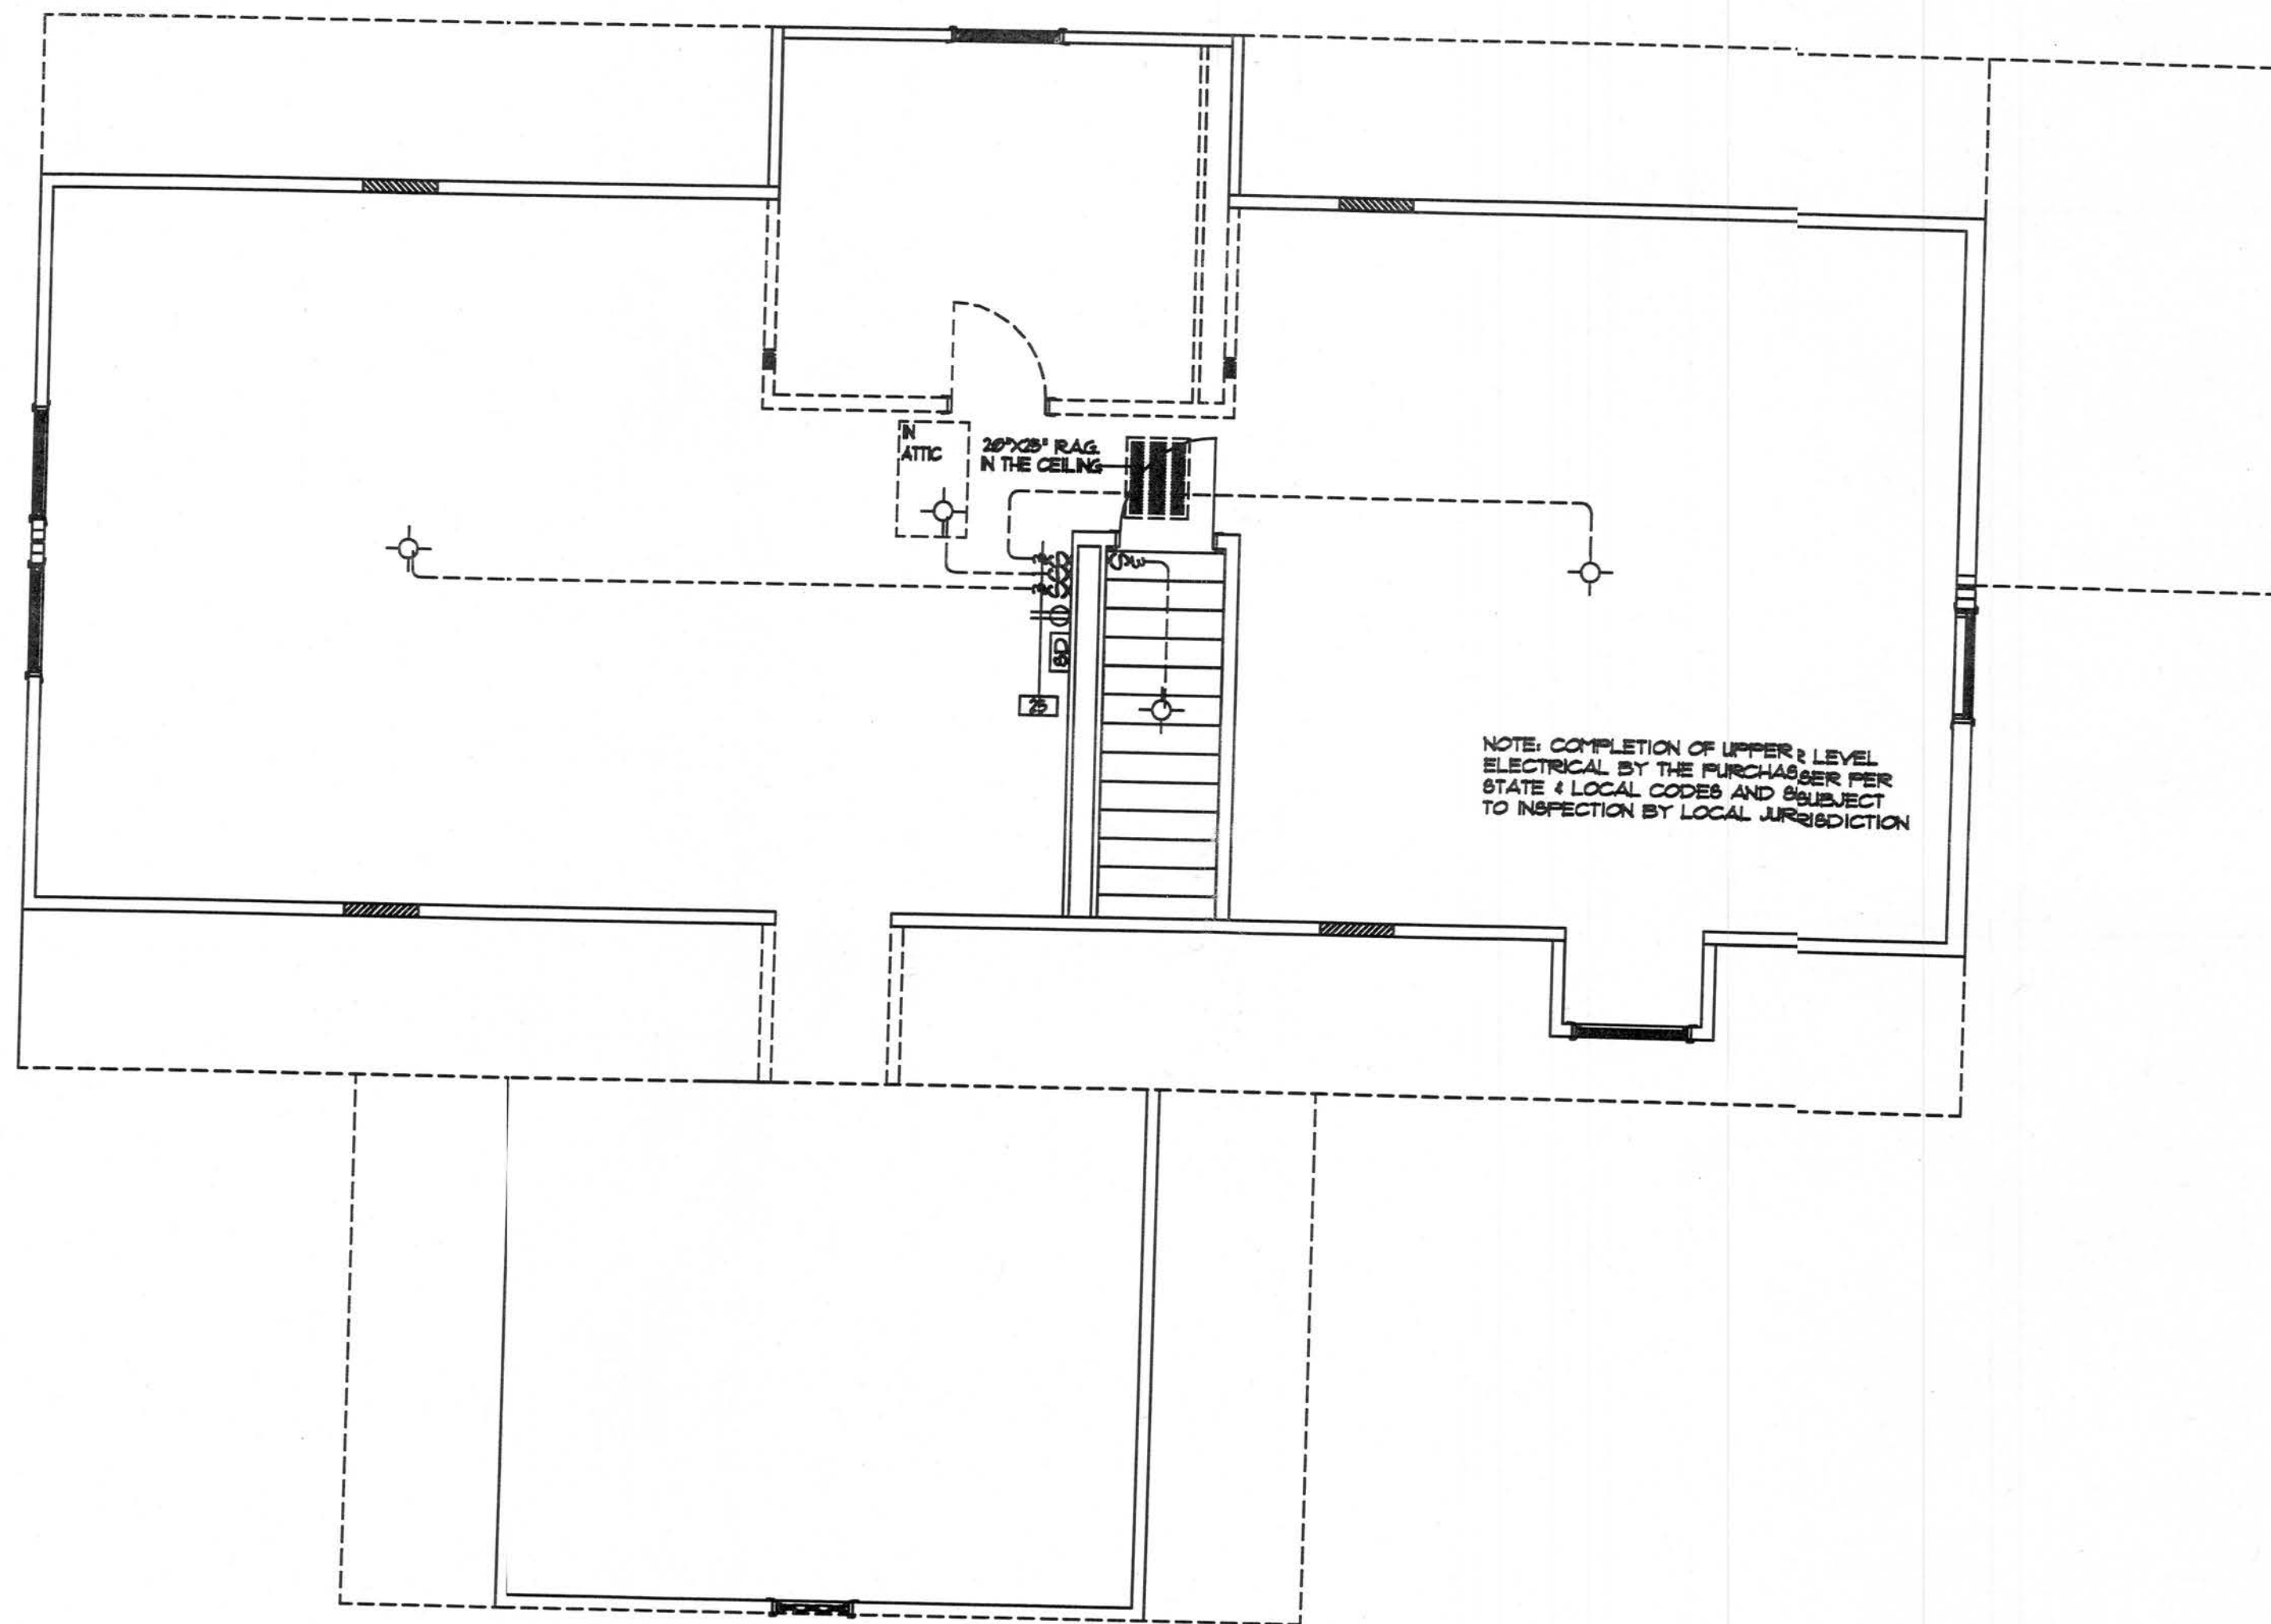

SECOND FLOOR ELECTRICAL LAYOUT
SCALE: 1/4"=1'-0"

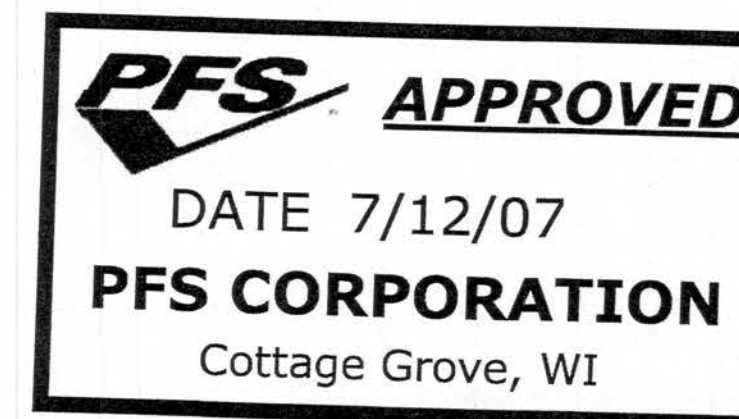

NOTE: ONLY ONE HOUSE MAY BE BUILT UTILIZING THE PLANS THAT ARE DESIGNATED FOR THIS CONTRACT JOB



NATIONWIDE
Custom Homes
P.O. BOX 5311 MARTINSVILLE, VA 24115
1100 RIVES ROAD, MARTINSVILLE, VA 24115
(716) 632-1100
FAX (716) 632-1181
WWW.NATIONWIDECUSTOMHOMES.COM


PLAN NAME: WINSTON			PURCHASER: KENNT HARRISS		
COLLECTION/SERIES: STANDARD / LEGACY			JOB NO: MS-1-07		
DESIGN DATE: 2/2/06	DWG. BY: CR	CHK. BY:	PROCESS DATE: 6-11-07	CONTRACT NO: 91636	
REV. DATE:	REV. BY:		CHANGE ORDER DATE: 06/25/07 CLH	DWG. BY: TODD A	CHK. BY:
REV. DATE:	REV. BY:		PRODUCTION DATE:	7/3/07 (SUB ELL)	
				DWG. BY:	

PAGE NO.
9
OF
46


Handwritten signature and date 7/19/07

3.) MIN. 1" CLEARANCE FROM RANGE
EXHAUST VENT TO COMBUSTIBLE MATERIAL

4.) DUCTLESS RANGE HOOD

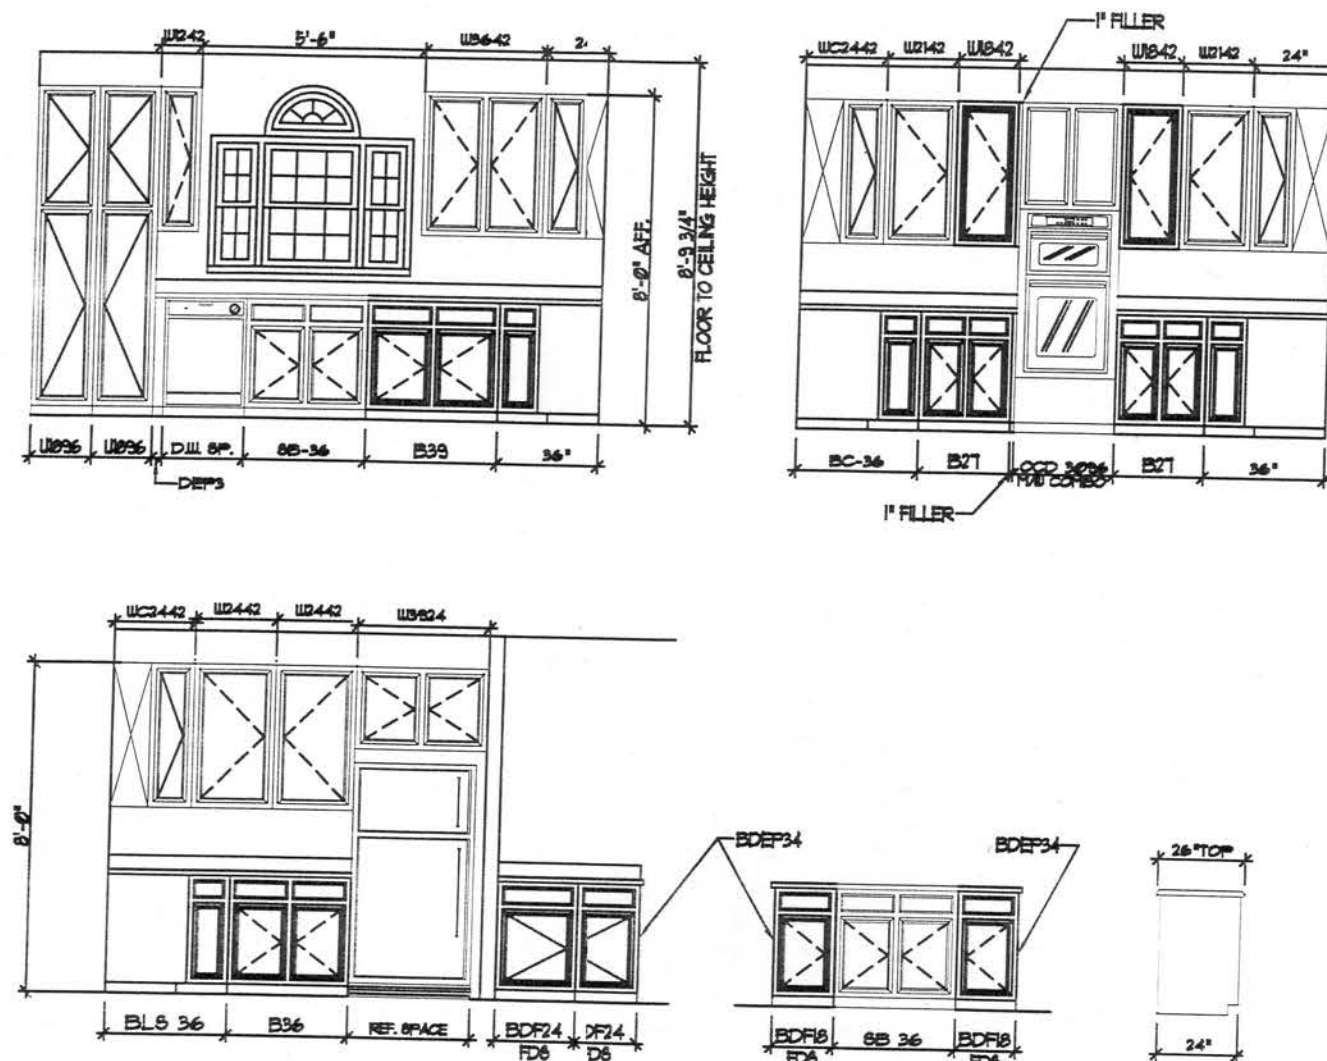

* C-TOPS ATTACHED W/ SCREWS ONLY - NO GLUE

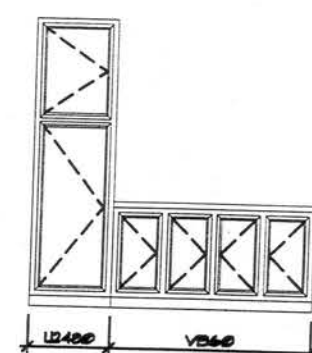

BATH-1



BATH-2

BATH DETAILS

NOTE: ONLY ONE HOUSE
MAY BE BUILT UTILIZING
THE PLANS THAT ARE
DESIGNATED FOR THIS
CONTRACT JOB



NATIONWIDE
Custom Homes
P.O. BOX 551 MARTINSVILLE, VA 24115
1102 RIVERS ROAD, MARTINSVILLE, VA 24115
(276) 632-1100
FAX (276) 632-1181
WWW.NATIONWIDECUSTOMHOMES.COM

PLAN NAME: WINSTON	
COLLECTION/SERIES: STANDARD / LEGACY	
DESIGN DATE: 2/21/06	DWG. BY:
REV. DATE:	REV. BY:
REV. DATE:	REV. BY:


PURCHASER: KENT F. HARRIS			
JOB NO: MS-1-07		CONTRACT NO: 91636	
PROCESS DATE: 6-11-07		DWG. BY: TODD A.	CHK. BY:
CHANGE ORDER DATE: 06/25/07 CLH			
PRODUCTION DATE:		DWG. BY:	

PAGE NO.
10
OF
46

TRAP SIZE	FALL PER FOOT	DISTANCE TO VENT FROM TRAP
1/4"	1/4"	3 FL 6 in.
1/2"	1/4"	5 FL 0 in.
2"	1/4"	6 FL 0 in.
3"	1/4"	10 FL 0 in.
4"	1/8"	12 FL 0 in.

ALL FACTORY INSTALLED PLUMBING TO CONFORM TO:
CURRENT PLUMBING CODE (SEE COVER SHEET)


REFER TO PLUMBING NOTES ON COVER SHEET FOR ADDITIONAL INFORMATION

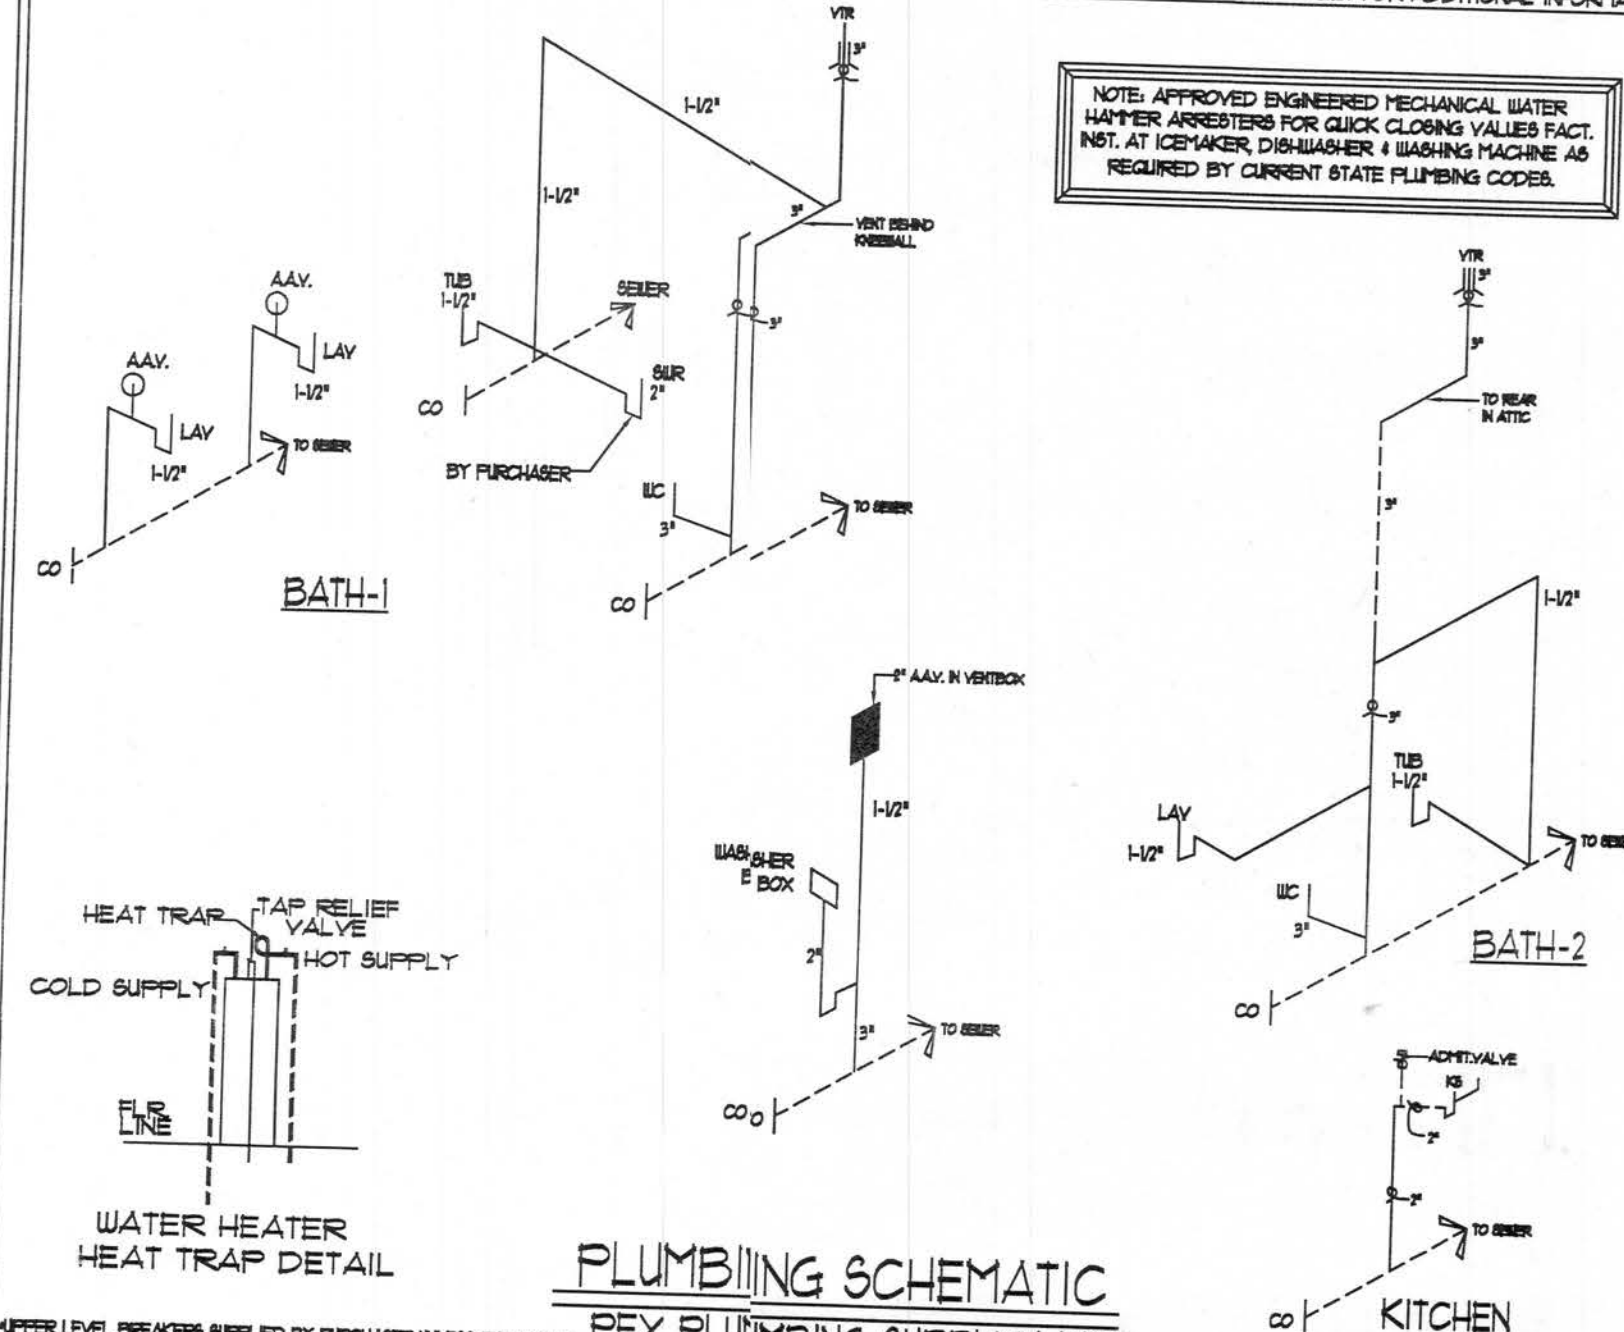

PLUMBING SCHEMATIC

PEX PLUMBING SUPPLY LINE

UPPER LEVEL BREAKERS SUPPLIED BY PURCHASER UNLESS PURCHASED					PEX PLUMBING SUPPLY LINE					
AMP	WIRE SIZE		PANEL SCHEDULE						AMP	WIRE SIZE
			200 AMP MAIN BREAKER		CONNECTION TO SERVICE BY OTHERS					
20	12/2	APCI	BEDROOM-1	1	2	SMALL APPLIANCE			20	12/2
20	12/2	APCI	BEDROOM-2	3	4	SMALL APPLIANCE			20	12/2
20	12/2	APCI	BATH-1	5	6				20	12/2
20	12/3	APCI	SMOKE DETECTOR	7	8	DRYER		240V	30	10/3W
25	10/2	140V	WATER HEATER	9	10	COVEN/MIU		240V	30	10/3W
25	10/2		WATER HEATER	11	12	COVEN/MIU		240V	30	10/3
20	12/2		UTILITY/HALL	13	14	LAUNDRY			20	12/2
20	12/2		DINING/KITCHEN	15	16	DISHWASHER			20	12/2
20	12/2		BATH-2/HALL	17	18	DO/DRAIFT		240V	40	8/3CU
20	12/2		LIVING ROOM	19	20	DO/DRAIFT			40	8/3CU
20	12/2		DEN	21	22	BATH-1 REC.			20	12/2
20	12/2		FOYER	23	24	BATH-2 REC.			20	12/2
20	12/2		GENERAL WIRING (UL)	25	26					
				27	28					
				29	30					
				31	32					
				33	34					
				35	36					
				37	38					
				39	40					

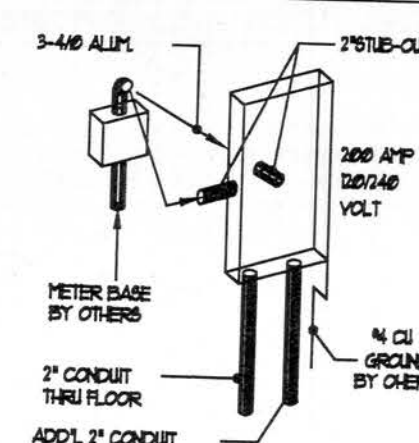

TYP. SERVICE ENTRY INSTALLATION

1) 2" RACEWAY STUBBED TO EXTERIOR PER
PLAN (OR SIDE) OF ELEC. PANEL.
NOTIFY NHI IF PREP FOR UNDERGROUND
SERVICE IS DESIRED.


2) 1/2" 2" CONDUIT DROPPED THRU FLOOR
SITE ELECTRICAL INSTALLATION BY OTHERS.

3) METER BASE BY OTHERS TO BE LOCATED
WITHIN 30" OF ELEC. PANEL STUB-OUT.



4) CHECK LOCAL CODE # POWER CO.
REQUIREMENTS FOR ANY ADDITIONAL
SITE RELATED INSTALLATION.

7/10/07

U:\FLORIDA\WINSTON #91636 KENT HARRISS 191636.dwg, 7/13/2007 2:35:07 PM, Printed by: Eddie Williams

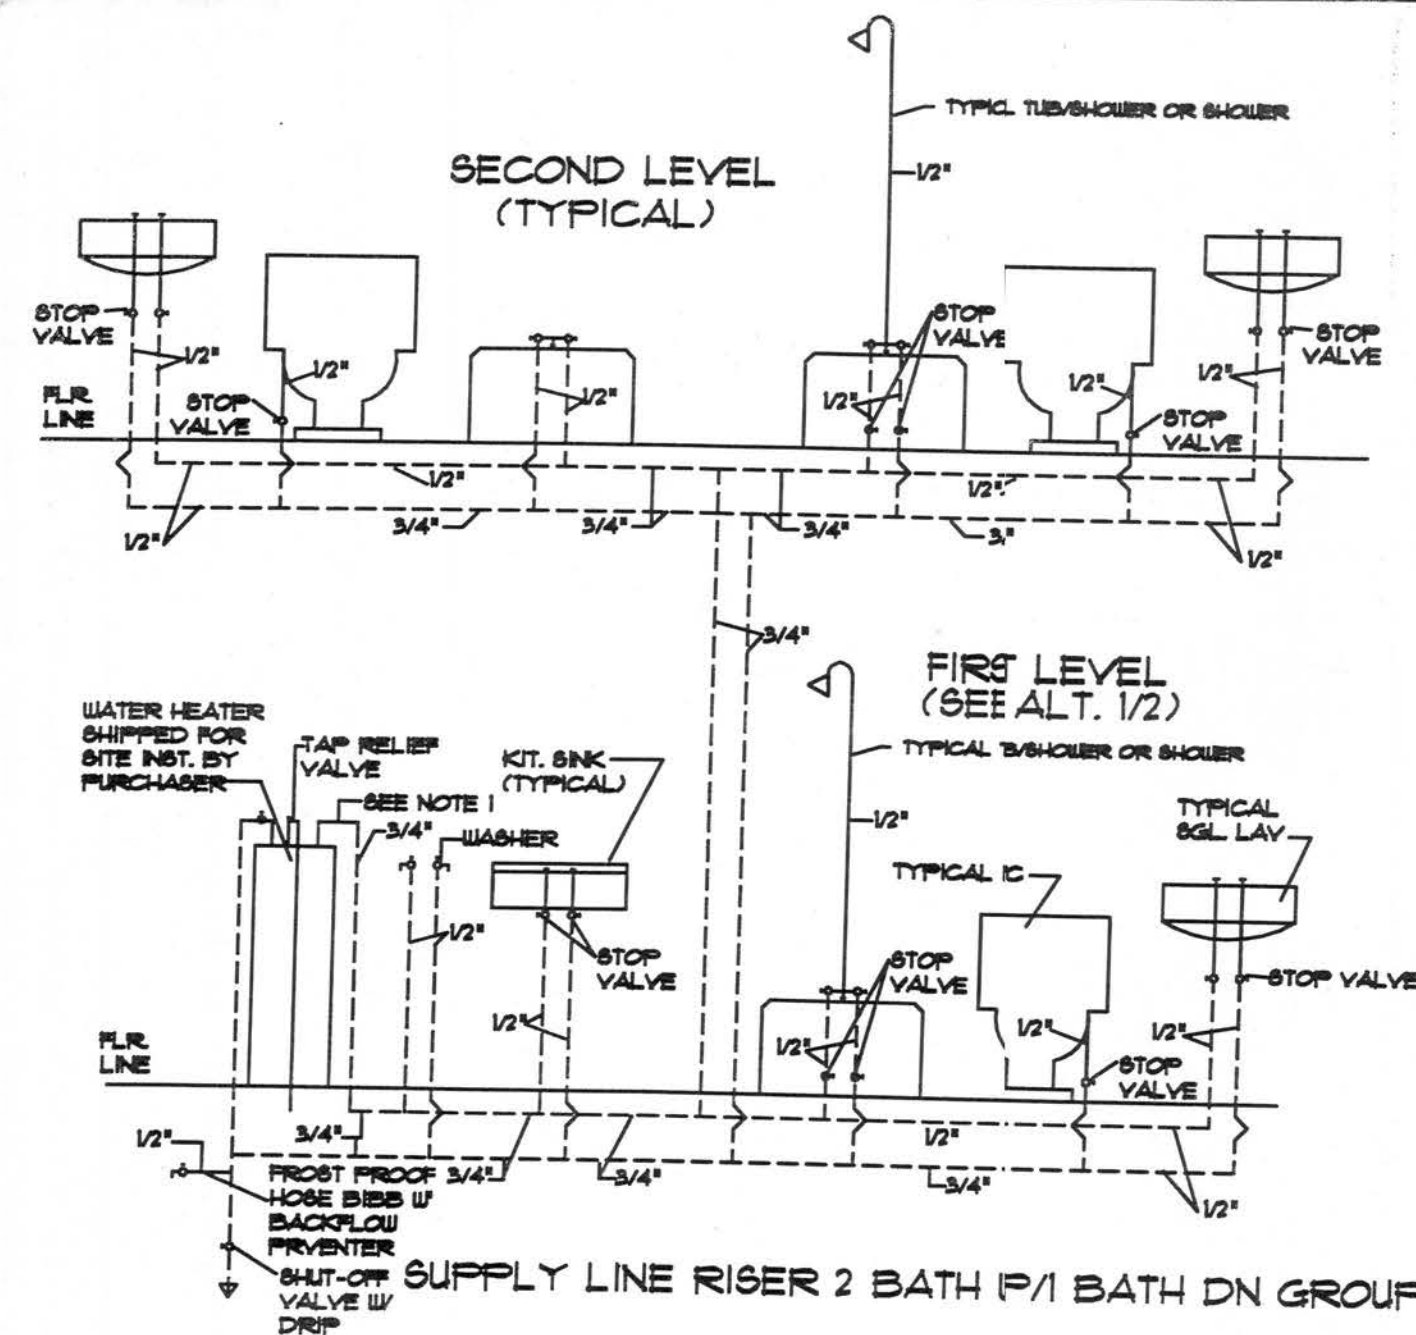

- ### PLUMBING NOTES:
- 1) WATER DISTRIBUTION SYSTEM PIPE SHALL BE COPPER PIPE (STD) SUPPORTED @ 4'-0" INTERVALS.
 - 2) FITTINGS & CONNECTIONS SHALL BE COPPER W/ COPPER COMPRESSION RINGS INST. PER MANUFACTURER'S INSTALLATION INSTRUCTIONS. FIXTURES VALVES SHALL HAVE COMPRESSION CONNECTION FITTINGS INSTALLED PER MANUFACTURER'S INST. INSTRUCTIONS.
 - 3) COPPER SUPPLY LINES TO BE INSTALLED A MINIMUM 18" FROM WATER HEATER OUTLET BEFORE CONNECTION TO "PEX" PIPING.
 - 4) BUILDER TO INSTALL BACKFLOW PREVENTERS ON EXTERIOR AND/OR OTHER FAUCETS WHERE REQ'D BY PLUMBING CODE.
 - 5) BUILDING TO SUPPLY & INSTALL COPPER T & P RELIEF LINE AND EXTEND TO BUILDING EXTERIOR.
 - 6) OVER AREA SUBJECT TO WATER DAMAGE, BUILDER SHALL INST. A 24 GAUGE GALVANIZED METAL DRAIN PAN W/ MIN. 1" DRAIN EXTENDED TO BLDG. BELOW WATER HEATERS.
 - 7) AS DICTATED BY THE SERVIC AVAILABLE, THE BUILDER SHALL INSTALL WATER HAMMER ARRESTORS (AIR CHAMBERS, PRESSURE REDUCING VALVES, ETC) ON THE WATER DISTRIBUTION SYSTEM TO REGULATE THE VELOCITY OF THE FLOW & LESSEN THE HYDRAULIC SHOCK OF QUICK-CLOSING VALVES & FAUCETS.
 - 8) WATER HEATER EQUIPPED W/DIP TUBE TO PREVENT SIPHONING OF WATER FROM TANK BACK INTO WATER SUPPLY LINES.
 - 9) ALL WATER HEATER TANKS SHALL BE EQUIPPED WITH DRAIN COCKS AT BASE OF TANK FOR EMPTYING.
 - 10) ALL SUPPLY LINES TO TERMINATE UNDER FLOOR @ BOTTOM OF FLOOR JOISTS. PURCHASER TO SUPPLY & INSTALL ALL HORIZONTAL SUPPLY LINE MATERIAL AND MAKE ALL CONNECTIONS UNDER FLOOR.
 - 11) MAXIMUM LENGTH OF INDIVIDUAL DISTRIBUTION LINES SHALL NOT EXCEED 60 FT.
- (COPPER PIPING)
- 1A) SUPPLY LINES, FITTINGS & FIXTURE VALVES SHALL BE TYPE "M" COPPER WITH 95/5 SOLDER JOINTS SUPPORTED @ 4'-0" INTERVALS.
- NOTE: MAXIMUM SPACING OF SUPPORTS FOR PVC/DWV DRAIN PIPE: HORIZONTAL: 4'-0" VERTICAL: 10'-0"
- NOTE: FOR PVC 2" DIA OR LARGER - PLUMBING SUPPORT REQUIRED AT MID-STORY FOR 1 1/2 STORY / 2 STORY / OR 2 1/2 STORY STRUCTURES

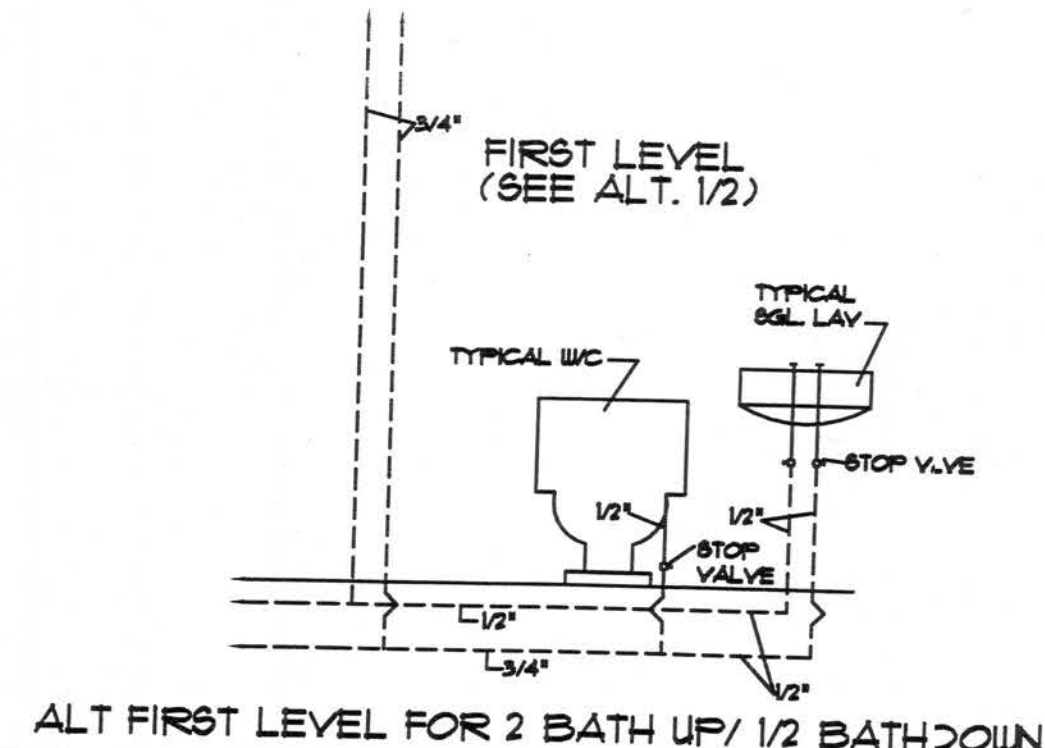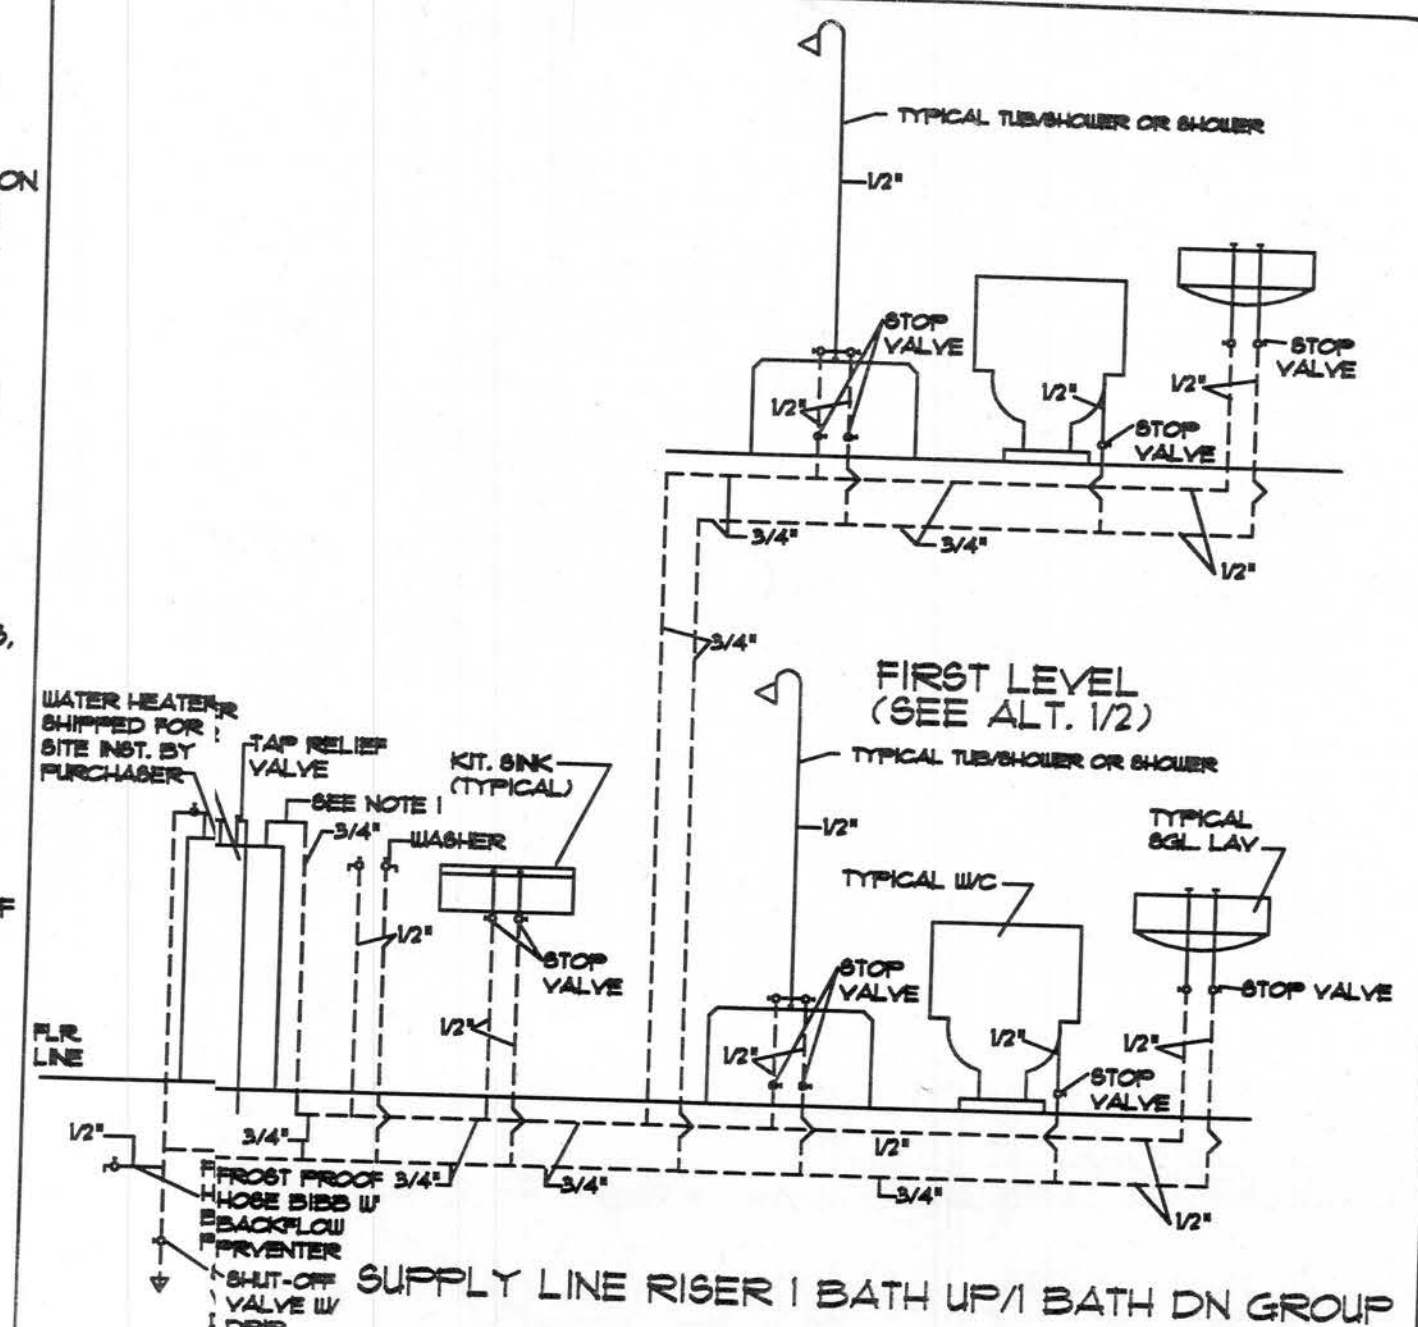

NOTE: ALL LINES BELOW FLOOR JOISTS TO BE BY THE PURCHASER (TYPICAL) SEE #10

NOTE: UNLESS OTHERWISE NOTED, STANDARD WATER HEATER IS 50 GAL. CAPACITY W/ DIMENSIONS OF 50" HGT. AND 20" IN DIA.


NOTE: APPROVED ENGINEERED MECHANICAL WATER HAMMER ARRESTERS FOR QUICK CLOSING VALVES SUPPLIED & SITE INSTALLED BY PURCHASER AS REQUIRED BY CURRENT PLUMBING CODES, SUBJECT TO INSPECTION BY LOCAL JURISDICTION.

NOTE: IF "PEX" PLUMBING OPTION SELECTED, "PEX" PLUMBING FACTORY INSTALLED PER MANUFACTURER'S INSTALLATION INSTRUCTIONS.


NOTE: ONLY ONE HOUSE MAY BE BUILT UTILIZING THE PLANS THAT ARE DESIGNATED FOR THIS CONTRACT JOB



NATIONWIDE
Custom Homes
P.O. BOX 351 MARTINSVILLE, VA. 24115
1100 RIVES ROAD, MARTINSVILLE, VA. 24115
(276) 632-1100
FAX (16) 632-1181
WWW.NATIONWIDECUSTOMHOMES.COM

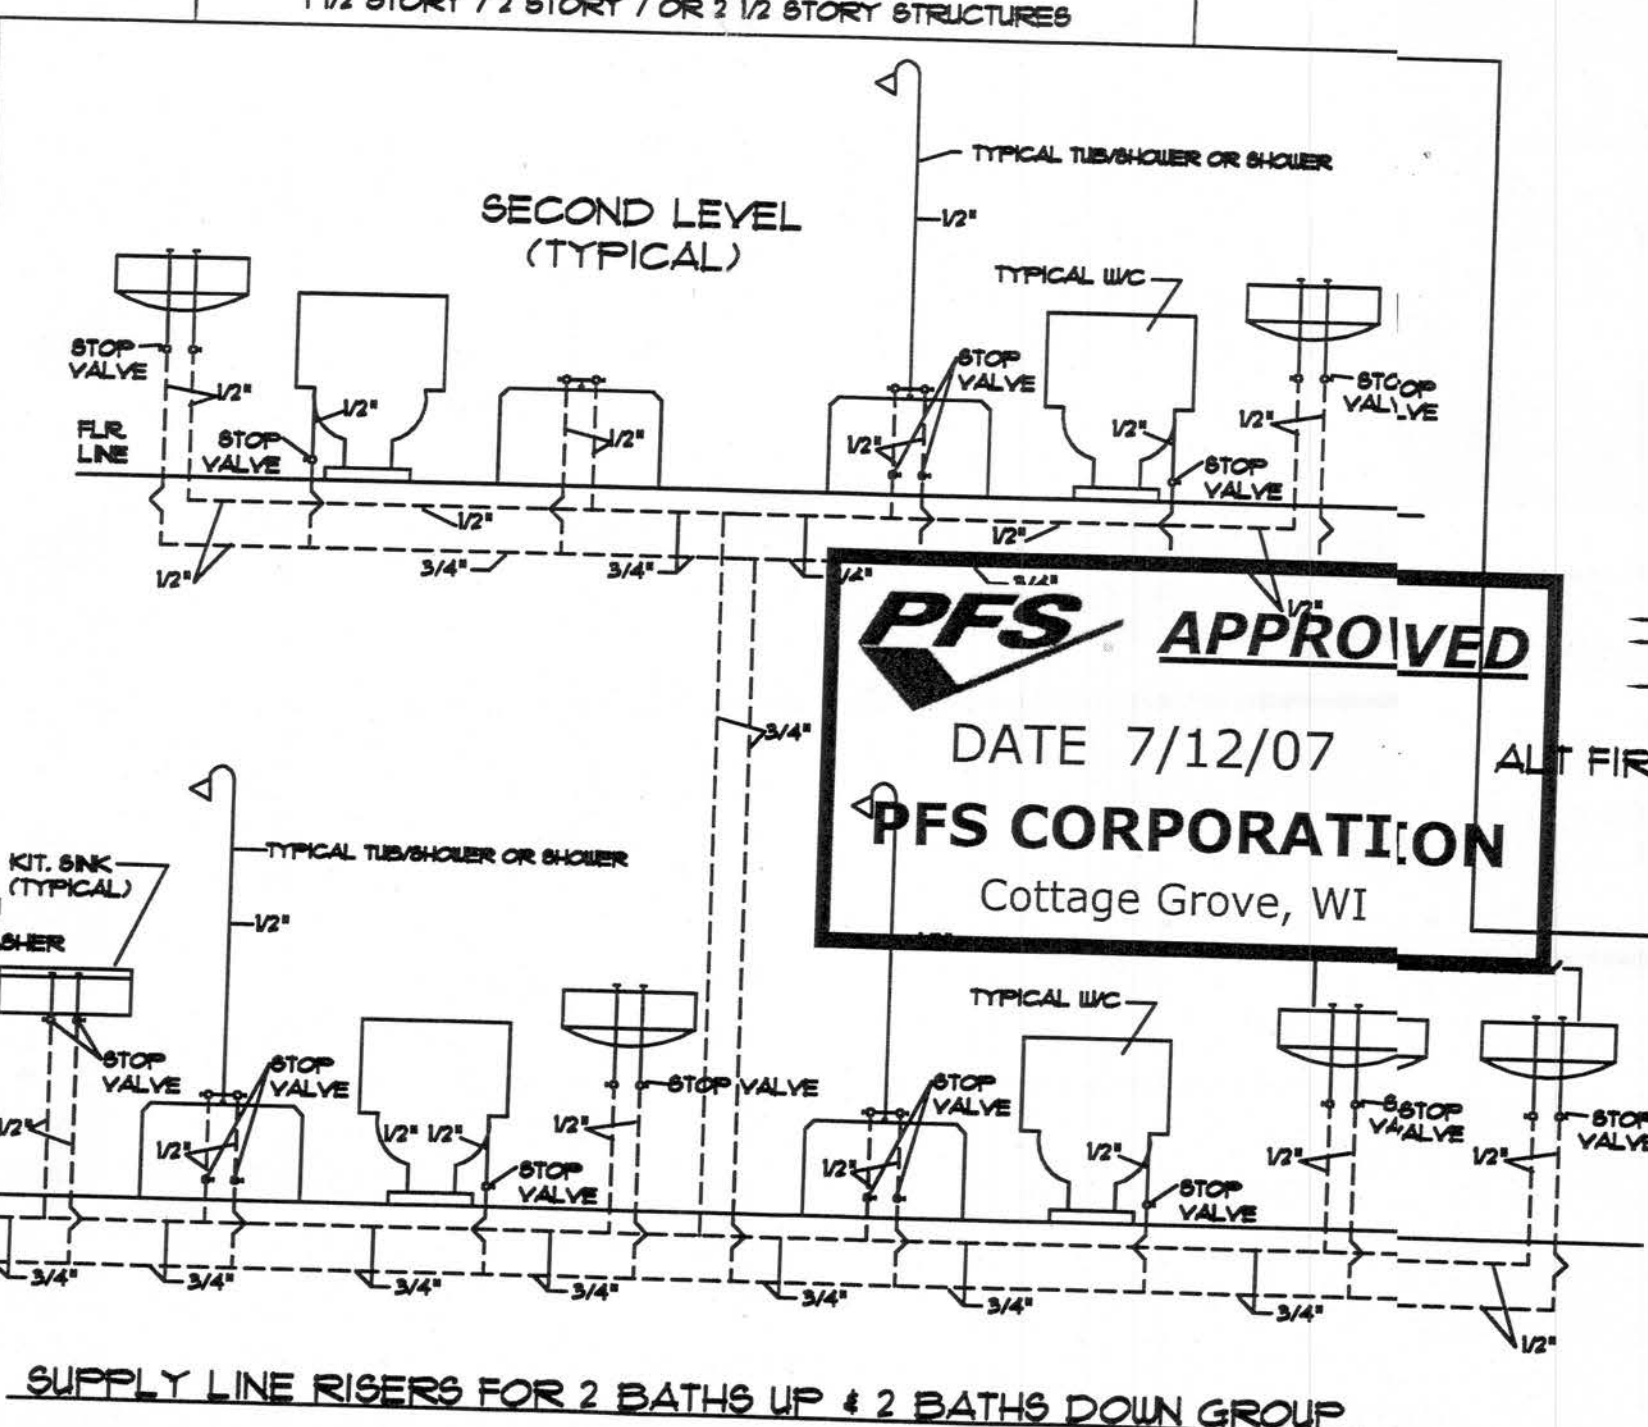

PFS APPROVED
DATE 7/12/07
PFS CORPORATION
Cottage Grove, WI

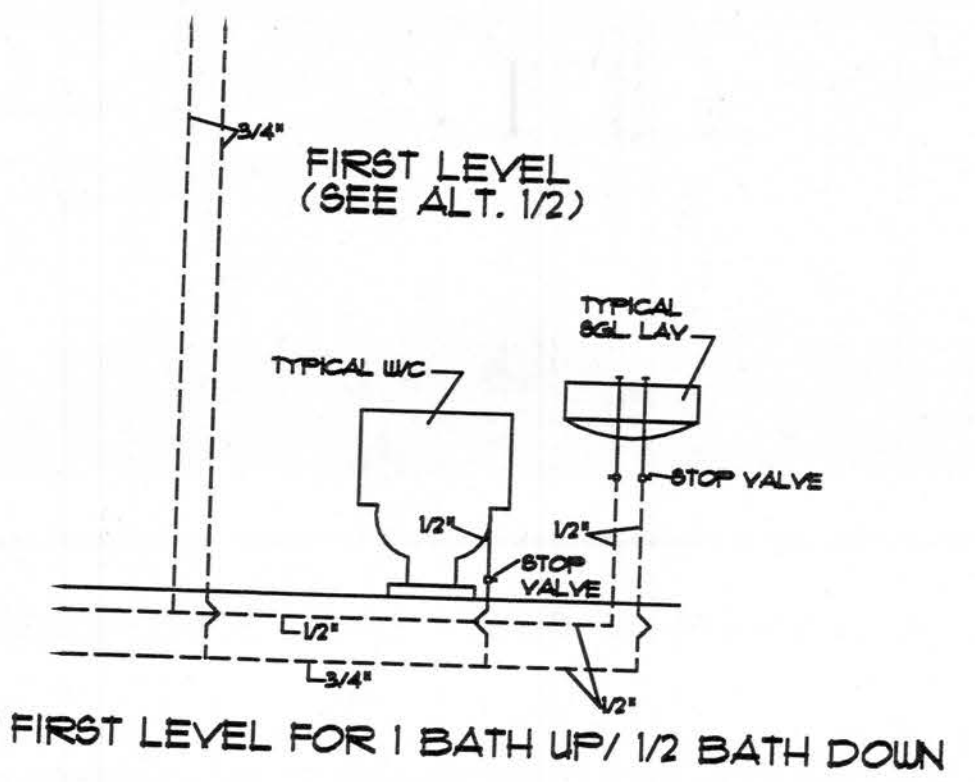



TYPICAL RISER DIAGRAM
for
STACK-ON TWO STORY
or **CAPE**

PLAN NAME: Stack-On / Cape Cod Typical Riser Diagram
COLLECTION/SERIES: ALL
DESIGN DATE: 1/10/04
REV. DATE: 6/10/10
REV. DATE: 7/15/03

PURCHASER:
JOB NO.:
CONTRACT NO.:
PROCESS DATE:
CHANGE ORDER DATE:
DESIGNATION DATE:



PAGE NO.
11
OF
46

Handwritten signature and date: 7/9/07

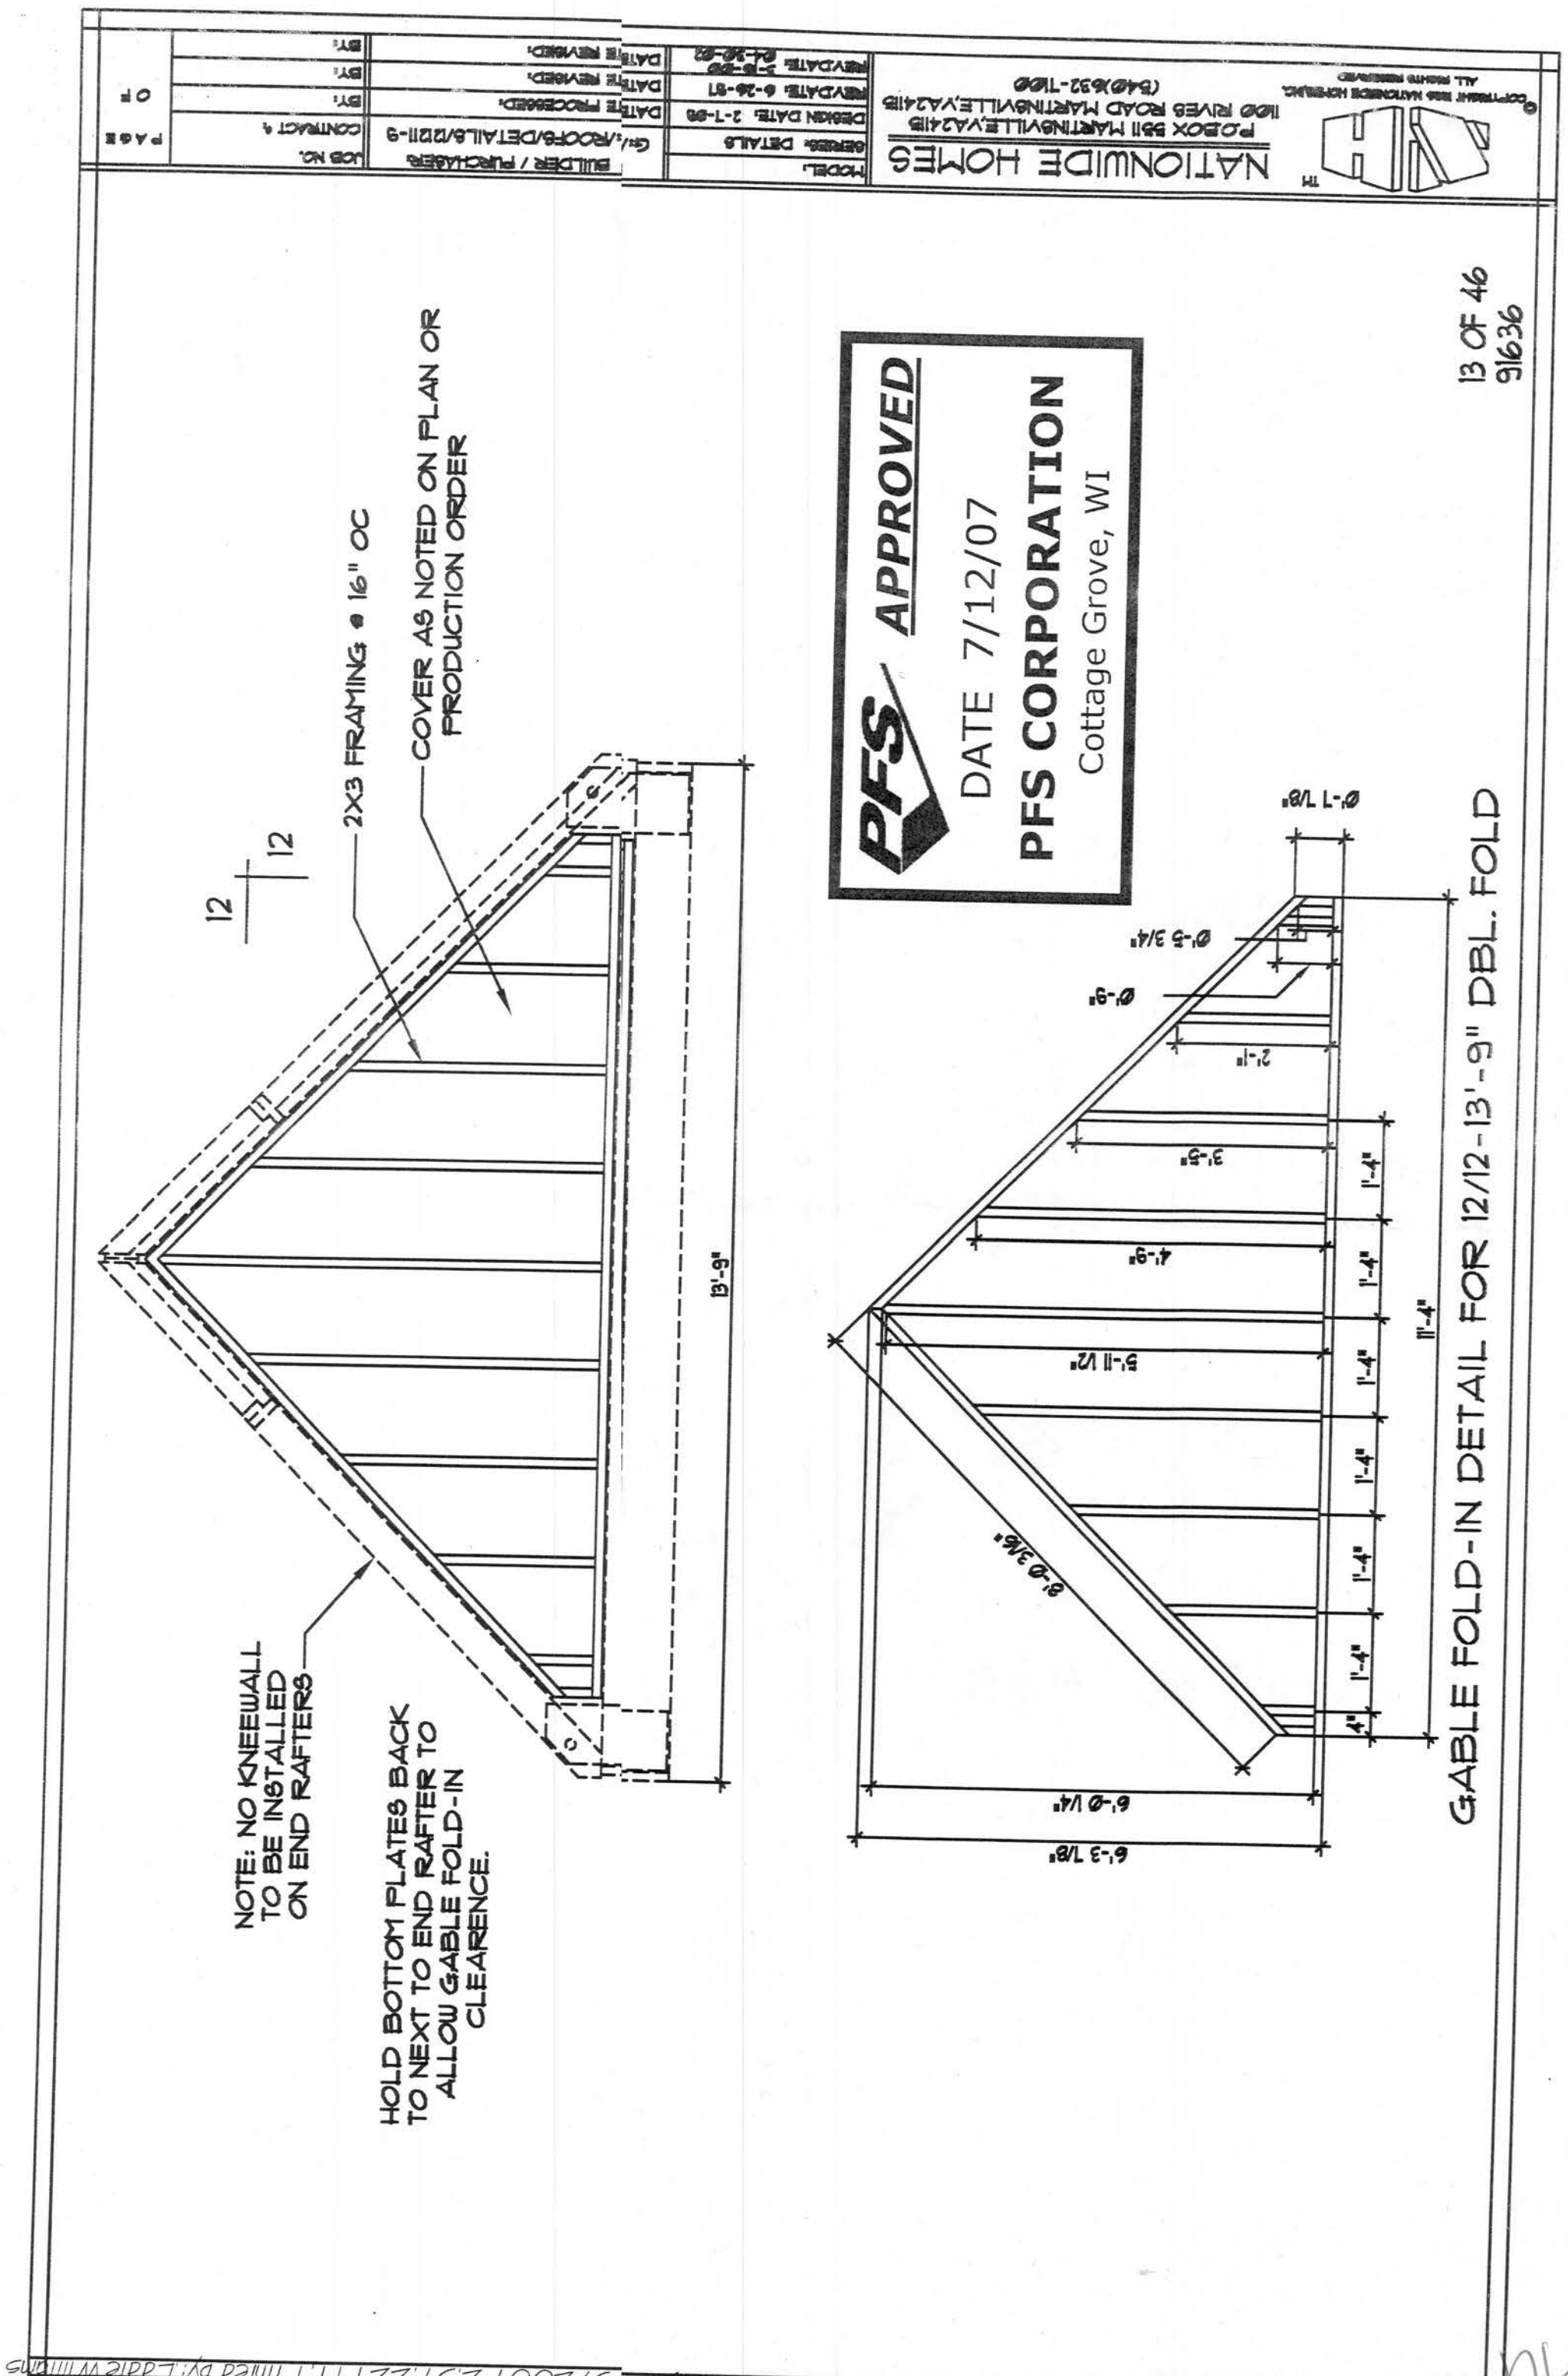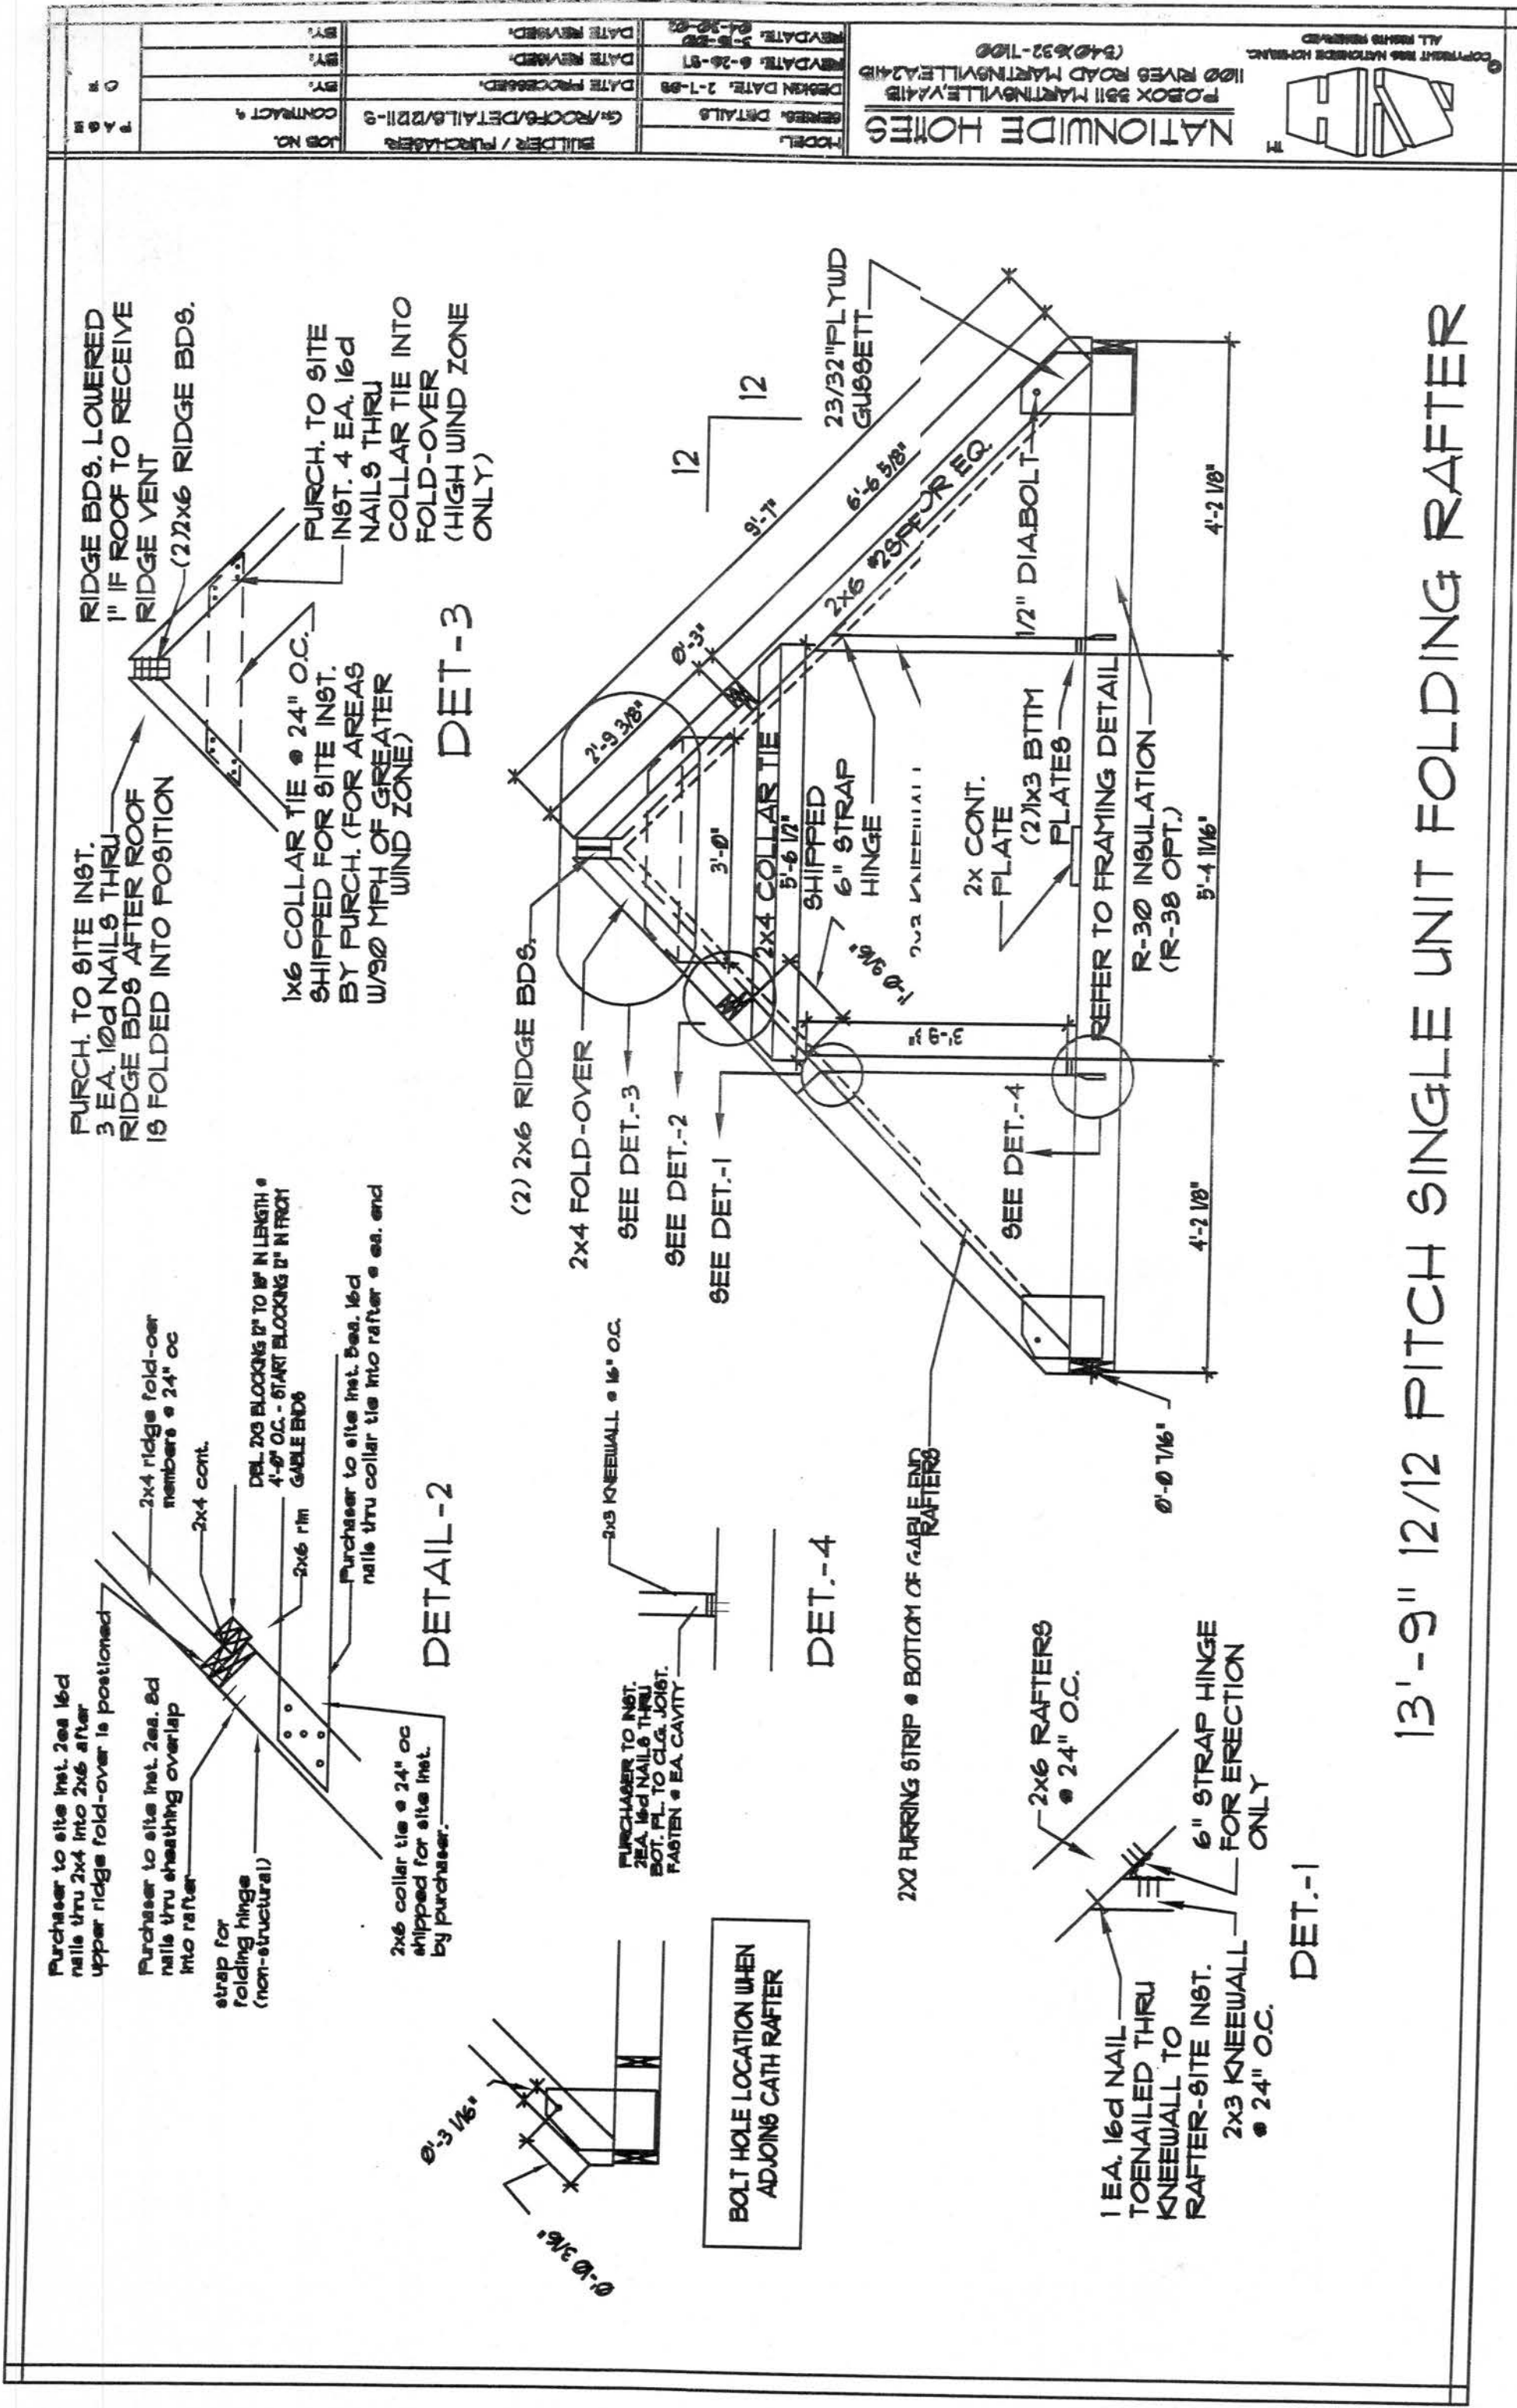


PFS APPROVED
 DATE 7/12/07
PFS CORPORATION
 Cottage Grove, WI

U:\FLORIDA\WINSTON #91636 KENT HARRISS 9/16/06.dwg, 7/13/2007 3:18:48 PM, Printed by: Eddie Williams

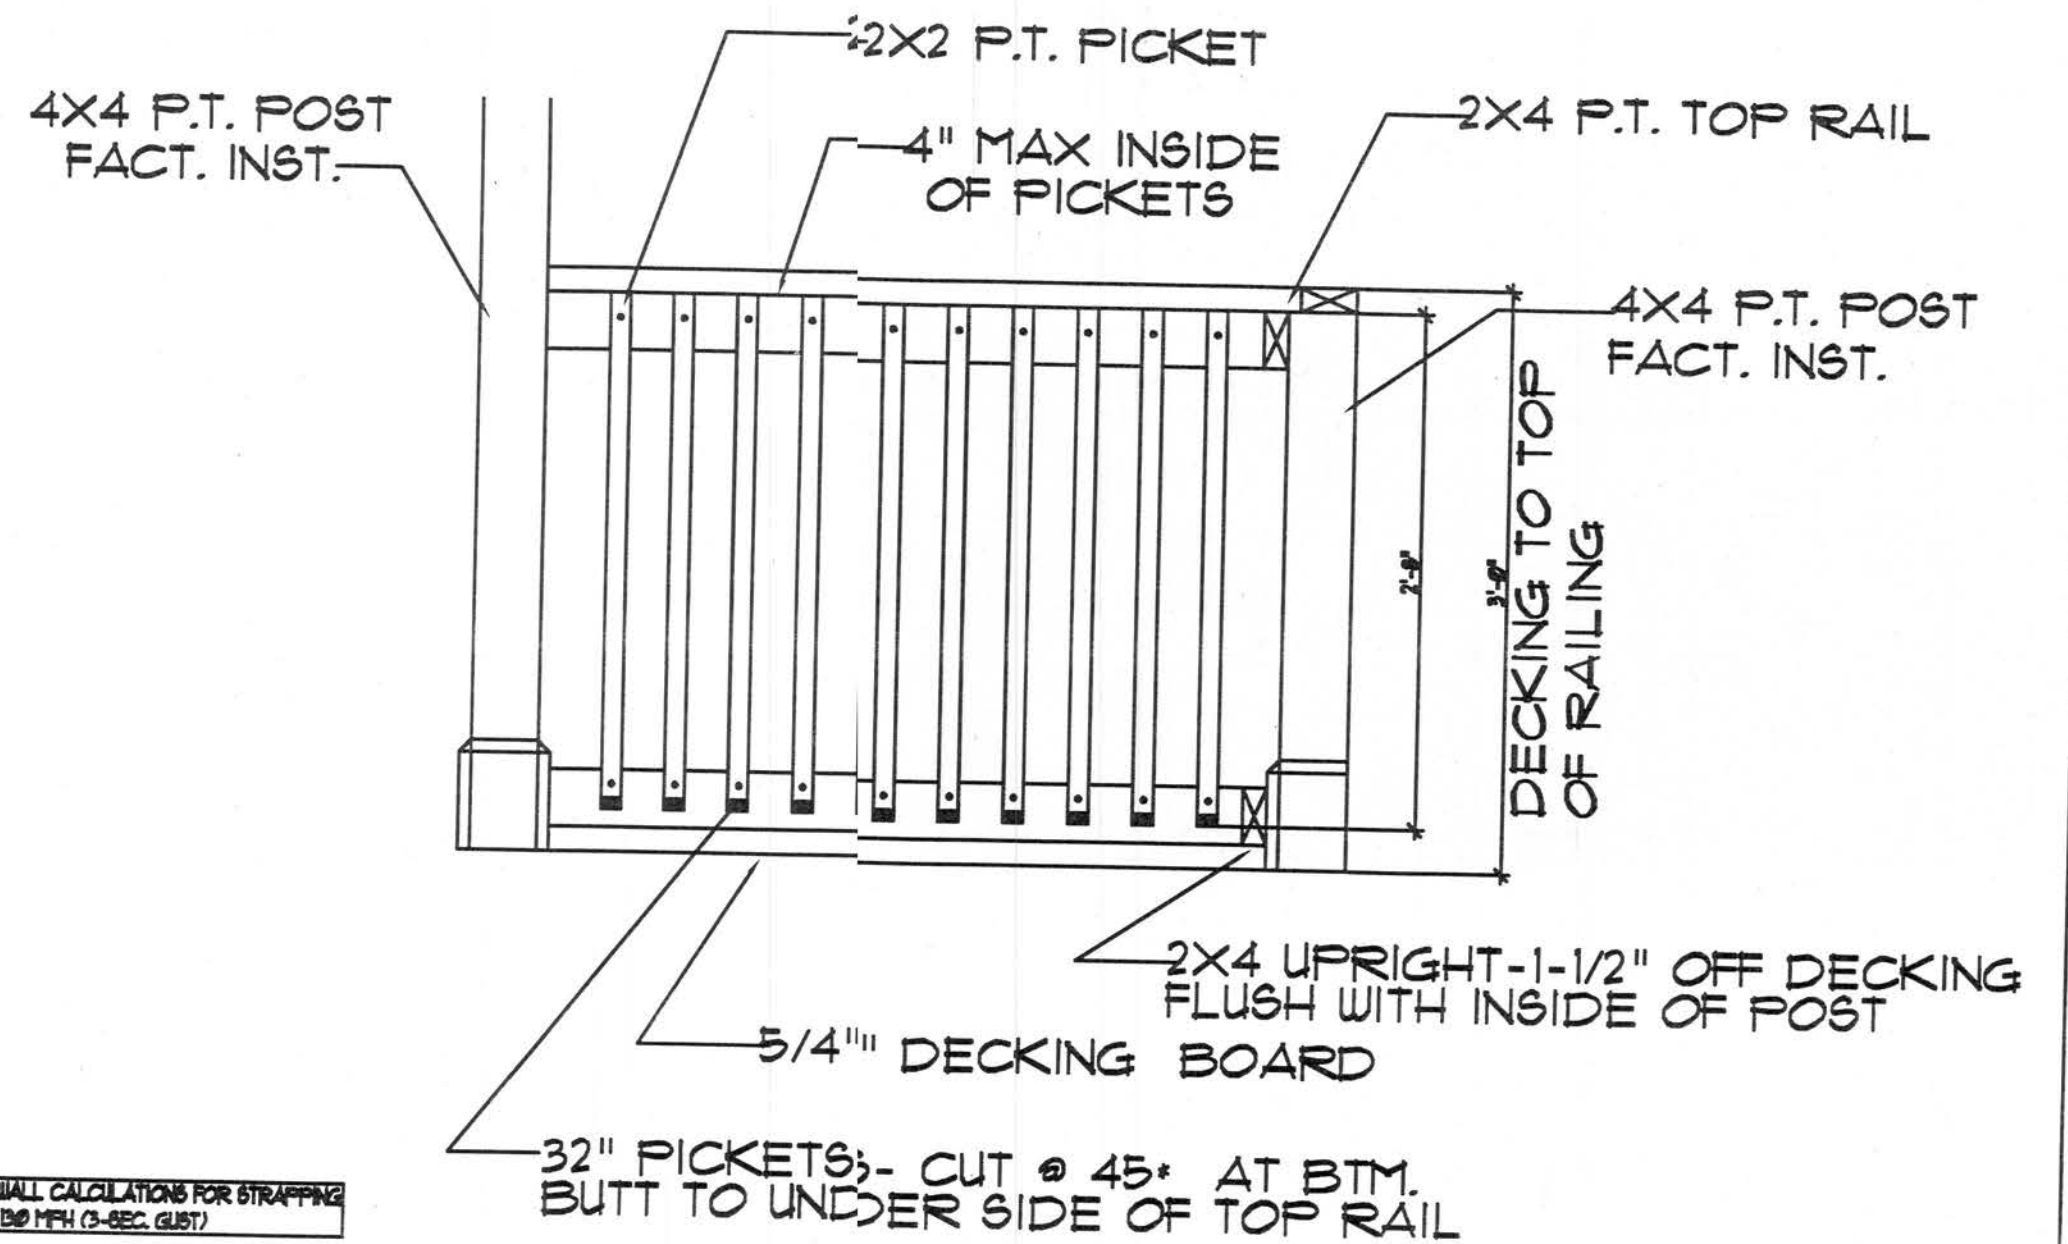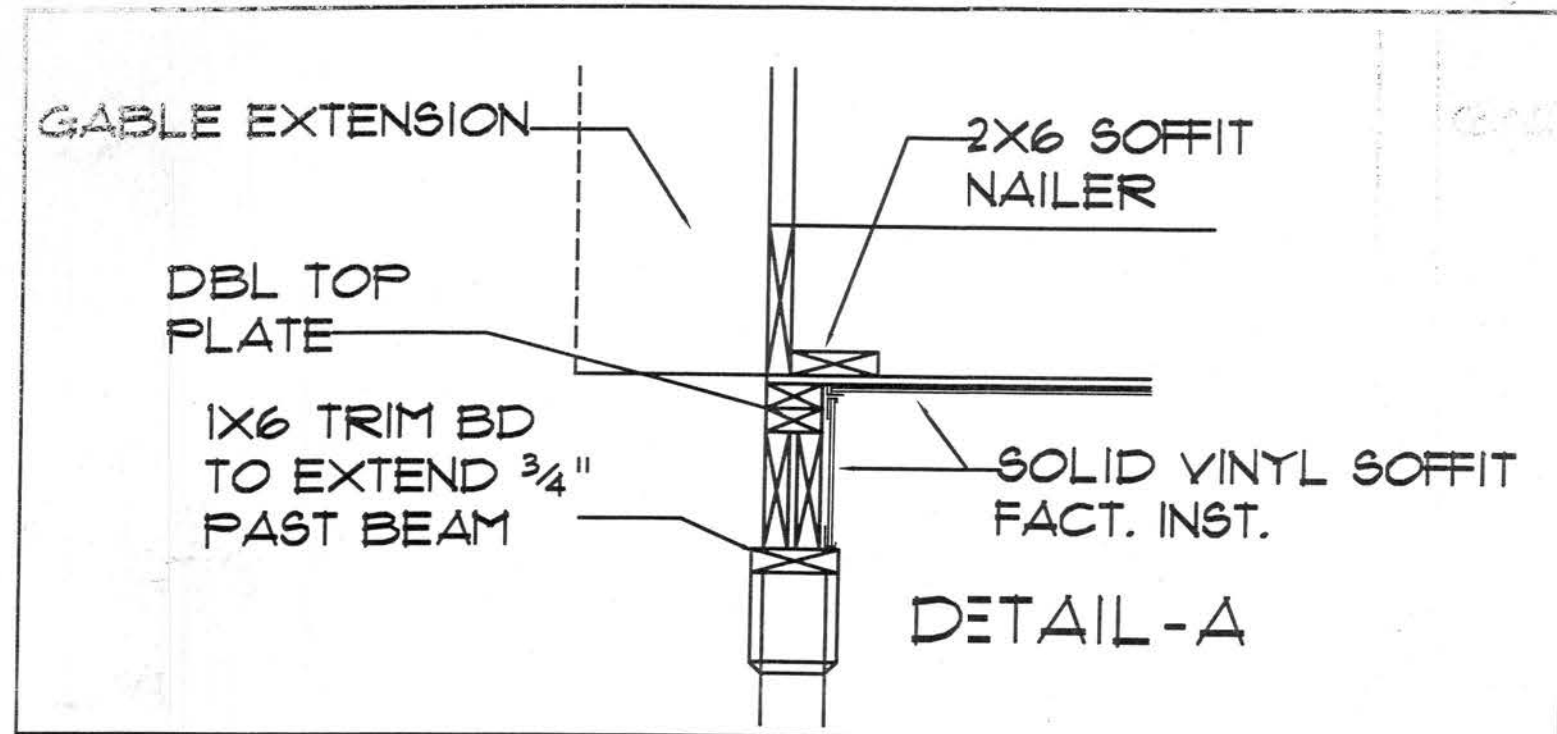


REFERENCE BEAR WALL CALCULATIONS FOR STRAPPING
REQUIREMENTS FOR DBO MPH (3-SEC. GUST)

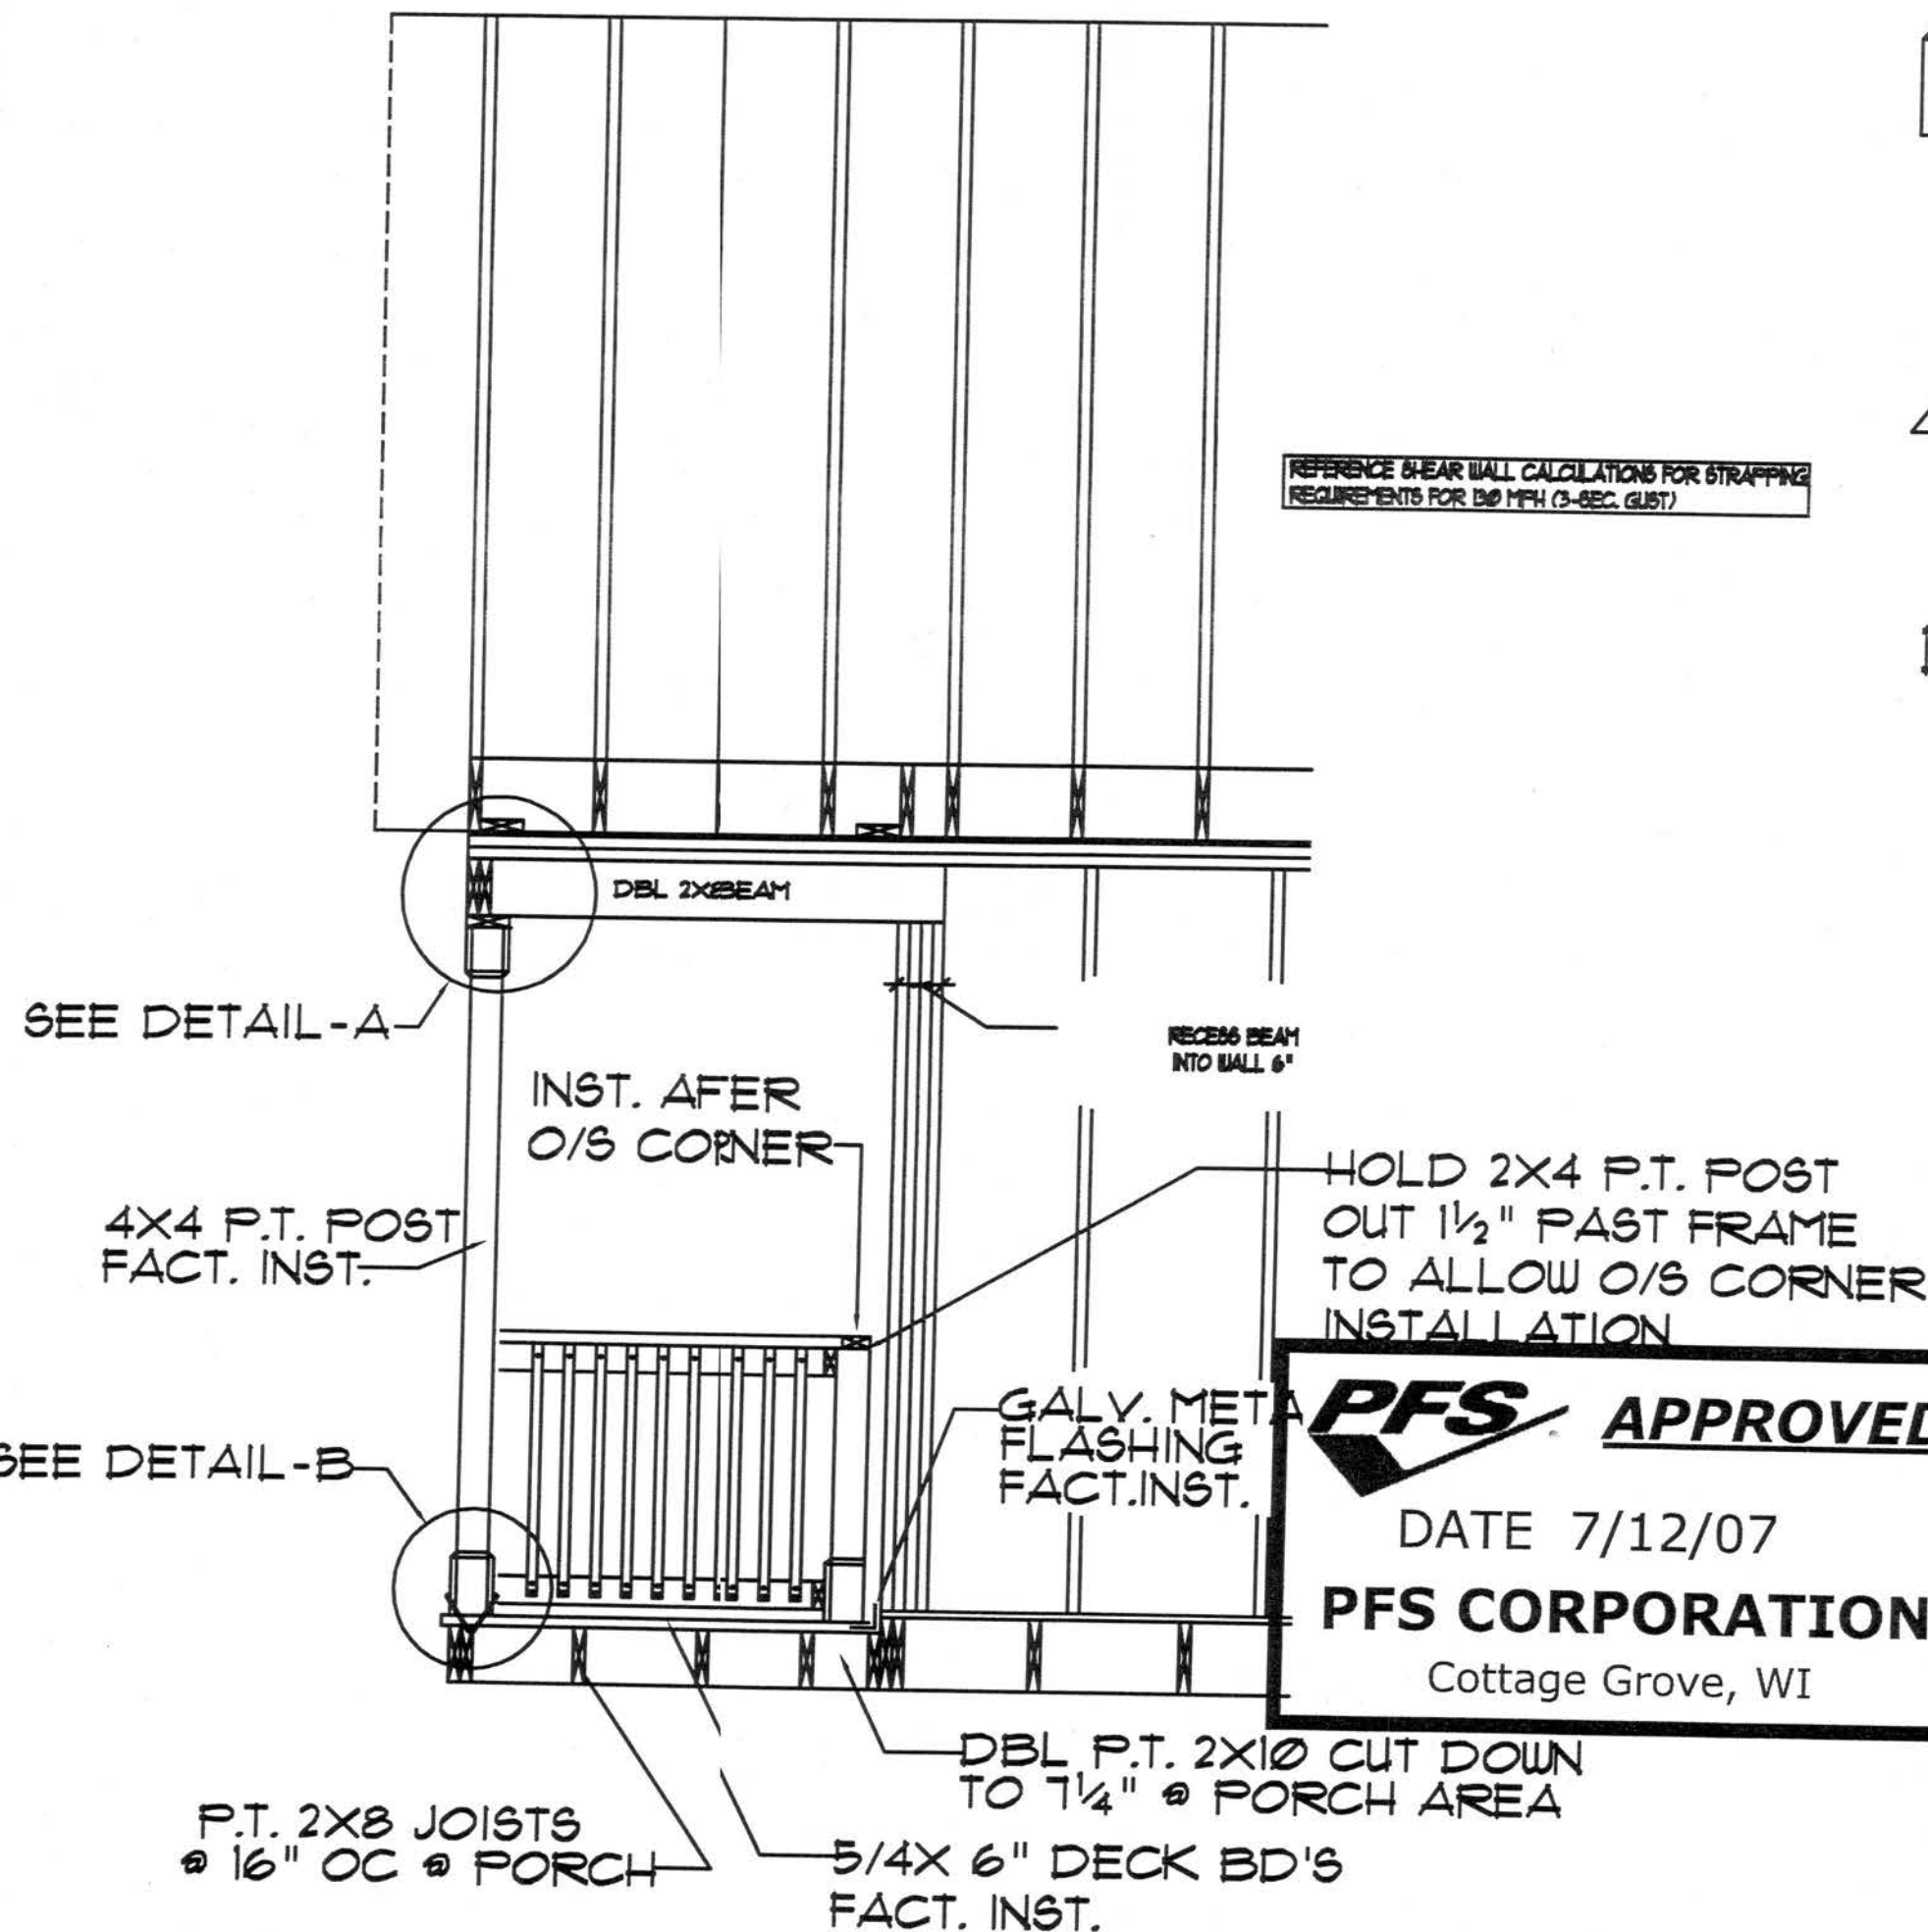


DECK BOARD INST. PROCEDURE


INSURE ALL DECKING BOARDS WITH THE
GRAIN CUPPED TO THE FLOOR JOIST
PRIOR TO FASTENING WITH GALV. SCREWS
2 SCREWS PER EACH BD. - EA. JOIST- AS SHOWN
DECK BOARDS TO EXTEND 1\"/>

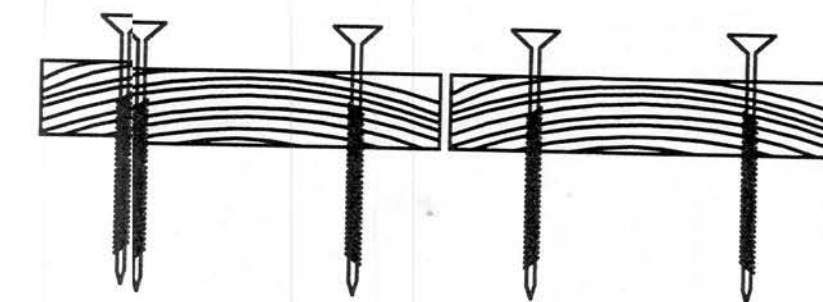

4EA. 3\"/>

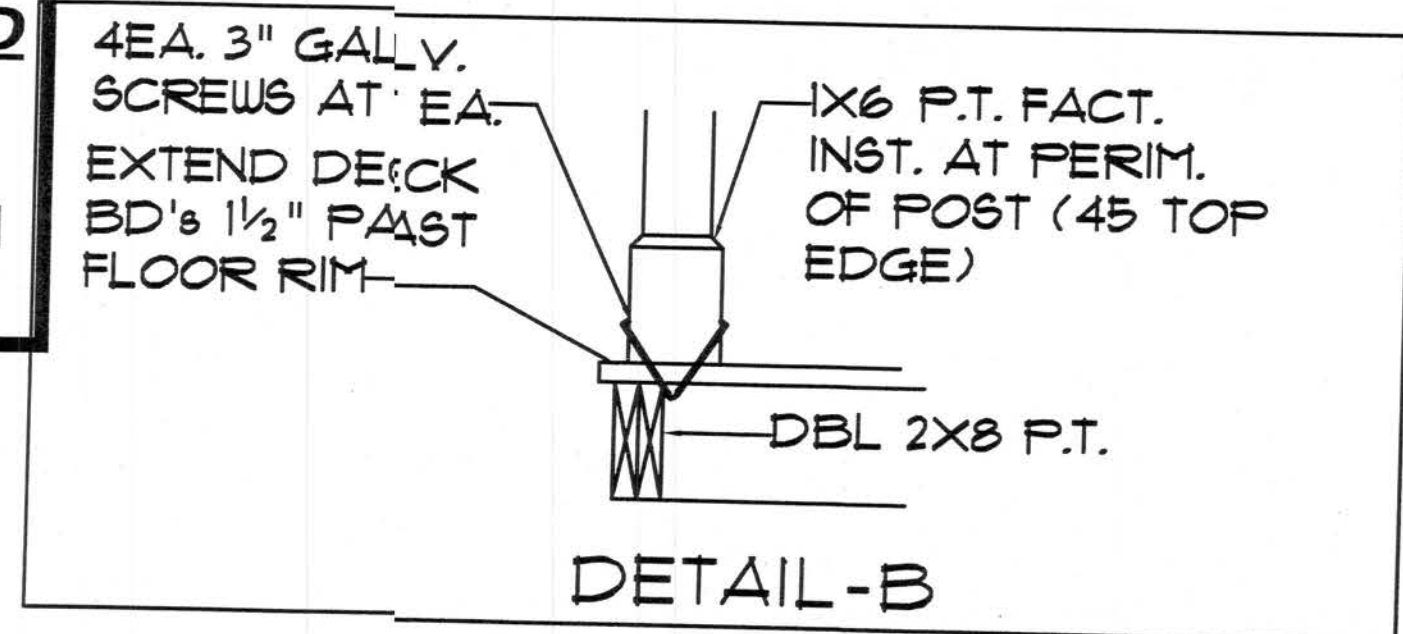

NOTE: ONLY ONE HOUSE
MAY BE BUILT UTILIZING
THE PLANS THAT ARE
DESIGNATED FOR THIS
CONTRACT JOB

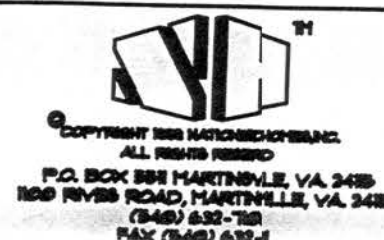

**NATIONWIDE
HOMES**
Web Site: www.nationwide-homes.com

PLAN NAME: STANDARD FACT. INST. PORCH PROCEDURE

COLLECTION:

DESIGN DATE: 9 JAN 02

REV. DATE:

REV. DATE:

DRG. BY: DDC

REV. BY:

REV. BY:

CK BY:

PURCHASER:

JOB NO.

CONTRACT NO.

PROCESS DATE:

ORDER REVISION DATES:

REVISION DATE

PAGE NO.

15

OF

46

Handwritten signature and date: 7/10/07

2x4 FRAMING (TYPICAL)

3'-1 1/2"

2x10 HEADER

TURN 2852 WINDOW SHIFTED LOOSE

8'-4 1/2"

8'-0 1/2"

1'-0 1/4"

2'-0 1/4"

3'-0"

2'-0 1/4"

8'-4 3/4"

8'-4 3/4"

INSTALL EXTERIOR SHEATHING ON PREBUILT WALLS


EXTEND WALL SHEATHING

Technical drawing of a roof structure showing dimensions and construction details. The drawing includes the following labels and dimensions:

- 2x4 FRAMING (TYPICAL)**: Label pointing to the top horizontal framing members.
- FILL CORNER SOLID W/ 2x6**: Label pointing to the corner area where the roof meets the wall.
- INSTALL EXTERIOR SHEATHING ON PREBUILT WALLS**: Label pointing to the exterior wall structure.
- Dimensions**:
 - Top horizontal dimensions: $T-8\ 1/4"$ and $T-3\ 3/16"$.
 - Vertical dimensions on the right: $T-4\ 3/16"$ and $T-8\ 1/4"$.
 - Diagonal dimensions: $12'-0\ 3/4"$ and $12'-0\ 3/4"$.
 - Internal vertical dimensions: $1'-1\ 1/8"$, $3'-3\ 1/8"$, $4'-1\ 1/8"$, and $4'-1\ 1/8"$.
 - Bottom horizontal dimension: $T-8\ 1/4"$.

[illegible]


REFERENCE SHEAR WALL CALCULATIONS FOR STRAPPING
REQUIREMENTS FOR 130 MPH (3-SEC. GUST)

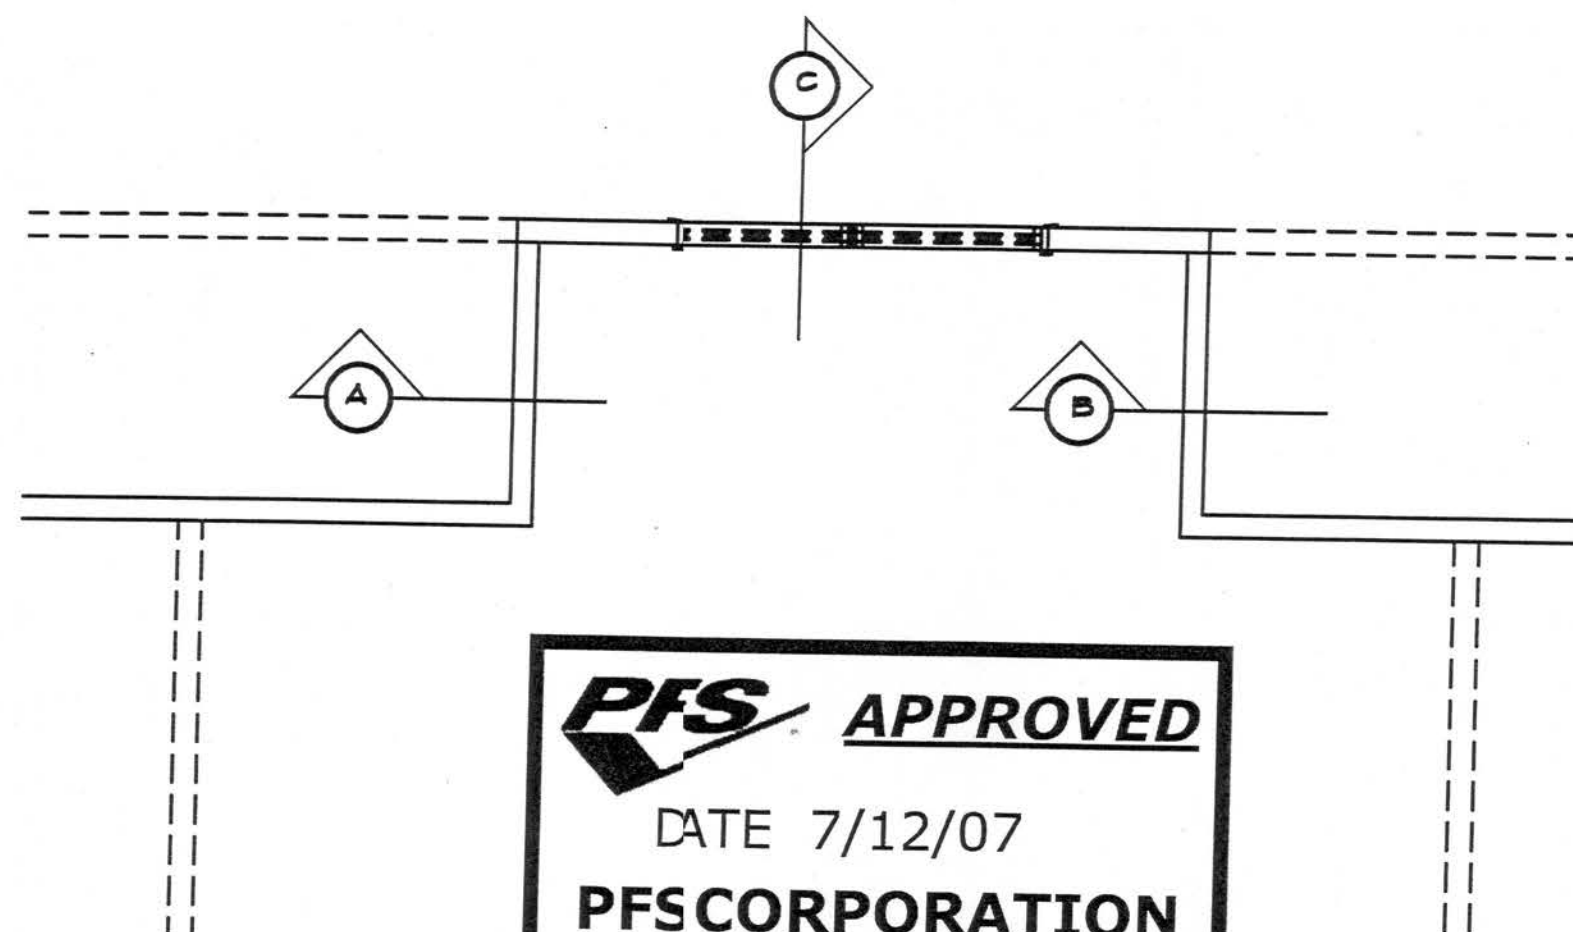

SHED DORMER DETAIL

N.T.S.

PREBUILT WALLS SHIPPED LOOSE

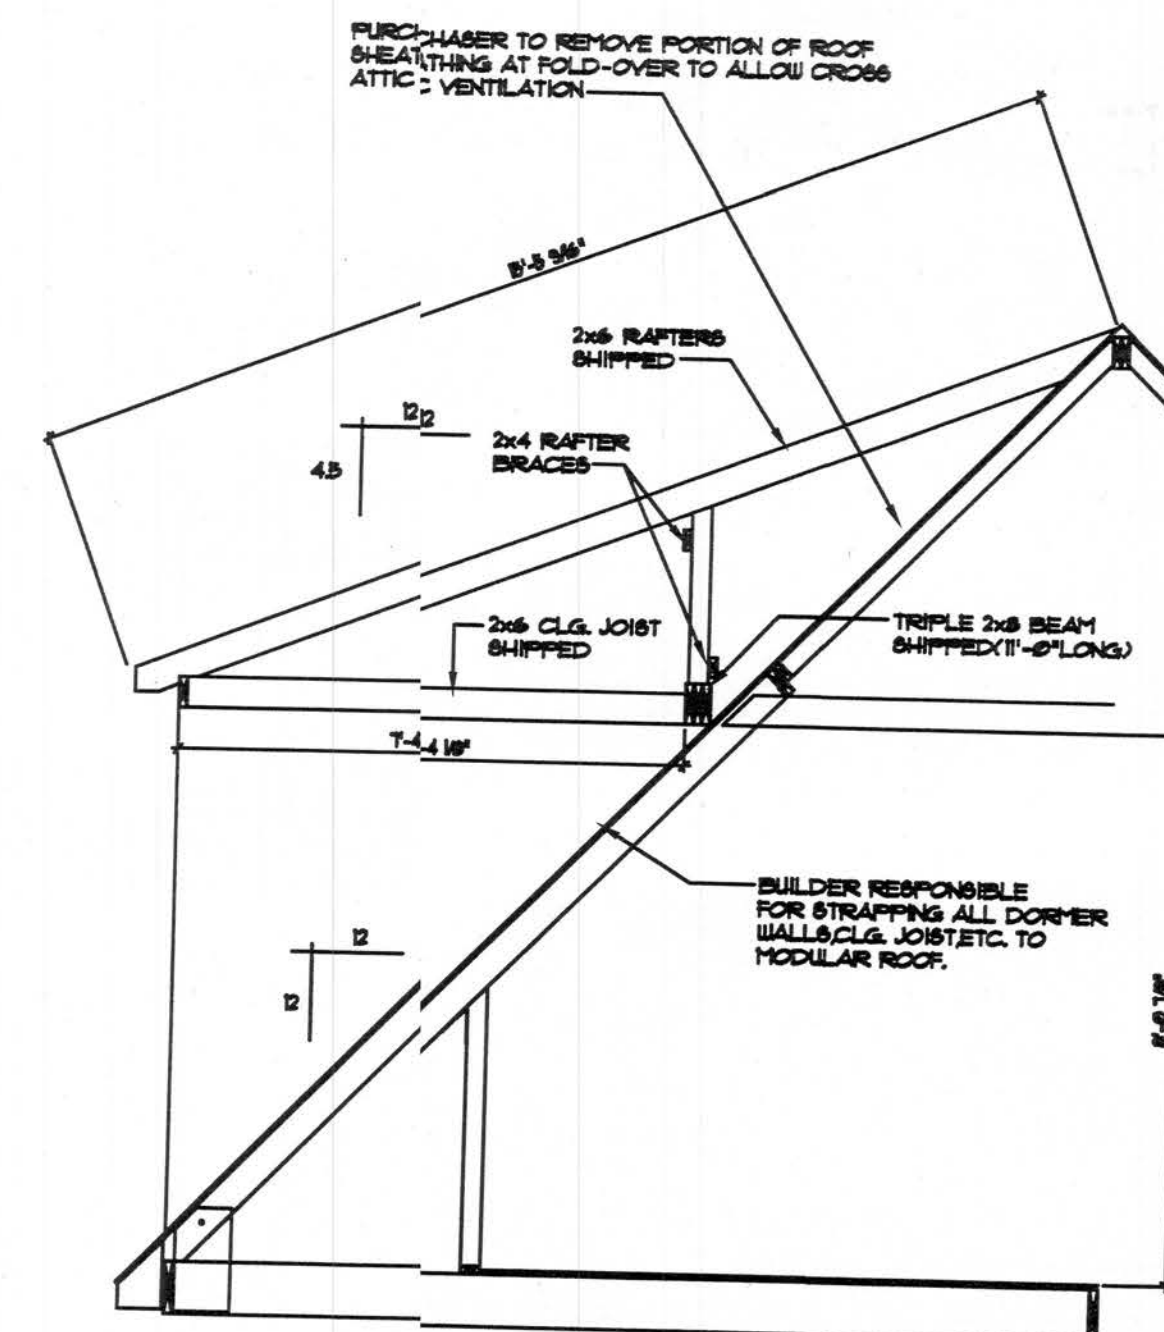

SECTION



NATIONWIDE HOMES

MAILING ADDRESS & PLANT LOCATIONS:
P.O. BOX 3511 MARTINSVILLE, VA 24115
1100 RIVES ROAD MARTINSVILLE, VA 24115
(340) 632-1100
FAX (340) 632-1101

PLAN NAME:
SERIES:
DESIGN DATE:
REV. DATE:

BY:	BUILDER / PURCHASER:
-----	----------------------

CONTRACT NO.	
--------------	--

	PROCESS DATE
--	--------------

REV.
DATE:

	PLANS
--	--------------

	DRAIN BY:
	IN LINE

PLANS CHECKED BY:	DATE:
----------------------	-------

JOB NO.	
--	--


[illegible]

PAGE NO.
16

Q


9/6/36 46

12/12 PITCH-28' WIDE
GABLE WALL FRAMING DETAIL

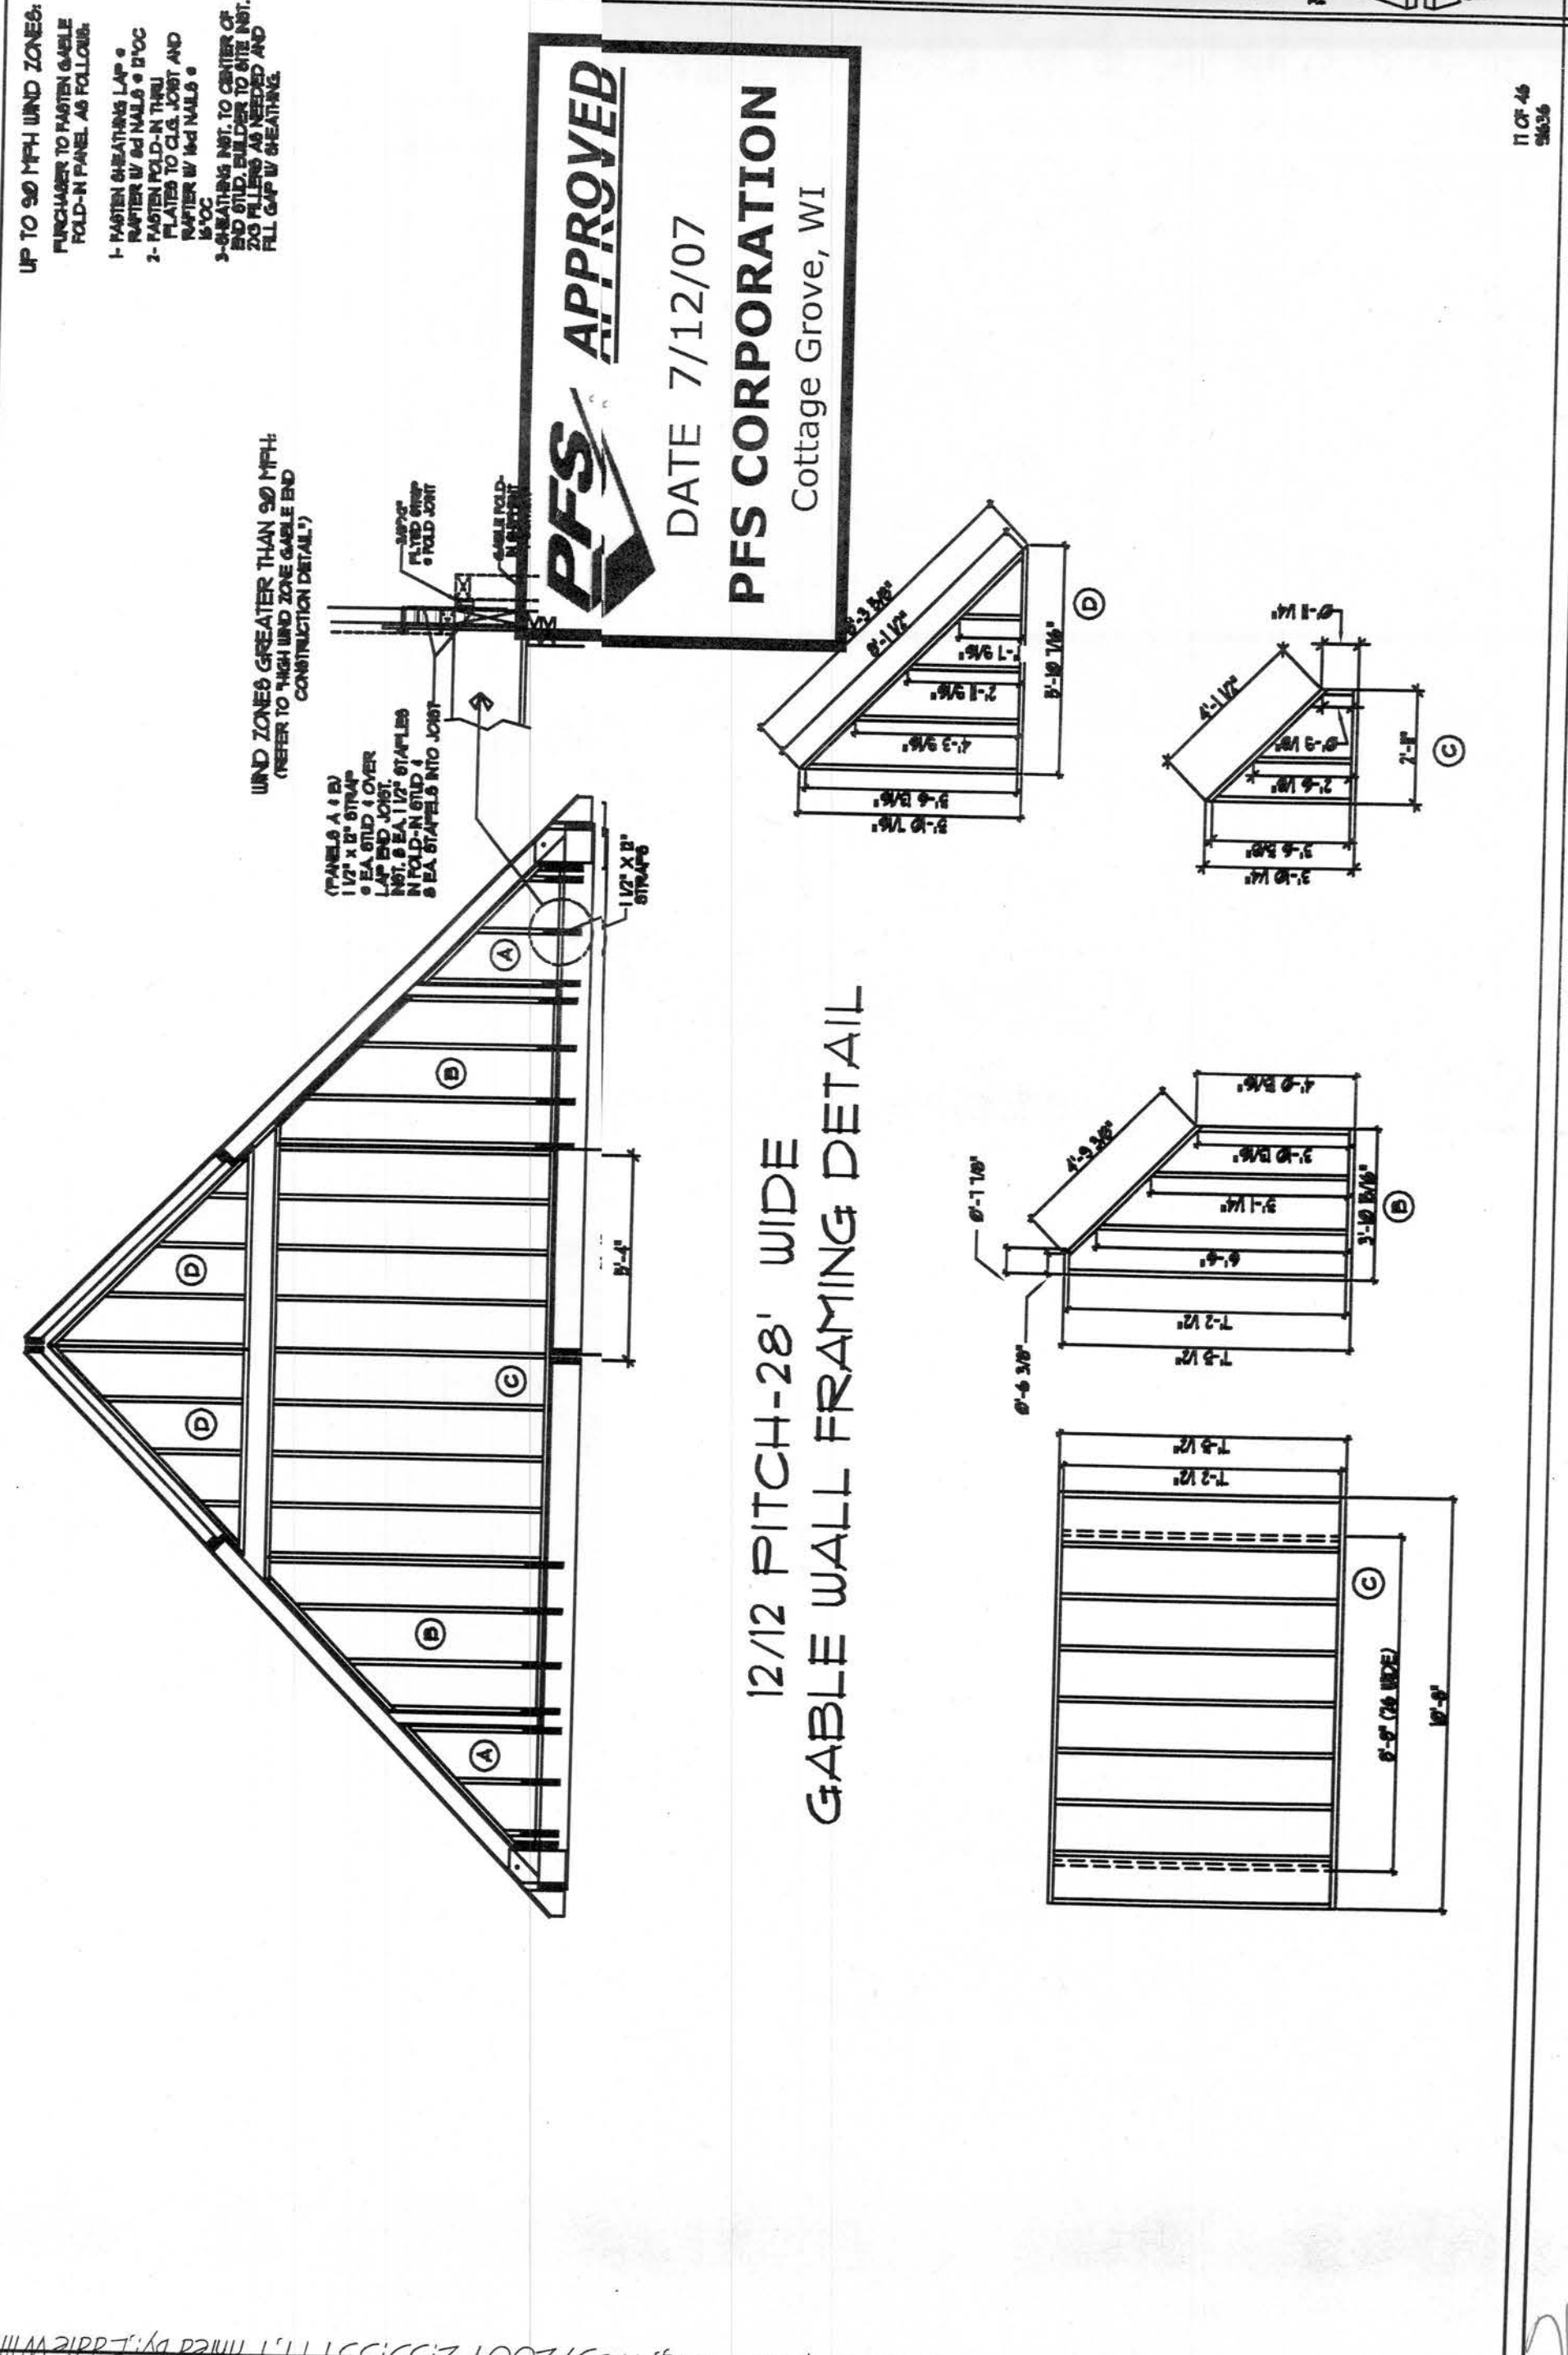


7/9/07

FRAMING NOTES:
1-RAFTER / JOIST SPACING 16"

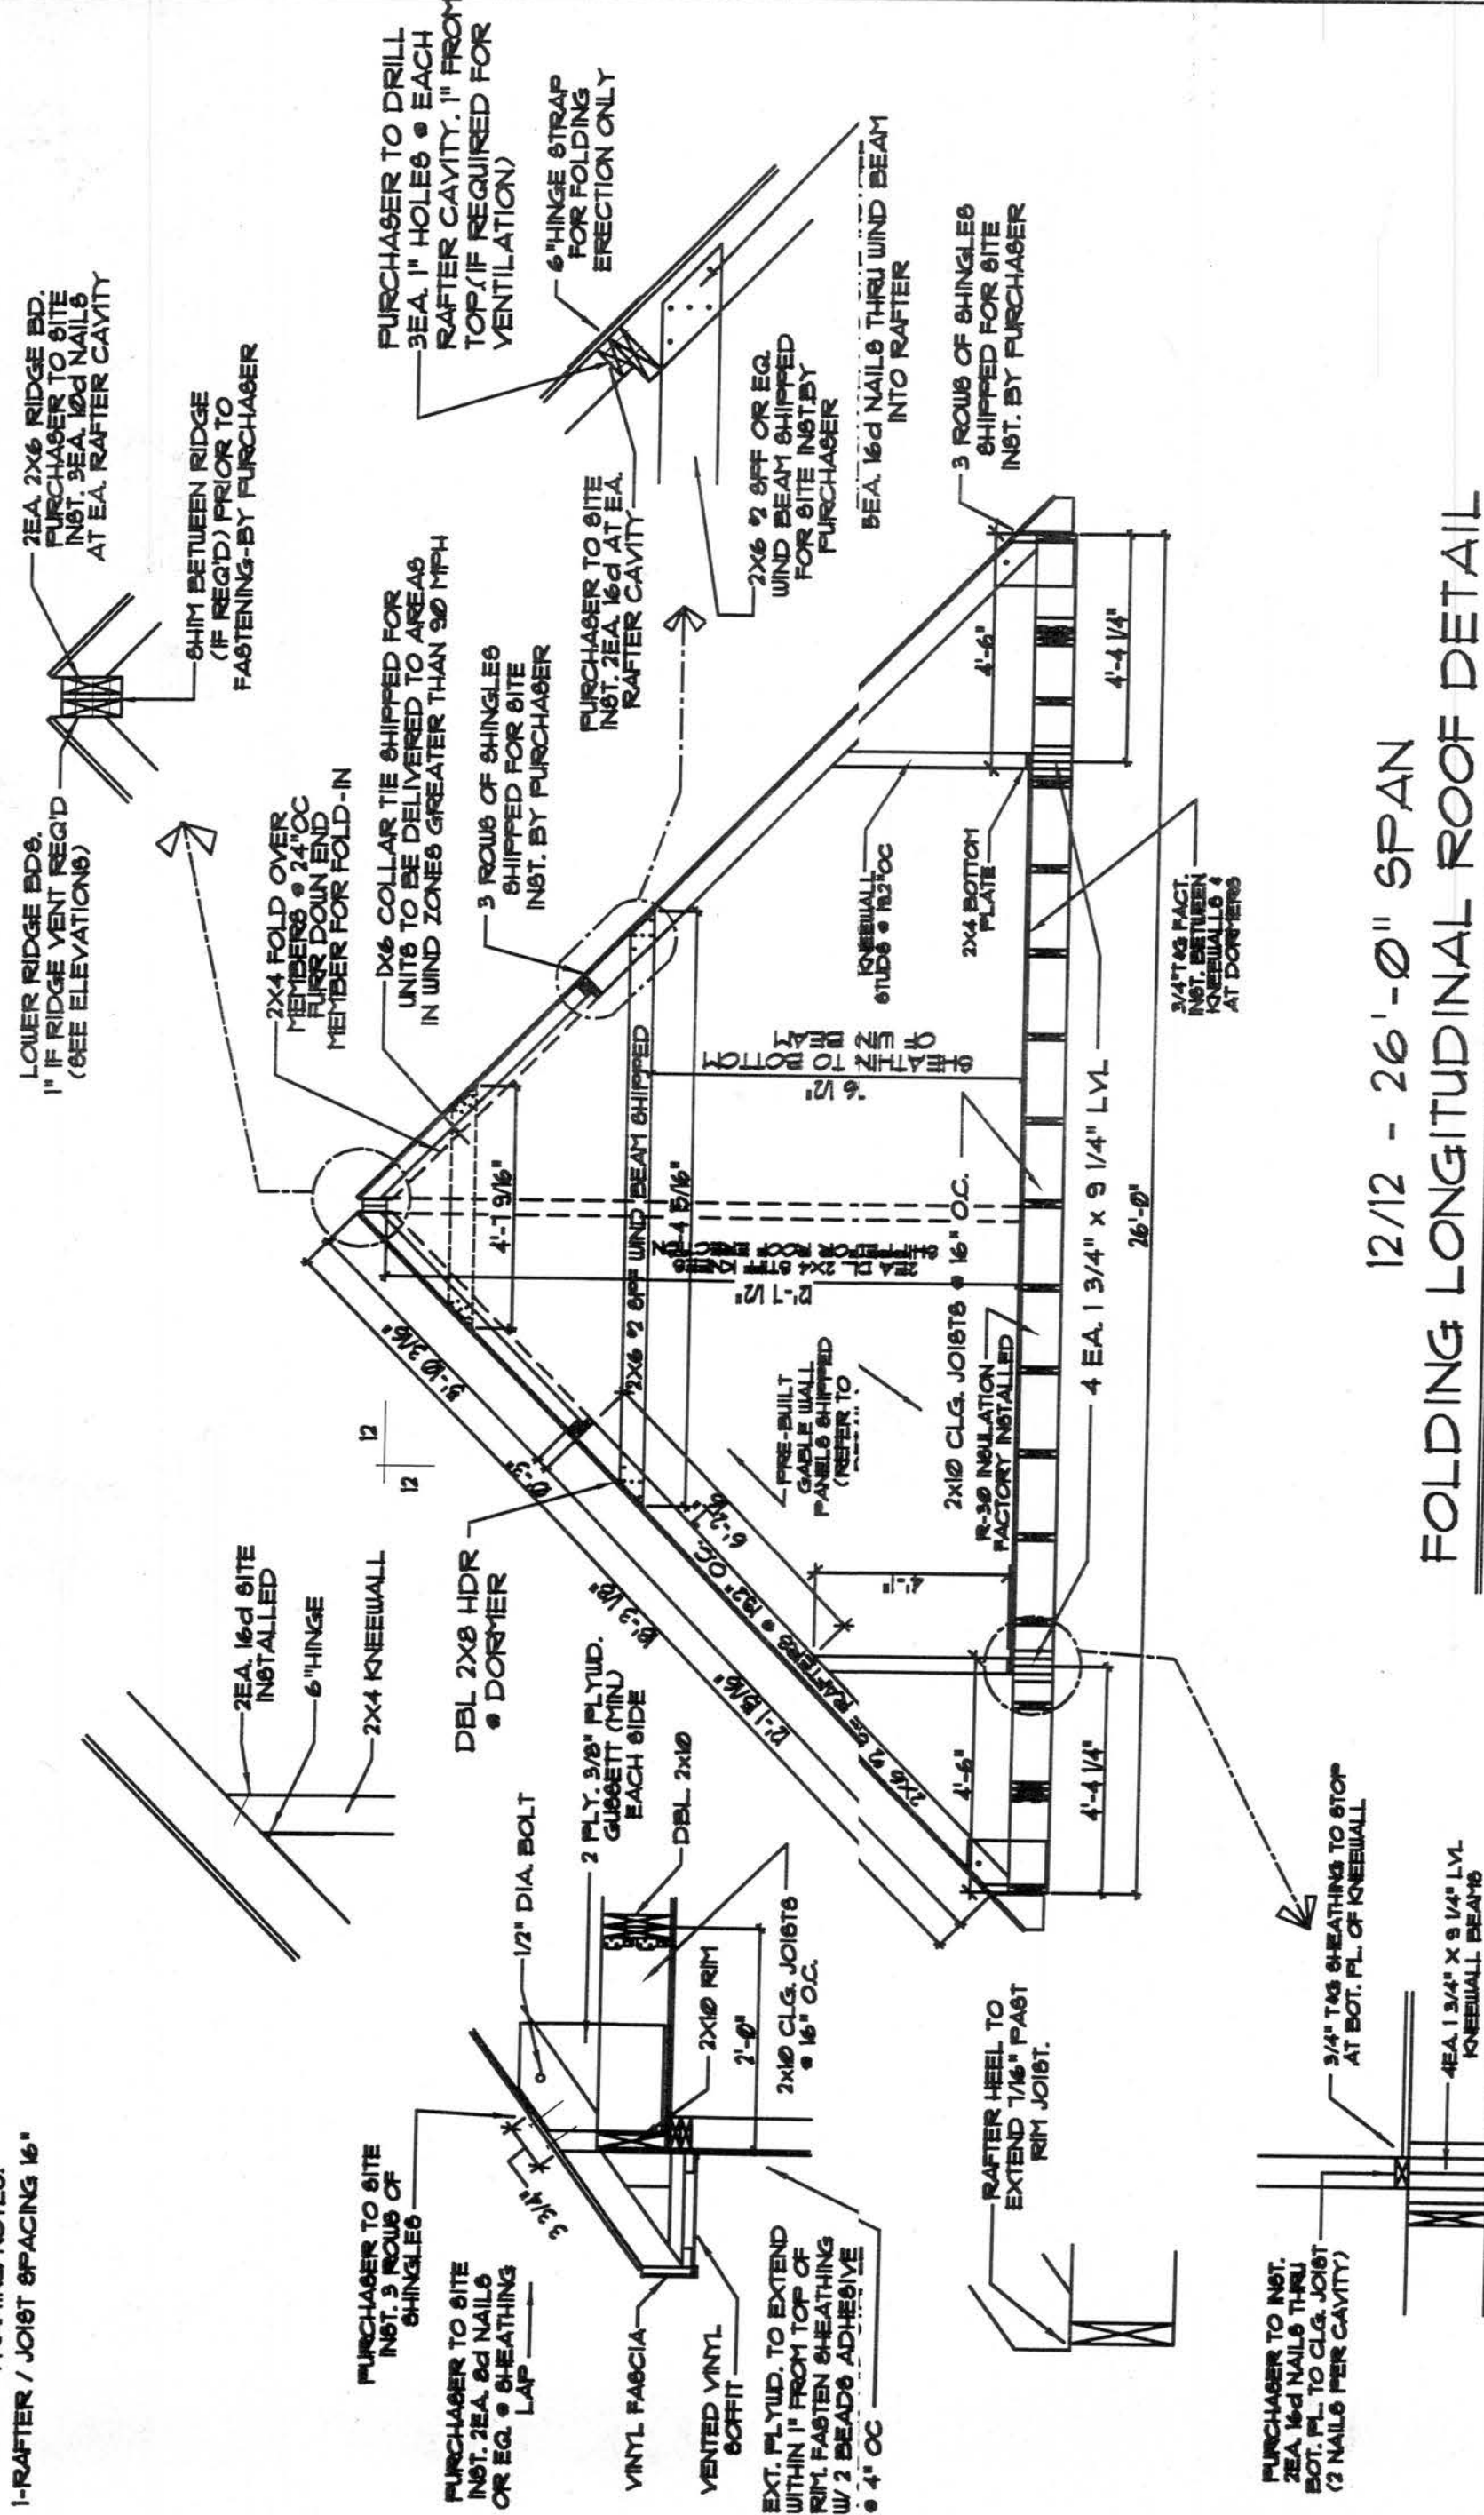


12/12 - 26'-0" SPAN FOLDING LONGITUDINAL ROOF DETAIL

POLONS RAFTER DESIGN FOR WIND ZONES UP TO MP-11. (2-SEC. GUST)
REFER TO WIND ZONE MAP FOR FASTENING /
STRAPPING OF FOLDING RAFTER DESIGN FOR WIND ZONES GREATER THAN MP-11. (2-SEC. GUST)

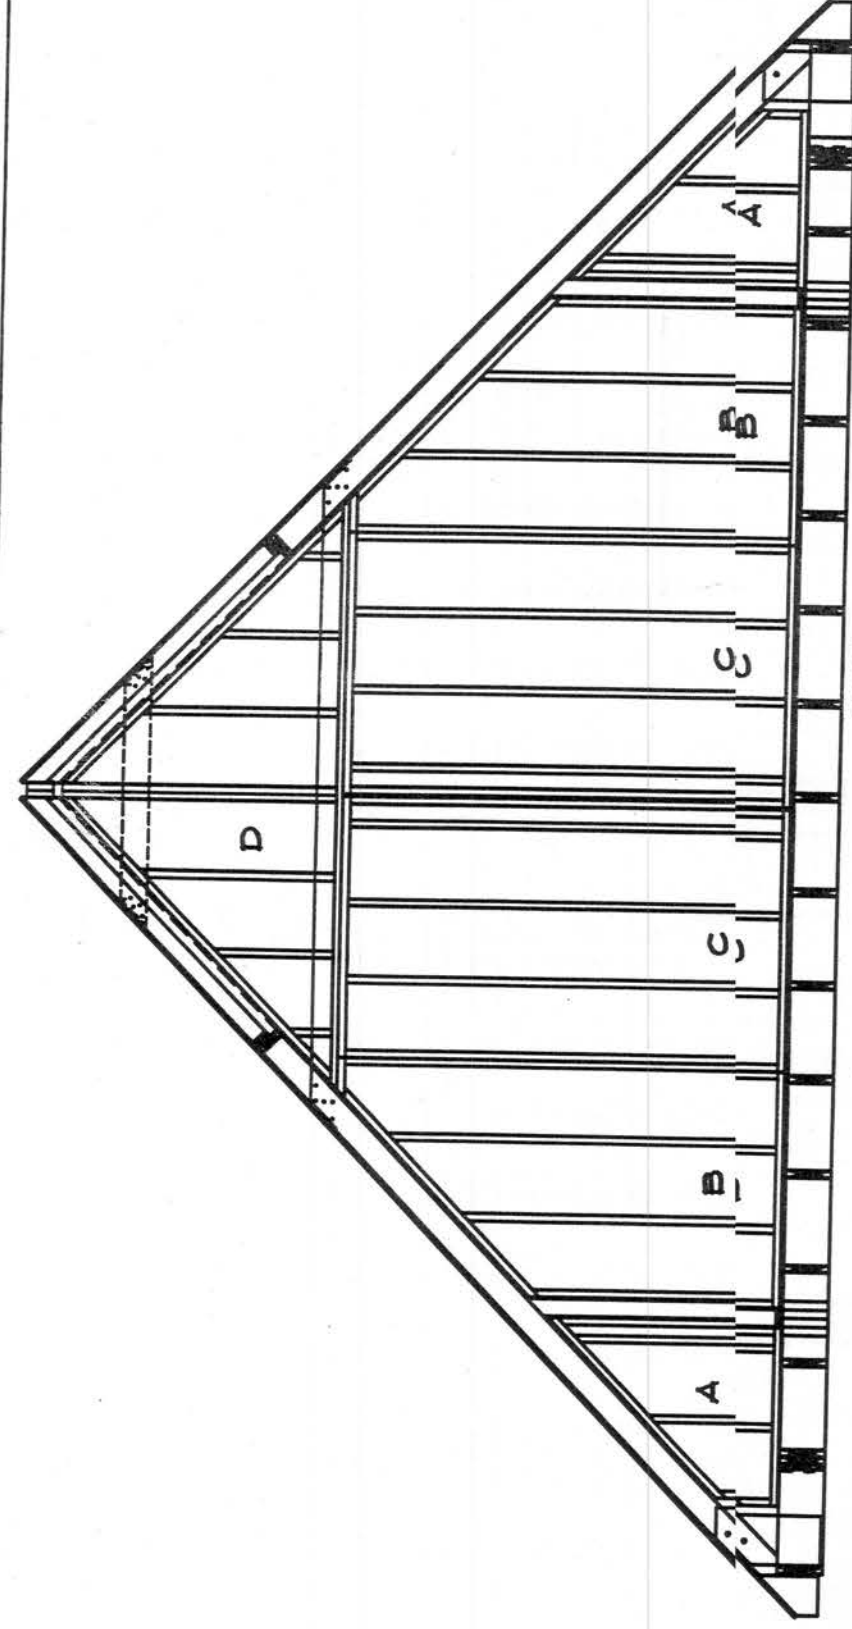

PRE-BUILT GABLE ATTIC
WALL PANEL DETAIL
FOR
12/12 - 26'-0" SPAN
LONGITUDINAL ROOF

2 SETS OF PANELS A, B AND C
AND 1 PANEL-D MAKE-UP EA.
GABLE END

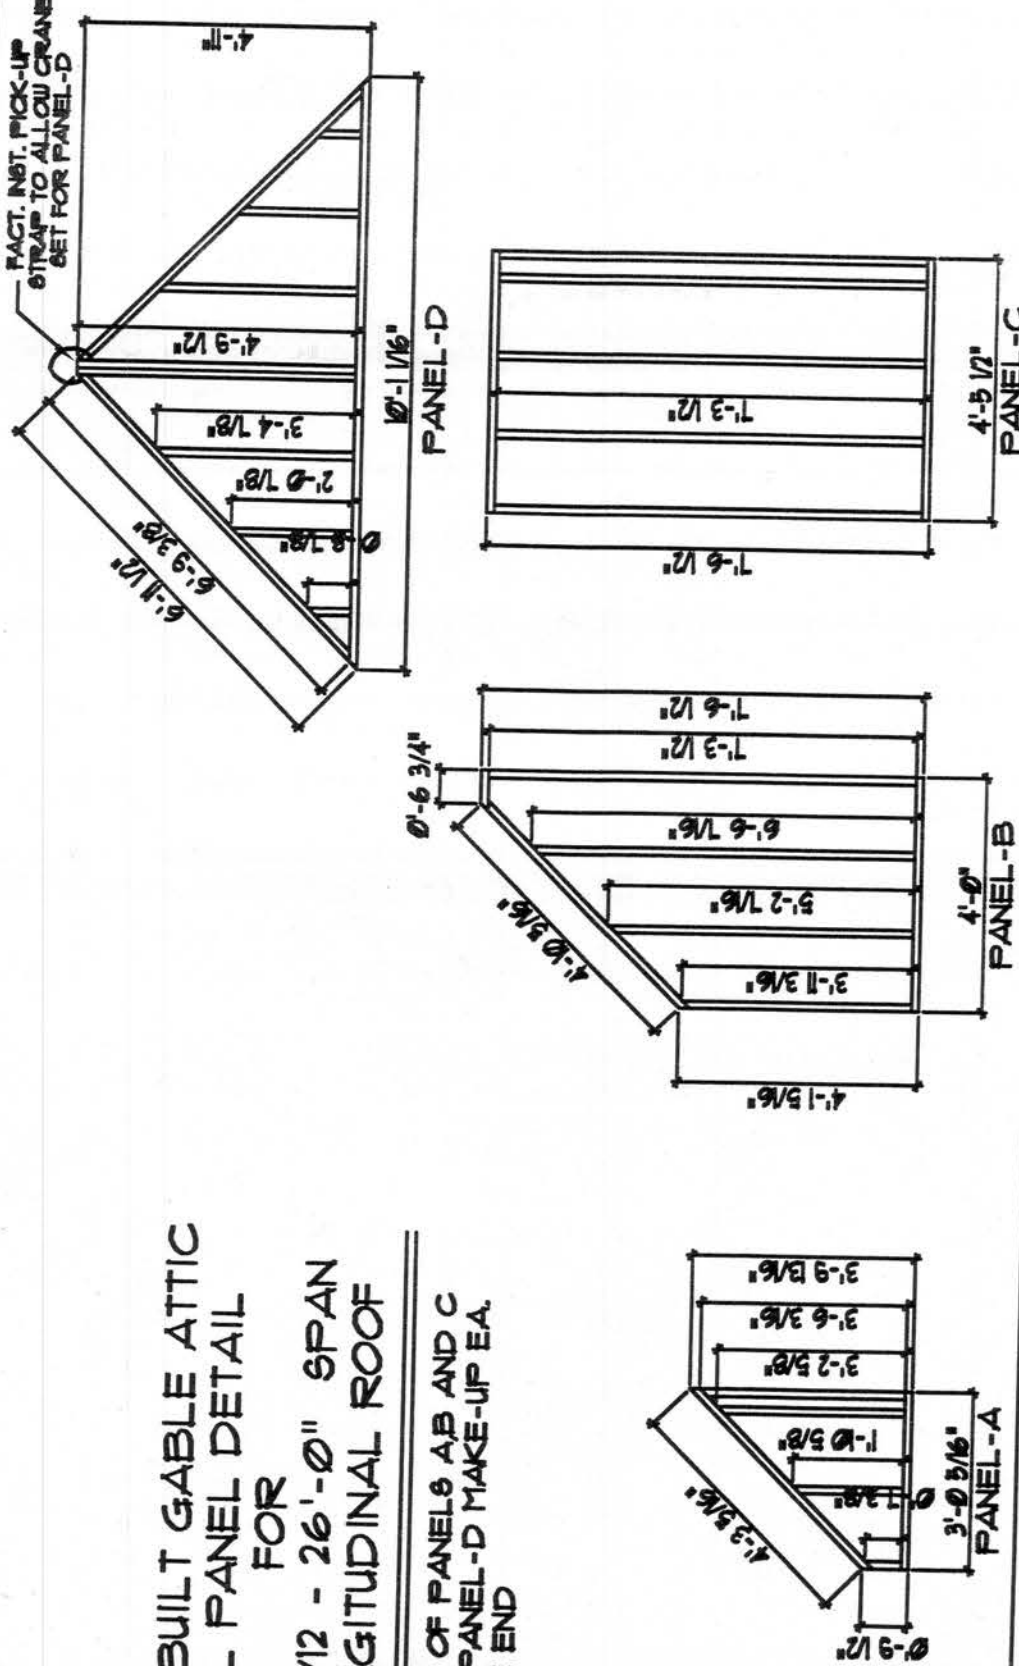

PFS APPROVED

DATE 7/12/07

PFS CORPORATION

Cottage Grove, WI

NOTE:
CENTER SECTION PRE-BUILT
WALL PANELS B-C FRAMED W/
2X4 STUDS @ 16" OC AND
SHEATHED W/ 5/8" PLYWOOD


MODEL	NATIONWIDE HOMES
DESIGN DATE	2-1-99
DATE PROCESSED	6-26-97
DATE REVIEWED	5-20-98
BY	J.D. BURRATT
CONTRACT #	
BUILDER / PURCHASER	
G./ROOF/DETAILS/DCAPE	

MODEL	NATIONWIDE HOMES
DESIGN DATE	2-1-99
DATE PROCESSED	6-26-97
DATE REVIEWED	5-20-98
BY	J.D. BURRATT
CONTRACT #	
BUILDER / PURCHASER	
G./ROOF/DETAILS/DCAPE	

MODEL	NATIONWIDE HOMES
DESIGN DATE	2-1-99
DATE PROCESSED	6-26-97
DATE REVIEWED	5-20-98
BY	J.D. BURRATT
CONTRACT #	
BUILDER / PURCHASER	
G./ROOF/DETAILS/DCAPE	




MODEL	NATIONWIDE HOMES
DESIGN DATE	2-1-99
DATE PROCESSED	6-26-97
DATE REVIEWED	5-20-98
BY	J.D. BURRATT
CONTRACT #	
BUILDER / PURCHASER	
G./ROOF/DETAILS/DCAPE	

MODEL	NATIONWIDE HOMES
DESIGN DATE	2-1-99
DATE PROCESSED	6-26-97
DATE REVIEWED	5-20-98
BY	J.D. BURRATT
CONTRACT #	
BUILDER / PURCHASER	
G./ROOF/DETAILS/DCAPE	

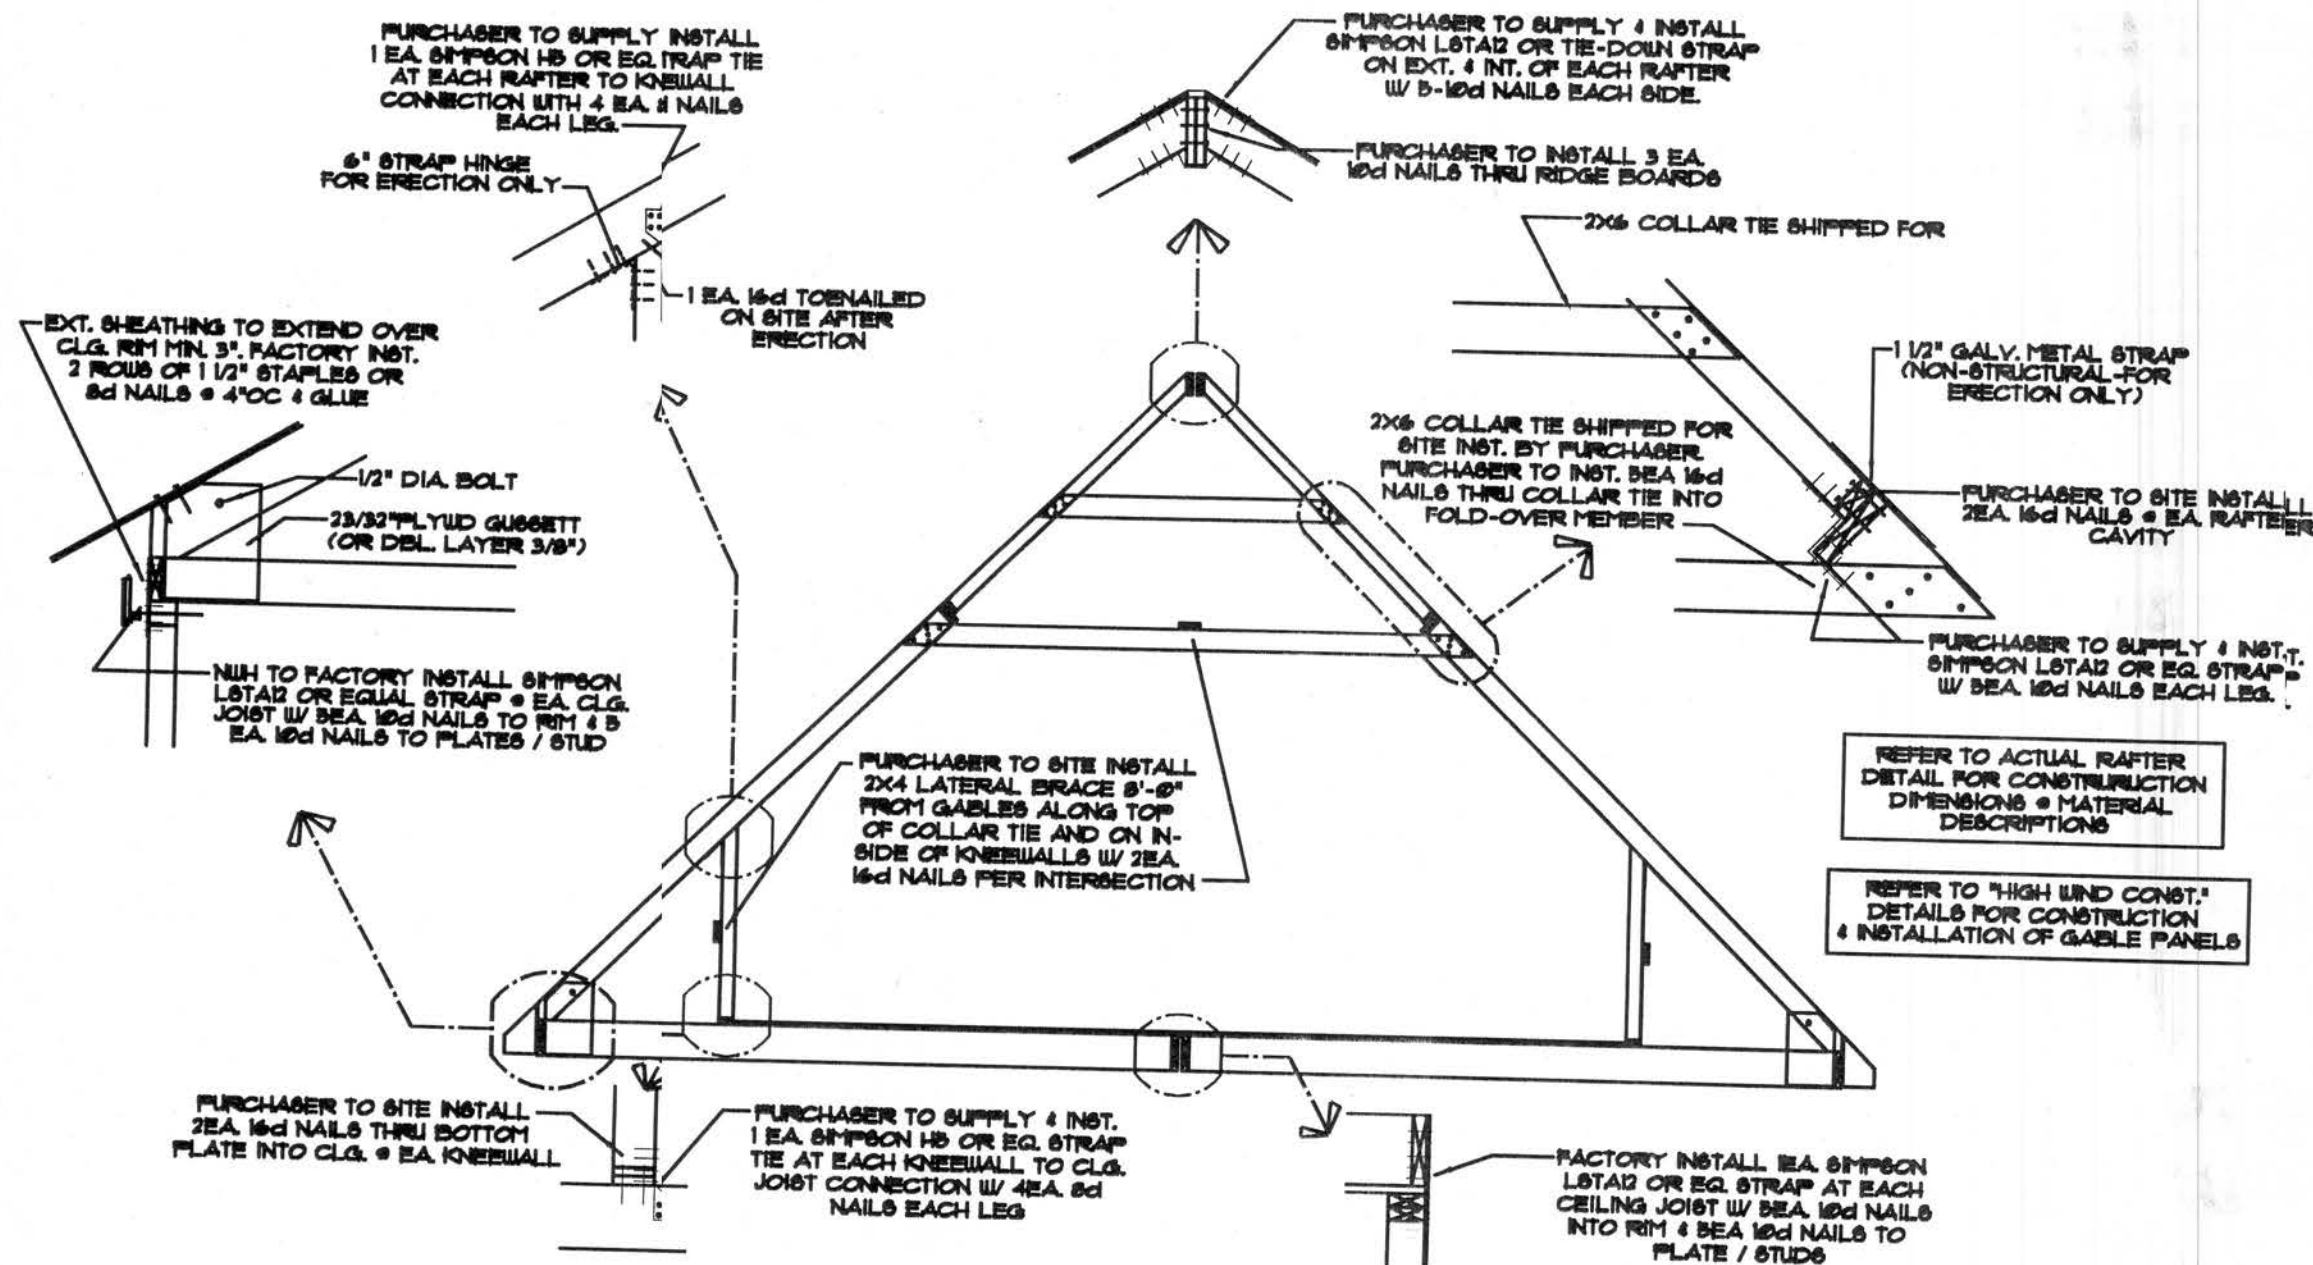

HIGH WIND ZONE CONSTRUCTION TYP. 16 & 28 WIDE CAPE ROOF SYSTEMS

(FOR AREAS UP TO 130 MPH (3-SEC. GUST) WIND ZONES)

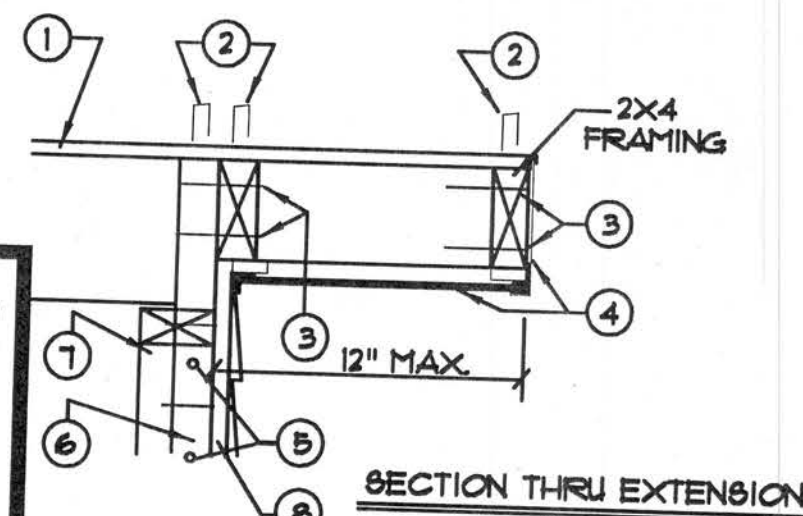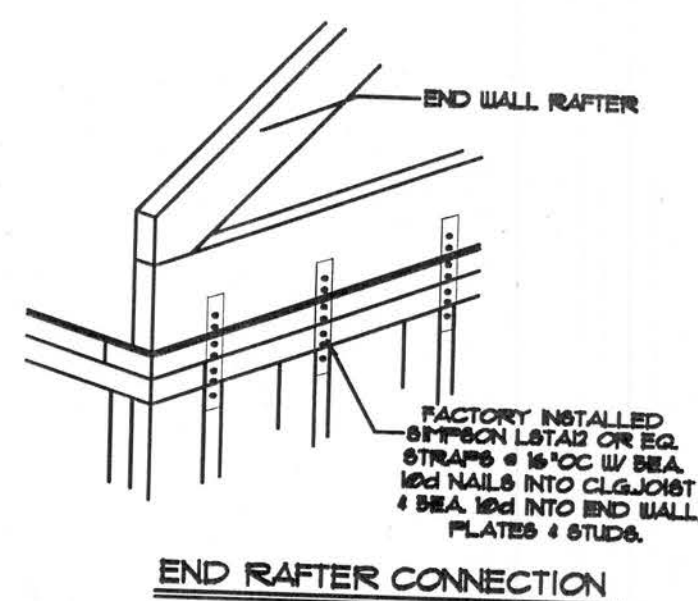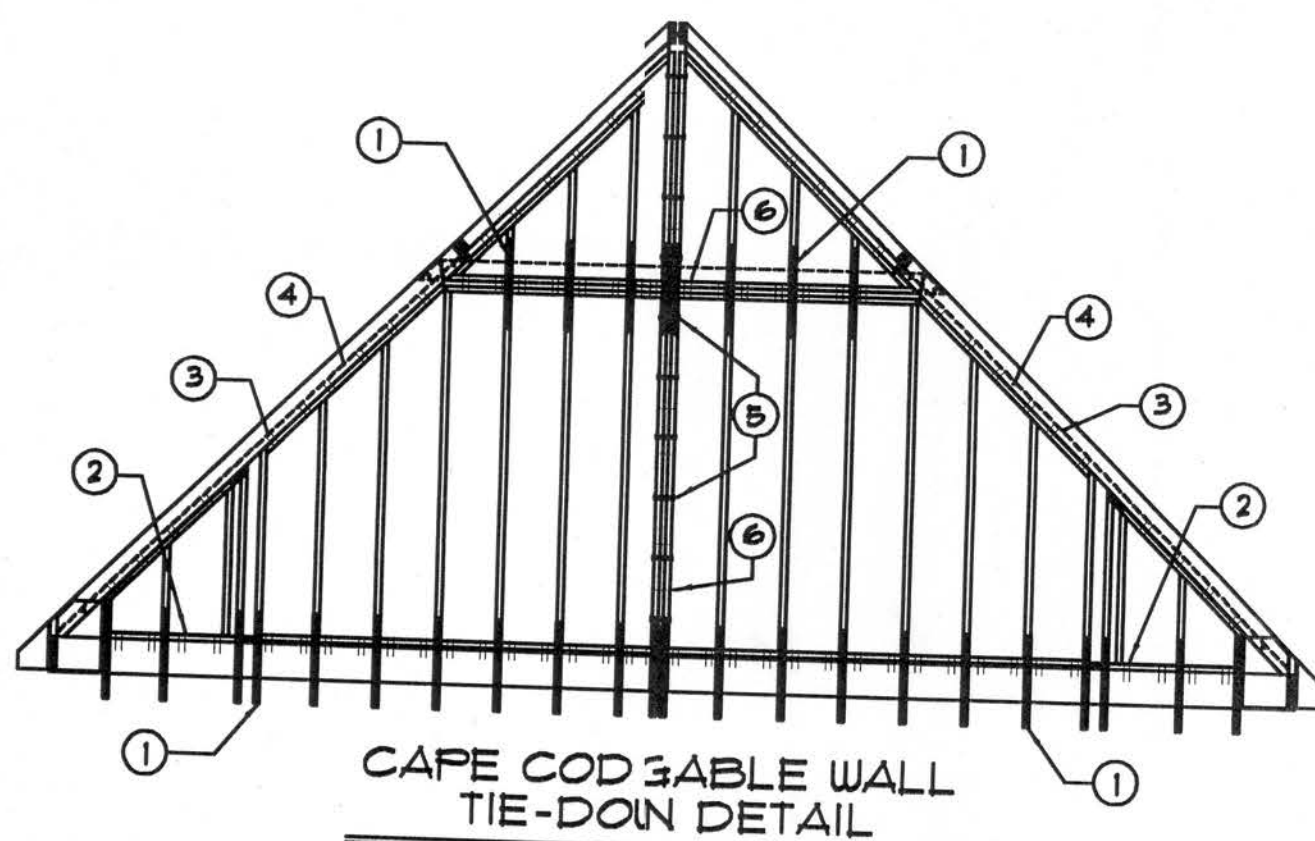

DESCRIPTION OF MATERIALS / FASTENING

1. SIMPSON L8TA24 OR EQ. W/ 16 EA. 16d NAIL SUPPLIED & SITE INST. BY PURCHASER
2. 16d NAIL 2 EA. @ 12" OC THRU PLATE INO RIM- SITE INSTALLED BY PURCHASER
3. 16d NAIL 2 EA. @ 12" OC THRU PLATE INO RAFTER- SITE INSTALLED BY PURCHASER
4. PRE-BUILT WALL PANELS W/ 1/2" EXT. FLYUD SHEATHING LAPPED OVER RAFTER 2"++ PURCHASER TO SITE INSTALL 2 ROWS 8d NAIL @ 12" OC THRU SHEATHING INTO RAFTER
5. 3/8" X 3 1/2" LAG SCREWS OR EQ. @ 16" X TO FASTEN PANEL TO PANEL. SUPPLIED AND SITE INST. BY PURCHASER
6. 16d NAIL 2 EA. @ 12" OC TO FASTEN PANEL TO PANEL. SITE INST. BY PURCHASER



NON-CORROSIVE FASTENERS / STRAPS
TO BE USED WHERE REQUIRED BY LOCAL
BUILDING JURISDICTION. PURCHASER
RESPONSIBLE FOR STRAPS NOT INDICATED
AS INSTALLED BY NATIONWIDE HOMES

DESCRIPTION OF MATERIAL / FASTENING

1. 1/16" OSB OR 1/2" PLYUD.
2. 1/2" STAPLES @ 4" OC.
3. 3" GUN NAILS (2) EVERY BLOCK (24" OC. ALONG EXTENSION TO RAFTER)
4. VINYL FASCIA / SCOFFIT (SITE INST.)
5. 16d NAIL 6 SITE INST. 2" OC END WALL TO END RAFTER THRU PLATE
6. PRE-ASSEMBLED GABLE PANEL WALLS (SITE INST.)
7. END RAFTER (2X6 OR LARGER)
8. 1/2" EXTERIOR PLYUD. SHEATHING



NATIONWIDE HOMES
Web Site: www.nationwide-homes.com

PLAN NAME: HIGH WIND

COLLECTION: DETAILS

DESIGN DATE: 03/01/2002

REV. DATE:

REV. DATE:

DWG. BY: JES

REV. BY:

REV. BY:

CK. BY: DA

PURCHASER:

JOB NO.

PROCESS DATE:

ORDER REVISION DATES:

CONTRACT NO.:

DWG. BY:

CHECK BY:



PAGE NO.

19

OF

46

U:\F\ORDINA\WINSTON\#91636 KENT HARRIS\91636.dwg, 11/21/2001 2:55:46 PM, Printed by: Eddie Williams

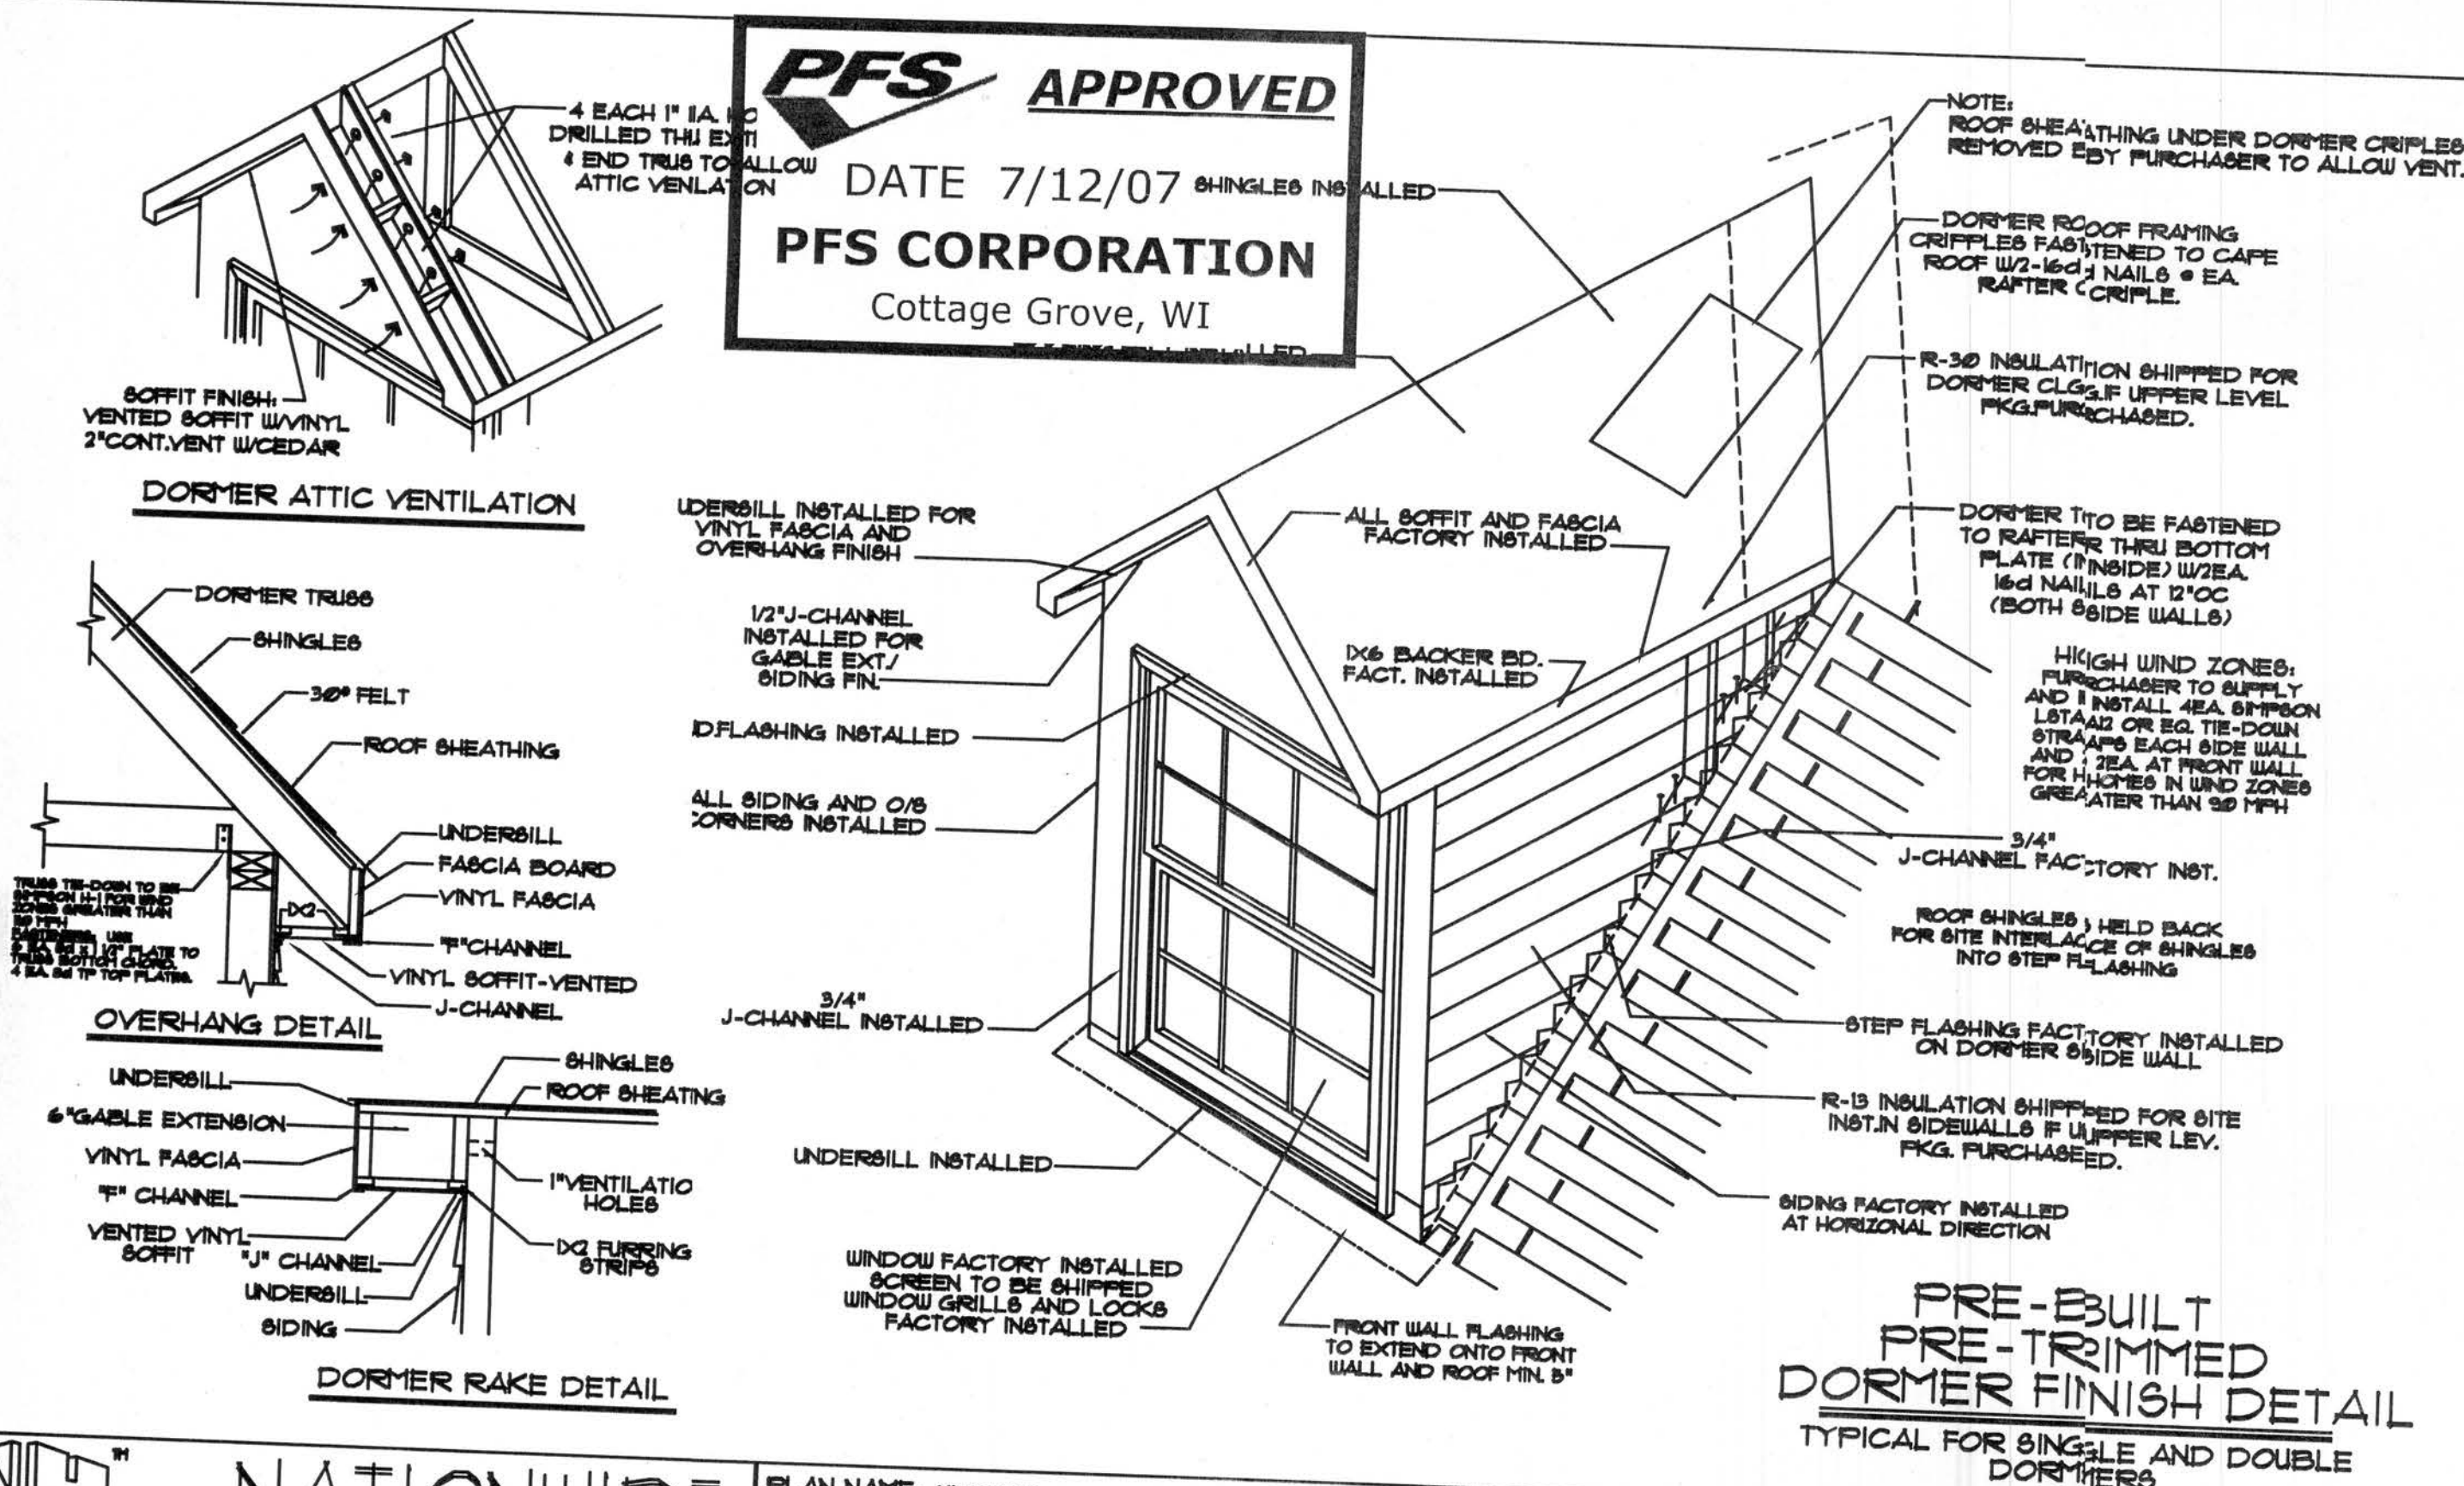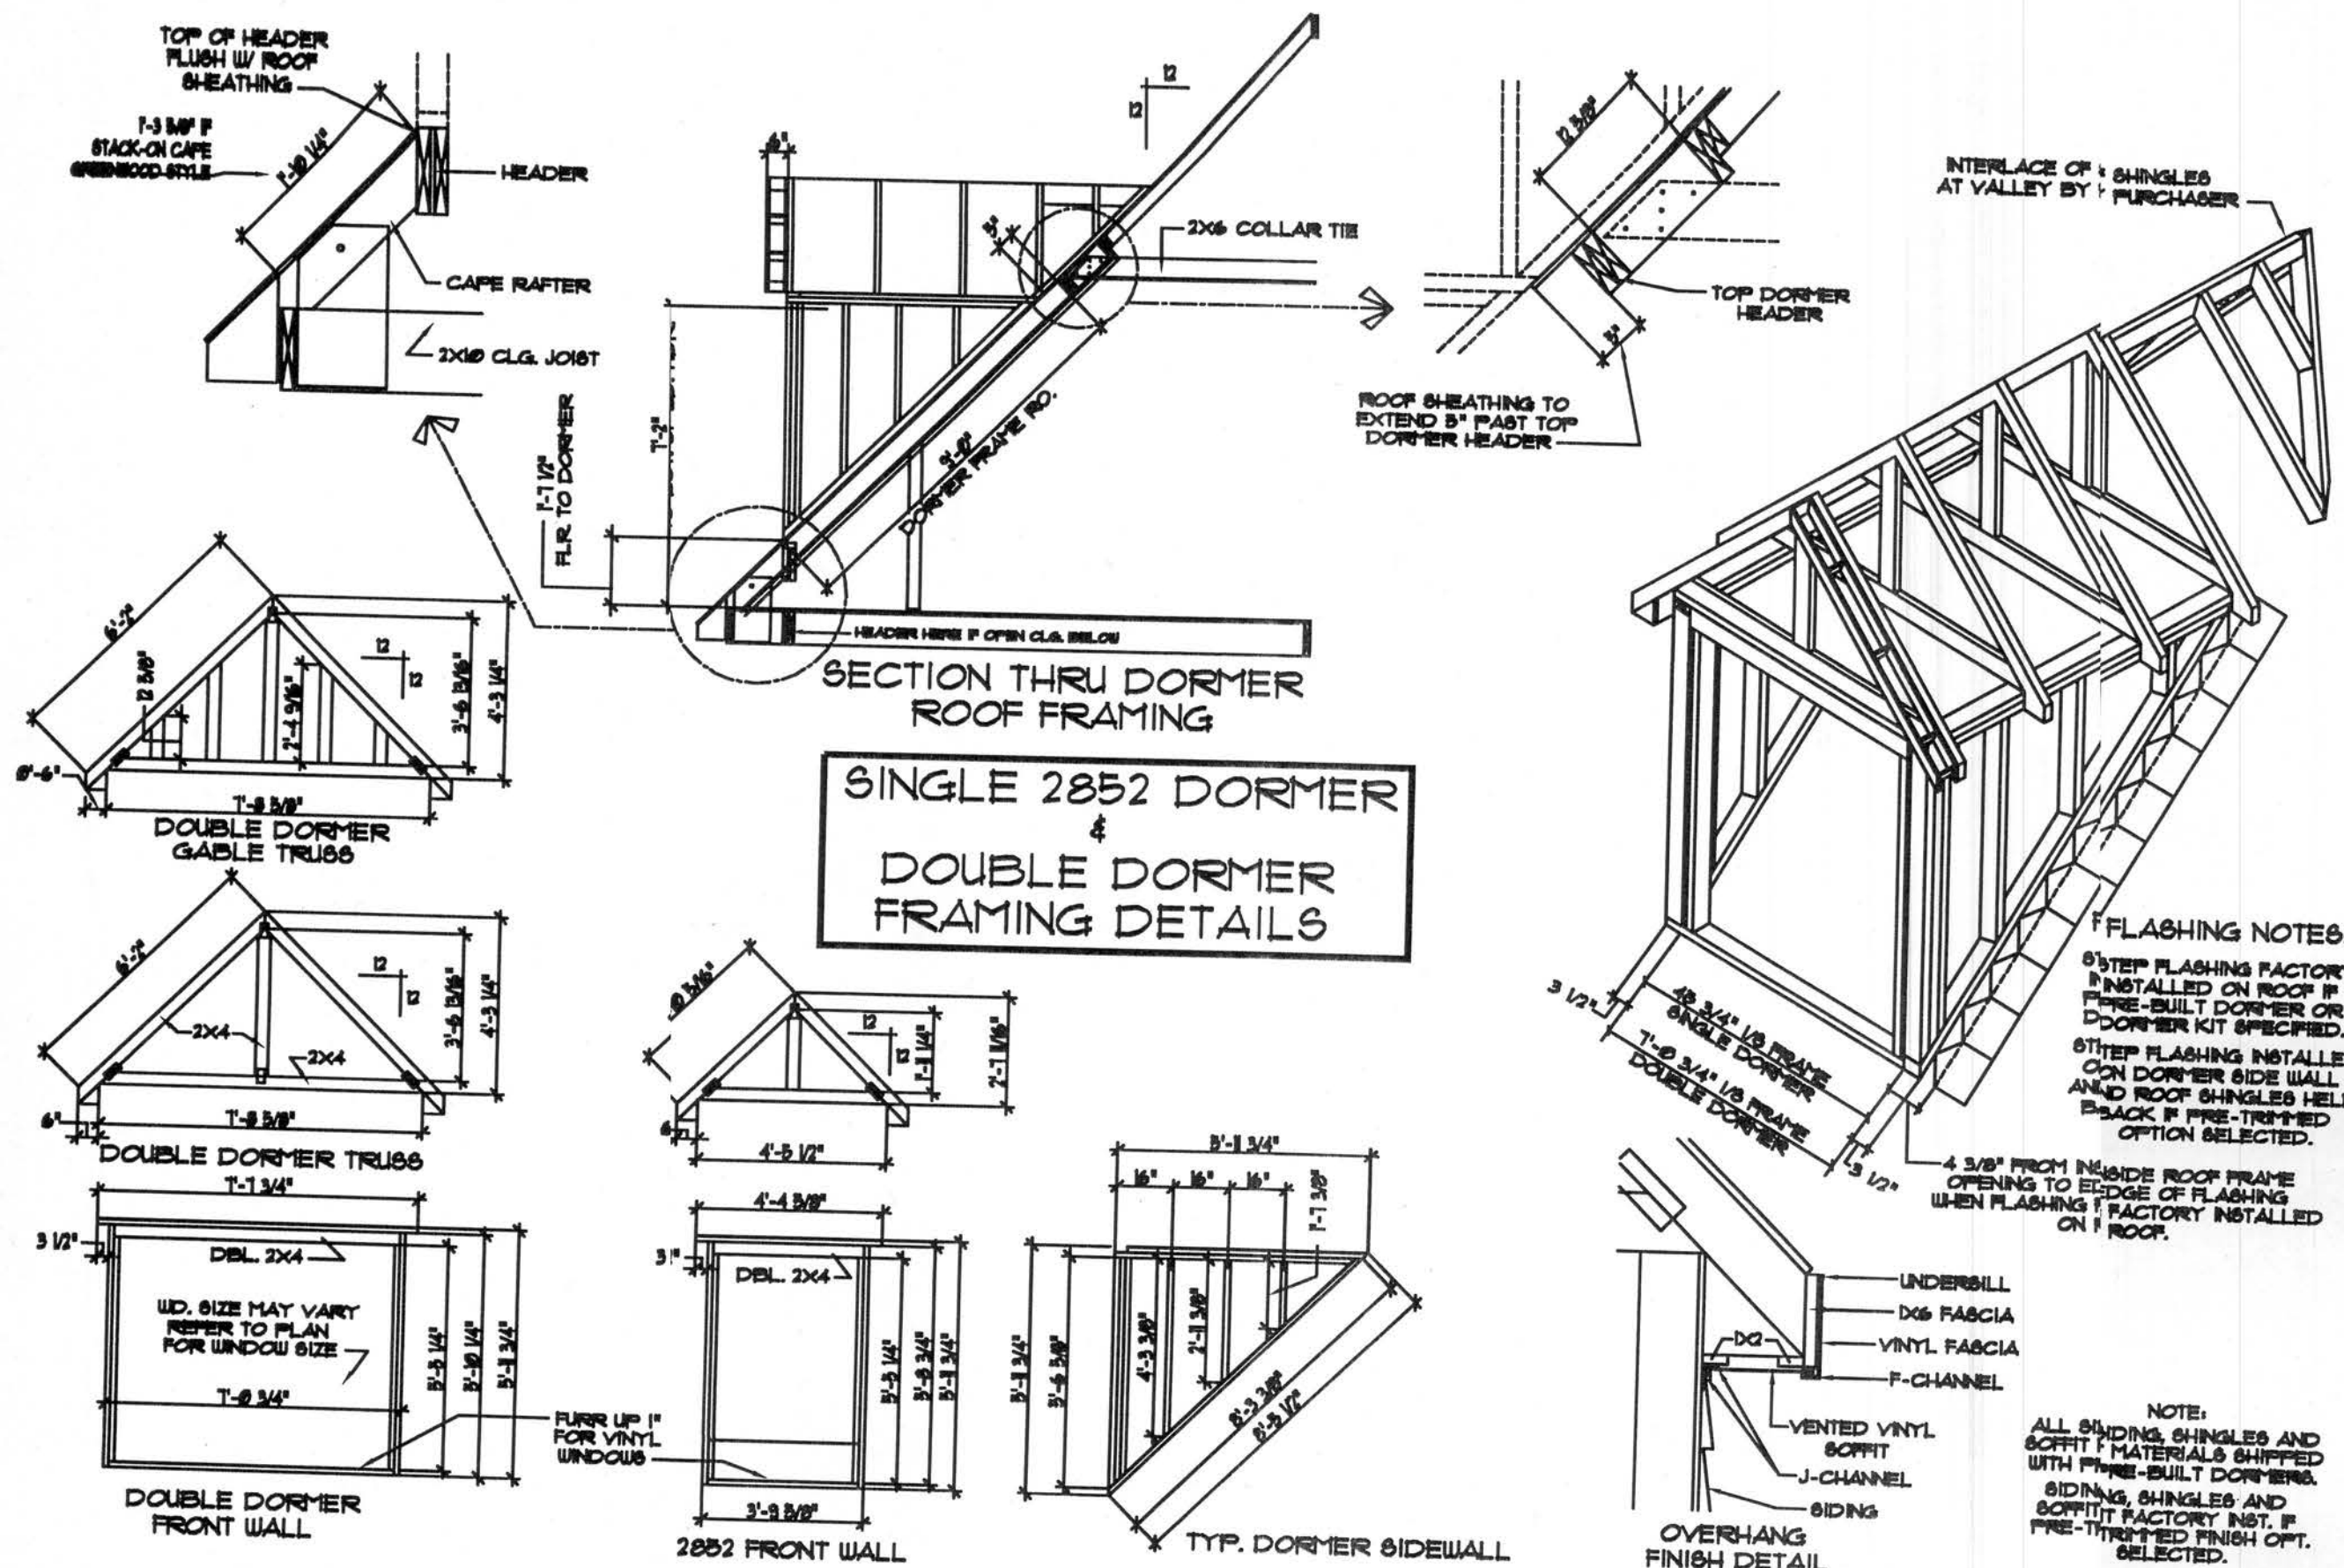


U:\FLORIDA\WINSTON #91636 KENT HARRISS 91636.dwg, 7/13/2007 3:00:04 PM, Printed by: Eddie Williams



PLAN NAME: HIGH WIND		PURCHASER:	
COLLECTION: DETAILS		JOB NO. CONTRACT NO.	
DESIGN DATE: 03/10/2002	DWG. BY: JES	PROCESS DATE:	DWG. BY:
REV. DATE:	REV. BY:	ORDER REVISION DATES:	CHECK BY:
REV. DATE:	REV. BY:		

U:\FLORIDA\WINSTON #91636 KENT HARRISS 9/16/2007 3:17:51 PM, Printed by: Eddie Williams

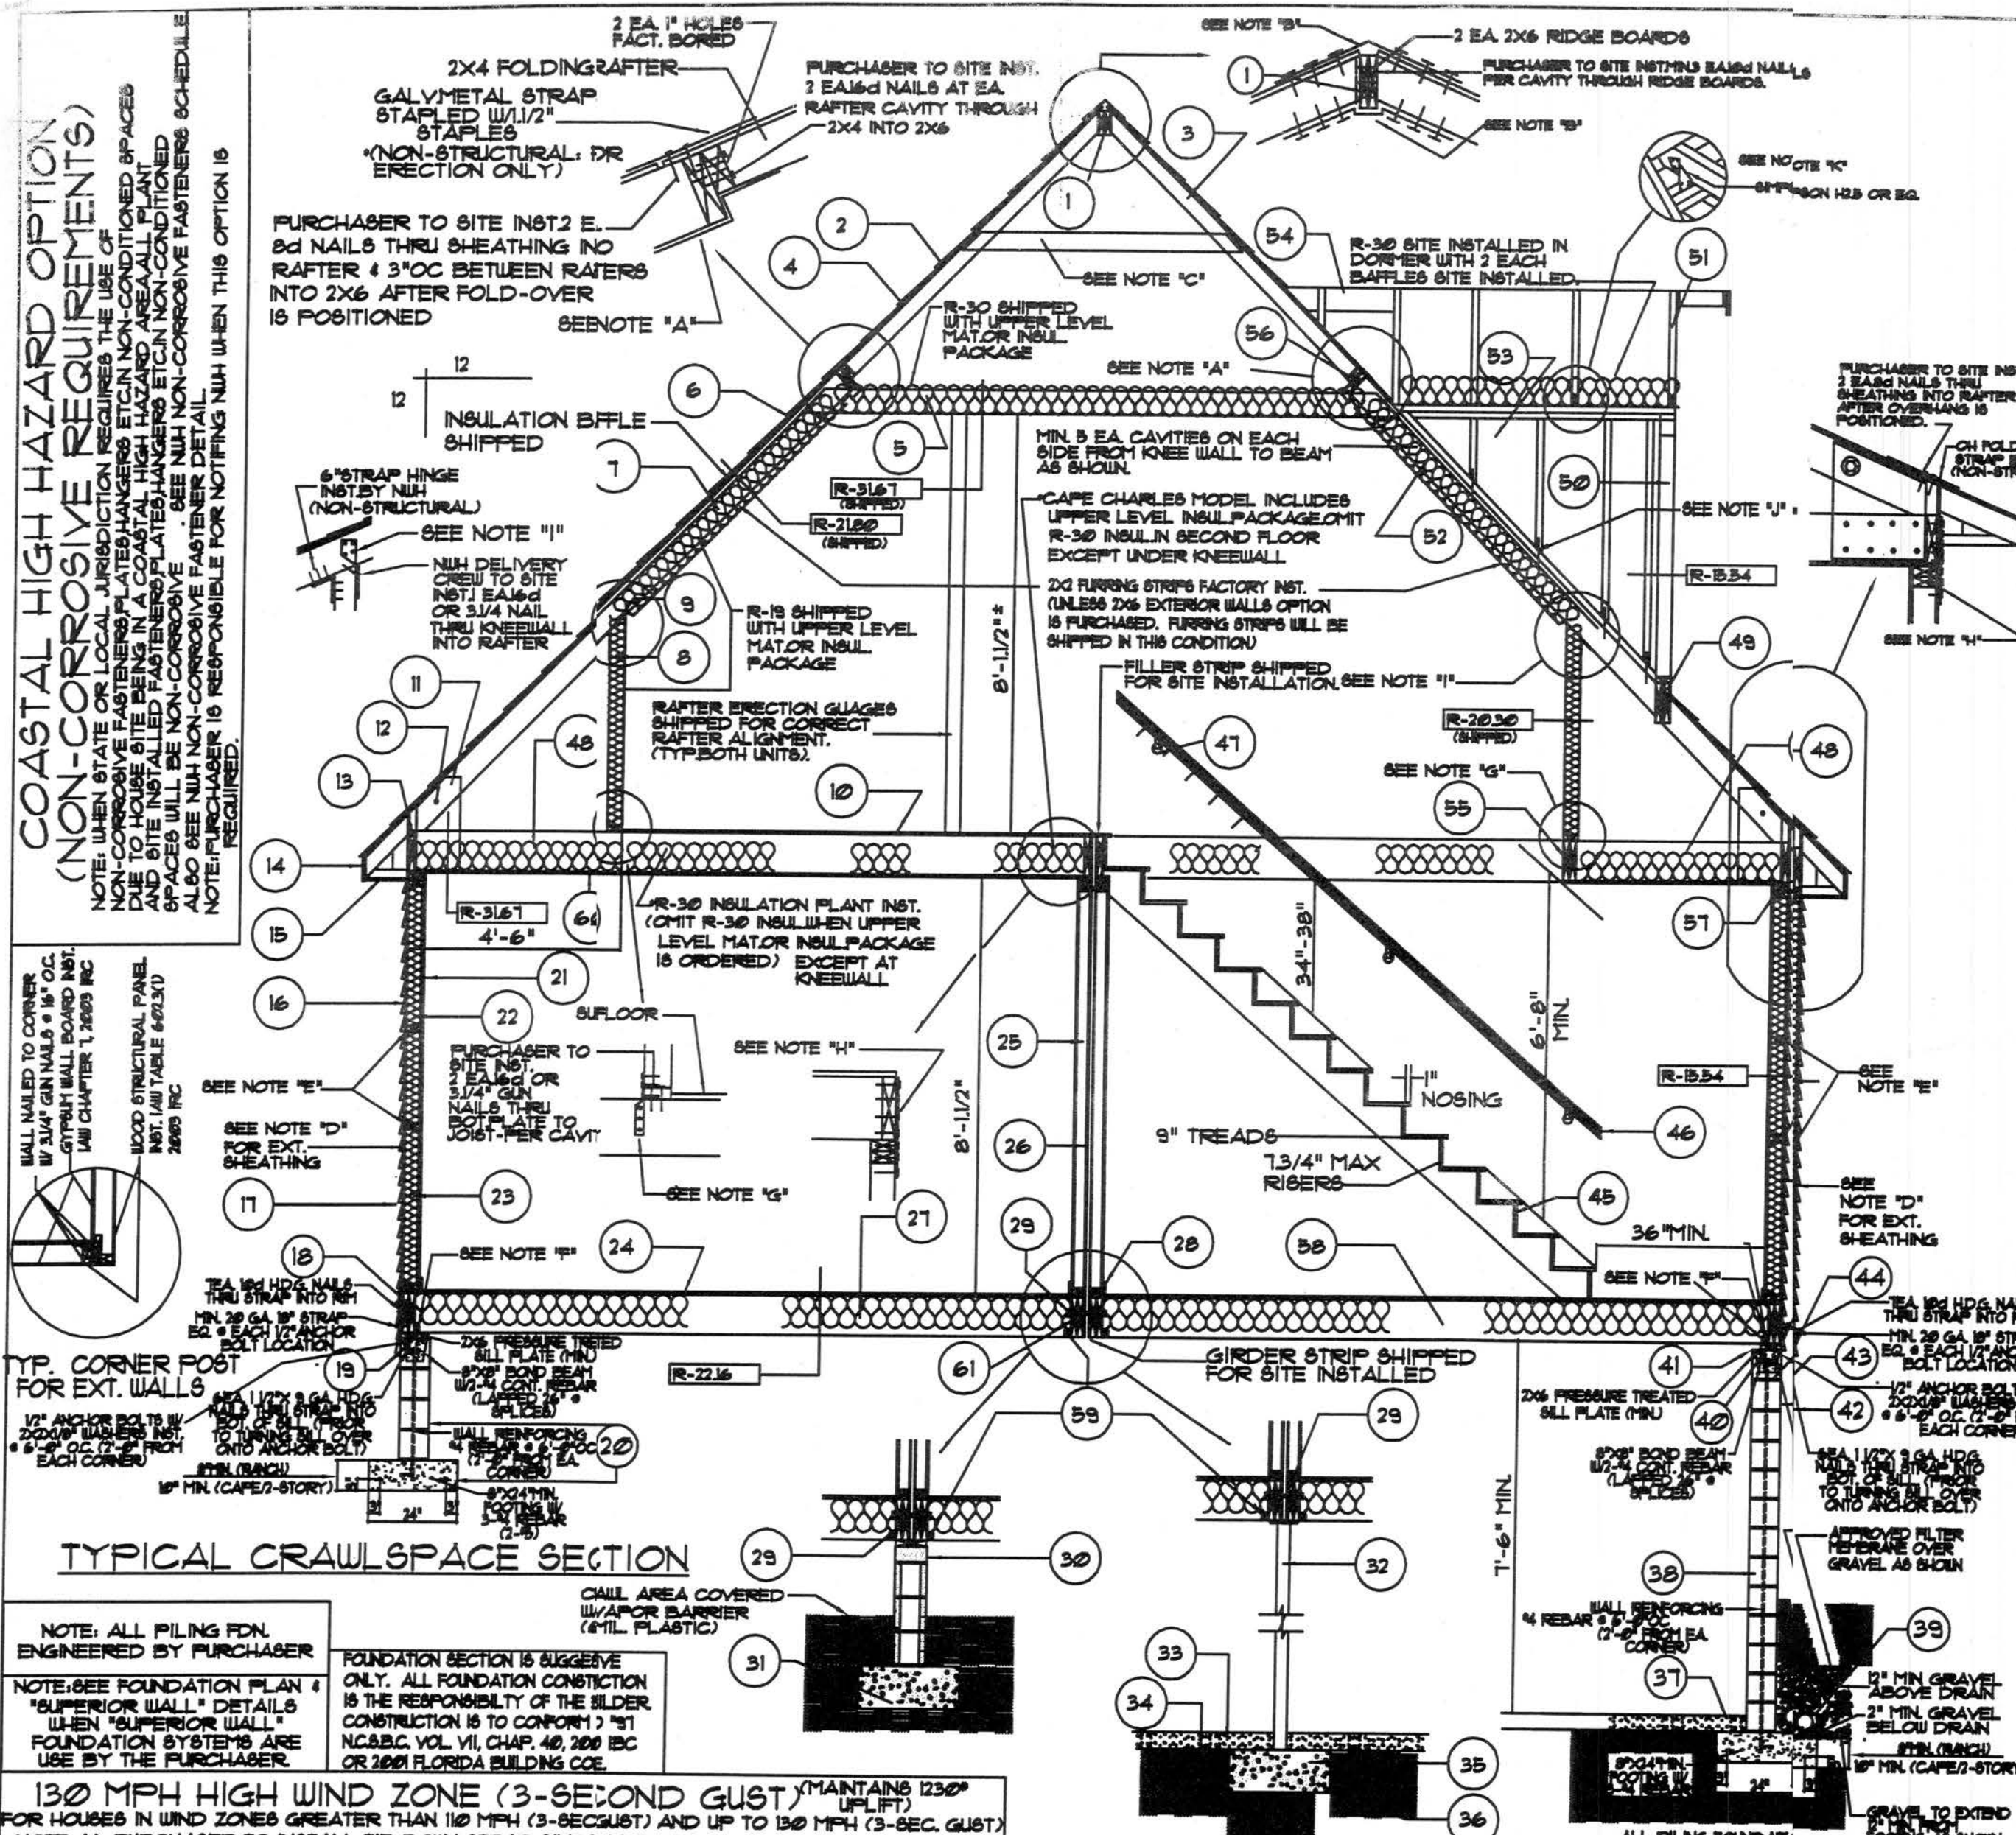

NOTE: ALL PILING FOR ENGINEERED BY PURCHASER

NOTE: SEE FOUNDATION PLAN & "SUPERIOR WALL" DETAILS WHEN "SUPERIOR WALL" FOUNDATION SYSTEMS ARE USED BY THE PURCHASER.

FOUNDATION SECTION IS SUGGESTIVE ONLY. ALL FOUNDATION CONSTRUCTION IS THE RESPONSIBILITY OF THE BUILDER. CONSTRUCTION IS TO CONFORM TO "1" NCABC VOL. VII, CHAP. 40, 2001 IBC OR 2001 FLORIDA BUILDING CODE.

130 MPH HIGH WIND ZONE (3-SECOND GUST)
FOR HOUSES IN WIND ZONES GREATER THAN 110 MPH (3-SECOND) AND UP TO 130 MPH (3-SEC. GUST)

NOTE A) PURCHASER TO INSTALL TIE-DOWN STRAP SIMPSON LSTA18 (SHIPPED) OR EQUAL AT EACH RAFTER

NOTE B) PURCHASER TO SUPPLY AND INSTALL 2 EA. RIDGE TIE-DOWN STRAP (1 AT INTERIOR/1 AT EXTERIOR) SIMPSON LSTA18 (R EQ. (SHIPPED))

NOTE C) 2X6 COLLAR BEAM AT 24" OC. NUT TO PROVIDE COLLAR BEAM/FURD INSTALL AT SITE

NOTE D) INSTALL OGB SHEATHING ON GABLE ENDS ILO BERRY BRACE

NOTE E) INSTALL HORIZONTAL BLOCKING AT SHEATHING JOINTS

NOTE F) INSTALL 2X6 LEDGER FOR HOUSES THAT WILL BE PLACED ON PILE PIER

NOTE G) PURCHASER TO INSTALL TIE STRAP SIMPSON H8 R EQ. (SHIPPED) AT EACH KNEEWALL TO JOIST CONNECTION

NOTE H) TIE DOWN STRAP SIMPSON LSTA18 OR EQUAL INST. NUT AT PLANT WITH MIN OF 4 EA. 1/2" NAILS TO RIM & 4 EA. TO TOP L. STUD. STRAP/CEILING JOIST. (INSTALL AT EA. CEILING JOIST)

NOTE I) PURCHASER TO INSTALL TIE STRAP SIMPSON H8 R EQ. (SHIPPED) AT EACH RAFTER/KNEEWALL CONNECTION

NOTE J) TIE DOWN STRAP SIMPSON LSTA18 OR EQ. SHIPPED FOR SITE INST. BY PURCHASER AT EACH DORMER SIDEWALL STUD TO RAFTER

NOTE K) TIE STRAP SIMPSON H23 OR EQUAL FACT. INST. @ EACH END OF DORMER TO DORMER WALL DEL. TOP PLATE

NOTE: PURCHASER IS RESPONSIBLE FOR NOTIFYING NTH WHEN THIS OPTION IS REQ'D. ALL TIE STRAPS & FASTENERS SUPPLIED BY PURCHASER TO MEET STATE BUILDING CODE REQUIREMENTS AND SUBJECT TO APPROVAL BY LOCAL BUILDING OFFICIAL.

PFS CORPORATION
Cottage Grove, WI

130 MPH WIND DESIGN
(3-SECOND GUST)

NOTE: PURCHASER IS RESPONSIBLE FOR NOTIFYING NTH WHEN THIS OPTION 1 IS REQUIRED.

NO.	DESCRIPTION	REVISIONS
1	DEL. 2X6 RIDGE BOARDS (2 OFF OR EQ.)	REVISION: 1-4-94 BY: JB
2	SHINGLES (SITE INST. @ CH HINGE & UL FOLD OVER)	REVISION: 1-4-94 BY: JB
3	2X4 FOLD RAFTERS @ 192" OC (16" OC OPT.) (OFF STD. OR EQ.)	REVISION: 1-4-94 BY: JB
4	30 LB FELT PAPER	REVISION: 1-4-94 BY: JB
5	2X6 WIND BEAM @ 192" OC (SITE-INSTALLED) (OFF STD. OR EQ.)	REVISION: 1-4-94 BY: JB
6	2X6 RAFTERS @ 192" OC (16" OC OPT.) (OFF STD. OR EQ.)	REVISION: 1-4-94 BY: JB
7	1/6" OGB ROOF SHEATHING	REVISION: 1-4-94 BY: JB
8	2X4 KNEEWALL @ 192" OC (16" OC OPT.) (OFF STD. OR EQ.)	REVISION: 1-4-94 BY: JB
9	KNEEWALL HINGE	REVISION: 1-4-94 BY: JB
10	3/4" FLOOR SHEATHING & 2X10 CEILING JOIST @ 192" OC (OFF STD. OR EQ.)	REVISION: 1-4-94 BY: JB
11	1/2" PLYWOOD GUSSET EA. SIDE	REVISION: 1-4-94 BY: JB
12	1/2" DIAMETER BOLT	REVISION: 1-4-94 BY: JB
13	CONTINUOUS PERIMETER BAND (2 OFF OR EQ.)	REVISION: 1-4-94 BY: JB
14	VINYL FASCIA BOARD (CEDAR/HARDPLANK OPTIONAL)	REVISION: 1-4-94 BY: JB
15	VINYL CONT. VENTED SOFFIT (CEDAR OPTIONAL)	REVISION: 1-4-94 BY: JB
16	1/6" OGB SHEATHING	REVISION: 1-4-94 BY: JB
17	VINYL EXTERIOR SIDING (CEDAR/HARDPLANK OPTIONAL)	REVISION: 1-4-94 BY: JB
18	DOUBLE PERIMETER BAND 2X10 (2 OFF OR EQ.)	REVISION: 1-4-94 BY: JB
19	2X6 P.T. BILL PLATE AND ANCHOR BOLT	REVISION: 1-4-94 BY: JB
20	FOUNDATION WALL & CONC. FOOTER	REVISION: 1-4-94 BY: JB
21	1/2" WALL GYPSUM	REVISION: 1-4-94 BY: JB
22	R-13 WALL INSULATION (R-13 W/ 2x6 Opt.)	REVISION: 1-4-94 BY: JB
23	2X4 STUDS @ 16" OC (OPL 2x6 @ 24" O.C.) (2 OFF OR EQ.)	REVISION: 1-4-94 BY: JB
24	3/4" PLYD. OR OGB FLOOR SHEATHING	REVISION: 1-4-94 BY: JB
25	2X3 MATING WALL STUDS @ 16" OC (OFF STD. OR EQ.)	REVISION: 1-4-94 BY: JB
26	3/8" PLYWOOD MATING WALL SHEATHING	REVISION: 1-4-94 BY: JB
27	R-13 FLOOR INSULATION	REVISION: 1-4-94 BY: JB
28	BASEMOULD	REVISION: 1-4-94 BY: JB
29	1/2" X 10" BOLTS @ 6" OC (SITE INST.)	REVISION: 1-4-94 BY: JB
30	CONCRETE	REVISION: 1-4-94 BY: JB
31	CONC. FOOTER	REVISION: 1-4-94 BY: JB
32	3" STEEL COLLUMS	REVISION: 1-4-94 BY: JB
33	CONCRETE GLASS FLOOR	REVISION: 1-4-94 BY: JB
34	GRAVEL & VAPOR BARRIER	REVISION: 1-4-94 BY: JB
35	CONC. FOOTER	REVISION: 1-4-94 BY: JB
36	EARTH	REVISION: 1-4-94 BY: JB
37	EXPANSION JOINT	REVISION: 1-4-94 BY: JB
38	FOUNDATION WALL (CONC. BLK OR POURED CONC.)	REVISION: 1-4-94 BY: JB
39	DRAIN TILE W/ GRAVEL SURROUND	REVISION: 1-4-94 BY: JB
40	SOLID CAP (IF REQUIRED)	REVISION: 1-4-94 BY: JB
41	TERMITE SHIELD (IF REQUIRED)	REVISION: 1-4-94 BY: JB
42	STUCCO & DAMP PROOFING	REVISION: 1-4-94 BY: JB
43	ANCHOR BOLT @ 6" - 8" O.C. MIN (OR STRAPS)	REVISION: 1-4-94 BY: JB
44	2X6 PRESSURE TREATED BILL PLATE	REVISION: 1-4-94 BY: JB
45	STAIR SYSTEM 2X10 STRINGERS, RIGERS & TREADS (2 OFF STD. OR EQ.)	REVISION: 1-4-94 BY: JB
46	HANDRAIL	REVISION: 1-4-94 BY: JB
47	HANDRAIL BRACKETS (SHIPPED LOOSE)	REVISION: 1-4-94 BY: JB
48	R-30 CEILING INSULATION PLANT INSTALLED	REVISION: 1-4-94 BY: JB
49	DORMER RAFTER HEADER (2 OFF STD. OR EQ.)	REVISION: 1-4-94 BY: JB
50	2X4 FRONT DORMER WALL WINDOW (OFF STD. OR EQ.)	REVISION: 1-4-94 BY: JB
51	DORMER TRUSSES-SITE INST. (OPT. PRE-BUILT) (OFF STD. OR EQ.)	REVISION: 1-4-94 BY: JB
52	SITE INSTALLED INSULATION Baffles	REVISION: 1-4-94 BY: JB
53	DORMER SIDE WALL-SITE INST. (OPT. PRE-BUILT) (OFF STD. OR EQ.)	REVISION: 1-4-94 BY: JB
54	DORMER SADDLE FRAMING (SITE INSTALLED) (OFF STD. OR EQ.)	REVISION: 1-4-94 BY: JB
55	DEL. 2X10 HEADER (2 OFF STD. OR EQ.)	REVISION: 1-4-94 BY: JB
56	CONT. DEL. 2X6 (2 OFF STD. OR EQ.)	REVISION: 1-4-94 BY: JB
57	DEL. 2X4 TOP PLATE (OFF STD. OR EQ.)	REVISION: 1-4-94 BY: JB
58	2X10 FLR JOISTS @ 192" O.C. (2X10 @ 16" O.C. OPT.) (2 OFF STD. OR EQ.)	REVISION: 1-4-94 BY: JB
59	2X2 LEDGER OR EQUAL (2 OFF STD. OR EQ.)	REVISION: 1-4-94 BY: JB
60	1/2" CEILING GYPSUM	REVISION: 1-4-94 BY: JB
61	DEL. 2X10 (2 OFF STD. OR EQ.) GIRDER EA. SIDE	REVISION: 1-4-94 BY: JB

GENERAL NOTES:

- ALL CONSTRUCTION BELOW BOTTOM OF FLOOR JOIST RESPONSIBILITY OF SITE CONTRACTOR.
- ALL INFORMATION SHOWN BELOW BOTTOM OF FLR JOIST IS SUGGESTIVE ONLY. REFER TO STATE AND LOCAL CODES FOR ACTUAL CONSTRUCTION METHODS REQUIRED.
- REFER TO FOUNDATION PLAN FOR LOCATION OF PIERS/COLLUMS.
- R-VALUES SHOWN ON SECTION REFLECT COMPLETE ASSEMBLY. ENERGY PERFORMANCE MET BY INCREASE OF ROOF & FLOOR TOTAL R-VALUES WHICH EXCEEDS CURRENT STATE ENERGY REQUIREMENTS.
- CONSTRUCTION OF BASEMENT STAIRS BY PURCHASER.
- MIN 6" FROM GRADE TO STRUCTURAL LUMBER.
- MIN 6" FROM GRADE TO EXTERIOR SIDING.
- PURCHASER TO REFER TO BUILDER RESPONSIBILITY BULLETIN INSTRUCTIONS FOR ERECTION COMPLETION REQUIREMENTS.

1000 RIVERS ROAD
MARTIN, TENNESSEE 38201
NATIONWIDE HOMES
© COPYRIGHT 1993 NATIONWIDE HOMES INC.
ALL RIGHTS RESERVED.

TYPICAL 28 WIDE CAPE COD
WALL SECTION

JOB NAME:
JOB NUMBER:
CONTRACT #:
REVISION: 1/20/93 BY: JB
REVISION: 1/20/93 BY: JB
PAGE NUMBER:
21 OF 46
5636

U:\FLORIDA WINSTON #91636 KENT HARRIS\5191636.dwg, 7/13/2001 3:18:14 PM, Printed by: Eddie Williams

STANDARD SINGLE & DOUBLE HUNG VINYL WINDOWS									
DESIGN CODE	SIZE	ROUGH OPENINGS		8% LIGHT (SQFT.)				4% VENTILATION (SQFT.)	
		W SINGLE	H	W TWIN	H	SINGLE FLOOR AREA	TWIN FLOOR AREA	SINGLE FLOOR AREA	TWIN FLOOR AREA
1/16x5/16-1856	1/8 X 5/8	22 3/4" X 6 1/2"	45 3/8" X 6 1/2"	11 1/4	8 1/2	8 1/2	11 1/4	8 1/2	11 1/4
2/1x3/3-2430	2/1 X 3/3	30 3/4" X 3 1/2"	61 5/8" X 3 1/2"	5 1/4	11 1/4	11 1/4	14 1/2	5 1/4	11 1/4
3/10x3/8-2830	3/10 X 3/8	33" X 4 1/2"	66"	8 3/3	13 1/2	13 1/2	16 1/2	8 3/3	13 1/2
3/10x4/5-2842	3/10 X 4/5	35 3/4" X 13 3/8"	71 1/8" X 13 3/8"	10 6/9	13 3/8	13 3/8	16 1/2	10 6/9	13 3/8
3/10x4/5-2846	3/10 X 4/5	35 3/4" X 5 1/8"	71 1/8" X 5 1/8"	9 3/5	11 1/2	11 1/2	14 1/2	9 3/5	11 1/2
3/10x5/5-2852	3/10 X 5/5	35 3/4" X 6 1/2"	71 1/8" X 6 1/2"	10 1/3	13 1/3	13 1/3	16 1/2	10 1/3	13 1/3
3/10x5/11-2854	3/10 X 5/11	35 3/4" X 6 1/2"	71 1/8" X 6 1/2"	10 1/3	13 1/3	13 1/3	16 1/2	10 1/3	13 1/3
3/10x5/10-2856	3/10 X 5/10	35 3/4" X 6 1/2"	71 1/8" X 6 1/2"	11 1/4	14 1/2	14 1/2	17 1/2	11 1/4	14 1/2
4/10x1/8-2856	4/10 X 1/8	48 1/2" X 2 1/2"	96 1/4" X 2 1/2"	9 4/4	11 1/2	11 1/2	14 1/2	9 4/4	11 1/2
1352	1/3 X 5/2 BAY	8 3/8" X 6 1/2"	16 5/8" X 6 1/2"	2 1/2	3 1/2	3 1/2	4 1/2	2 1/2	3 1/2
2810	2/1 X 3/3	30 3/4" X 3 1/2"	61 5/8" X 3 1/2"	5 1/4	11 1/4	11 1/4	14 1/2	5 1/4	11 1/4
PALLADIUM	1/8x28x1/8x4/2	8EE DETAIL	DECOR WINDOW	18 1/2	22 1/2	22 1/2	28 1/2	18 1/2	22 1/2
BLOCK WD.	3/6x3/6	42 1/2" X 42 1/2"	DECOR WINDOW	12 1/2	15 1/2	15 1/2	19 1/2	12 1/2	15 1/2
1810 TRANSOM	1/8 X 1/8	20 1/2" X 12 1/2"	40 5/4" X 12 1/2"	4 1/2	5 1/2	5 1/2	6 1/2	4 1/2	5 1/2
2410 TRANSOM	2/4 X 1/8	28 1/2" X 12 1/2"	56 1/4" X 12 1/2"	5 1/2	7 1/2	7 1/2	9 1/2	5 1/2	7 1/2
2810 TRANSOM	2/8 X 1/8	32 1/2" X 12 1/2"	64 1/4" X 12 1/2"	6 1/2	8 1/2	8 1/2	10 1/2	6 1/2	8 1/2
3010 TRANSOM	3/10 X 1/8	36 1/2" X 12 1/2"	72 1/4" X 12 1/2"	7 1/2	9 1/2	9 1/2	11 1/2	7 1/2	9 1/2
4010 TRANSOM	4/10 X 1/8	48 1/2" X 12 1/2"	96 1/4" X 12 1/2"	9 1/2	11 1/2	11 1/2	14 1/2	9 1/2	11 1/2
5010 TRANSOM	5/10 X 1/8	60 1/2" X 12 1/2"	120 1/4" X 12 1/2"	11 1/2	14 1/2	14 1/2	17 1/2	11 1/2	14 1/2
6010 TRANSOM	6/10 X 1/8	72 1/2" X 12 1/2"	144 1/4" X 12 1/2"	14 1/2	17 1/2	17 1/2	21 1/2	14 1/2	17 1/2
TRFL 2852	3/10 X 5/6	10 1/8" X 6 1/2"	20 1/4" X 6 1/2"	3 1/2	4 1/2	4 1/2	5 1/2	3 1/2	4 1/2
TRFL 2856	3/10 X 5/10	10 1/8" X 6 1/2"	20 1/4" X 6 1/2"	3 1/2	4 1/2	4 1/2	5 1/2	3 1/2	4 1/2
1/16x5/16-1856	1/8 X 5/8	22 3/4" X 8 1/2"	45 3/8" X 8 1/2"	8 3/4	11 1/4	11 1/4	14 1/2	8 3/4	11 1/4
2/1x3/3-2430	2/1 X 3/3	30 3/4" X 5 1/2"	61 5/8" X 5 1/2"	8 1/4	10 1/4	10 1/4	12 1/2	8 1/4	10 1/4
3/10x3/8-2830	3/10 X 3/8	35 3/4" X 7 1/2"	71 1/8" X 7 1/2"	13 1/2	16 1/2	16 1/2	19 1/2	13 1/2	16 1/2
3/10x5/10-2856	3/10 X 5/10	35 3/4" X 8 1/2"	71 1/8" X 8 1/2"	14 1/2	17 1/2	17 1/2	21 1/2	14 1/2	17 1/2
TRFL 2852	3/10 X 5/6	10 1/8" X 7 1/2"	20 1/4" X 7 1/2"	4 1/2	5 1/2	5 1/2	6 1/2	4 1/2	5 1/2
TRFL 2856	3/10 X 5/10	10 1/8" X 8 1/2"	20 1/4" X 8 1/2"	4 1/2	5 1/2	5 1/2	6 1/2	4 1/2	5 1/2

VINYL CASEMENT WINDOWS									
DESIGN CODE	SIZE	ROUGH OPENINGS		8% LIGHT (SQFT.)				4% VENTILATION (SQFT.)	
		W SINGLE	H	W TWIN	H	SINGLE FLOOR AREA	TWIN FLOOR AREA	SINGLE FLOOR AREA	TWIN FLOOR AREA
C-2430	2/4 X 3/10	29" X 36 1/2"	57 1/2" X 36 1/2"	5 1/4	11 1/4	11 1/4	14 1/2	5 1/4	11 1/4
C-2440	2/4 X 4/10	29" X 48 1/2"	57 1/2" X 48 1/2"	9 1/8	14 1/8	14 1/8	17 1/8	9 1/8	14 1/8
C-2446	2/4 X 4/6	29" X 53 3/8"	57 1/2" X 53 3/8"	9 1/2	15 1/2	15 1/2	18 1/2	9 1/2	15 1/2
4040	4/10 X 4/10	48 1/2" X 48 1/2"	TEMPERED GLASS	15 1/2	19 1/2	19 1/2	23 1/2	15 1/2	19 1/2
C-2430	2/4 X 3/10	29" X 50"	57 1/2" X 50"	11 1/8	14 1/8	14 1/8	17 1/8	11 1/8	14 1/8
C-2440	2/4 X 4/10	29" X 62"	57 1/2" X 62"	11 1/8	14 1/8	14 1/8	17 1/8	11 1/8	14 1/8
C-2446	2/4 X 4/6	29" X 67"	57 1/2" X 67"	12 1/2	15 1/2	15 1/2	18 1/2	12 1/2	15 1/2

NOTE: GLAZING FOR ALL VINYL WINDOWS MEET OR EXCEED GLAZING PRESSURES FOR 3 STORY-130 (3-SEC. GUST) MN ZONES

OPTIONAL WOOD CASEMENT WINDOWS

NOTE: WOOD WINDOWS TO BE HIGH WIND HIGH PERFORMANCE TYPE FOR WIND ZONES 100 TO 110 MPH (Fastest Mile)									
SINGLE		TWIN		SINGLE		TWIN		SINGLE	
CW3	2/4 X 3/10	28 7/8" X 36 1/2"	CW23	57 1/8" X 36 1/2"	5 1/2	65 1/2	10 1/2	13 1/2	24 1/2
CW4	2/4 X 4/10	28 7/8" X 48 1/2"	CW24	57 1/8" X 48 1/2"	7 1/2	90 1/2	14 1/2	18 1/2	34 1/2
CW45	2/4 X 4/6	28 7/8" X 53 3/8"	CW45-2	57 1/8" X 53 3/8"	8 1/2	100 1/2	16 1/2	20 1/2	37 1/2

EMERGENCY EGRESS REQUIREMENTS:
1. SIZES W/ "*" NOTATION INDICATES WINDOW MEETS 5.7 SQFT. EMERGENCY EGRESS REQMT.
2. "*" WINDOWS MEET MIN 20" WIDTH & 24" HEIGHT CLEAR OPENING REQMT.
3. MIN OF 1 EGRESS WINDOW OR EXTERIOR DOOR SHALL BE LOCATED IN EACH SLEEPING ROOM.

PFS APPROVED
DATE 7/12/07
PFS CORPORATION
Cottage Grove, WI



NATIONWIDE HOMES
Web Site: www.nationwide-homes.com

PLAN NAME: DOOR & WINDOW SCHEDULE

SERIES: ALL MODELS

DESIGN DATE: 12-16-96 DWG BY: CK BY: JDS

REV. DATE: 12-16-96

REV. DATE: 12-16-96

PURCHASER: TYPICAL ALL PLANS

JOB NO.

CONTRACT NO.

PROCESS DATE:

ORDER REVISION DATE:

PRODUCTION DATE:

DWG. BY:

CHECK BY:

DWG. BY:

DWG. BY:

PAGE NO.

22

OF

46

9636

Diagram showing various window and door configurations, including transoms, awnings, and casement windows, with labels for design codes and sizes.

Diagram showing various door configurations, including sliding doors, patio doors, and exterior doors, with labels for design codes and sizes.

Diagram showing various window and door configurations, including transoms, awnings, and casement windows, with labels for design codes and sizes.

Diagram showing various door configurations, including sliding doors, patio doors, and exterior doors, with labels for design codes and sizes.