
 


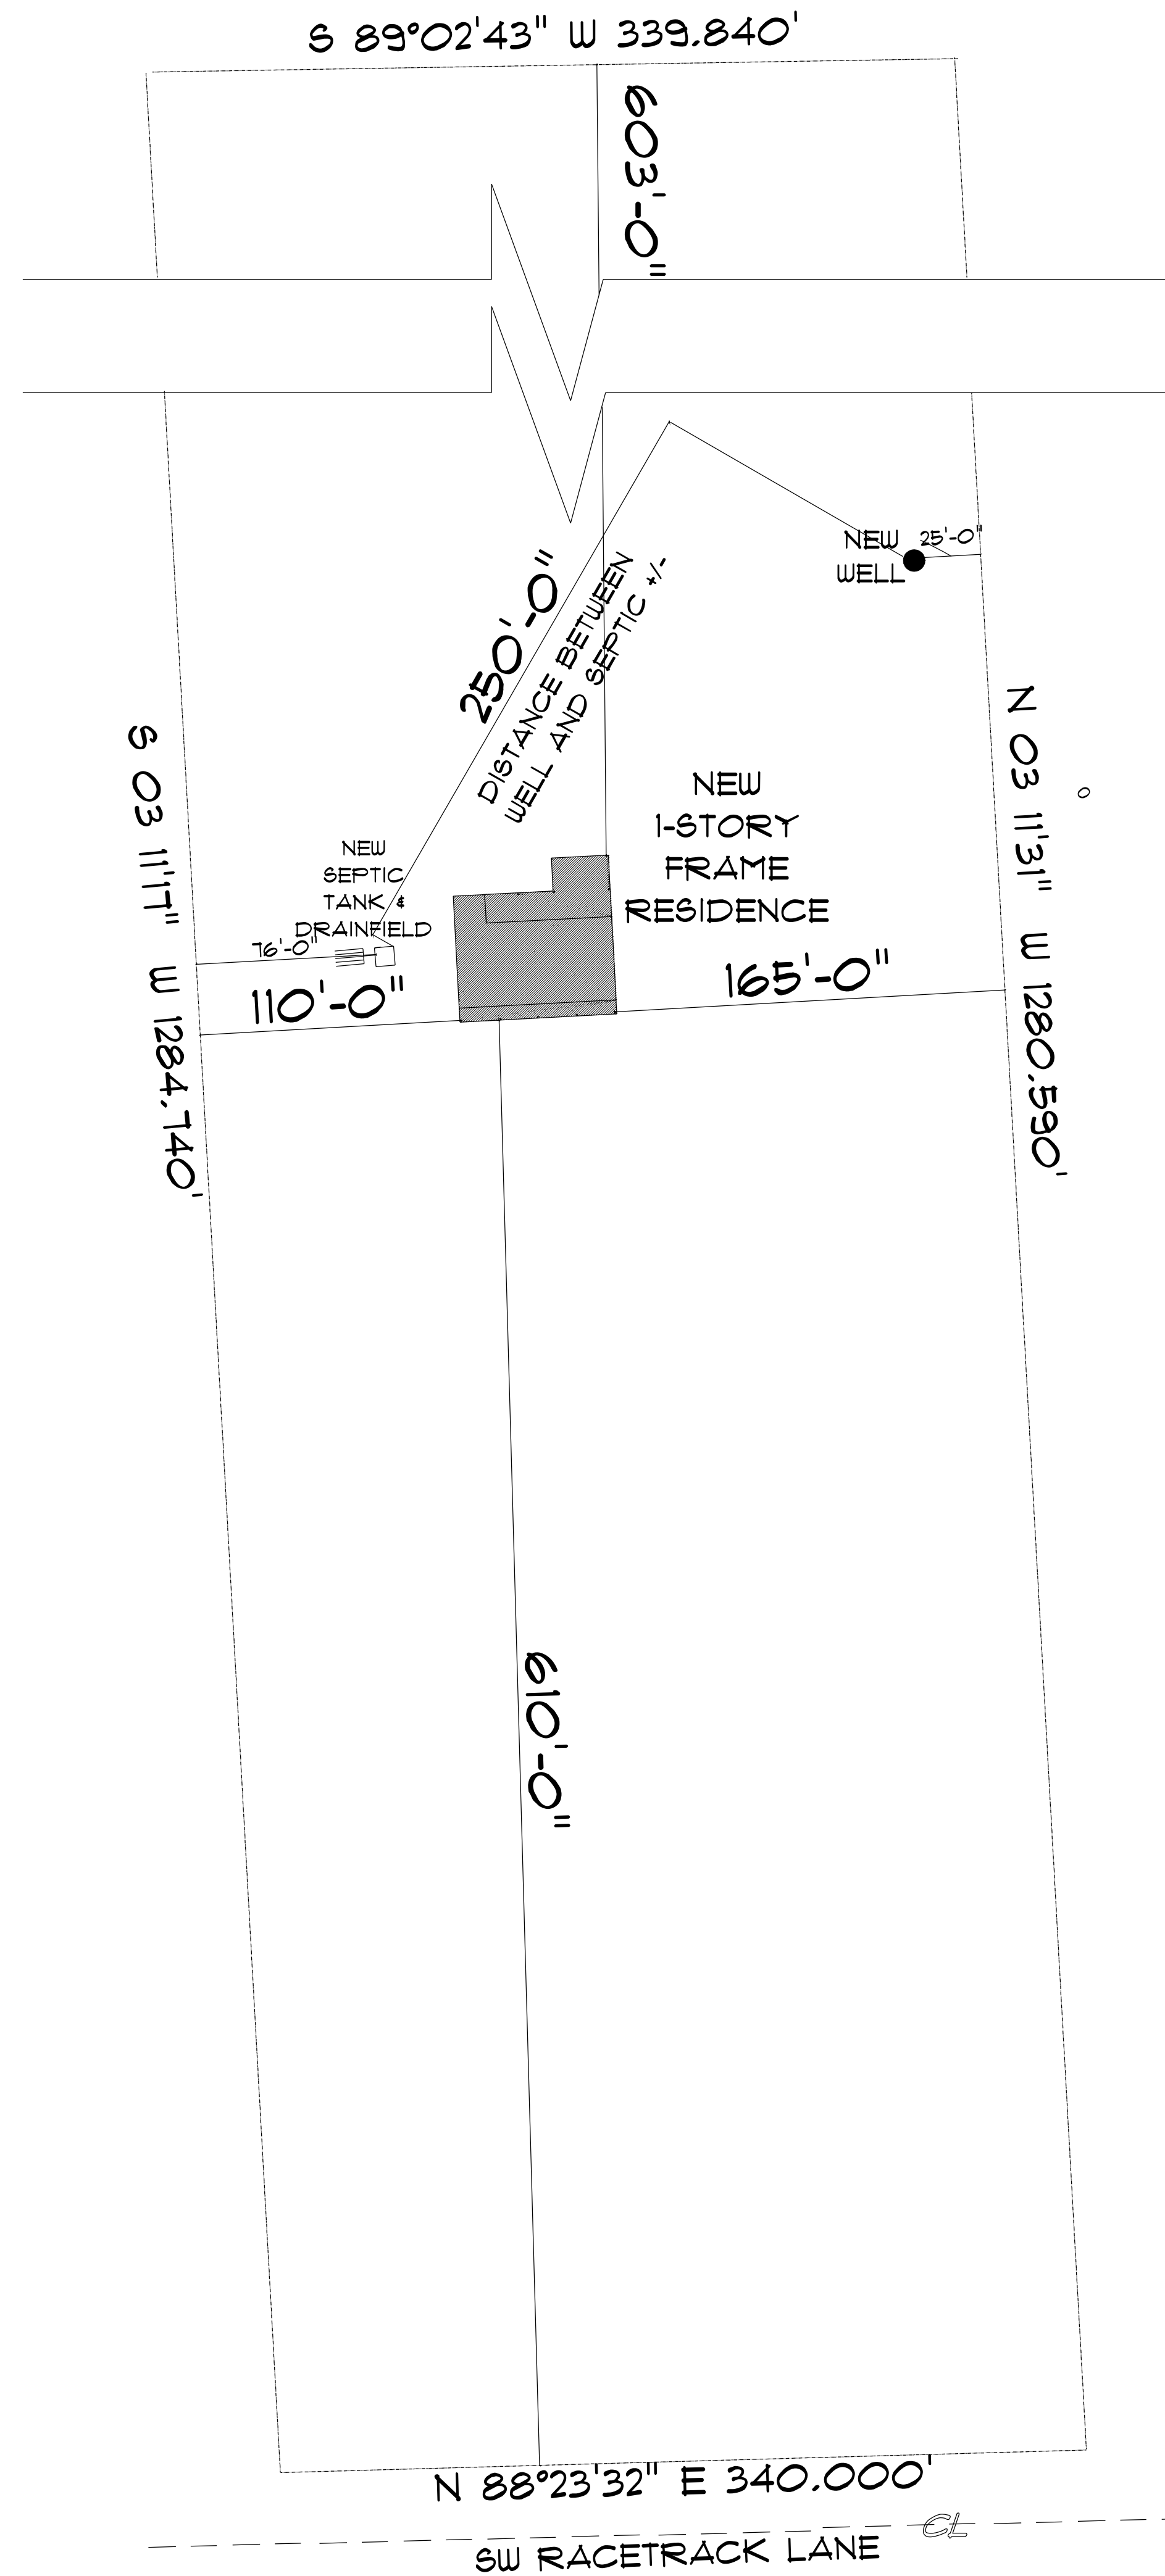

* SITE PLAN *

SCALE: 1" = 50'-0"



RESIDENCE
for
AUSTIN & KELSEY
BARBER

Teena M. Ruffo
2925 SW 8R 41
Lake City Florida, 32025
Cell: (386) 861-1191
Email: teenaruffo@gmail.com

PRINTED DATE:
Wednesday, June 5, 2024

DRAWN BY: Teena M. Ruffo
CHECKED BY:


BUILDING CONTRACTOR

FINAL DATE:

JOB NUMBER:

DRAWING NUMBER
A-1

OF 6 SHEETS

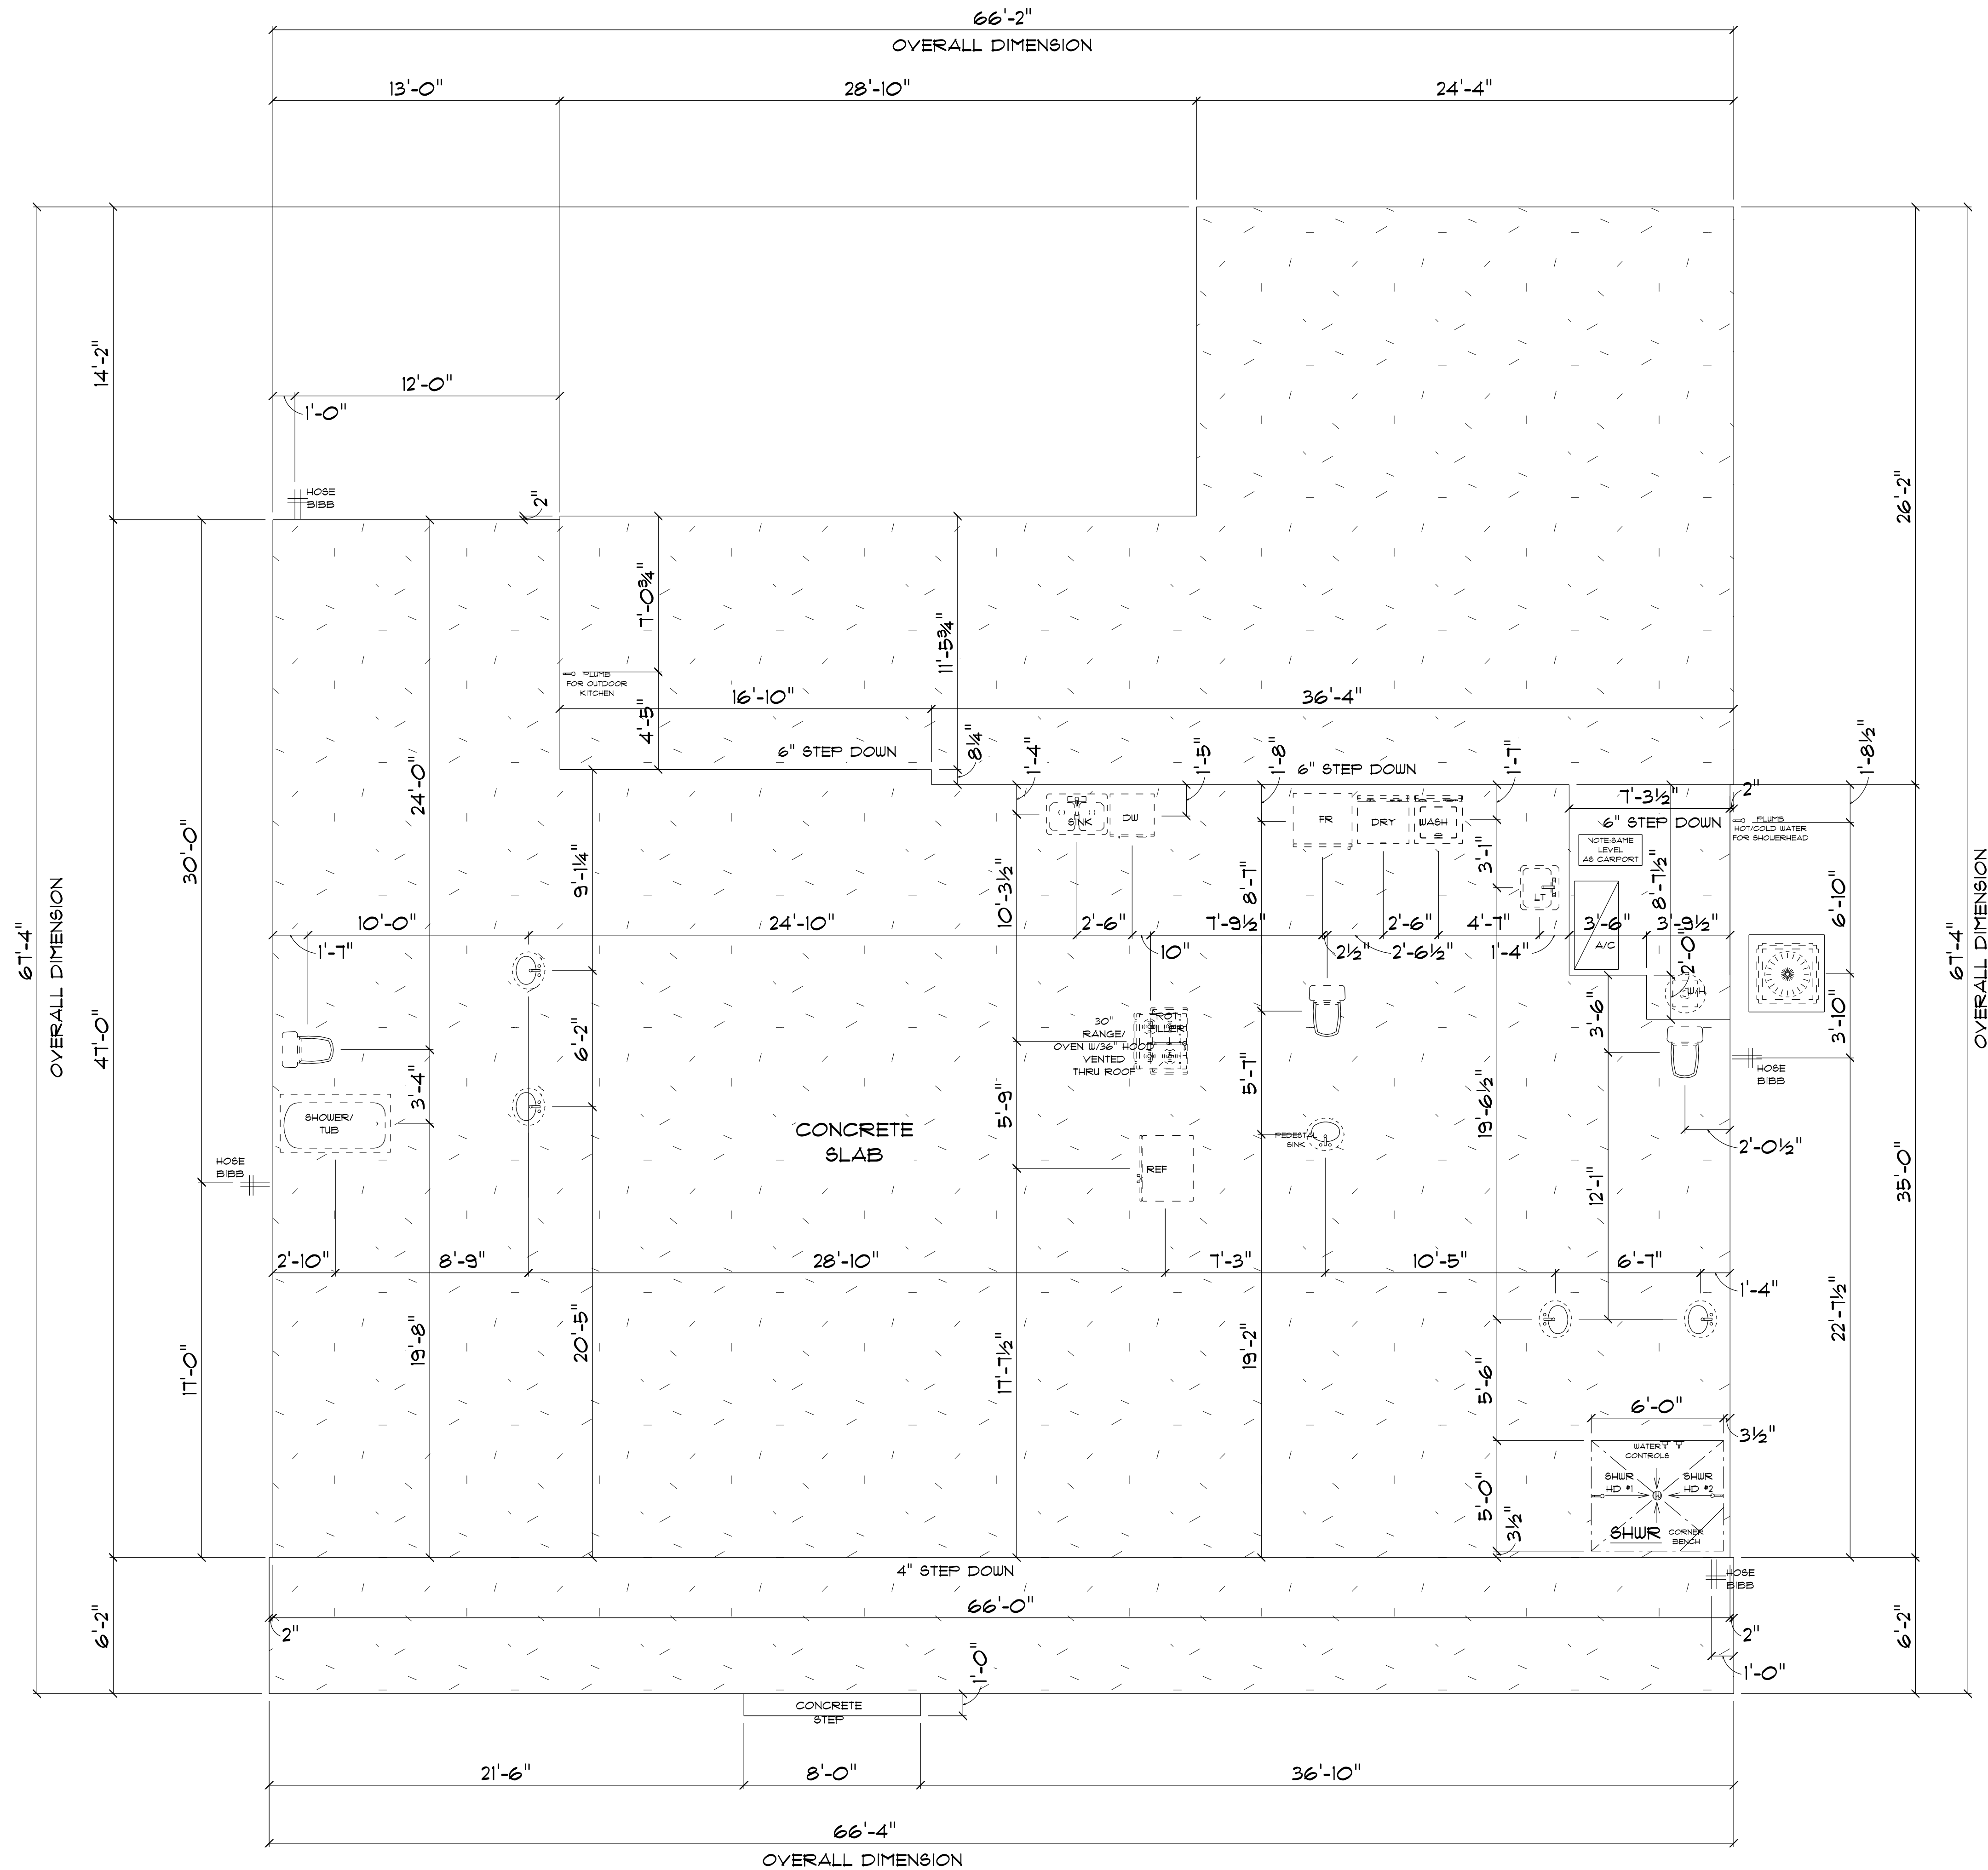

* PLUMBING &
* FOUNDATION PLAN *

SCALE : 1/4" = 1'-0"

- IMPORTANT NOTES:
1. IT IS THE BUILDER'S RESPONSIBILITY TO VERIFY ALL GEOMETRY AND DIMENSIONS BEFORE ORDERING ANY MATERIALS OR BEGINNING CONSTRUCTION.
 2. THESE PLANS ARE FOR LAYOUT AND DESIGN PURPOSES ONLY ALL STRUCTURAL NOTES AND DETAILS TO BE PROVIDED BY AN ENGINEER.

RESIDENCE
for
AUSTIN & KELSEY
BARBER

Teena M. Ruffo
2925 SW 8R 41
Lake City Florida, 32025
Cell: (386) 861-1191
Email: teenaruffo@gmail.com

PRINTED DATE:
Wednesday, June 5, 2024

DRAWN BY: Teena M. Ruffo

CHECKED BY:

BUILDING CONTRACTOR


FINAL DATE:

JOB NUMBER:

DRAWING NUMBER

A-2

OF 6 SHEETS

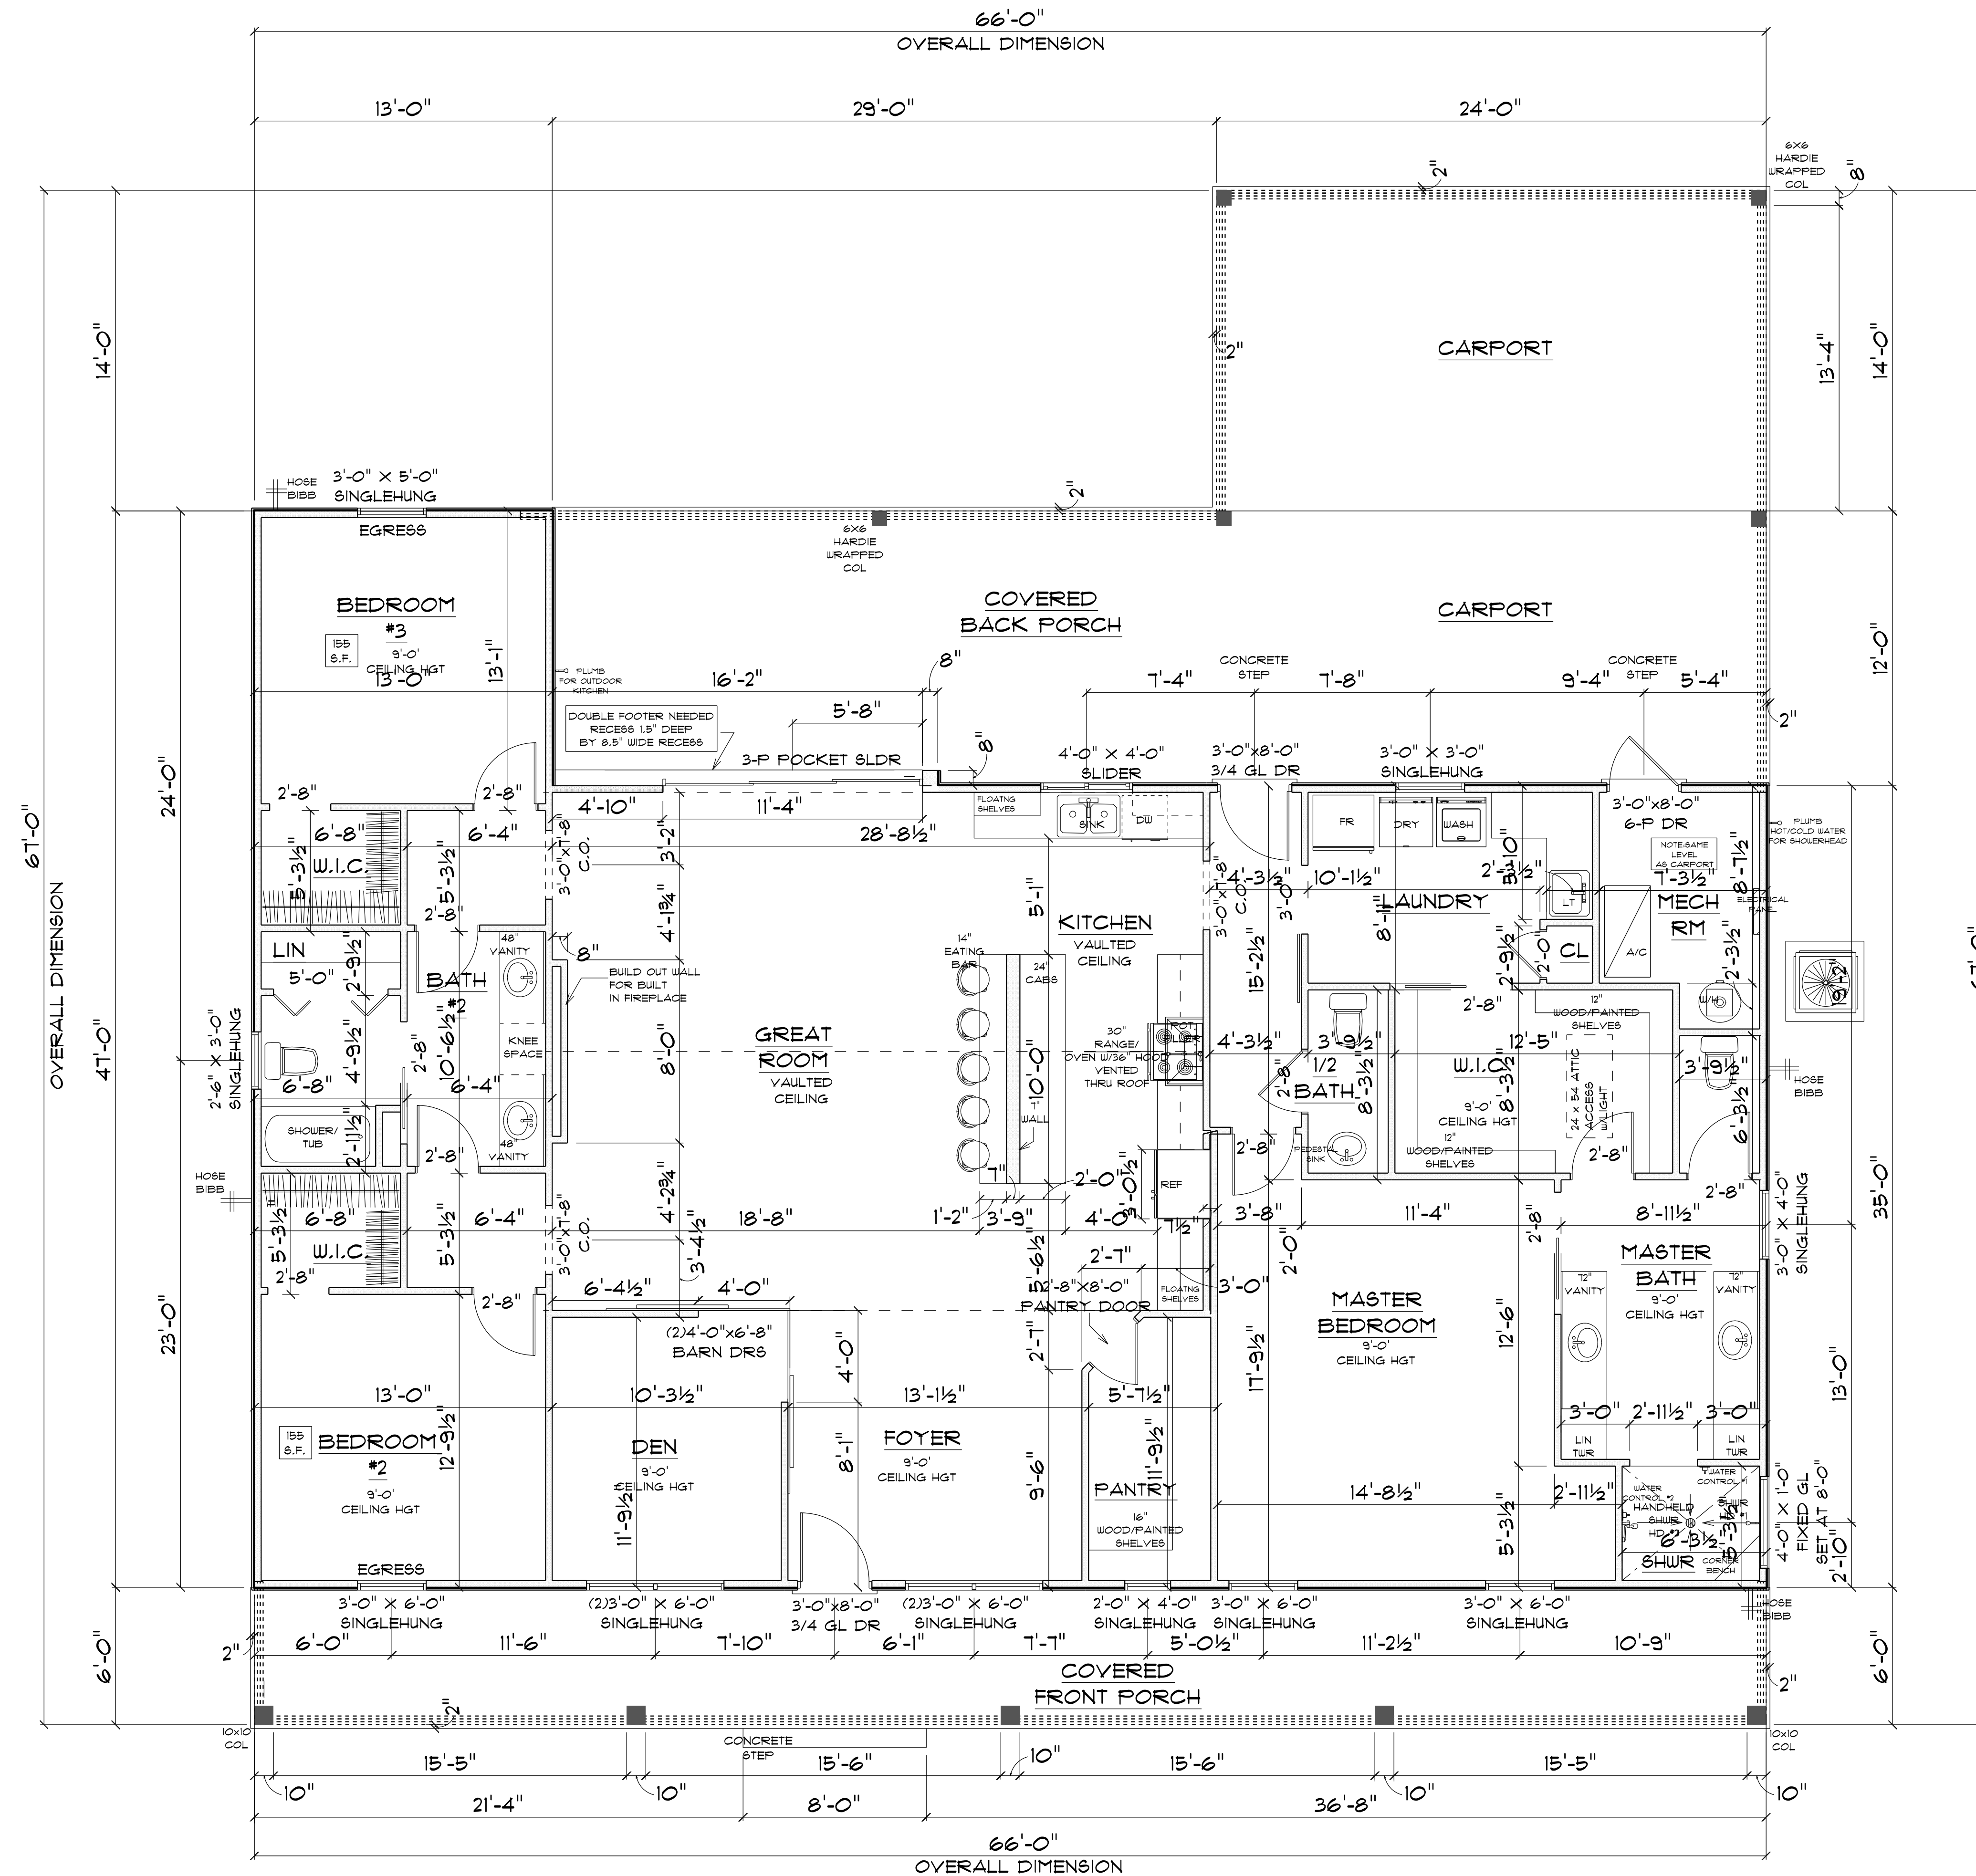

* FLOOR PLAN *

SCALE : 1/4" = 1'-0"

IMPORTANT NOTES:
1. IT IS THE BUILDERS RESPONSIBILITY TO VERIFY ALL GEOMETRY AND DIMENSIONS BEFORE ORDERING ANY MATERIALS OR BEGINNING CONSTRUCTION.
2. THESE PLANS ARE FOR LAYOUT AND DESIGN PURPOSES ONLY ALL STRUCTURAL NOTES AND DETAILS TO BE PROVIDED BY AN ENGINEER.

TOTAL A/C AREA UNDER ROOF	=	2466 S.F.
COVERED FRONT PORCH	=	394 S.F.
COVERED REAR PORCH	=	345 S.F.
2 CAR CARPORT	=	623 S.F.
TOTAL AREA UNDER ROOF	=	3,828 S.F.

RESIDENCE
for
AUSTIN & KELSEY
BARBER

Teresa M. Ruffo
2925 SW SR 47
Lake City Florida, 32025
Cell: (386) 867-1191
Email: tsernuffo@gmail.com

PRINTED DATE:
Wednesday, June 5, 2024

DRAWN BY: T.M. Ruffo

CHECKED BY:

BUILDING CONTRACTOR


FINAL DATE:

JOB NUMBER:

DRAWING NUMBER

A-3


OF 6 SHEETS

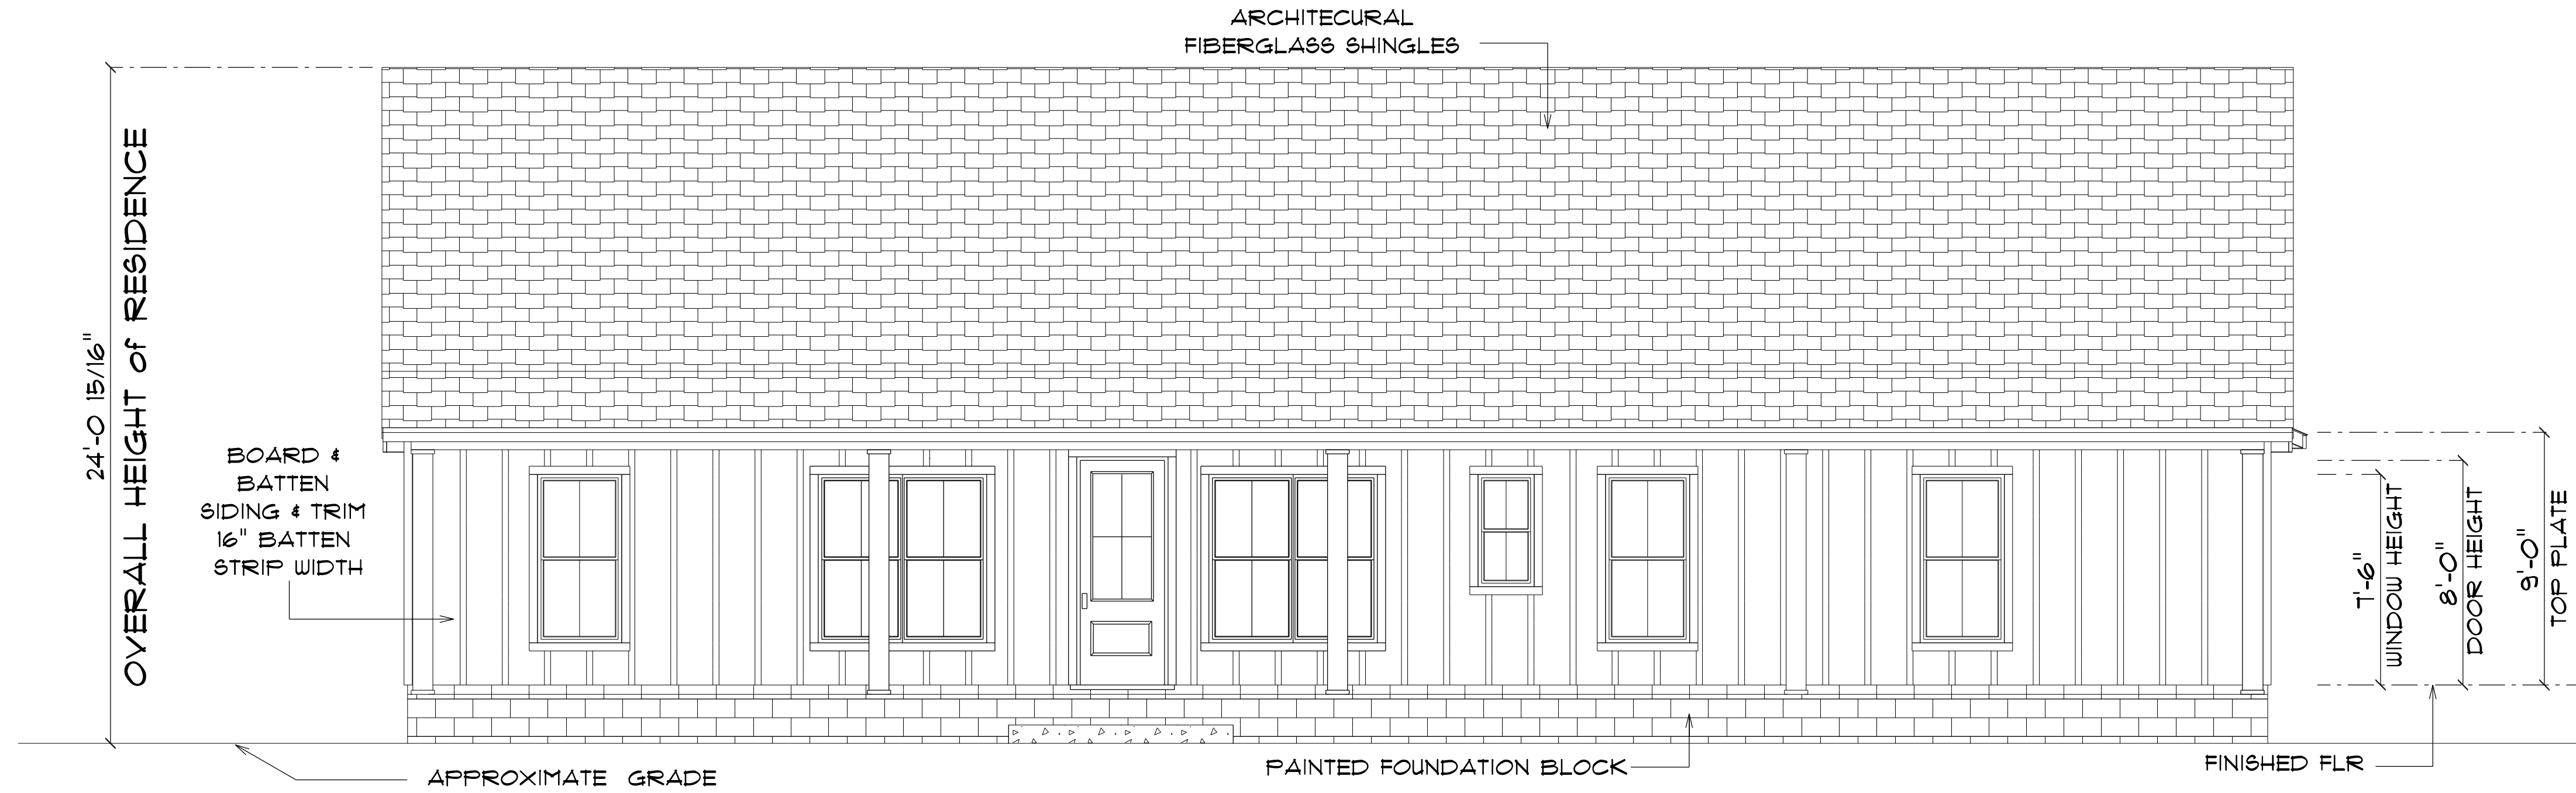

* FRONT ELEVATION *

SCALE : 1/4" = 1'-0"

NOTE: 12" OVERHANG GABLE ENDS
18" ALL OTHER EAVES

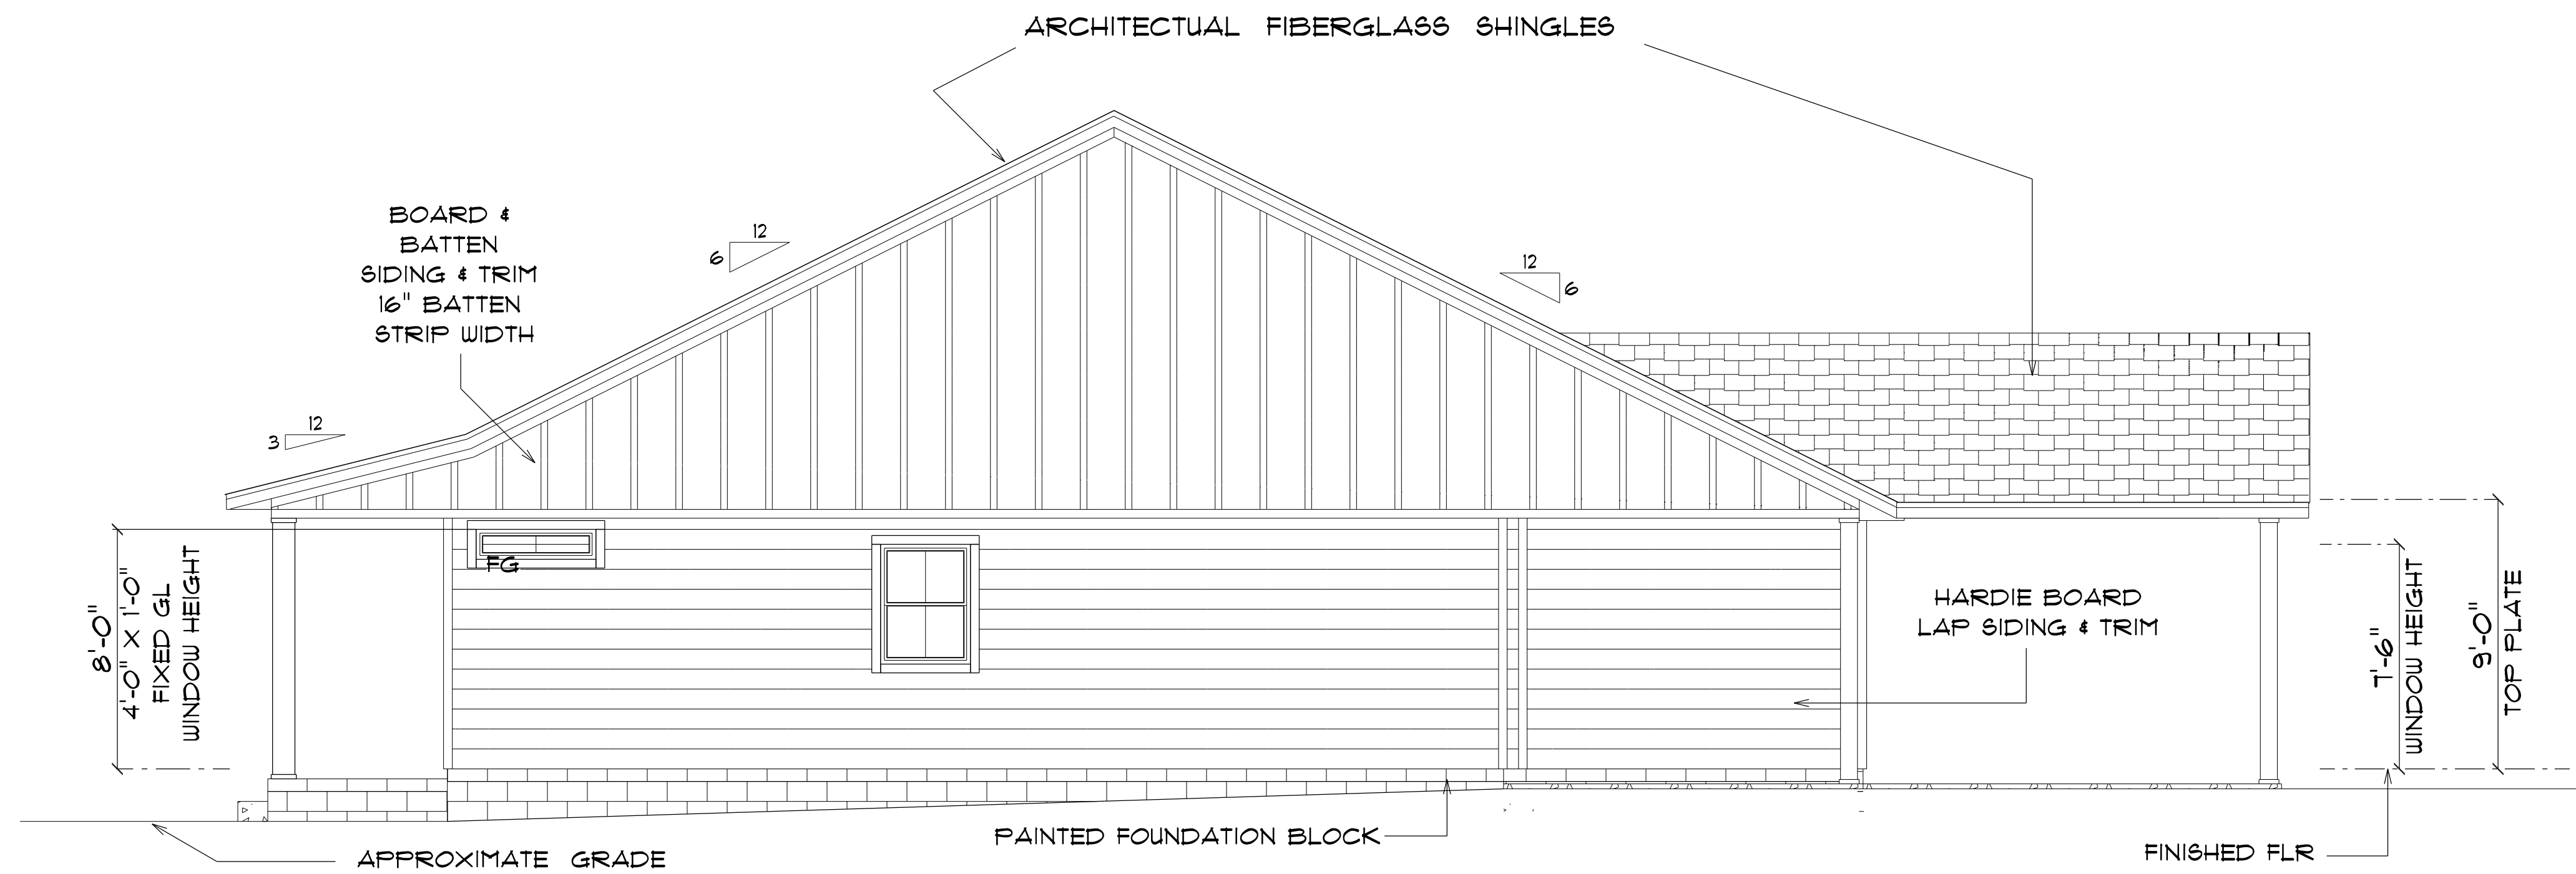

* RIGHT ELEVATION *

SCALE : 1/4" = 1'-0"

NOTE: 12" OVERHANG GABLE ENDS
18" ALL OTHER EAVES

RESIDENCE
for
AUSTIN & KELSEY
BARBER

Teena M. Ruffo
2925 SW SR 41
Lake City Florida, 32025
Cell: (386) 861-1191
Email: teenaruffo@gmail.com

PRINTED DATE:
Wednesday, June 5, 2024

DRAWN BY: Teena M. Ruffo CHECKED BY:

BUILDING CONTRACTOR


FINAL DATE:

JOB NUMBER:

DRAWING NUMBER

A-4


OF 6 SHEETS

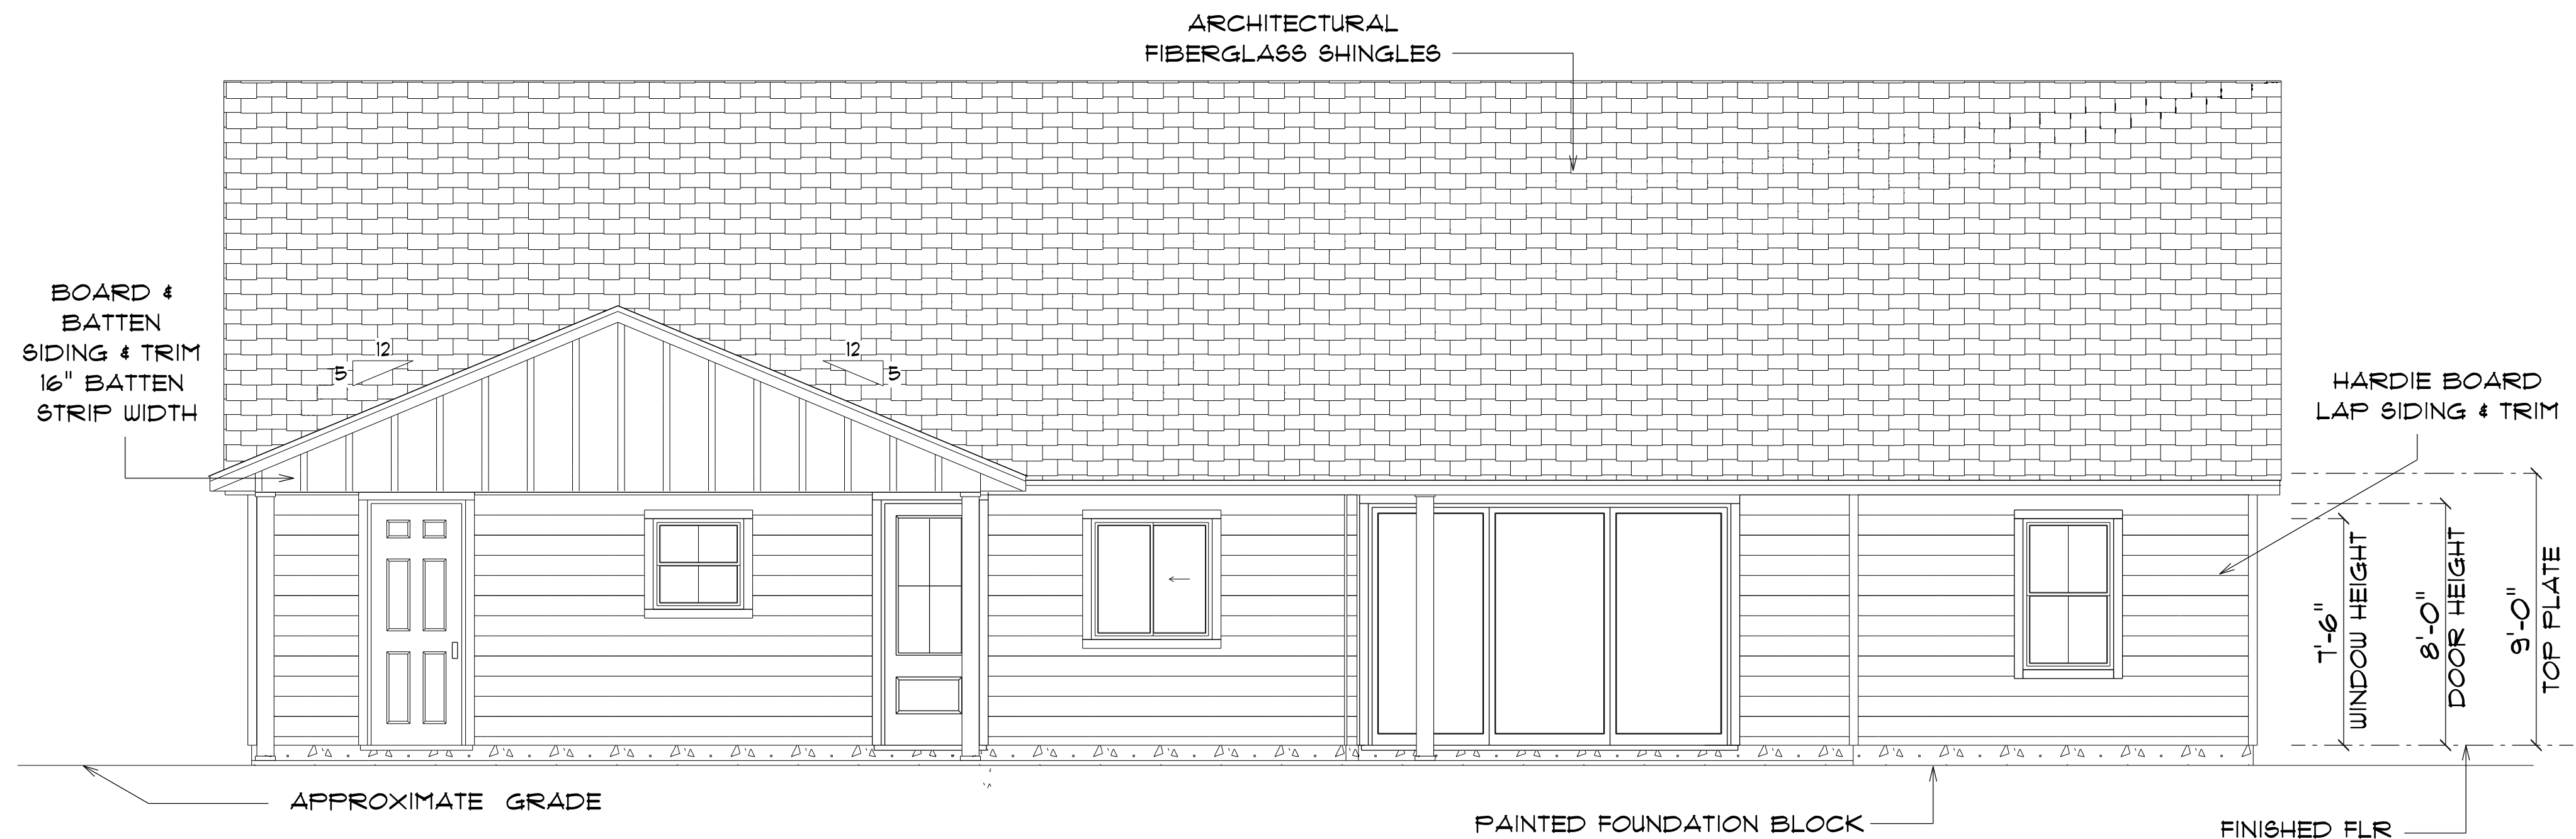

* REAR ELEVATION *

SCALE : 1/4" = 1'-0"

NOTE: 12" OVERHANG GABLE ENDS
18" ALL OTHER EAVES

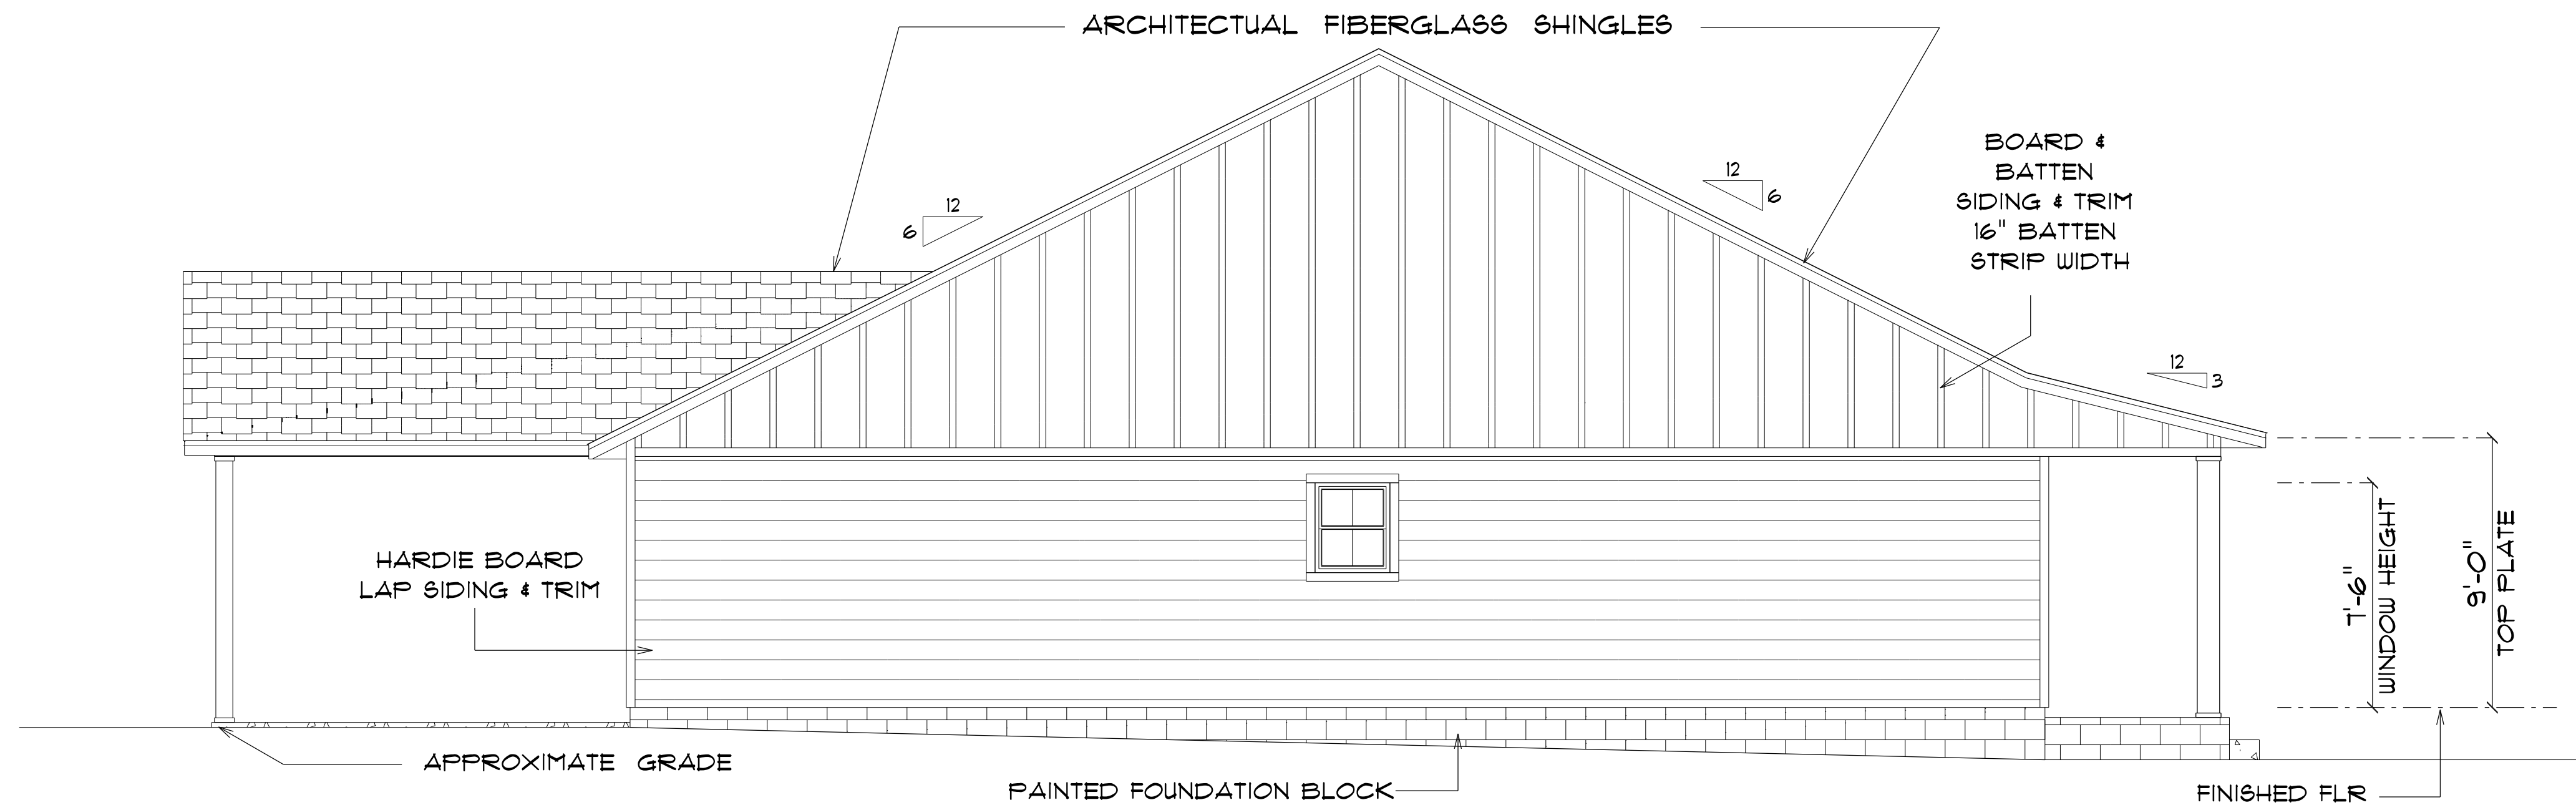

* LEFT ELEVATION *

SCALE : 1/4" = 1'-0"

NOTE: 12" OVERHANG GABLE ENDS
18" ALL OTHER EAVES

RESIDENCE
for
AUSTIN & KELSEY
BARBER

Teena M. Ruffo
2925 SW SR 47
Lake City Florida, 32025
Cell: (386) 861-1191
Email: teenaruffo@gmail.com

PRINTED DATE:
Wednesday, June 5, 2024

DRAWN BY: Teena M. Ruffo CHECKED BY:

BUILDING CONTRACTOR


FINAL DATE:

JOB NUMBER:

DRAWING NUMBER

A-5

OF 6 SHEETS

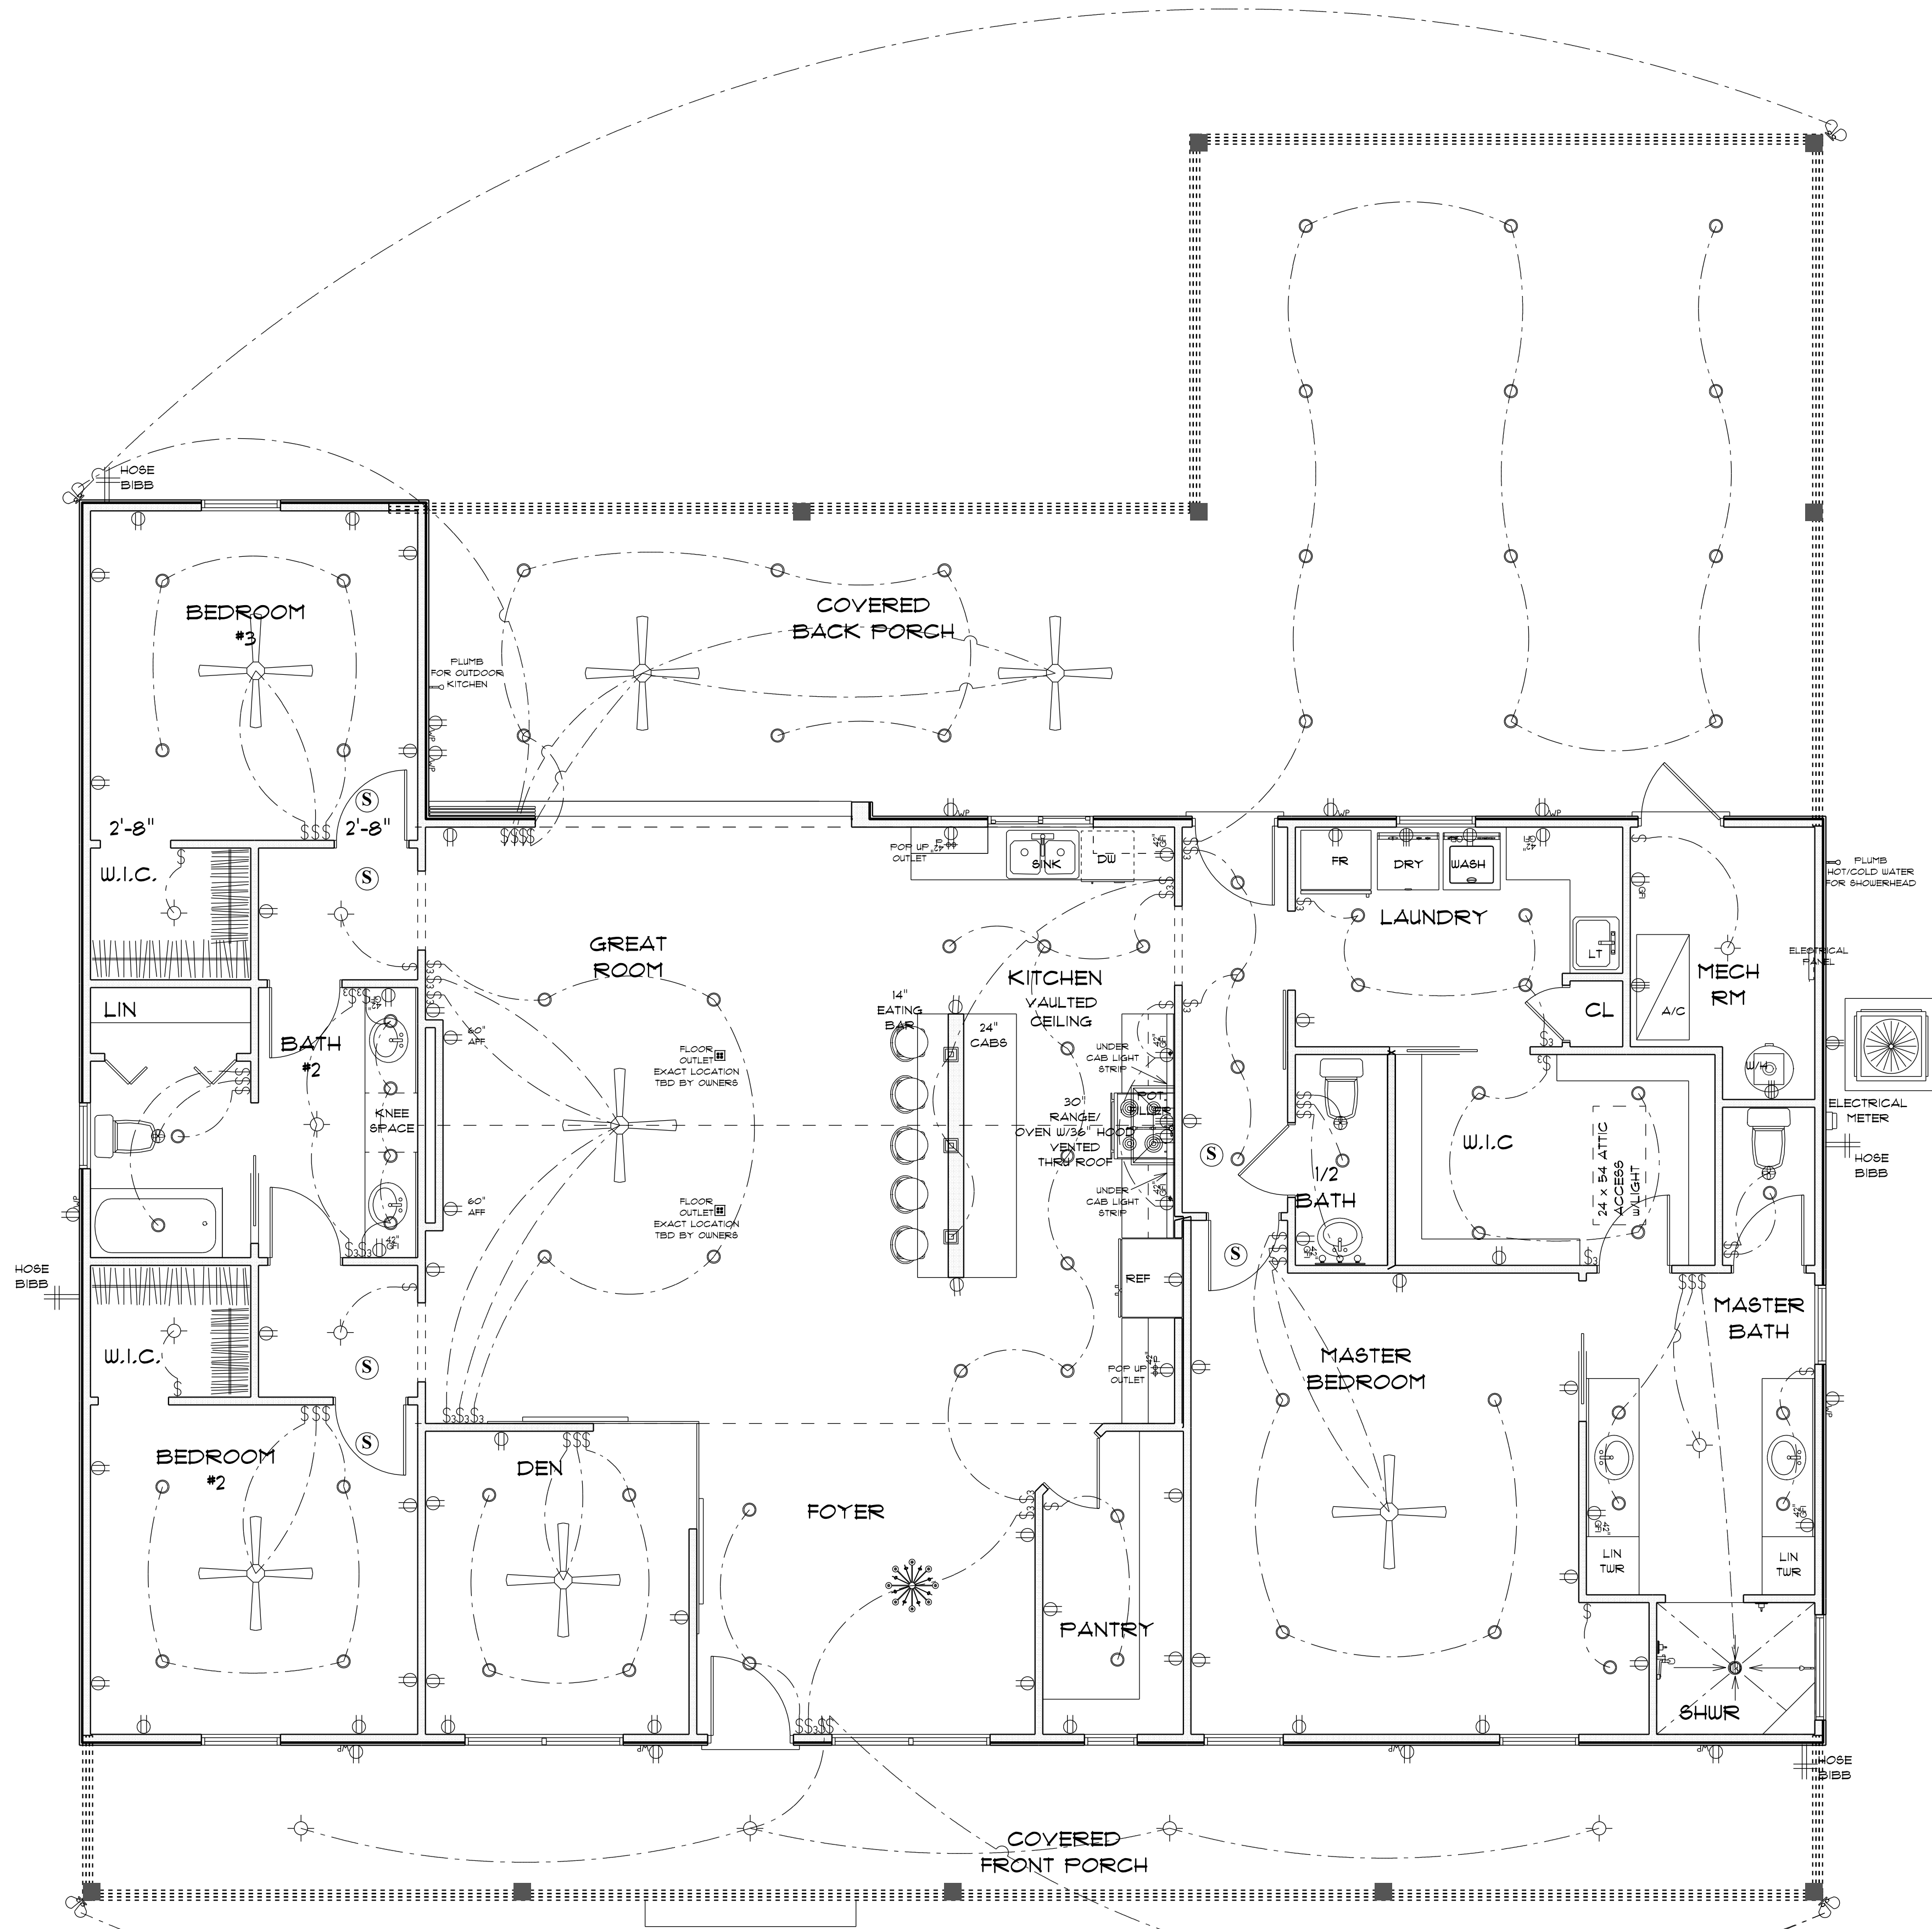

ELECTRICAL LEGEND		
ELECTRICAL	COUNT	SYMBOL
ceiling fan	7	
ceiling classic	1	
pendant large	3	
wafer light	76	
Under Cab Light Strip	2	
spotlight double	4	
Smoke Detector	6	
electrical panel	1	
floor outlet double	2	
light	11	
outlet	47	
outlet 220v	5	
outlet gfi	11	
outlet wp	11	
switch	41	
switch 3 way	20	
exhaust fan	3	
vanity bar light 02	1	
pop up outlet	2	

ELECTRICAL PLAN NOTES

- E-1 WIRE ALL APPLIANCES, HVAC UNITS AND OTHER EQUIPMENT PER MANUFACTURER'S SPECIFICATIONS.
- E-2 CONSULT THE OWNER FOR THE NUMBER OF SEPERATE TELEPHONE LINES TO BE INSTALLED.
- E-3 ALL INSTALLATIONS SHALL BE PER NATIONAL ELECTRIC CODE.
- E-4 ALL SMOKE DETECTORs SHALL BE 120V W/BATTERY BACKUP OF THE PHOTOELECTRIC TYPE, AND SHALL BE INTERLOCKED TOGETHER. INSTALL INSIDE AND NEAR ALL BEDROOMS.
- E-5 TELEPHONE, TELEVISION AND OTHER LOW VOLTAGE DEVICES OR OUTLETS SHALL BE AS PER THE OWNER'S DIRECTION AND IN ACCORDANCE WITH APPLICABLE SECTIONS OF NATIONAL ELCT. CODE LATEST EDITION.
- E-6 ELECTRICAL CONTRACTOR SHALL BE RESPONSIBLE FOR THE DESIGN AND SIZING OF ELECTRICAL SERVICE AND CIRCUITS.
- E-7 ENTRY OF SERVICE UNDERGROUND OR OVERHEAD) IS TO BE DETERMINED BY THE POWER COMPANY.
- E-8 ALL BEDROOM RECEPTALS ARE TO BE AFCI (ARC FAULT CIRCUIT INTERRUPT)

* ELECTRICAL PLAN *

SCALE : 1/4" = 1'-0"

RESIDENCE
for
AUSTIN & KELSEY
BARBER

Teena M. Ruffo
2925 SW SR 47
Lake City Florida, 32025
Cell: (386) 867 - 1191
Email: teenaruffo@gmail.com

PRINTED DATE:
Wednesday, June 5, 2024

DRAWN BY: Teena M. Ruffo CHECKED BY:

BUILDING CONTRACTOR

FINAL& DATE:

JOB NUMBER:

DRAWING NUMBER

A-6

OF 6 SHEETS